


CONFIRM MATCH OF NEW SPECIFIED WATER CLOSET FIXTURE TO EXISTING CARRIER. UTILIZE EXISTING WASTE AND SUPPLY PLUMBING SYSTEMS FOR WATER CLOSET INSTALLATIONS.

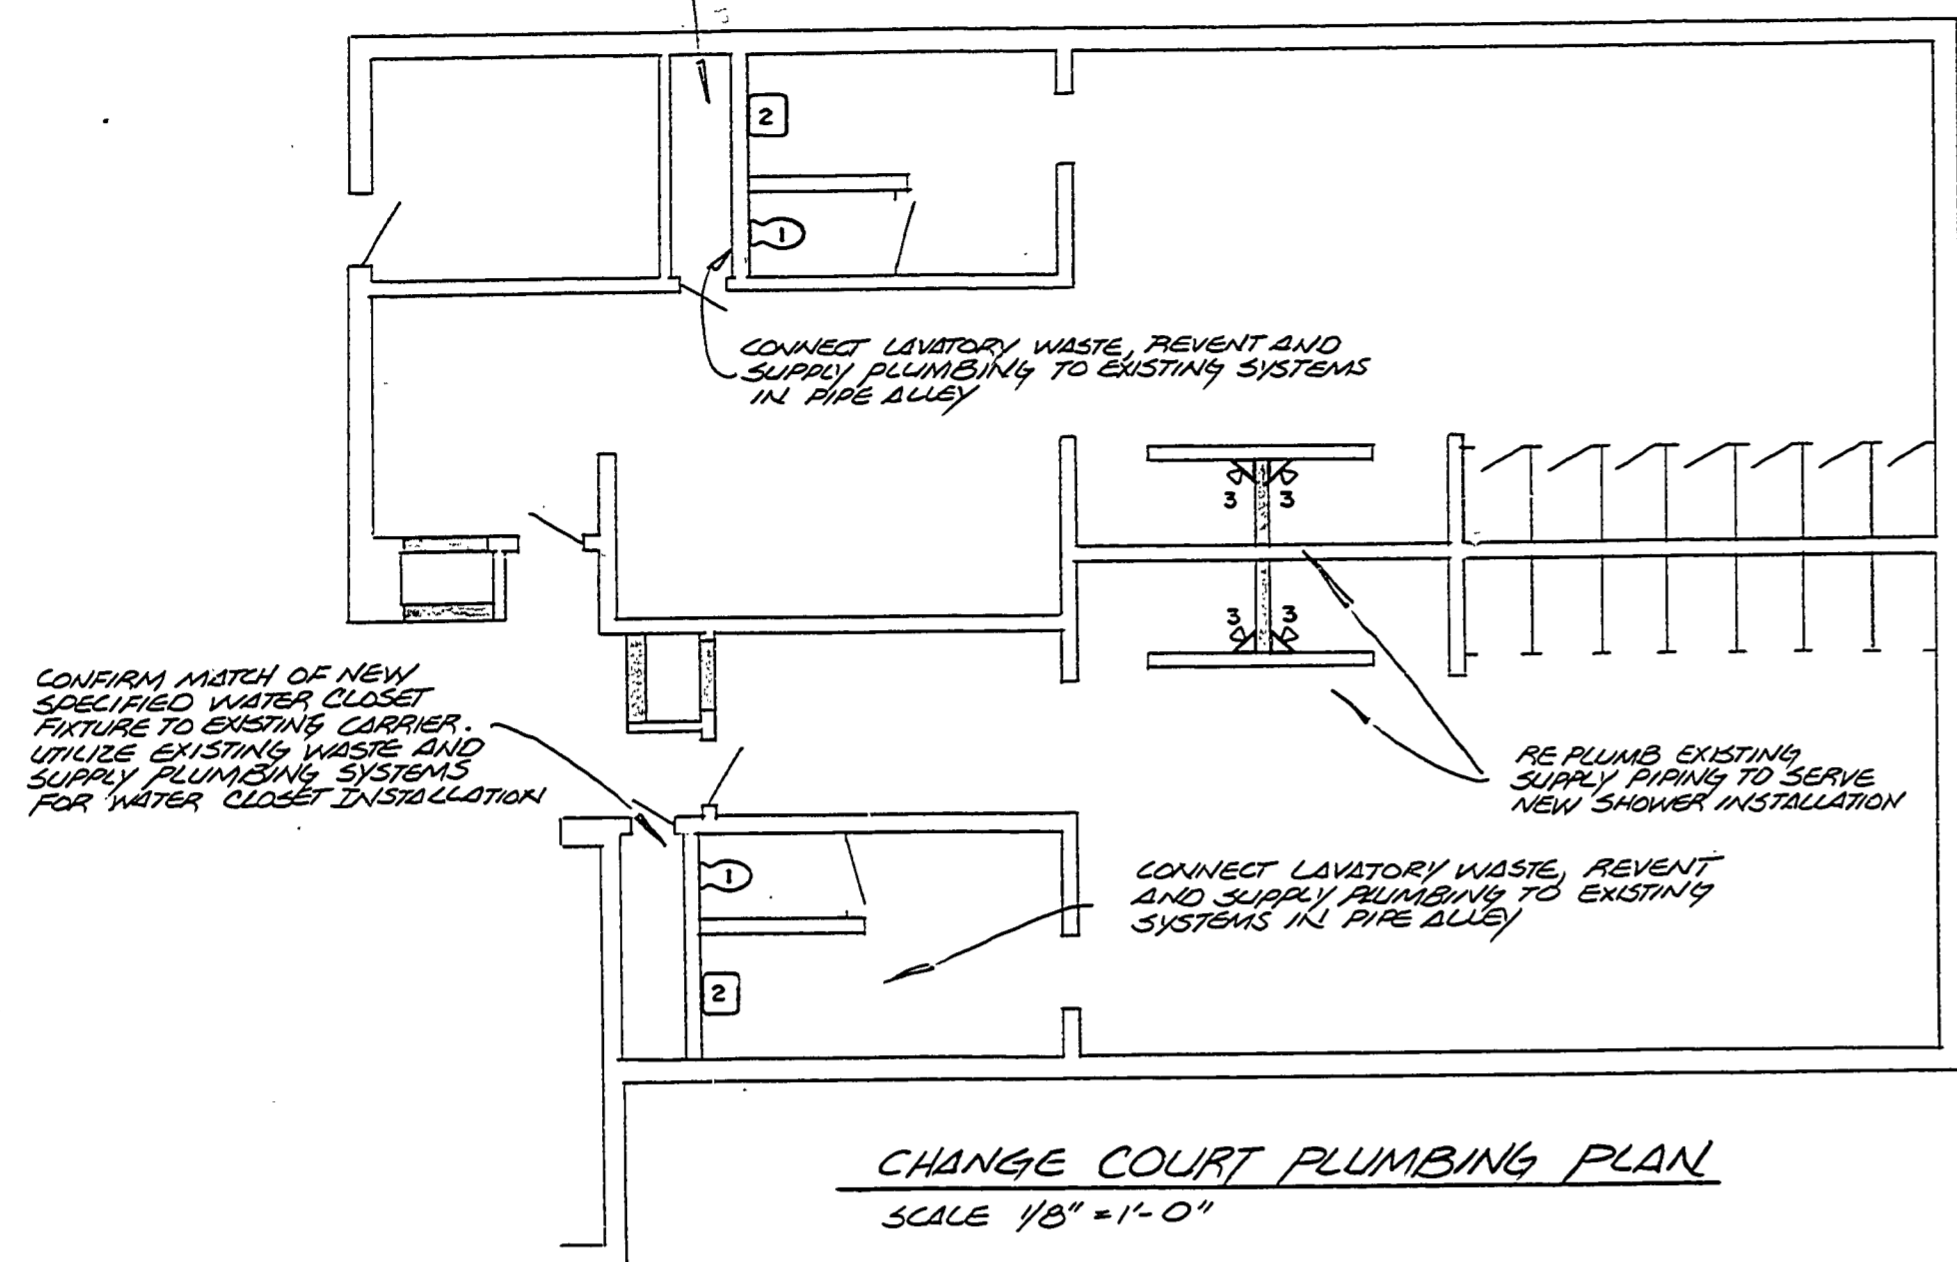

CHANGE COURT PLUMBING PLAN
SCALE 1/8" = 1'-0"

CONFIRM MATCH OF NEW SPECIFIED WATER CLOSET FIXTURE TO EXISTING CARRIER. UTILIZE EXISTING WASTE AND SUPPLY PLUMBING SYSTEMS FOR WATER CLOSET INSTALLATIONS.

CONNECT LAVATORY WASTE, REVENT AND SUPPLY PLUMBING TO EXISTING SYSTEMS IN PIPE ALLEY

RE PLUMB EXISTING SUPPLY PIPING TO SERVE NEW SHOWER INSTALLATION


CONNECT LAVATORY WASTE, REVENT AND SUPPLY PLUMBING TO EXISTING SYSTEMS IN PIPE ALLEY

PLUMBING FIXTURE DESCRIPTIONS

- FIXTURE #1 WATER CLOSET
- KOHLER # K 4432R KINGSTON WALL HUNG SIFON-JET ELONGATED BOWL, 1 1/2" REAR SPUD.
 - KOHLER # K4666 LUSTRA HEAVY DUTY WHITE SEAT.
 - DELANEY # SA3-B CONCEALED ROUGH BRASS FLUSH VALVE WITH NON-HOLD-OPEN PUSH BUTTON CONTROL FOR 6" WALL THICKNESS.
 - CONFIRM FIXTURE MATCH TO EXISTING CARRIER.
- FIXTURE #2 LAVATORY
- KOHLER # K 2032 GREENWICH 20 X 18 WALL MOUNTED VITREOUS CHINA WITH DRILLING FOR CONCEALED ARM BRACKETS AND 4" CENTERSET FAUCET FOR A SINGLE PIPE WATER SUPPLY.
 - SYMMONS # S-61 VANDAL PROOF 4" CENTERSET SLOW-CLOSING LAVATORY FAUCET FOR A SINGLE PIPE WATER SUPPLY. TIME LIMIT STOP TO ADJUST FLOW TIME. ROSE SPRAY OUTLET WITH 0.5 GPM FLOW RATE.
 - KOHLER # K-7715 DRAIN.
 - KOHLER # K-9000, 1/4" TRAP.
 - KOHLER # K-7607, 3/8" SUPPLY WITH LOOSE KEY STOP.
 - JOSAM # 17100 LAVATORY CARRIER WITH CONCEALED ARMS.
- FIXTURE #3
- SYMMONS CORNER HYDRAPE 6L PACKAGED SHORT LENGTH UNIT MODEL # 1-808-60, PUSH BUTTON CONTROL, AUTOMATIC SHOWER LIMITING VALVE WITH INTEGRAL STOP, VANDAL PROOF INSTITUTIONAL SHOWER HEAD WITH 2.0 GPM MAX FLOW, TOP CORNER CAP, 1/2 GAUGE STAINLESS STEEL COVERING WITH #2 BRUSH FINISH. UNIT TO BE THRU WALL SINGLE SUPPLY CONFIGURATION.

PLUMBING SCHEDULE			
FIXTURE	DESIG	WASTE	SUPPLY
WATER CLOSET	1	4"	1"
LAVATORY	2	2"	3/8"
SHOWER	3		1/2"

FIXTURE MOUNTING SCHEDULE	
FIXTURE	MOUNTING HEIGHT
WATER CLOSET	MOUNT 17" ABOVE FINISHED FLOOR TO TOP OF SEAT.
LAVATORY	MOUNT 32" ABOVE FINISHED FLOOR TO TOP OF LAVATORY.
SHOWER	MOUNT TOP PLATE FLUSH WITH WALL OPENING, APPROXIMATELY 6'-0" ABOVE FINISHED FLOOR.

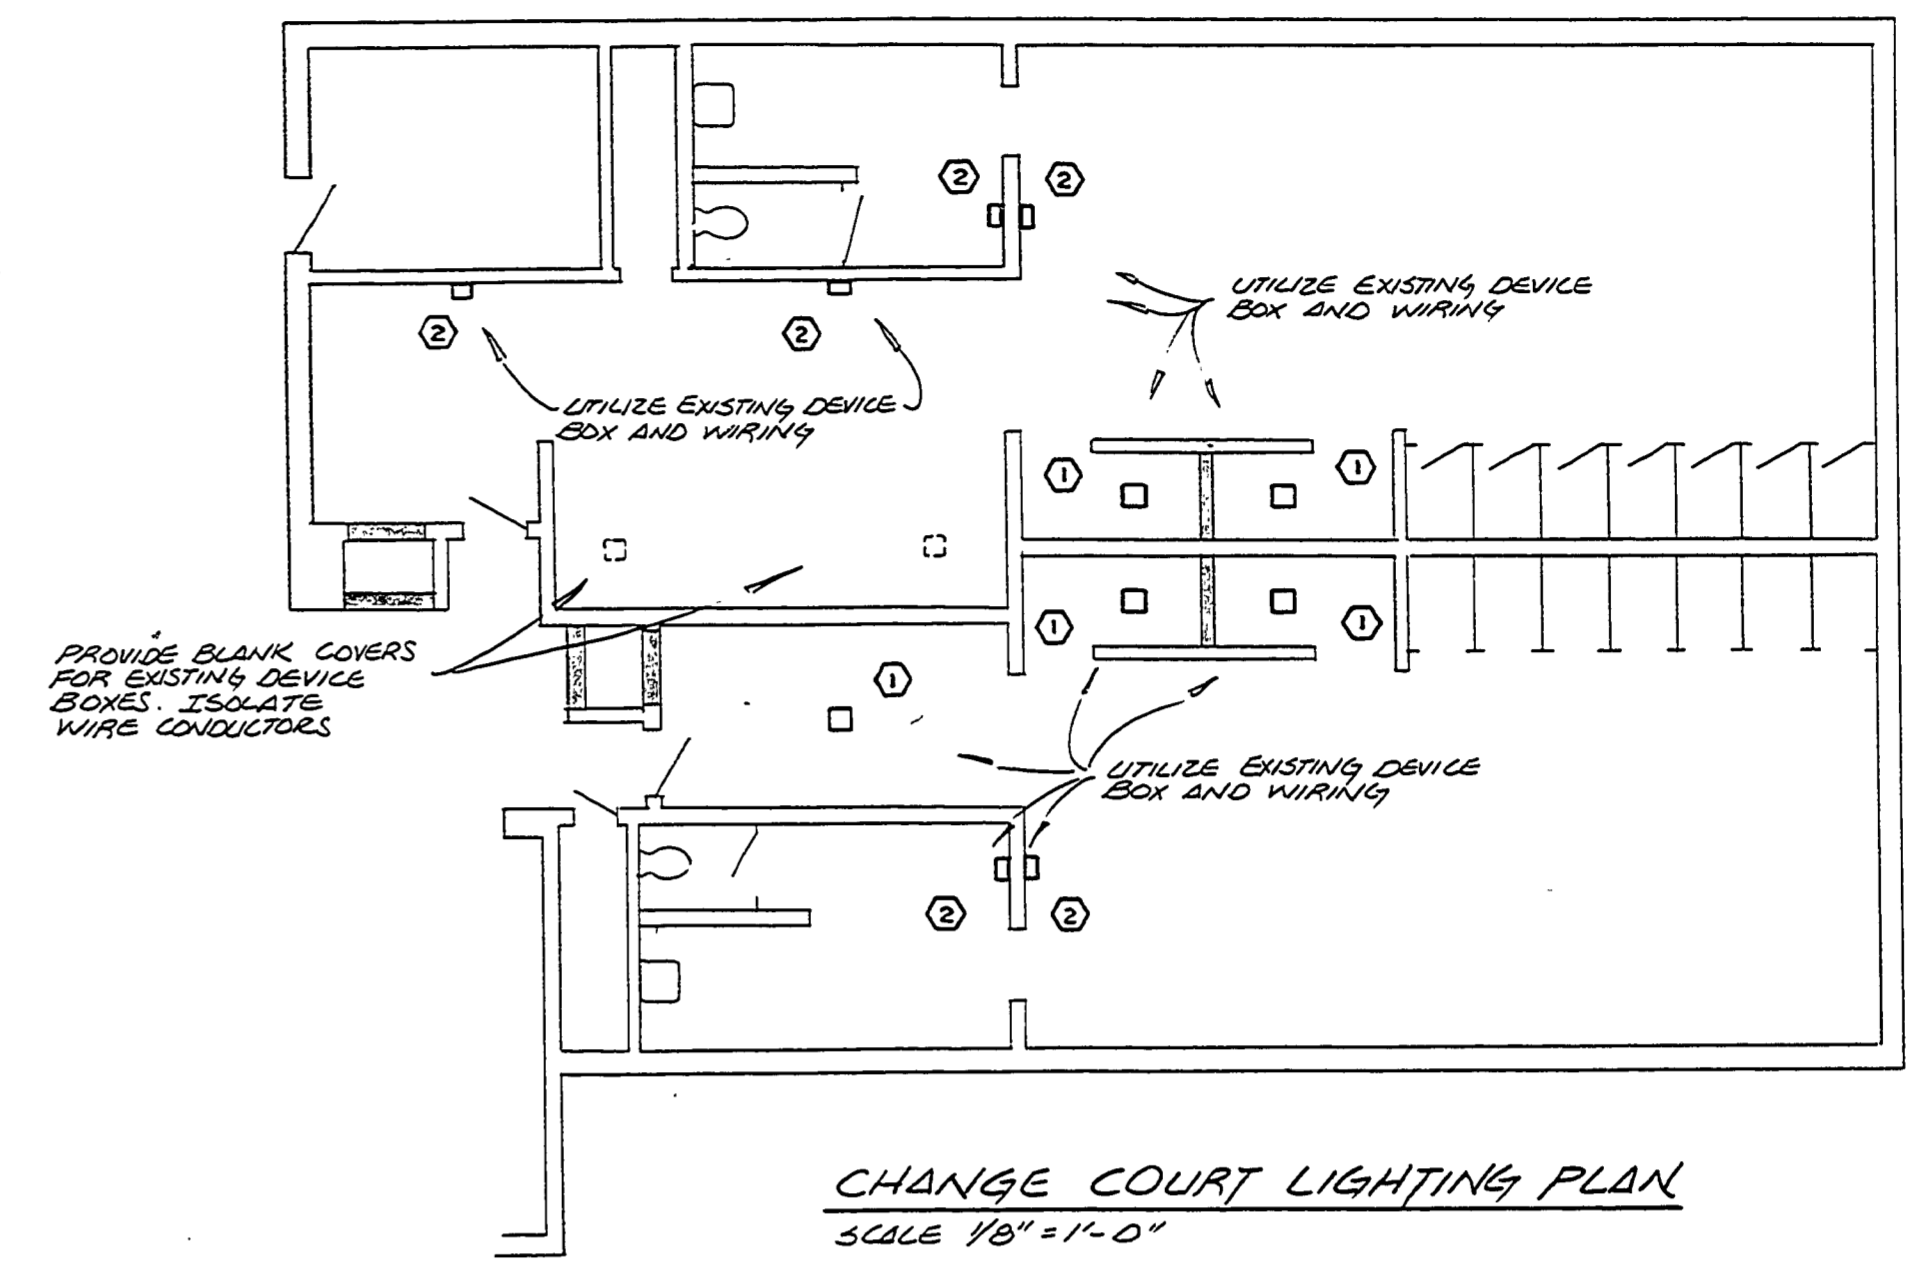

CHANGE COURT LIGHTING PLAN
SCALE 1/8" = 1'-0"

UTILIZE EXISTING DEVICE BOX AND WIRING

PROVIDE BLANK COVERS FOR EXISTING DEVICE BOXES, ISOLATE WIRE CONDUCTORS

UTILIZE EXISTING DEVICE BOX AND WIRING

UTILIZE EXISTING DEVICE BOX AND WIRING

LIGHTING FIXTURE SCHEDULE						
NO.	MFR.	CATALOG NUMBER	DESCRIPTION	LAMPS	DIFFUSER	REMARKS
①	LUMARK	H19V-PB-35-120V-LL	HIGH PRESSURE SODIUM VANDAL RESISTANT CEILING MOUNT FIXTURE	35 WATT H.P.S. MED BASE	PRISMATIC POLYCARBONATE	U.L. LISTED WET LOCATIONS. PROVIDE WITH TAMPER PROOF SCREWS.
②	LUMARK	H19V-PB-35-120V-LL	HIGH PRESSURE SODIUM VANDAL RESISTANT WALL MOUNT FIXTURE	35 WATT H.P.S. MED BASE	PRISMATIC POLYCARBONATE	U.L. LISTED WET LOCATIONS. PROVIDE WITH TAMPER PROOF SCREWS.

SURVEYED BY	DRAWN BY BARKER	4/BS	NO. DATE BY	REVISIONS	NO. DATE BY	REVISIONS	MICHIGAN DEPARTMENT OF NATURAL RESOURCES	PLUMBING & LIGHTING FLOOR PLANS	MUSKEGON STATE PARK AREA OR PARK	PROJECT NO. 24-2589
DESIGNED BY BARKER	4/BS	CHECKED BY	1.		3.			SHEET TITLE	BEACHHOUSE INTERIOR REMODELING PROJECT	SHEET 3 OF 3
	DATE	DATE	2.		4.					PLAN NO. A 117