


# CONSTRUCTION PLANS FOR MUSKEGON STATE PARK WASTEWATER SYSTEM IMPROVEMENTS

## QUALITY OF LIFE RECREATION BOND PROGRAM LAKE MICHIGAN SHORELINE REGION

MICHIGAN DEPARTMENT OF NATURAL RESOURCES  
PARKS DIVISION  
ACCT. NO. 607-75-2450-400

**REBID**

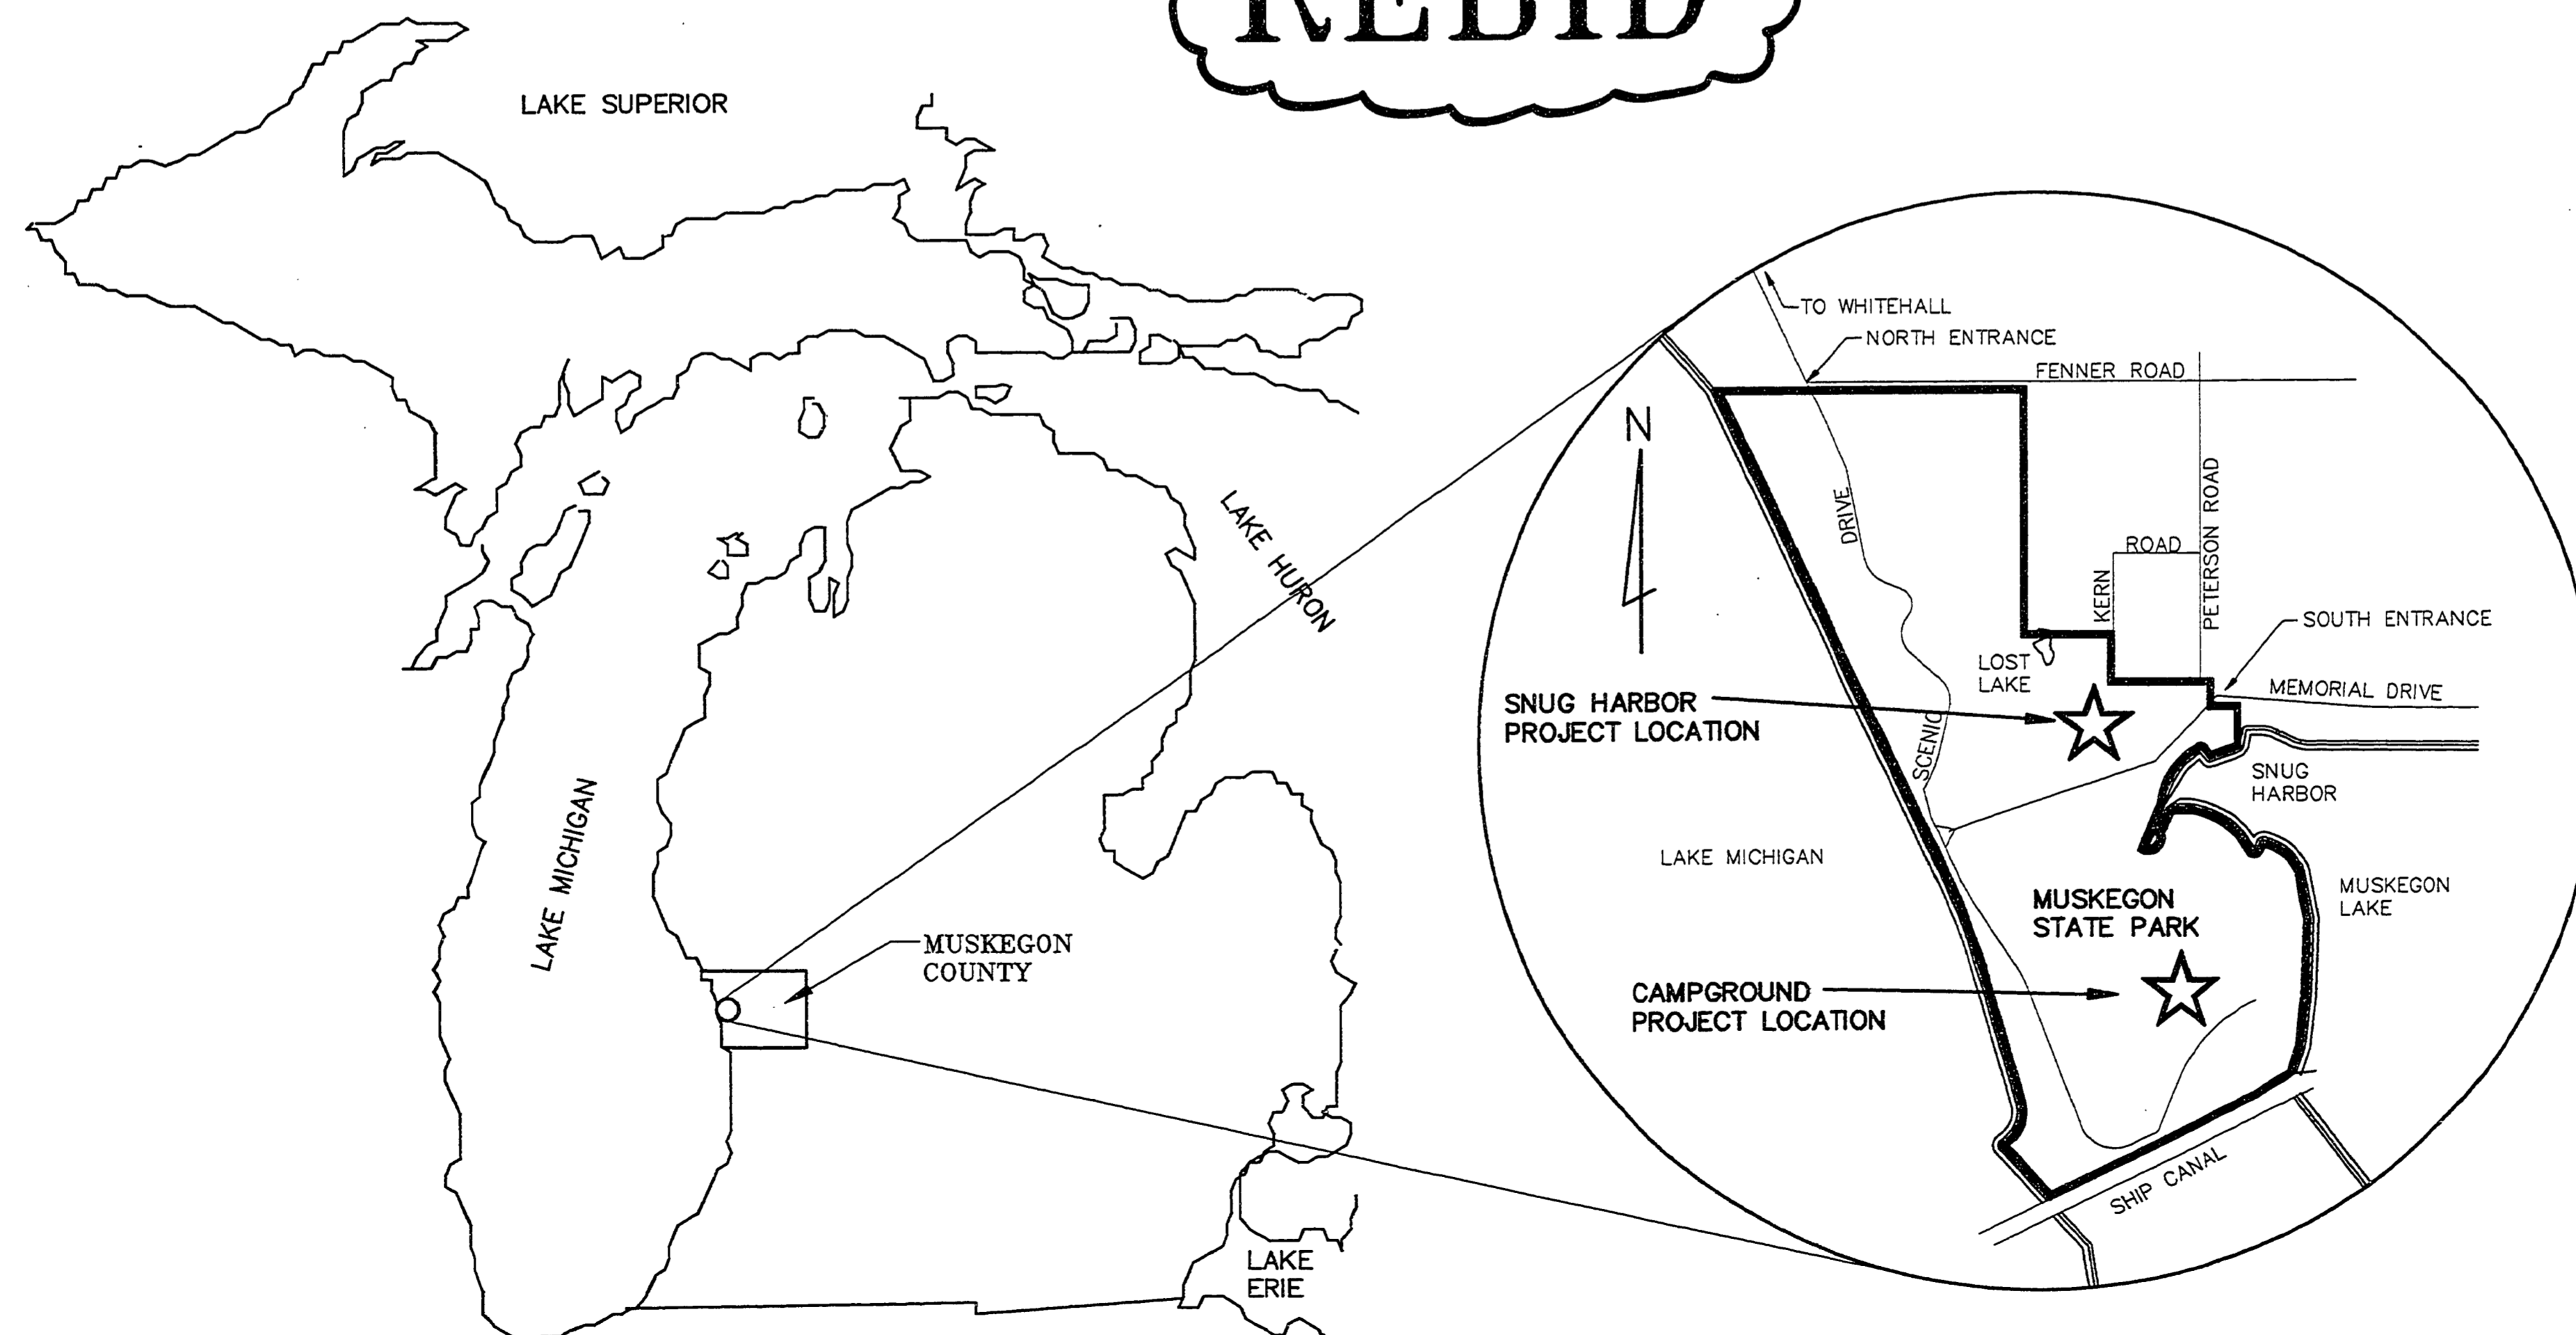

LIST OF DRAWINGS

1. TITLE SHEET
2. CAMPGROUND WASTEWATER SYSTEM - GENERAL SITE MAP
3. SNUG HARBOR WASTEWATER SYSTEM - GENERAL SITE MAP
4. STANDARD DETAILS
5. CAMPGROUND WASTEWATER SYSTEM - EXISTING PUMP STATION DEMOLITION
6. CAMPGROUND WASTEWATER SYSTEM - SITE PLAN
- 6A. CAMPGROUND PUMP STATION IMPROVEMENTS
- 6B. CAMPGROUND PUMP STATION IMPROVEMENTS - ELECTRICAL
7. CAMPGROUND WASTEWATER SYSTEM - ABSORPTION FIELD DETAILS
8. CAMPGROUND WASTEWATER SYSTEM - EAST ABSORPTION FIELD CROSS SECTIONS
9. CAMPGROUND WASTEWATER SYSTEM - WEST ABSORPTION FIELD CROSS SECTIONS
10. CAMPGROUND WASTEWATER SYSTEM - SEPTIC TANKS AND PUMP STATION DETAILS
11. CAMPGROUND WASTEWATER SYSTEM - PUMP STATION ELECTRICAL
12. SNUG HARBOR WASTEWATER SYSTEM - EXISTING PUMP STATION DEMOLITION
13. SNUG HARBOR WASTEWATER SYSTEM - FORCE MAIN PLAN AND PROFILE
14. SNUG HARBOR WASTEWATER SYSTEM - FORCE MAIN PLAN AND PROFILE
15. SNUG HARBOR WASTEWATER SYSTEM - PUMP STATION DETAIL AND SITE PLAN
16. SNUG HARBOR WASTEWATER SYSTEM - PUMP STATION ELECTRICAL
17. SNUG HARBOR WASTEWATER SYSTEM - ABSORPTION FIELD DETAILS
18. SNUG HARBOR WASTEWATER SYSTEM - NORTH/SOUTH CROSS SECTIONS
19. SNUG HARBOR WASTEWATER SYSTEM - EAST/WEST CROSS SECTIONS
20. SNUG HARBOR WASTEWATER SYSTEM - RETAINING WALL DETAILS
21. WASTEWATER SYSTEM - PUMP STATION ELECTRICAL SERVICE DETAILS

**Heartland**  
Professional Construction Services, Inc.  
1800 Michigan National Tower • Lansing, Michigan 48933 • 517-482-6100

**CAPITAL CONSULTANTS**  
ENGINEERS  
820 N. WASHINGTON AVE. LANSING, MICHIGAN 48208 TELEPHONE 517-371-1300

STATE OF MICHIGAN  
DEPARTMENT OF MANAGEMENT AND BUDGET  
Office of Facilities

STATE OF MICHIGAN  
DEPARTMENT OF NATURAL RESOURCES  
APPROVED BY: *Robert Helms* for the  
CHIEF, PARKS DIVISION  
DATE: 11/14/94

SHEET  
1 of 21

**REBID DNR-8 MUSKEGON STATE PARK - WASTEWATER SYSTEM IMPROVEMENTS**



FILE NO. 11807LE  
DATE 11/14/94  
DRAWN BY: JLS