

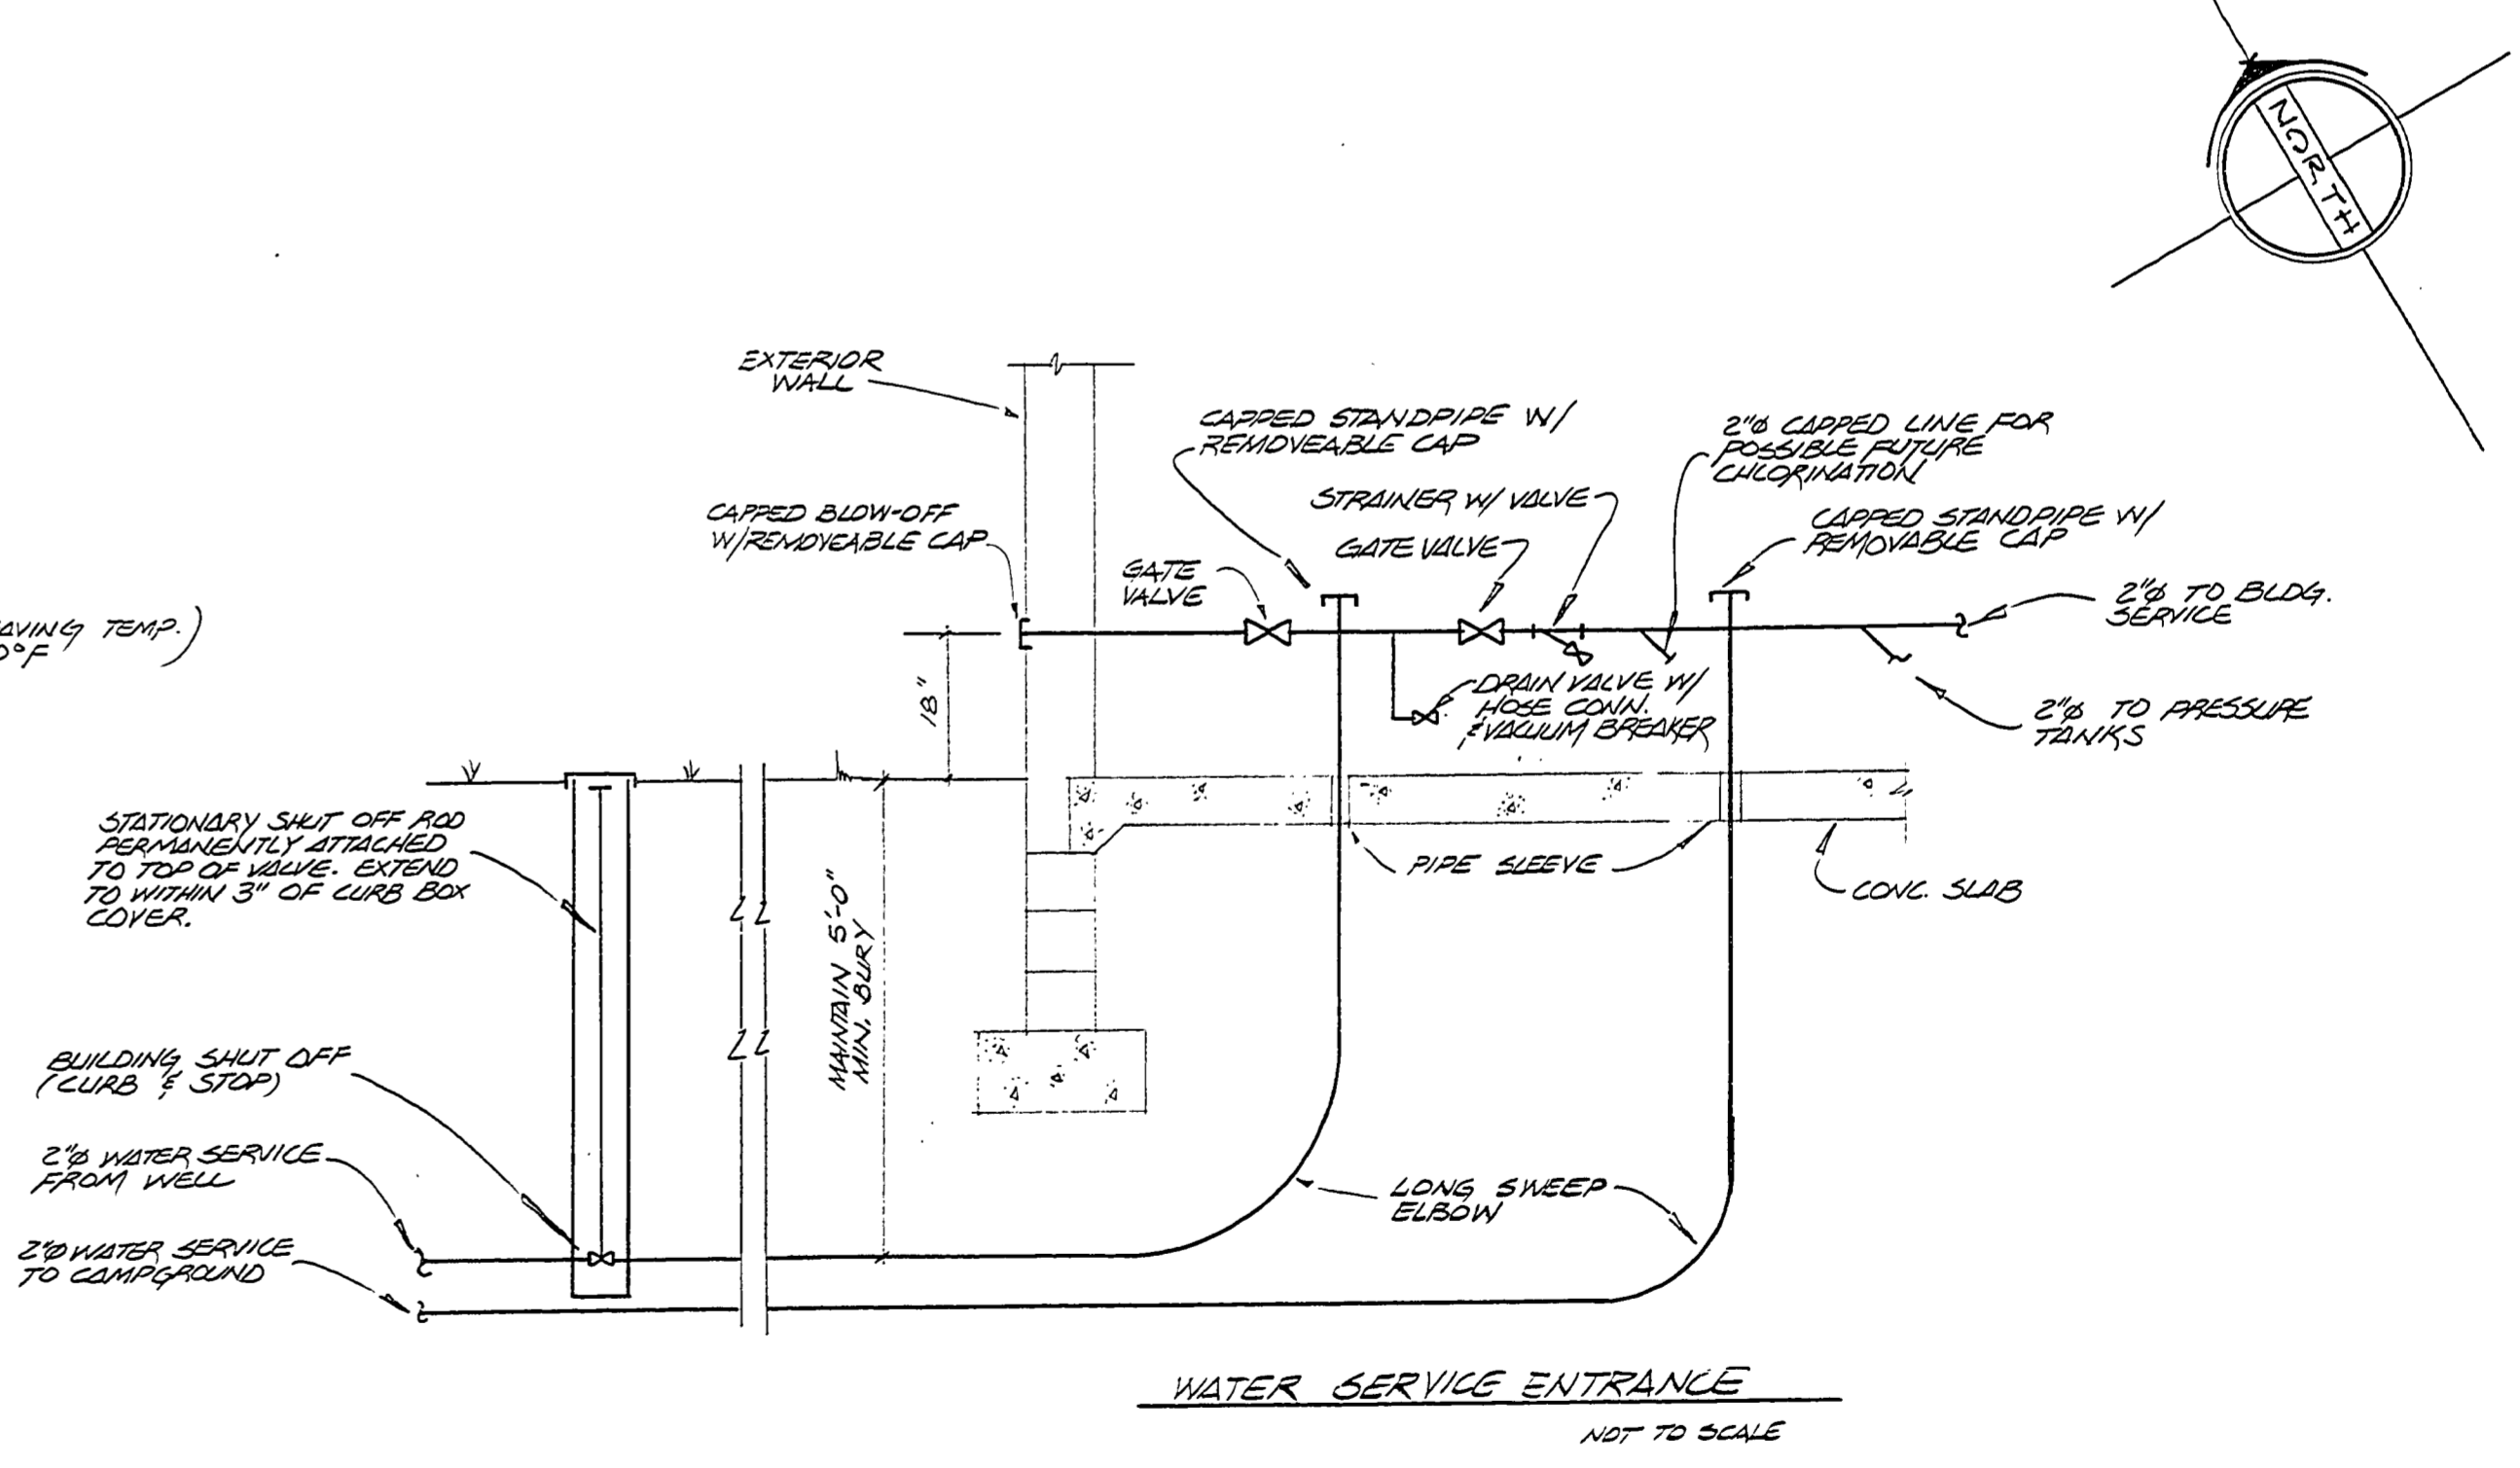
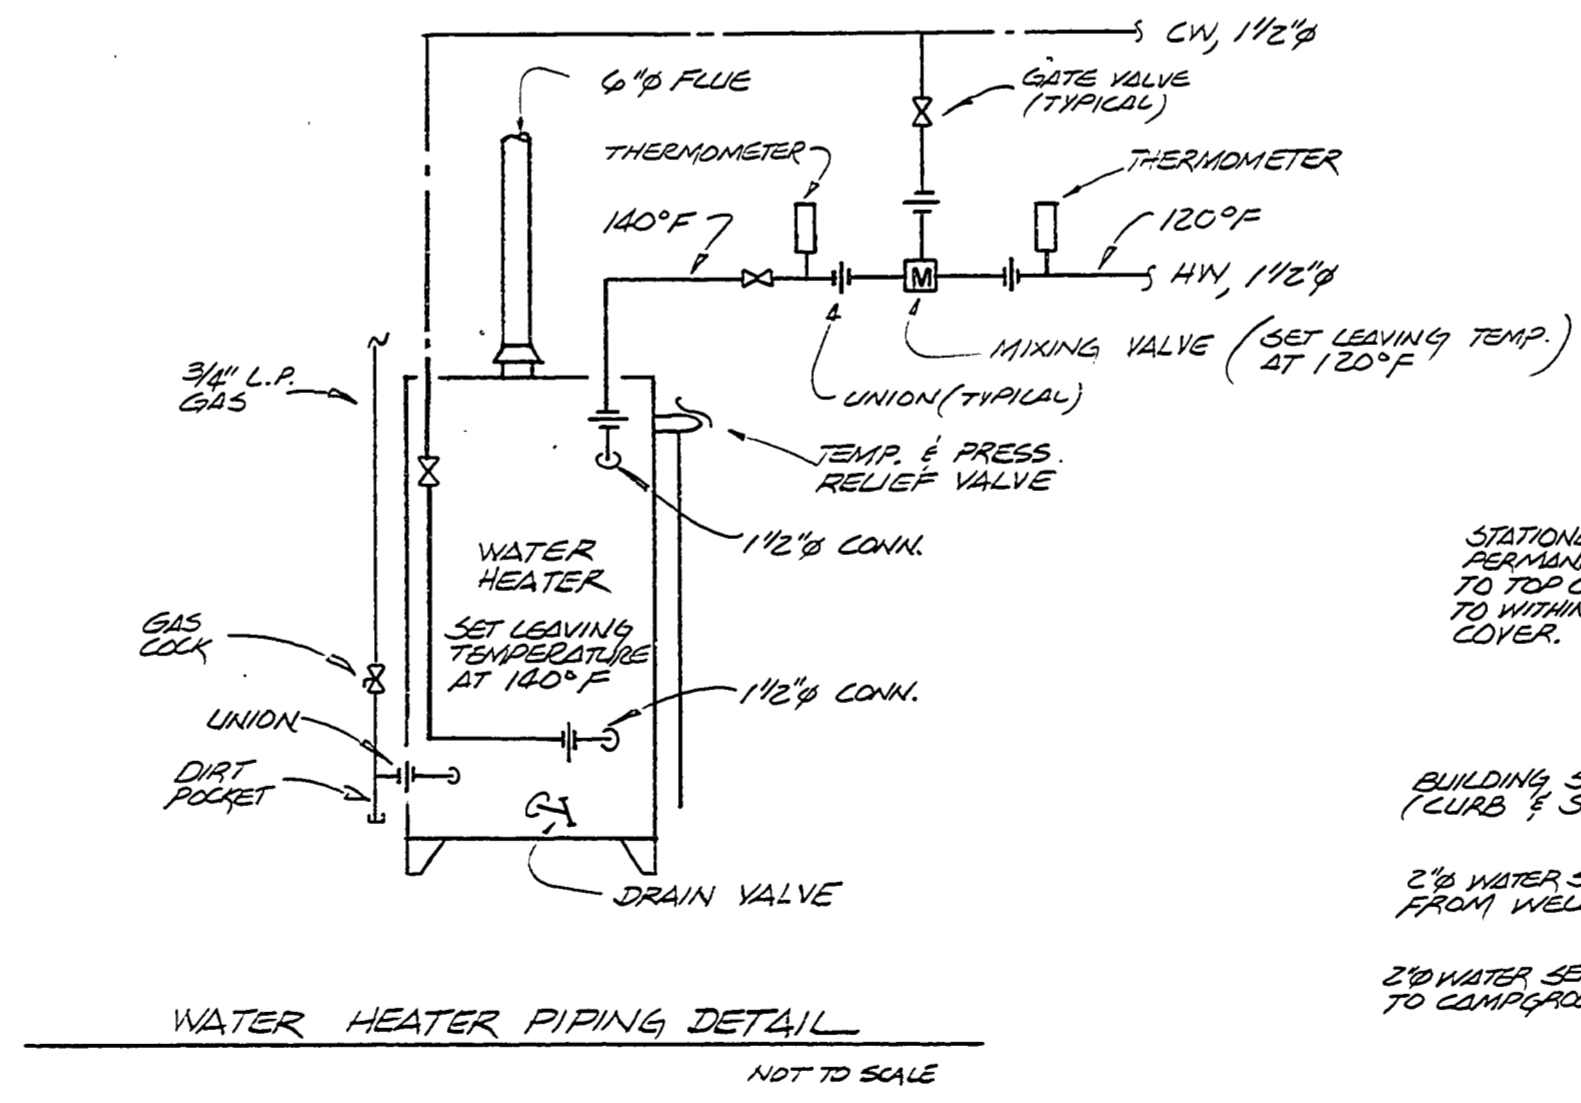


PLUMBING SCHEDULE				
FIXTURE	NO.	WASTE	CW	HW
WATER CLOSET	1	4"	1"	—
WATER CLOSET	2	4"	1"	—
SHOWER	3	—	1/2"	1/2"
LAVATORY	4	1 1/4"	1/2"	1/2"
LAVATORY	5	1 1/4"	1/2"	1/2"
URINAL	6	3"	3/4"	—
URINAL	7	3"	1"	—
SERVICE BASIN	8	3"	1/2"	1/2"
WALL HYDRANT	9	—	3/4"	—
HOSE BIBB	10	—	1/2"	—
SHOWER DRAIN	11	4"	—	—
FLOOR DRAIN	12	4"	—	—
CONDENSED STACK CLEANOUT	13	4"	—	—
FLOOR CLEANOUT	14	4"	—	—
EXPOSED STACK CLEANOUT	15	4"	—	—
MANIFOLD CLEANOUT	16	*	—	—

* SAME SIZE AS MANIFOLD
NOTE: FOR MOUNTING HT'S SEE ELEVATIONS, SHT. NO'S 3 & 4.

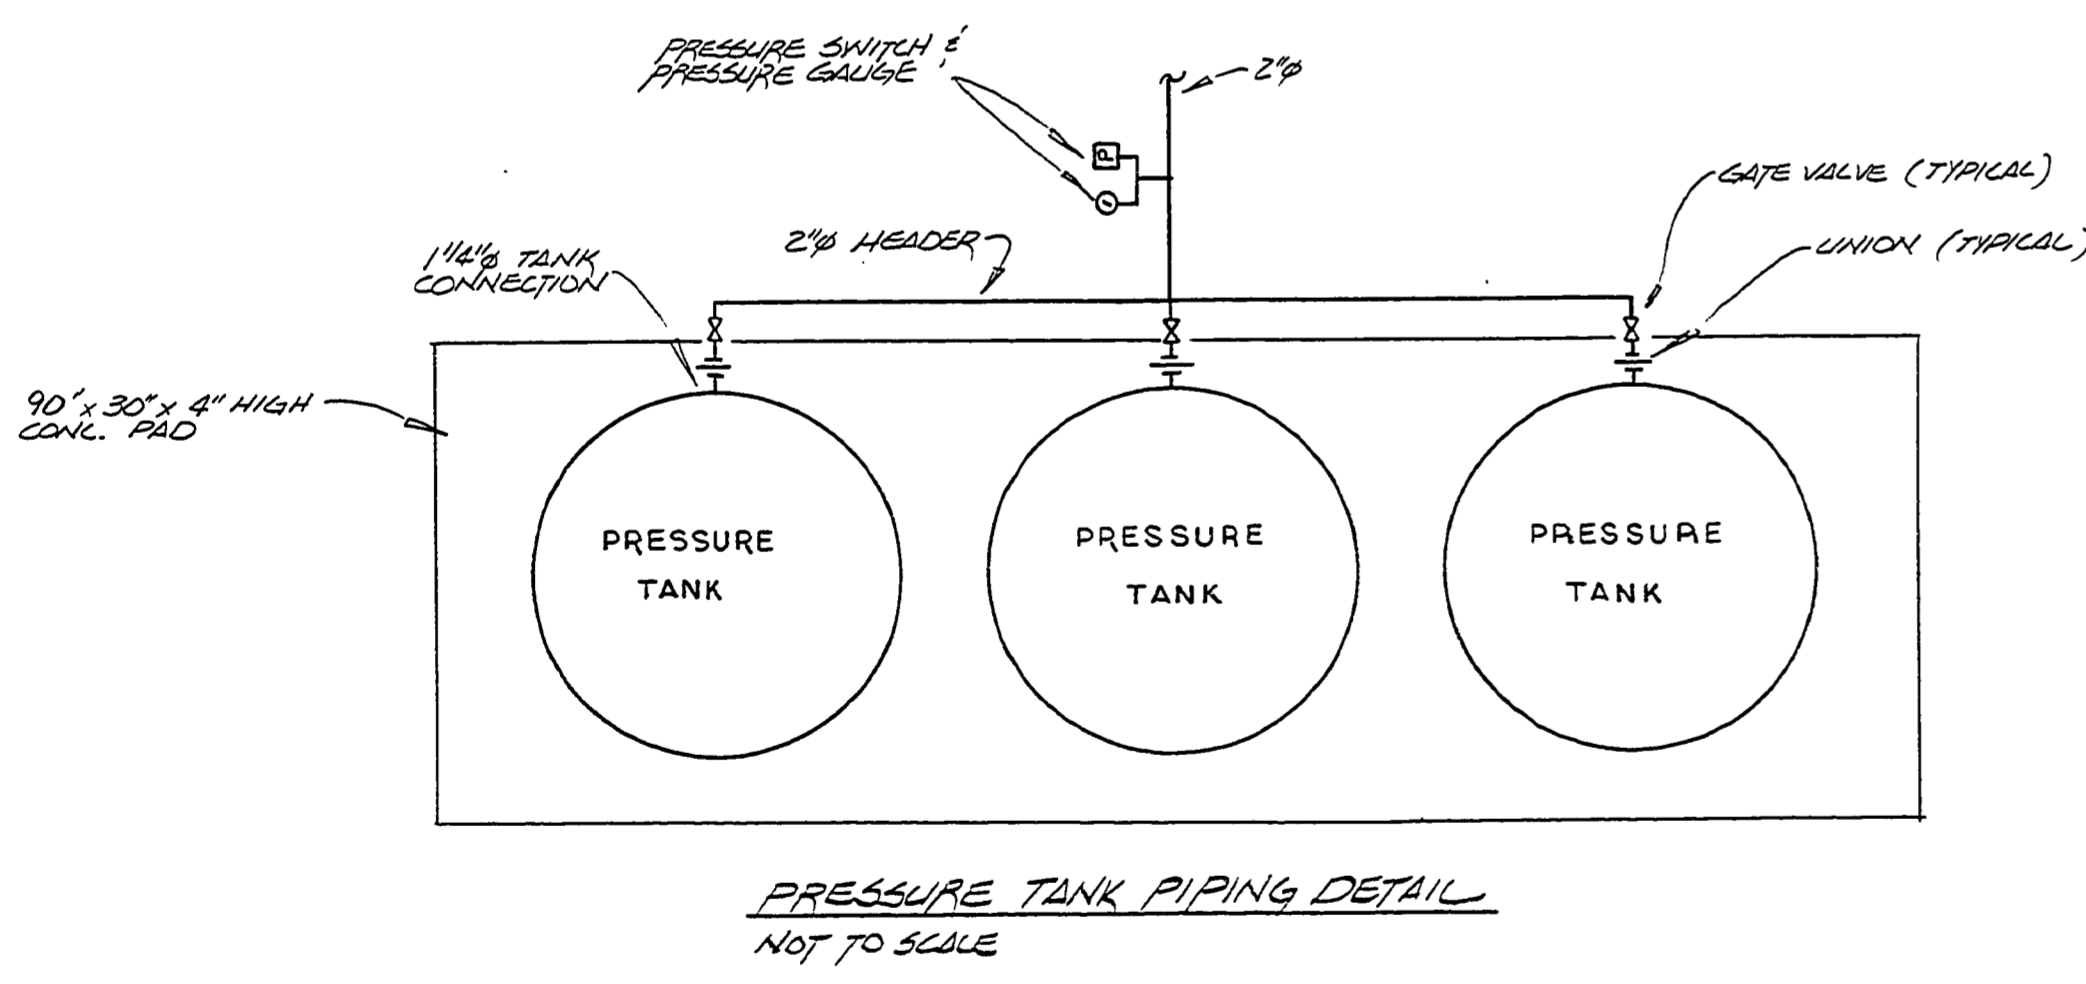

SURVEYED BY	DRAWN BY	NO.	DATE	BY	REVISIONS	NO.	DATE	BY	REVISIONS	MICHIGAN DEPARTMENT OF NATURAL RESOURCES	DOMESTIC WATER SUPPLY PLAN	SLEEPY HOLLOW STATE PARK TOILET & SHOWER BLDG. PROJECT NORTH CAMPGROUND	PROJECT NO. 24-2588
DESIGNED BY	CHECKED BY	1.				3.				DEPARTMENT OF NATURAL RESOURCES	SHEET TITLE	PROJECT NORTH CAMPGROUND	SHEET 11 OF 21 PLAN NO. A-104
DATE	DATE	2.				4.							

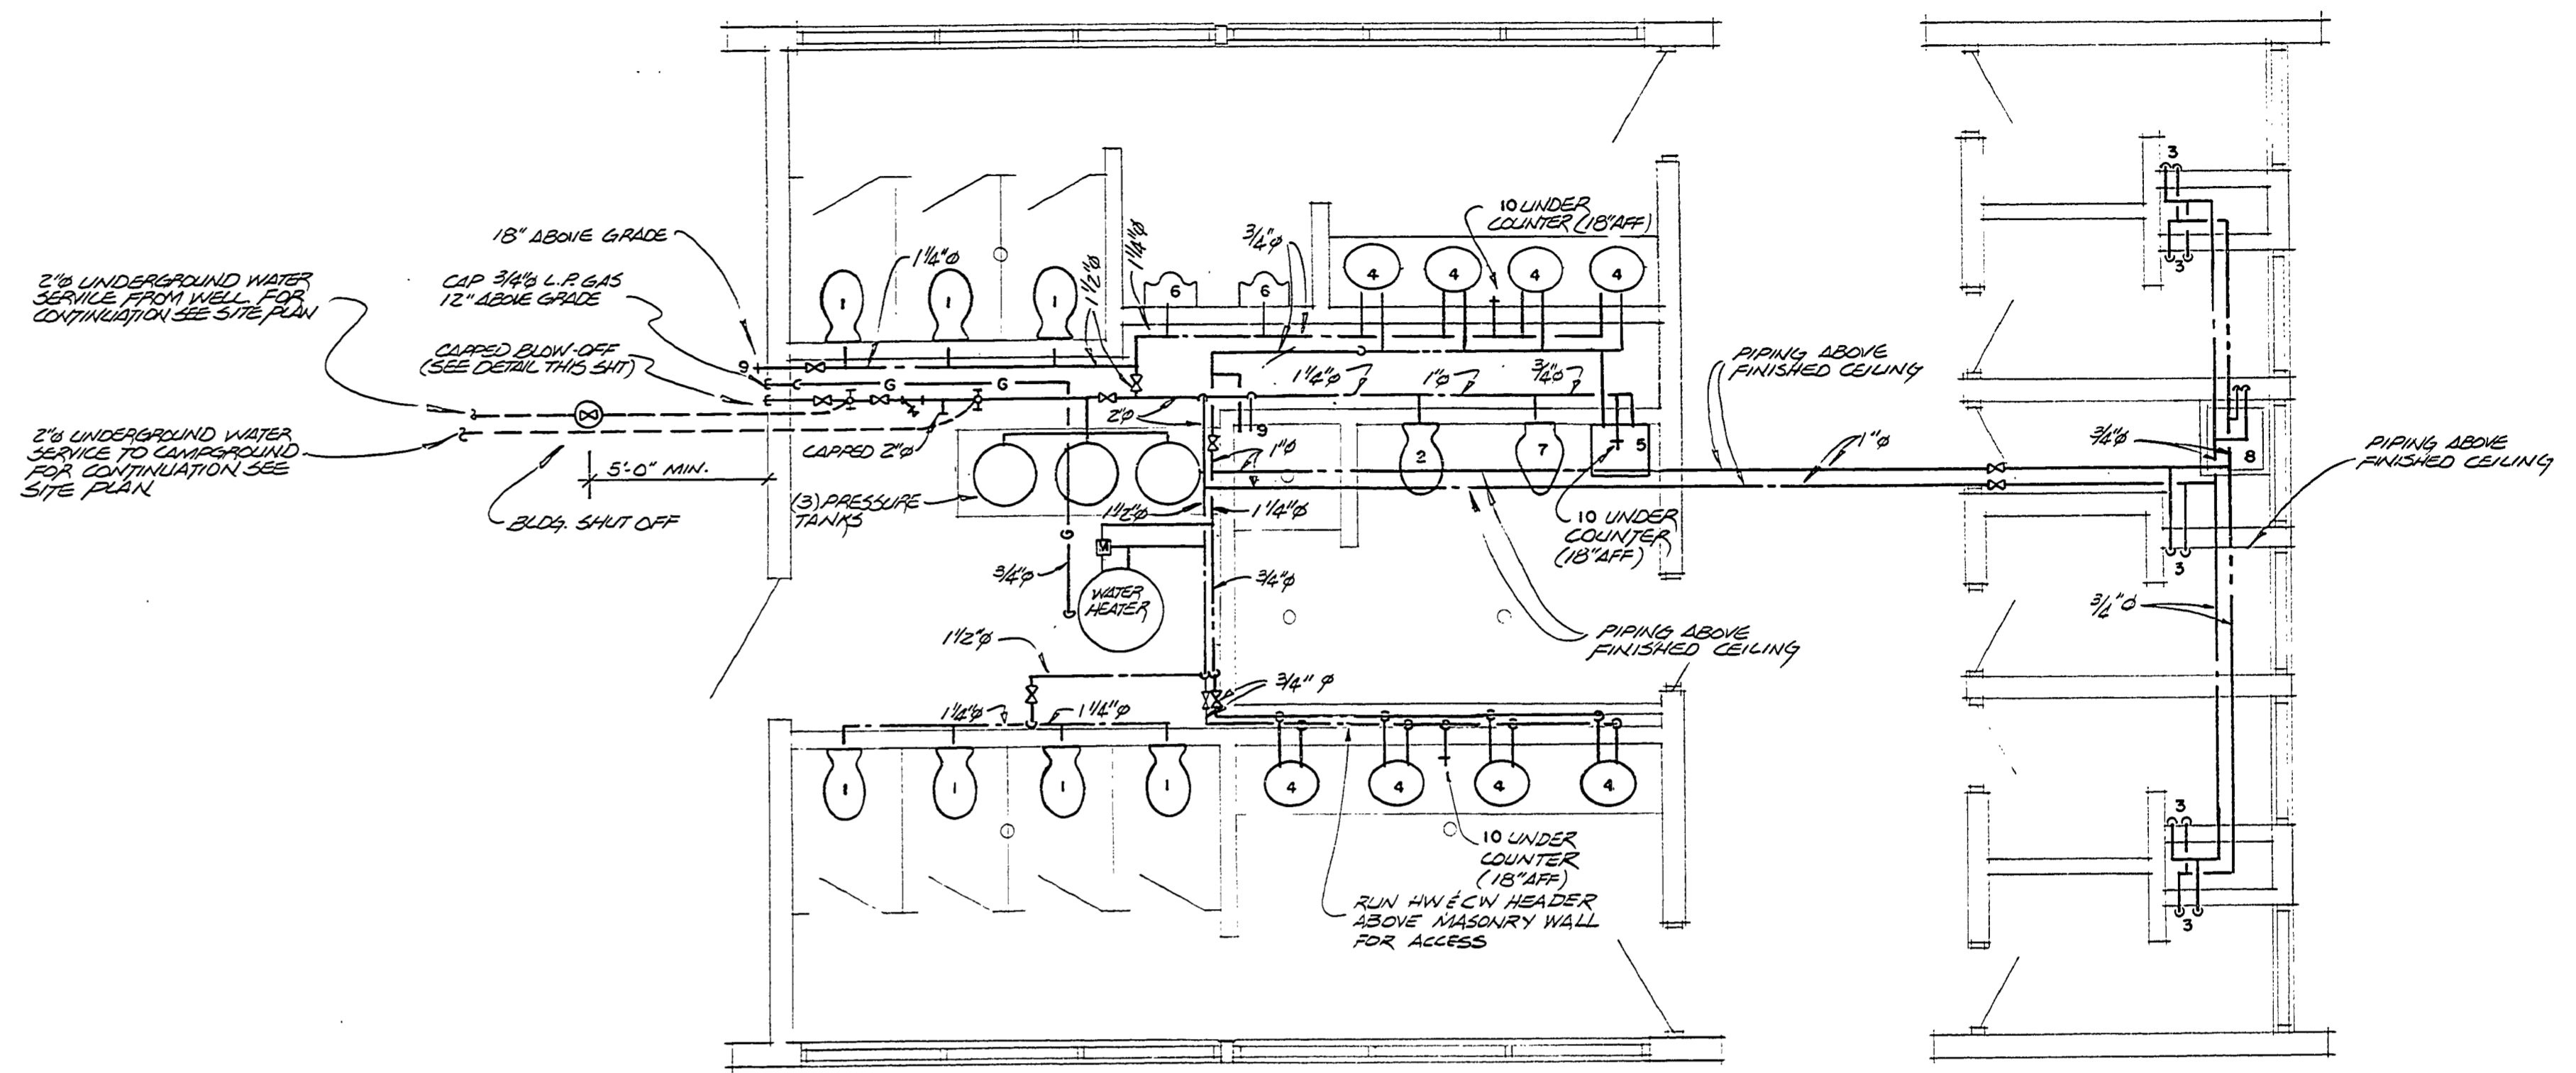