


ELECTRICAL FLOOR PLAN  
SCALE 1/4" = 1'-0"

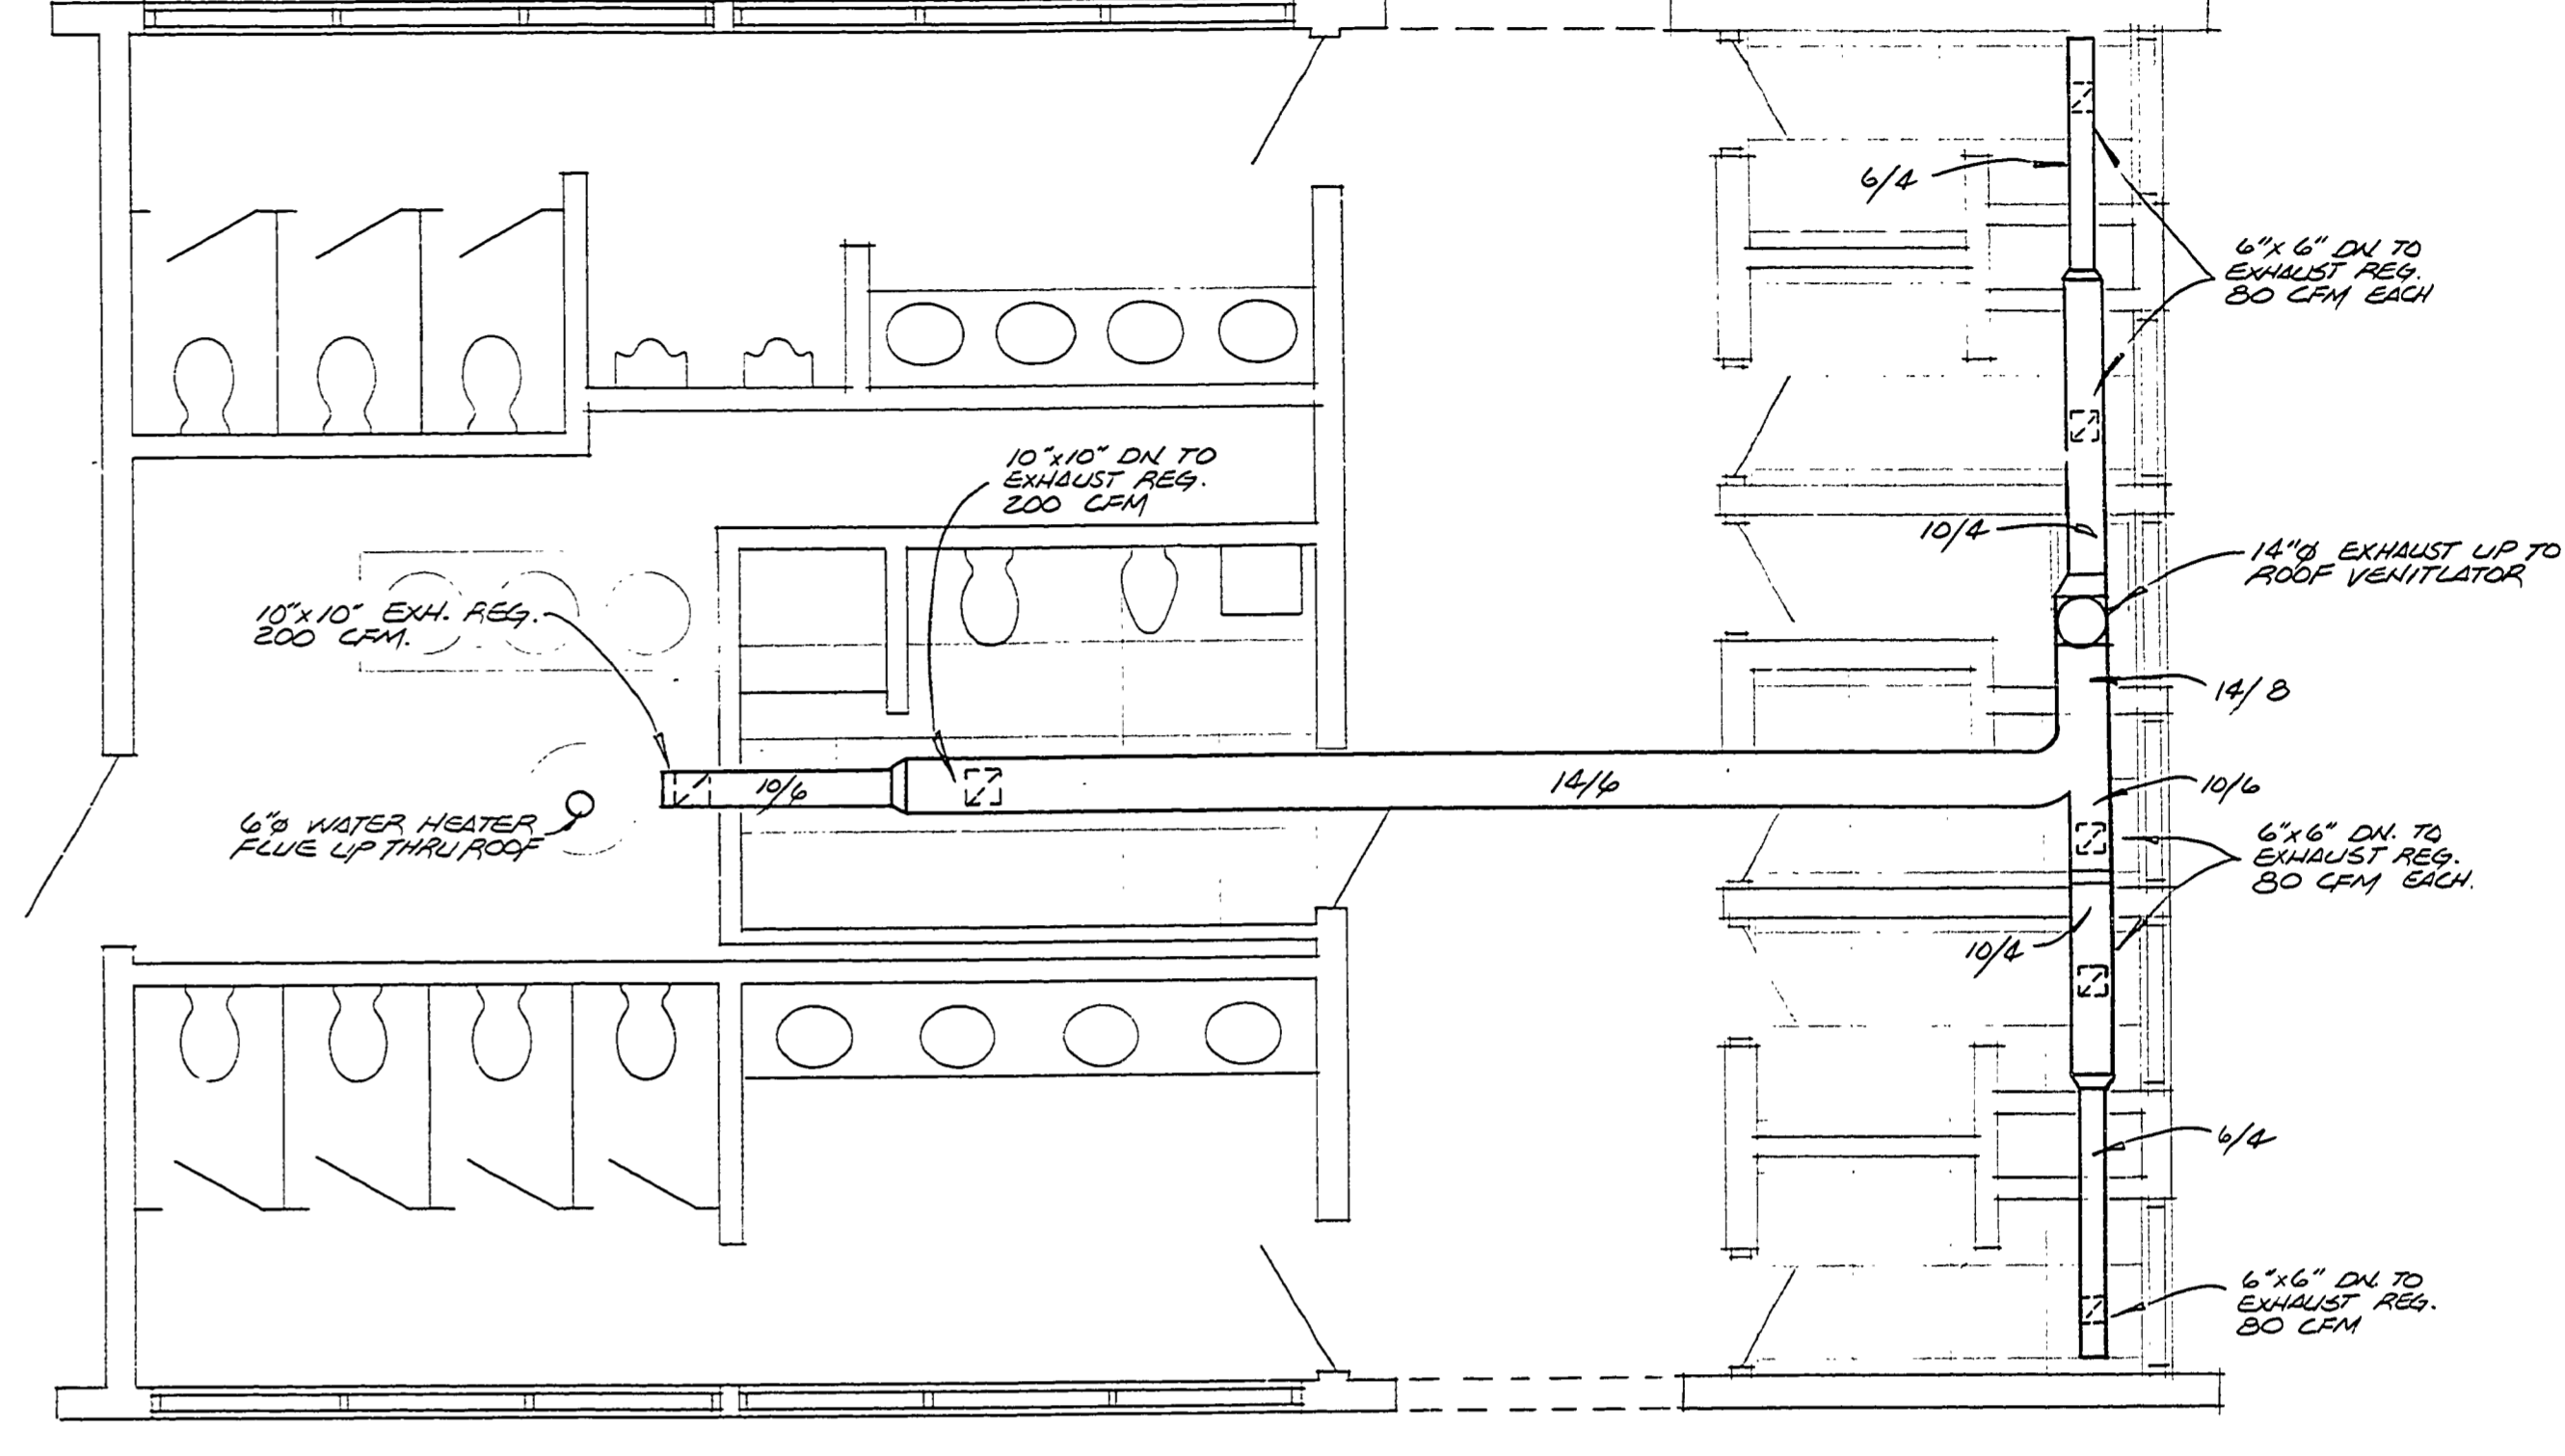

VENTILATION FLOOR PLAN  
SCALE 1/4" = 1'-0"

3#2 SERVICE ENTRANCE FROM CAMPGROUND SERVICE PANEL AT ENTRANCE RACK TO BUILDING ELECTRICAL PANEL PROVIDES 120V GROUND SERVICE ENTRANCE CONDUIT W/ LONG SWEEP ALL CONDUIT SLEEVE IN CONC. SLAB FROM BLDG ELECTR. PANEL TO 5'-0" OUTSIDE BLDG. MAINTAIN 30 MIN. CURT. MAKE FINAL CONNECTION TO 100A 2P BREAKER IN CAMPGROUND SERVICE PANEL & ENTRANCE RACK. (SEE BREAKER FORWARD SERVICE PANEL BY OTHERS.) SEE SITE PLAN FOR LOCATION OF UNDERGROUND SERVICE PANEL AND CONTINUATION OF UNDERGROUND SERVICE ENTRANCE

**LIGHTING FIXTURE SCHEDULE**



NO.	MFR.	CATALOG NO.	DESCRIPTION	LAMPS	DIFFUSER	REMARKS
1	McPHILBEN	4A-8202-MB-RS	SQUARE RECESSED 70 WATT HIGH PRESSURE SODIUM DOWN LIGHT	LU 70	FLAT PRISMATIC W/ 1/2" IMPACT RESISTANT GLASS PANEL	PROVIDE W/ MEDIUM BRONZE FINISH AND UL DAMP LOCATION LABEL
2	McPHILBEN	43A-6202-MB-RS	ROUND RECESSED 70 WATT HIGH PRESSURE SODIUM DOWN LIGHT	LU 70	FLAT PRISMATIC W/ 1/2" IMPACT RESISTANT GLASS PANEL	PROVIDE W/ MEDIUM BRONZE FINISH AND UL DAMP LOCATION LABEL
3	LEVITON	9575	PORCELAIN ONE PIECE KEYLESS INCANDESCENT FIXTURE	100 W 4-19	NONE	MOUNT ON BOTTOM CHORD OF TRUSS

**ELECTRICAL NOTES**

- CIRCUIT NUMBERS REPRESENT SINGLE POLE CIRCUITS IN THE ELECTRICAL PANEL AND DO NOT CORRESPOND TO ACTUAL PANEL PHASING.
- LOADS ON THE ELECT. PANEL ARE TO BE BALANCED BY THE ELECT. CONTRACTOR AT TIME OF INSTALLATION.
- CIRCUIT BREAKERS FOR RECEPTACLES ARE TO BE GROUND FAULT BREAKERS.
- DEVICE BOXES IN THE PIPE ALLEY STORAGE ROOM AND THE CLOSET ROOM SHALL BE SURFACE MOUNTED. DEVICE BOXES IN ALL OTHER AREAS SHALL BE FLUSH MOUNTED.

**ELECTRICAL AND VENTILATION SYMBOLS AND ABBREVIATIONS**

	INCANDESCENT PORCELAIN FIXTURE	A	AMP
	RECESSED ROUND FIXTURE	C	CONDUIT
	RECESSED SQUARE FIXTURE	CCT	CIRCUIT
	SINGLE POLE SWITCH	CFM	CUBIC FEET PER MINUTE
	SINGLE POLE SWITCH W/ PILOT LIGHT	DN	DOWN
	TIMER	EA	EACH
	CONVENIENCE OUTLET	GRD	GROUND
	NON FUSED DISCONNECT	GFI	GROUND FAULT INTERRUPTER (CIRCUIT-BREAKER)
	MAGNETIC STARTER W/ H-O-A SELECTOR	HOA	HAND-OFF-AUTOMATIC
	PRESSURE SWITCH	HP	HORSE POWER
	ELECTRICAL PANEL	HPS	HIGH PRESSURE SODIUM
	MANUFACTURER'S CONTROL PANEL	P	POLE
	SINGLE PHASE MOTOR	PRV	POWER ROOF VENTILATOR
	EXPOSED CONDUIT	SP	STATIC PRESSURE
	CONCEALED CONDUIT	V	VENT
		W	WIRE
		AC	ABOVE COUNTER
		AFF	ABOVE FINISHED FLOOR

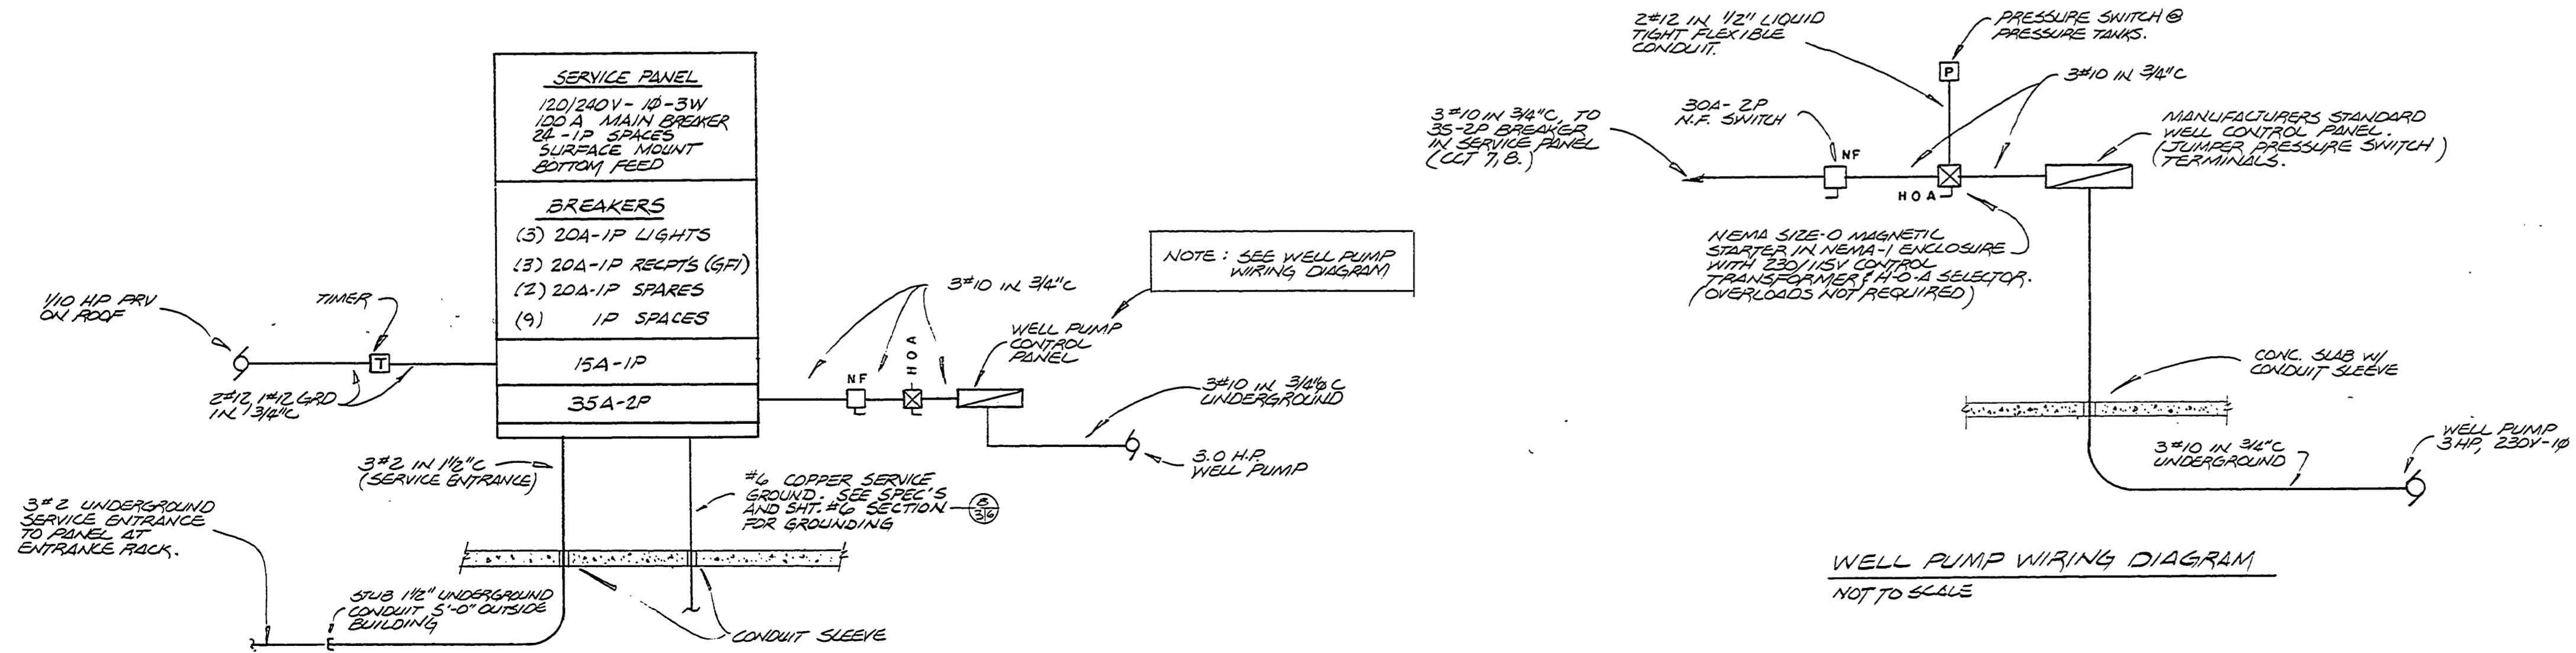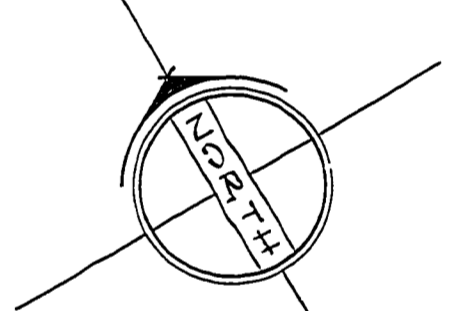

WELL PUMP WIRING DIAGRAM  
NOT TO SCALE

SURVEYED BY	DRAWN BY	NO.	DATE	BY	REVISIONS	NO.	DATE	BY	REVISIONS	MICHIGAN DEPARTMENT OF NATURAL RESOURCES	ELECTRICAL & VENTILATION FLOOR PLANS	SLEEPY HOLLOW STATE PARK TOILET & SHOWER BLDG. PROJECT NORTH CAMPGROUND	PROJECT NO. 24-2588	SHEET 12 OF 21	PLAN NO. A-104
DESIGNED BY	CHECKED BY	1.				3.									
		2.				4.									