

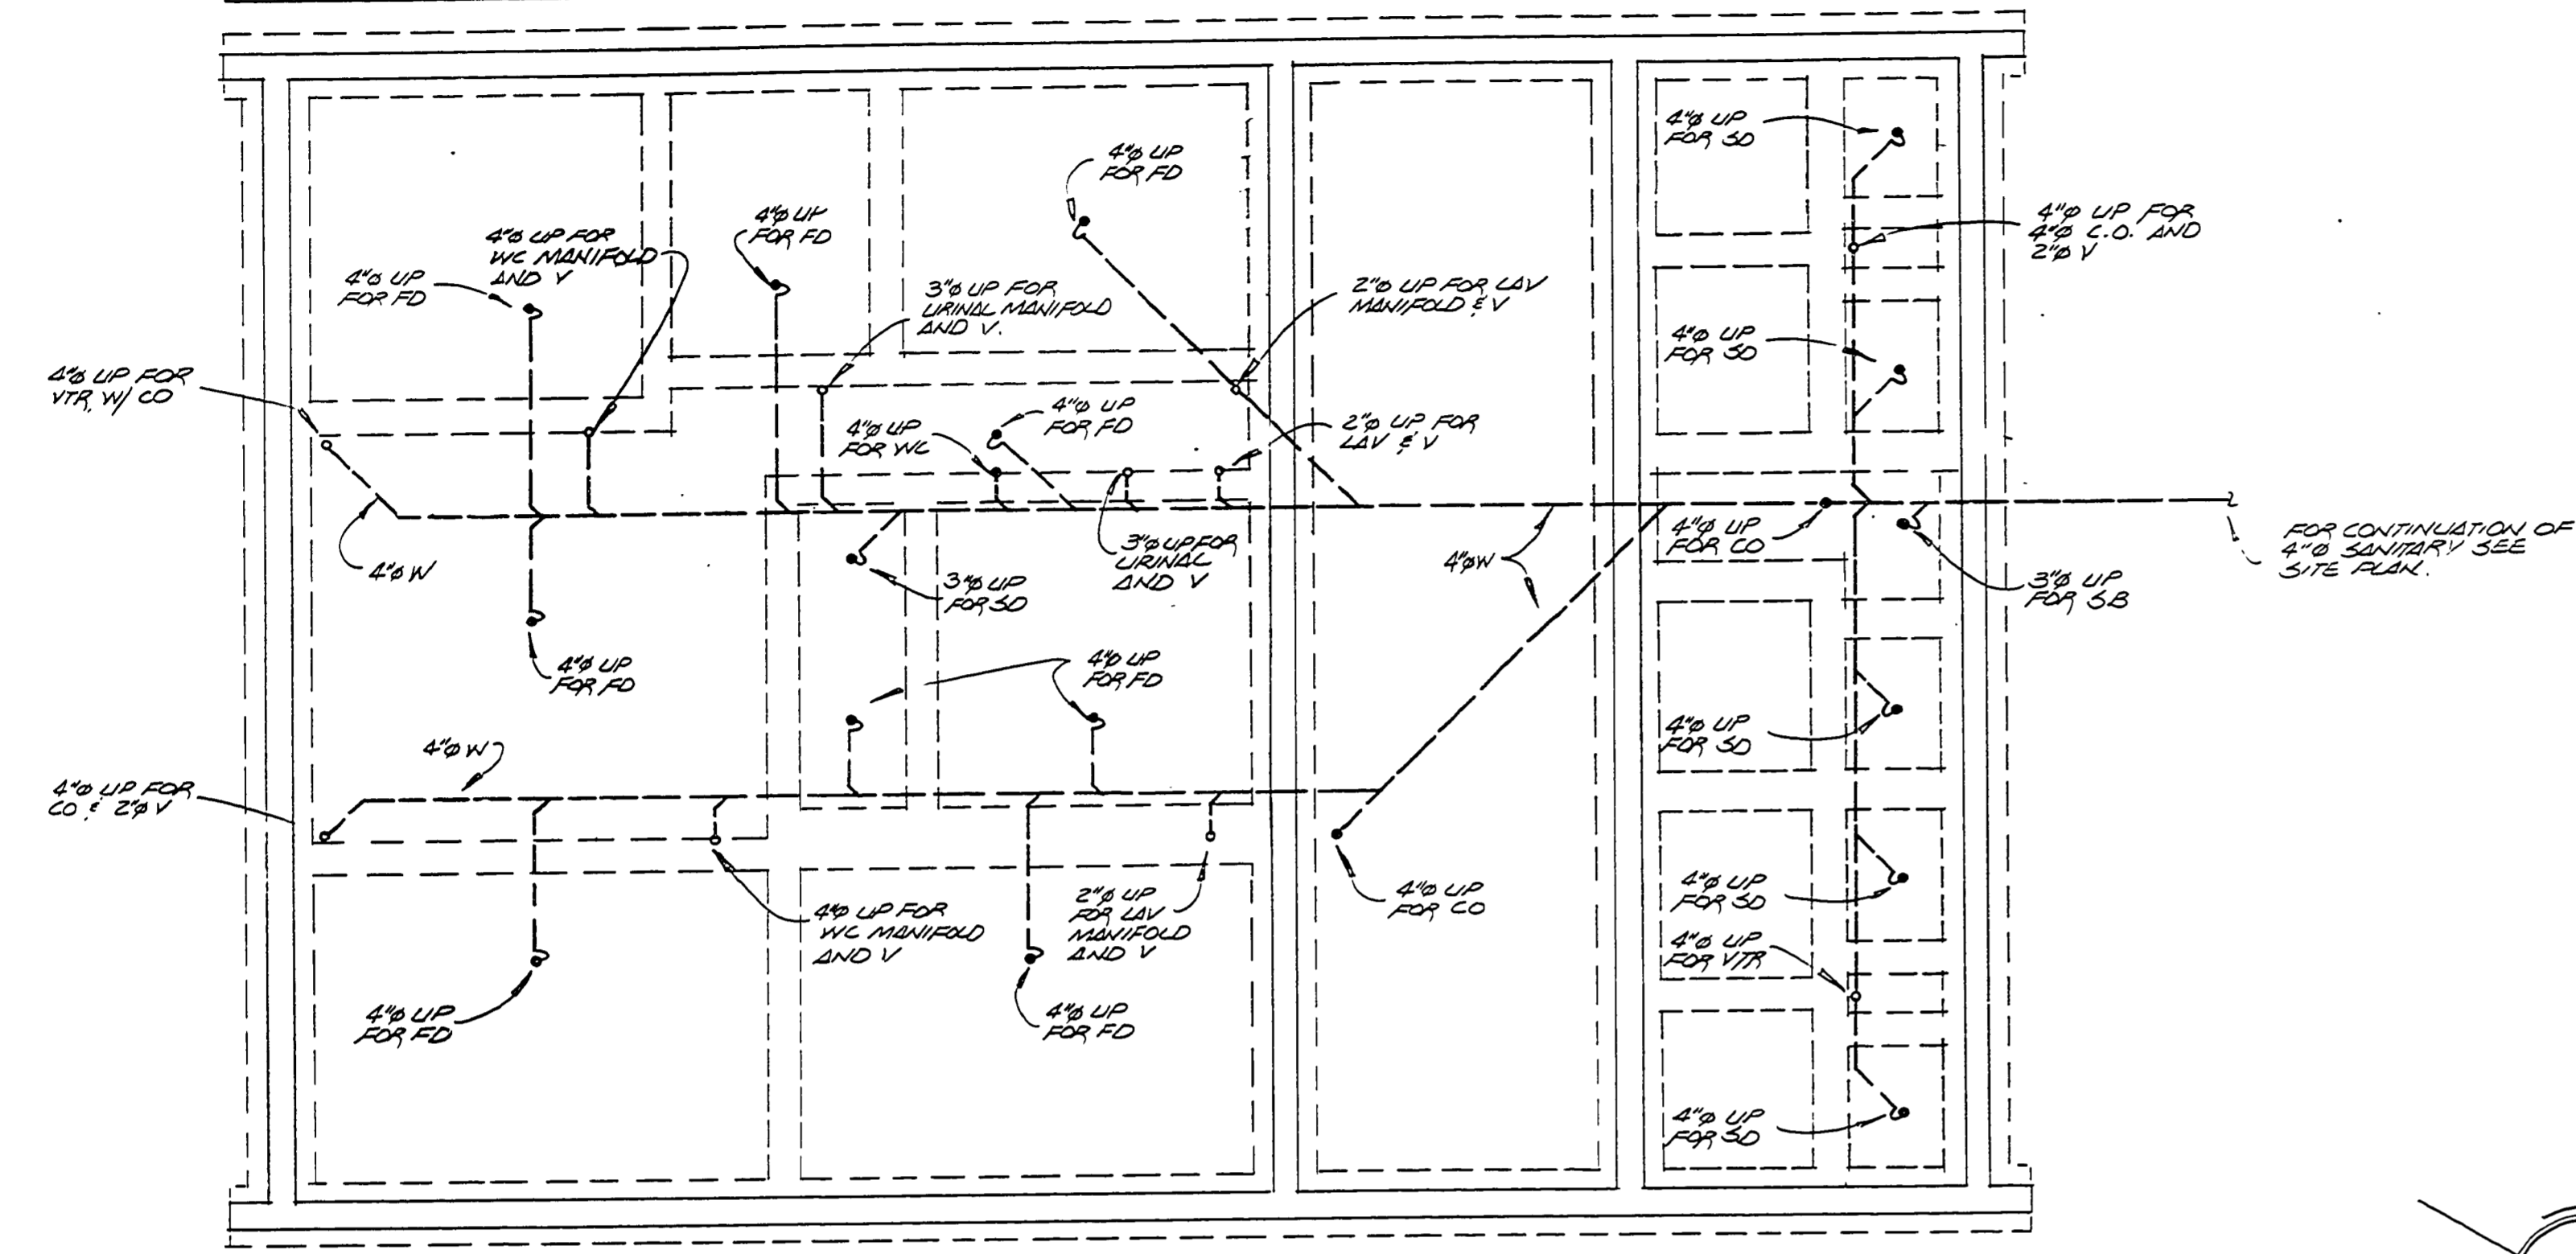


FINISHED FLOOR ELEV. =

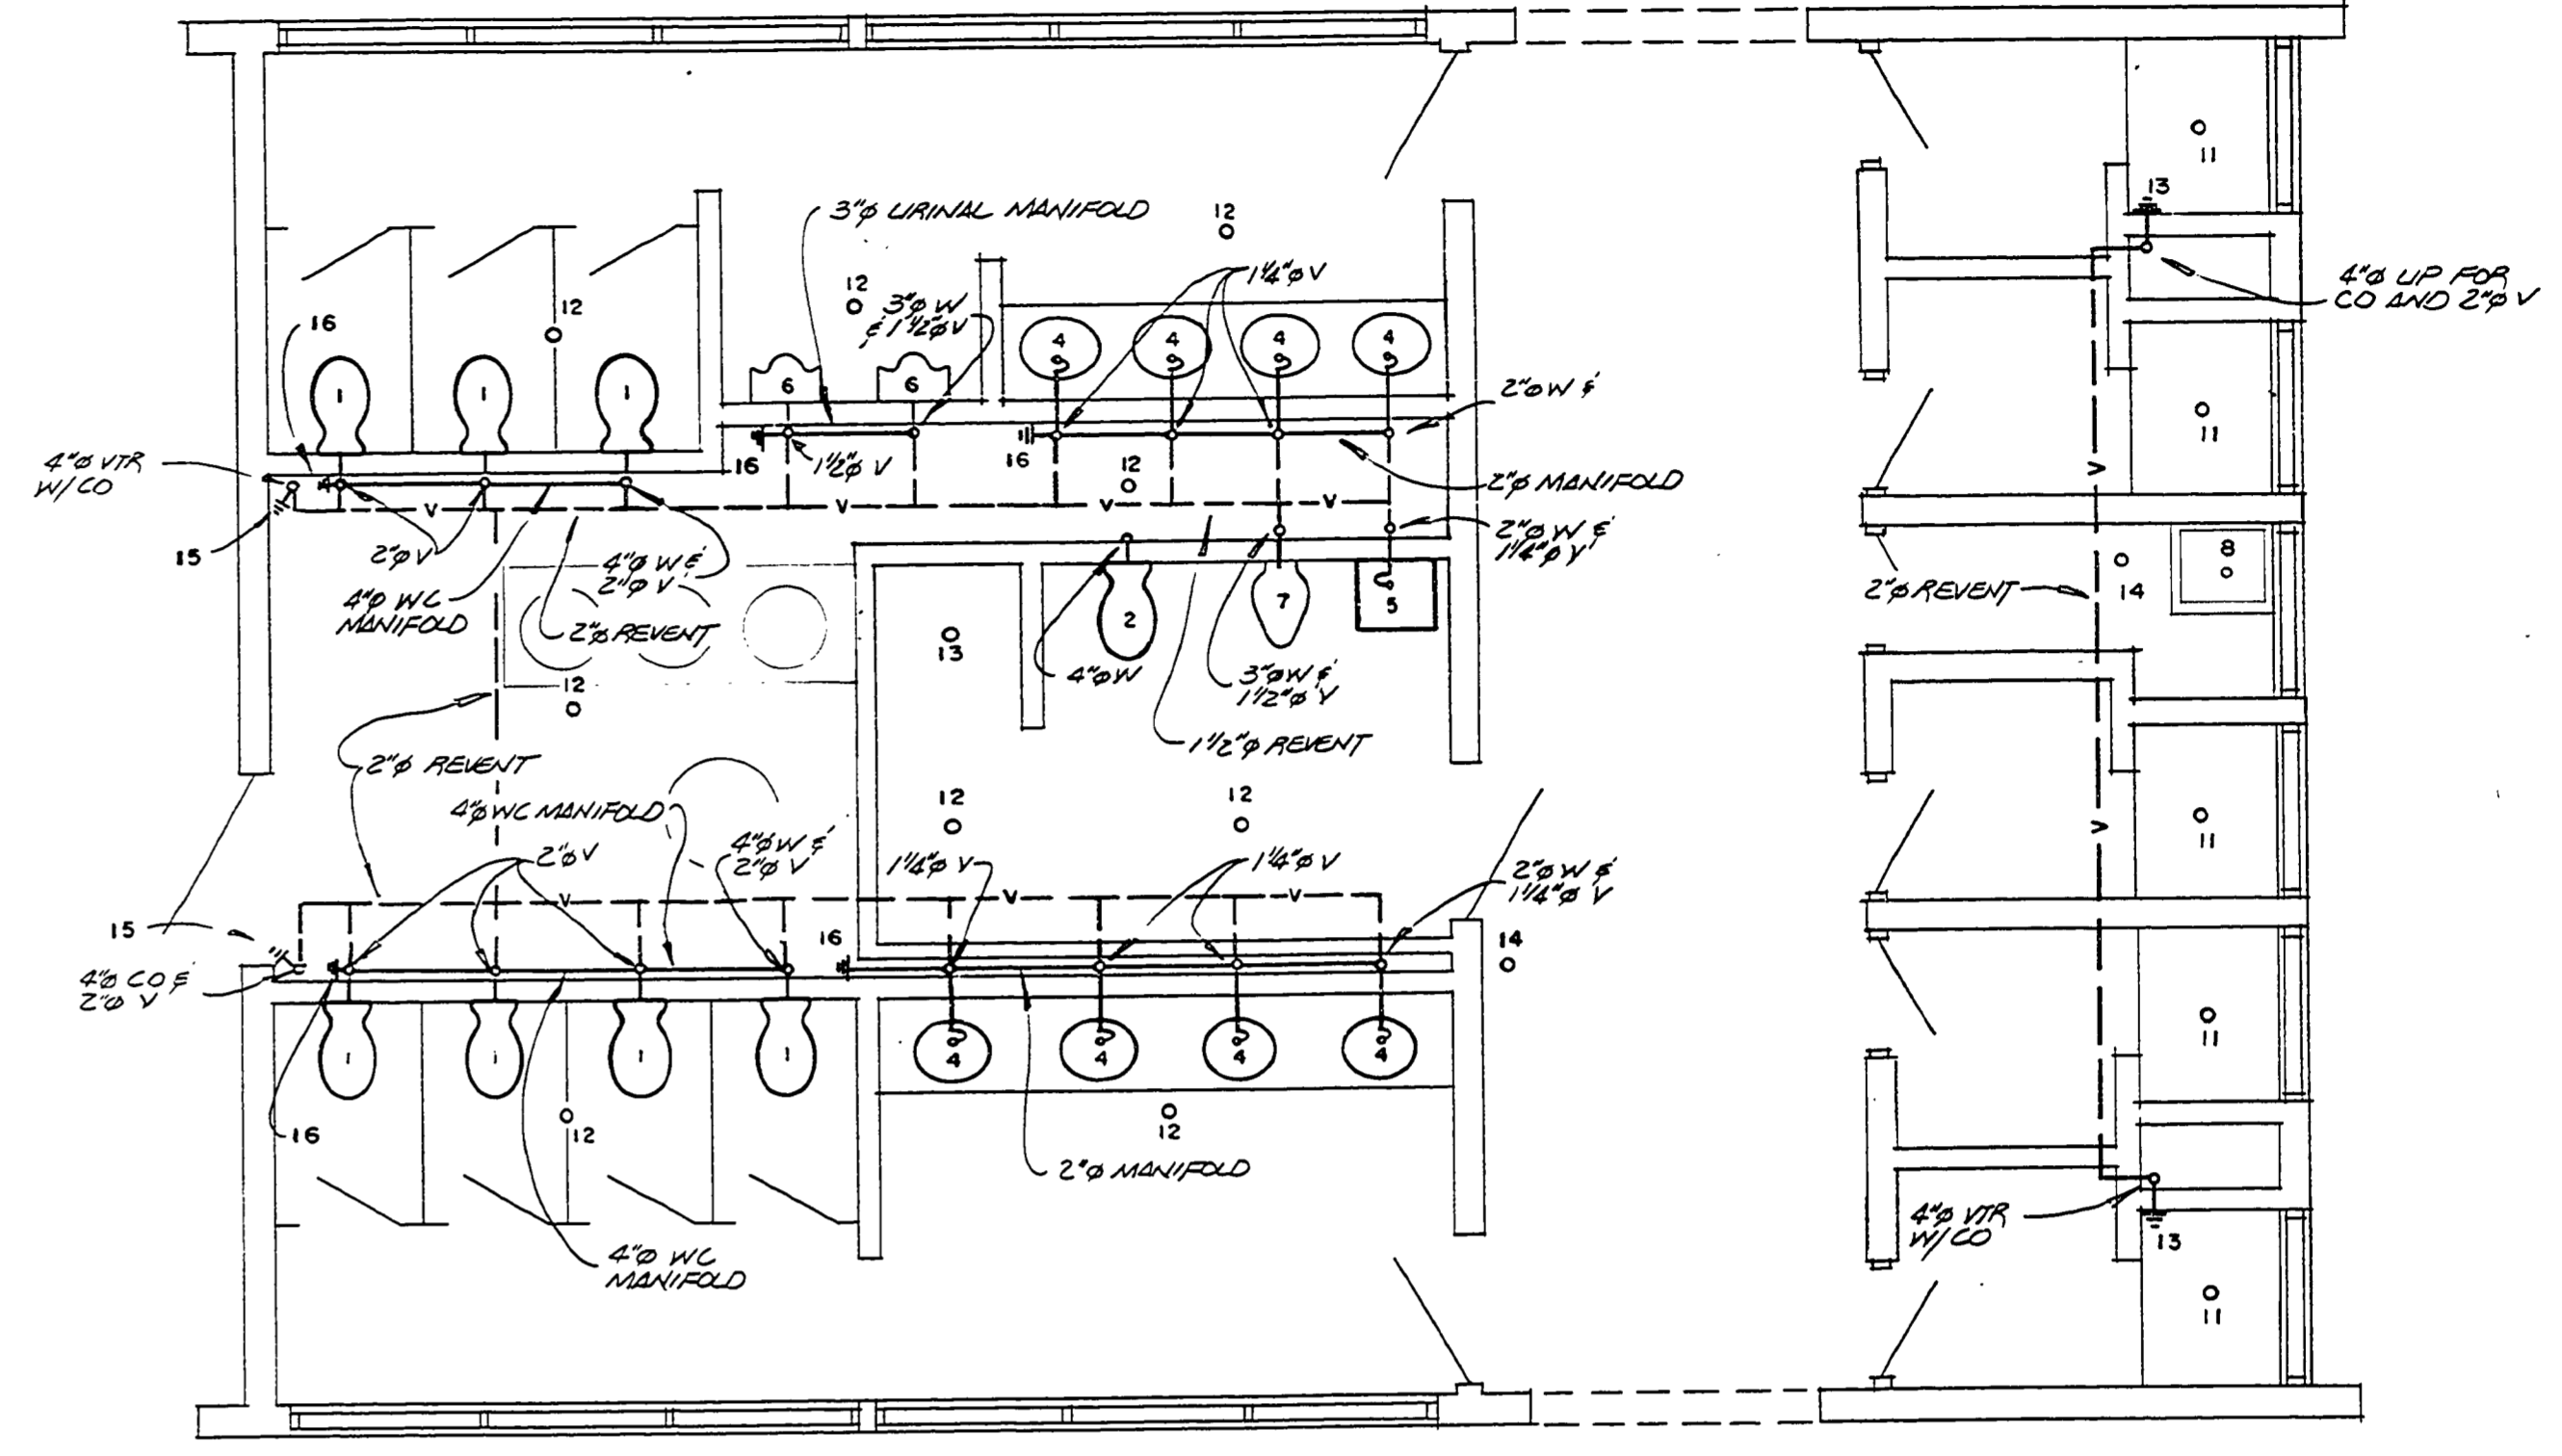

BELOW SLAB WASTE PLUMBING PLAN
SCALE 1/8" = 1'-0"

NOTE: MAINTAIN 1/4" PER FOOT SLOPE MIN. FOR SANITARY WITHIN BLDG.

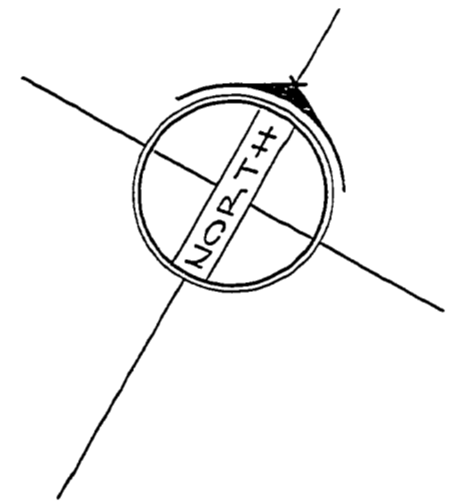

ABOVE SLAB WASTE PLUMBING PLAN
SCALE 1/4" = 1'-0"

NOTE: ALL REVENTS TO BE ABOVE CEILINGSS OR 1'-0" AFF MIN. IN EXPOSED AREAS.

PLUMBING SCHEDULE				
FIXTURE	NO.	WASTE	CW	HW
WATER CLOSET	1	4"	1"	—
WATER CLOSET	2	4"	1"	—
SHOWER	3	—	1/2"	1/2"
LAVATORY	4	1 1/2"	1/2"	1/2"
LAVATORY	5	1 1/2"	1/2"	1/2"
URINAL	6	3"	3/4"	—
URINAL	7	3"	1"	—
SERVICE BASIN	8	3"	1/2"	1/2"
WALL HYDRANT	9	—	3/4"	—
HOSE BIBB	10	—	1/2"	—
SHOWER DRAIN	11	4"	—	—
FLOOR DRAIN	12	4"	—	—
CONCEALED STACK CLEAN OUT	13	4"	—	—
FLOOR CLEAN OUT	14	4"	—	—
EXPOSED STACK CLEANOUT	15	4"	—	—
MANIFOLD CLEANOUT	16	*	—	—

* SAME SIZE AS MANIFOLD

PLUMBING SYMBOLS & ABBREVIATIONS

	GATE VALVE	CO	CLEANOUT
	UNION	CW	COLD WATER
	CHECK VALVE	DF	DRINKING FOUNTAIN
	THERMOMETER	FD	FLOOR DRAIN
	CAPPED STANDPIPE	HW	HOT WATER
	STRAINER W/VALVE	LAV	LAVATORY
	TRAP	SD	SHOWER DRAIN
	STACK CLEANOUT	V	VENT
	VENT LINE	VTR	VENT THRU ROOF
	MIXING VALVE	W	WASTE
	TEMPERATURE AND PRESSURE RELIEF VALVE	WC	WATER CLOSET
	COLD WATER LINE	WH	WATER HEATER
	HOT WATER LINE	SB	SERVICE BASIN

SURVEYED BY	DRAWN BY	NO.	DATE	BY	REVISIONS	NO.	DATE	BY	REVISIONS	MICHIGAN DEPARTMENT OF NATURAL RESOURCES	WASTE PLUMBING FLOOR PLANS	SLEEPY HOLLOW STATE PARK TOILET & SHOWER BLDG. PROJECT SOUTH CAMPGROUND	PROJECT NO. 24-2588
DESIGNED BY	CHECKED BY	1.				3.					SHEET TITLE		SHEET 19 OF 21
	DATE	2.				4.							PLAN NO. 1-104