
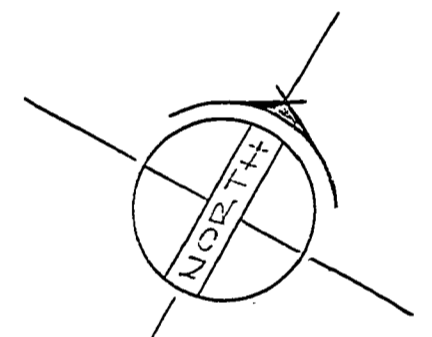
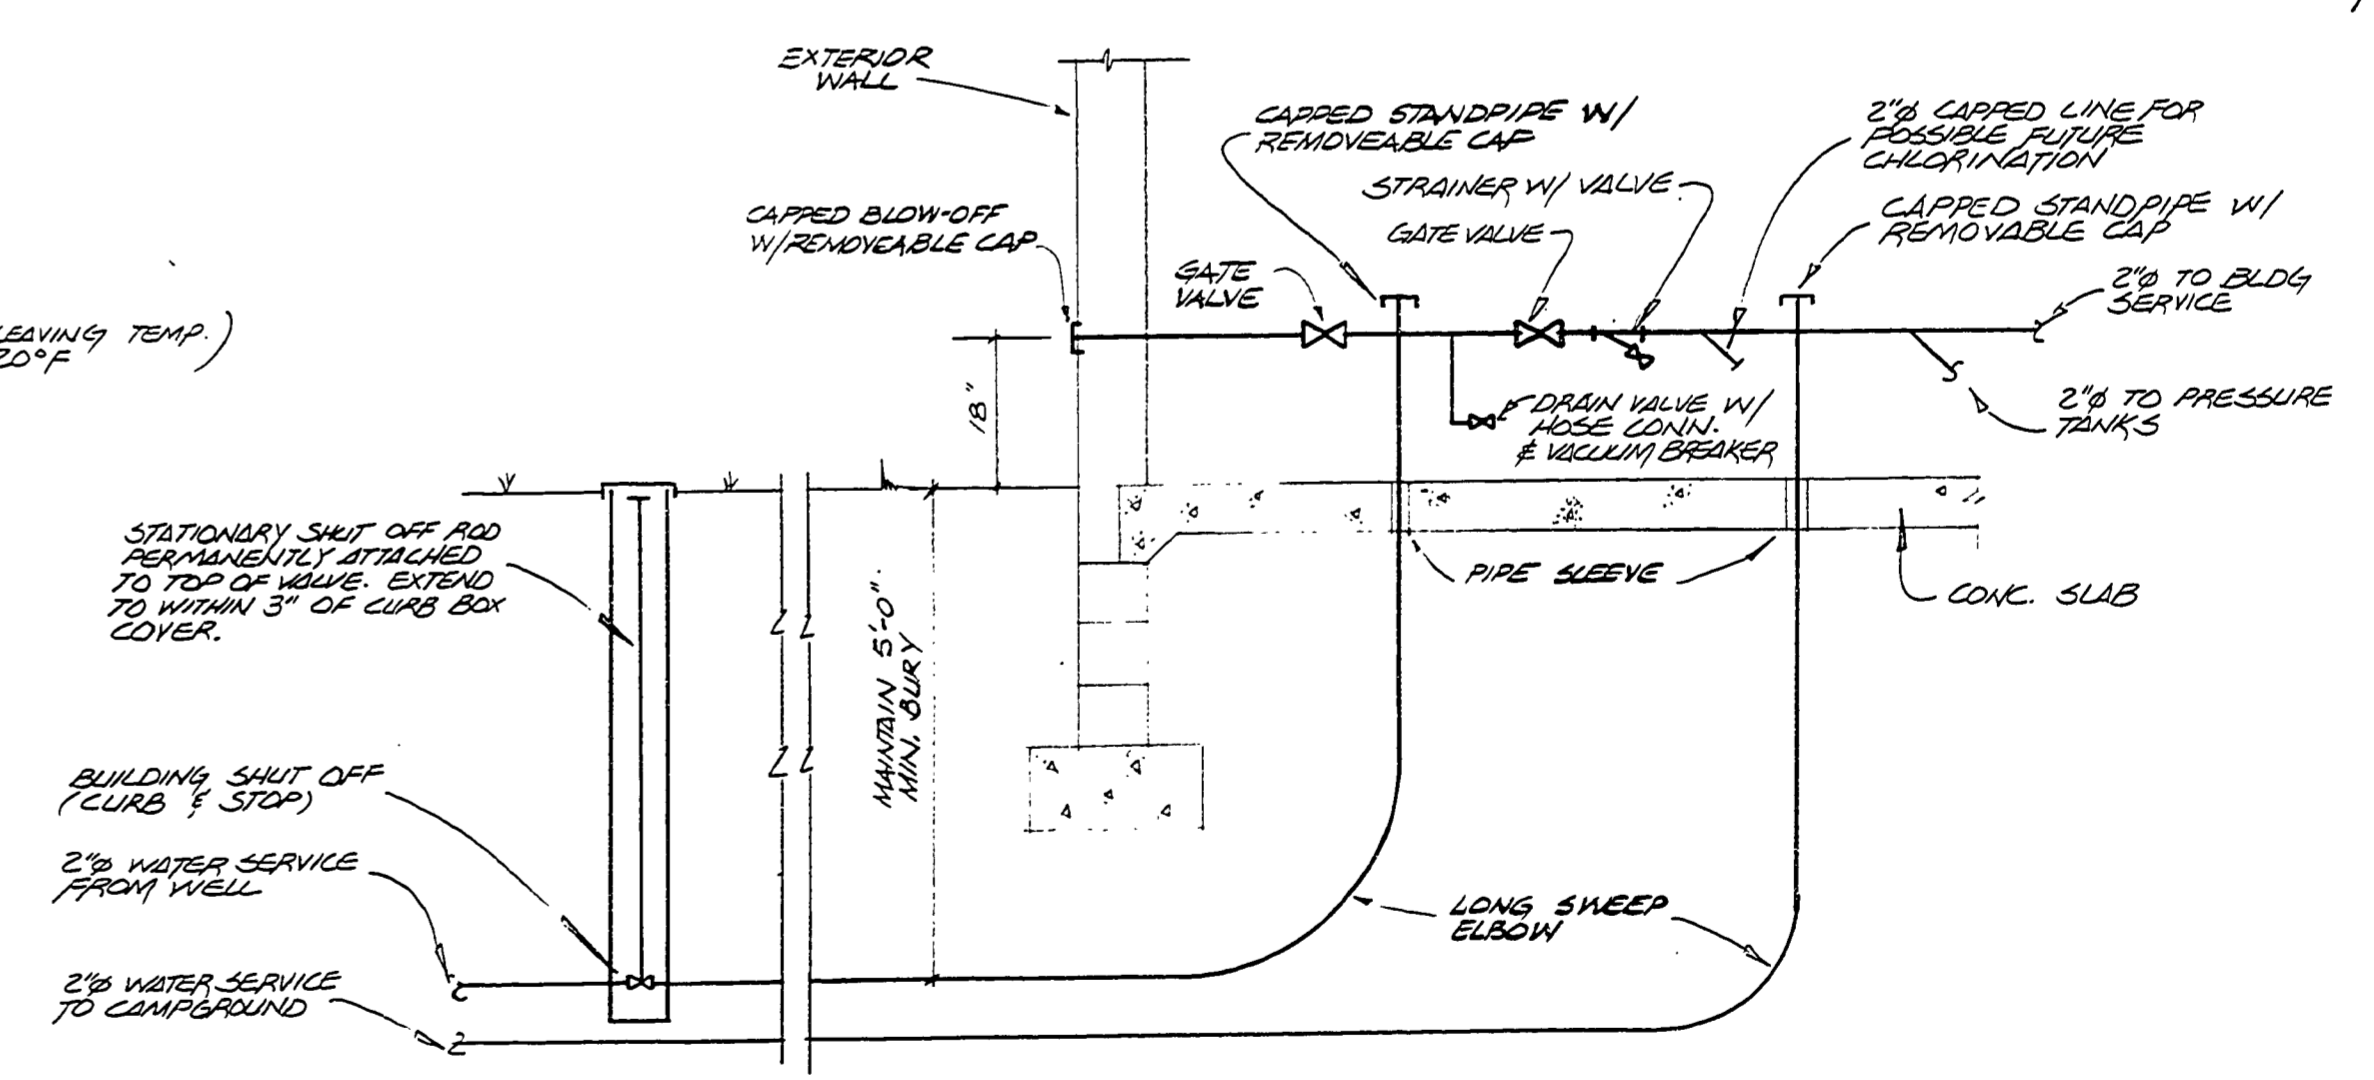
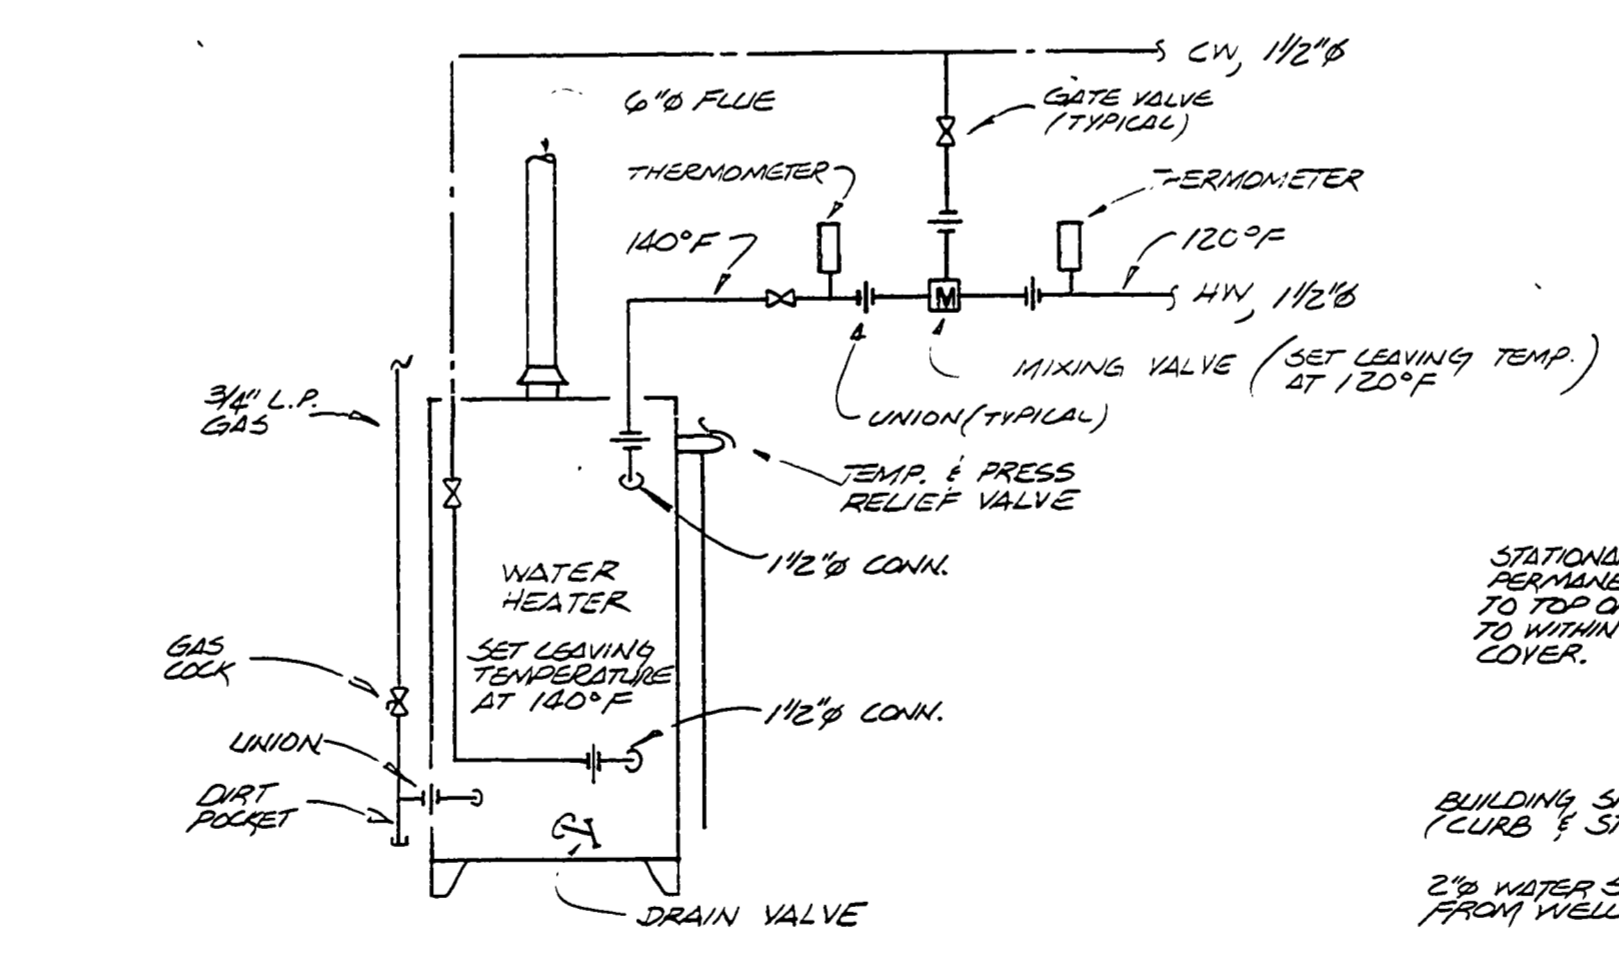
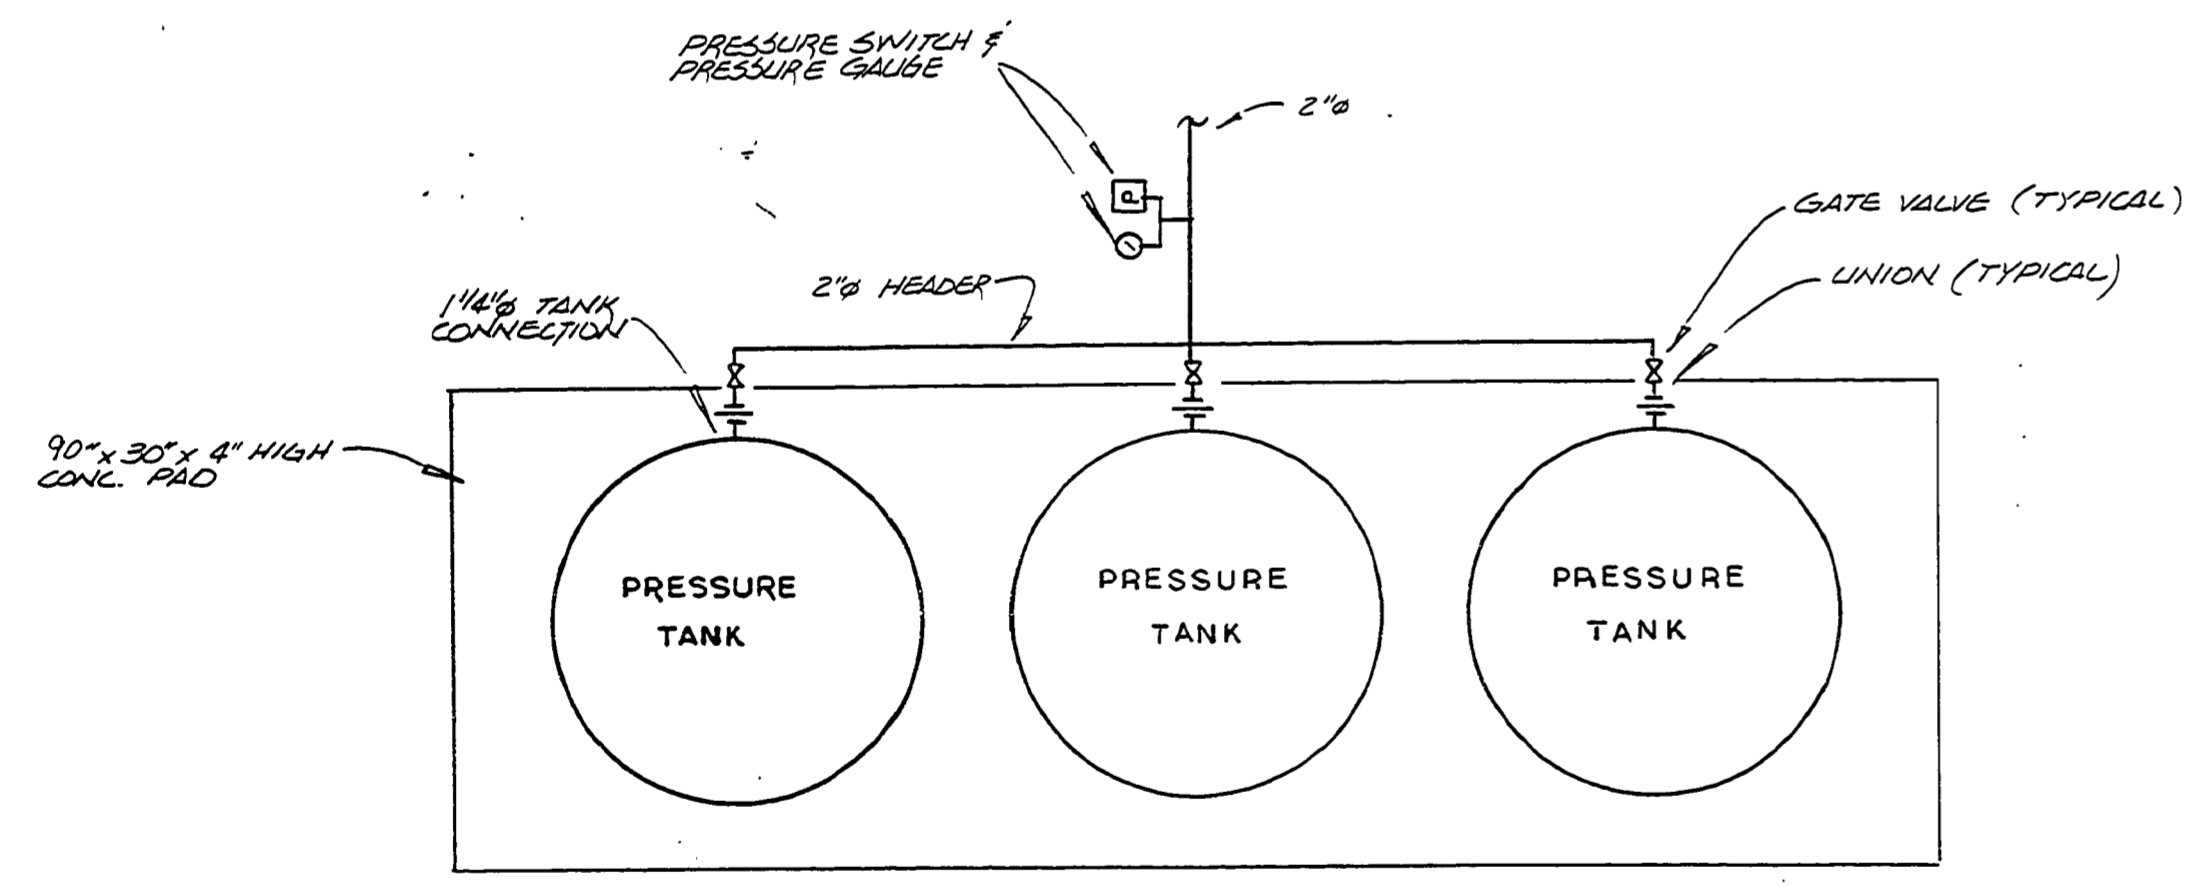


PLUMBING SCHEDULE				
FIXTURE	NO.	WASTE	CW	HW
WATER CLOSET	1	4"	1"	—
WATER CLOSET	2	4"	1"	—
SHOWER	3	—	1/2"	1/2"
LAVATORY	4	1 1/4"	1/2"	1/2"
LAVATORY	5	1 1/4"	1/2"	1/2"
URINAL	6	3"	3/4"	—
URINAL	7	3"	1"	—
SERVICE BASIN	8	3"	1/2"	1/2"
WALL HYDRANT	9	—	3/4"	—
HOSE B/SS	10	—	1/2"	—
SHOWER DRAIN	11	4"	—	—
FLOOR DRAIN	12	4"	—	—
CONCEALED STACK CLEANOUT	13	4"	—	—
FLOOR CLEANOUT	14	4"	—	—
EXPOSED STACK CLEANOUT	15	4"	—	—
MANIFOLD CLEANOUT	16	*	—	—

* SAME SIZE AS MANIFOLD
NOTE: FOR MOUNTING HTS SEE ELEVATIONS, SHT. NOS 3 & 4.

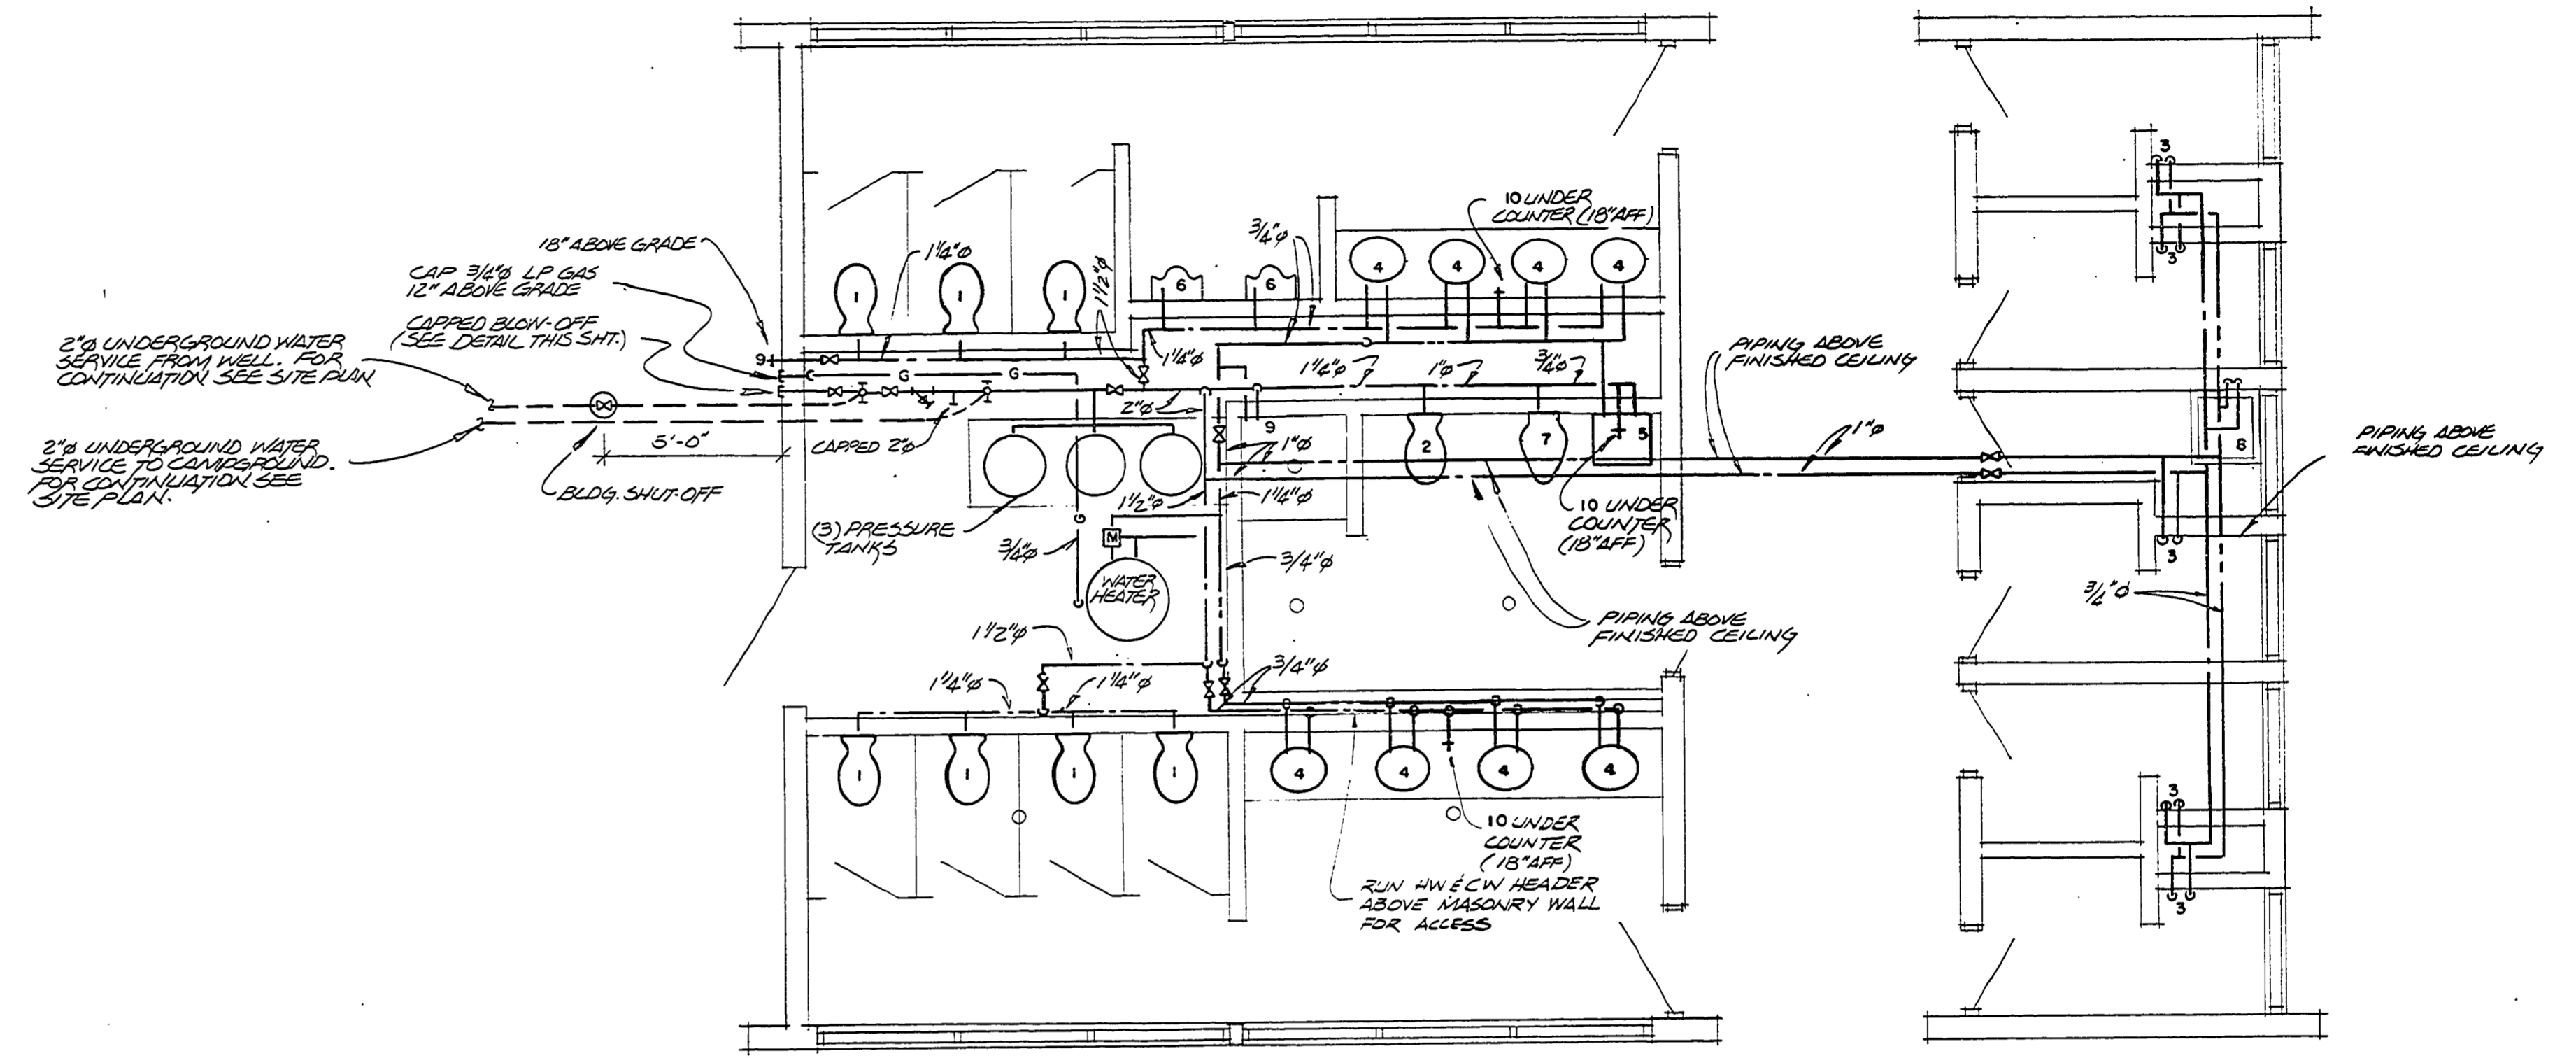

SURVEYED BY	DRAWN BY	NO.	DATE	BY	REVISIONS	NO.	DATE	BY	REVISIONS	MICHIGAN DEPARTMENT OF NATURAL RESOURCES	DOMESTIC WATER SUPPLY PLAN	SLEEPY HOLLOW STATE PARK TOILET & SHOWER BLDG. PROJECT SOUTH CAMPGROUND	PROJECT No. 24-2588
DESIGNED BY	CHECKED BY	1.				3.					SHEET TITLE		SHEET 20 OF 21
	DATE	DATE				4.							PLAN No. A-104