


SLEEPY HOLLOW STATE PARK

BEACHHOUSE & ENTRANCE BLDG.

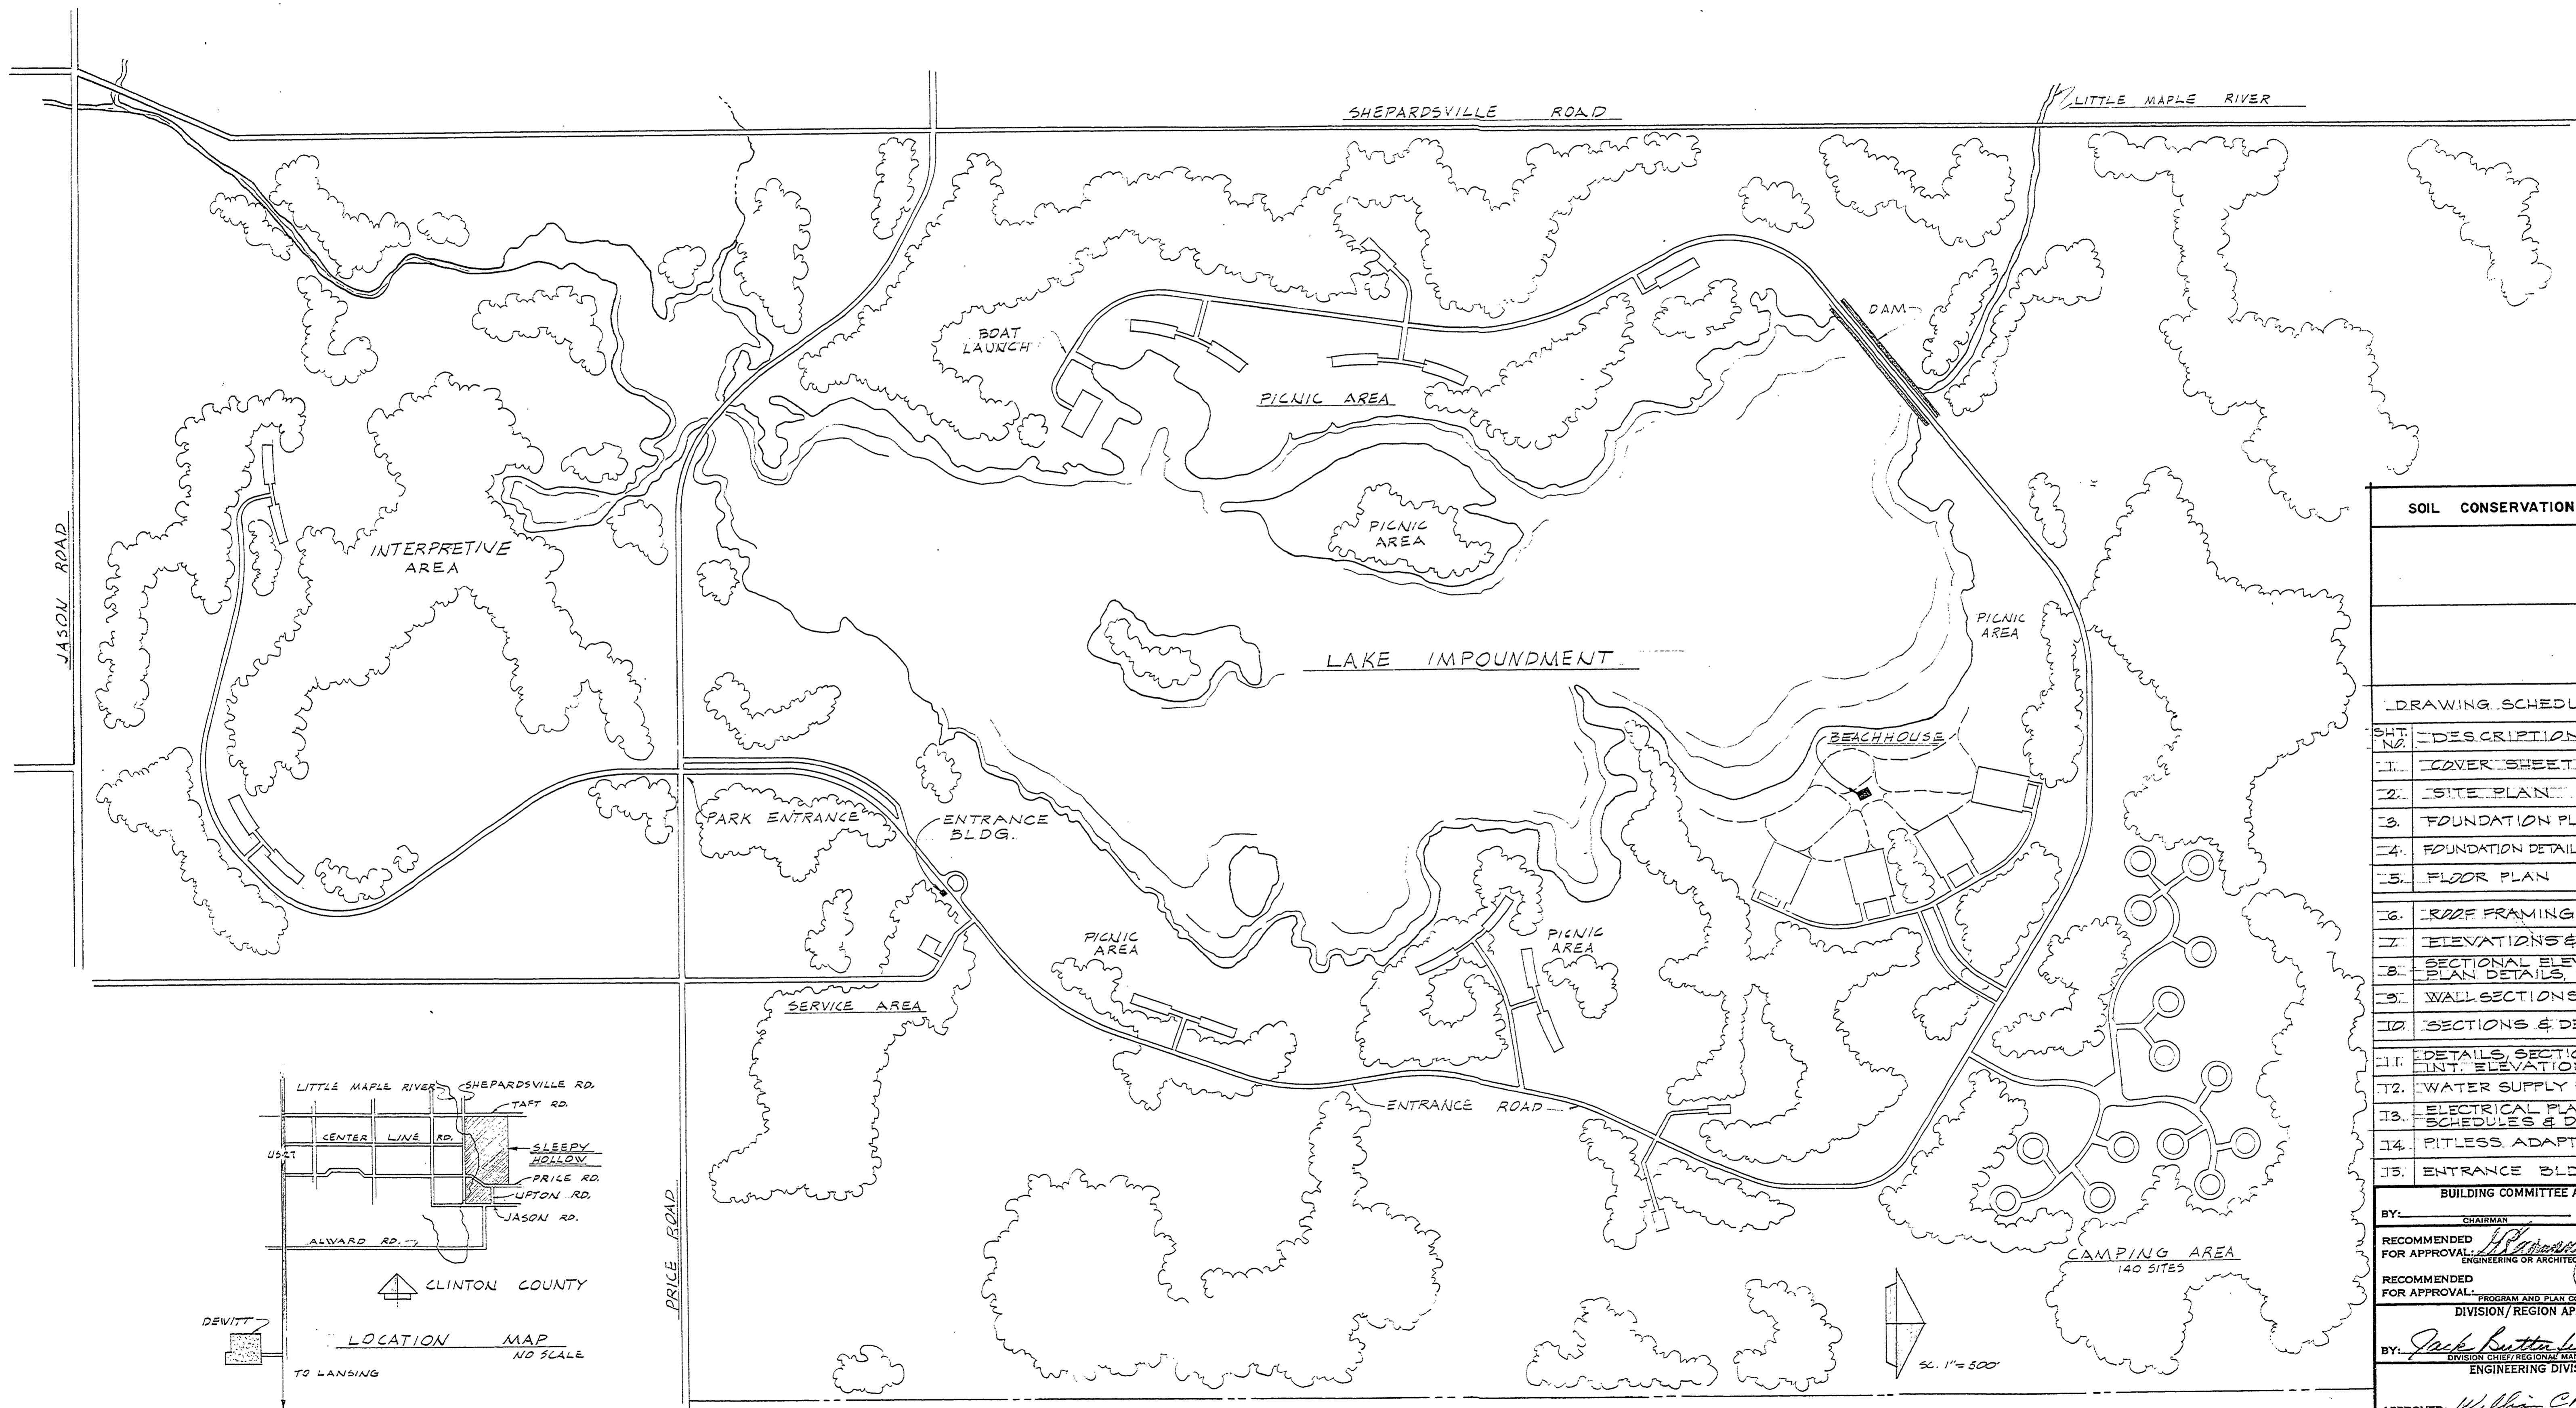

SOIL CONSERVATION SERVICE	
DRAWING SCHEDULE	
SHT. NO.	DESCRIPTION
1.	COVER SHEET
2.	SITE PLAN
3.	FOUNDATION PLAN & DETAILS
4.	FOUNDATION DETAILS + SCHEDULES
5.	FLOOR PLAN
6.	ROOF FRAMING PLAN
7.	ELEVATIONS & DETAILS
8.	SECTIONAL ELEVATIONS, PLAN DETAILS
9.	WALL SECTIONS & DETAILS
10.	SECTIONS & DETAILS
11.	DETAILS, SECTIONS, INT. ELEVATIONS
12.	WATER SUPPLY PLUMBING
13.	ELECTRICAL PLAN, SCHEDULES & DETAILS
14.	PITLESS ADAPTER TANK
15.	ENTRANCE BLDG.
BUILDING COMMITTEE APPROVAL	
BY: _____	CHAIRMAN DATE _____
RECOMMENDED FOR APPROVAL: _____	ENGINEERING OR ARCHITECTURAL SUPERVISOR DATE 12/17/76
RECOMMENDED FOR APPROVAL: _____	PROGRAM AND PLAN COORDINATOR DATE _____
DIVISION/REGION APPROVAL	
BY: <i>Jack Butcher</i>	DIVISION CHIEF/REGIONAL MANAGER DATE 12-28-76
ENGINEERING DIVISION	
APPROVED: <i>William Chas.</i>	CHIEF ENGINEER DATE 12-28-76

SURVEYED BY	DRAWN BY <i>G. TOMPKINS</i>	8/76	NO.	DATE	BY	REVISIONS	NO.	DATE	BY	REVISIONS	MICHIGAN DEPARTMENT OF NATURAL RESOURCES	COVER SHEET SHEET TITLE	SLEEPY HOLLOW STATE PARK AREA OR PARK	PROJECT NO. 21-5530
DESIGNED BY	CHECKED BY	DATE	1.				3.						BEACHHOUSE & ENTRANCE BLDG. PROJECT	SHEET 1 OF 15 PLAN NO. A-101
			2.				4.							