


**DOOR SCHEDULE**

MARK TYPE SIZE MATL. COMMENTS




1	A	3'-0" x 7'-0"	
2	C	3'-0" x 7'-0"	
3	B	3'-0" x 7'-0"	
4	A	3'-0" x 7'-0"	
5	B	3'-0" x 7'-0"	
6	A	3'-0" x 7'-0"	
7	A	3'-0" x 7'-0"	
8	C	3'-0" x 7'-0"	

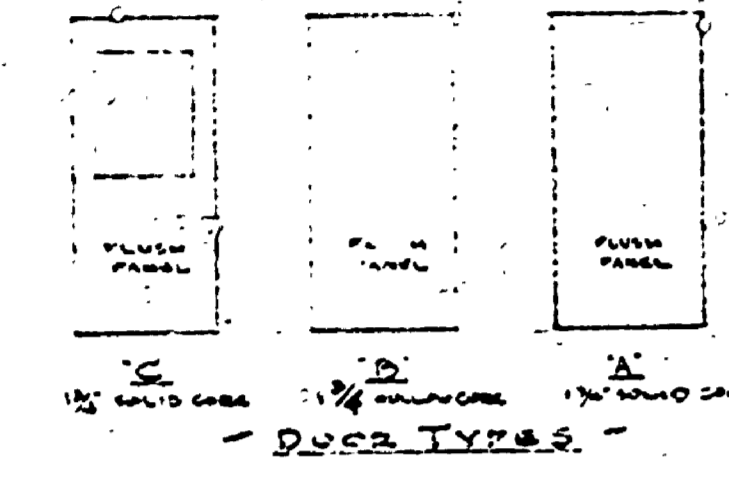



**WINDOW SCHEDULE**

MARK UNIT NO. SIZE H. REMARKS




A	3	3'-0" x 7'-0"	WOODEN FRAME UNIT
B	2	3'-0" x 7'-0"	BASIC
C	1	3'-0" x 7'-0"	UNIT

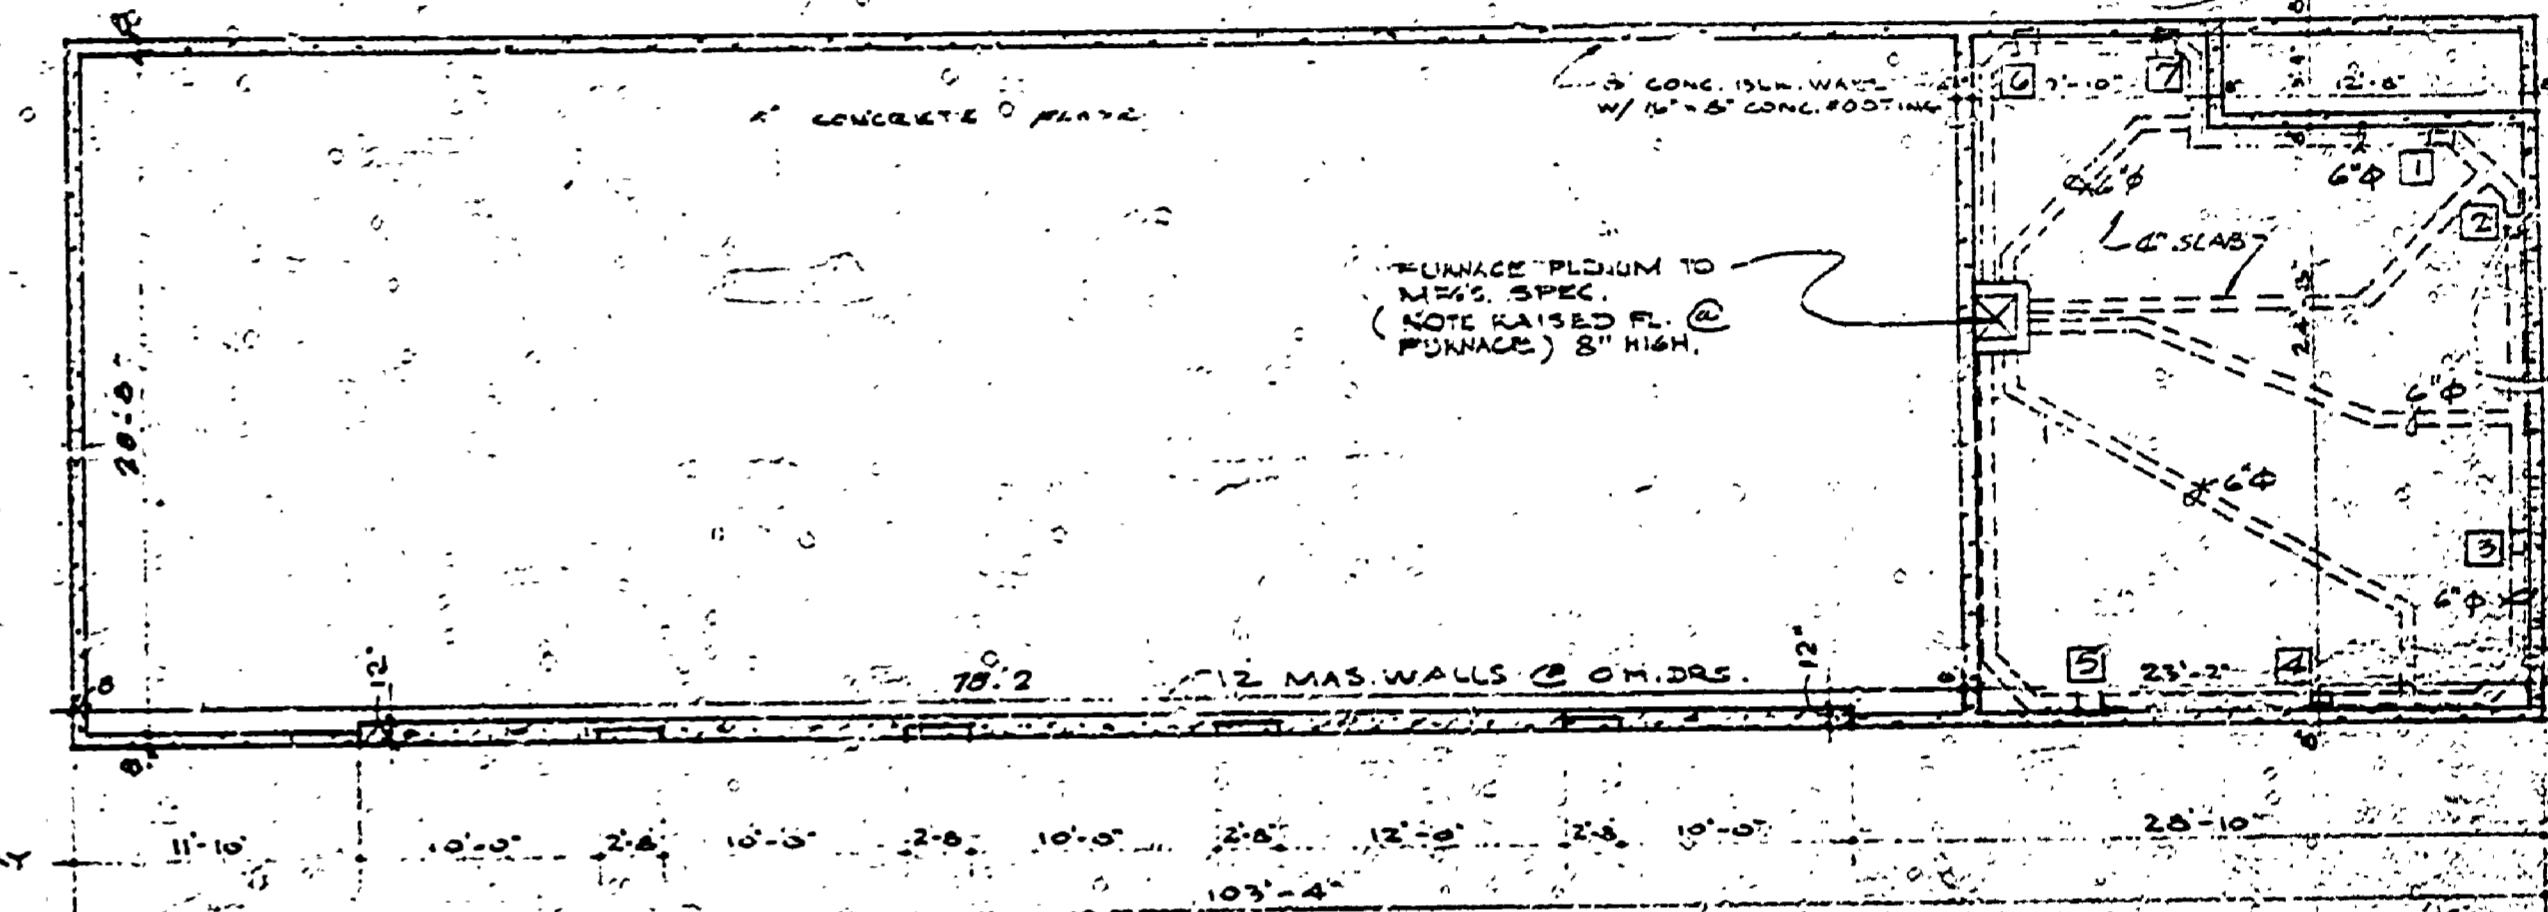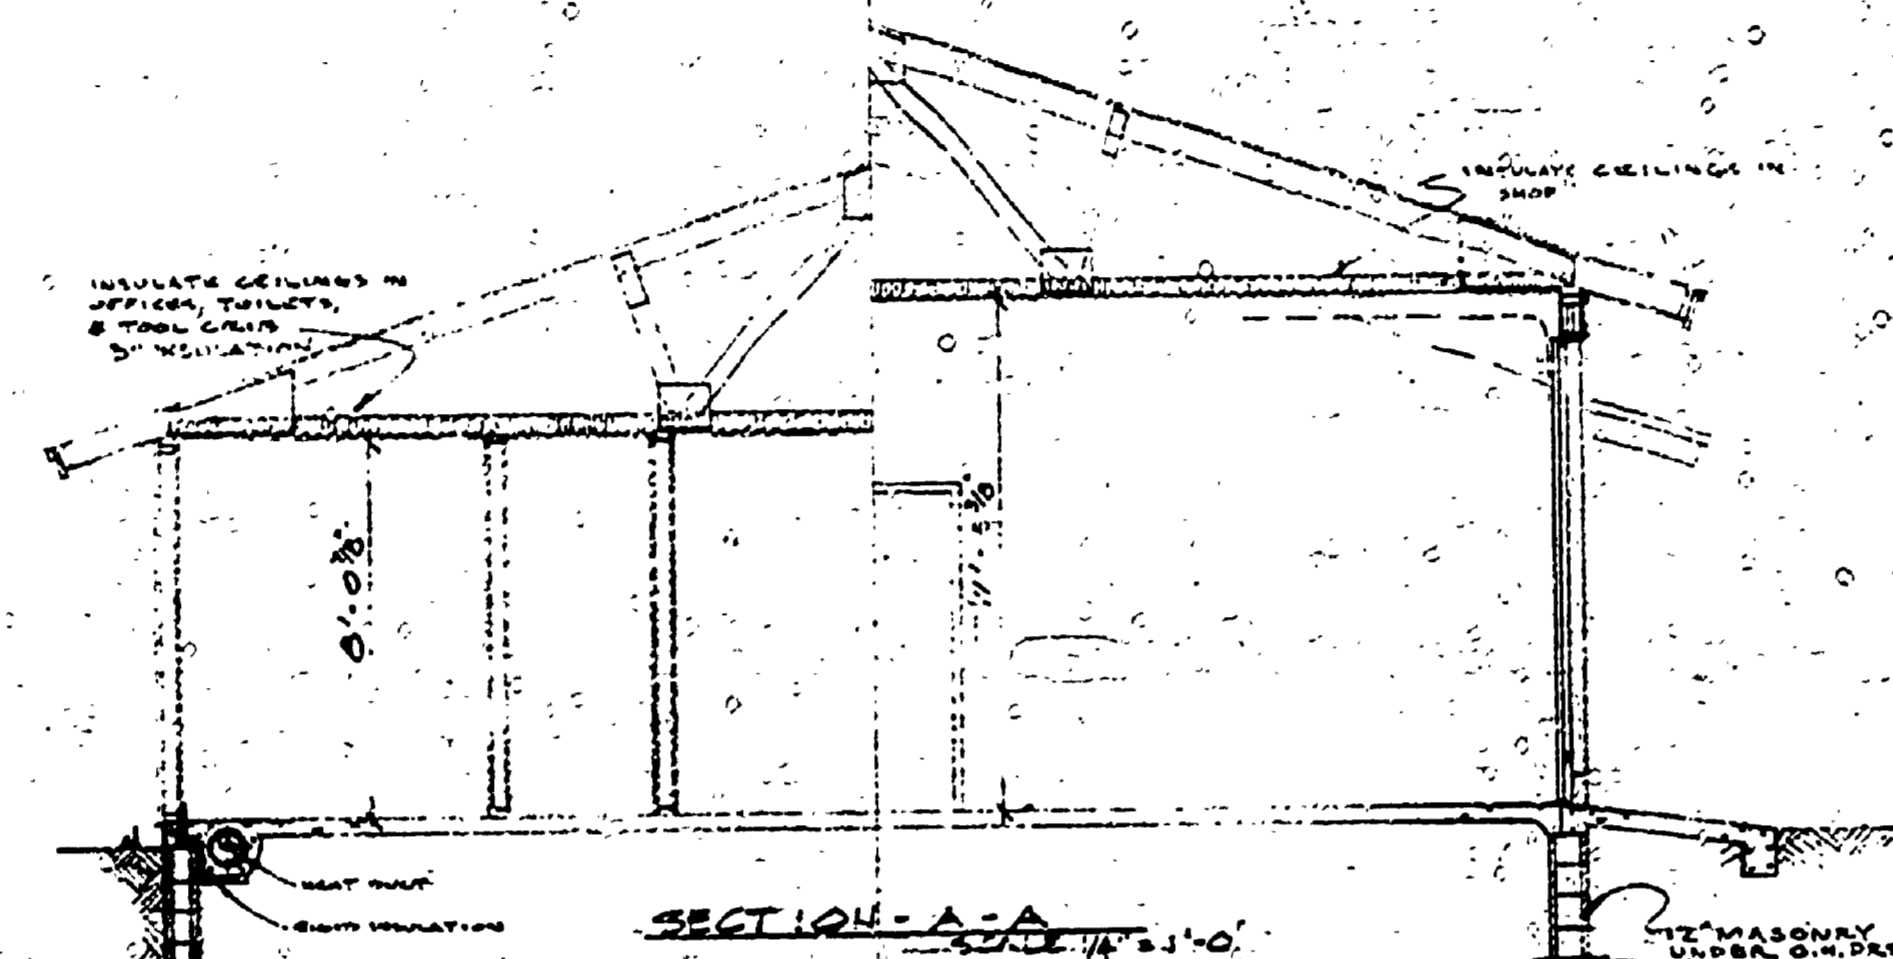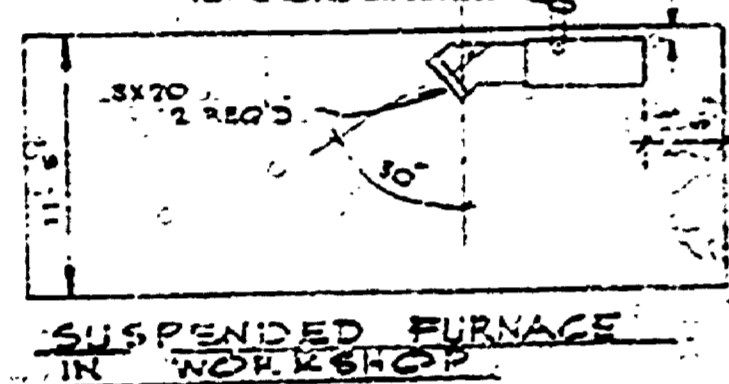

NOTE: For Rough Opening Add 1/2" to Basic Unit W.D.T. Deduct 3/8" from R.C.U. H.T.C. See Window Det. Sht. 2.

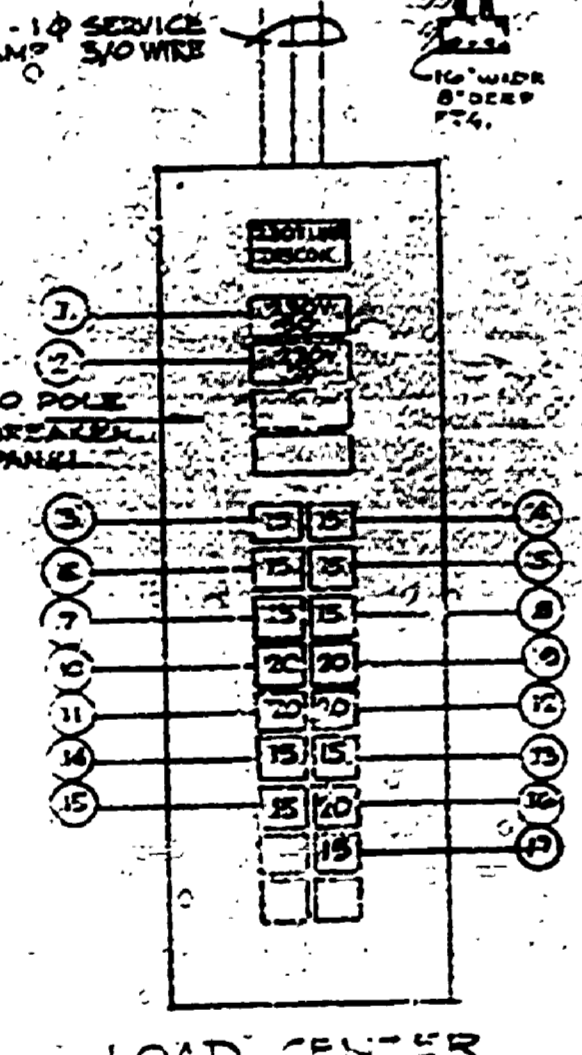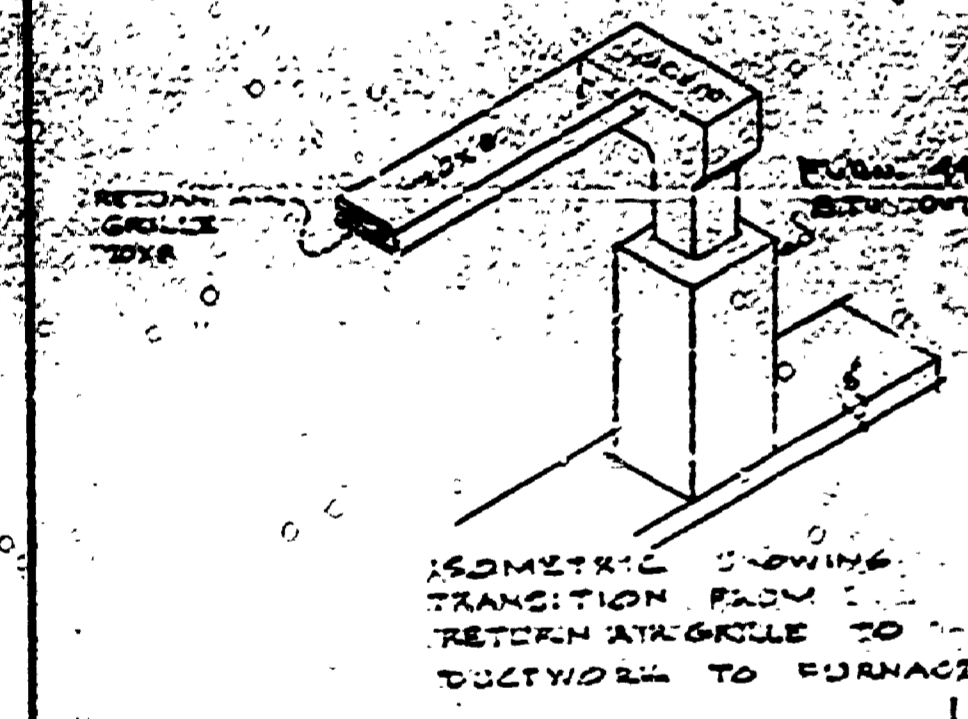

- CIRCUITS**
- 1 230V. SHOP OUTLET FOR WELDER
  - 2 230V. POWER TOOL
  - 3 115V. FRONT OFFICE & WALL LIGHTING
  - 4 115V. REAR OFFICE PORCH & TOILET LIGHTING
  - 5 115V. TOOL CRIB LIGHTING & GENERAL WORKSHOP
  - 6 115V. WORKSHOP LIGHTING (2 FIXTURES)
  - 7 115V. GARAGE LIGHTING (2 FIXTURES)
  - 8 115V. GARAGE LIGHTING (2 FIXTURES)
  - 9 115V. TOP RECEPTACLE CONVENIENCE OUTLETS FOR OFFICE PORCH & REAR
  - 10 115V. BOTTOM RECEPTACLE CONVENIENCE OUTLETS FOR OFFICE
  - 11 115V. CONV. OUTLETS TOOL CRIB & TOILETS
  - 12 115V. CONV. OUTLETS FOR SHOP
  - 13 115V. OFFICE FURNACE CONTROL
  - 14 115V. OFFICE FURN. FAN CONTROLLER & POWER HUMIDIFIER
  - 15 115V. SHOP FURNACE CONTROLLER
  - 16 115V. SHOP FURNACE FAN CONTROLLER
  - 17 115V. FOR WATER HEATER

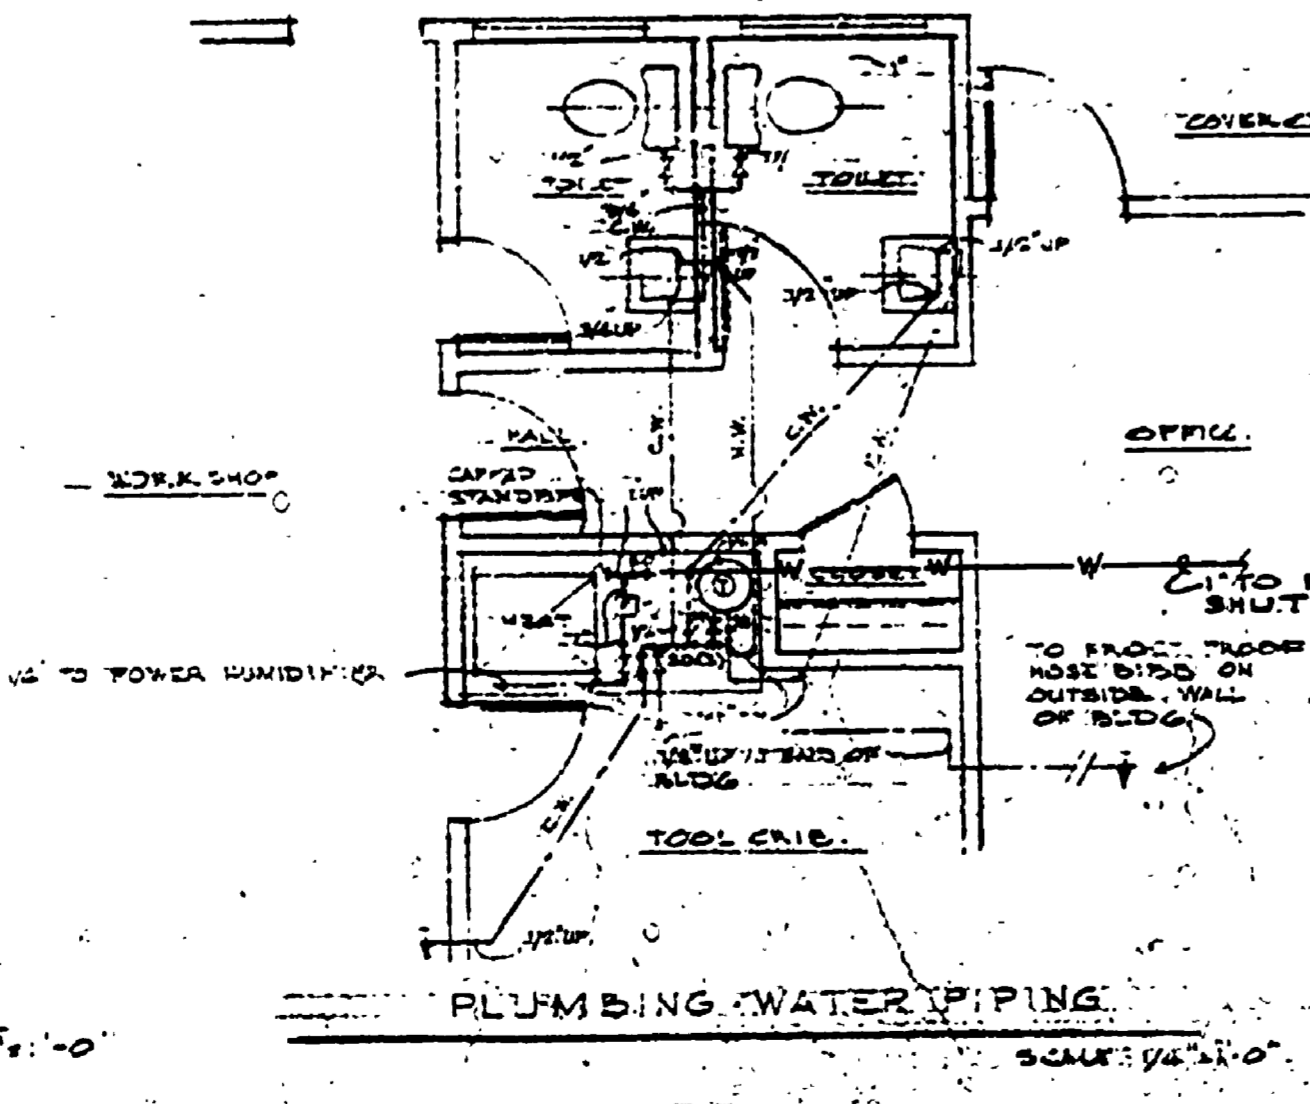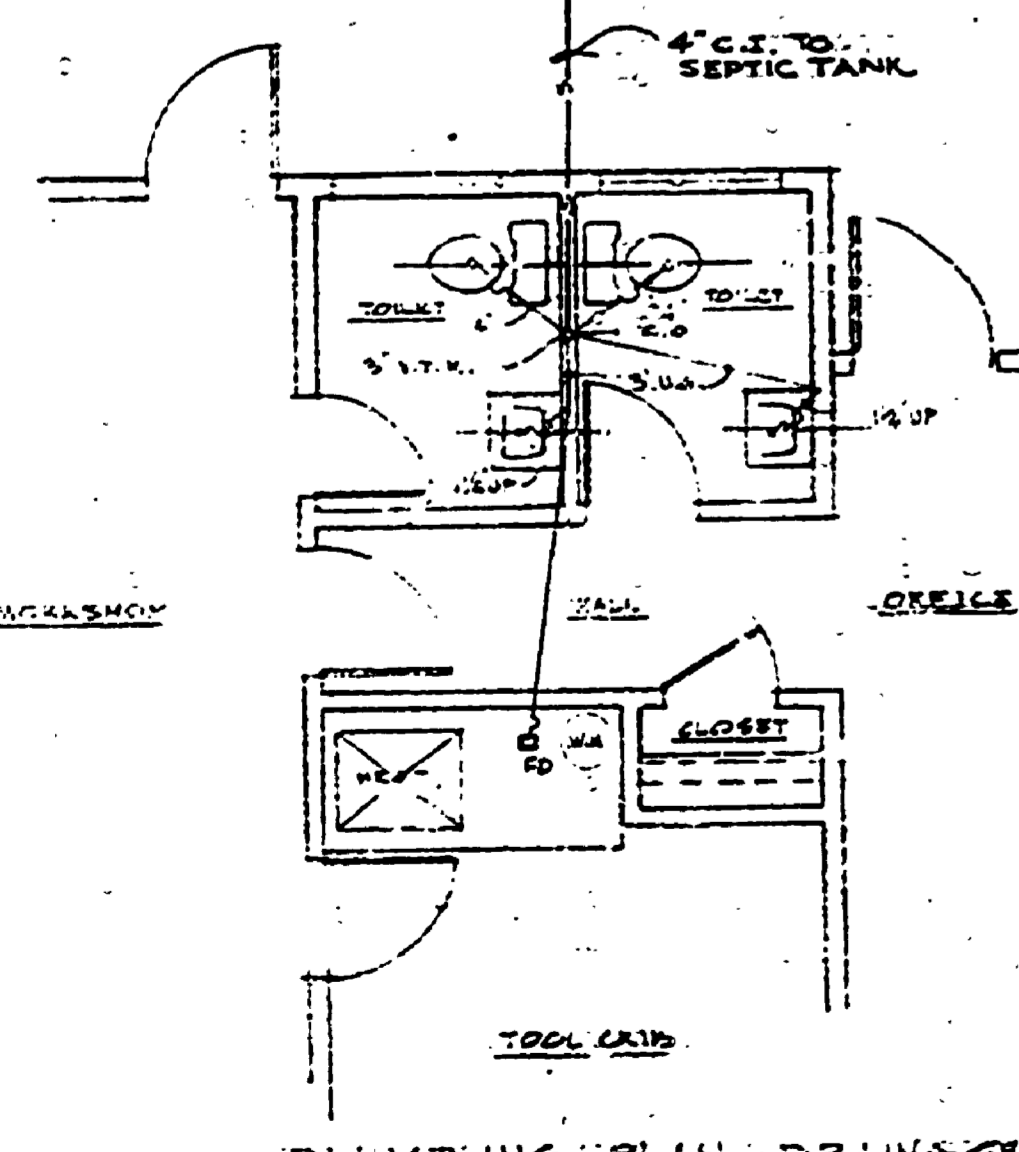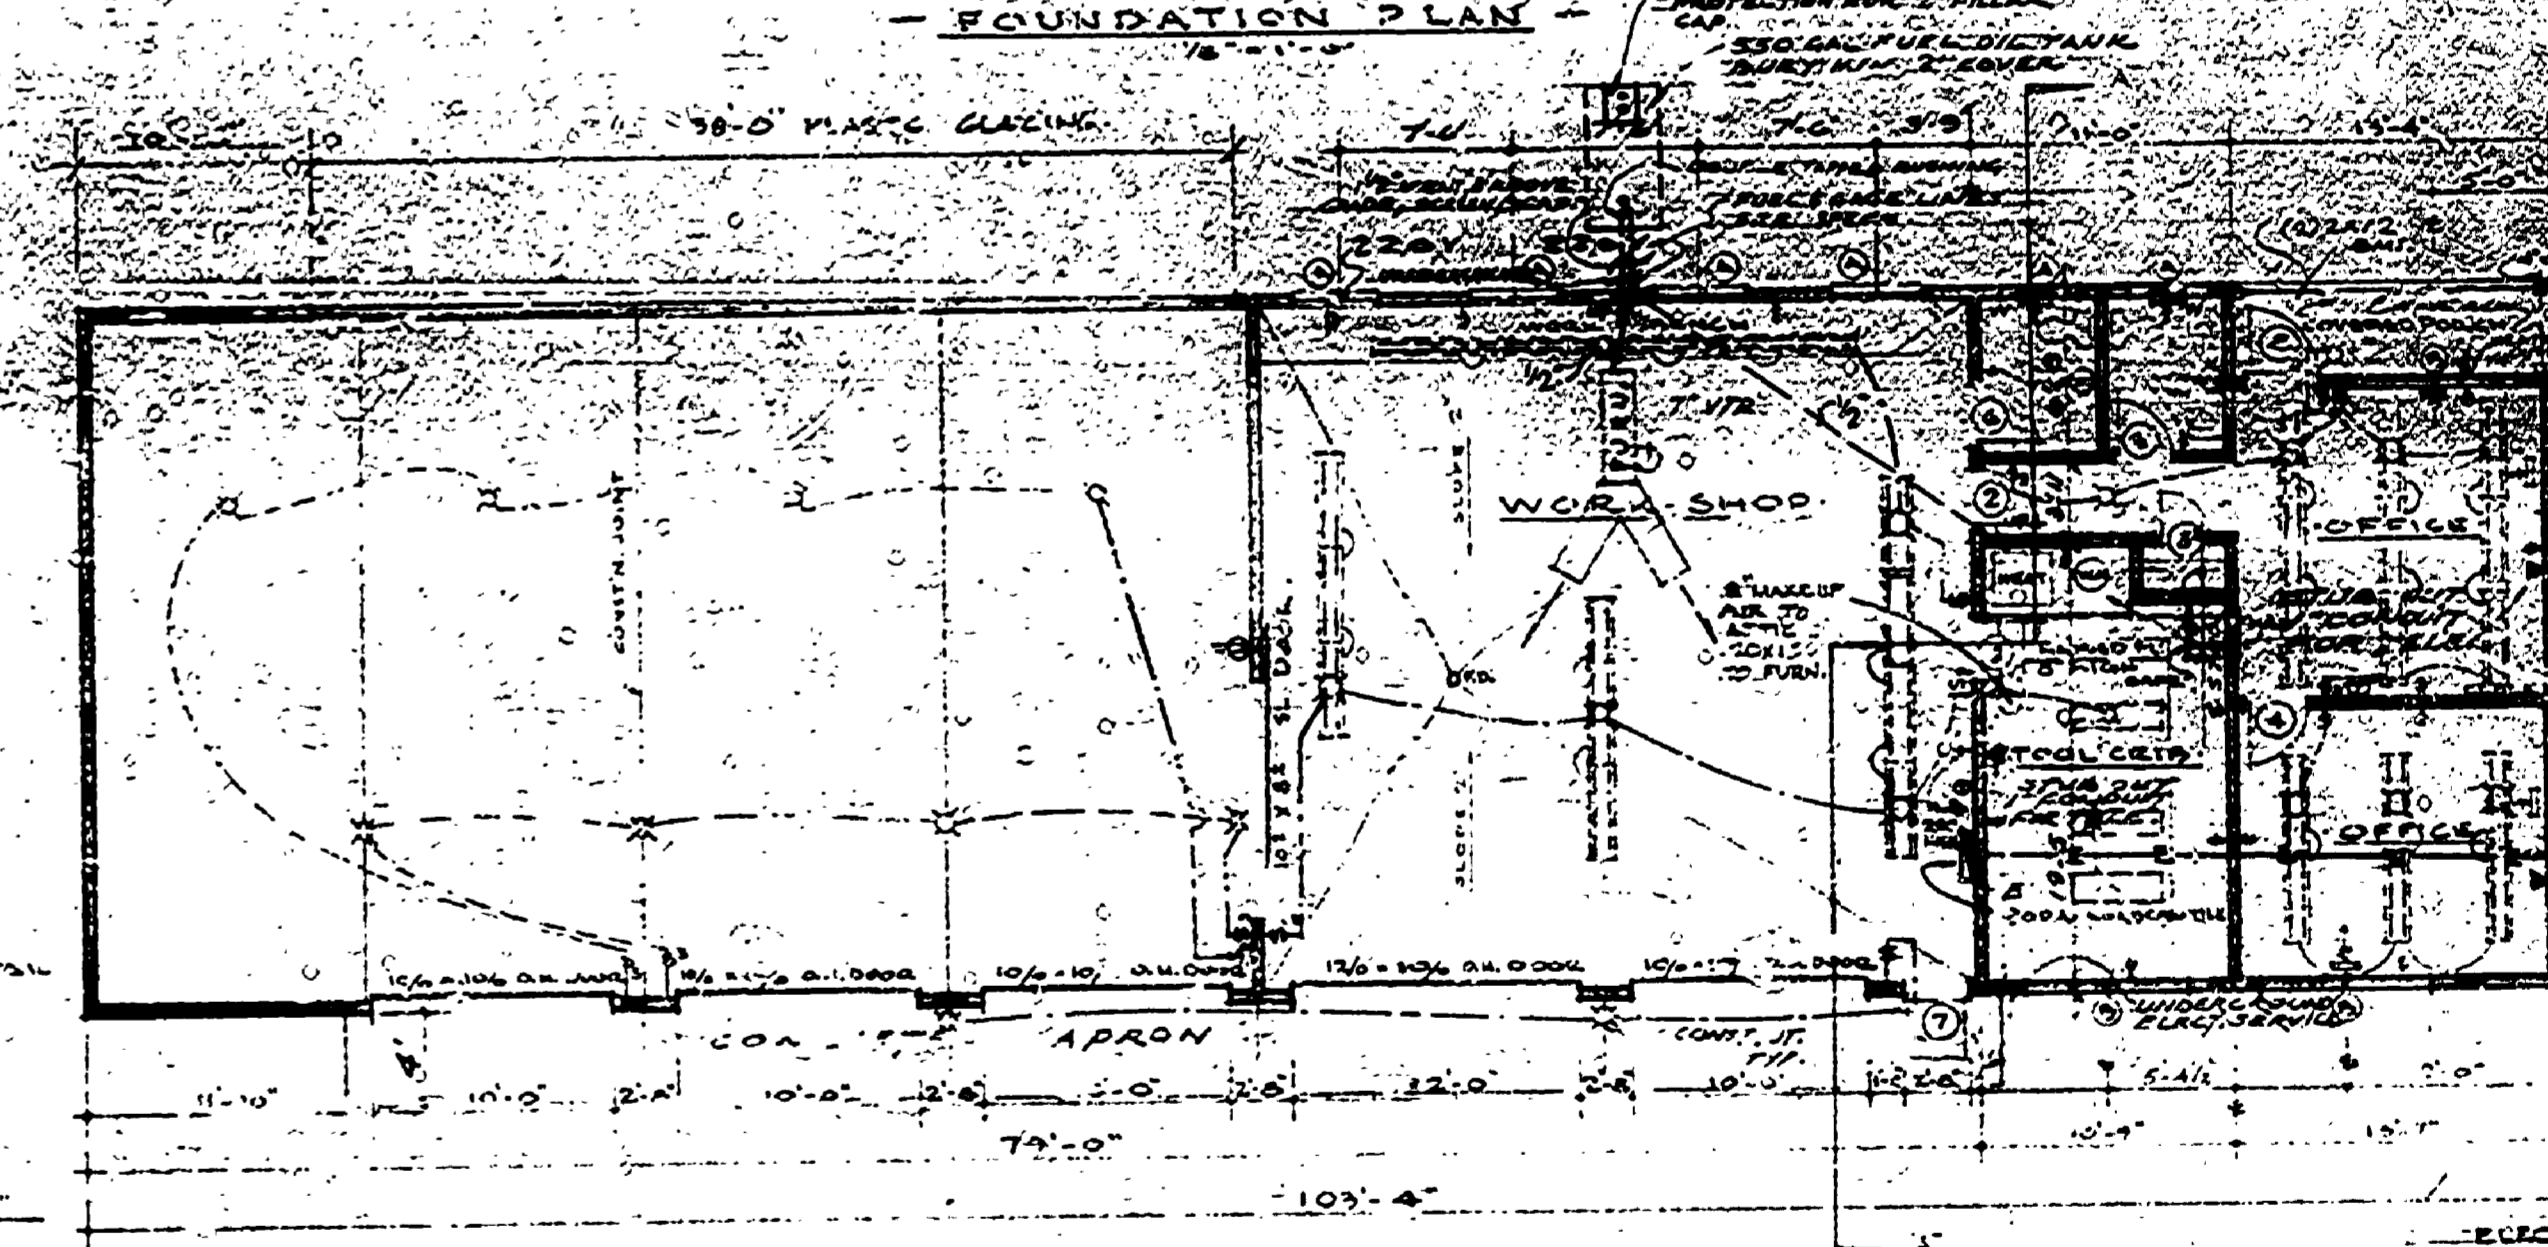

**LEGEND**

- F. FILTER
- T. TEMPERATURE & PRESSURE RELIEF VALVE
- W.H. WATER HEATER
- GOLD WATER
- HOT WATER

**FINISH SCHEDULE**

ROOM NAME	FLOOR	WALL	BASE	CEILING	REMARKS
TOOL CRIB					
HALL					
OFFICE					
TOILET					
WORKSHOP					
GARAGE					
CLOSET					

SURVEYED BY	DRAWN BY	DATE	NO.	DATE	BY	REVISIONS
			1	3-64	BBE	GEN. OPENING OF PLUMBING
			2	3-70	BBP	PLUMBING PLAN, ELBOW, HEATING