




DESIGNED BY	DATE	REVIEWED	DATE	APPROVED	DATE	NO.	DATE	BY	REVISIONS
DRAWN BY G.A.C. & H.P.P.		ARCHITECTURAL				1			4
CHECKED BY J.M.A.C.		ENGINEERING				2			5
		LANDSCAPE				3			6

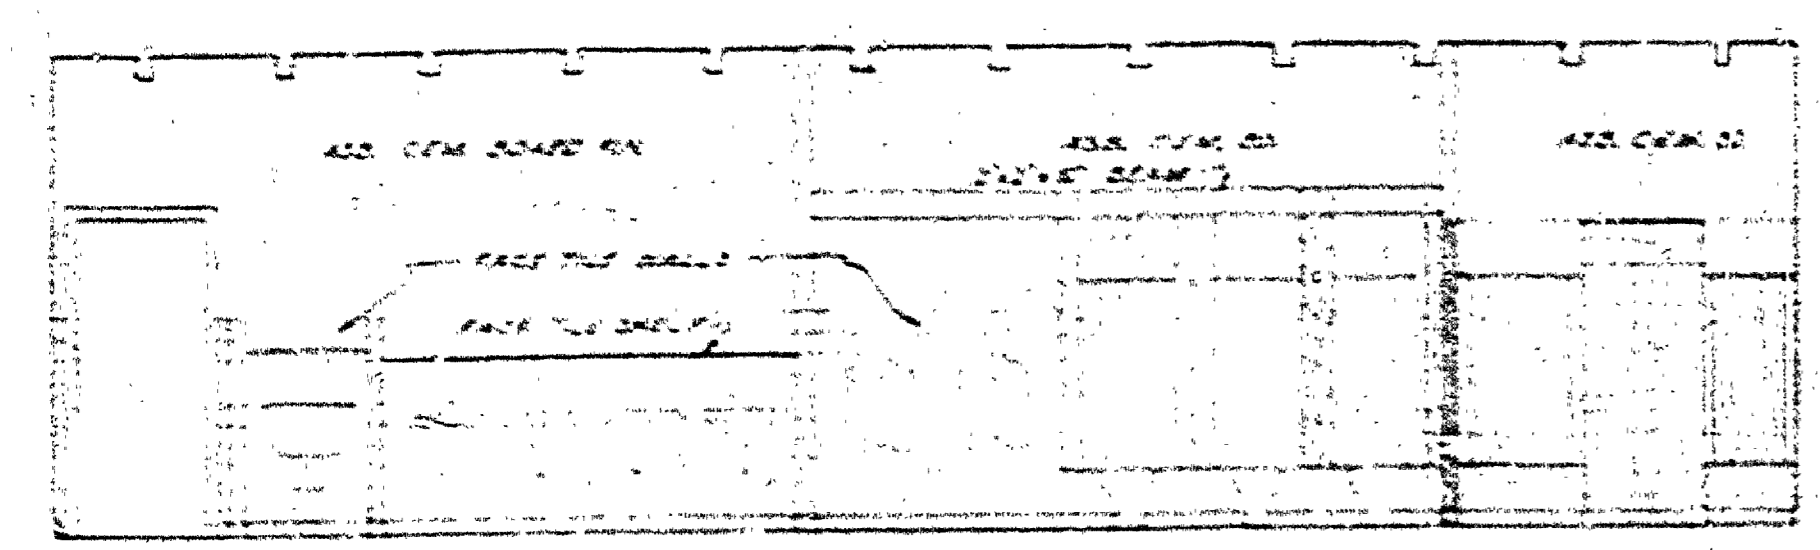




ELEVATION 'C'

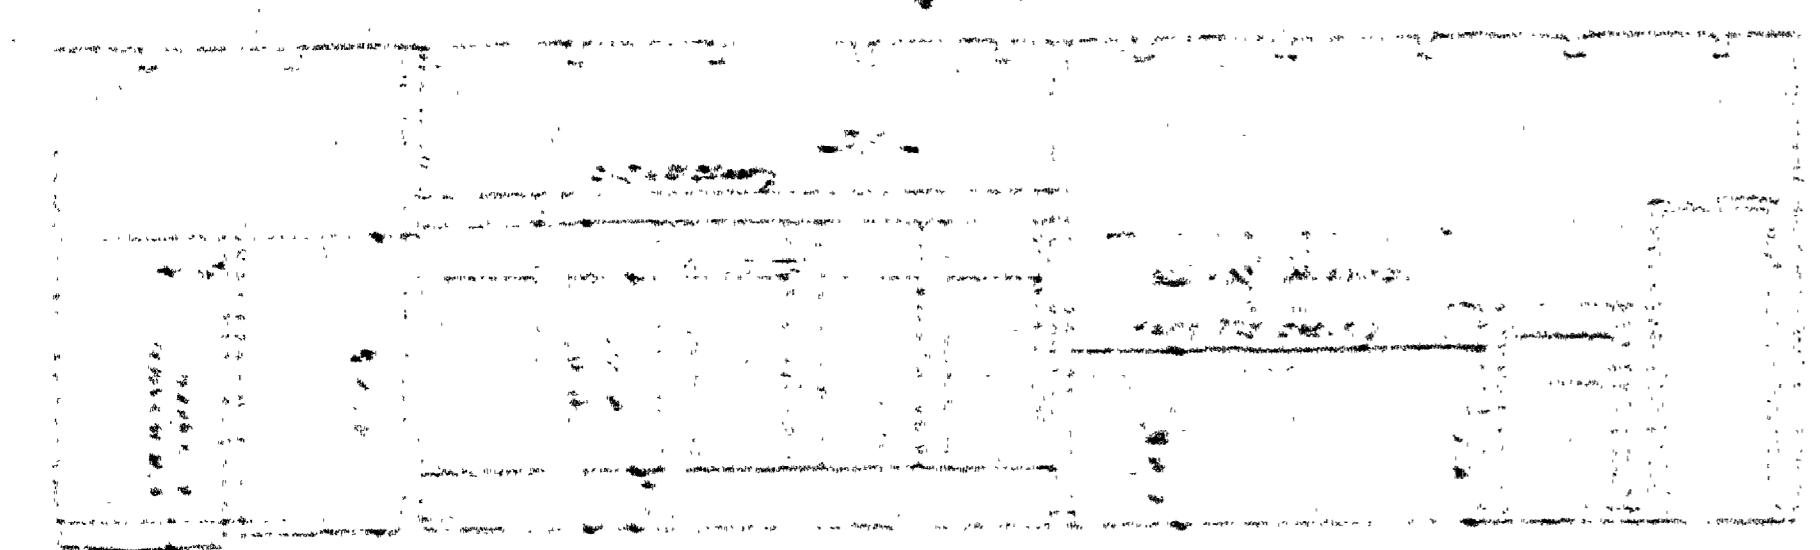


ELEVATION 'B'

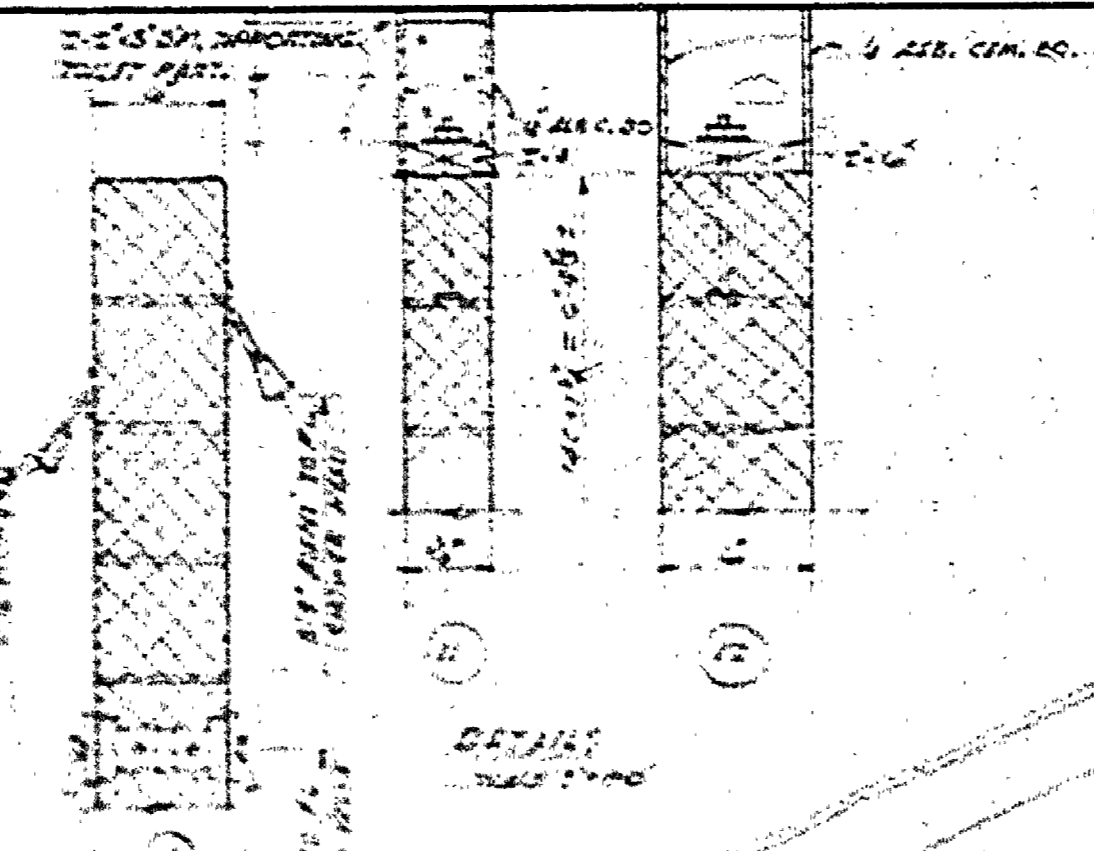


DETAILS

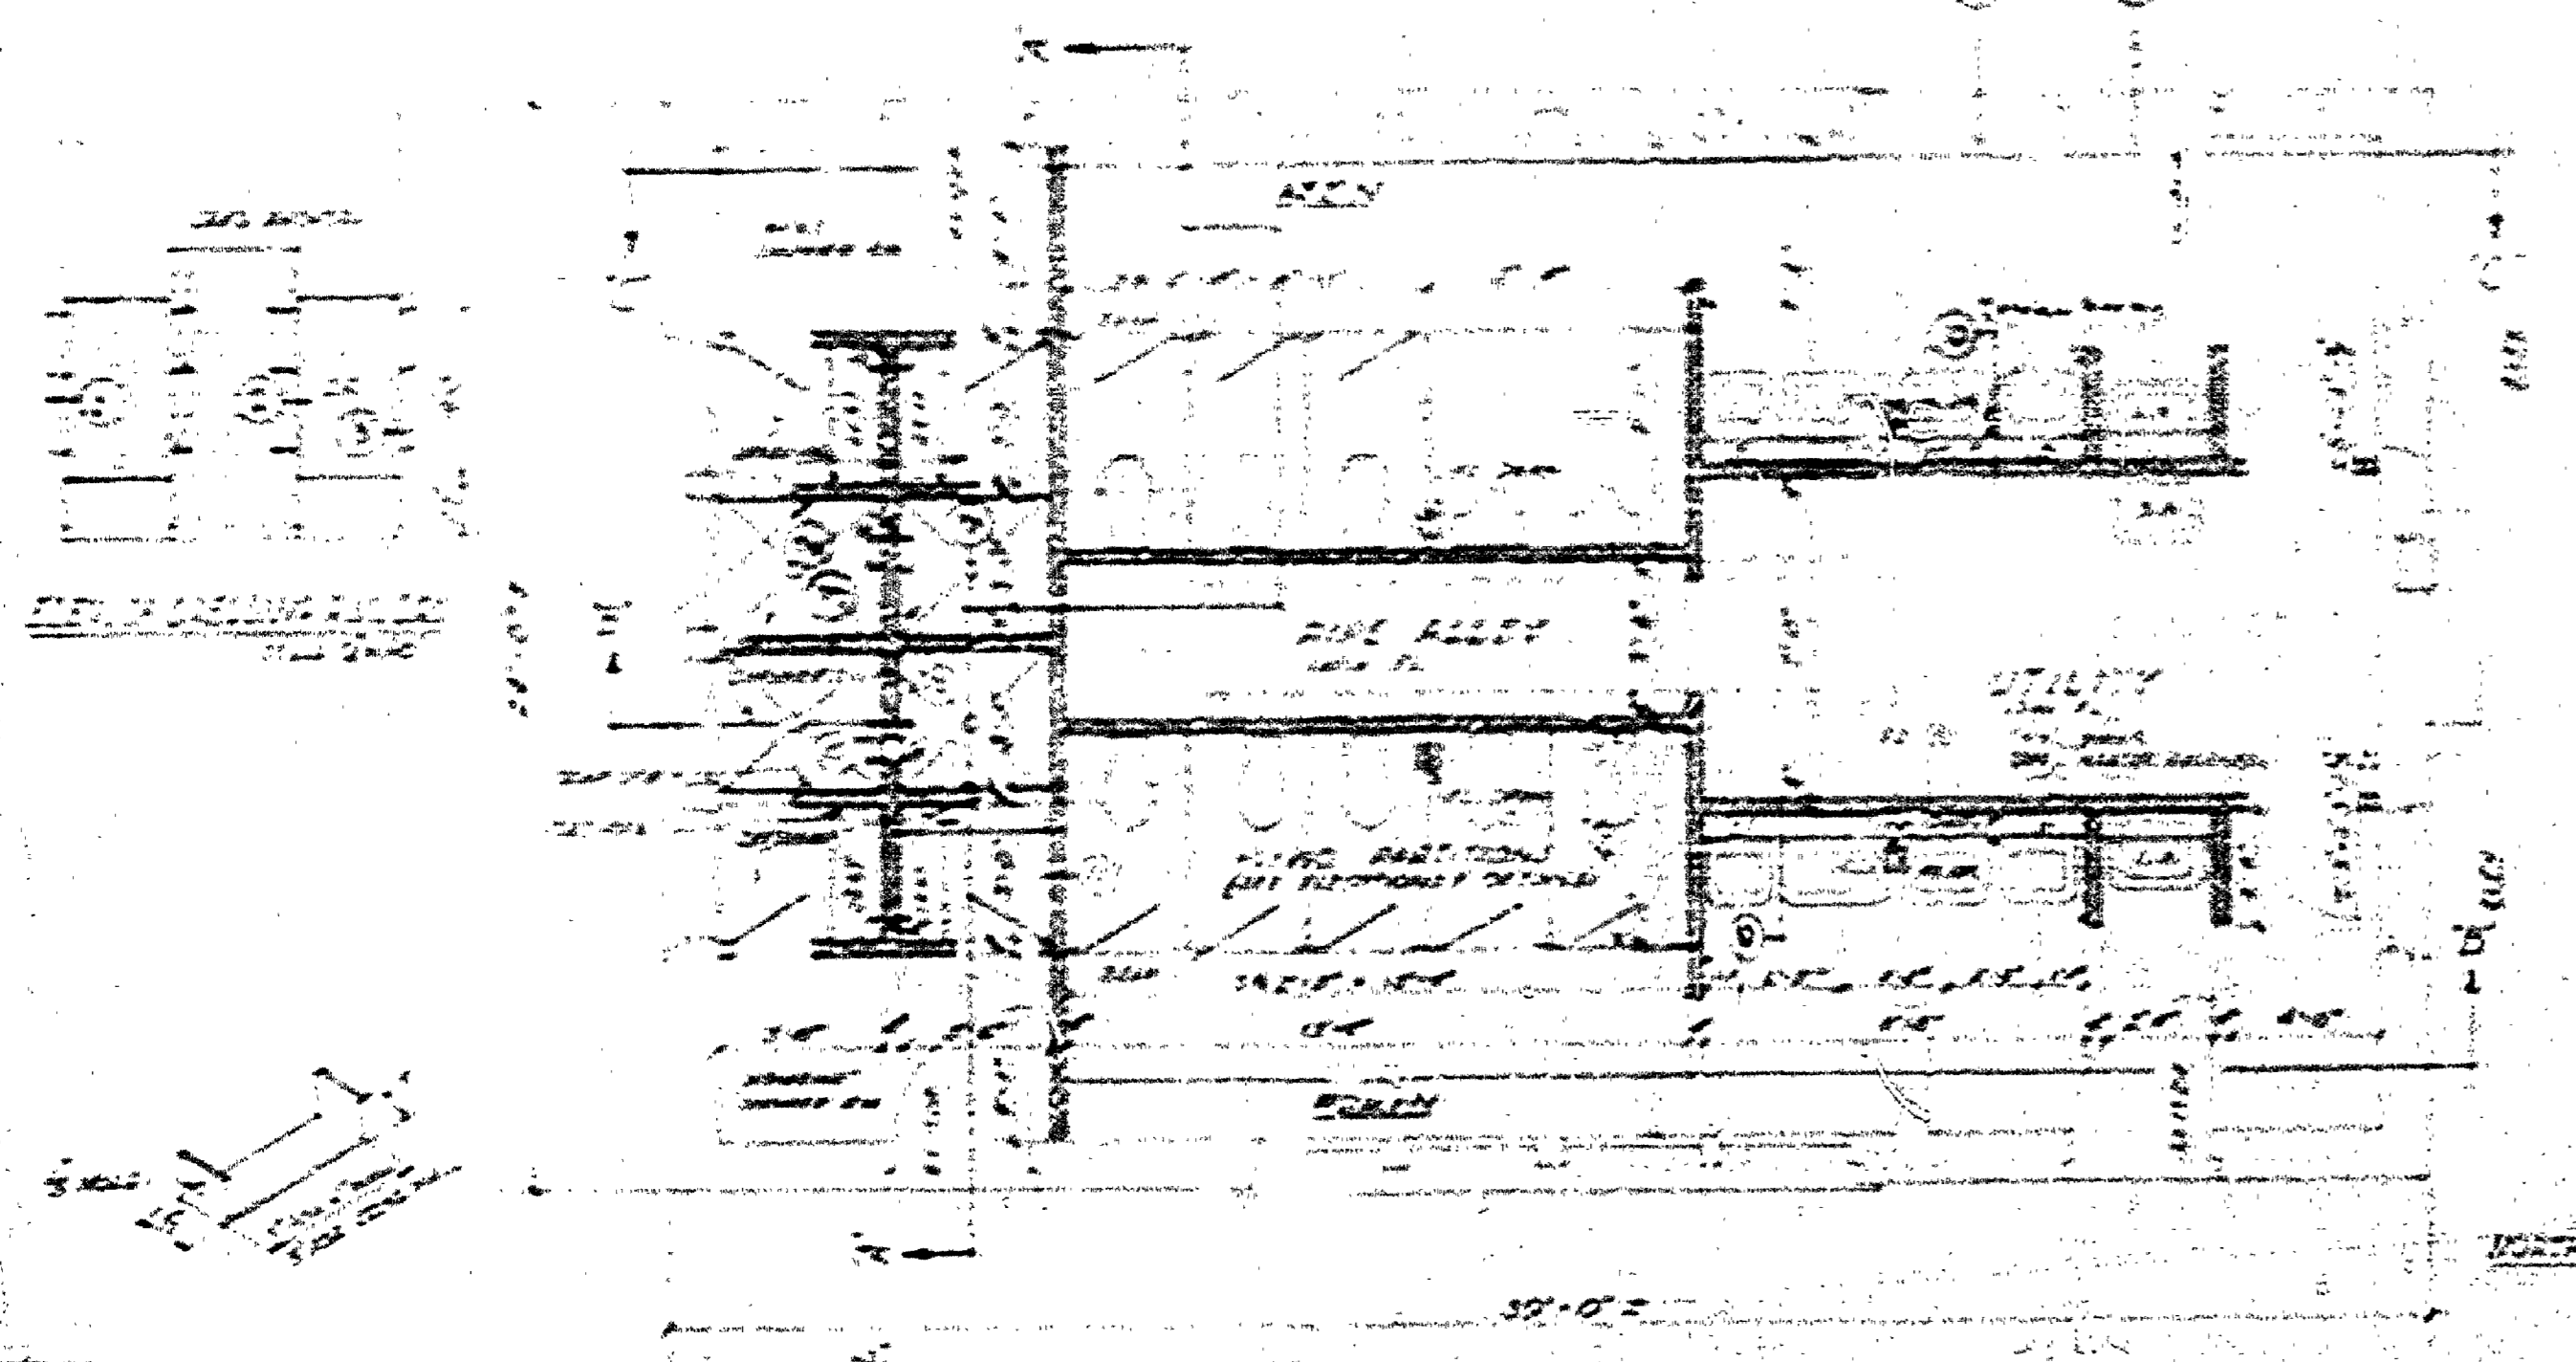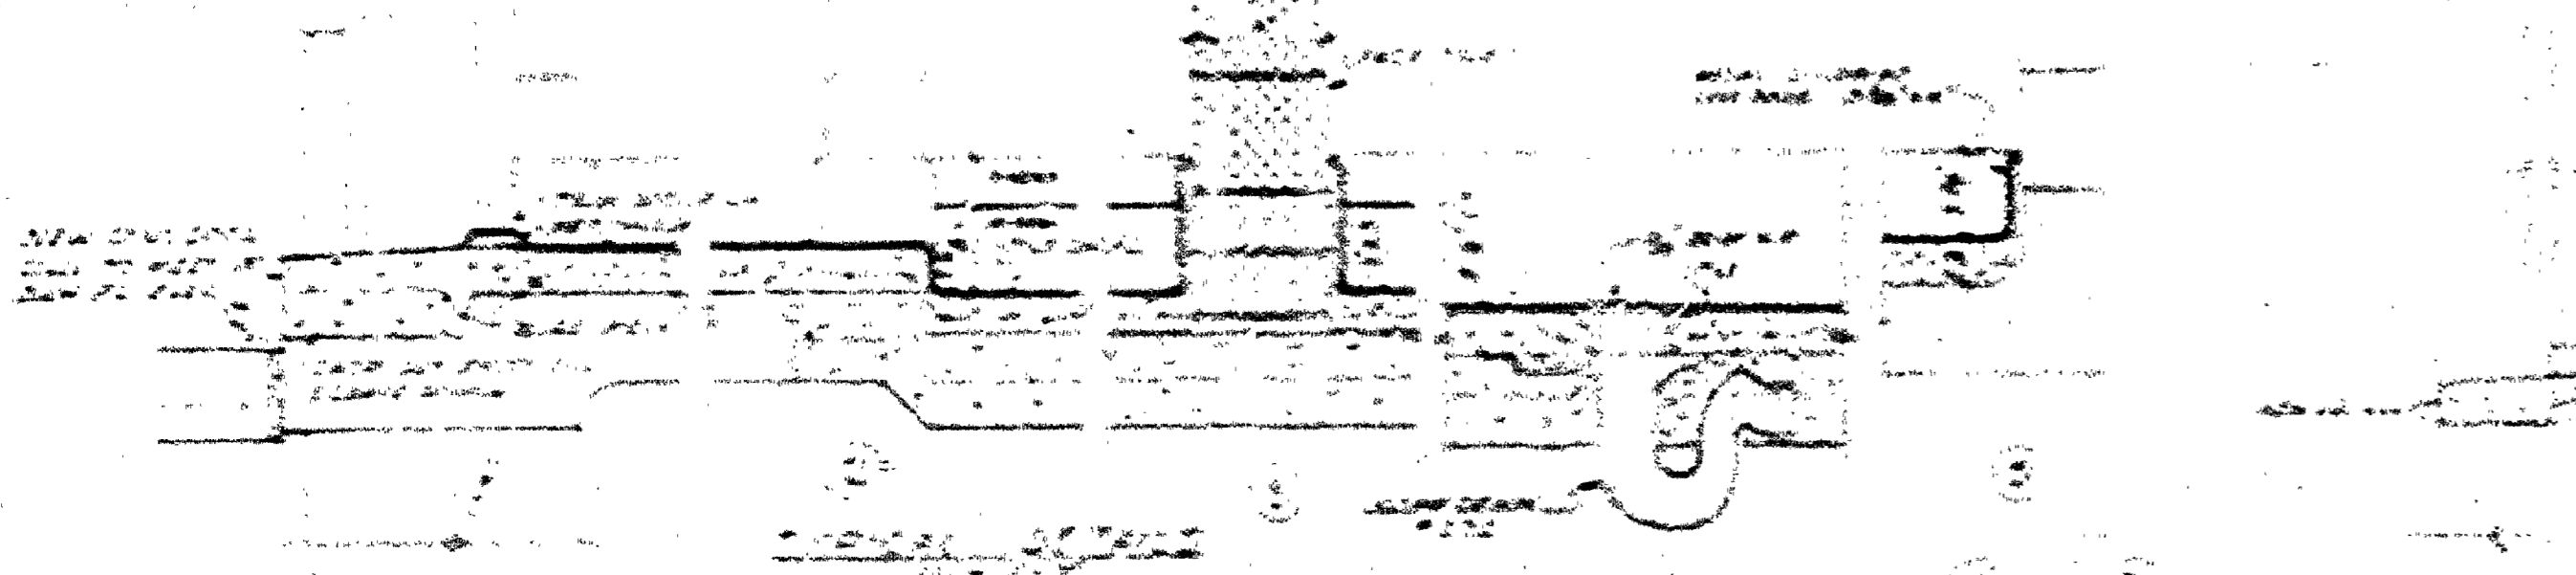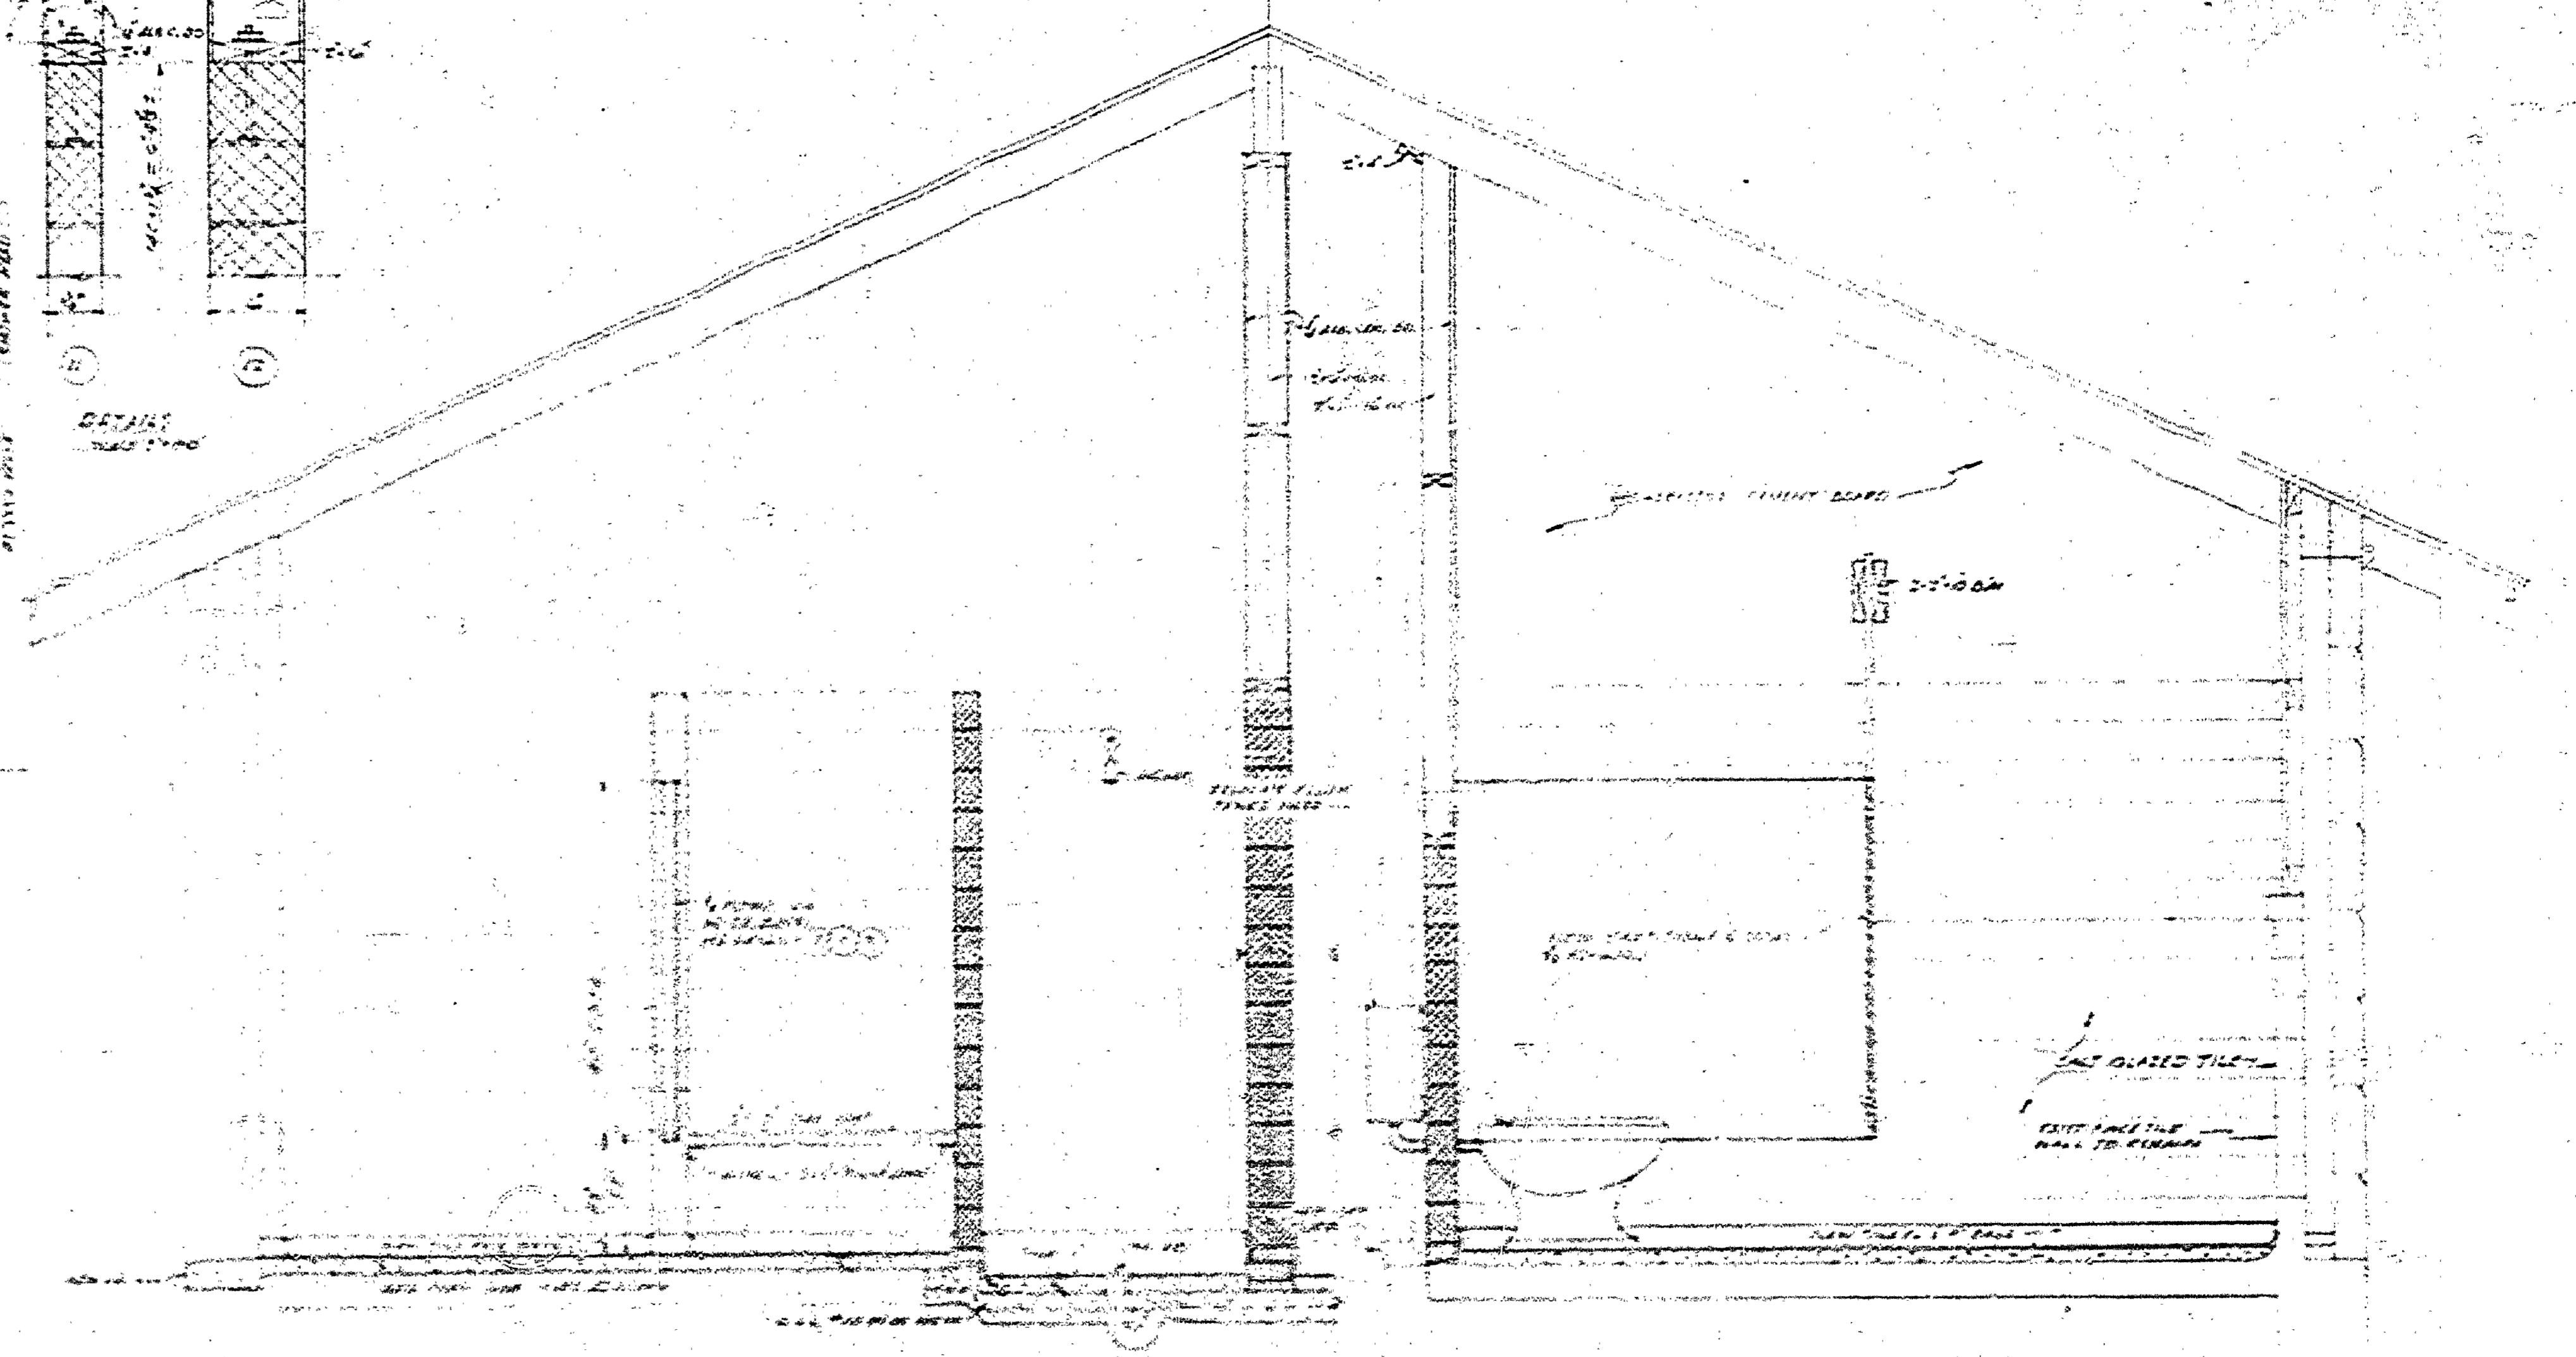


FLOOR PLAN

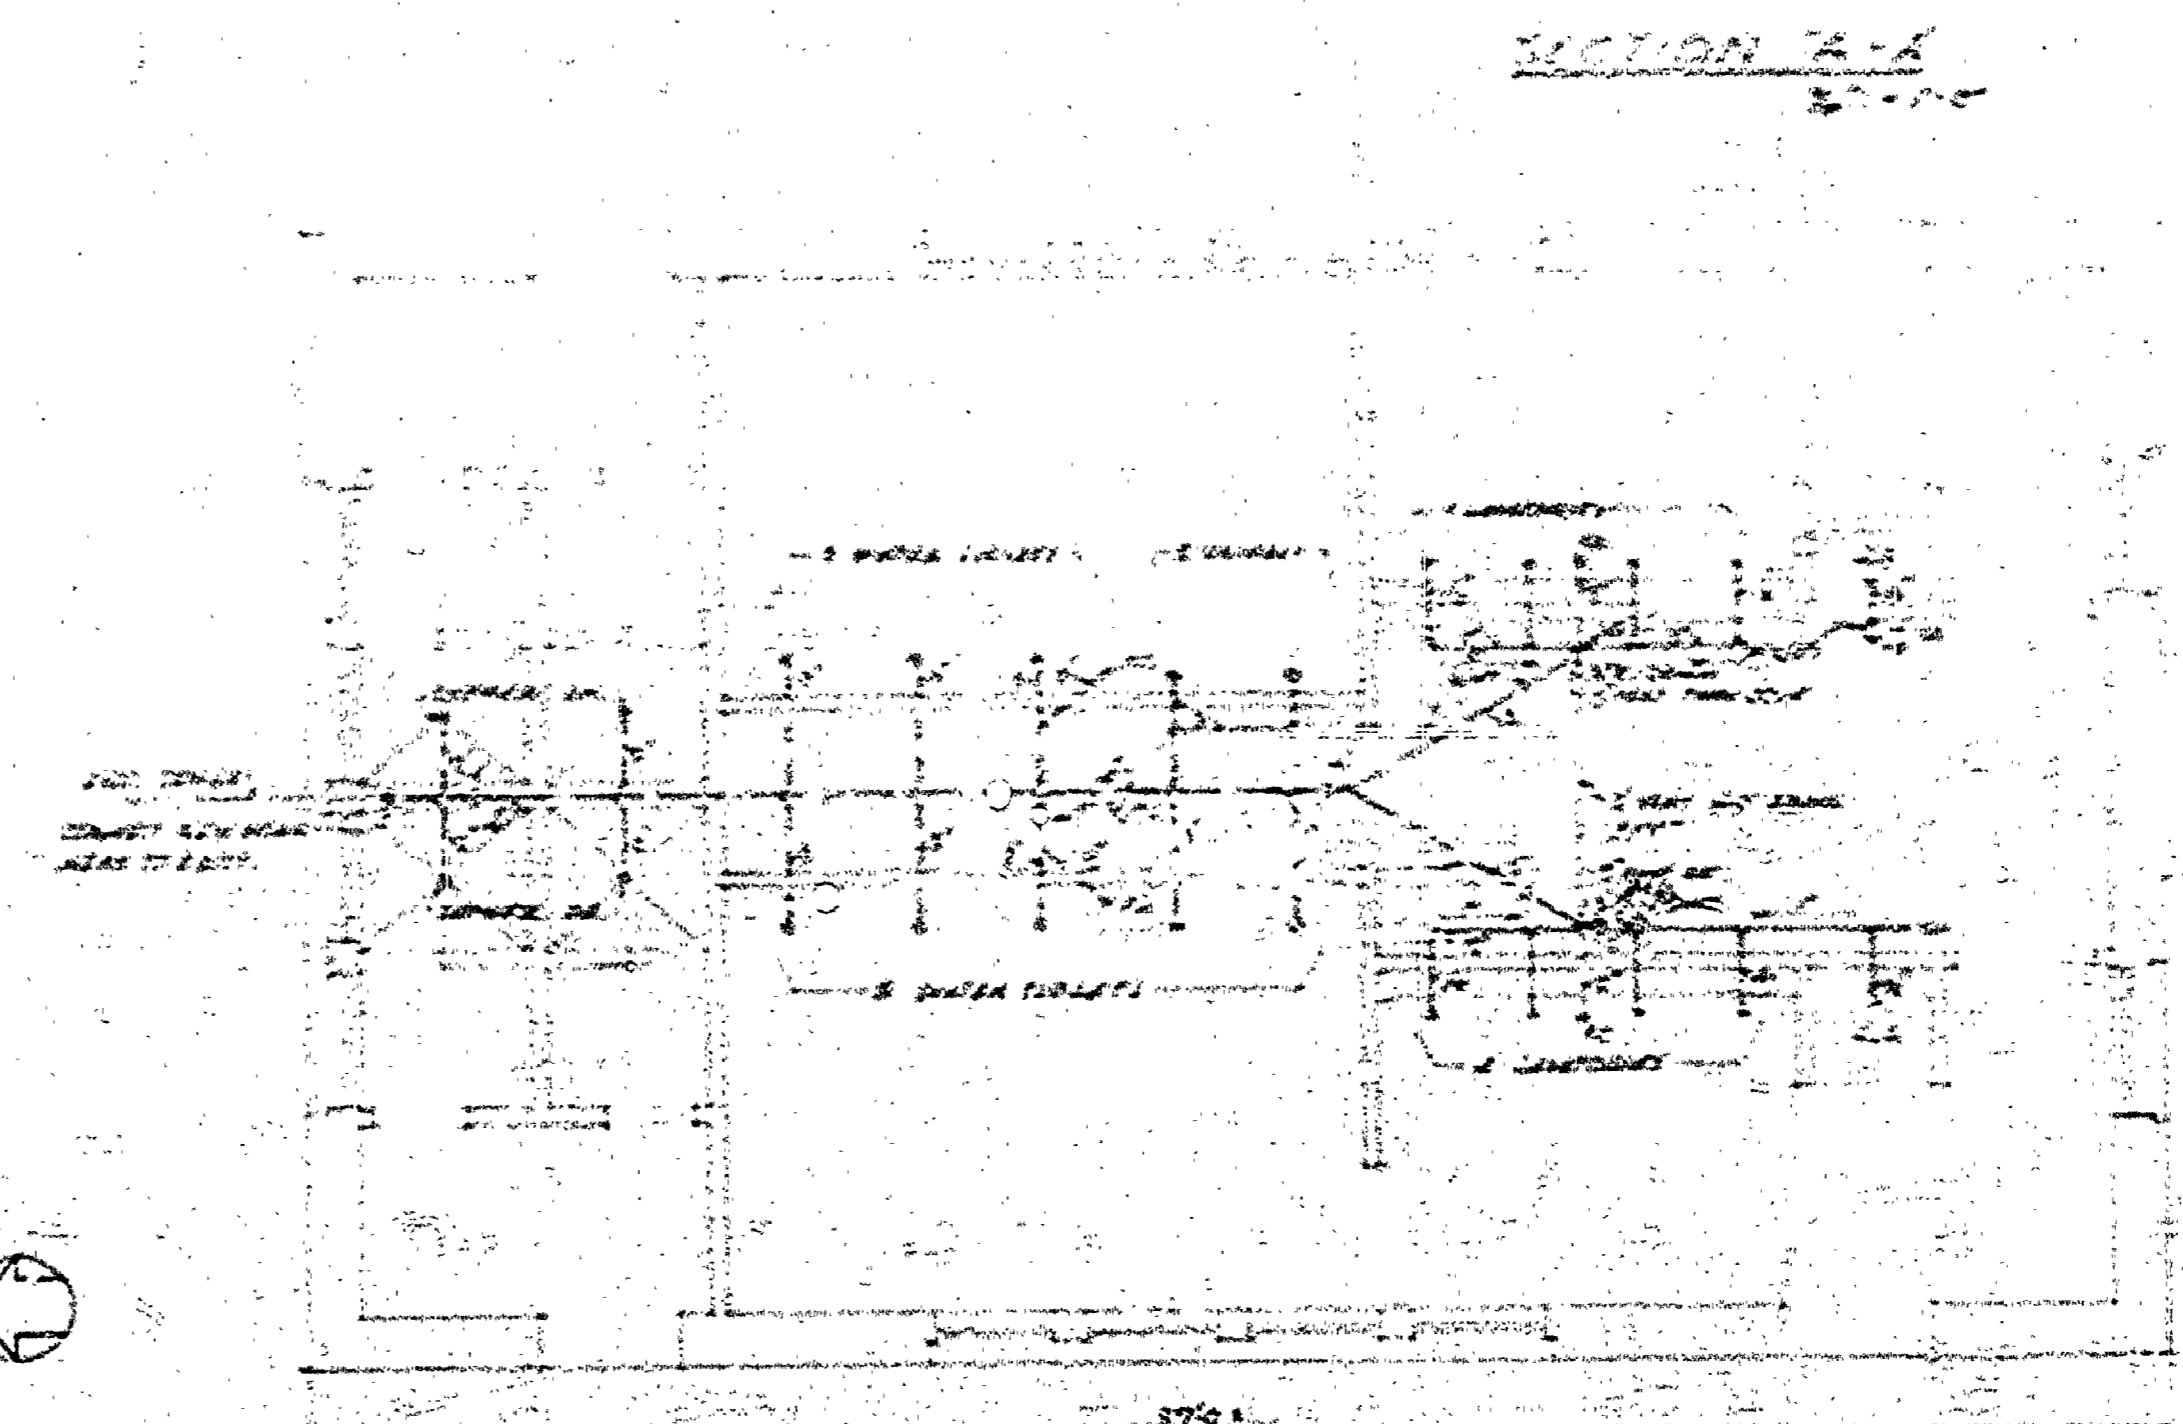

SANITARY PLUMBING PLAN

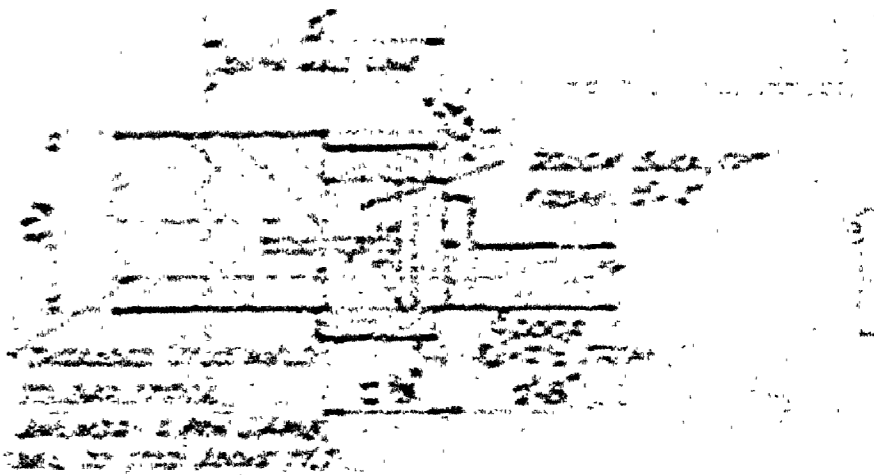

TYPICAL FOR TWO UTILITY DRAINS

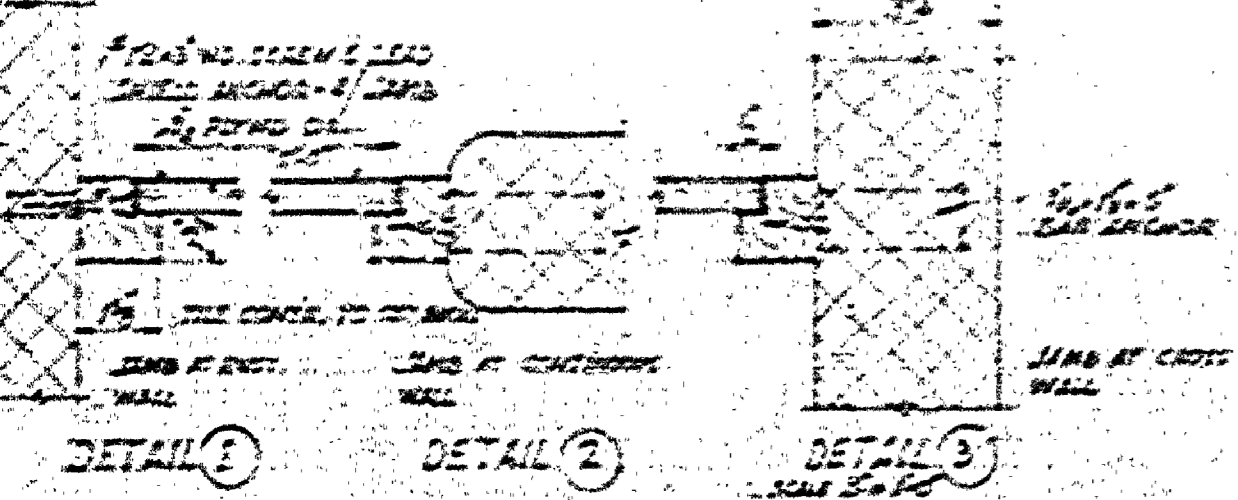

DETAIL 1

DETAIL 2

DETAIL 3

**GENERAL NOTE:**  
 ALL EXISTING WALLS SHOWN DOTTED  
 ARE TO BE REMOVED.  
 BREAK-OUT FLOOR SLABS ONLY FOR  
 REMOVAL OF THE MAIN EXISTING C.L.  
 SEWER LINES FOR THE PLACEMENT OF  
 NEW UNDER SLAB STONES AT NEW  
 DRAINAGE AREAS FOR IMPROVED DRAINAGE.  
 ALL FLOORS TO BE THE FLOORING  
 SHOWN EXCEPT AS NOTED.

CONSERVATION COMMISSION APPROVAL	
BY: _____	DATE: _____
RECOMMENDED FOR APPROVAL	DESIGN DATE: 1-22-65
BY: W.B.C.	DESIGNER
RECOMMENDED FOR APPROVAL	DATE: 1-22-65
BY: E.J. D... ..	DESIGNER
SECTION CHIEF APPROVAL	
BY: _____	DATE: 1/27/65
SECTION CHIEF	
MICHIGAN DEPARTMENT OF CONSERVATION	
APPROVED BY: _____	DATE: 5-26-65
CHIEF ENGINEER	
PLAN NO. A-105a	PROJECT NUMBER REG. III-TPDS-300-270
SHEET 17 OF 2	

MICHIGAN DEPARTMENT OF CONSERVATION  
 PARKS AND RECREATION DIVISION

MUSKEGON STATE PARK  
 NORTH CAMP GROUND  
 ALTERATIONS TO TOILET BLDG.

SHEET NO. 17 OF 2  
 PLAN NO. A-105a