




DATE BY	REVISIONS	DATE BY	APPROVED	DATE	REVIEWED	DATE
	4	11-17-63	<i>[Signature]</i>	11-17-63	ARCHITECTURAL	11-17-63
	3	11-17-63		11-17-63	ENGINEERING	11-17-63
	2				LANDSCAPE	
	1					
	0					
DESIGNED BY	11-17-63	11-17-63				
DRAWN BY						
CHECKED BY						

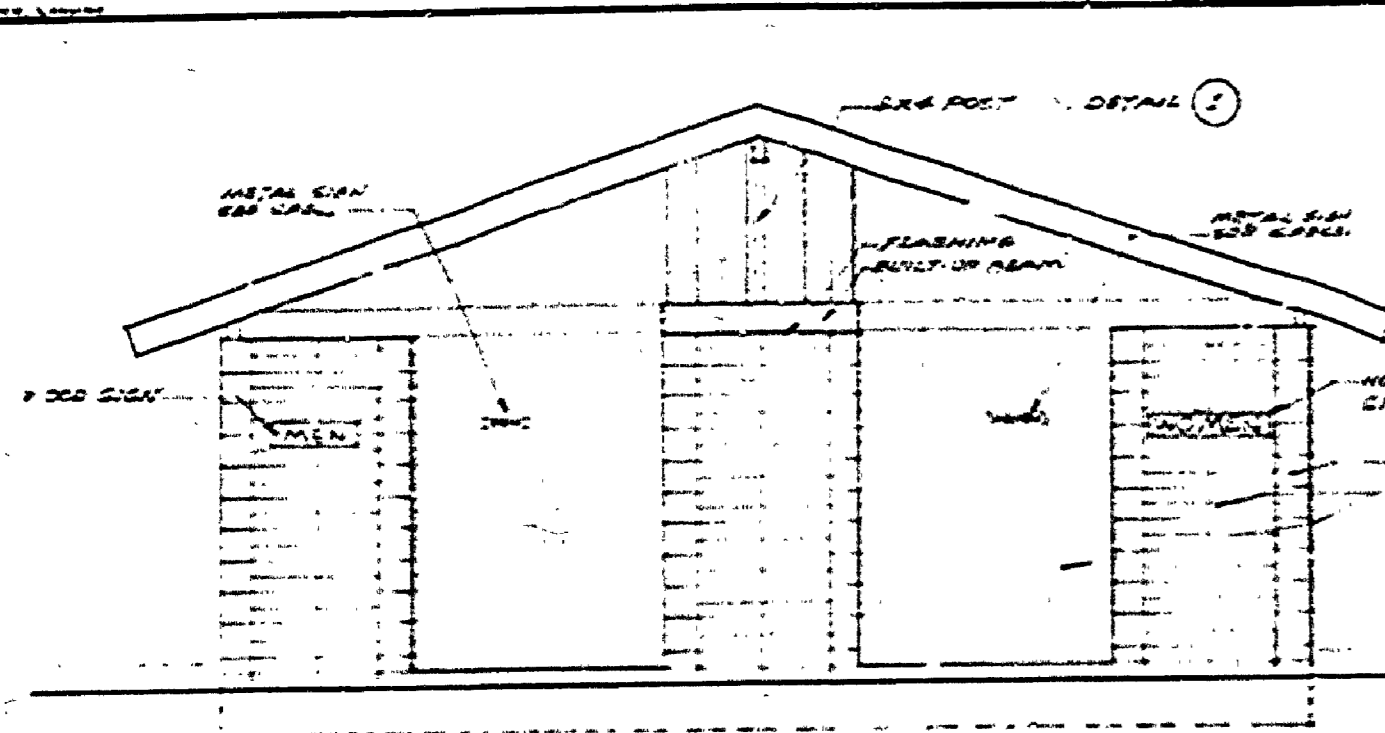


SOUTH ELEVATION

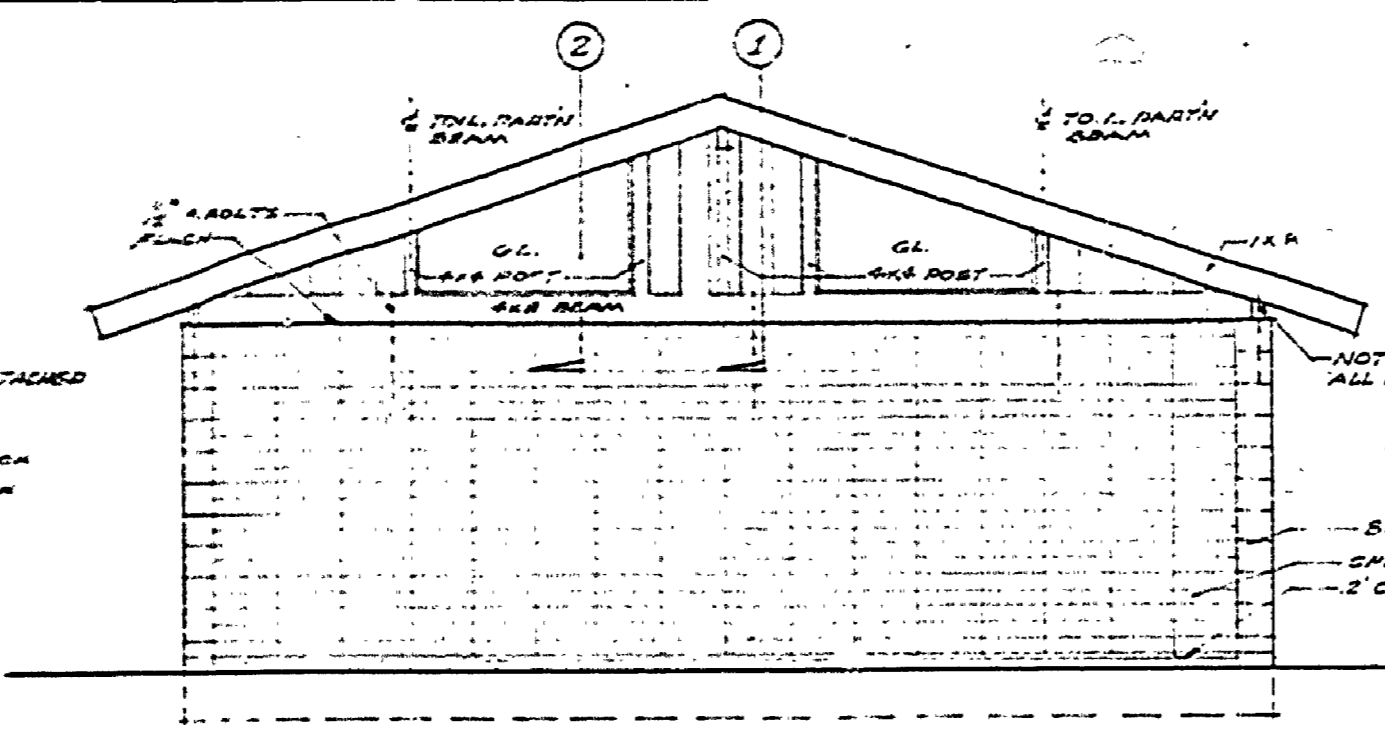


NORTH ELEVATION

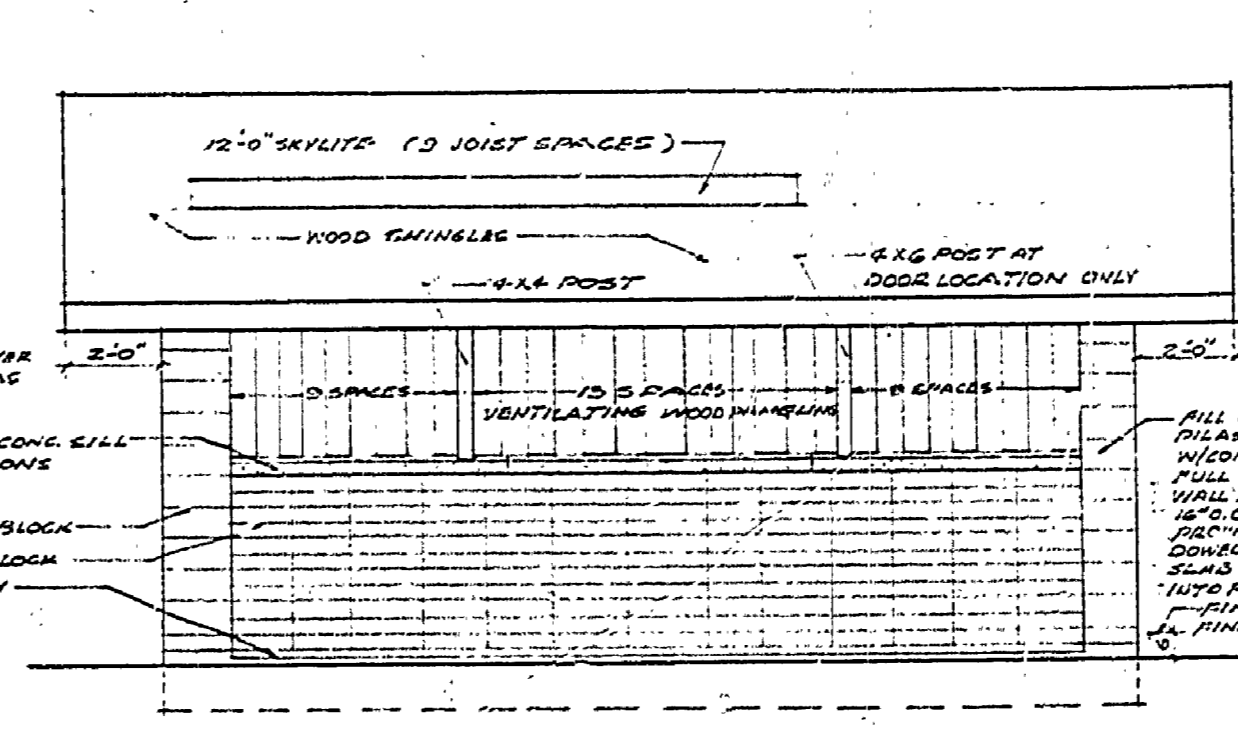


WEST ELEVATION EAST ELEV. OPP. HAND

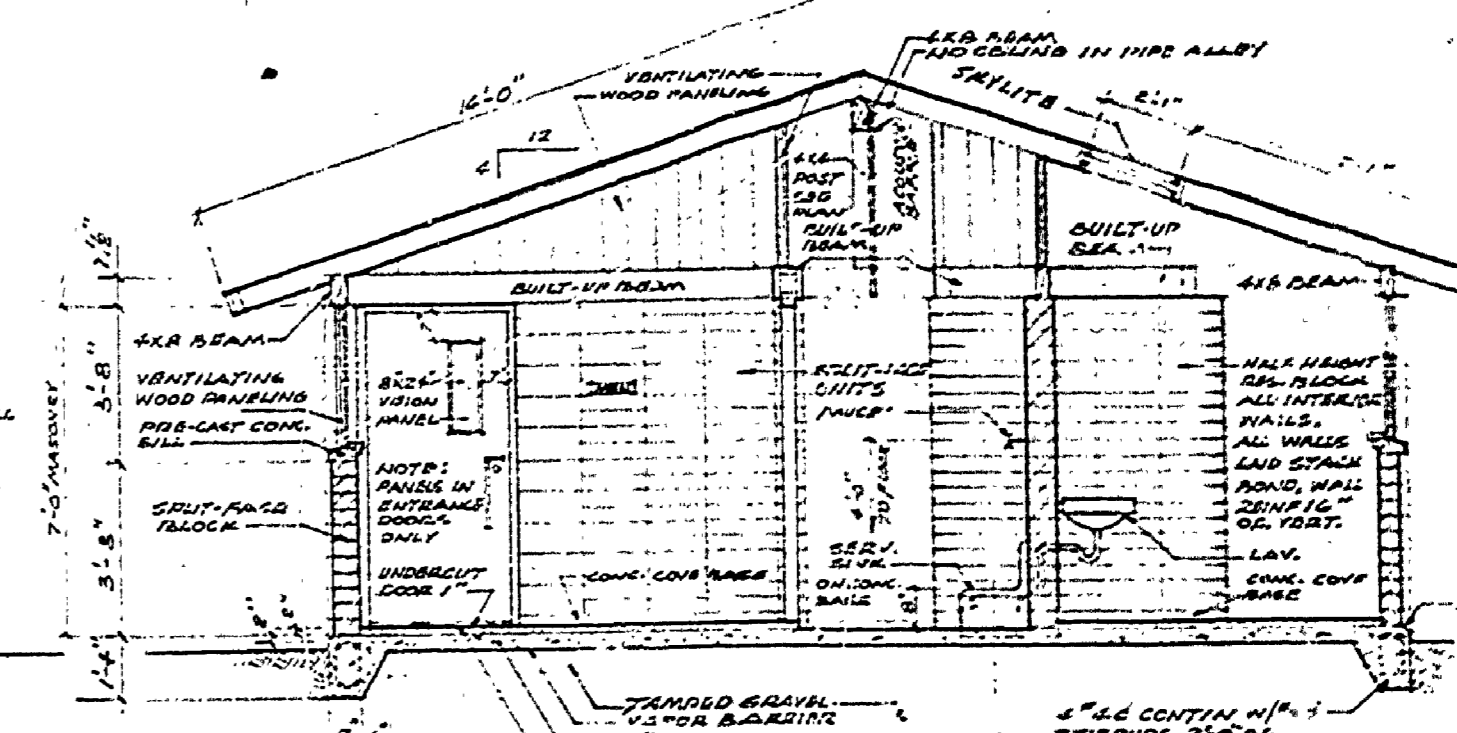


SECTION A-A

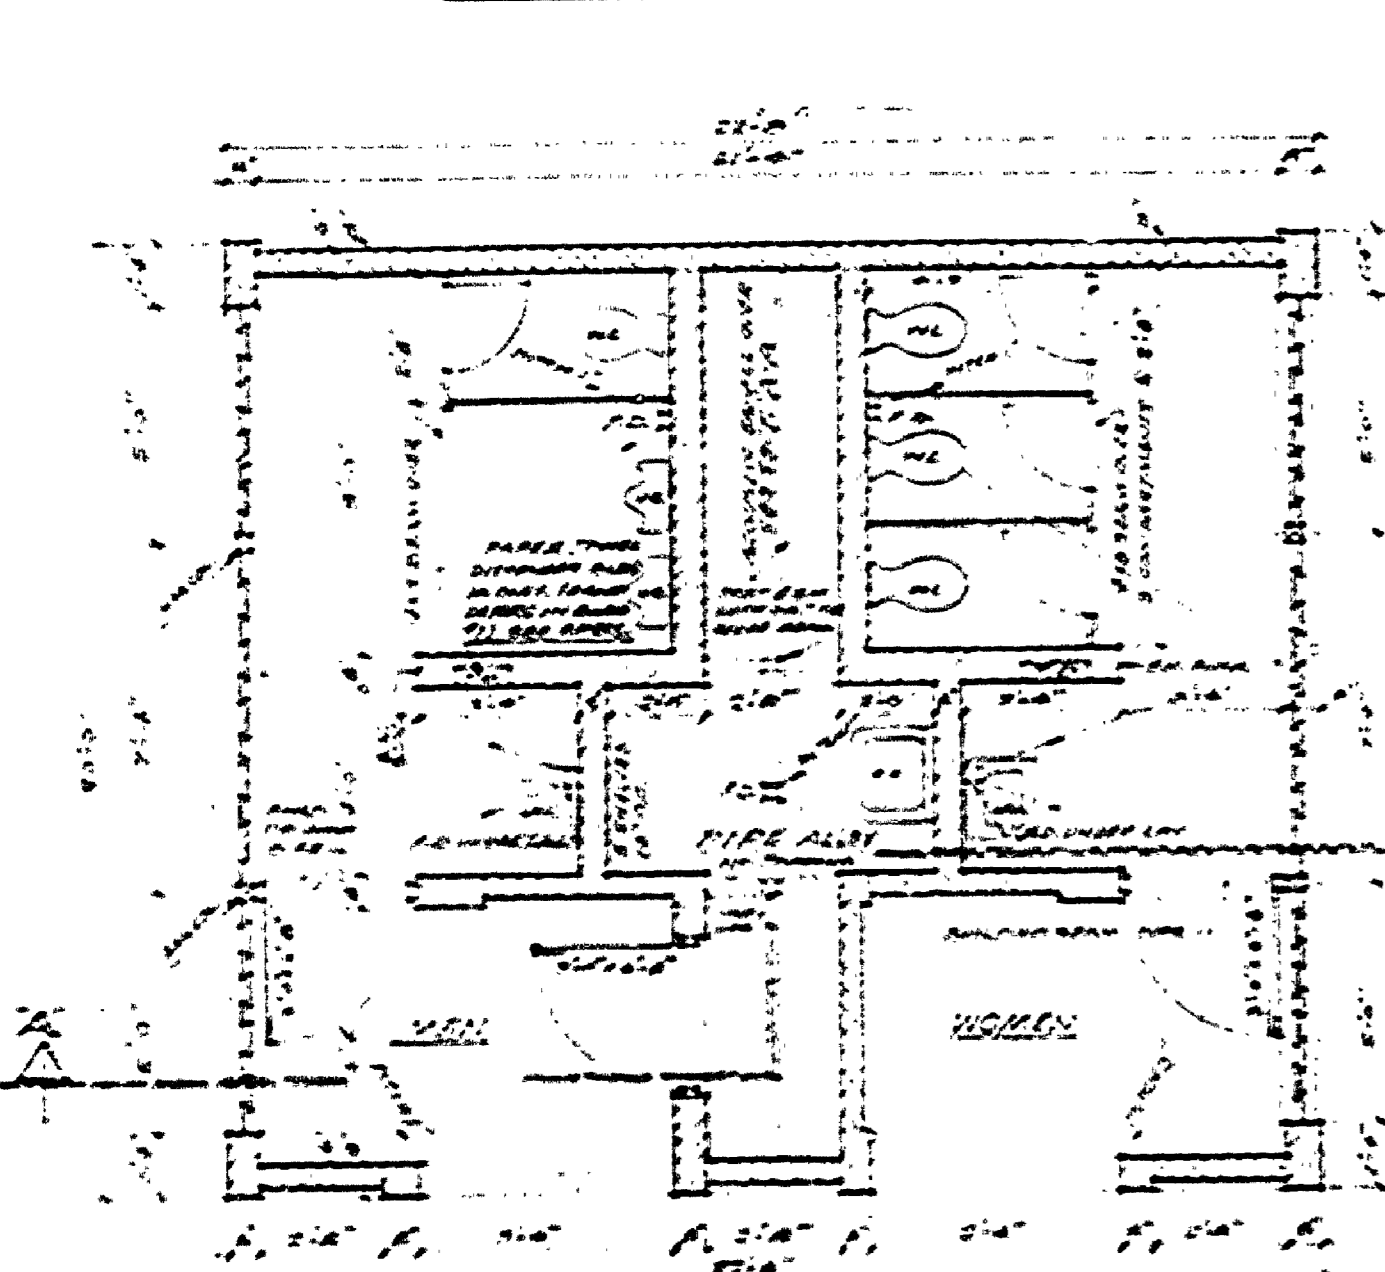


FLOOR PLAN SCALE 1/4" = 1'-0"

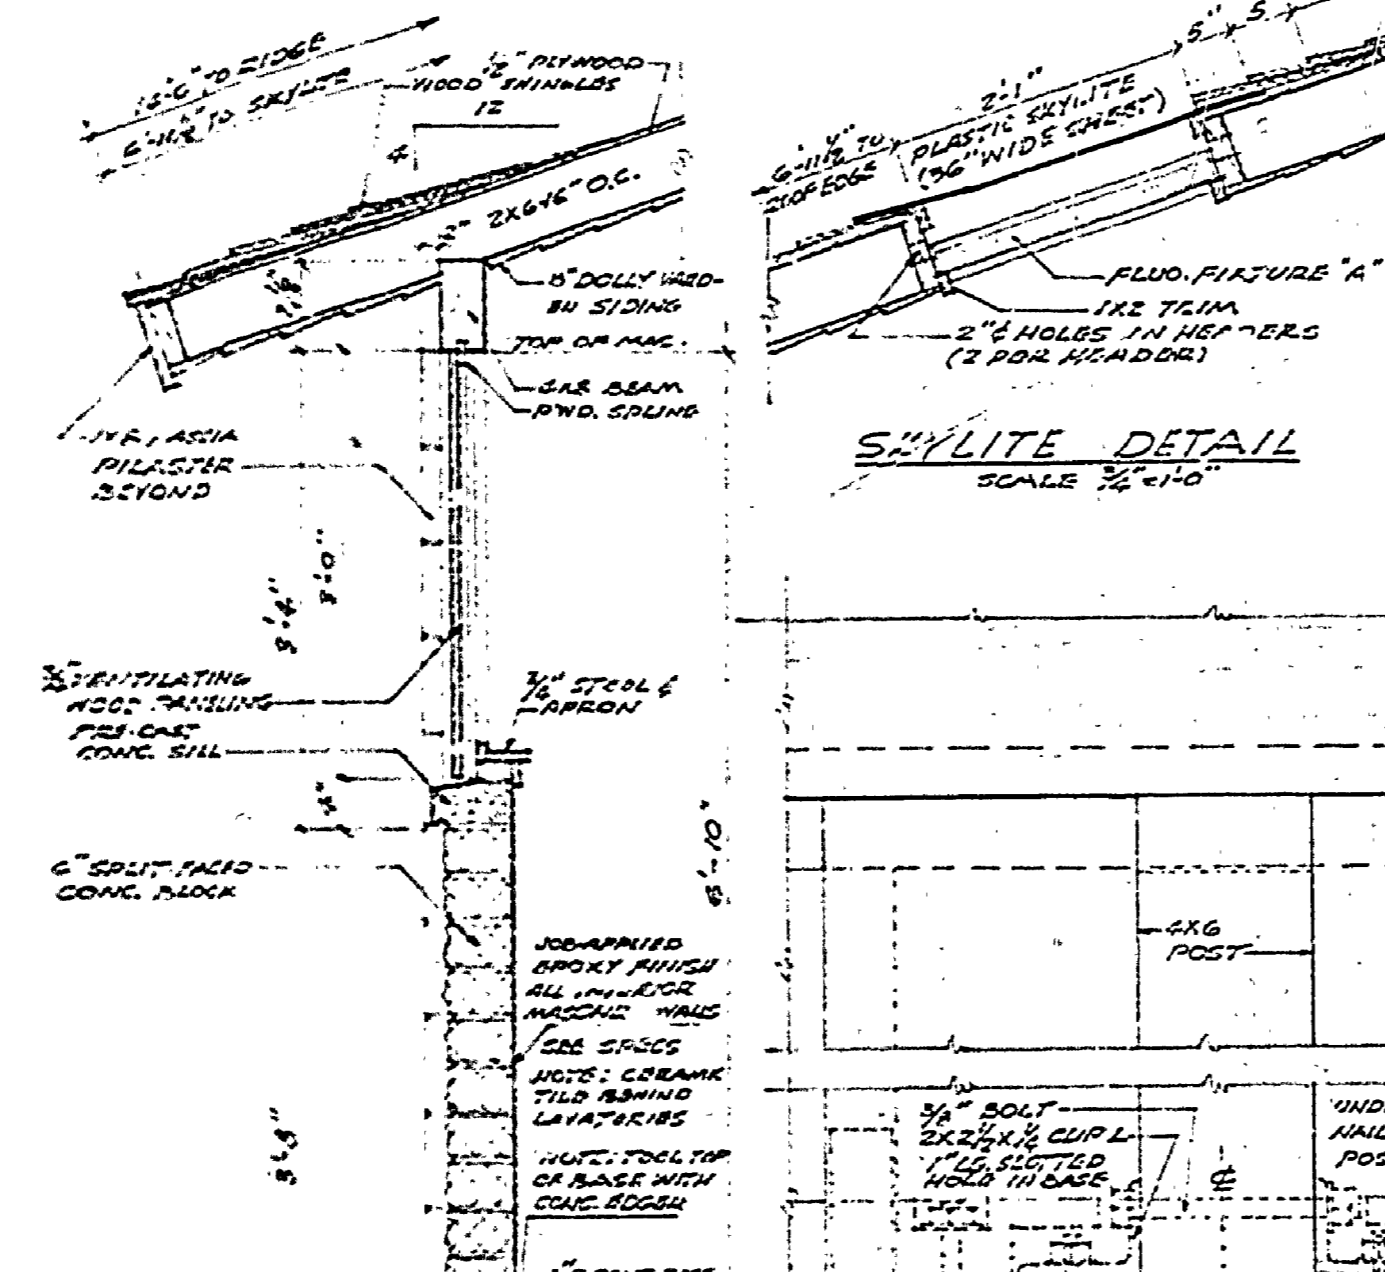


SKYLITE DETAIL SCALE 1/2" = 1'-0"

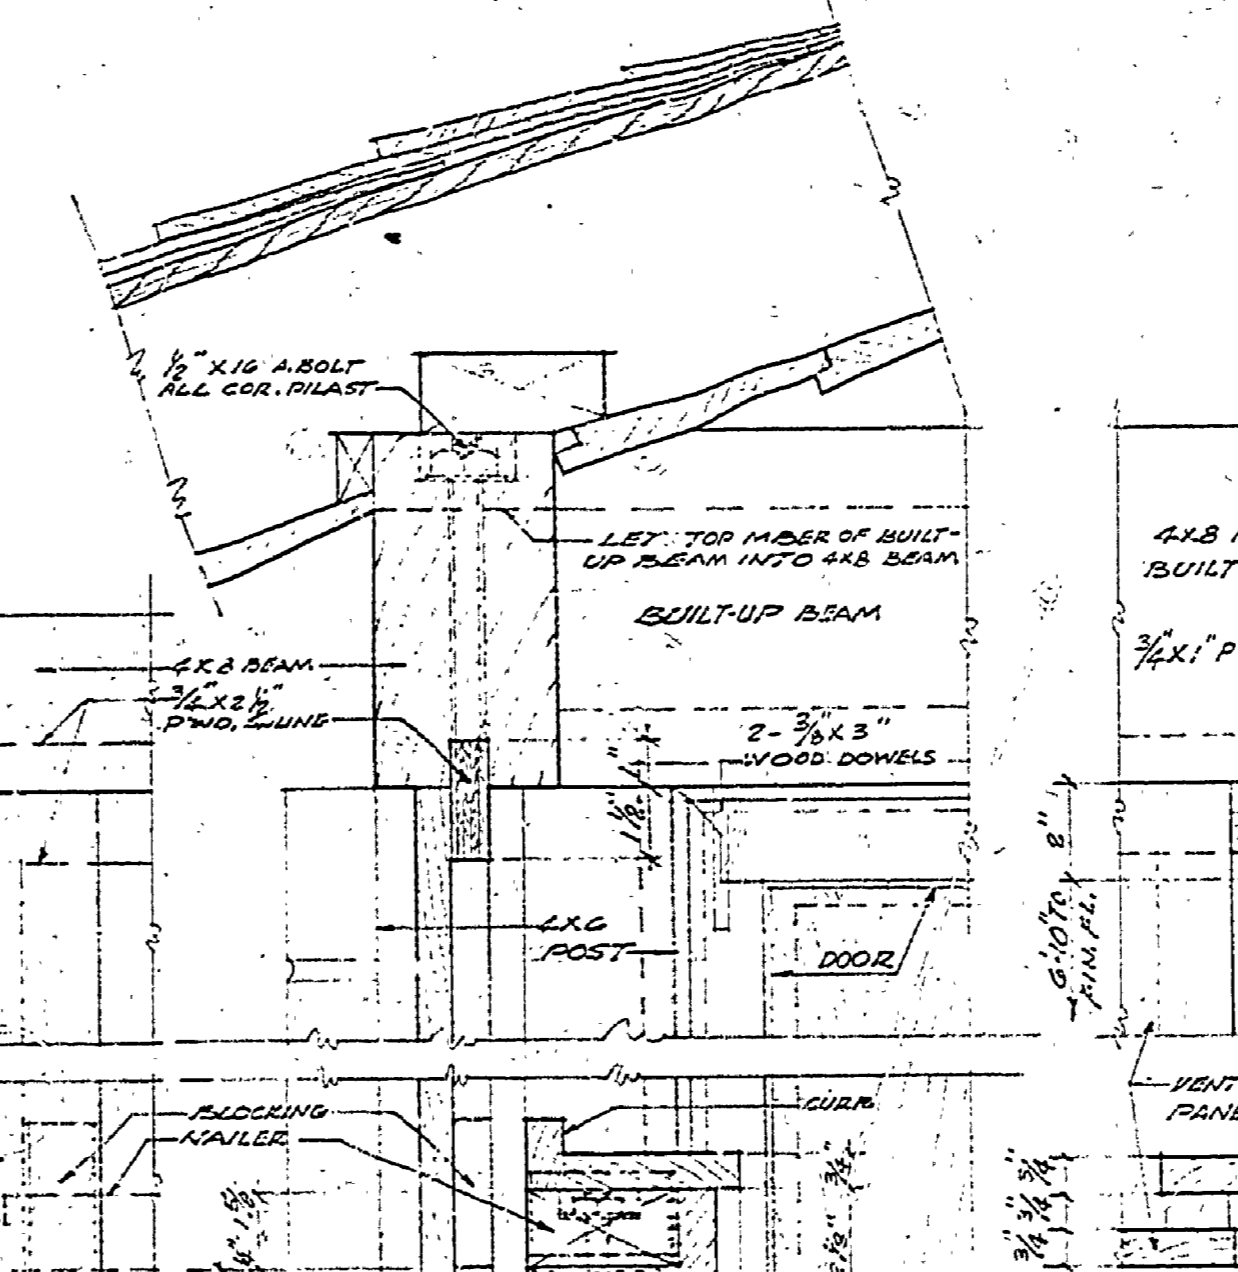


ELEVATION CONCRETE SILL & WOOD PANELING DETAILS SCALE 3" = 1'-0"

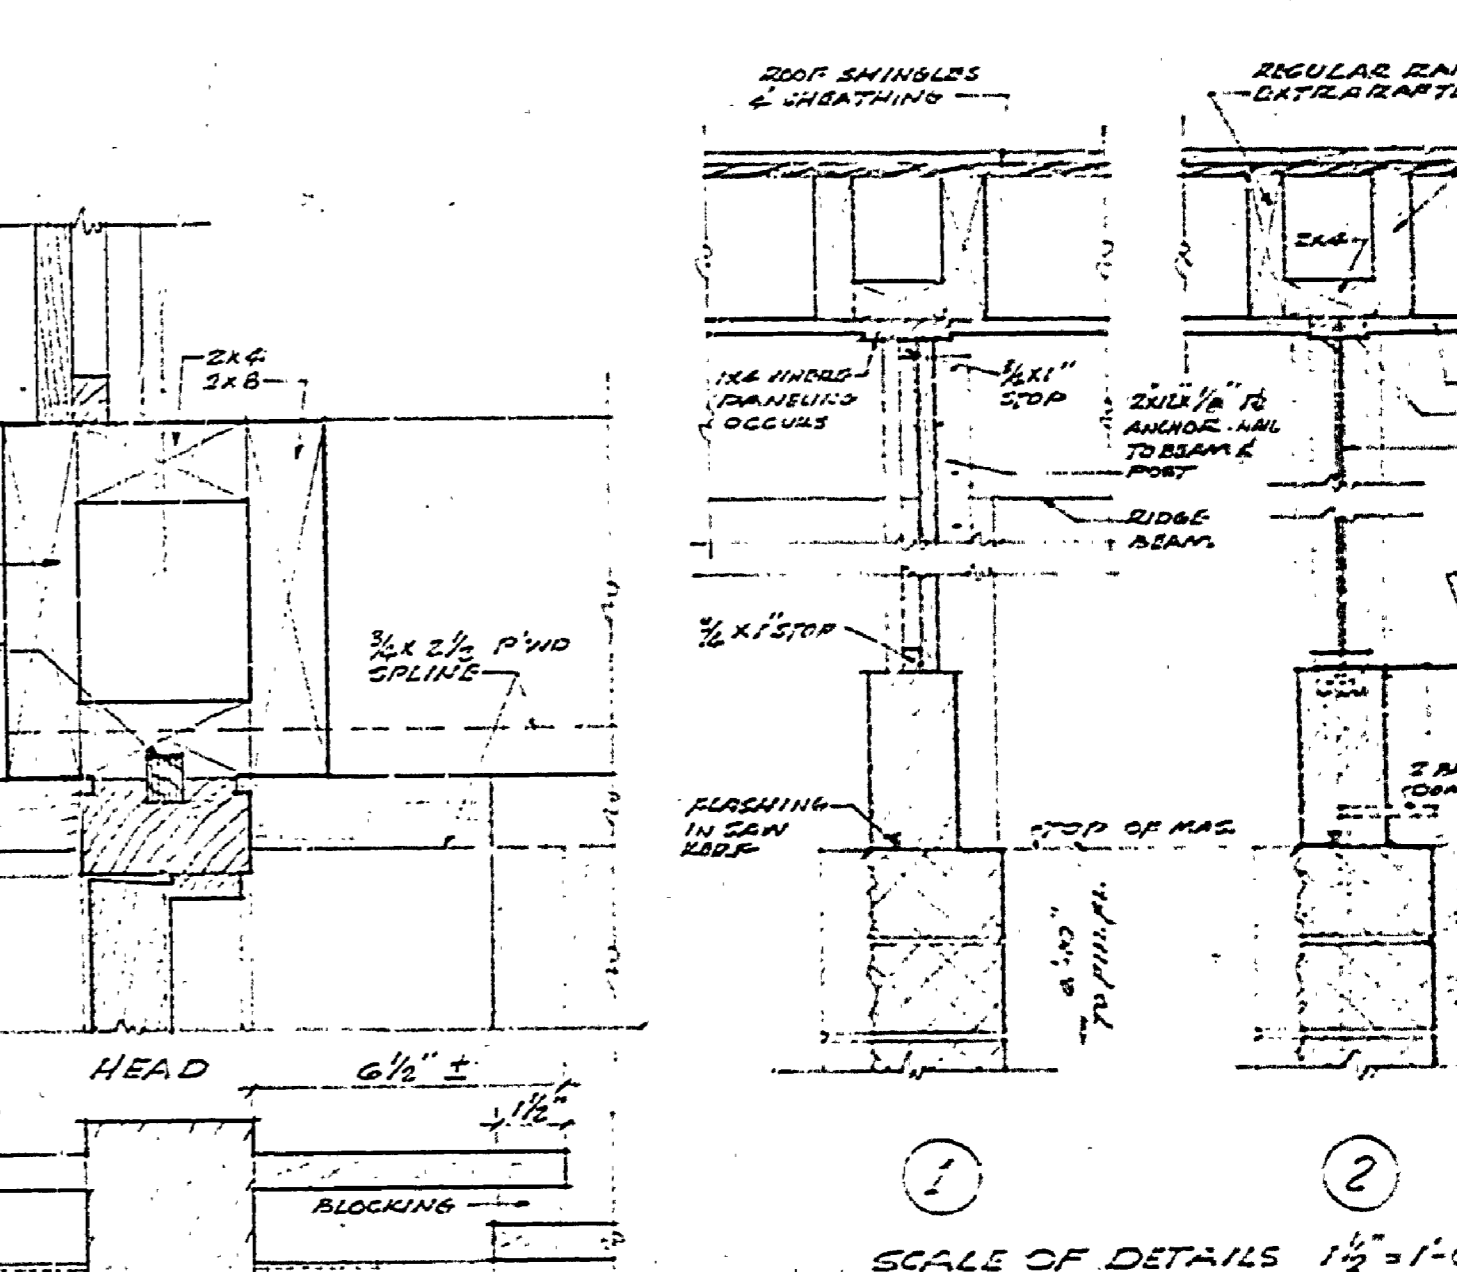


DOOR JAMB DETAILS SCALE 3" = 1'-0"

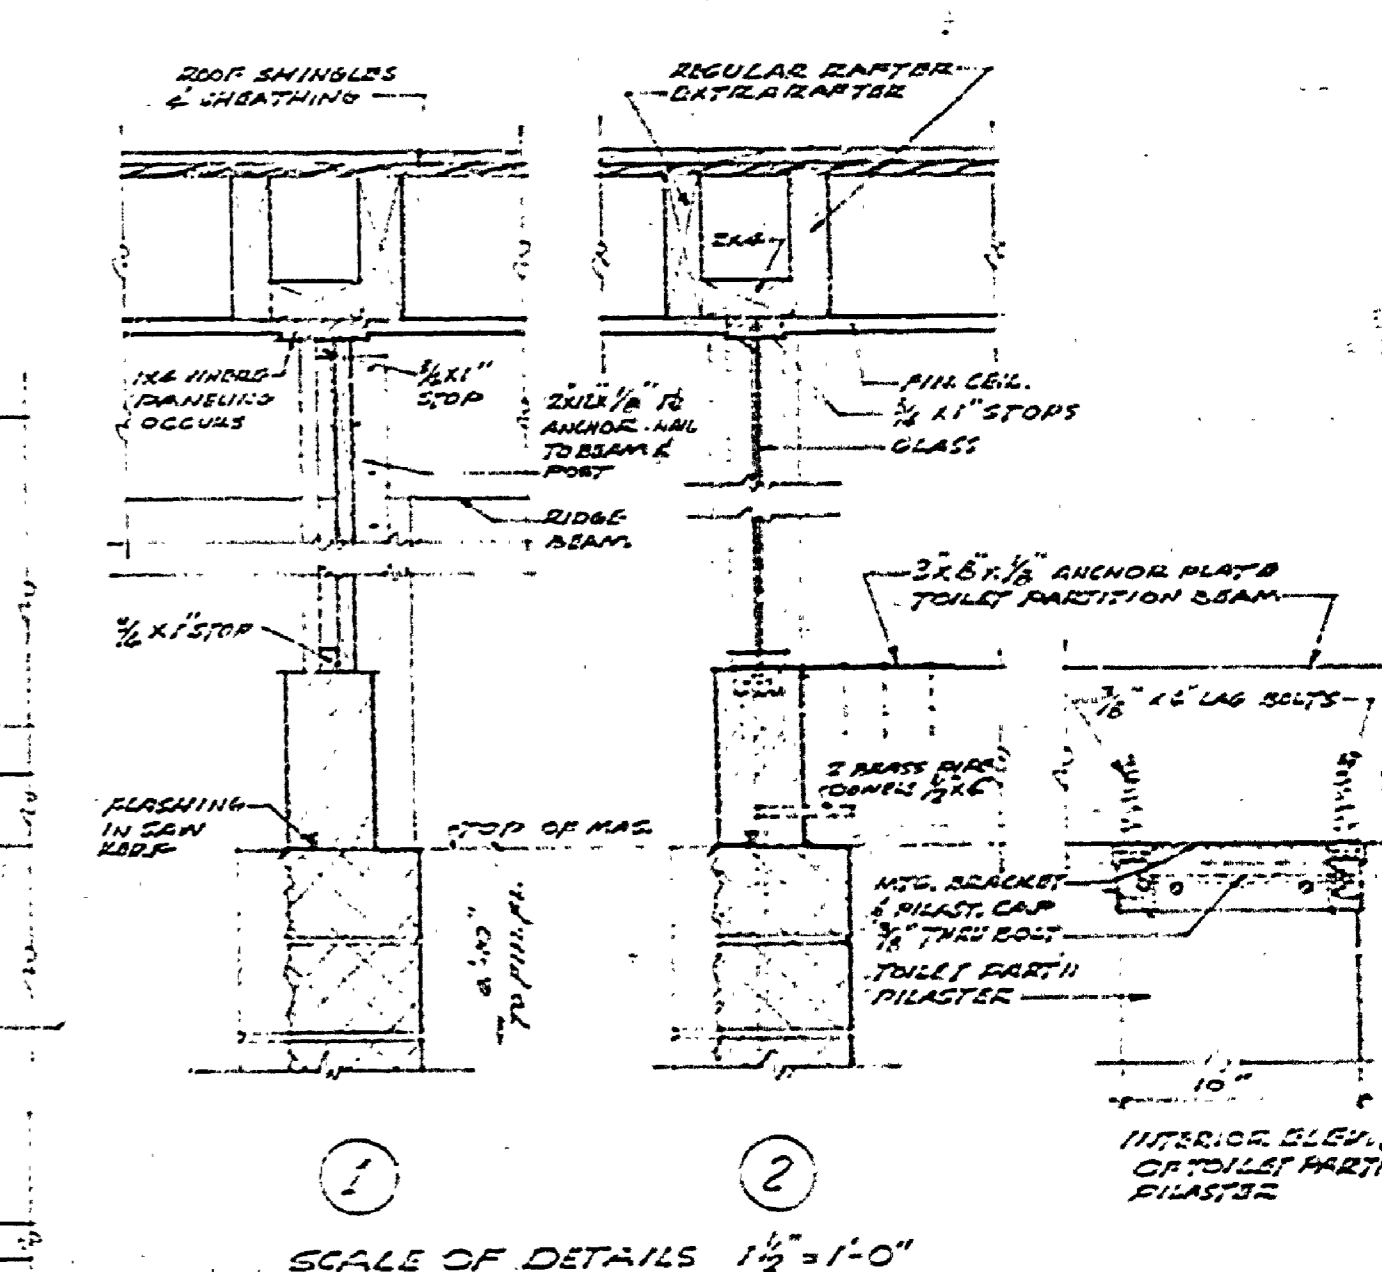


SCALE OF DETAILS 1/2" = 1'-0"

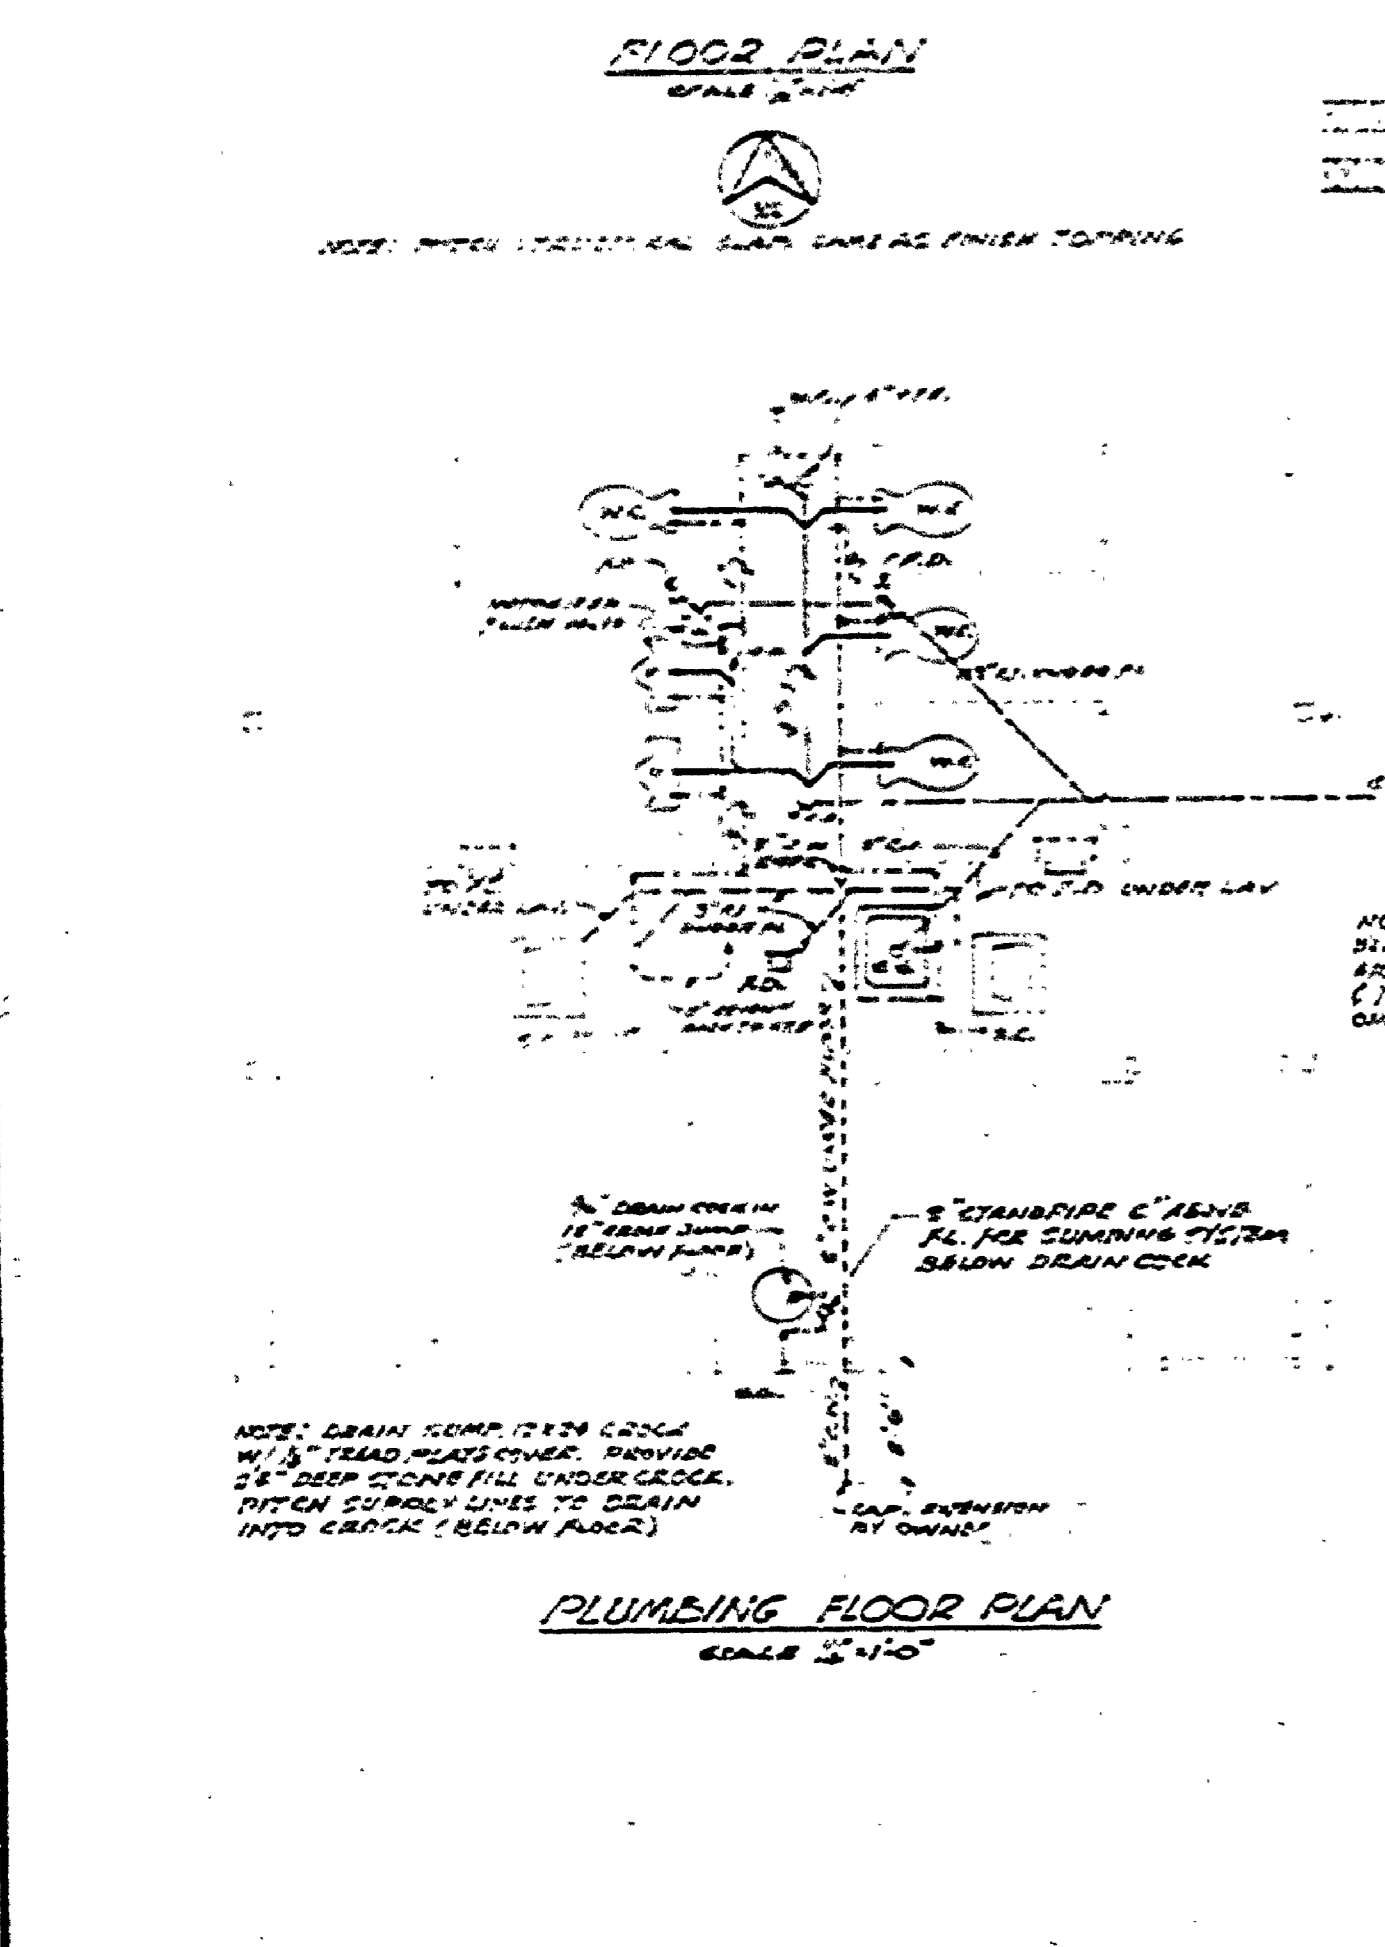


PLUMBING FLOOR PLAN SCALE 1/4" = 1'-0"

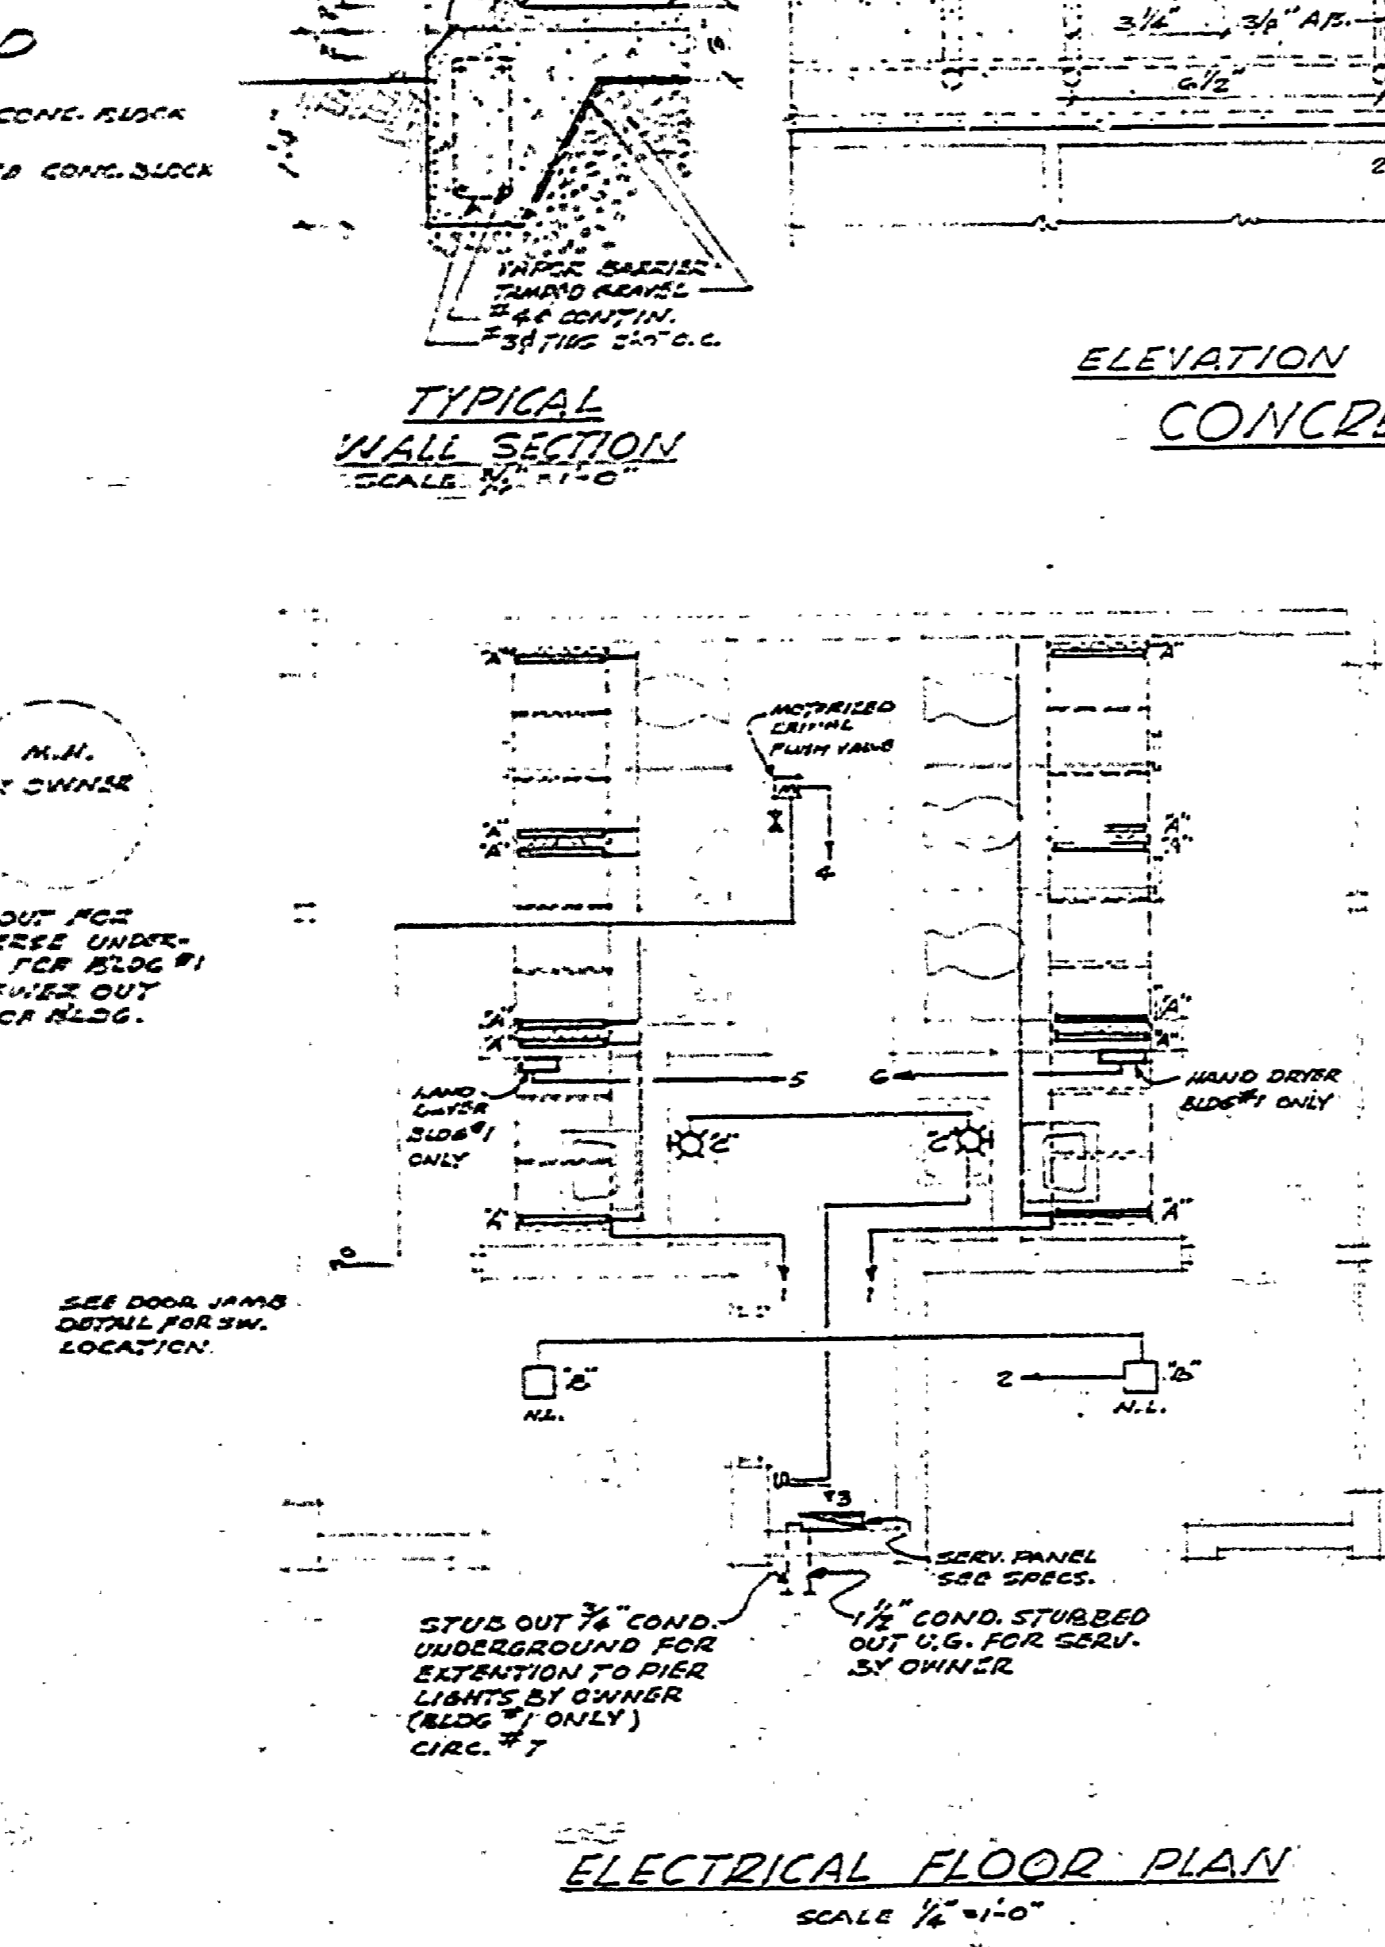

ELECTRICAL FLOOR PLAN SCALE 1/4" = 1'-0"

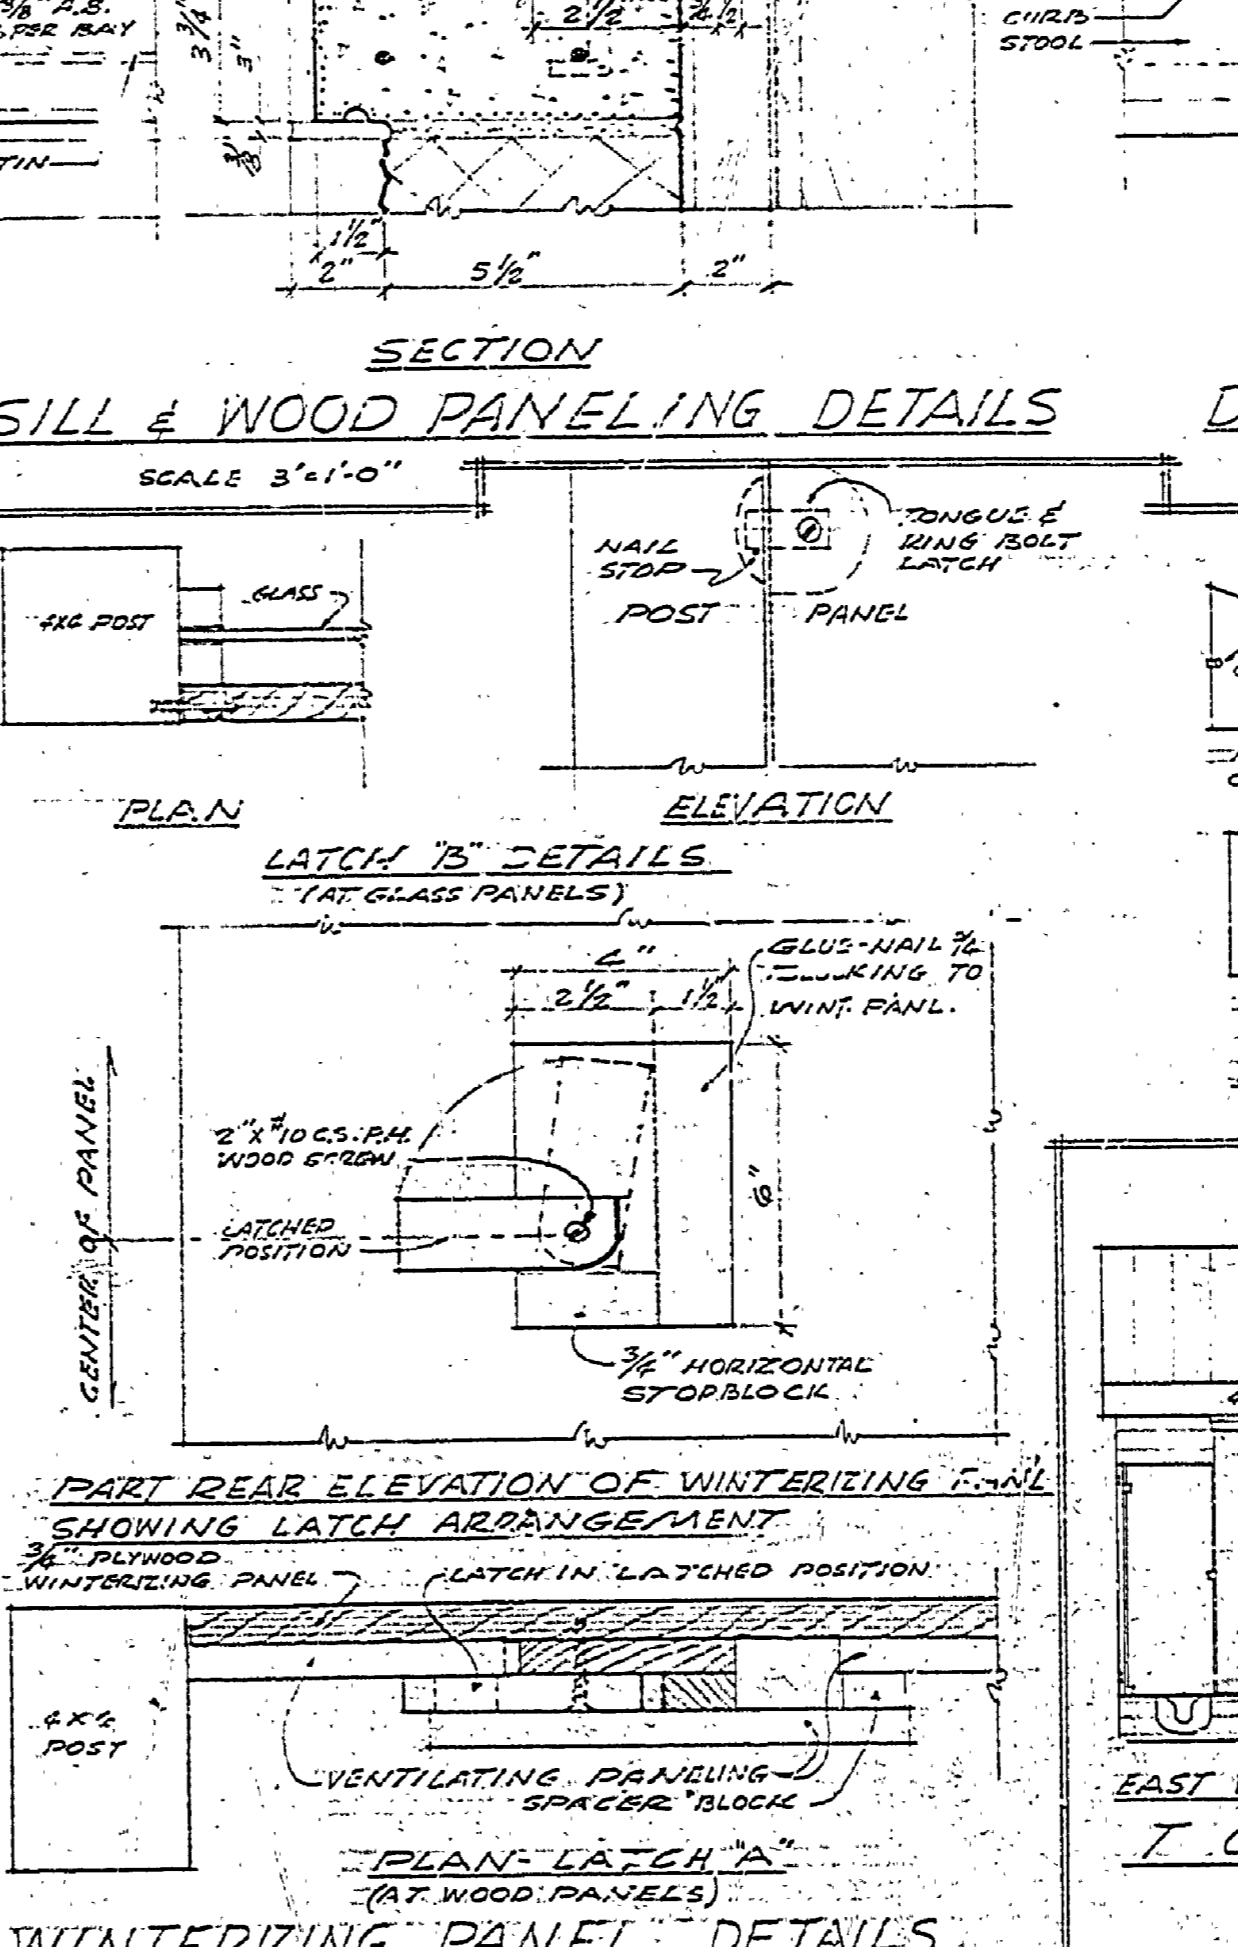

WINTERIZING PANEL DETAILS SCALE 3" = 1'-0"

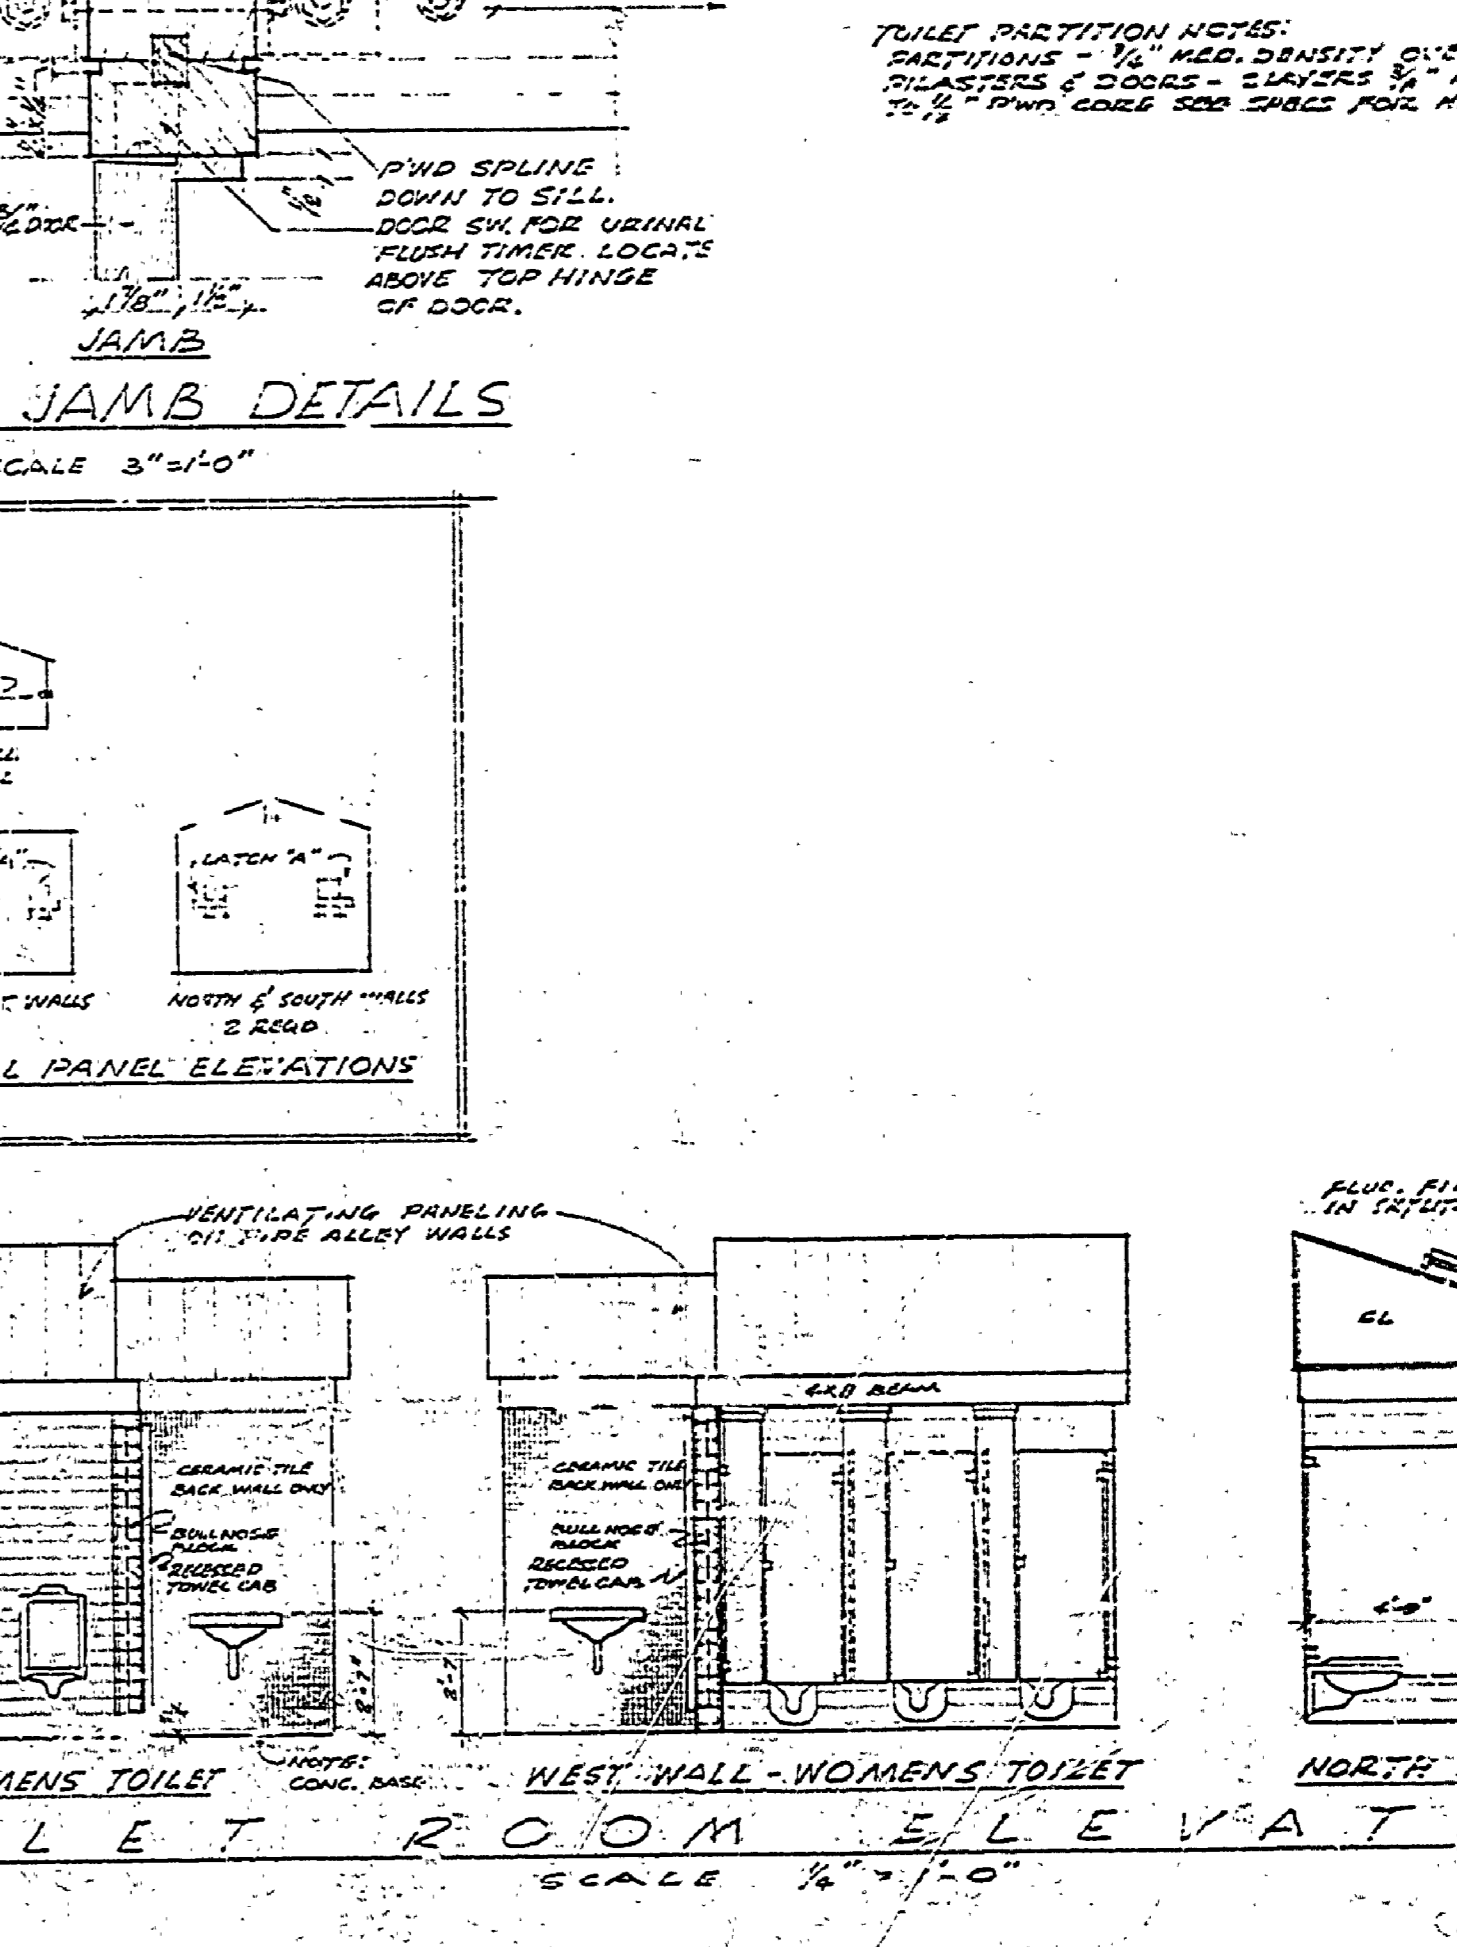

EAST WALL - MEN'S TOILET TOILET ROOM ELEVATIONS SCALE 1/2" = 1'-0"