




DRAWN BY	E. J. P.	REVIEWED BY SECTIONS	DATE	APPROVED BY	NO.	DATE	BY
TRACED BY	E. J. P.	ARCHITECTURAL	7-8-46	<i>[Signature]</i>	1		
CHECKED BY		ENGINEERING	3 Jun 46	ASSISTANT CHIEF IN CHARGE	2		
DATE	4-17-46	LANDSCAPE	7/5/46	OF DESIGN	3		
					4		
					5		
					6		

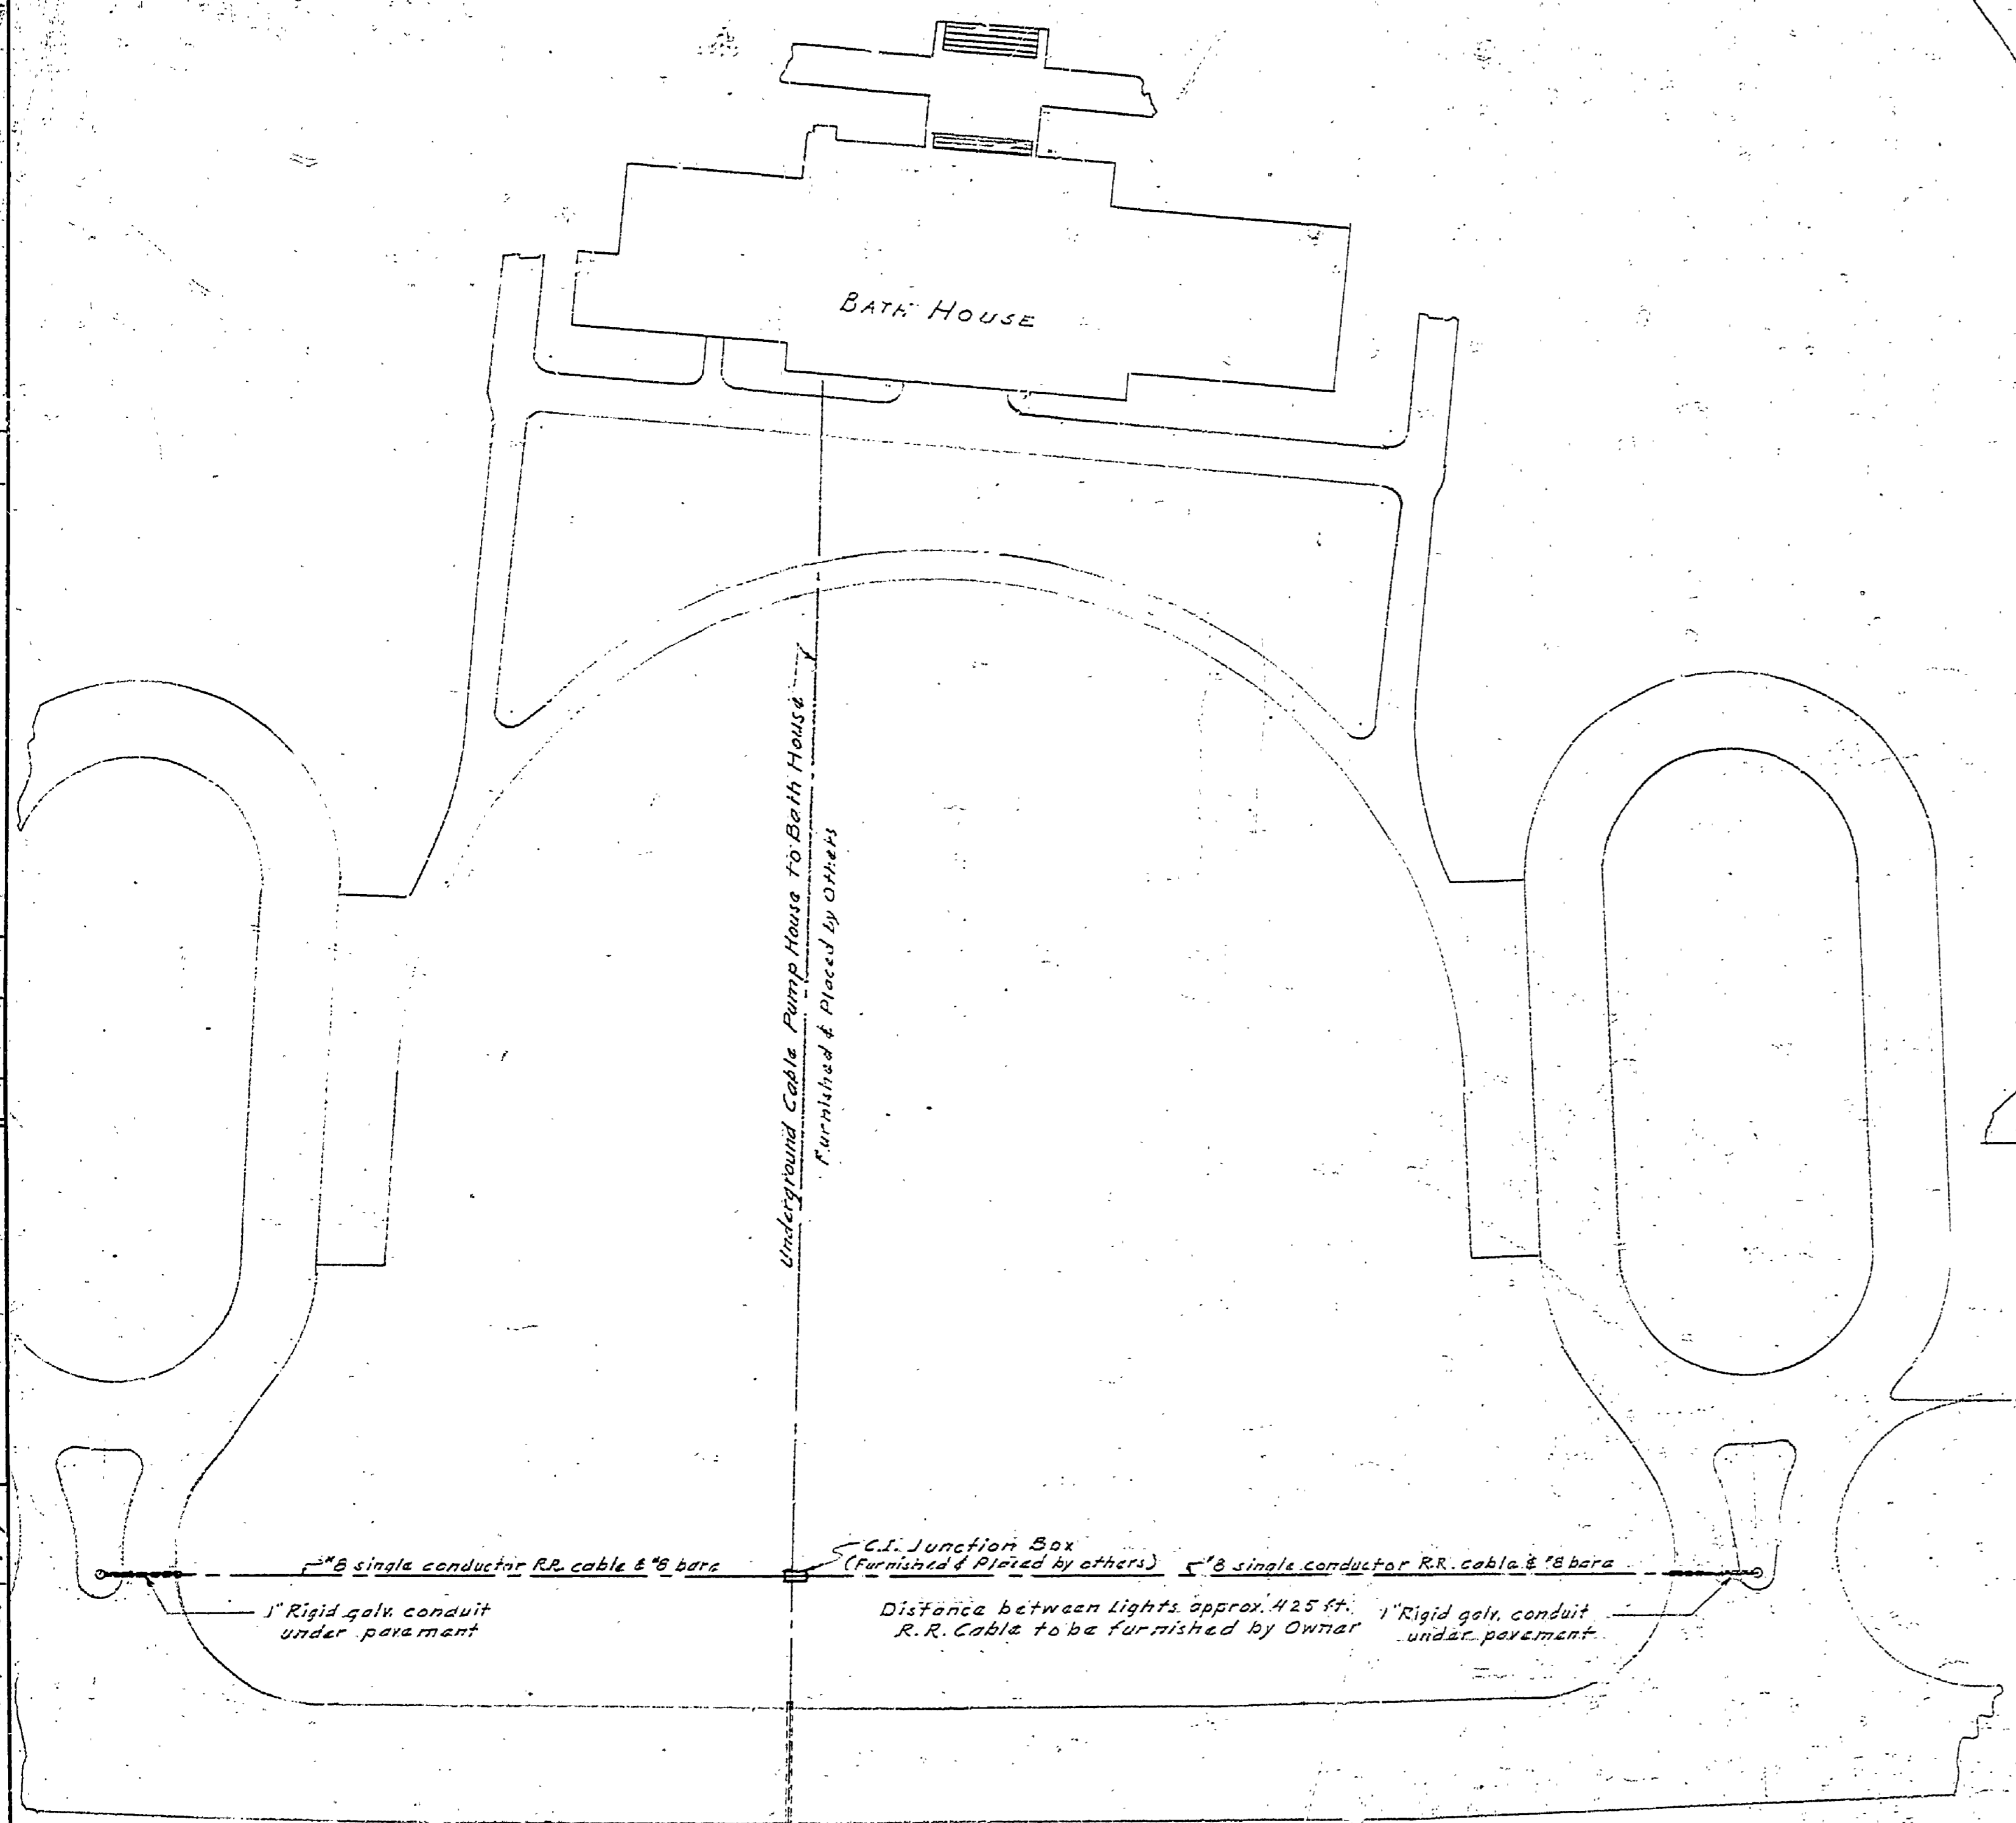


PLAN OF LIGHTING LAYOUT
SCALE 1" = 30'-0"

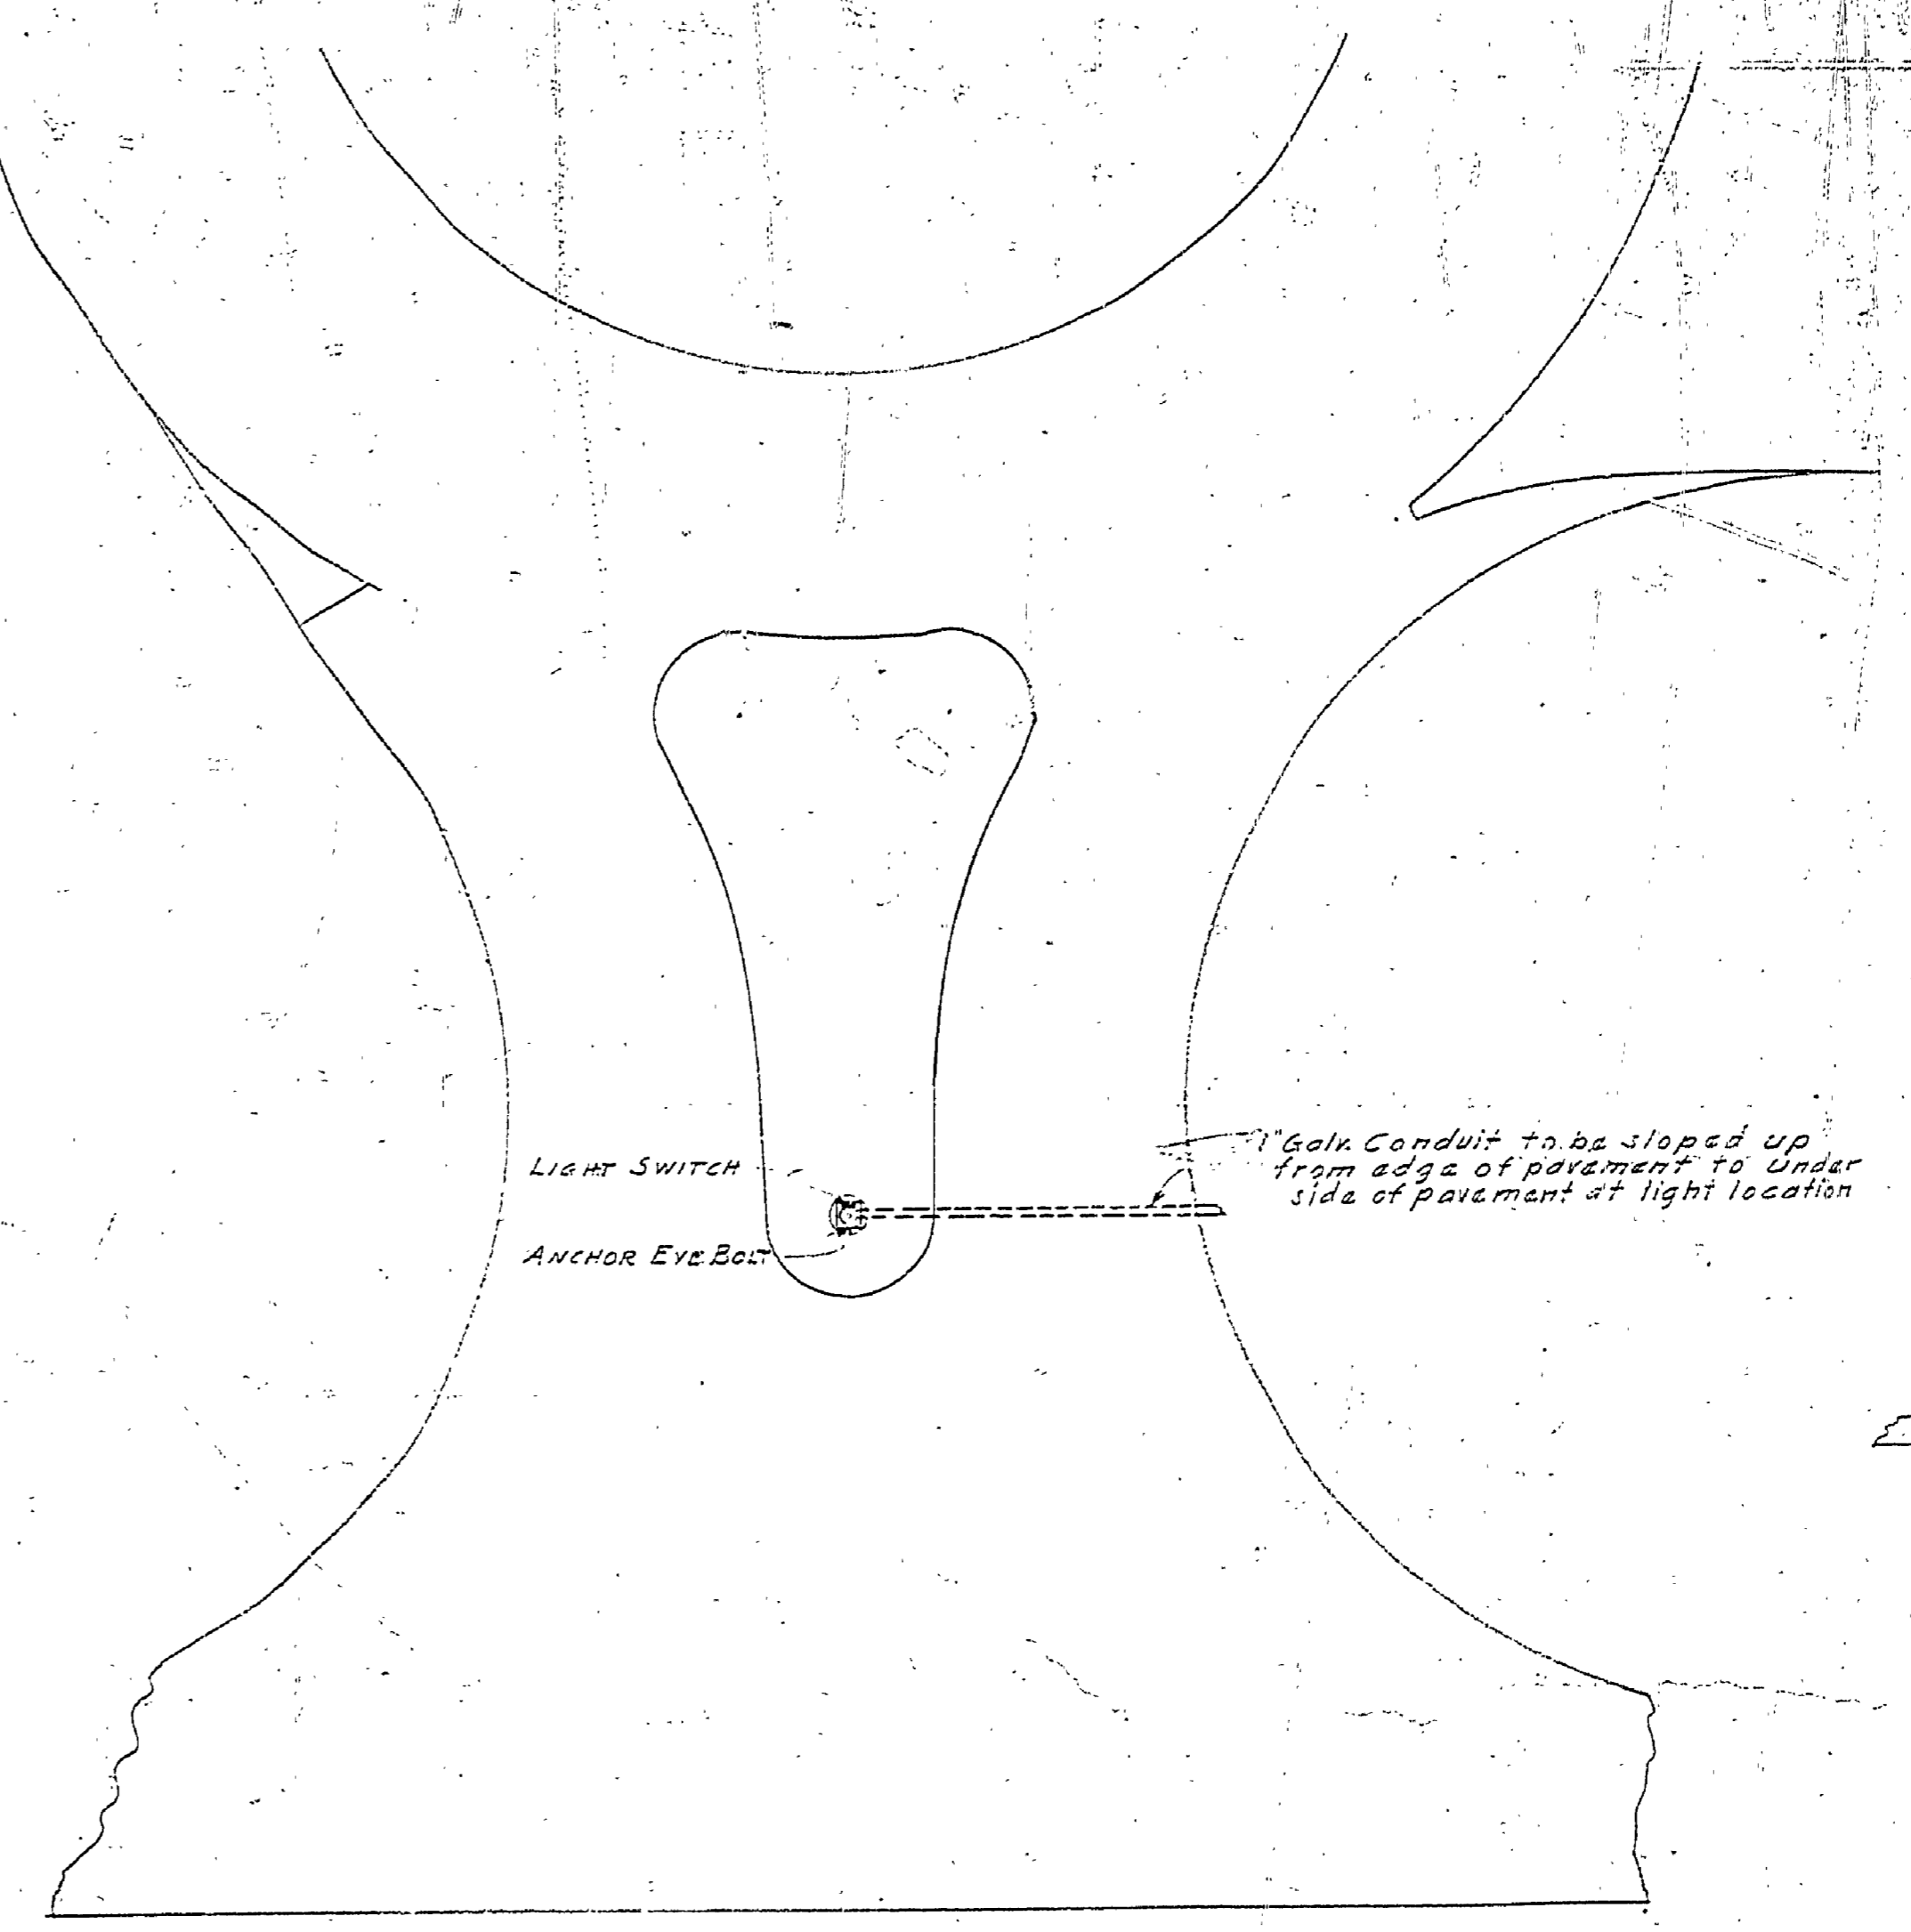


ISLAND LIGHT LOCATION
SCALE 1" = 10'-0"

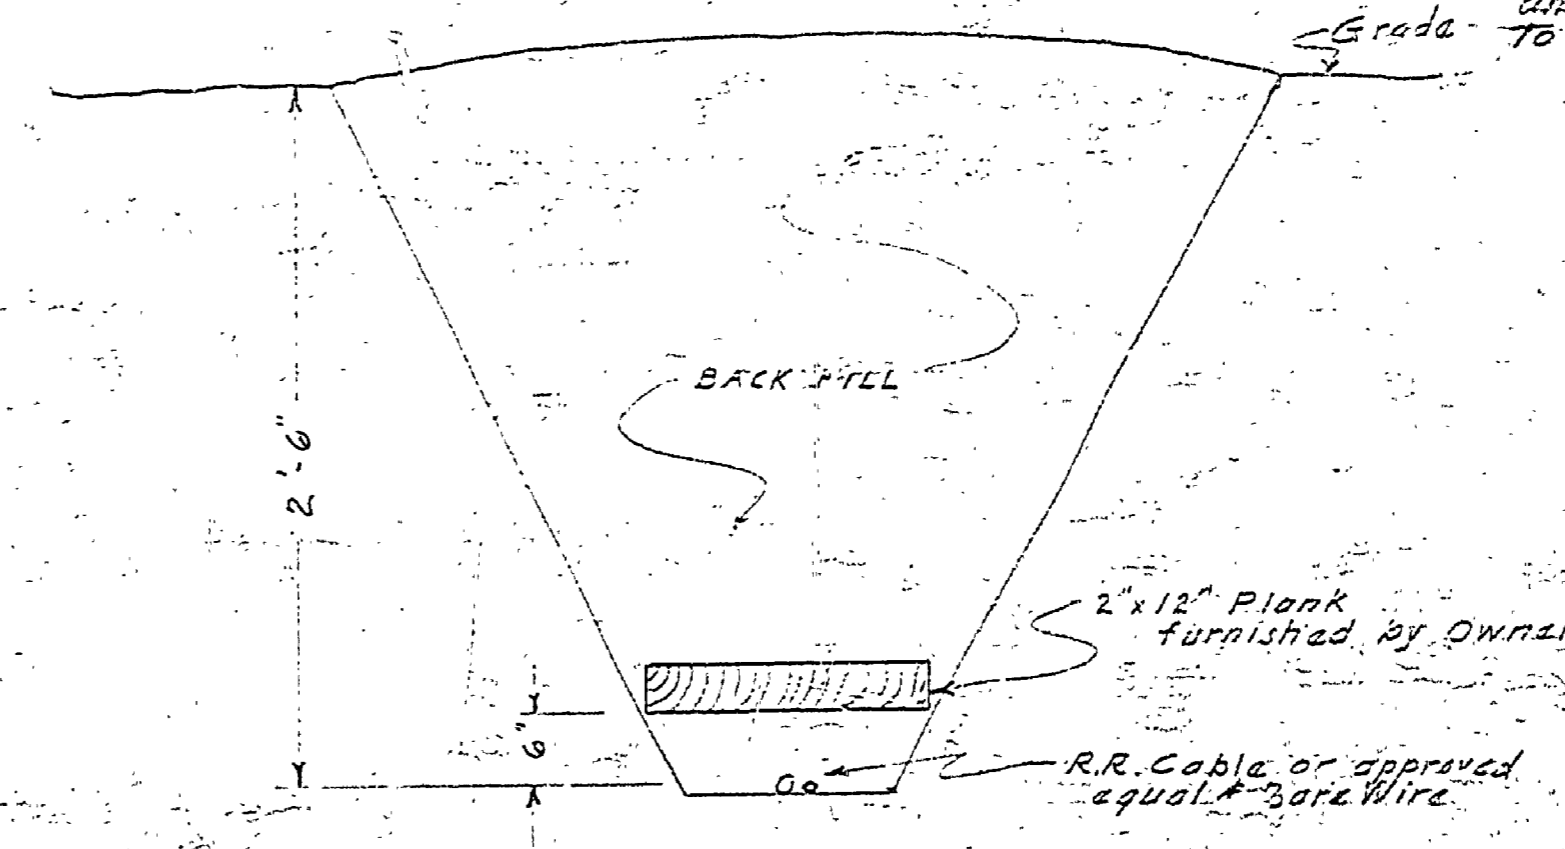

CROSS SECTION OF CABLE TRENCH
NO SCALE

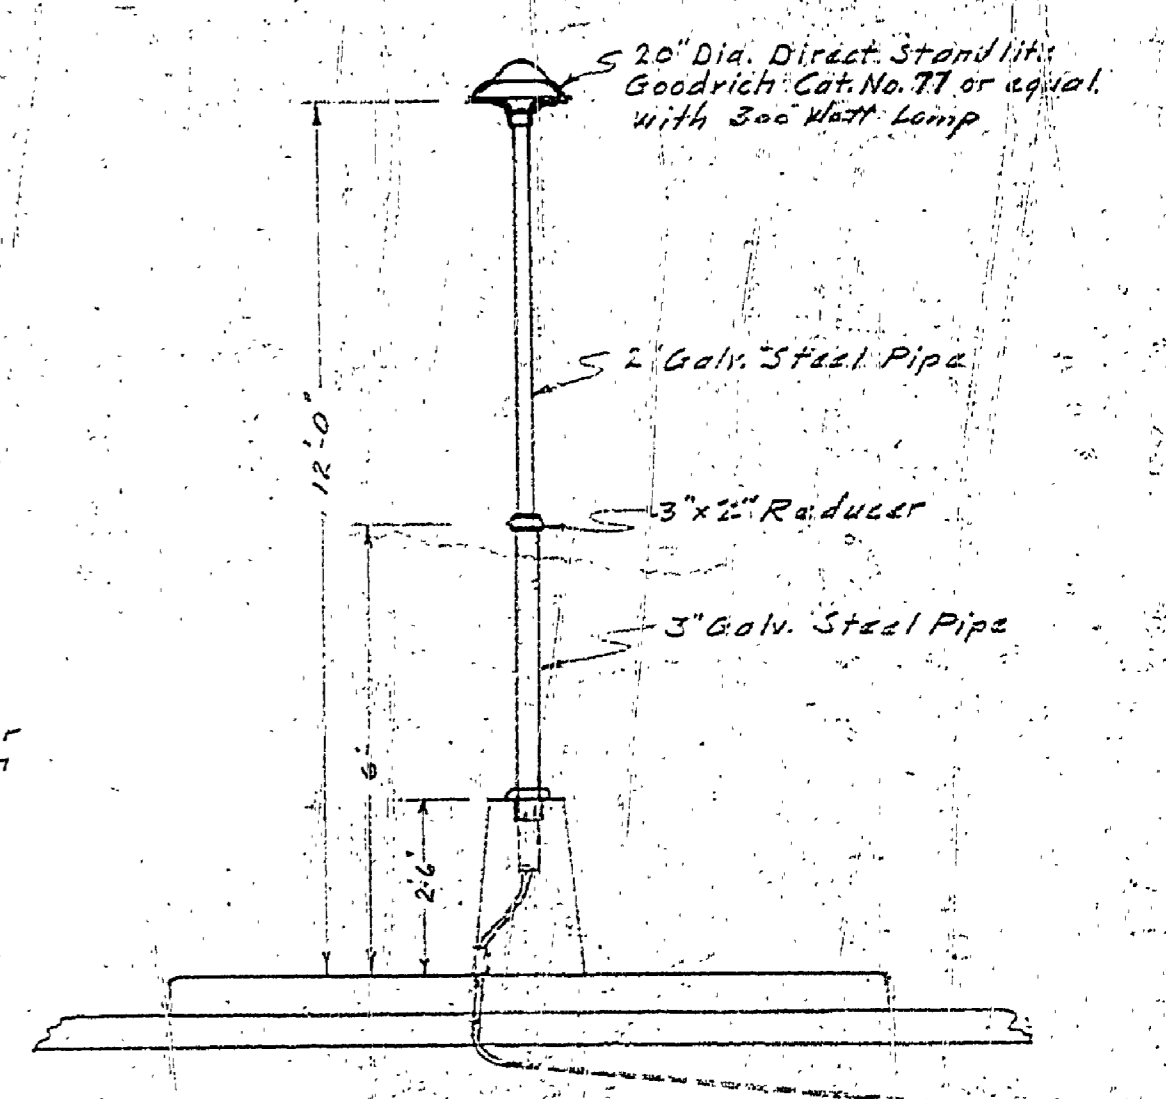

LIGHTING STANDARD DETAILS
SCALE 3/8" = 1'-0"

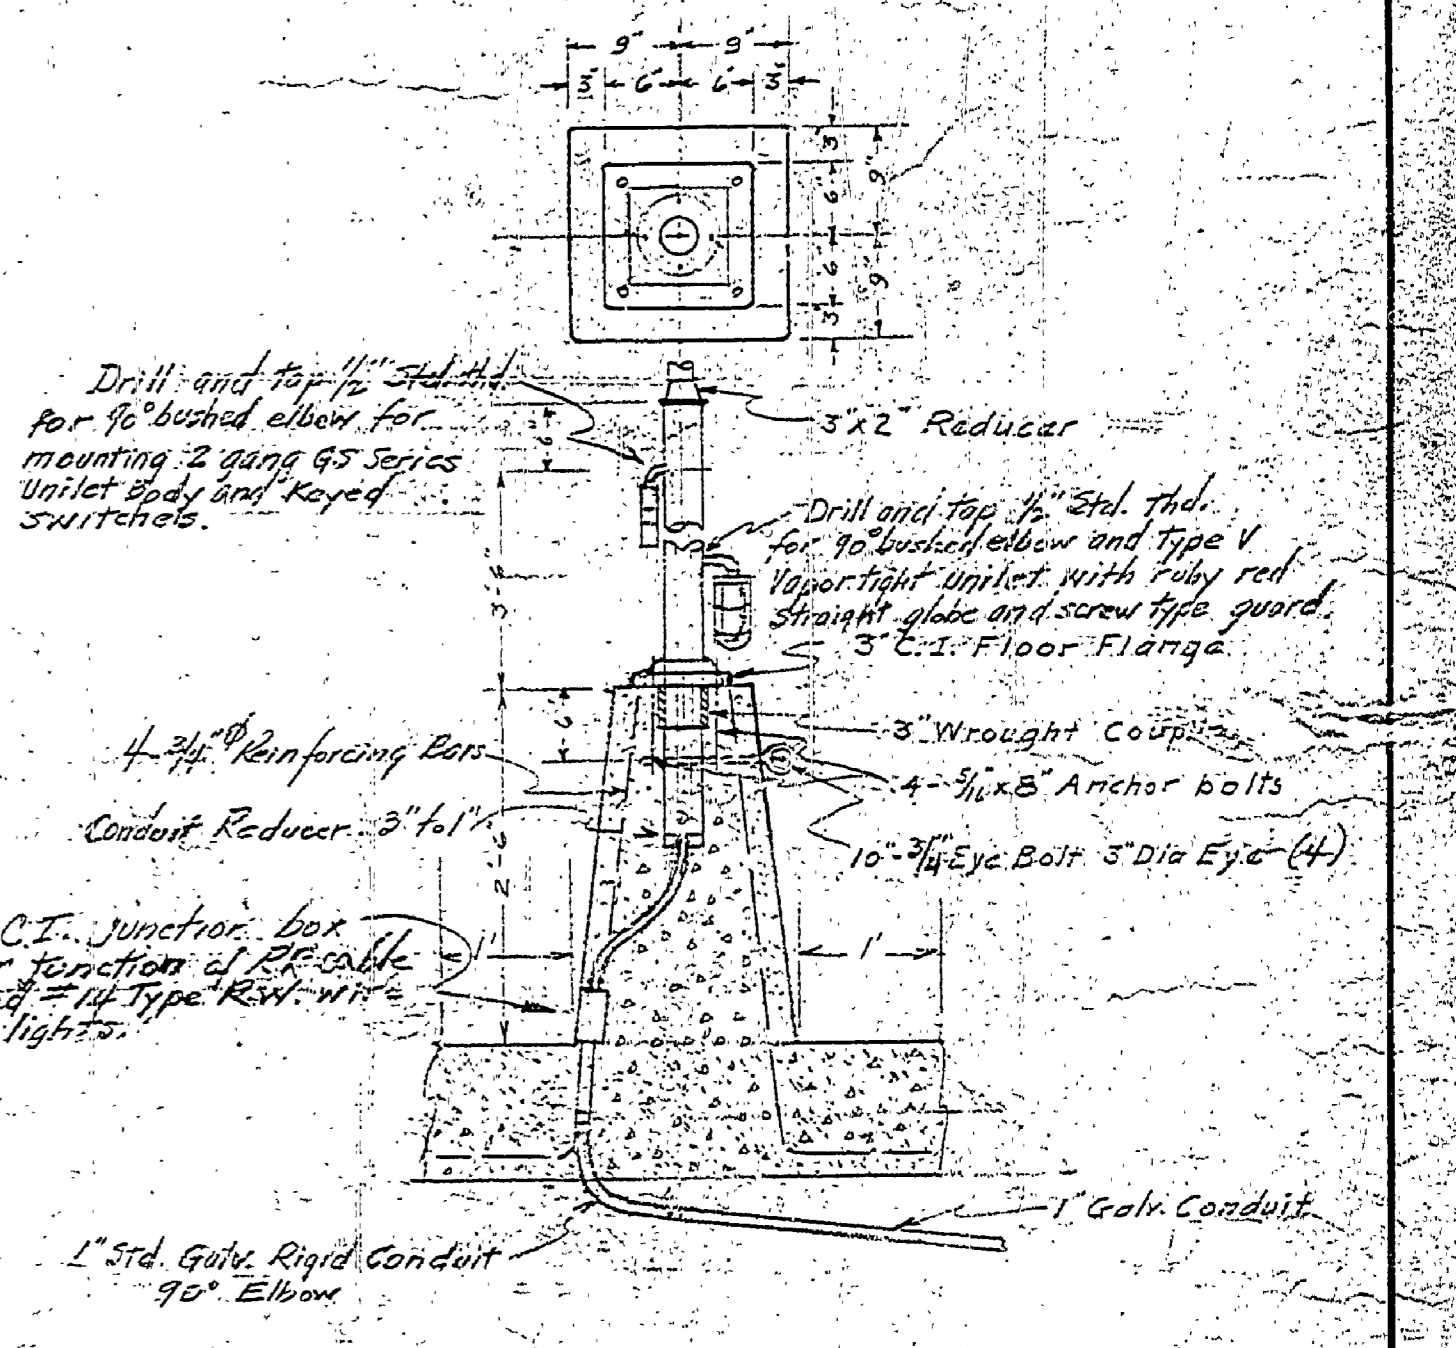

DETAIL OF CONC. BASE
SCALE 3/4" = 1'-0"