

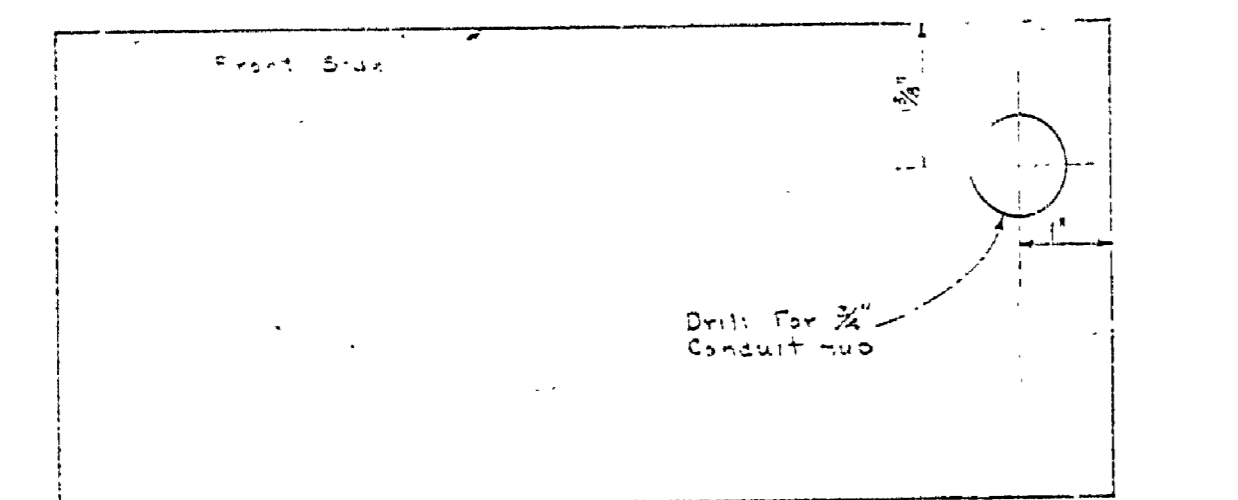
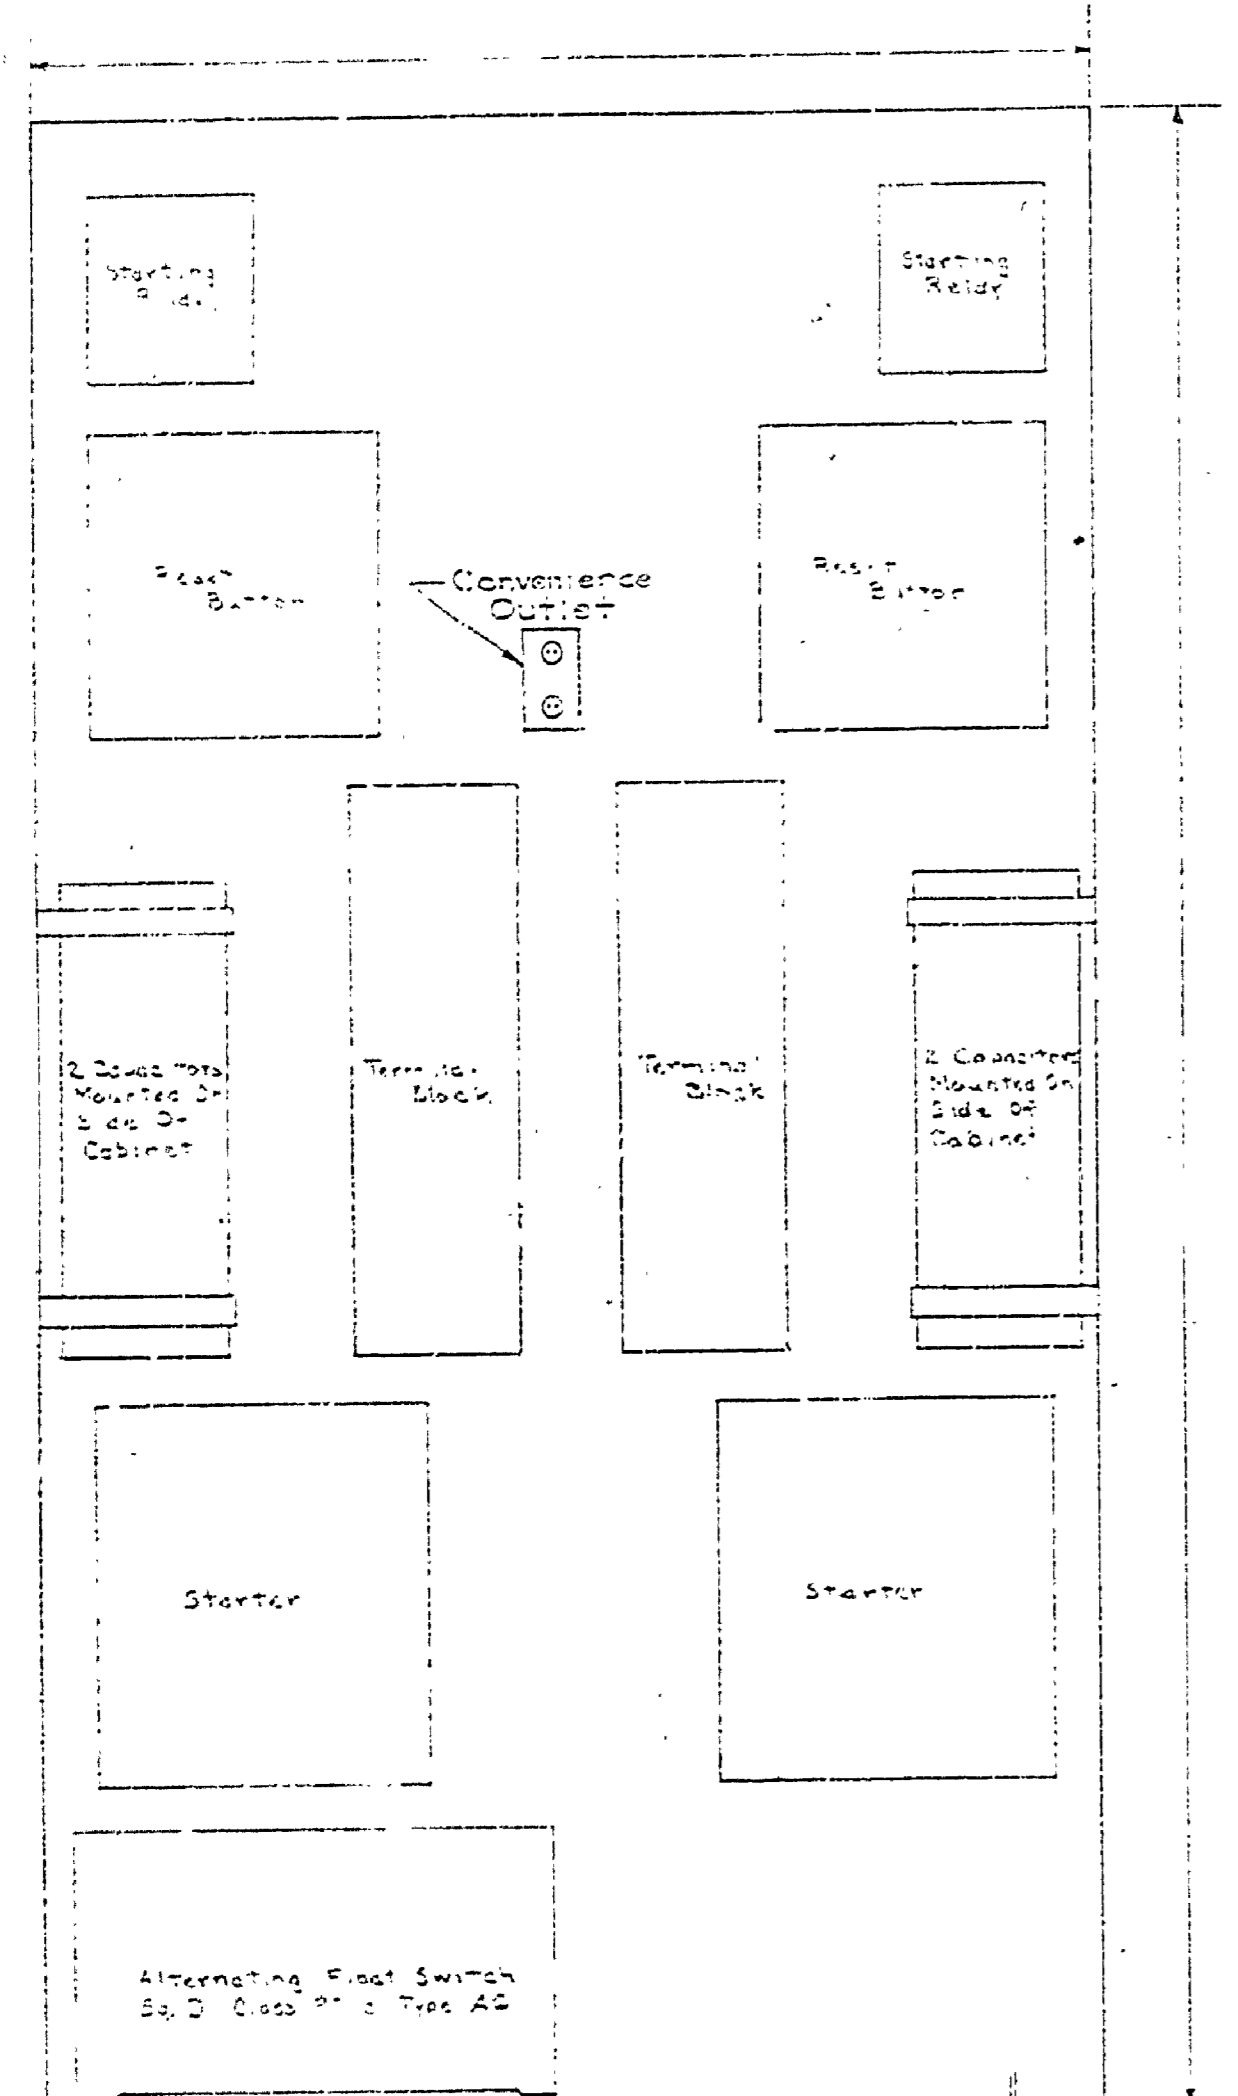


DRAWN BY D.M.C.	CHECKED BY DATE	REVIEWED BY SECTIONS		APPROVED BY	
		ARCHITECTURAL ENGINEERING LANDSCAPE	DATE 12/17/63 12/14/63 12/17/63 12/17/63	DATE 12/17/63 12/14/63 12/17/63 12/17/63	DATE 12/17/63 12/14/63 12/17/63 12/17/63
DATE		REVISIONS		NO. DATE BY	
				1	
				2	
				3	
				4	
				5	
				6	

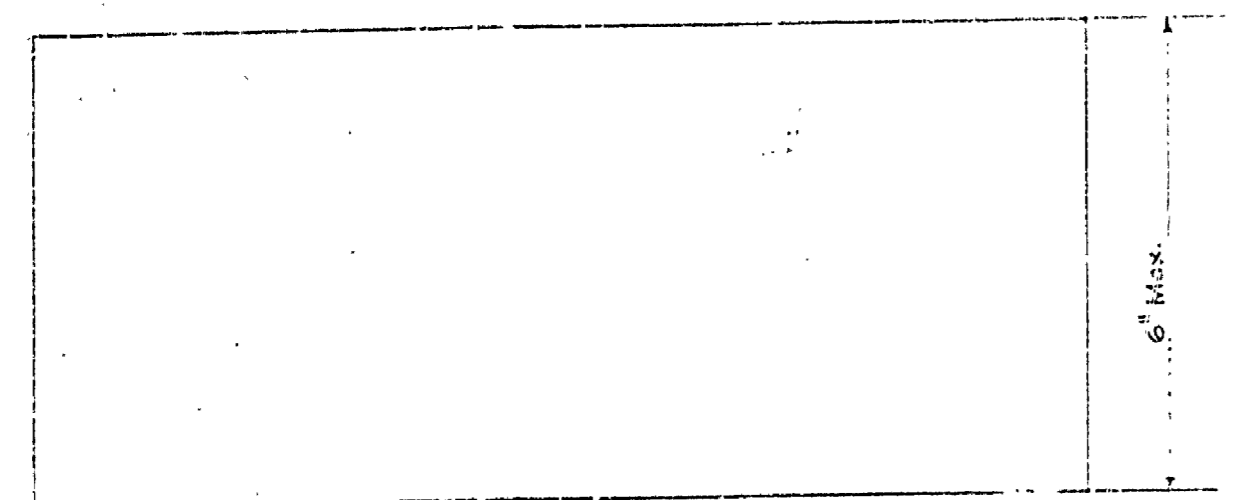




CONTROL FOR DUAL PUMPS  
Half Scale

1 PHASE PUMP CONTROL PANEL

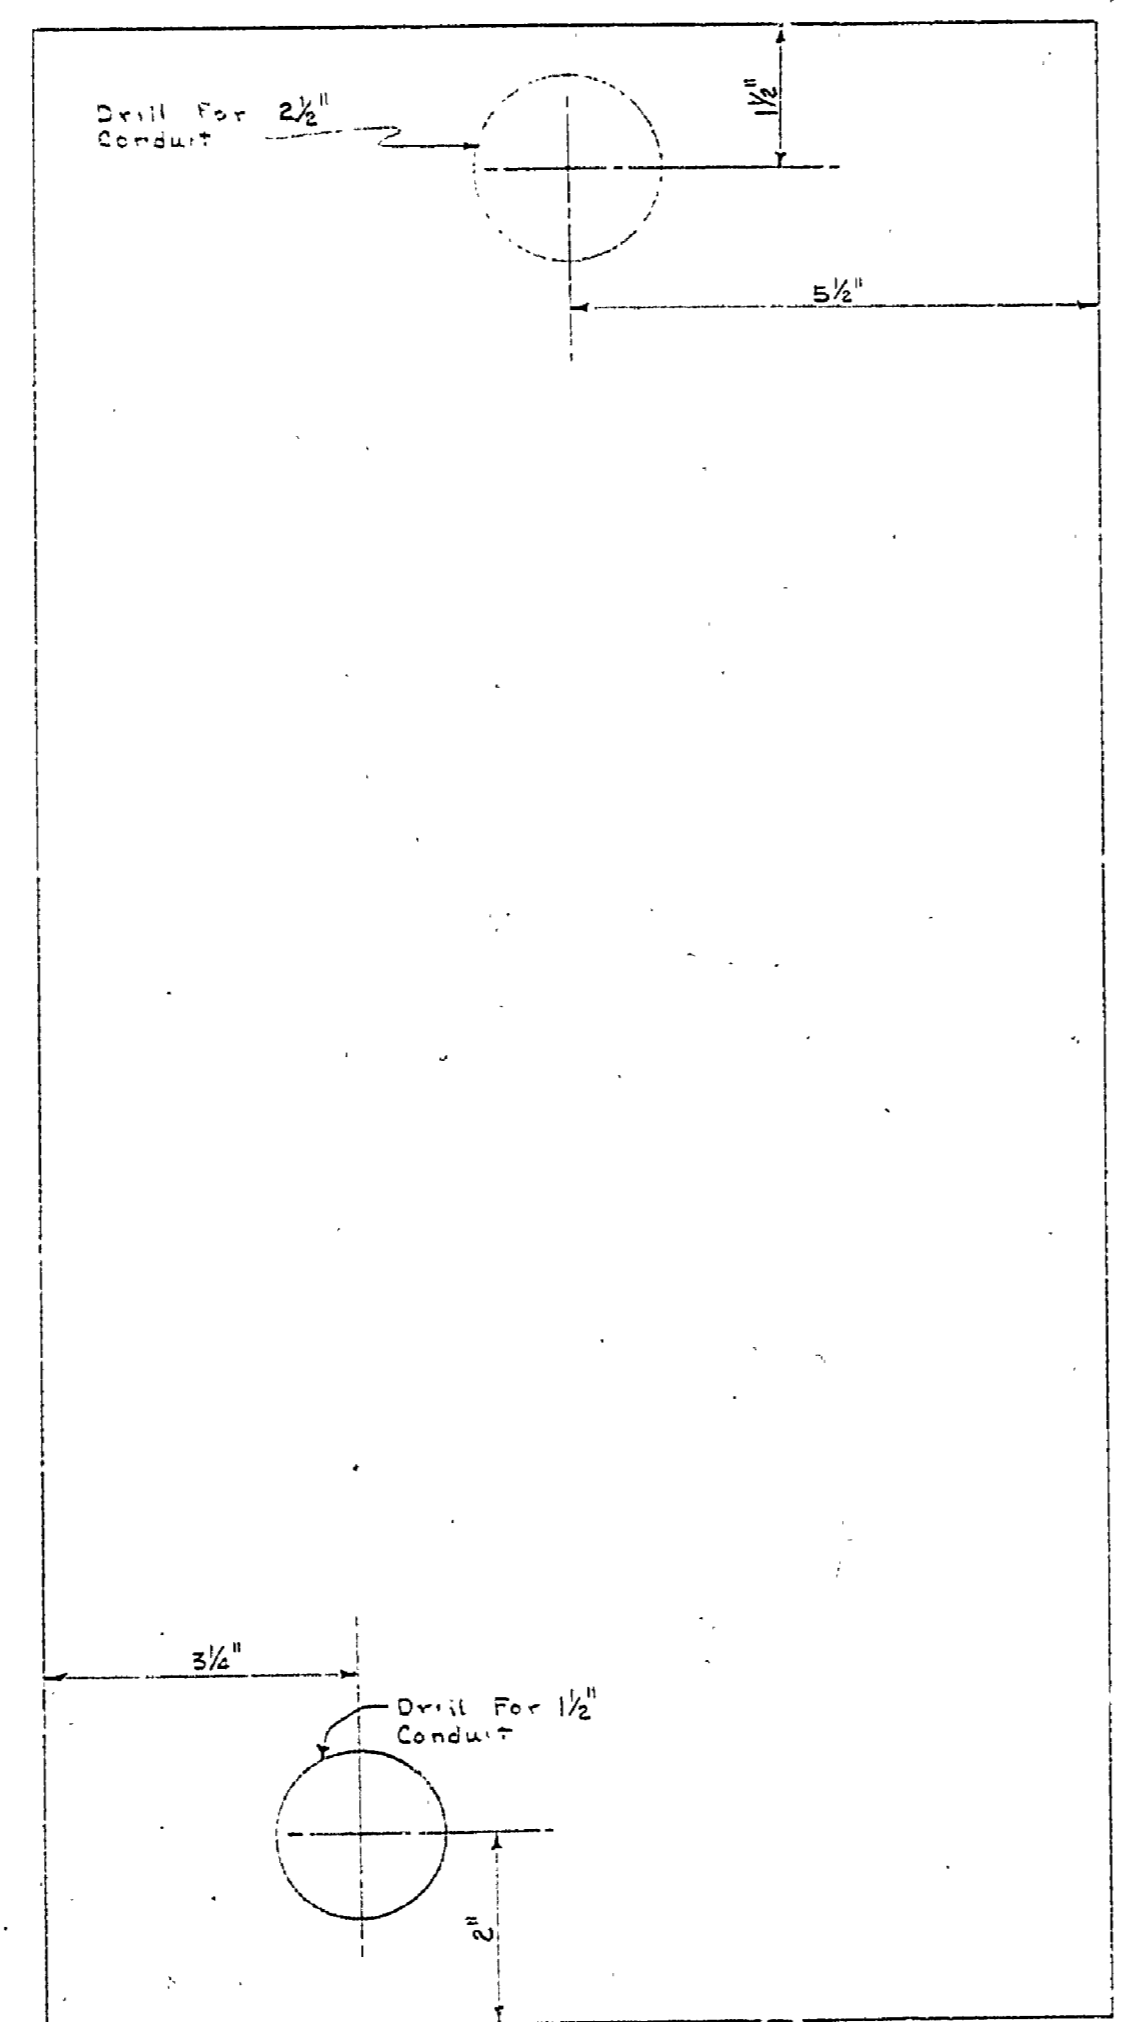


BACK

NOTES:  
Cabinet is shown here with cover removed.

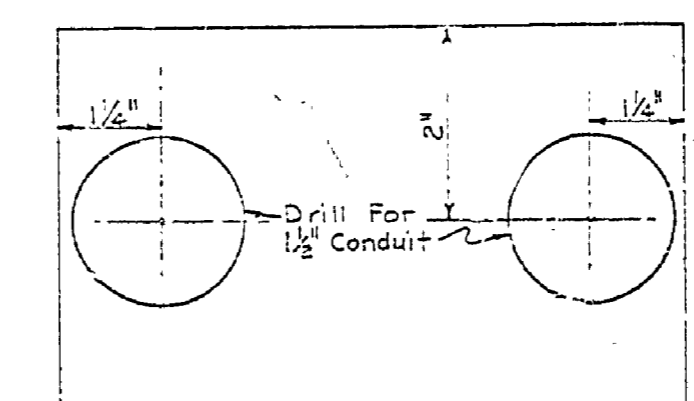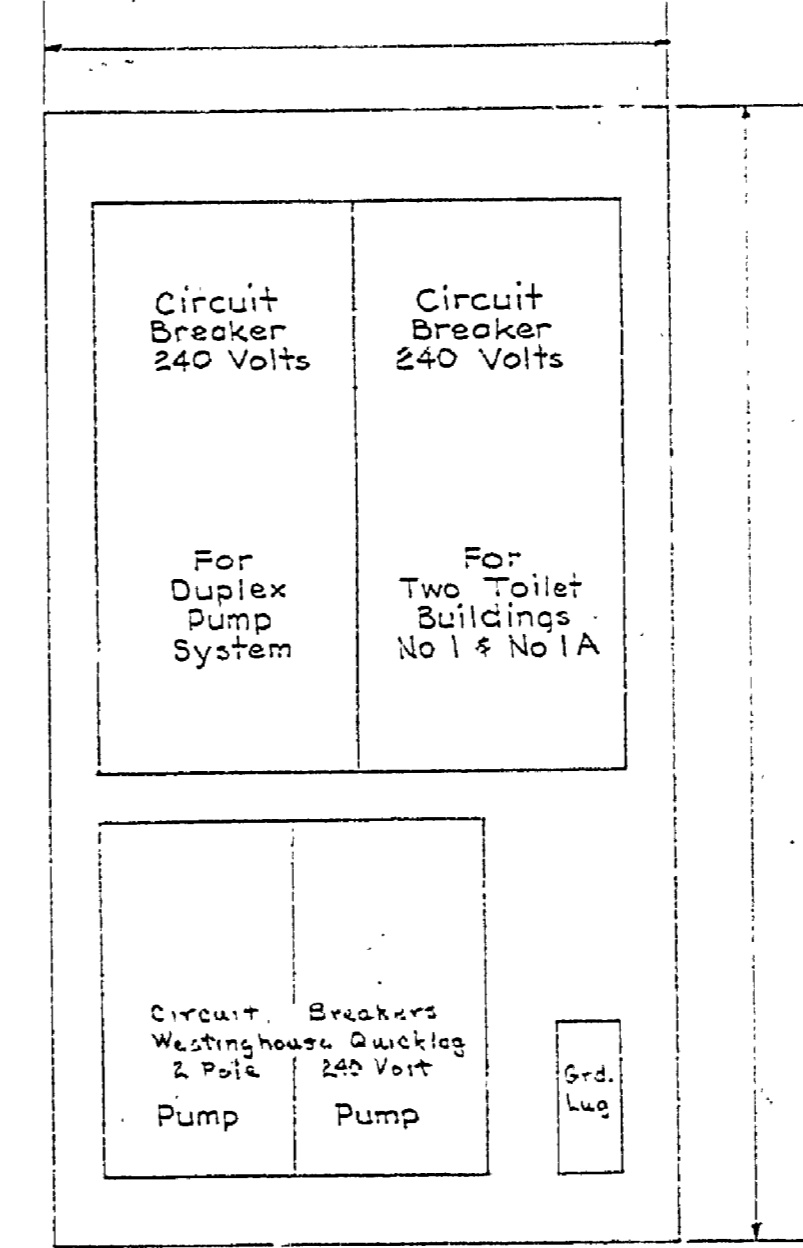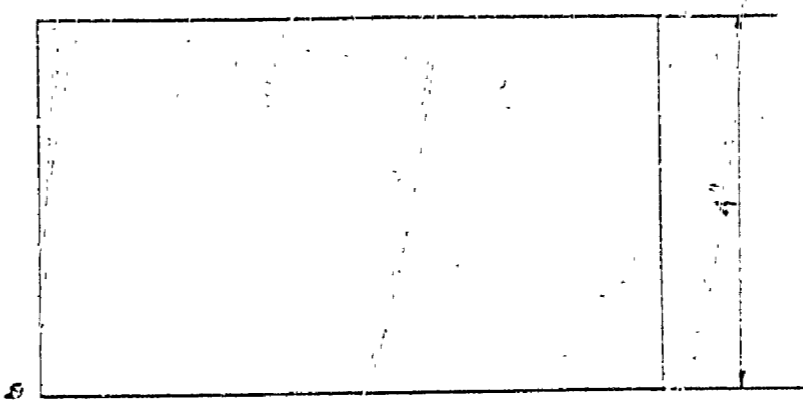


MAIN DISCONNECT  
Half Scale

NOTES:  
Do Not Pour Top Slab of Wet Well Until After Switch & Pump Control Pedestal is Assembled and Set in Position in Form for Top Slab.

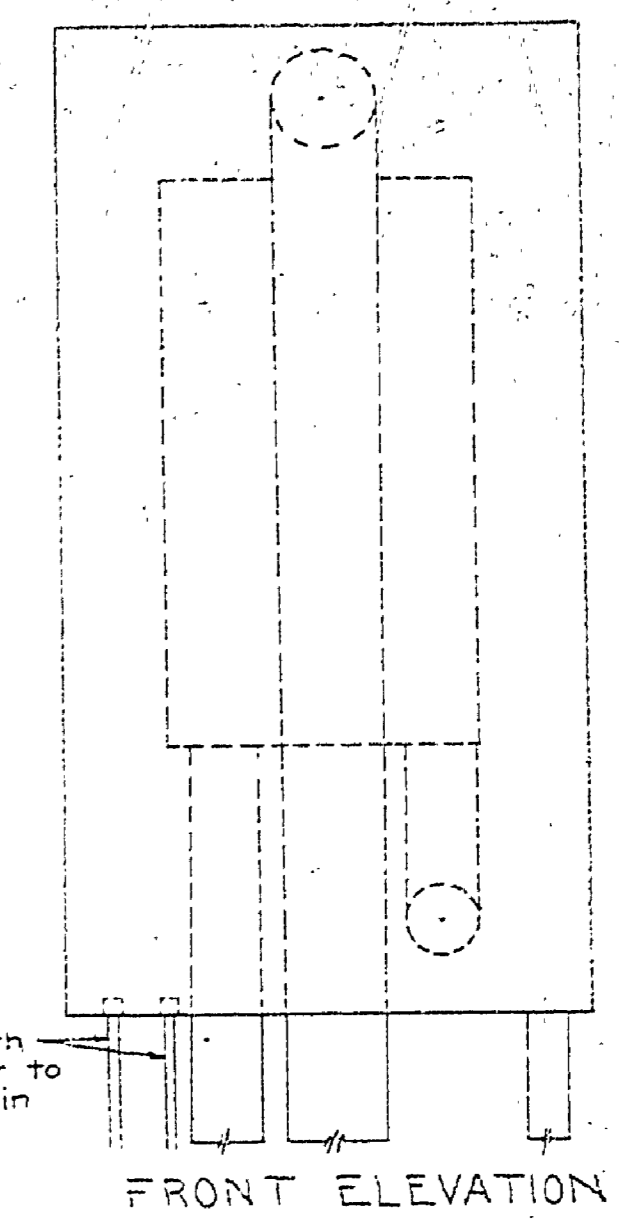

FRONT ELEVATION

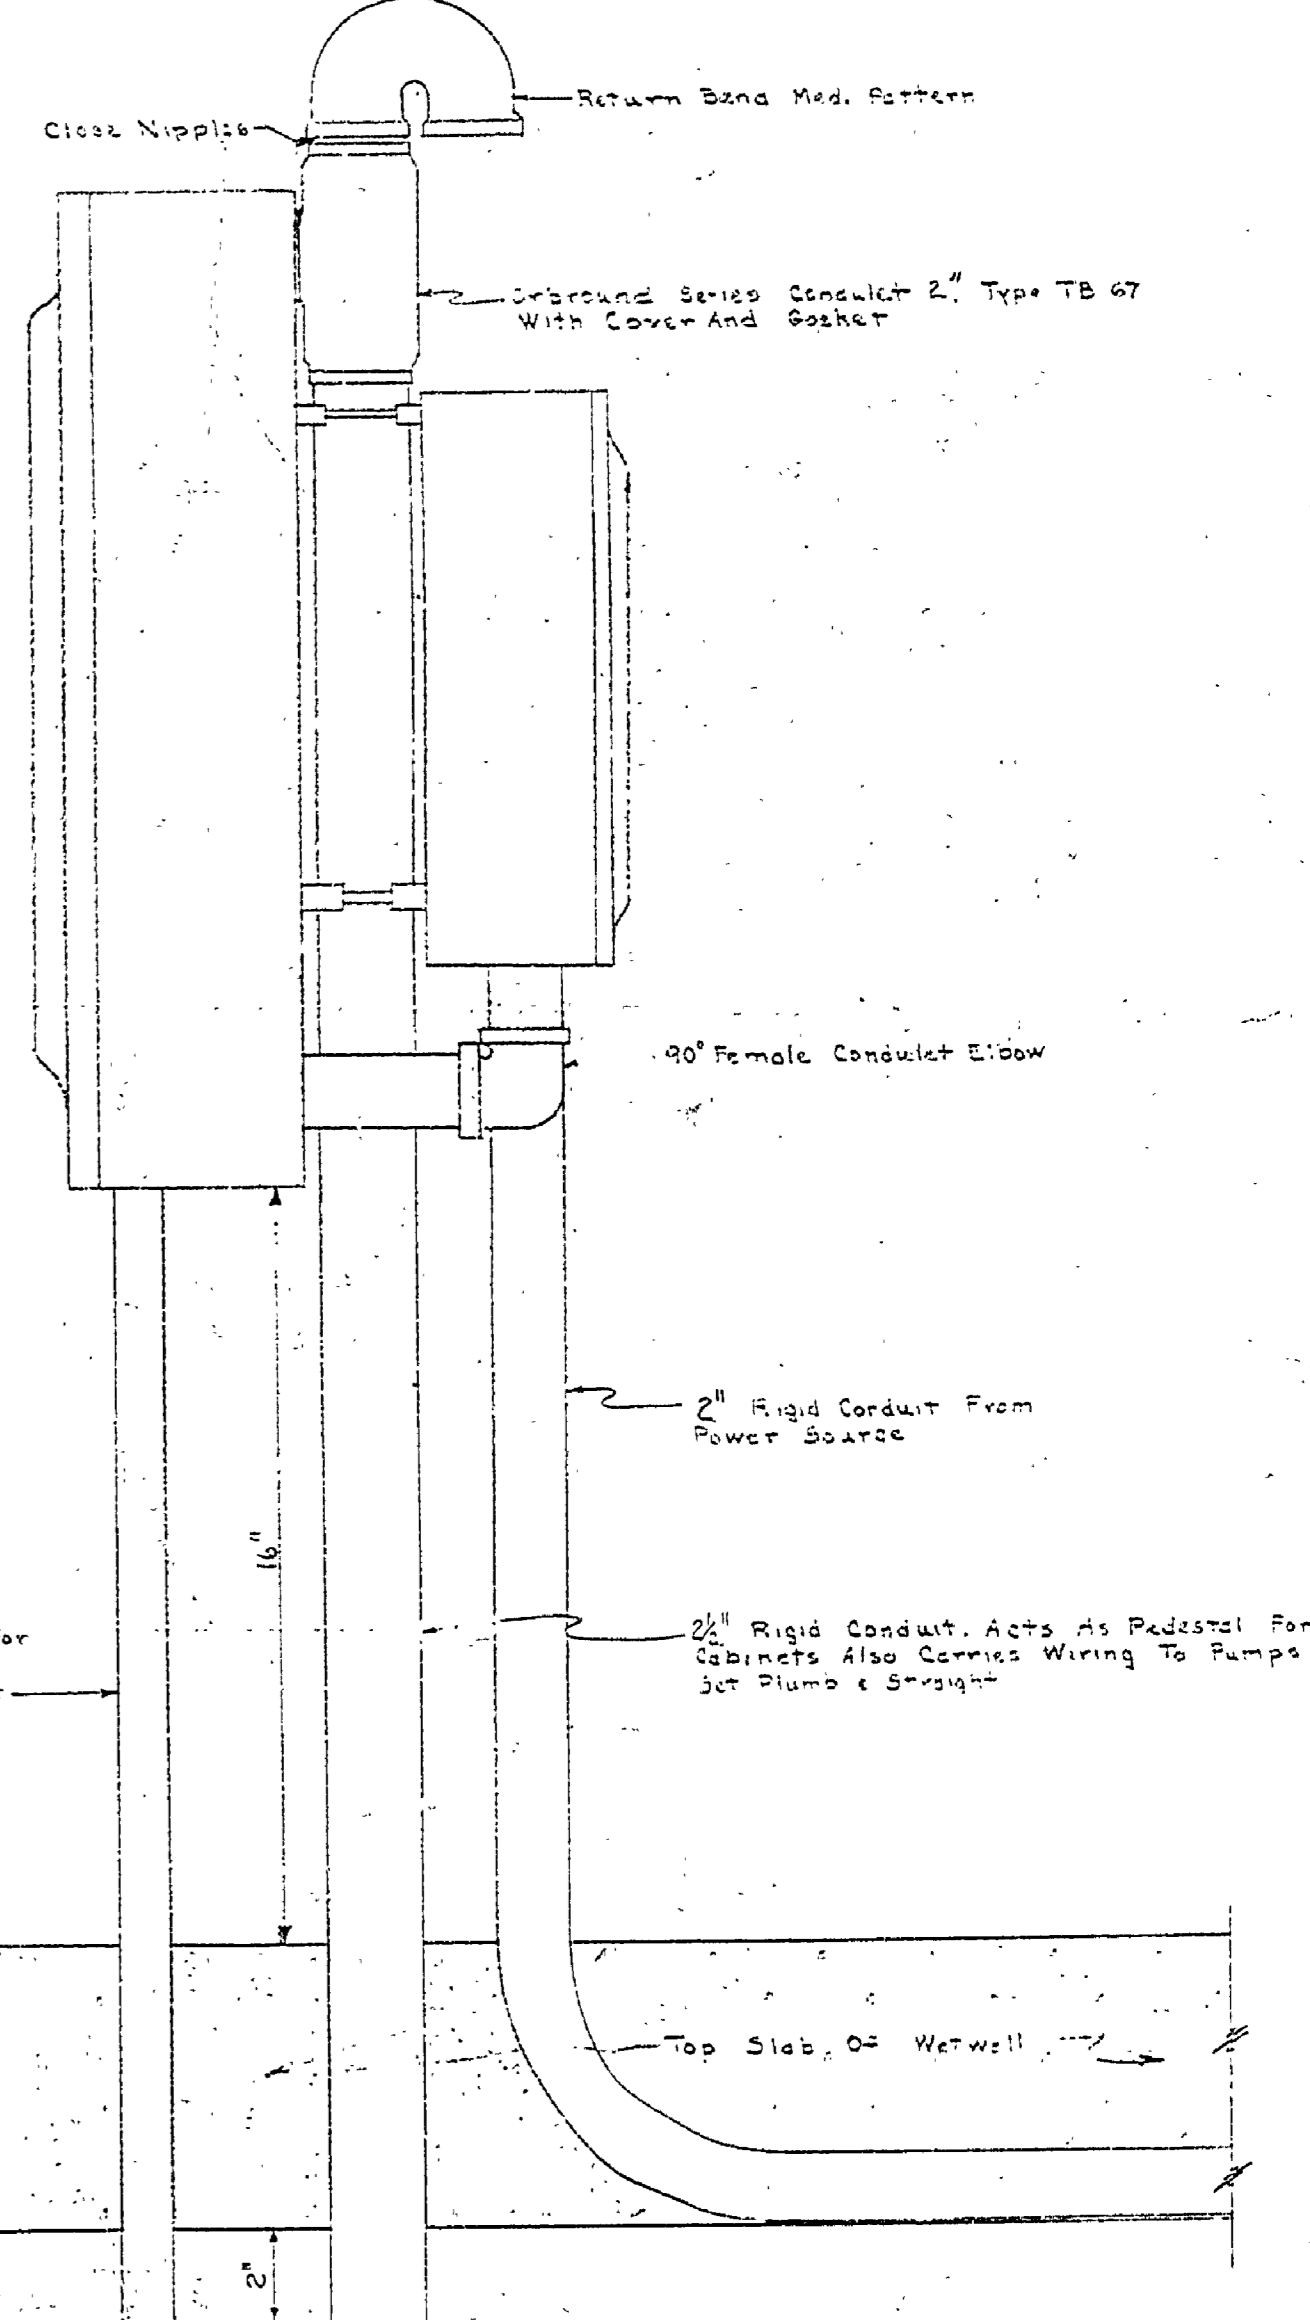

SIDE ELEVATION

SWITCH AND PUMP CONTROL PEDESTAL  
Scale 3/4" = 1'-0"

MICHIGAN  
DEPARTMENT OF CONSERVATION  
PARKS AND RECREATION DIVISION

MUSKOGON STATE PARK  
SNUG HARBOR PICNIC AREA  
SEWER SYSTEM

SHEET  
NO. 5  
OF 5  
E-11D

976-004-39-C4, SHEET 9 OF 9