



ELECTRICAL PLAN

CIRCUIT DATA


1. INTERIOR FL. FIXTURES
2. EXTERIOR LIGHTS
3. SHOWER LIGHTS
4. SEE BELOW

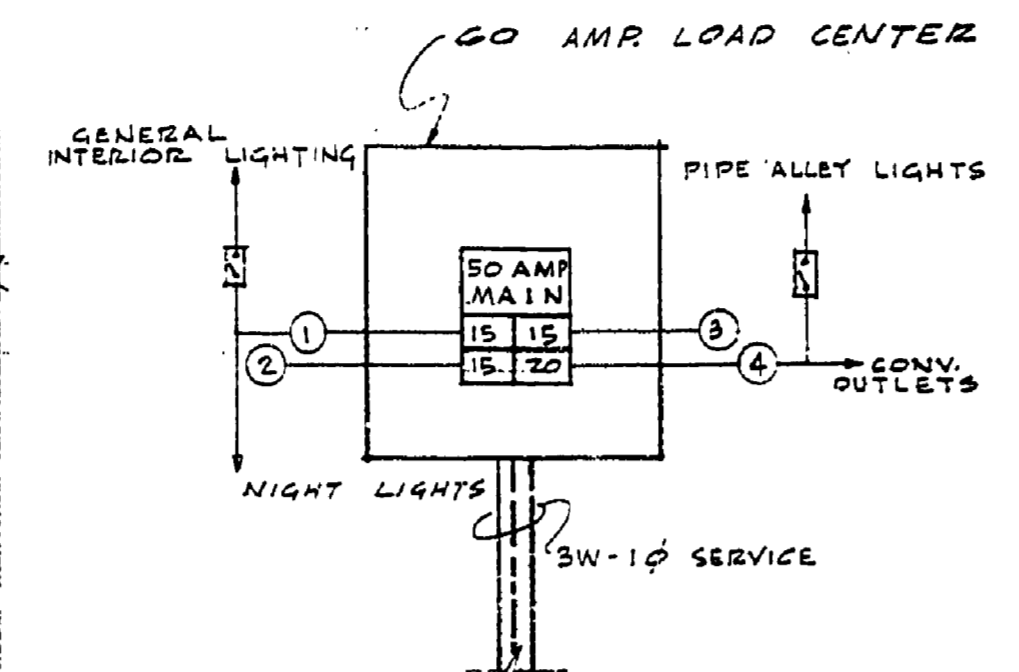


ELECTRICAL SERV.

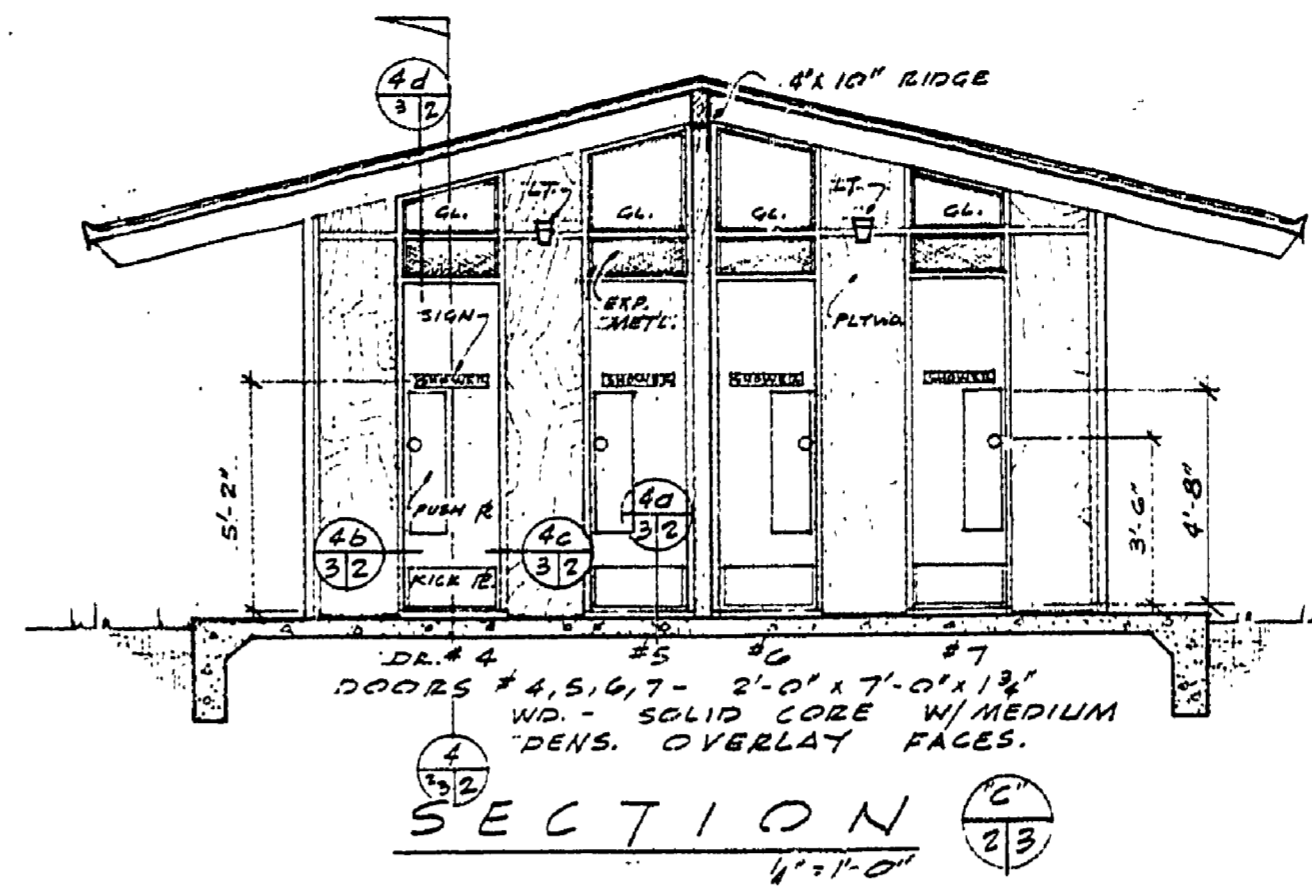


SECTION C-2/B

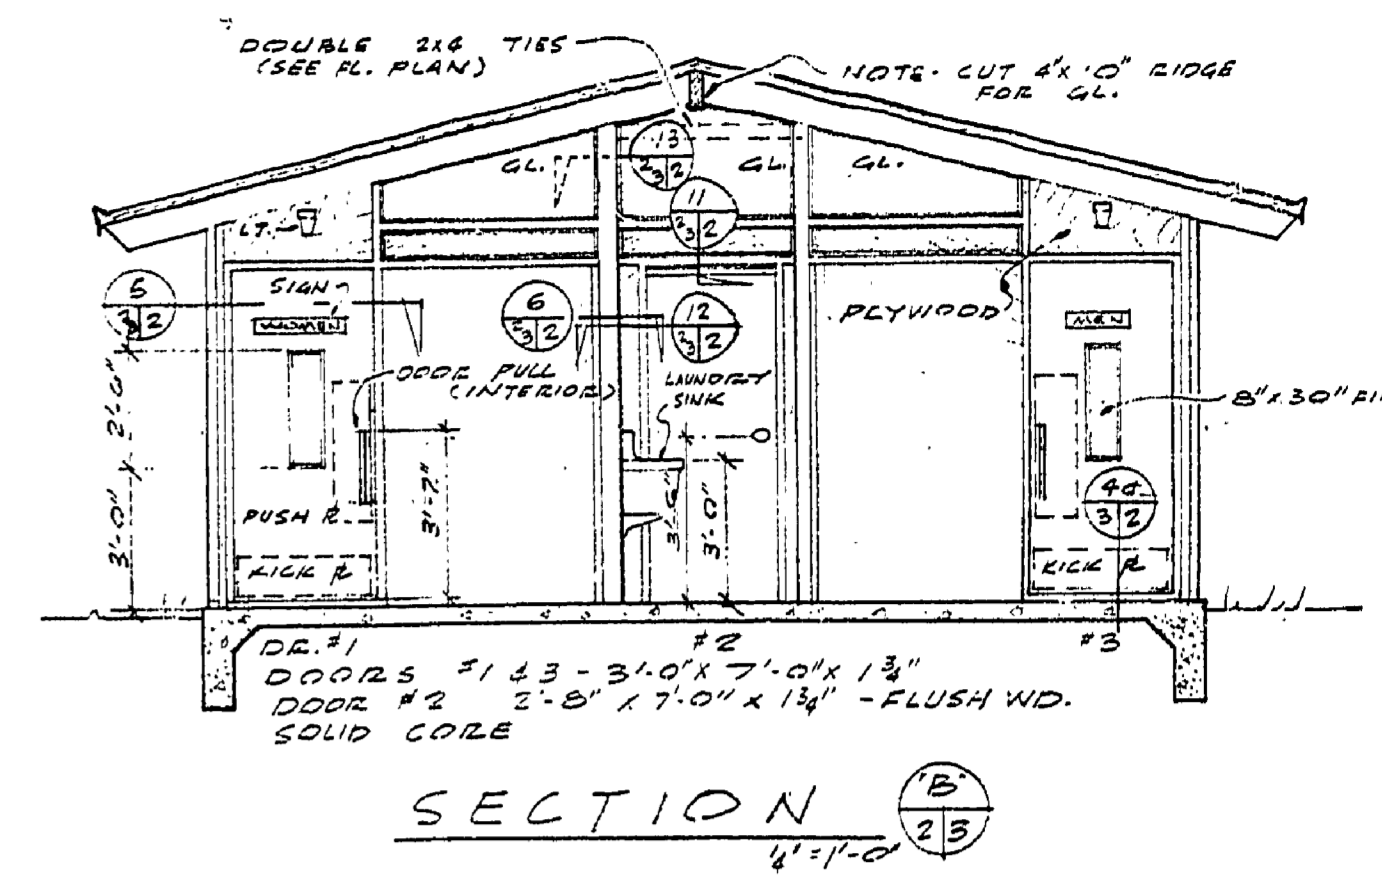

SECTION B-2/B

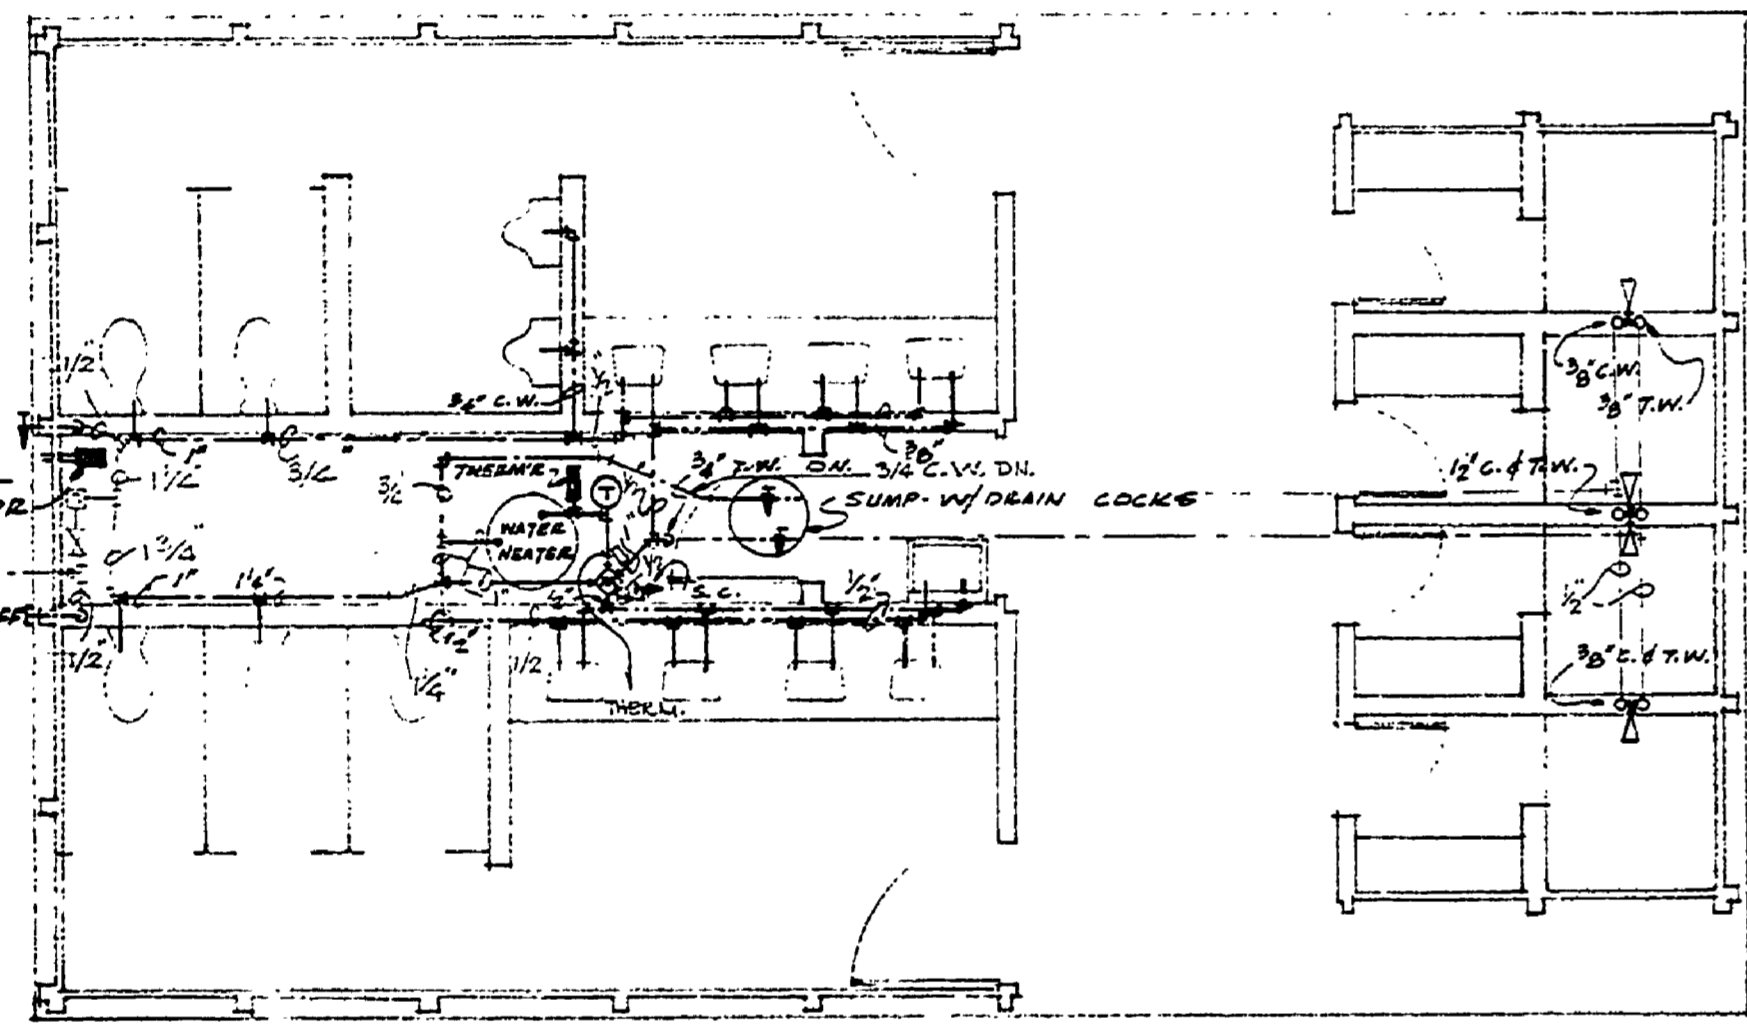


WATER - FLOOR PLAN

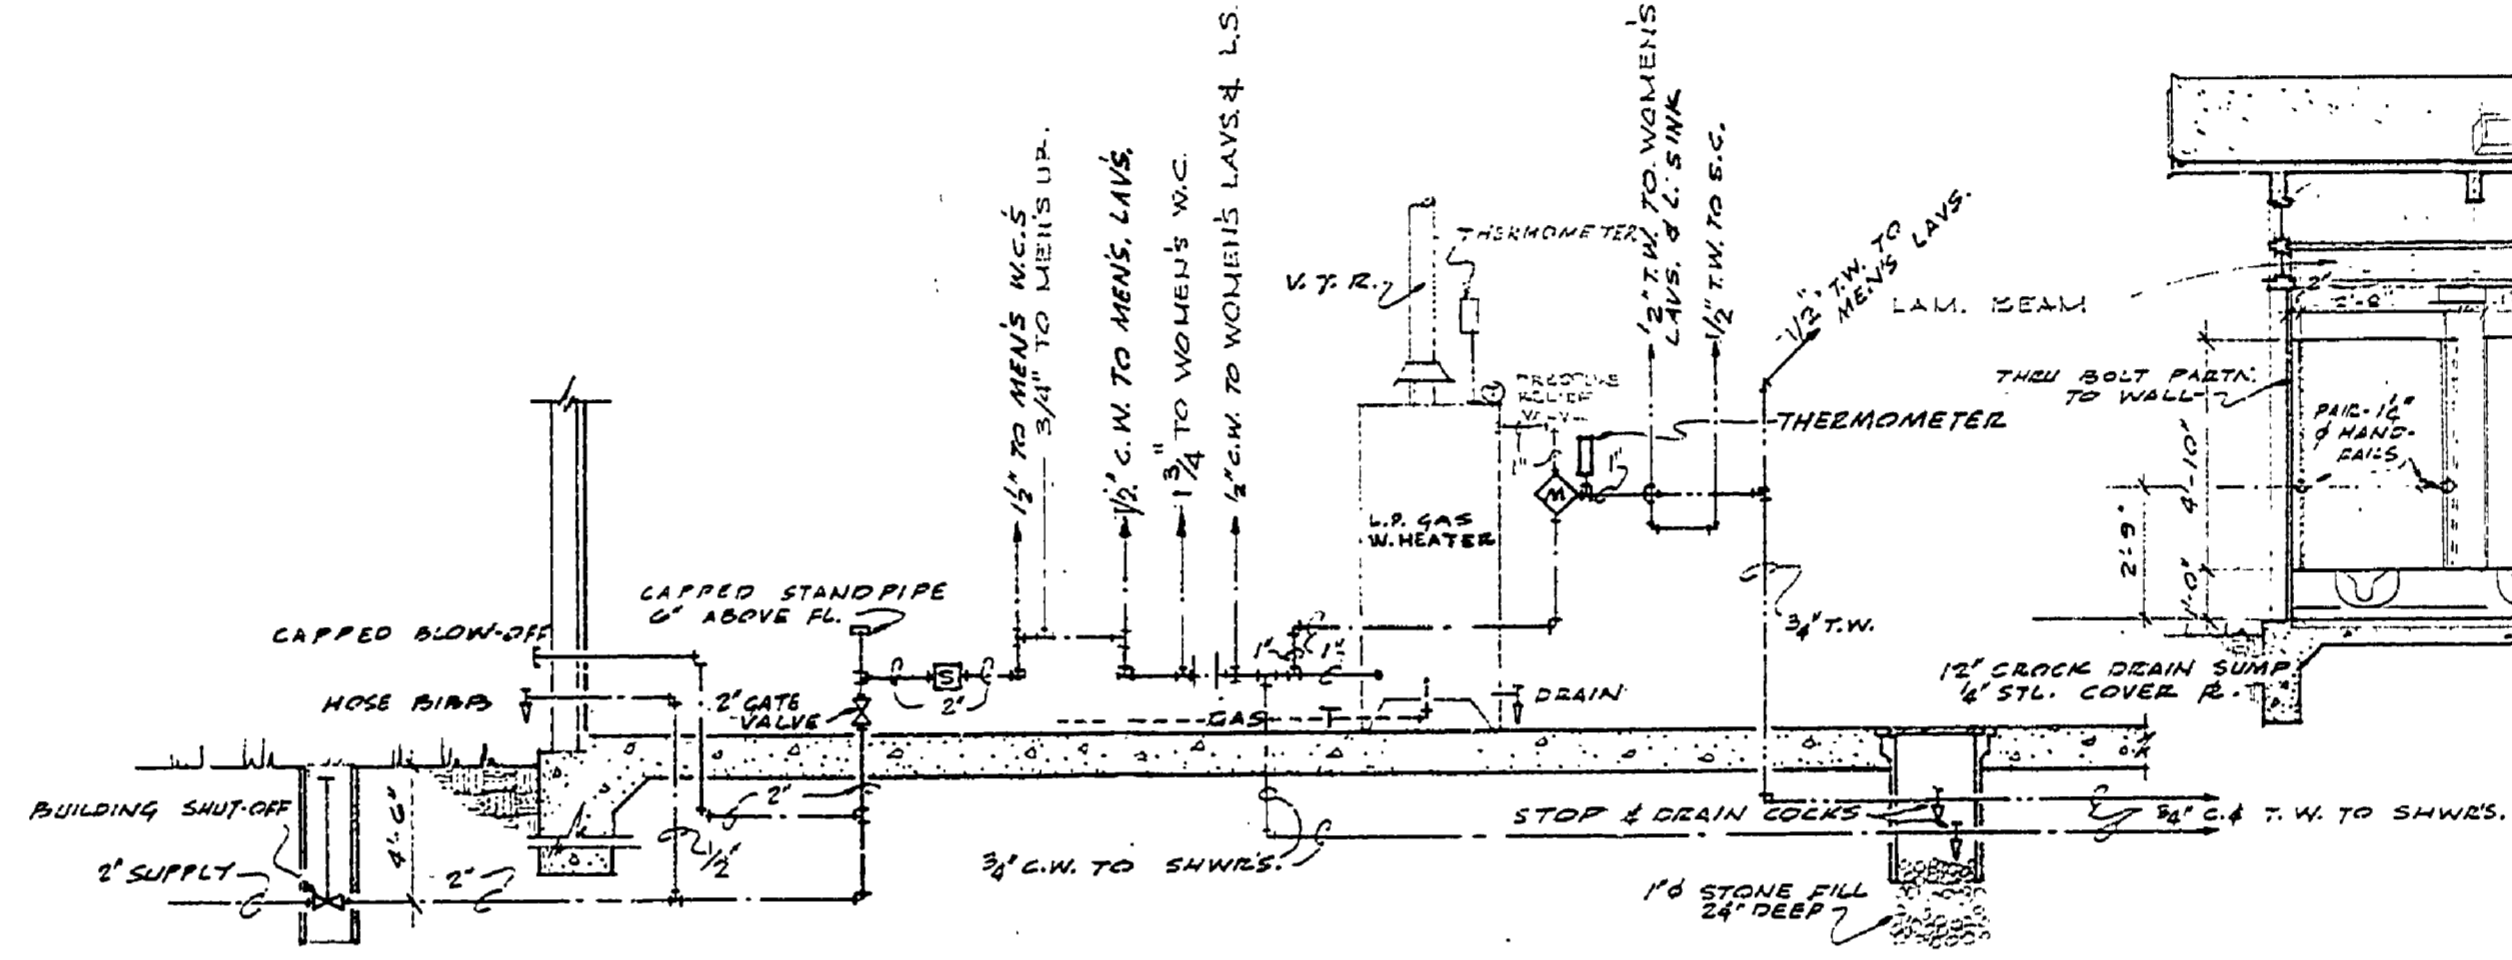


WATER SYSTEM DIAGRAM


STEAMER [5] THERMOSTATIC MIXING VALVE MOUNT 4'-0\"/>

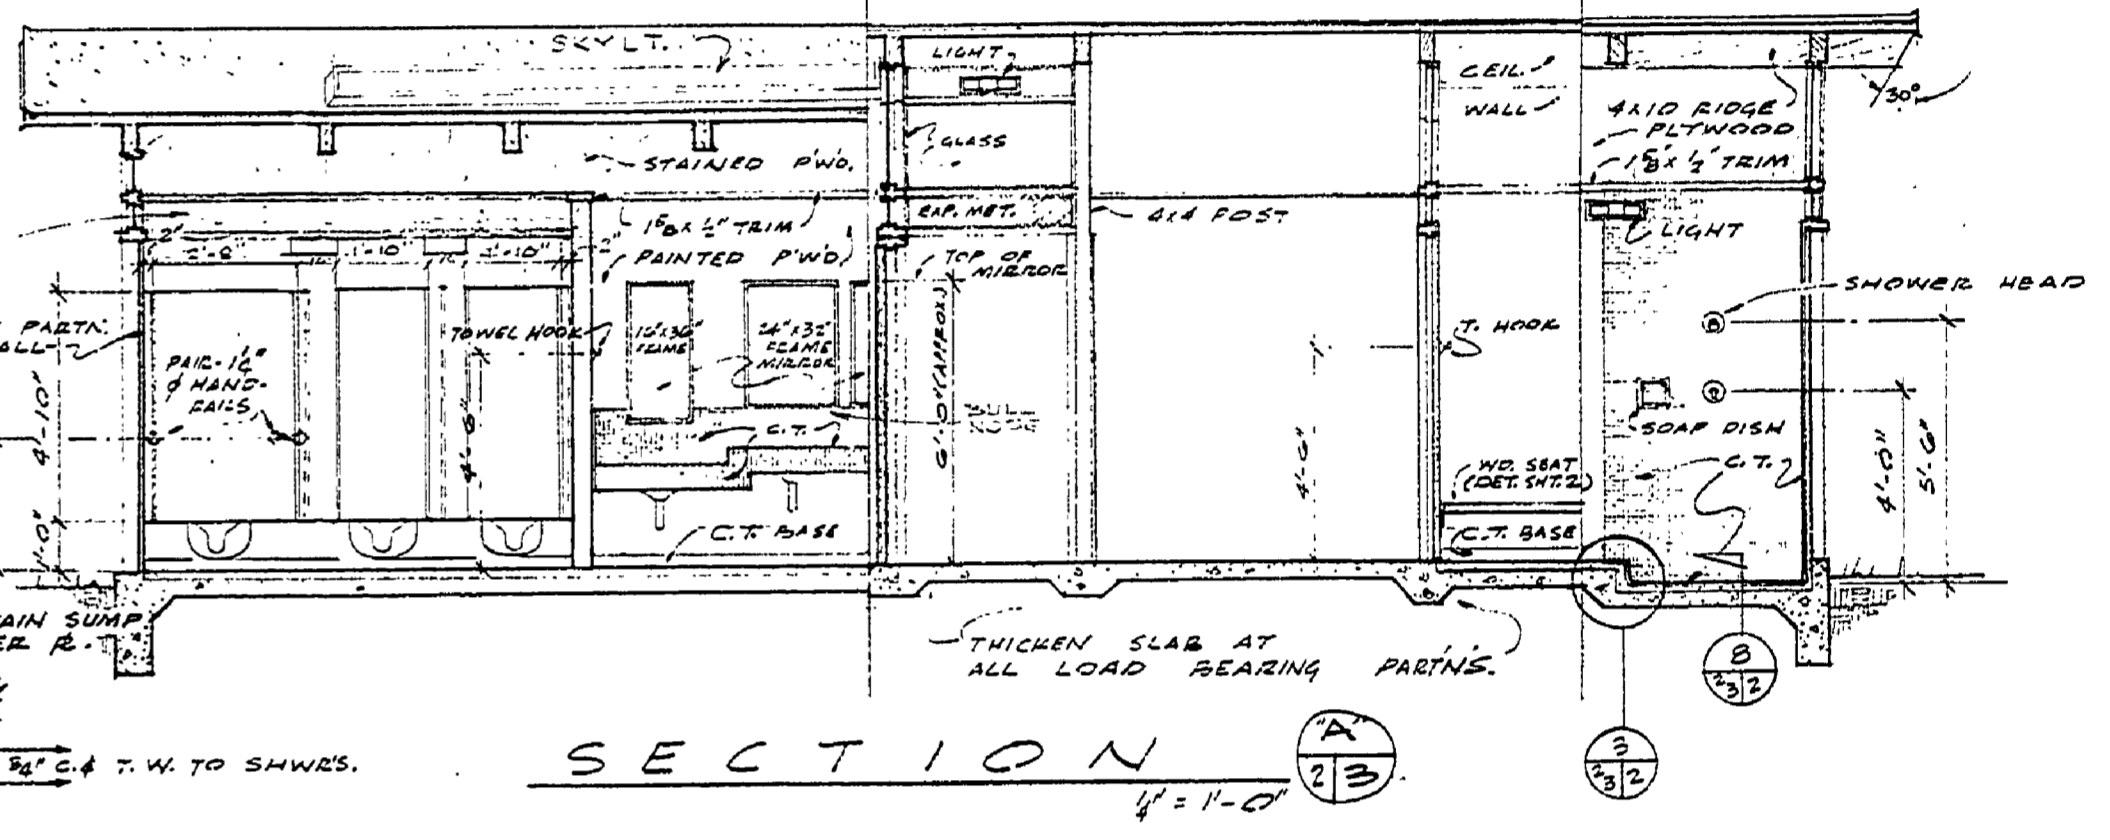


SECTION A-2/B

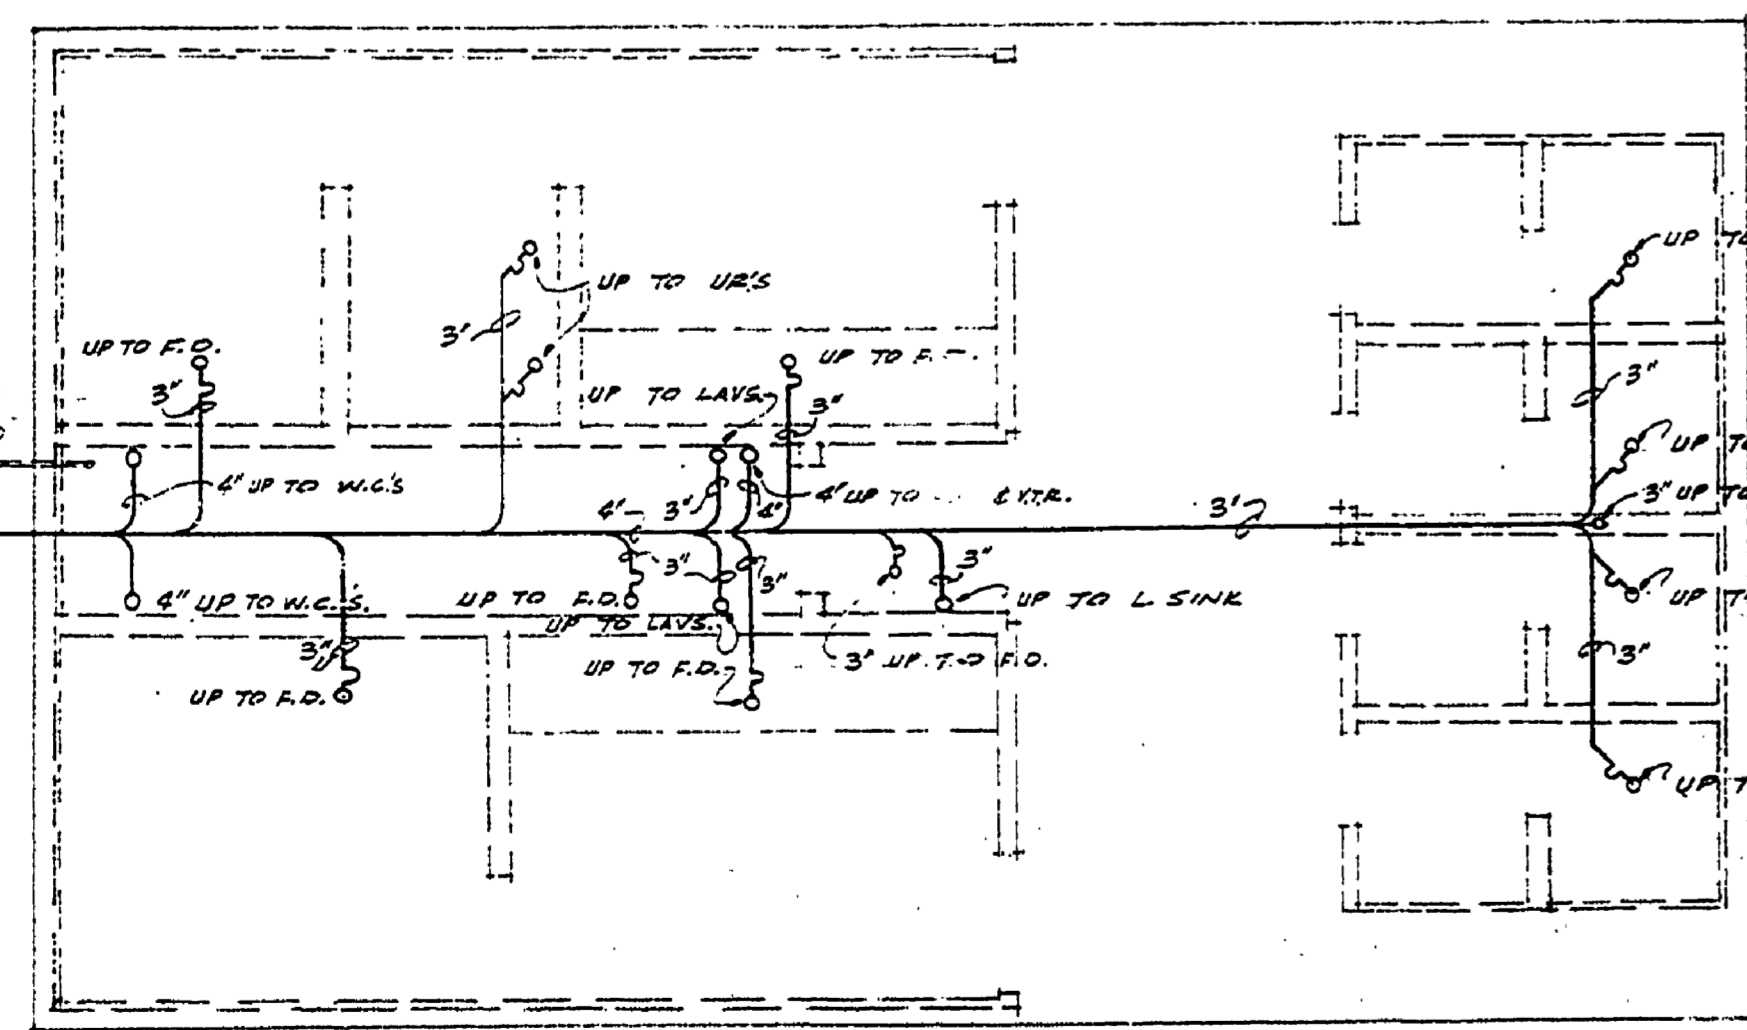


UNDERGROUND PLUMBING

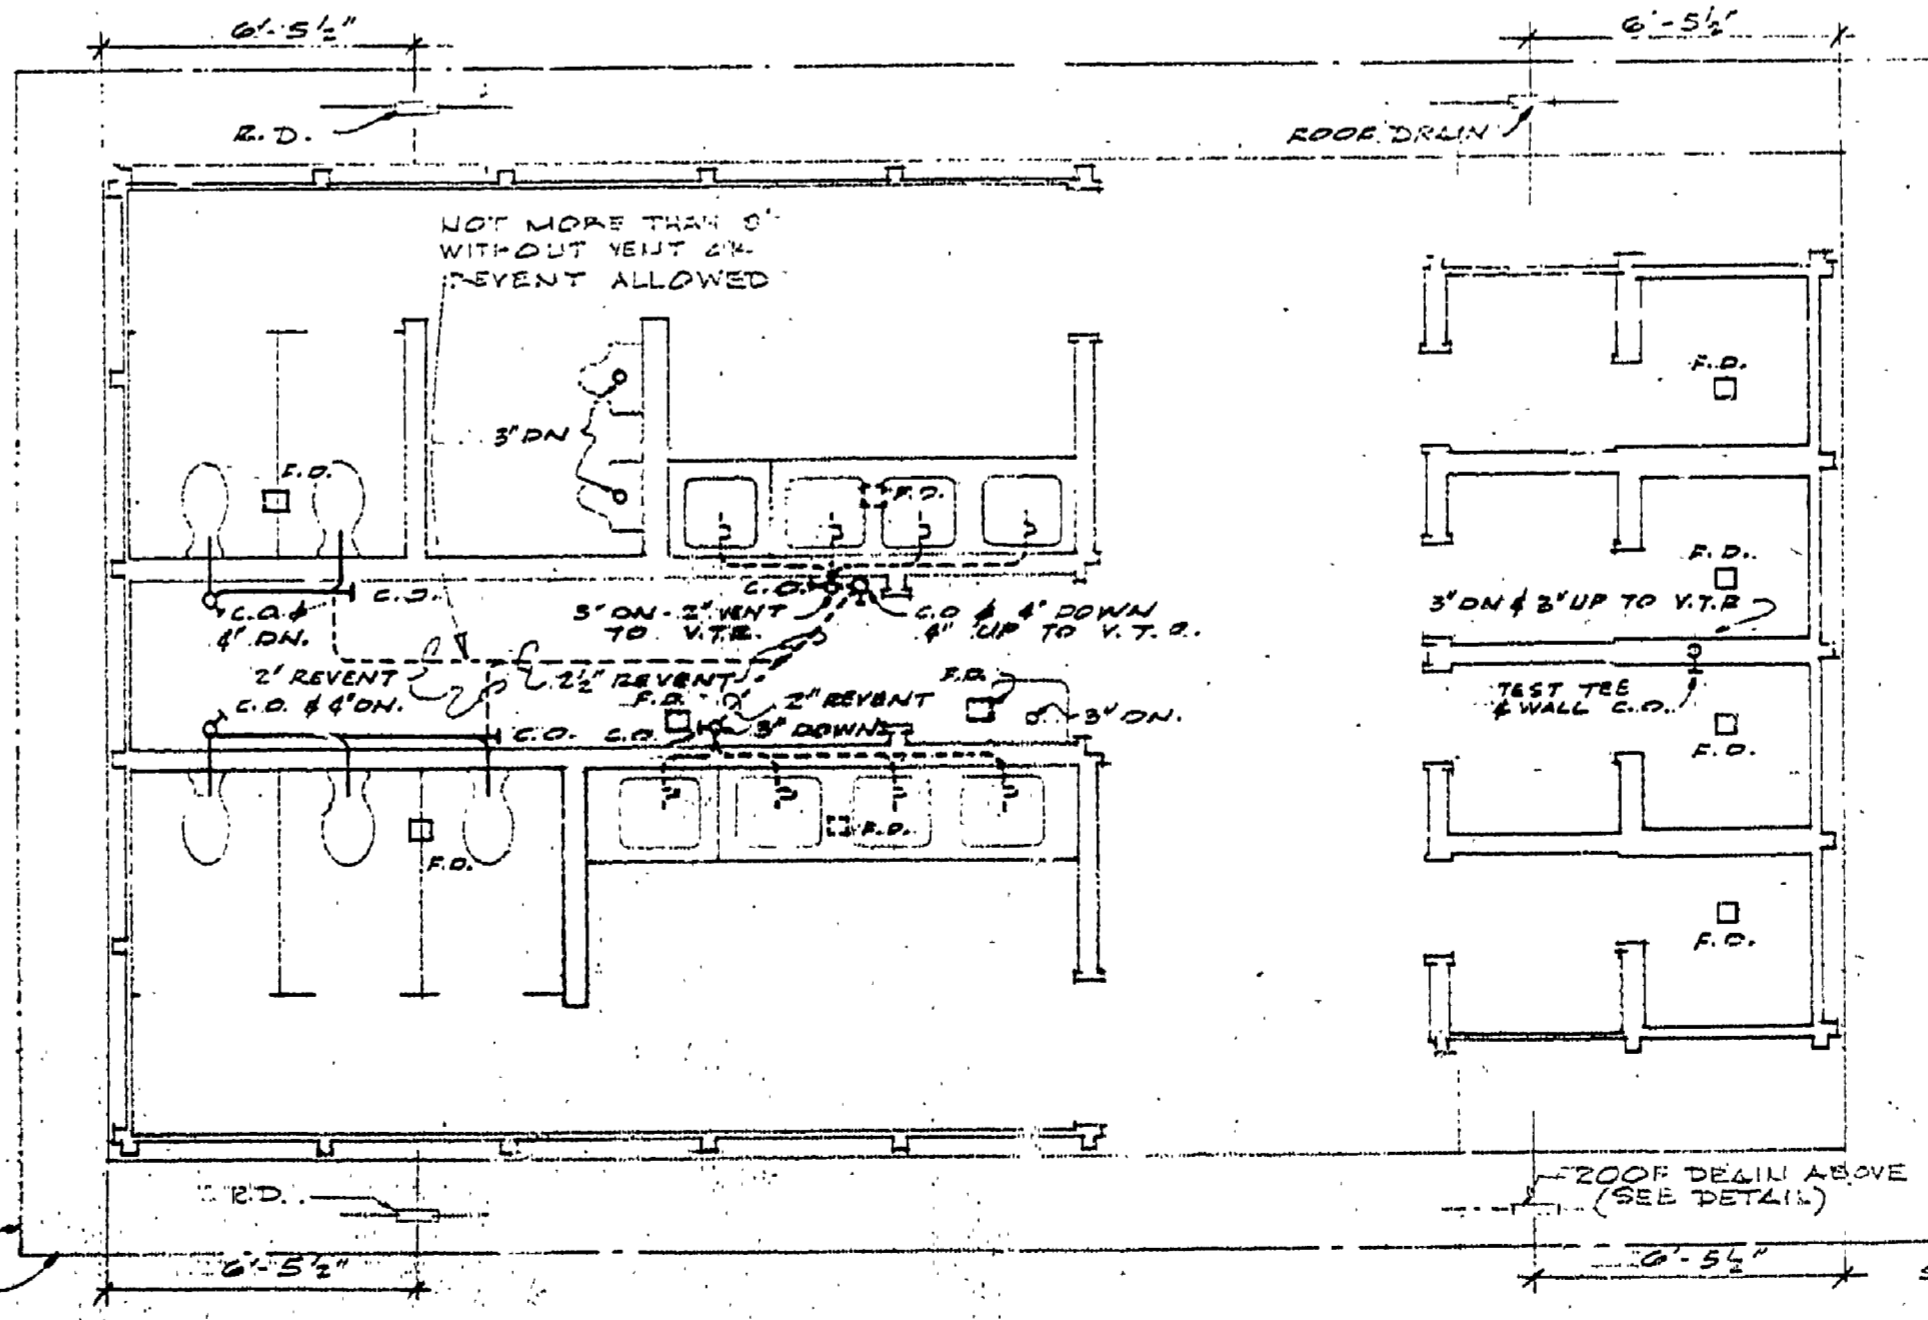


PLUMBING PLAN

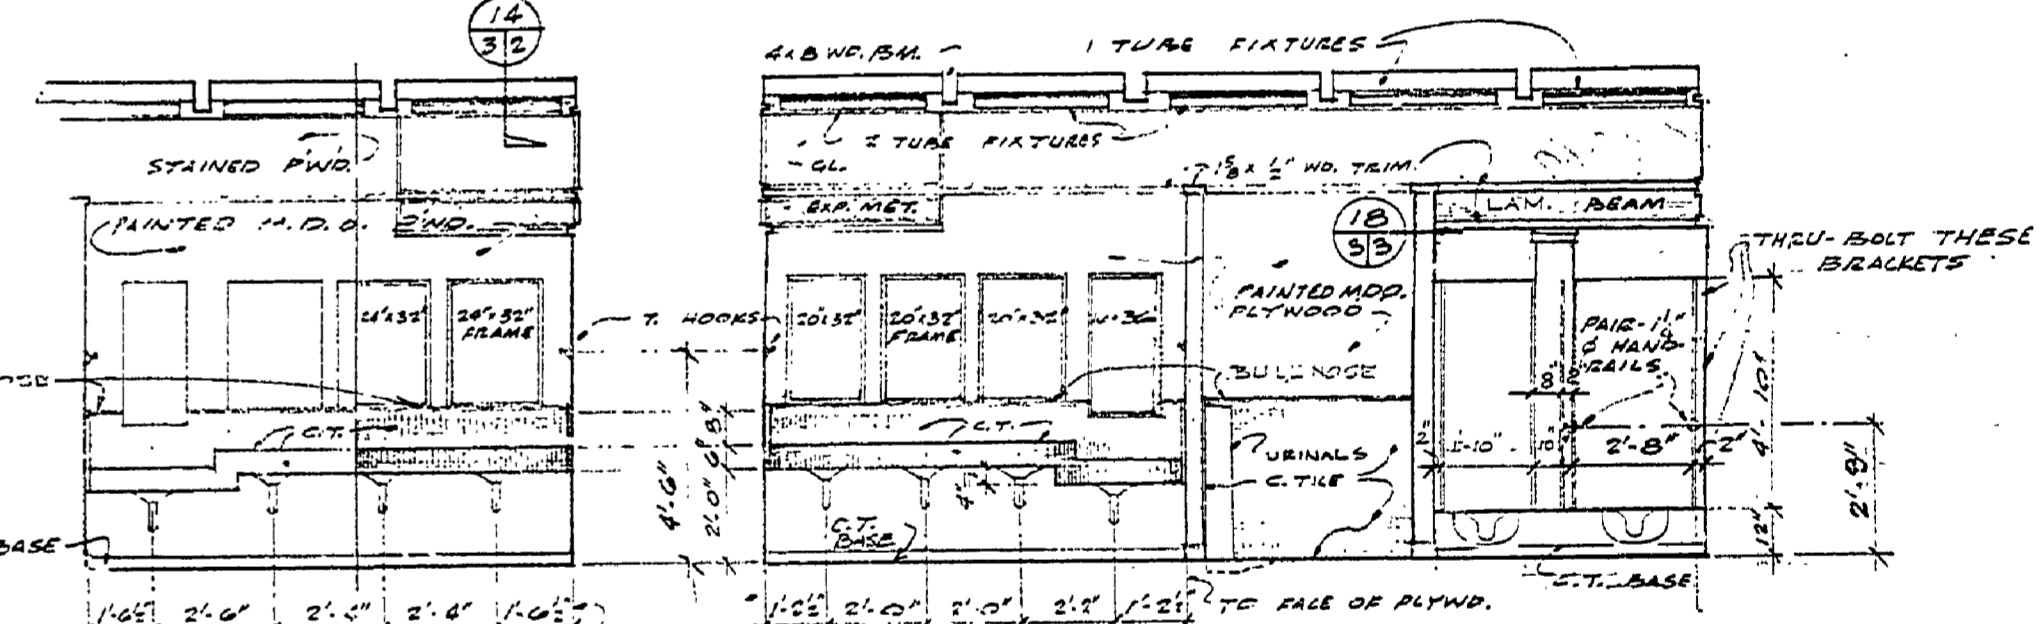

ELEV - WOMEN'S VANITY ELEV - MEN'S TOILET ROOM

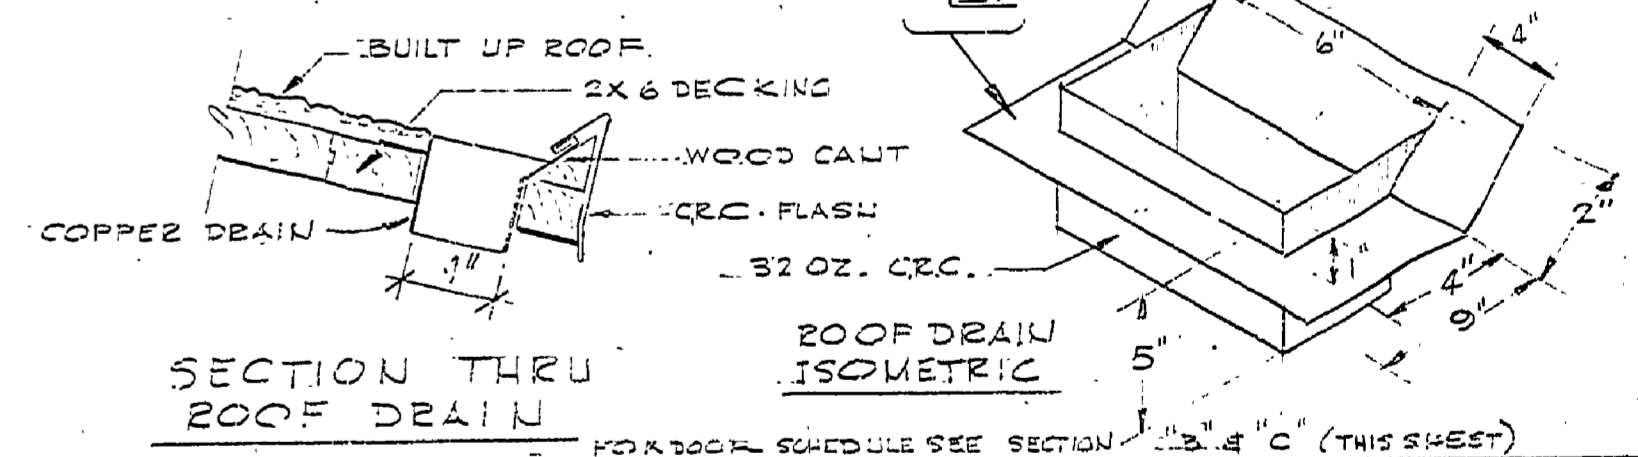

SECTION THRU ROOF DRAIN

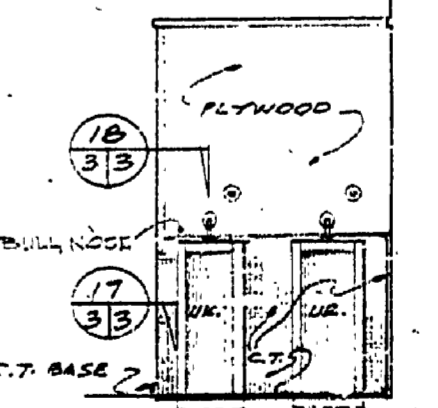

ELEV - URINALS

ROOM FINISH SCHEDULE

ROOMS	CEIL.	WALLS	TRIM	BASE FL.	REMARKS
WOMEN'S TOIL	0	0	2	0	1. WALL BEHIND L. SINK TO BE PAINTED M. D.O.
MEN'S TOIL	0	0	3	0	2. AT VANITY
SHOWERS	0	0	0	0	3. VANITY'S URINAL AREA
PASSAGE	0	0	0	0	
ALCOVE	0	2	0	0	
PIPE ALLEY	0	0	0	0	

SYMBOL

DETAIL NO. 10
SHT. WHERE DETAIL IS TAKEN
DETAIL NO. 11
SHT. WHERE DETAIL IS SHOWN

SURVEYED BY	DRAWN BY	NO.	DATE	BY	REVISIONS	NO.	DATE	BY	REVISIONS	MICHIGAN DEPARTMENT OF CONSERVATION	FOR WASTER STATE PARK TOILET & SHOWER BLDG. BLDG. A	SHEET NO. 7 OF 8	MECHANICAL - ELECTRICAL SECTIONS - INT. ELEV'S - DETS.
DESIGNED BY	CHECKED BY	1.	3-10-47	CP	E. SUMP (PREV. P.)	3.						FOR PROJECT NO. PA-108-1-1-100-0000	SHEET 3 OF 3 PLAN NO. A-101-A

LIGHTS: A. SOLUX GREGAL STEPA, B. SOLUX GREGAL STEPA, C. SOLUX GREGAL STEPA, D. SOLUX GREGAL STEPA, E. SOLUX GREGAL STEPA, F. SOLUX GREGAL STEPA