




PLAN - WASTE PLUMBING
DETAIL FIRST FLOOR
SC. 1/2" = 1'-0"

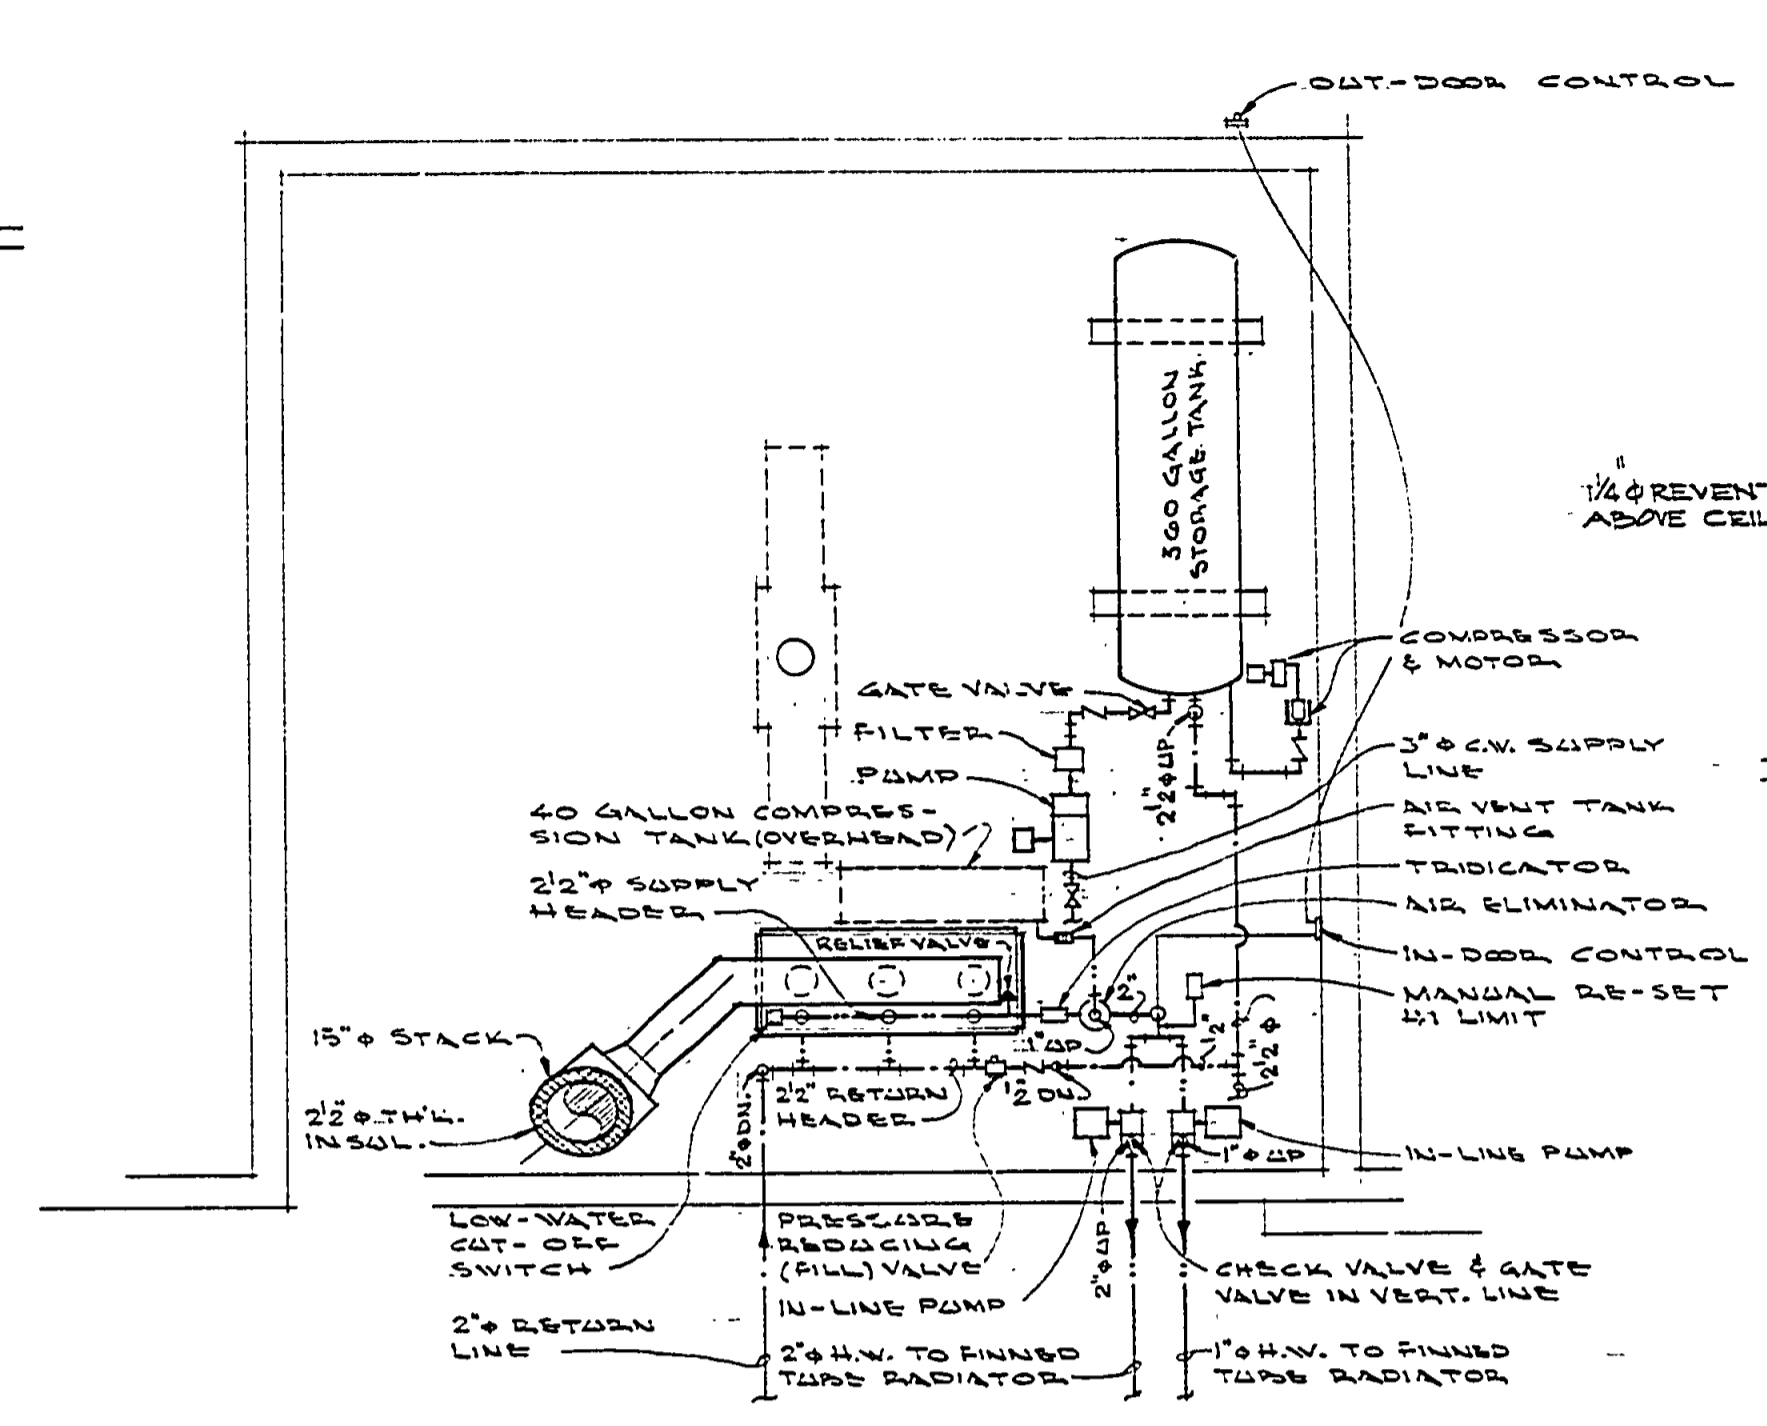

PLAN - BASEMENT BOILER ROOM
WATER SUPPLY PLUMBING
SC. 1/2" = 1'-0"

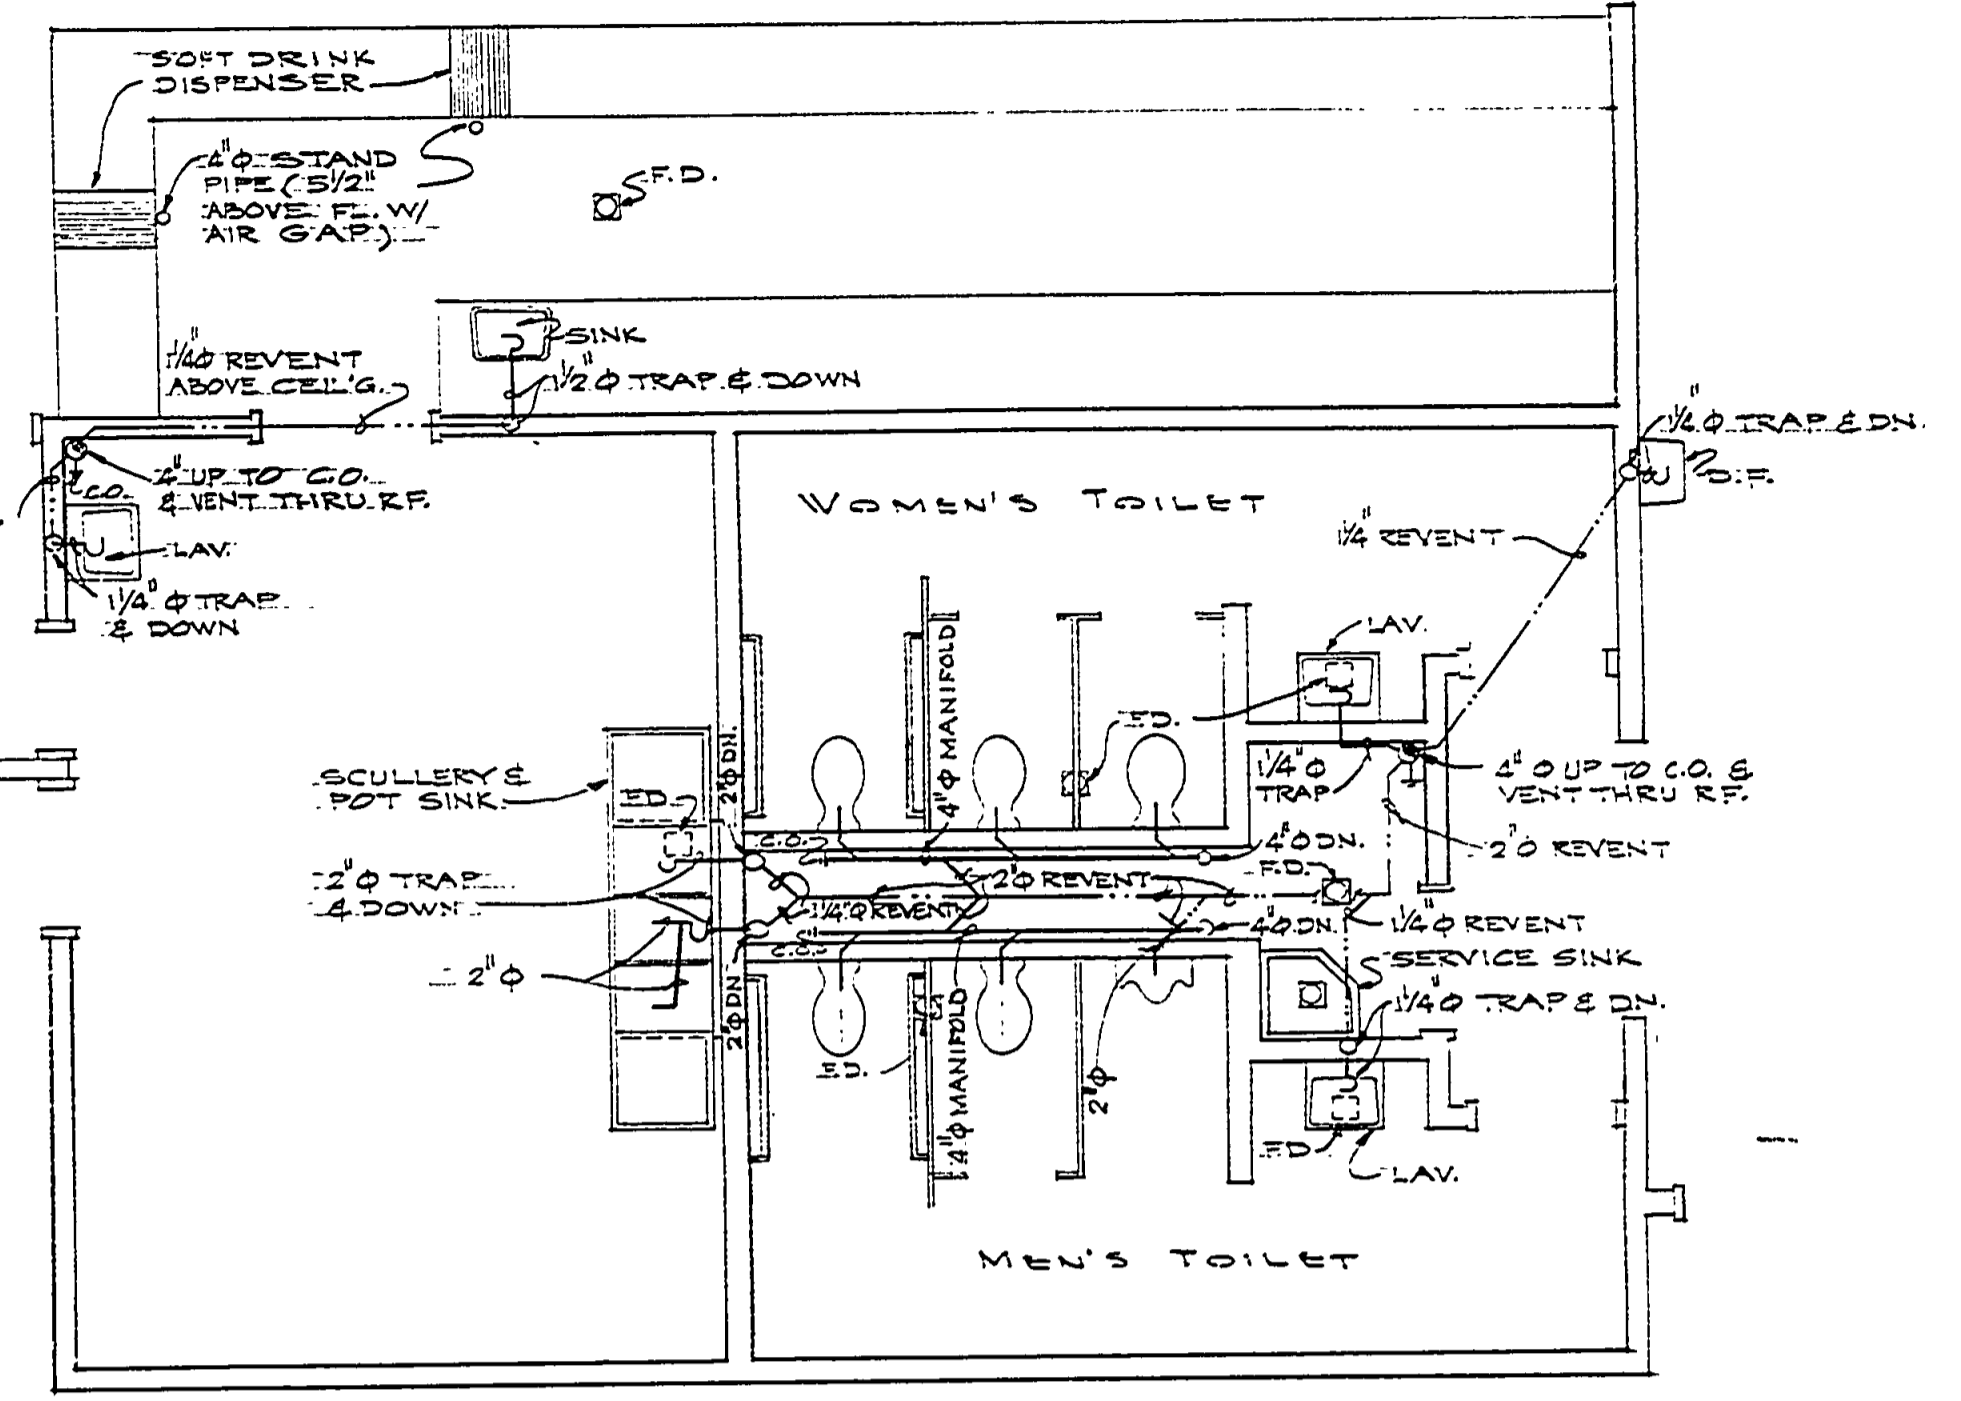


PLAN - FIRST FLOOR WASTE PLUMBING
SC. 1/2" = 1'-0"

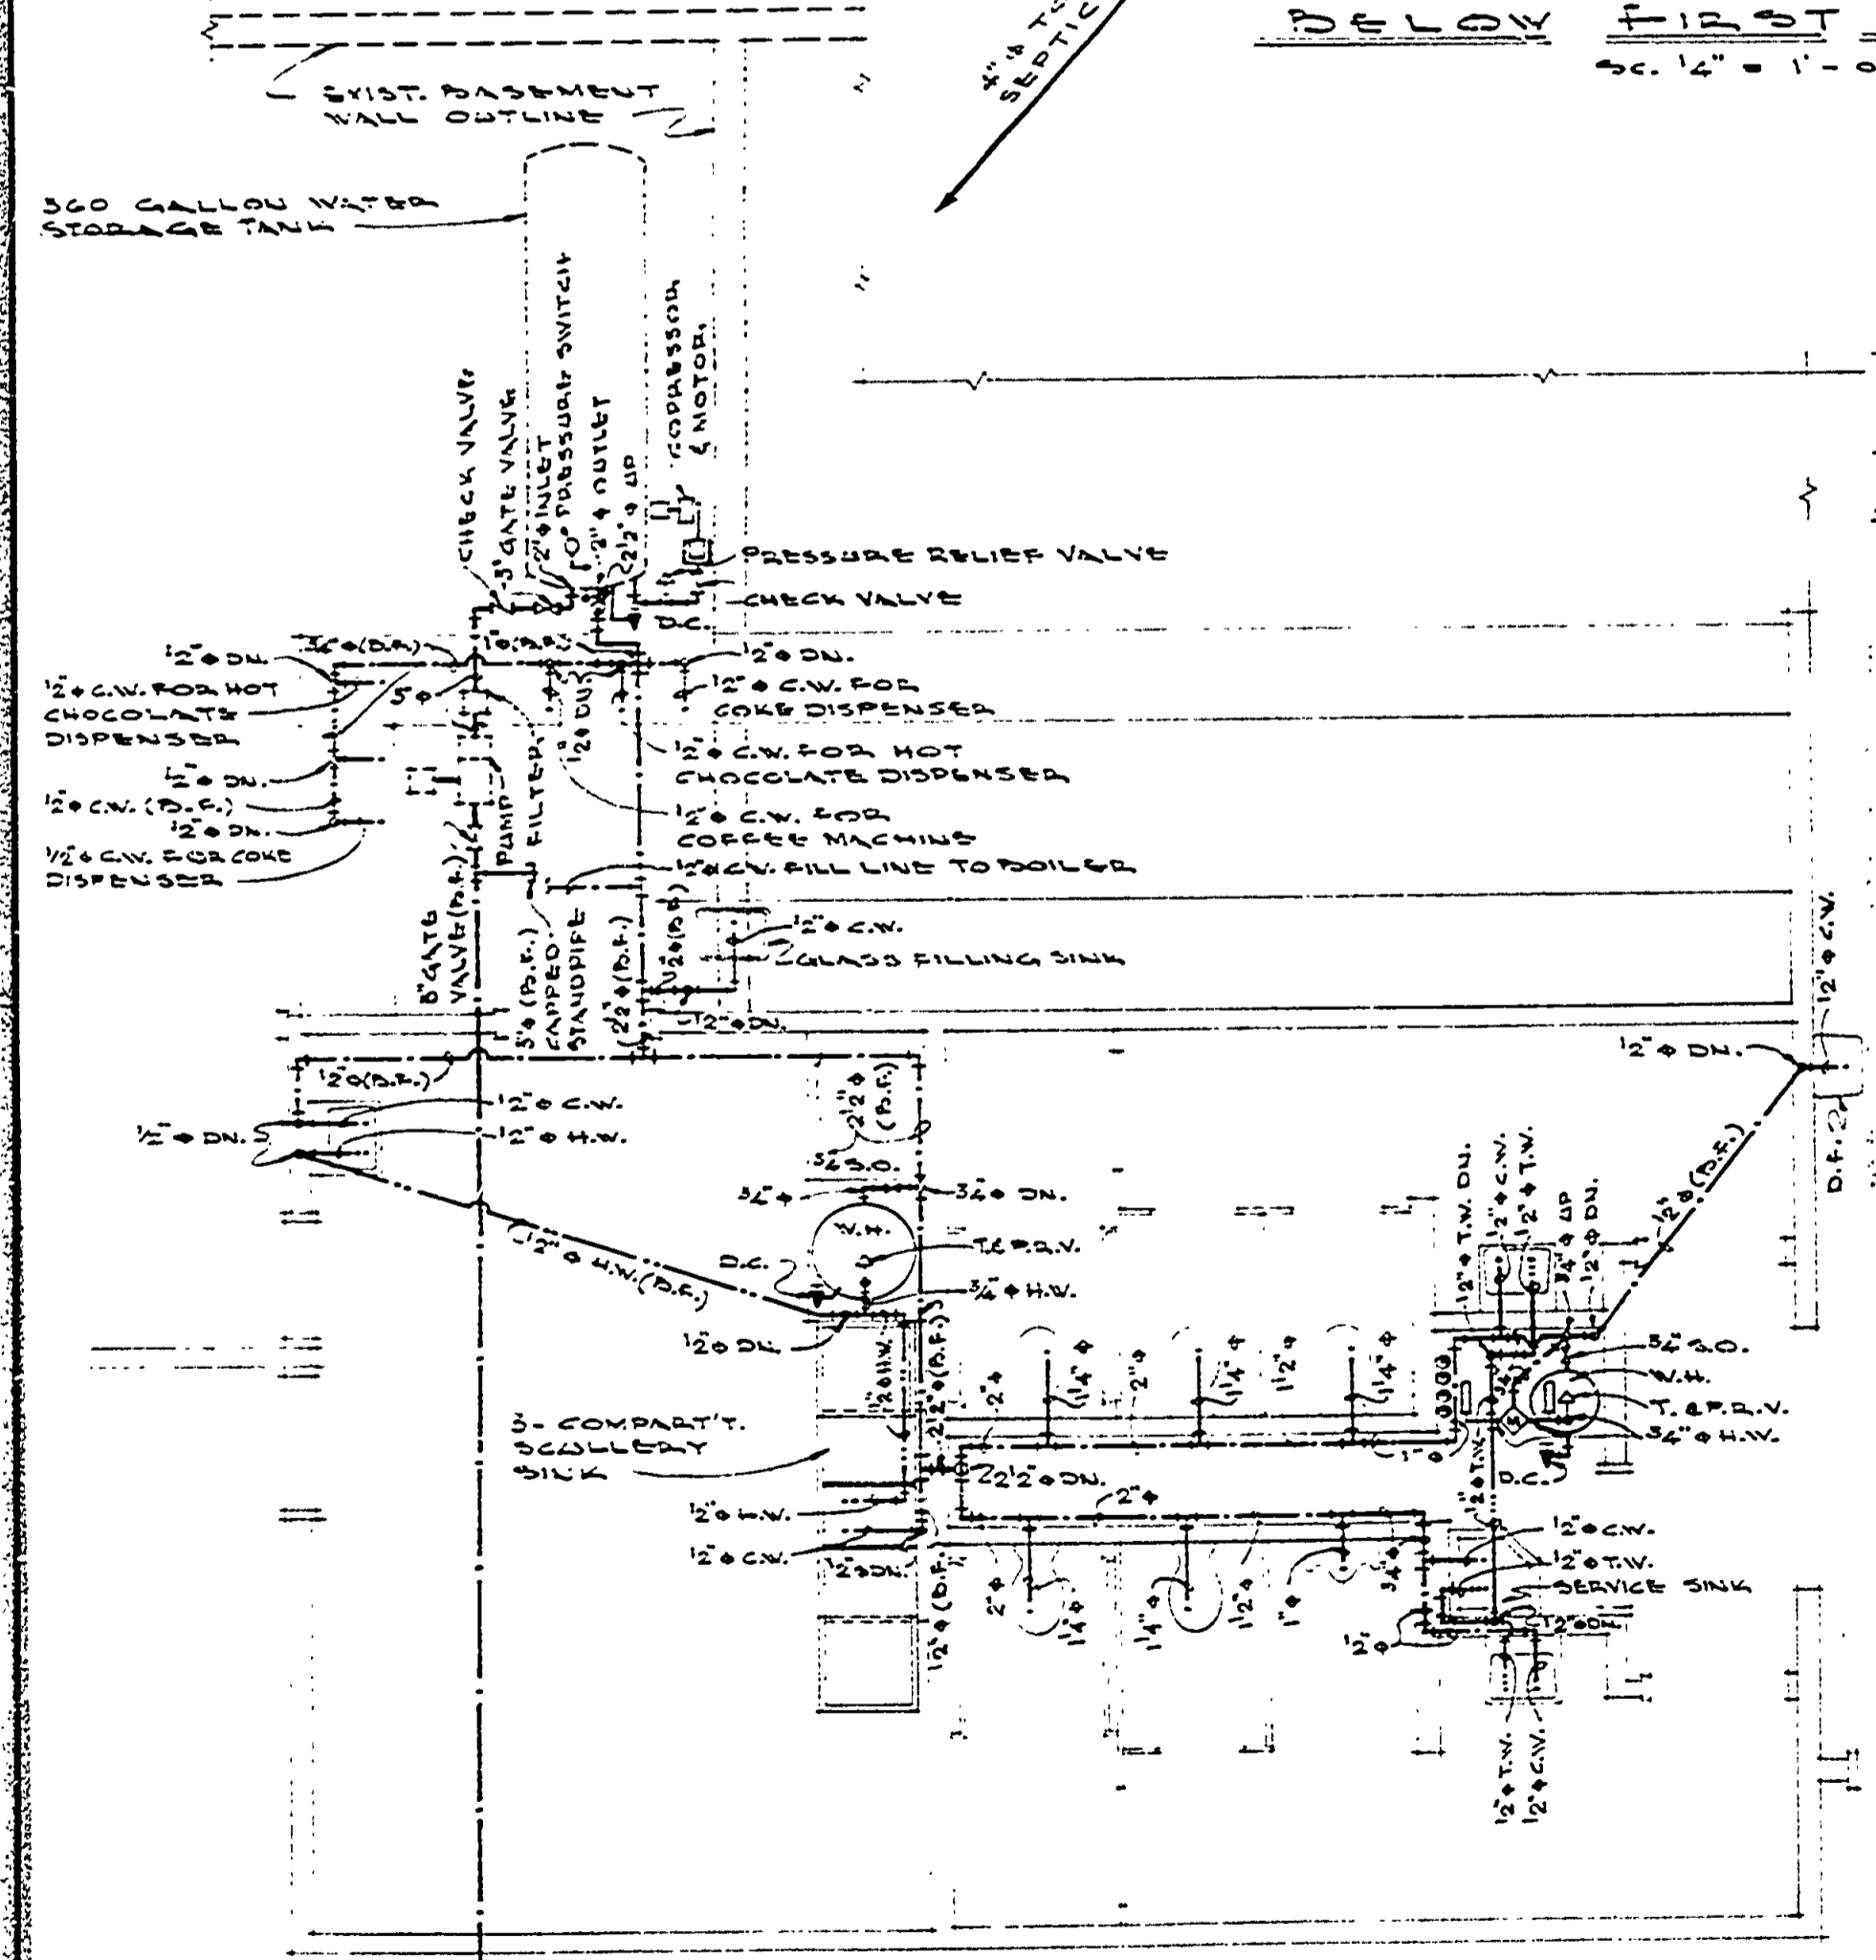

PLAN - BASEMENT & FIRST FLOOR
WATER SUPPLY PLUMBING
SC. 1/2" = 1'-0"

PLUMBING LEGEND		
SYMBOL	ABBREV	DESCRIPTION
—	T.W.	TEMPERED WATER
—	C.W.	COLD WATER
—	H.W.	HOT WATER
—	F	FILTER
—	T.P.R.V.	TEMPERATURE & PRESSURE RELIEF VALVE
—	M.V.	MIXING VALVE
—	S.O.	SHUT OFF
—	D.C.	DRAIN COCK
—	T.	THERMOMETER
—	LAV.	LAVATORY
—	DN.	DOWN
—	B.F.	BELOW FLOOR
—	F.D.	FLOOR DRAIN
—	C.O.	CLEAN OUT
—	—	CHECK VALVE
—	—	GATE VALVE

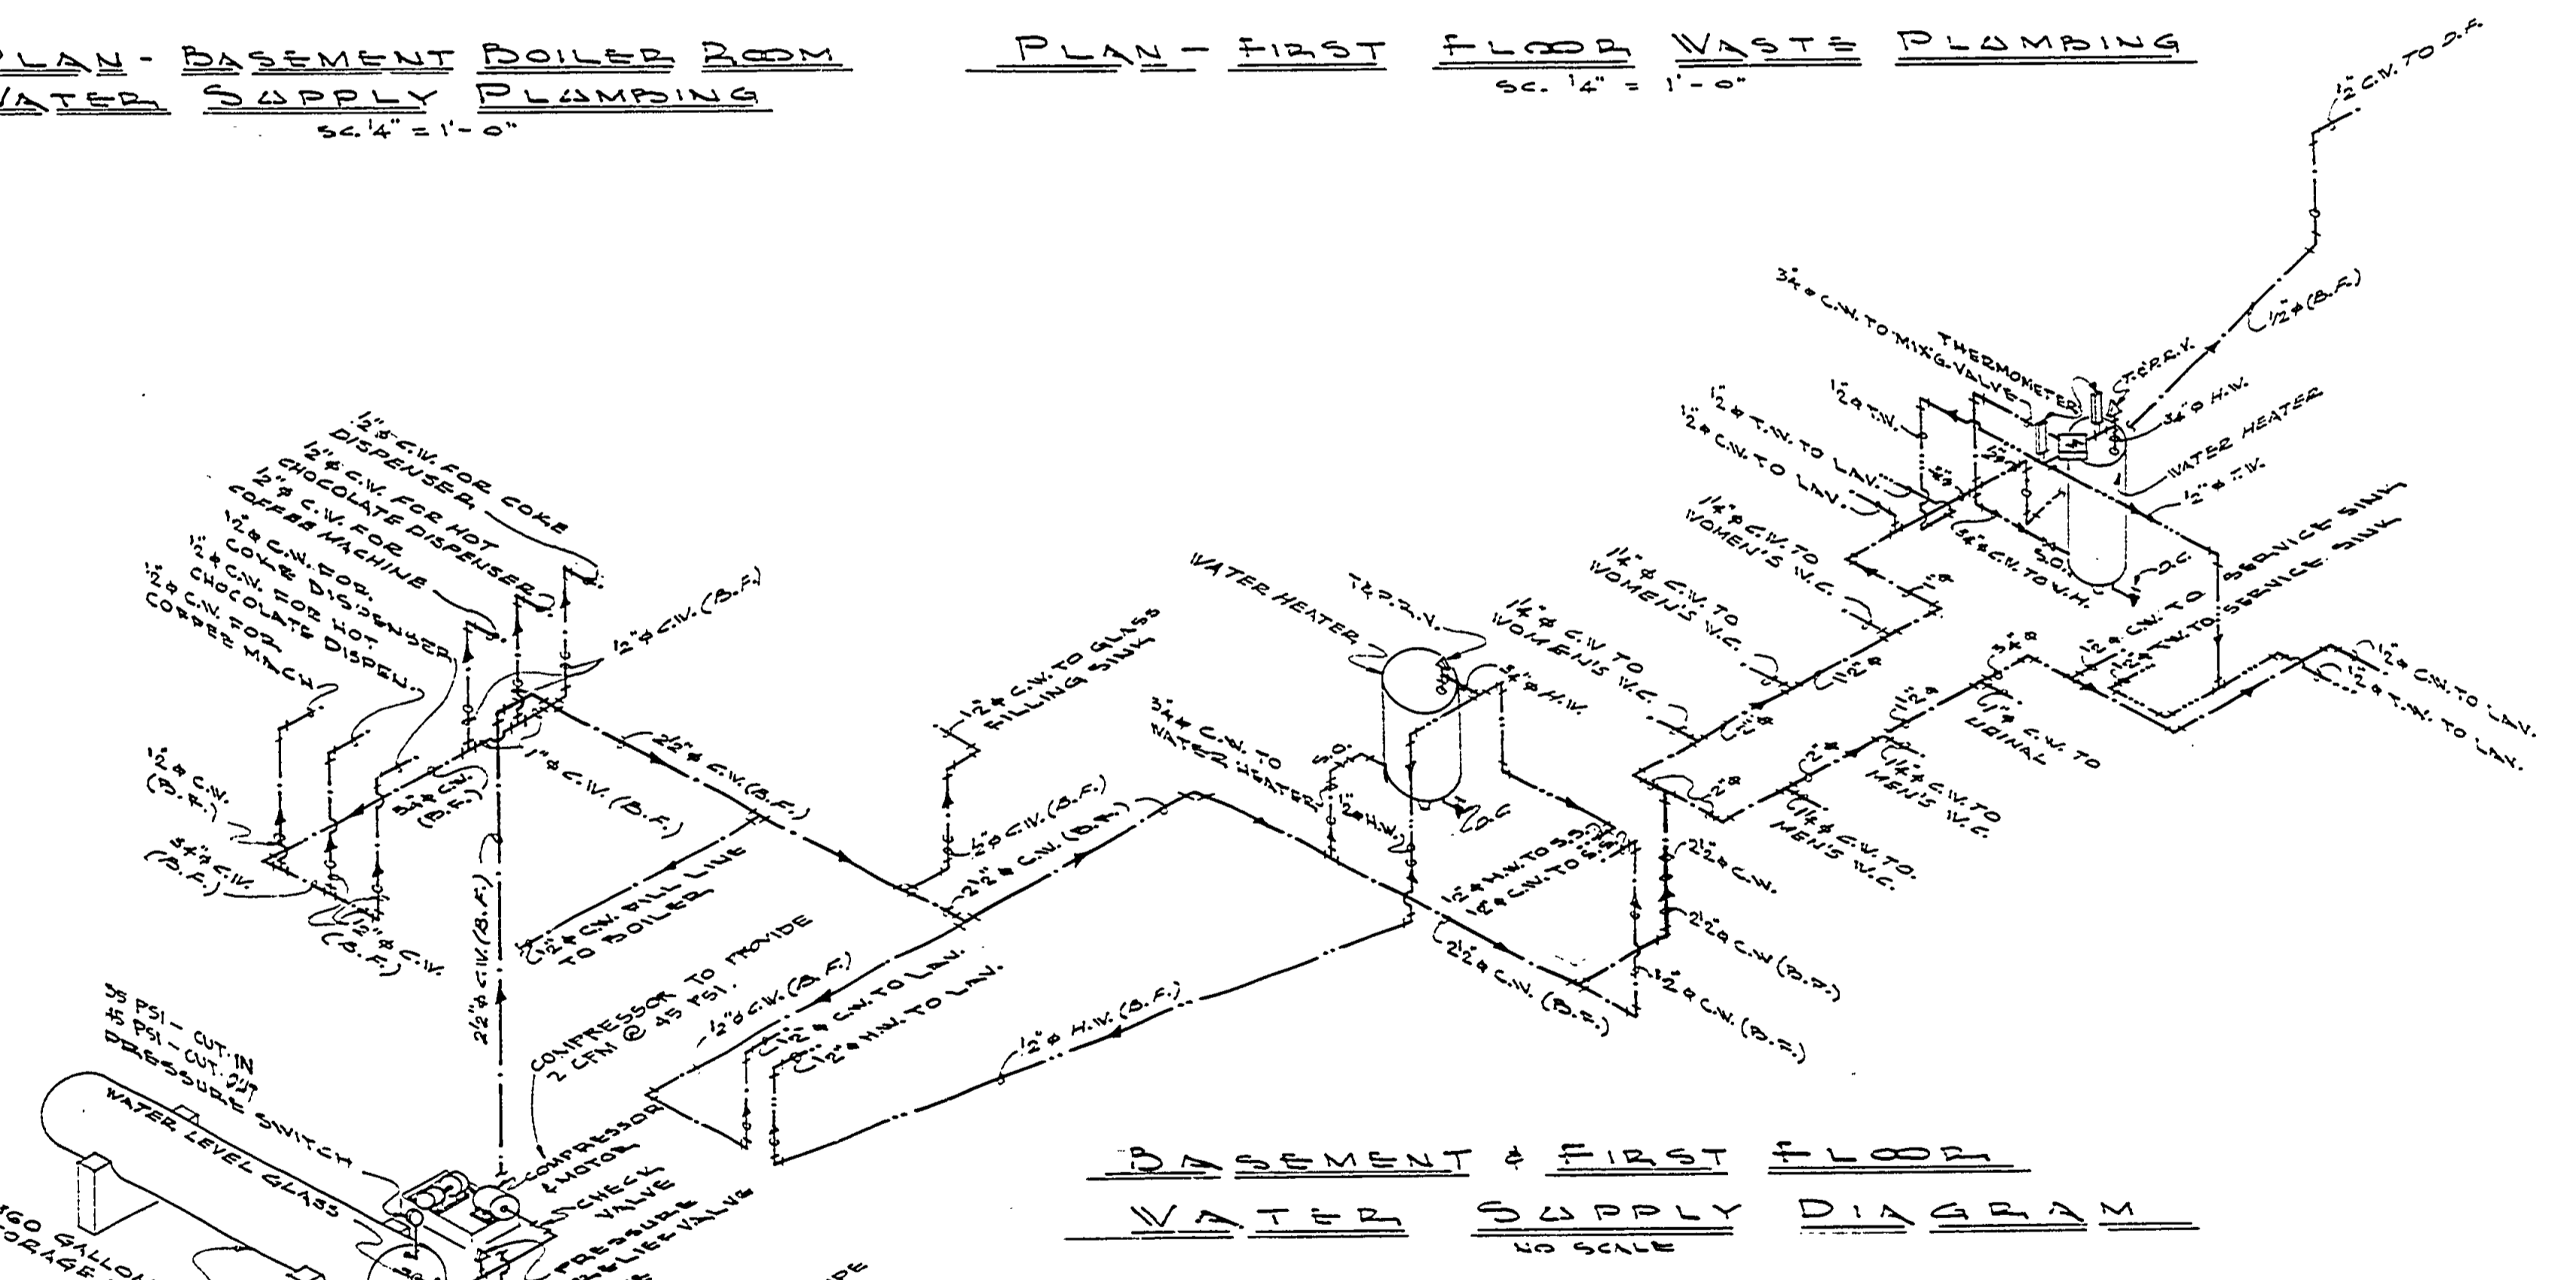

BASEMENT & FIRST FLOOR
WATER SUPPLY DIAGRAM
NO SCALE

REVISED AND APPROVED
By: *[Signature]*
PLUMBING DIVISION
DATE: 6-16-74

DESIGNED BY: M. & M.		DRAWN BY: D.D.P. & M.		DATE: 4/75		NO. 1.		DATE		REVISIONS		NO. 2.		DATE		REVISIONS		NO. 3.		DATE		REVISIONS		NO. 4.		DATE		REVISIONS	
MICHIGAN DEPARTMENT OF NATURAL RESOURCES										PLUMBING PLANS										PORCUPINE MOUNTAIN STATE PARK AREA OR PARK PROJECT									
SHEET TITLE										PROJECT										PROJECT NO. 24-1434									
SHEET 11 OF 15										PLAN NO. A-118																			