


# PORCUPINE MOUNTAINS STATE PARK

## SKI CHALET ADDITION

PORCUPINE MOUNTAINS  
WILDERNESS STATE PARK

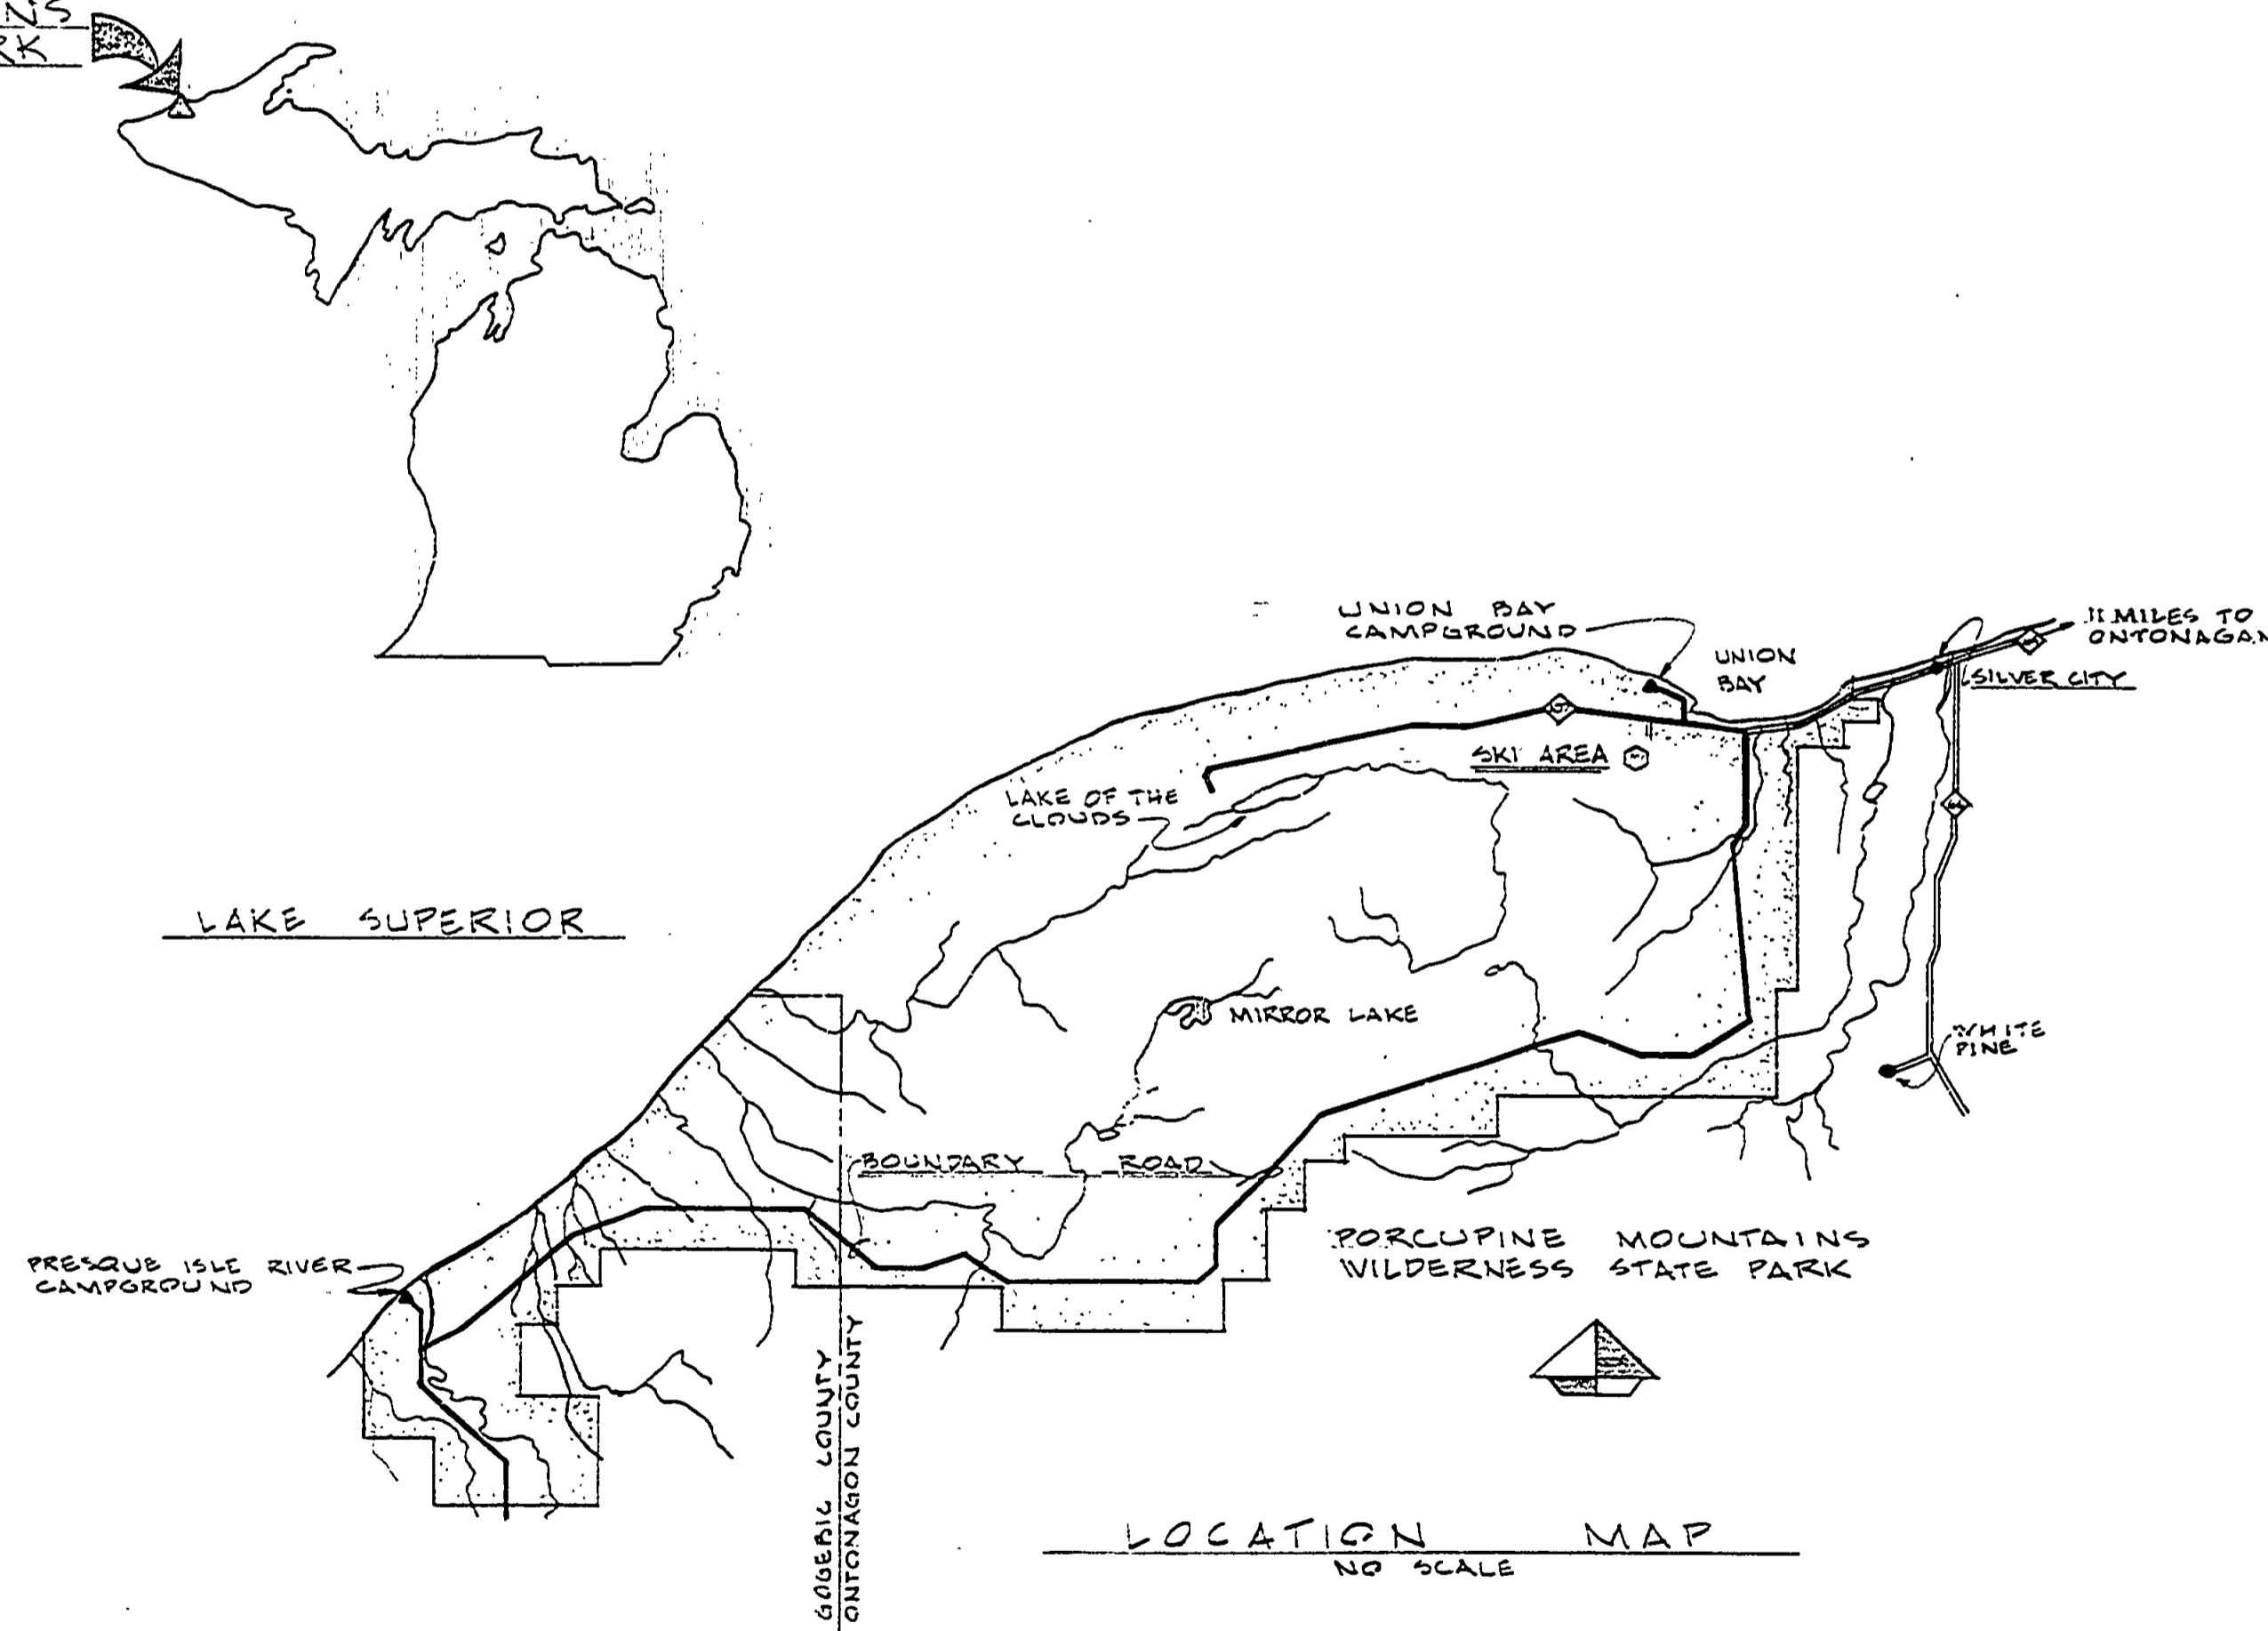

LOCATION MAP  
NO SCALE

DRAWING SCHEDULE	
NO.	DESCRIPTION
1	TITLE SHEET
2	SITE PLAN
3	FOUNDATION PLAN
4	FLOOR PLAN & RM. FINISH SCH.
5	ELEVATION & DOOR SCHEDULE
6	ELEVATION & DETAILS
7	ELEVATION & DETAILS
8	SECTIONS & DETAILS
9	SECTIONS & DETAILS
10	FLOOR FRAMING PLAN
11	PLUMBING PLANS
12	MECH. HEATING PLAN
13	MECH. DETAIL SHEET
14	MECH. HEATING DIAGRAMS
15	MECH. ELECTRICAL PLAN
15A	

BUILDING COMMITTEE APPROVAL	
BY: <i>[Signature]</i>	DATE: 6-2-75
RECOMMENDED FOR APPROVAL: <i>[Signature]</i>	
ENGINEERING OR ARCHITECTURAL SUPERVISOR DATE	
RECOMMENDED FOR APPROVAL: <i>[Signature]</i>	
PROGRAM AND PLAN COORDINATOR DATE	
DIVISION/REGION APPROVAL	
BY: <i>[Signature]</i>	
ENGINEERING DIVISION DATE	
APPROVED: <i>[Signature]</i> 6-20-75	
CHIEF ENGINEER DATE	

SURVEYED BY	DRAWN BY G. TOMPKINS	NO.	DATE	BY	REVISIONS	NO.	DATE	BY	REVISIONS
DESIGNED BY GRC & JLC	CHECKED BY	1.				3.			
DATE	DATE	2.				4.			

MICHIGAN  
DEPARTMENT OF NATURAL RESOURCES

TITLE SHEET  
SHEET TITLE

PORCUPINE MOUNTAINS STATE PARK  
PROJECT SKI CHALET ADDITION

PROJECT NO. 24-1454  
SHEET 1 OF 15 PLAN NO. A-118