

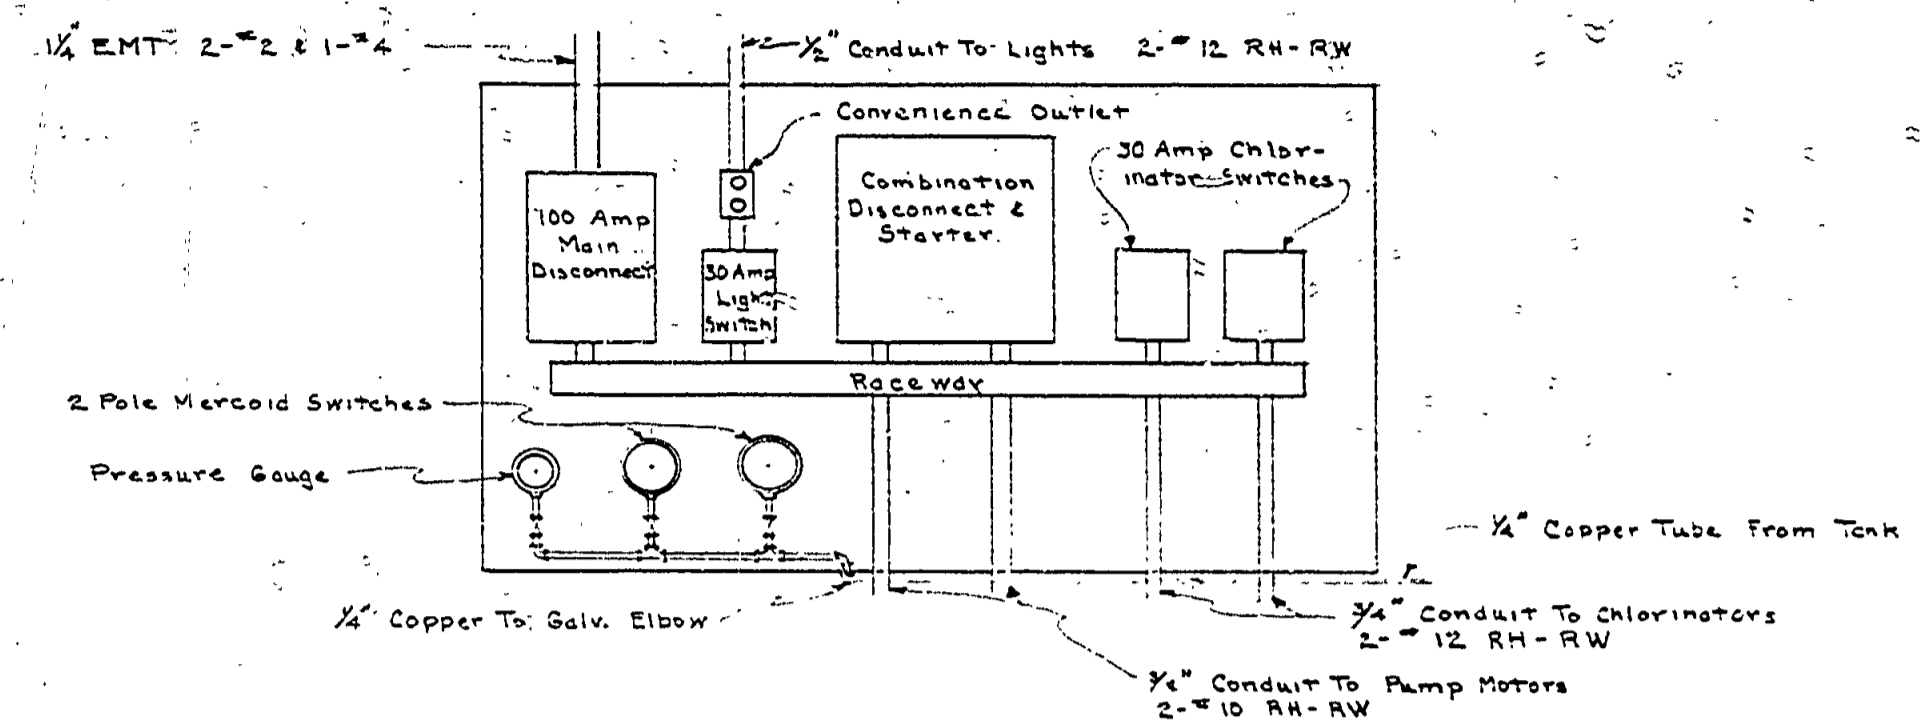



NO.	DATE	BY	REVISIONS
1			
2			
3			
4			
5			
6			

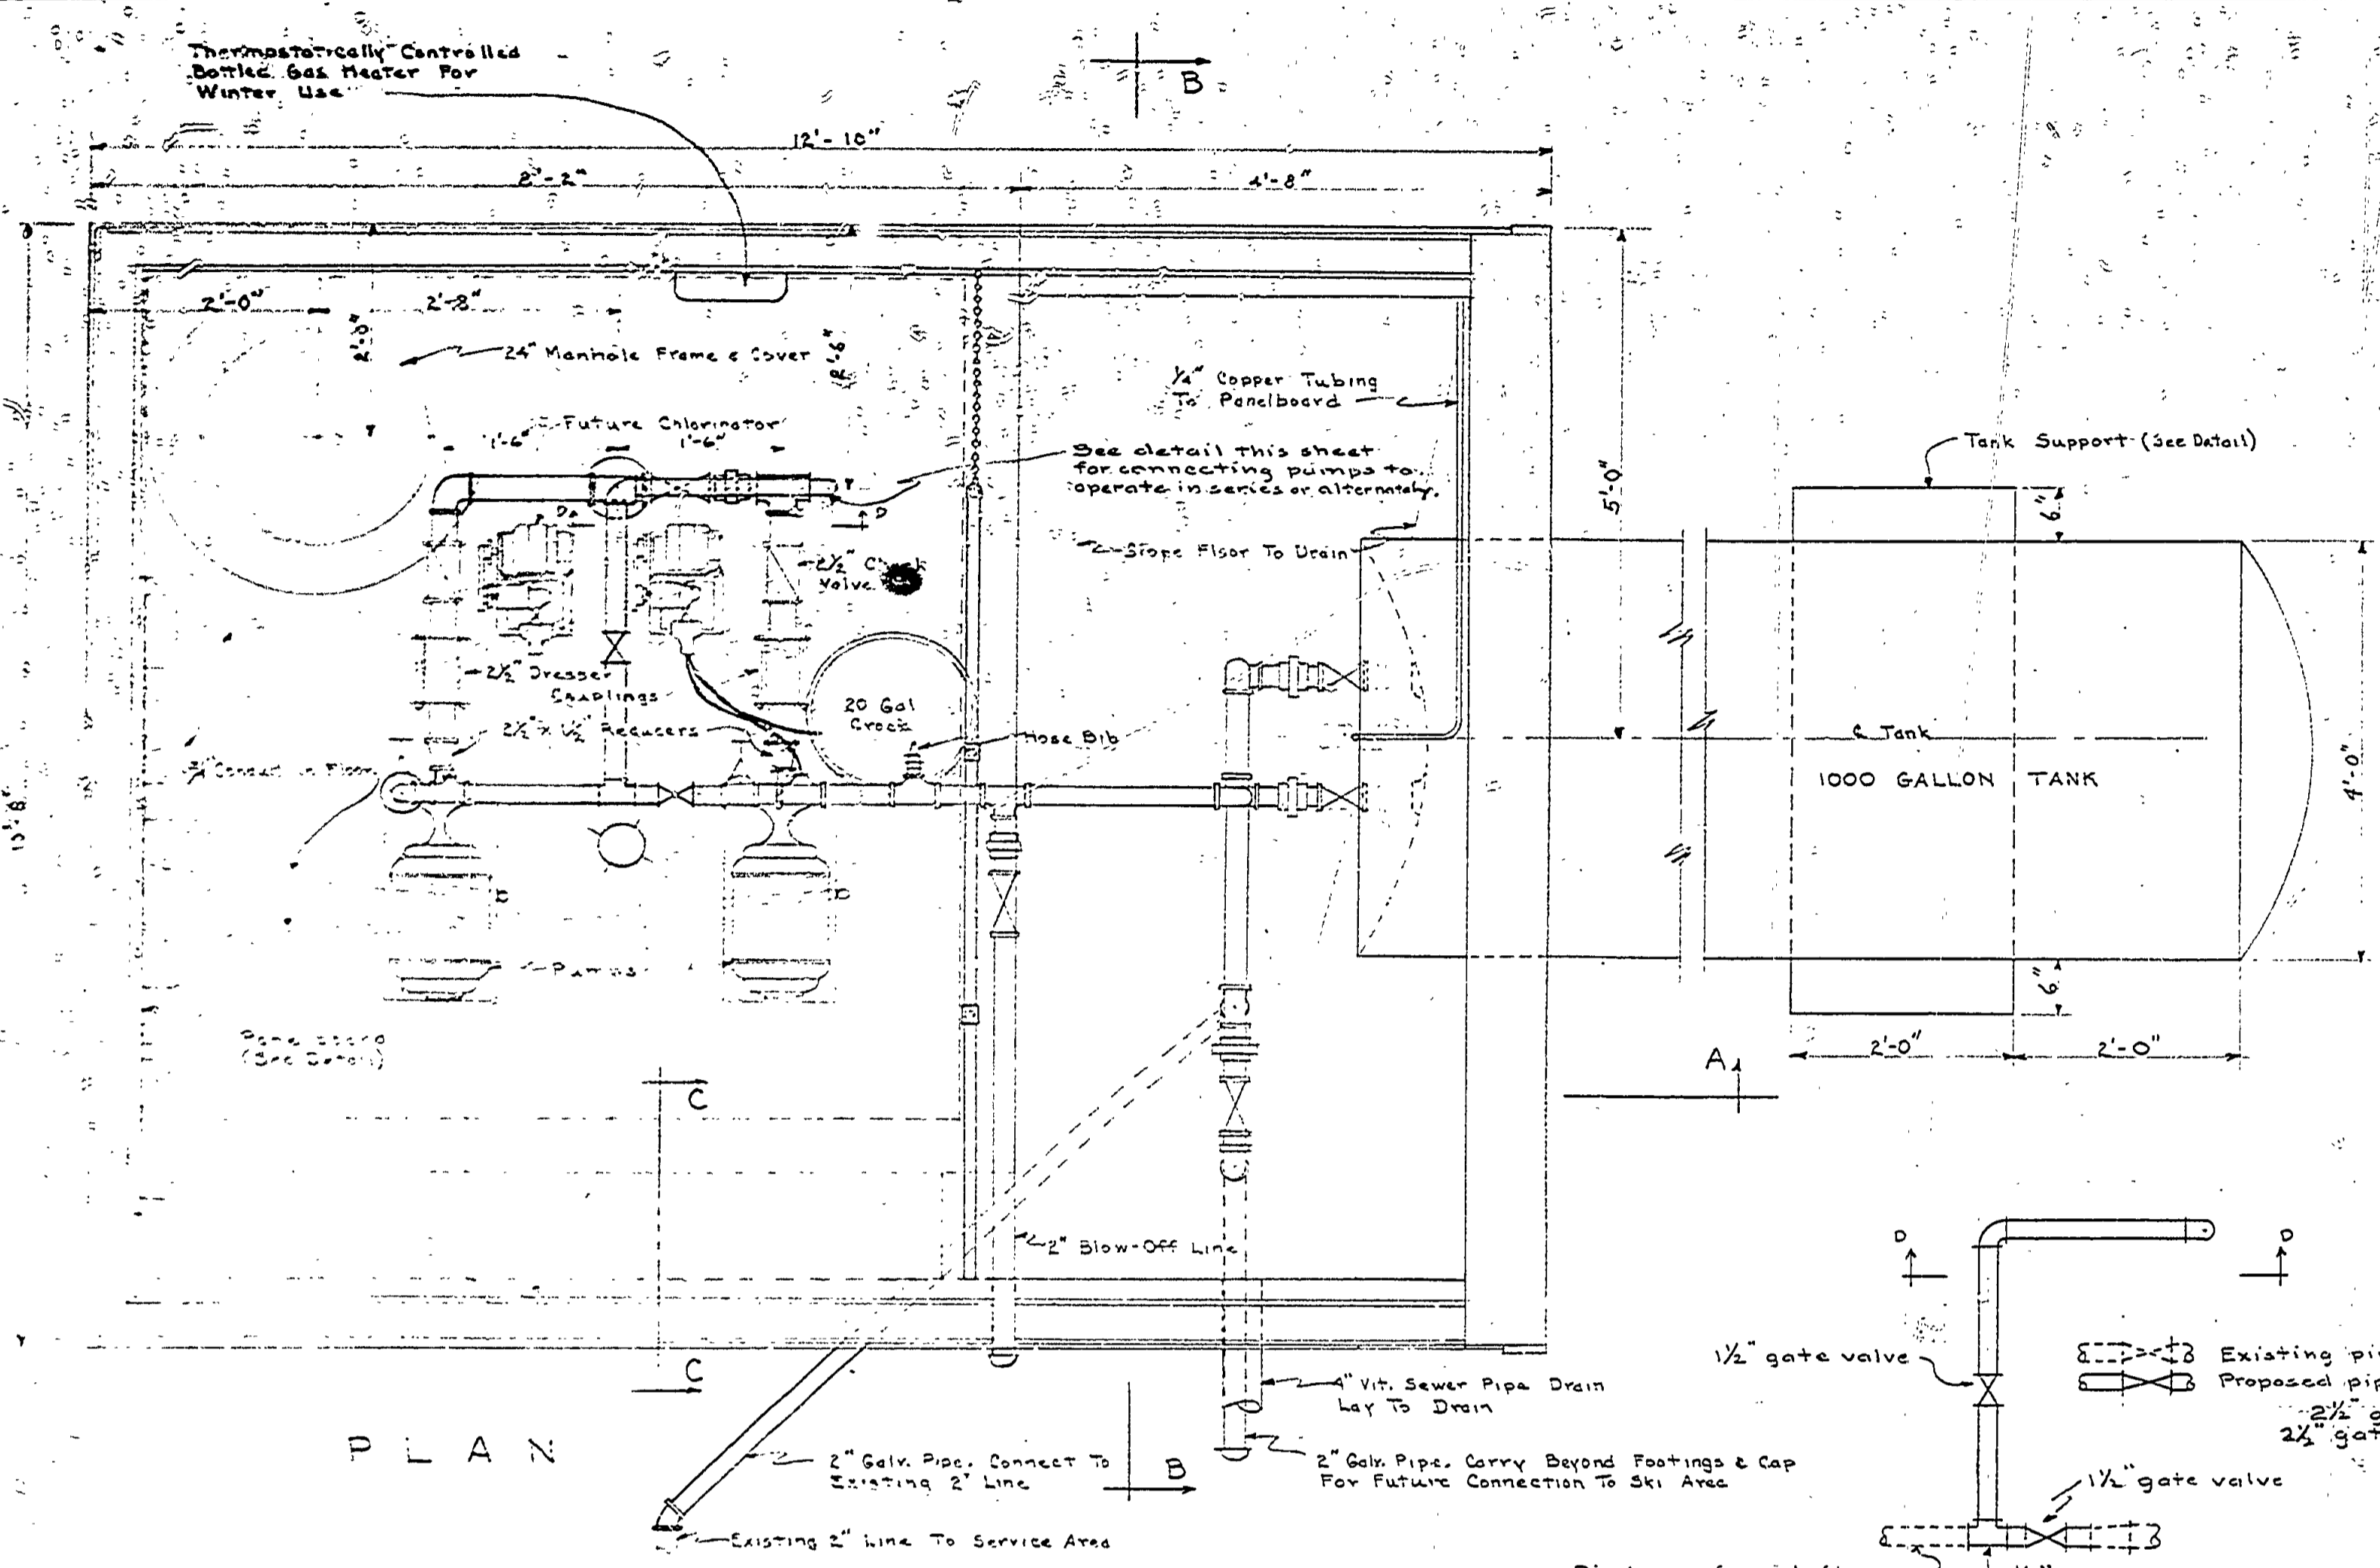


PANELBOARD DETAIL
Not To Scale

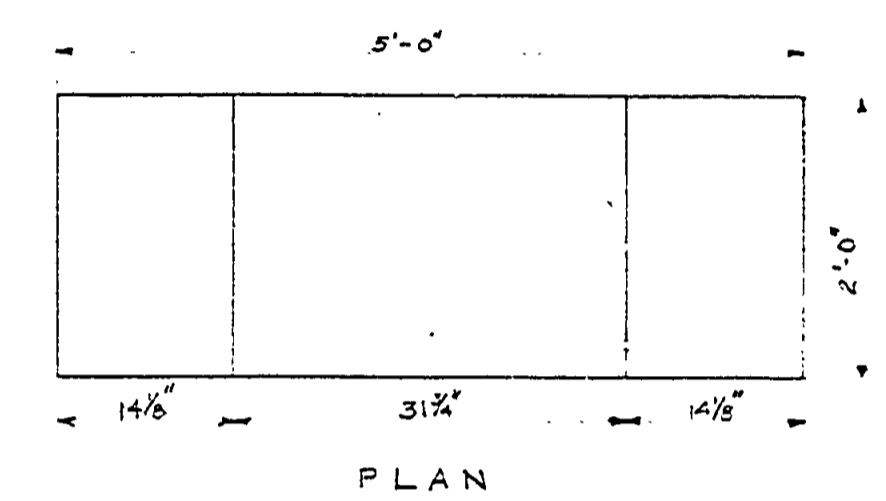


PLAN
SECTION
TANK SUPPORT DETAIL

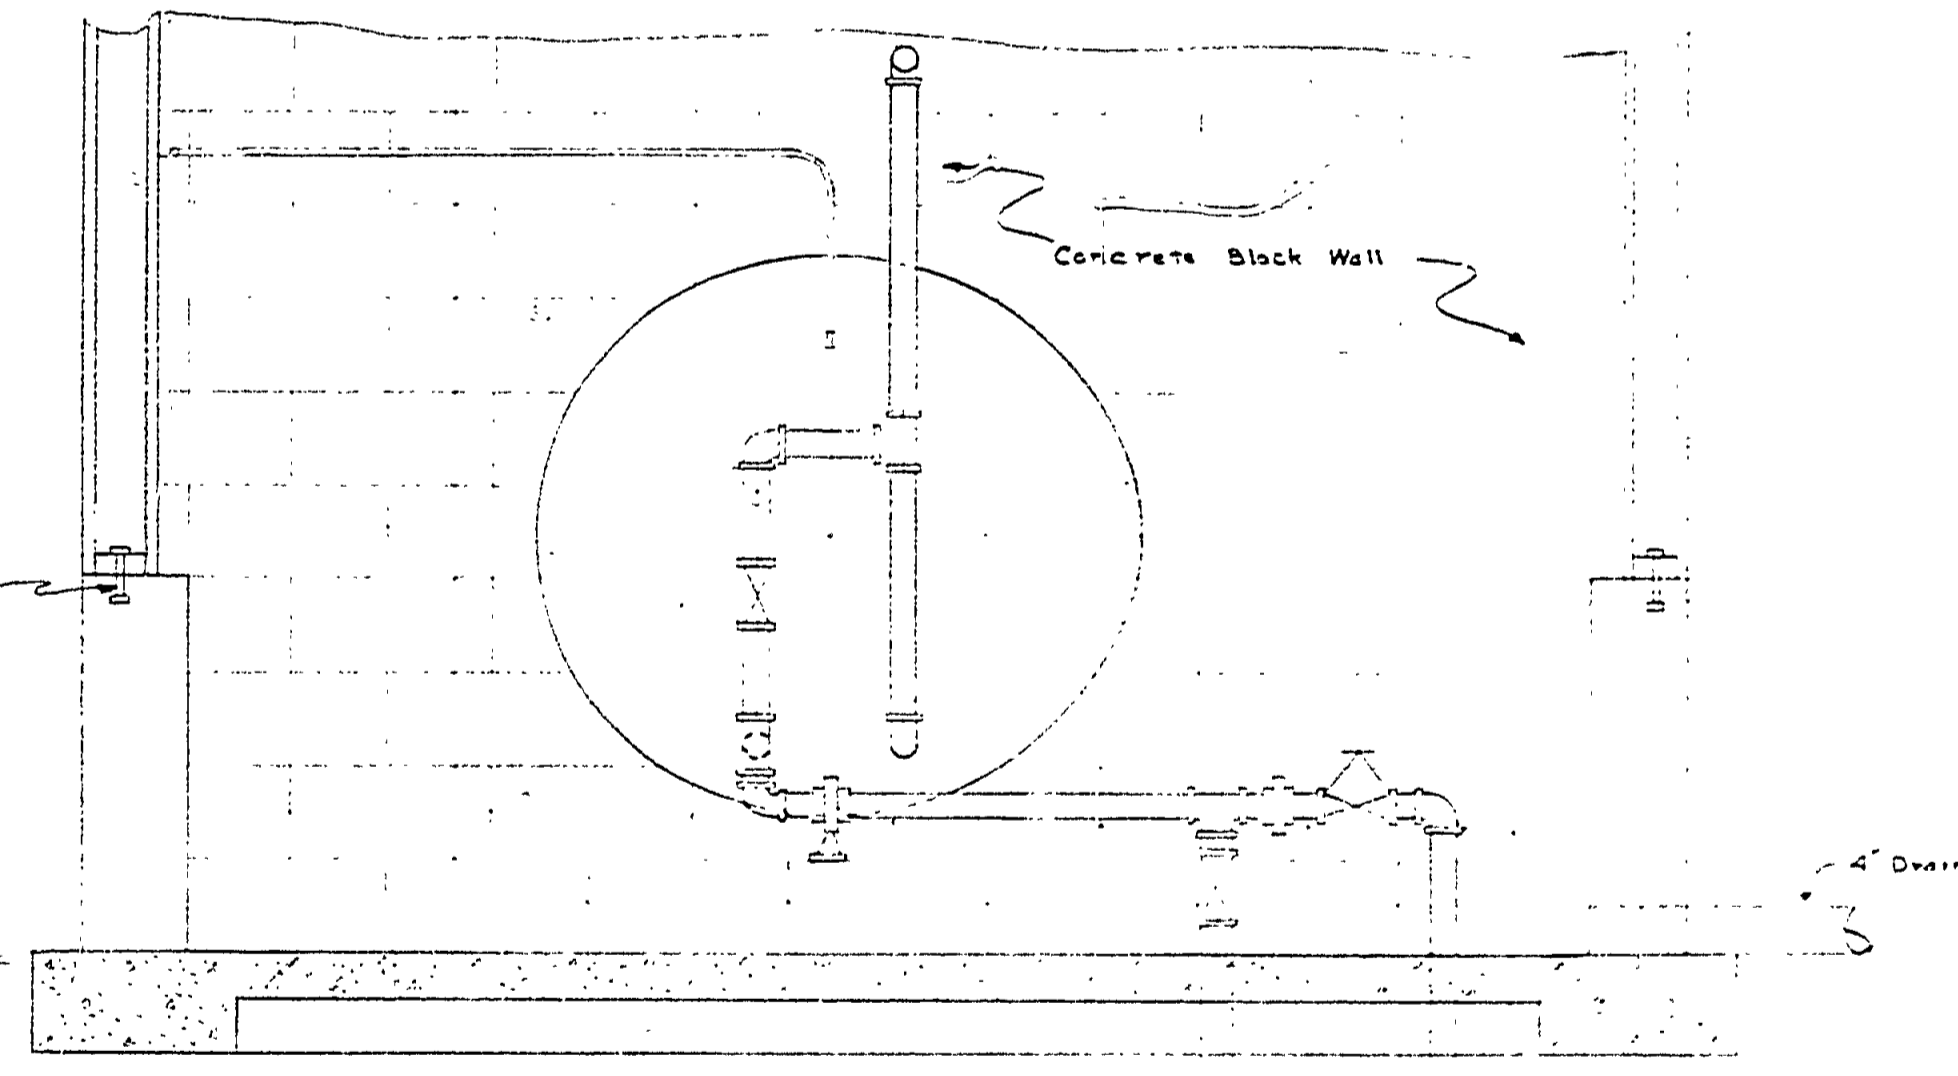


SECTION B-B

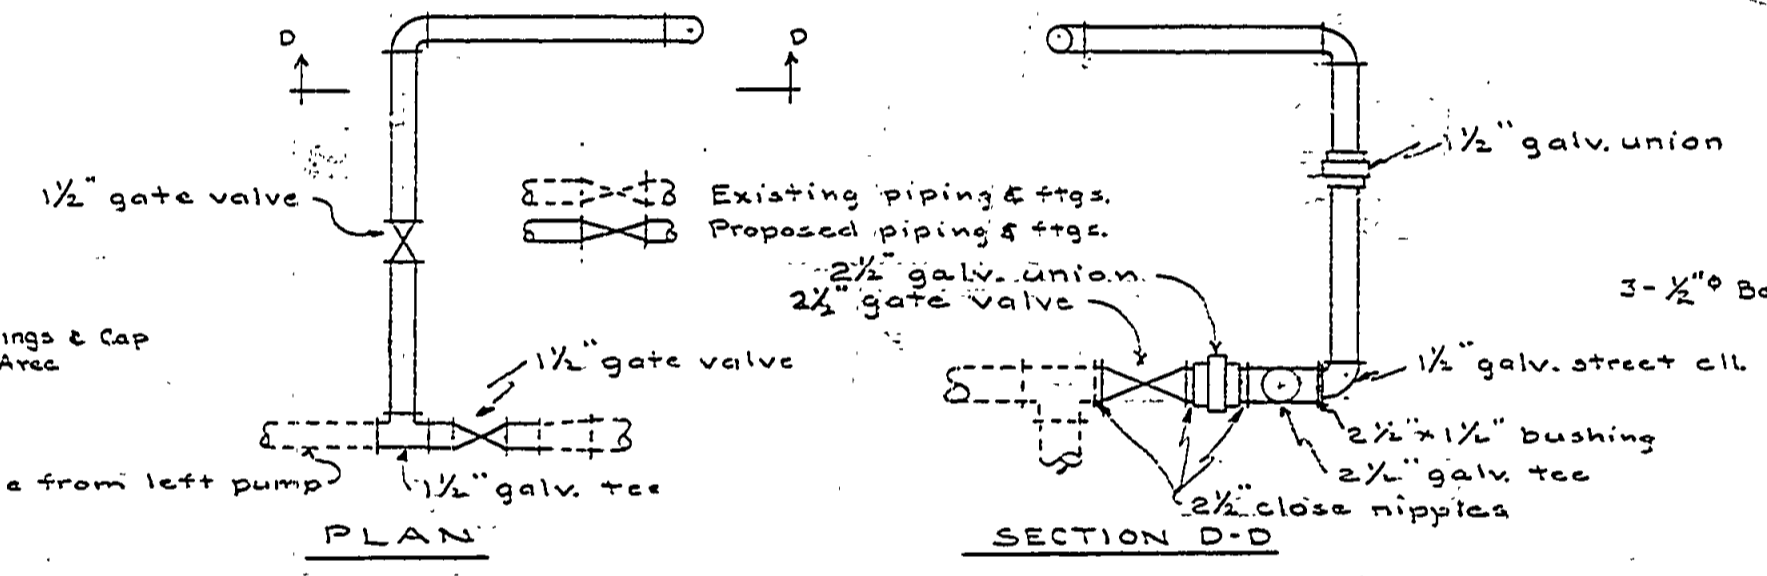

DETAIL FOR CONNECTING PUMPS TO OPERATE IN SERIES OR ALTERNATELY

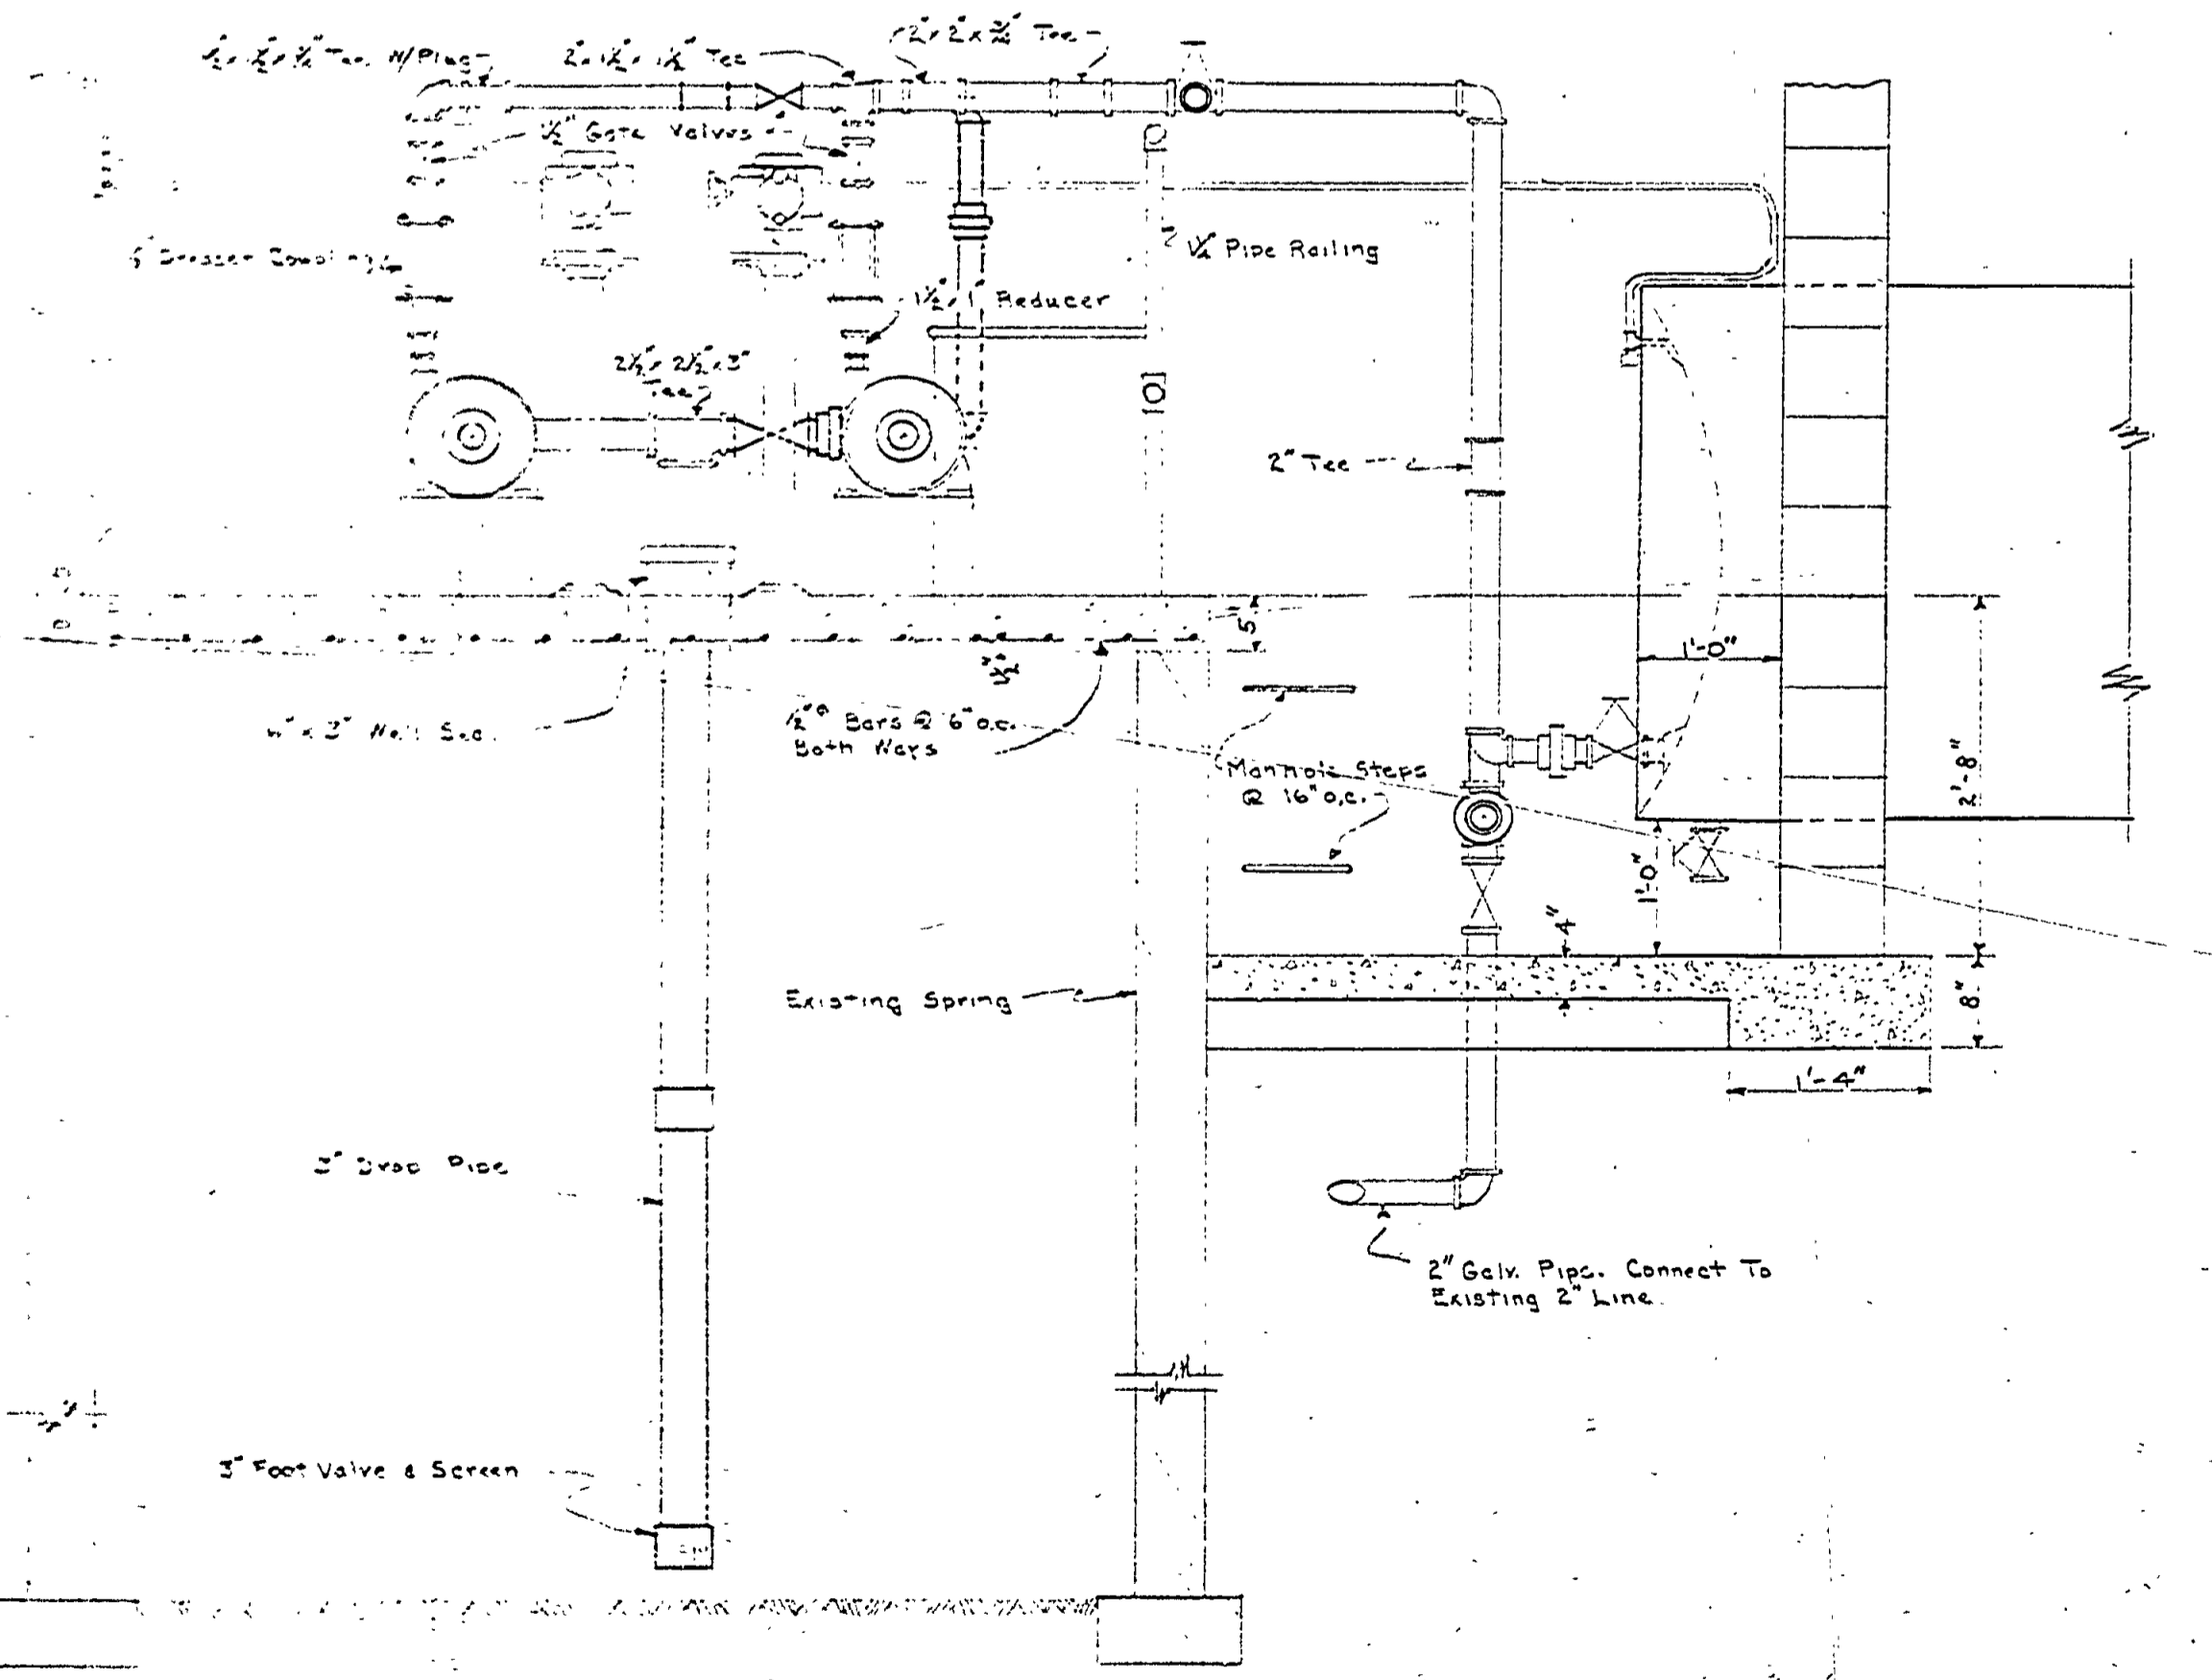

SECTION A-A

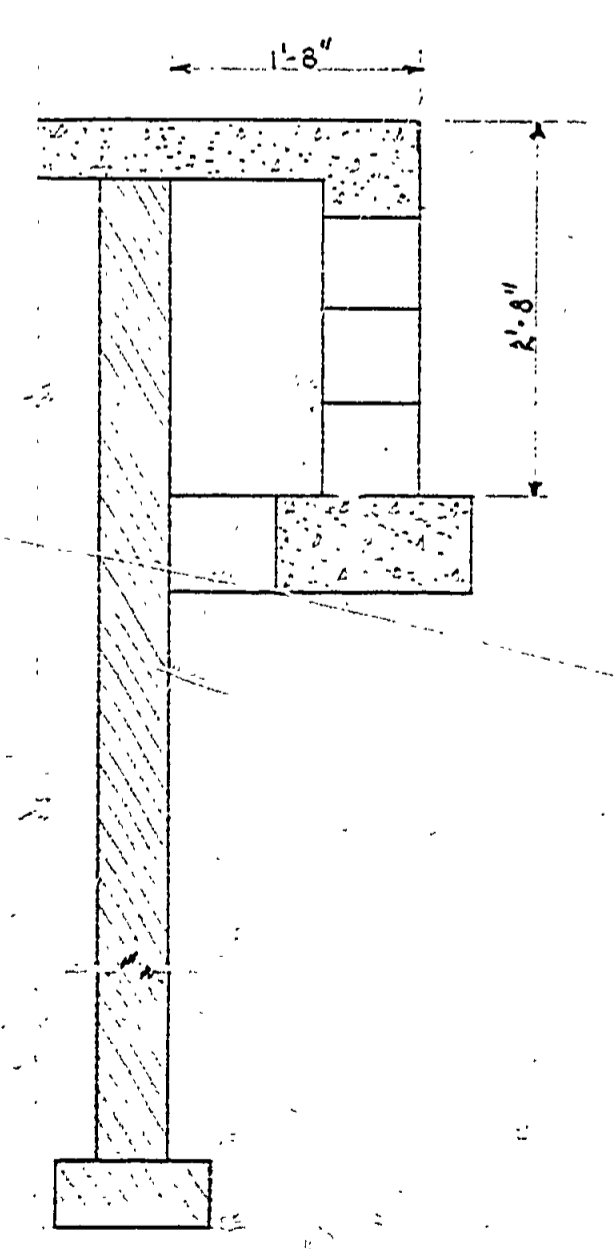

SECTION C-C

PUMPHOUSE SUBSTRUCTURE AND MECHANICAL DETAILS

MICHIGAN DEPARTMENT OF CONSERVATION PARKS AND RECREATION DIVISION

PORCUPINE MOUNTAINS STATE PARK WATER SYSTEM - EAST SECTION
Scale 3/4" = 1'-0"

SHEET NO. 4 OF 5
PLAN NO. E-111