


NO. DATE BY	1		
2			
3			
4			
5			
6			

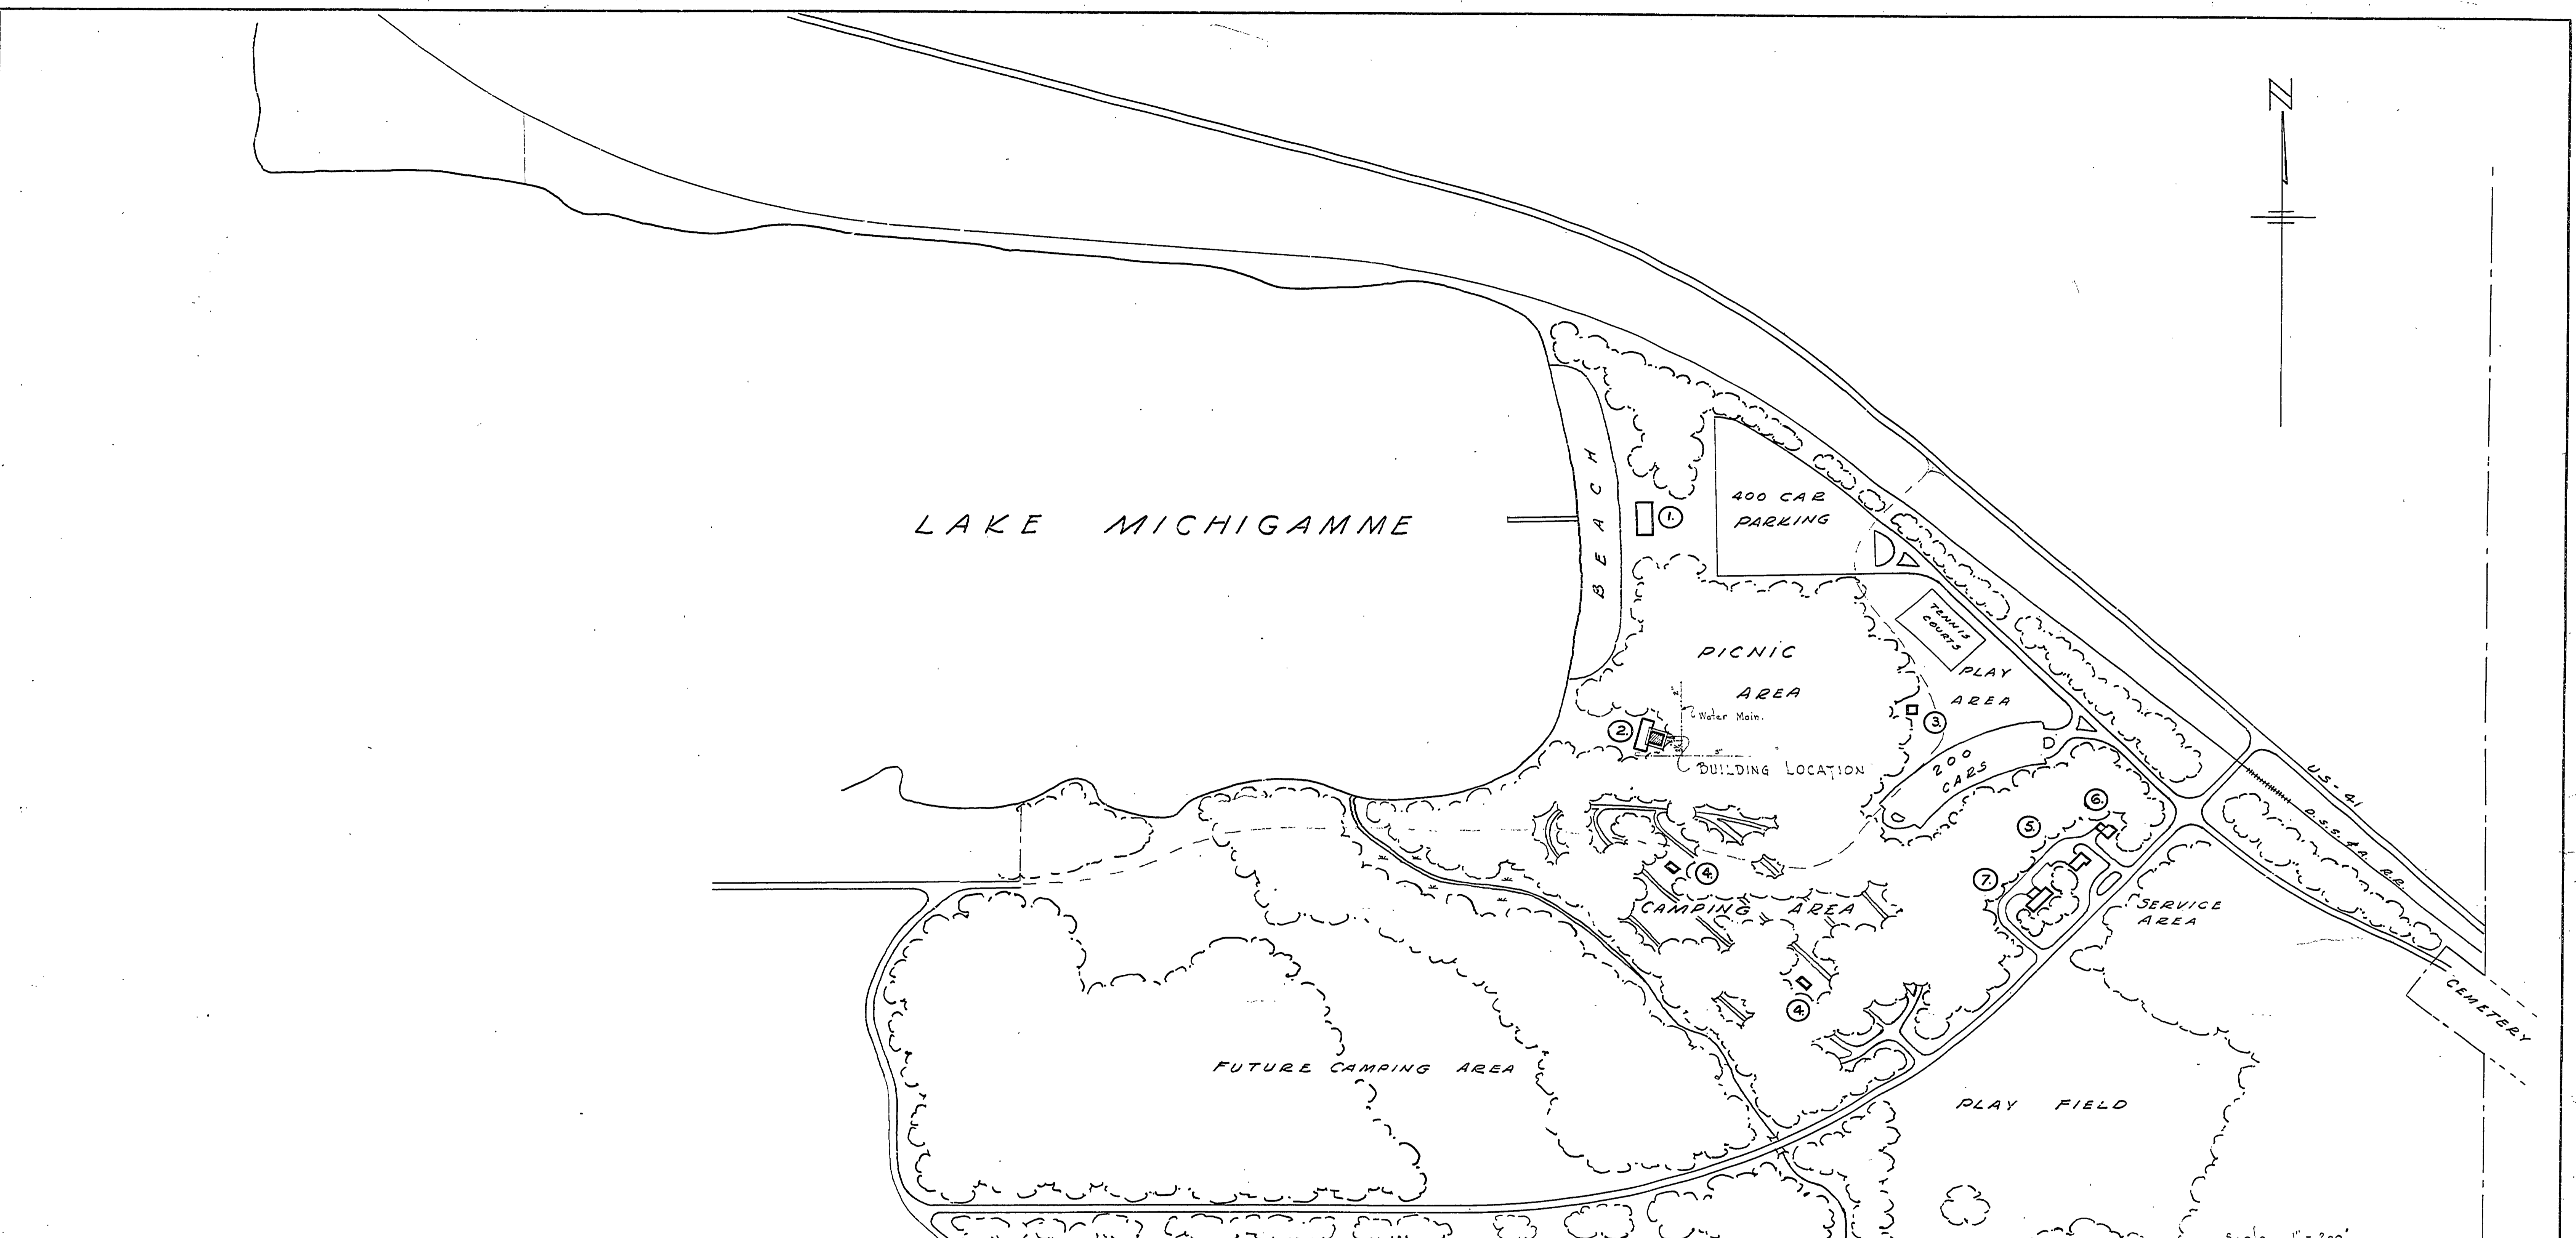

DRAWING SCHEDULE		
PLAN No.	SHEET No.	TITLE
A-101	1	Title sheet and location map.
A-101	2	Foundation, floor and electrical plan.
A-101	3	Elevations, section and details.
A-101	4	Interior elevations, section & details.

SCALE 1" = 200'

MICHIGAN
DEPARTMENT OF CONSERVATION
PARKS AND RECREATION DIVISION

TITLE AND LOCATION PLAN
VAN RIPER STATE PARK
SHELTER AND TOILET BLDG #2
TOILET PORTION

SHEET NO. 1 OF 3
PLAN NO. A-101