
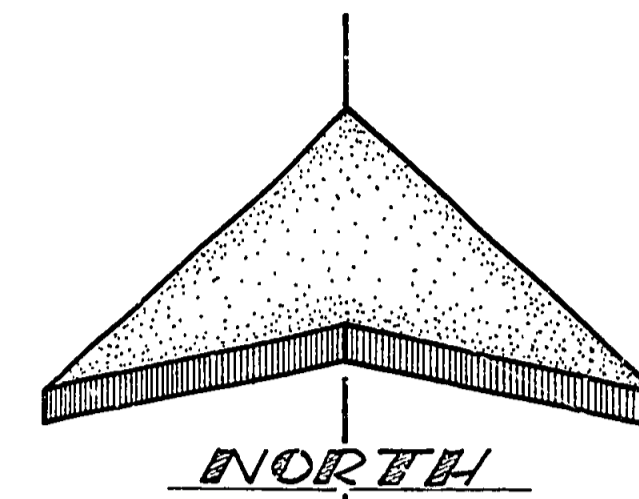


# VAN RIPER STATE PARK




## TOILET AND SHOWER BUILDING 5-A & 5-B

### PROJECT NO. 975-12-C2

*Arthur James "Viper" Viper*  
 CHIEF, PARKS AND RECREATION DIVISION

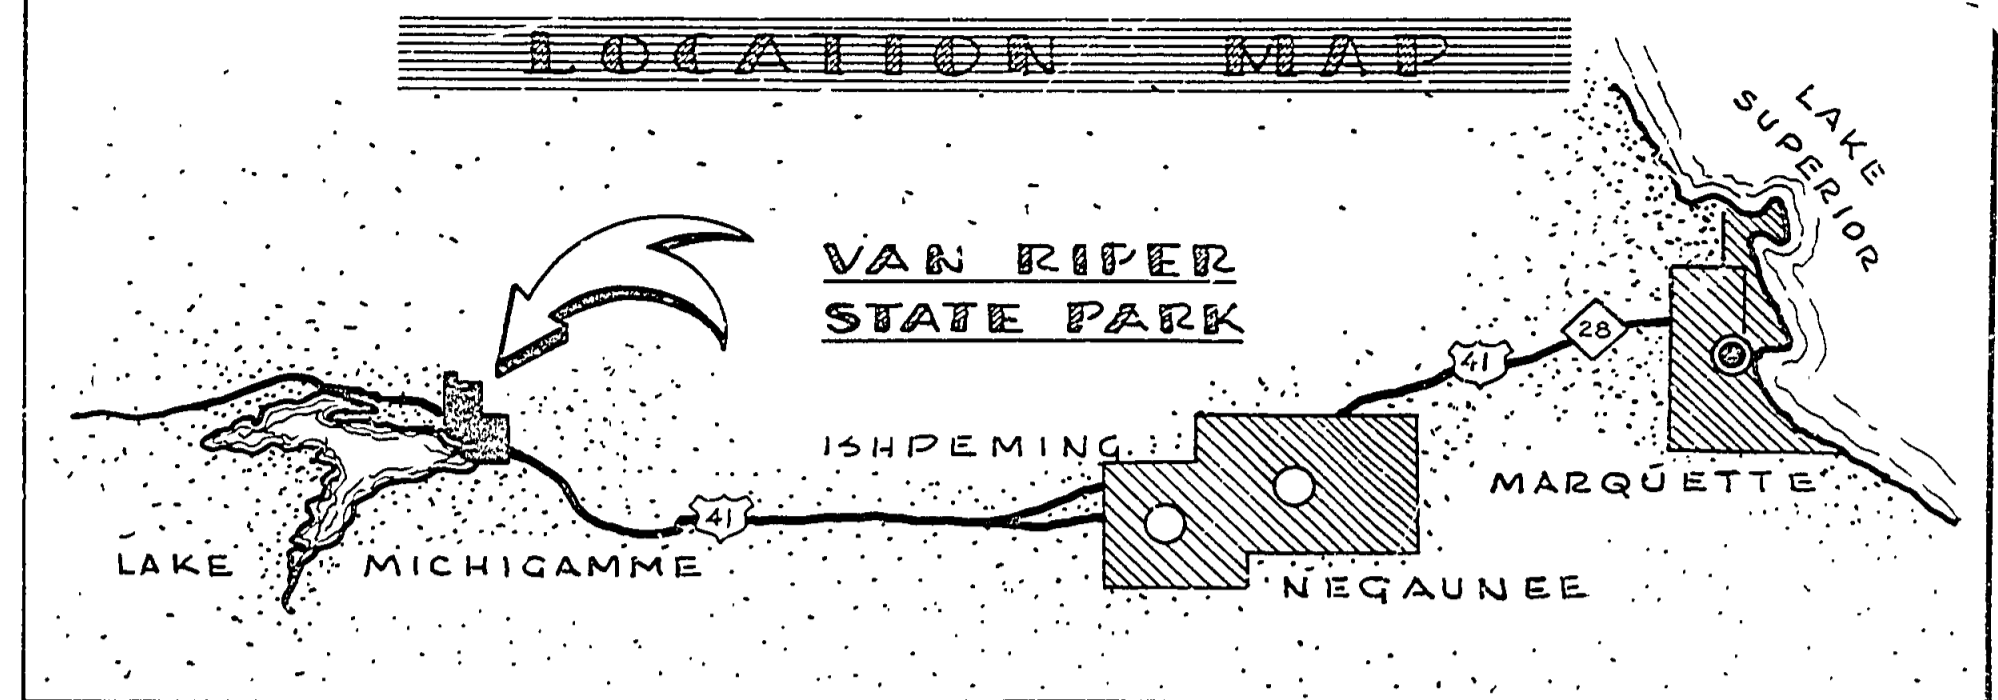

- SHEET INDEX**
- SHEET NO.
1. COVER SHEET, SITE PLANS.
  2. FOUNDATION PLAN & SECTION.
  3. FLOOR PLAN & DETAILS.
  4. ROOF FRAMING PLAN & DETAILS.
  5. ELEVATIONS & DETAILS.
  6. ELECTRICAL & MECHANICAL PLANS.

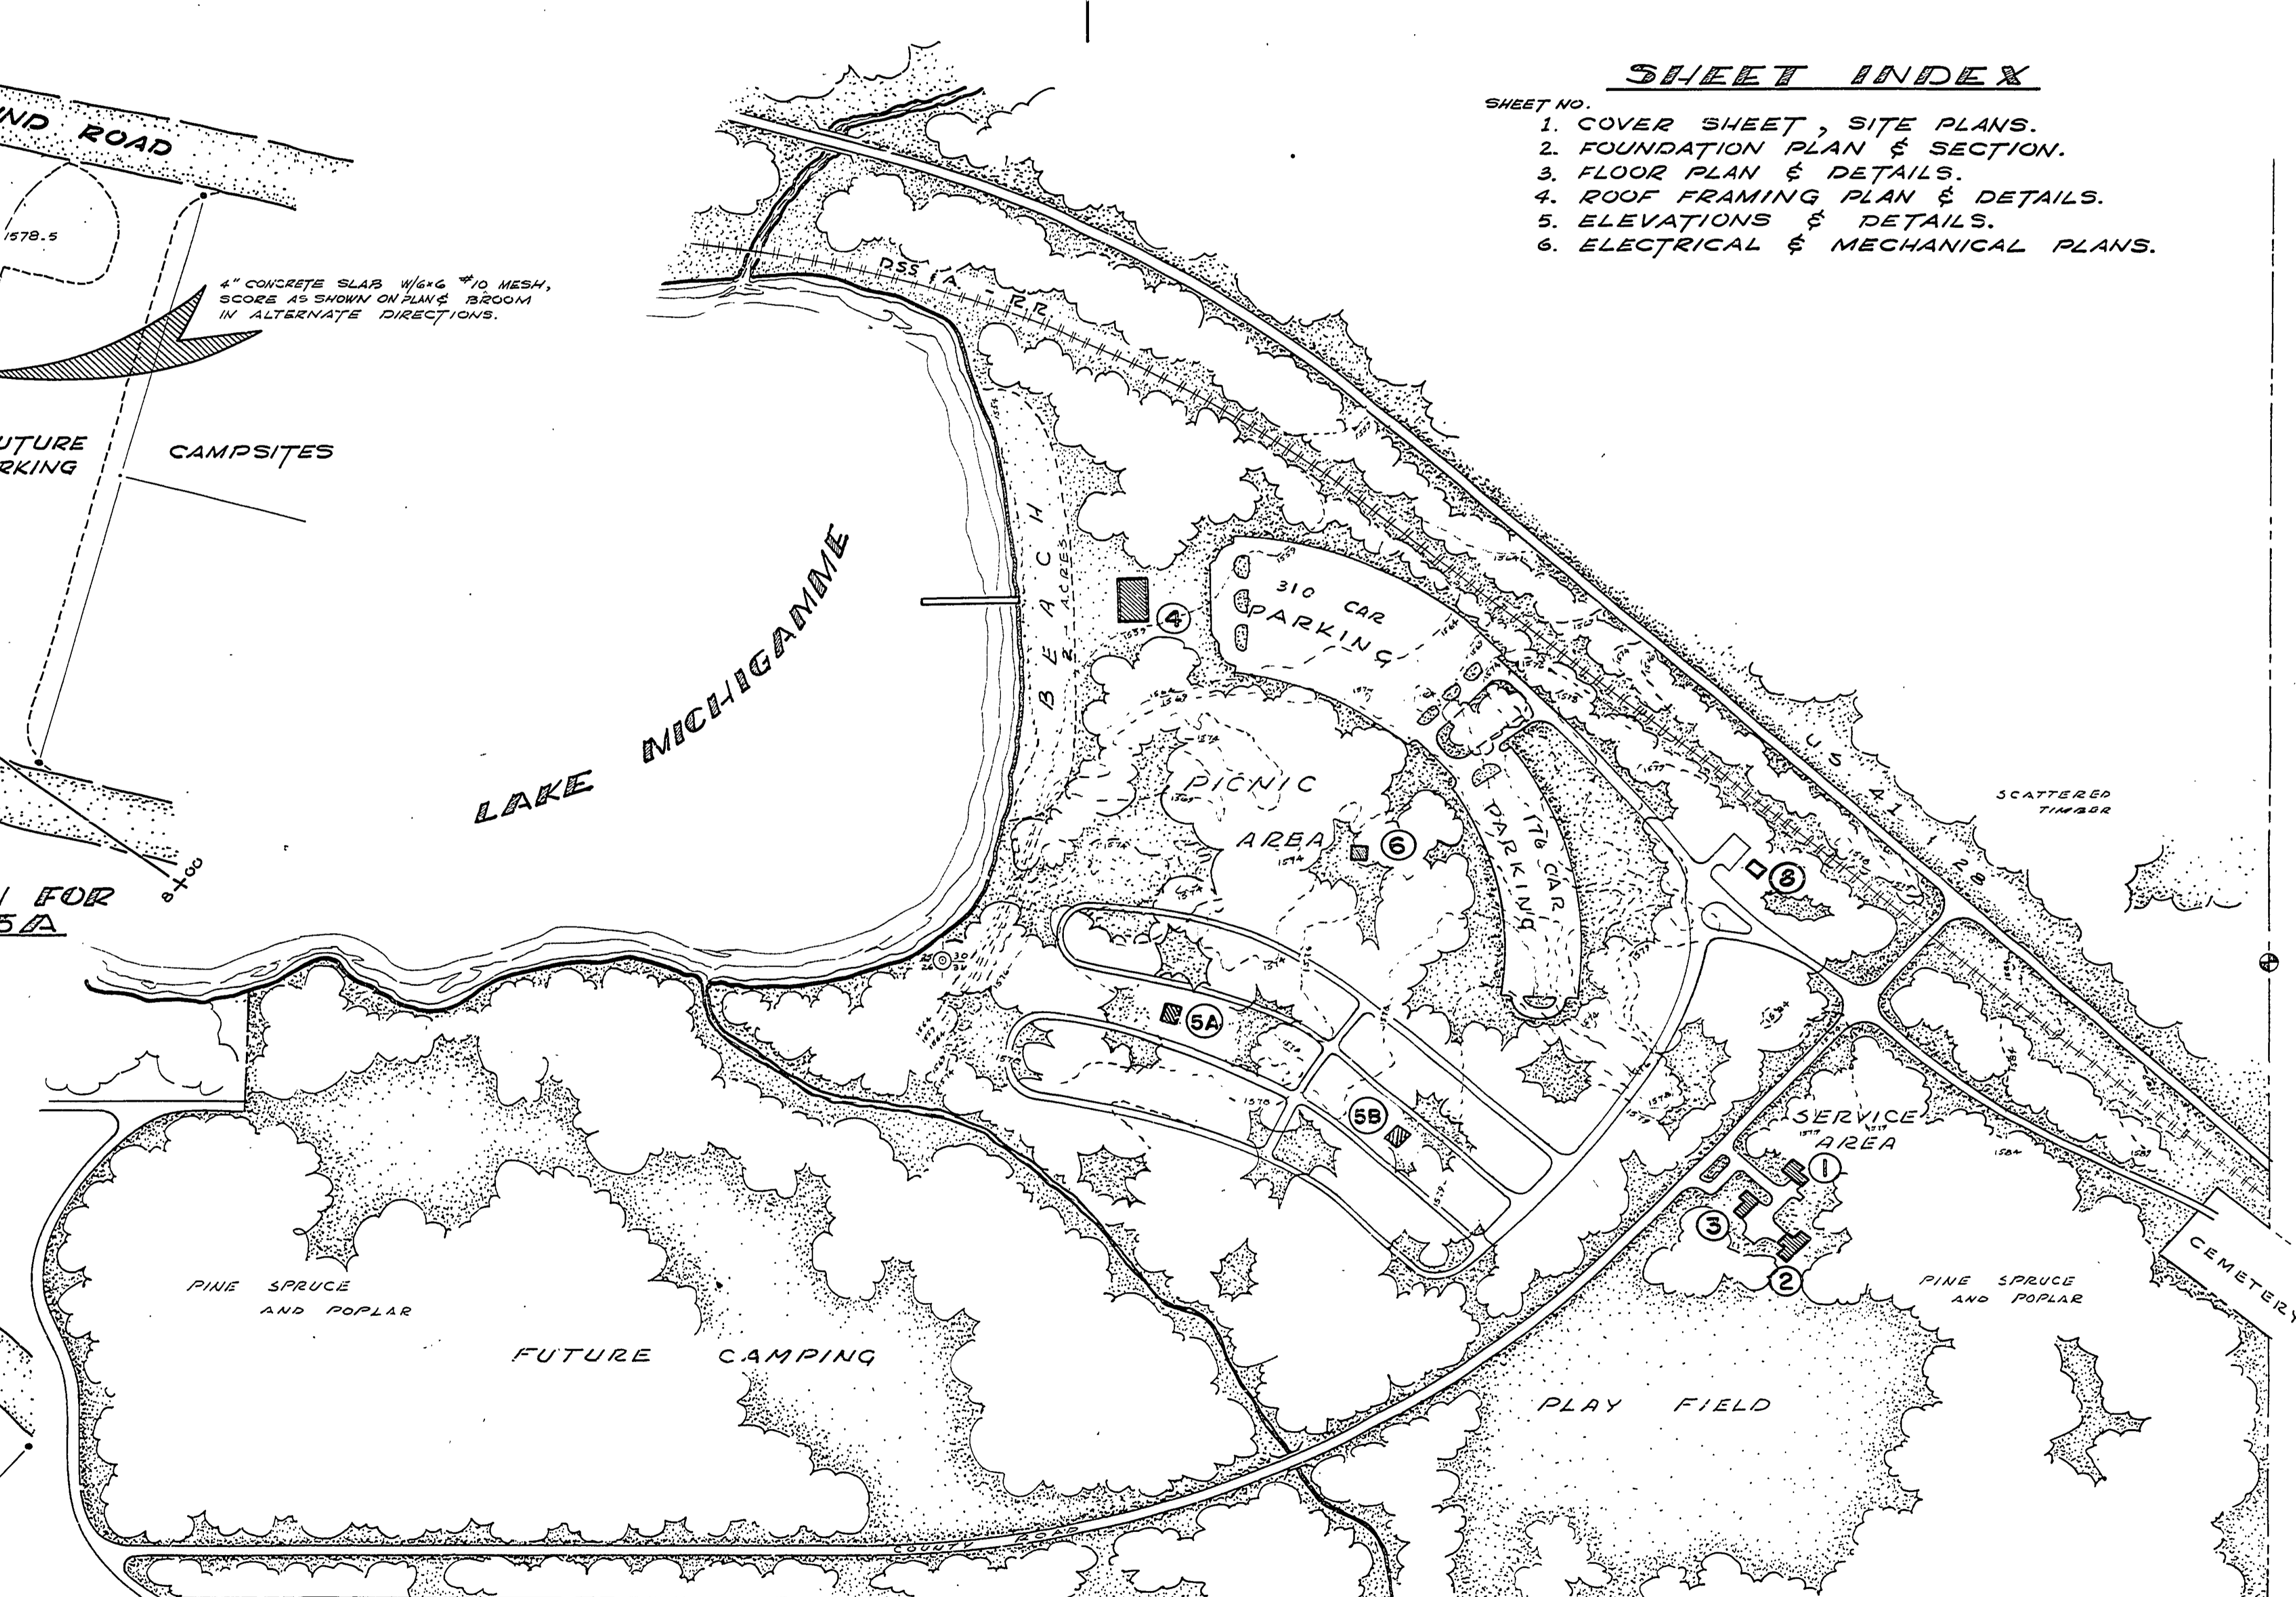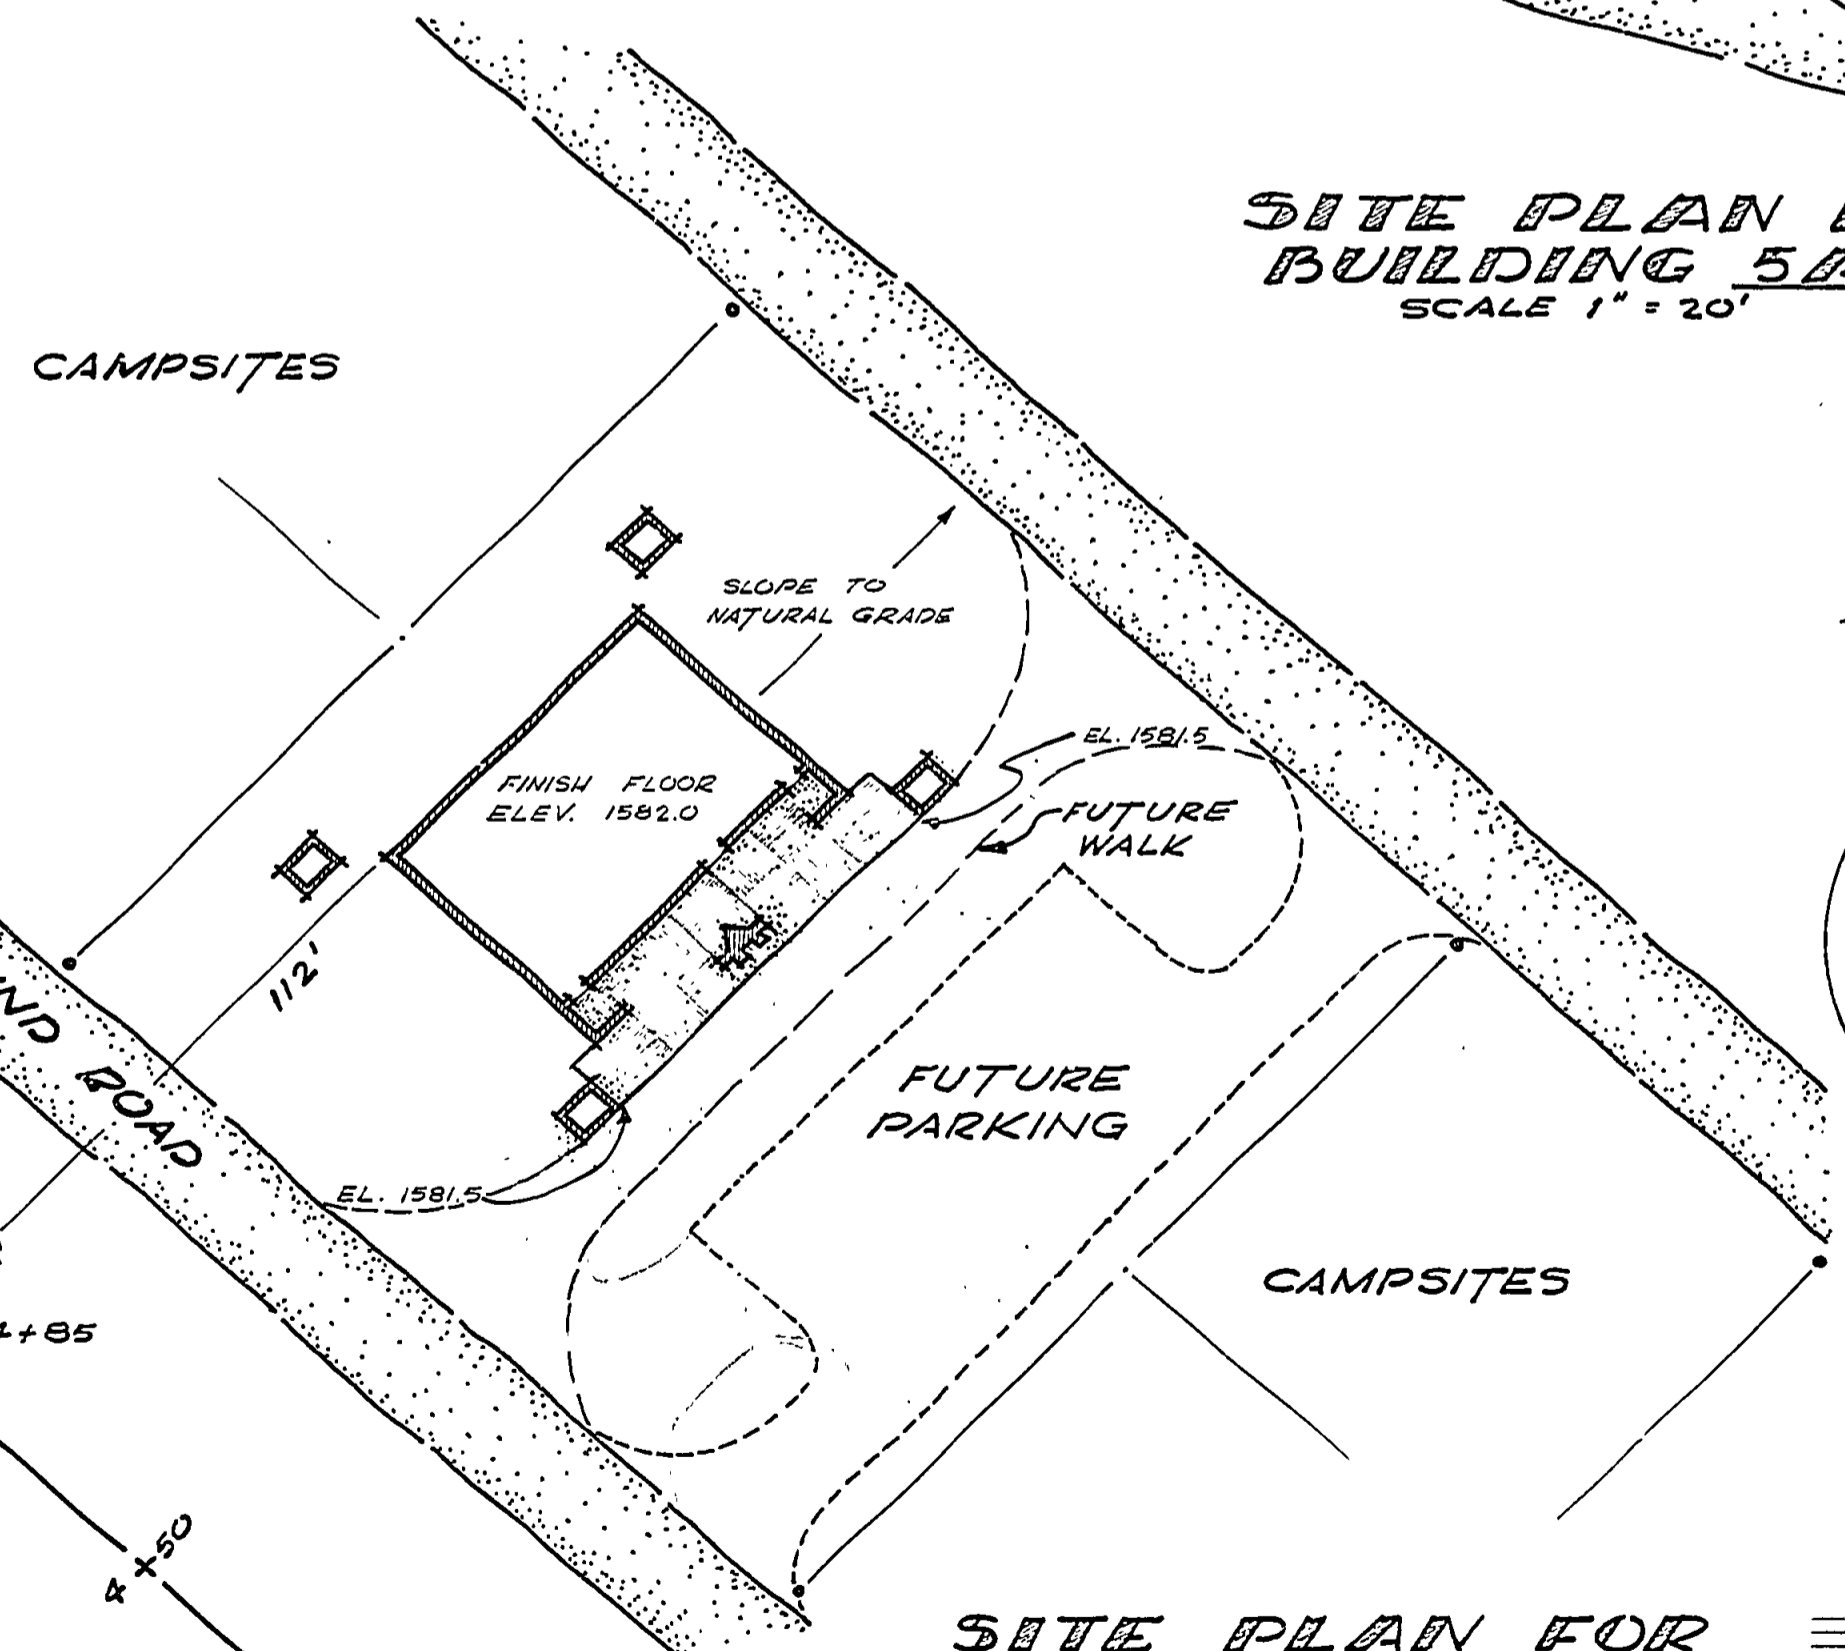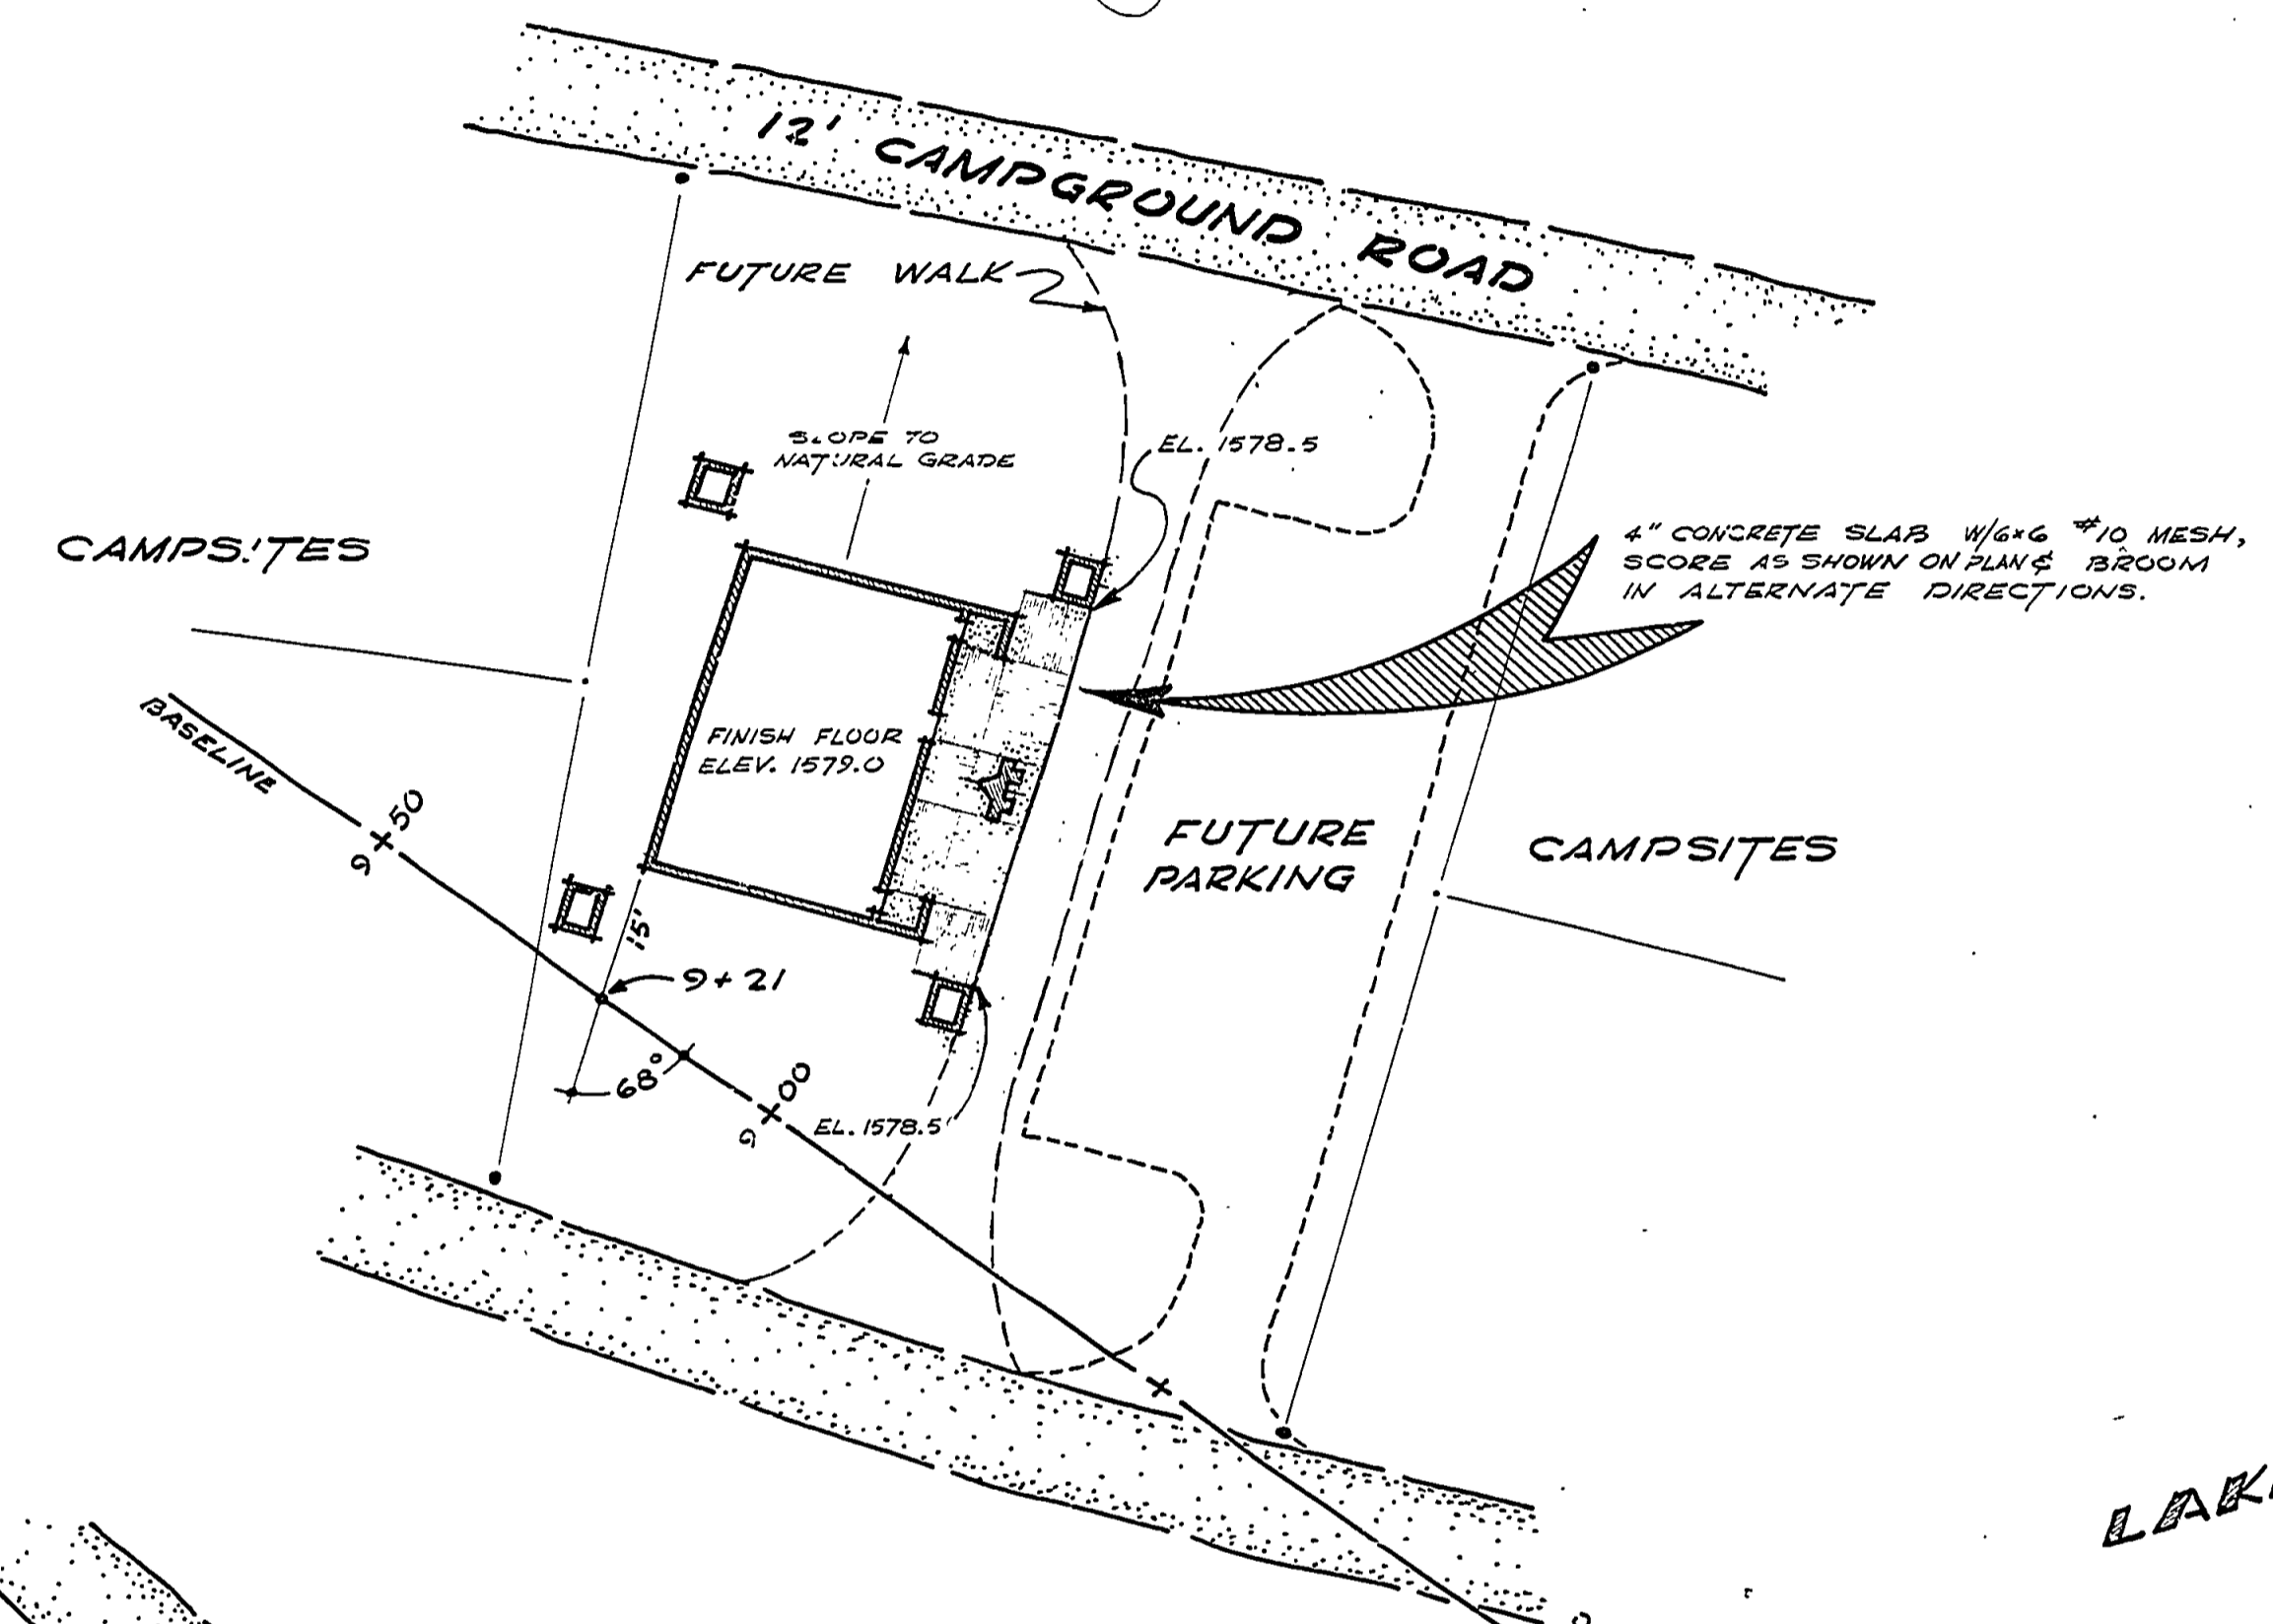

REVISIONS	DATE	BY
4		
5		
6		
7		

NO.	DATE	BY
1		
2		
3		

APPROVED BY	DATE	REVIEWED BY SECTIONS
<i>H. C. ...</i>	11.23.64	ARCHITECTURAL ENGINEERING LANDSCAPE

DRAWN BY	TRACED BY	CHECKED BY	DATE
<i>S. A. A.</i>	<i>S. A. A.</i>	<i>S. A. A.</i>	12-14-64