
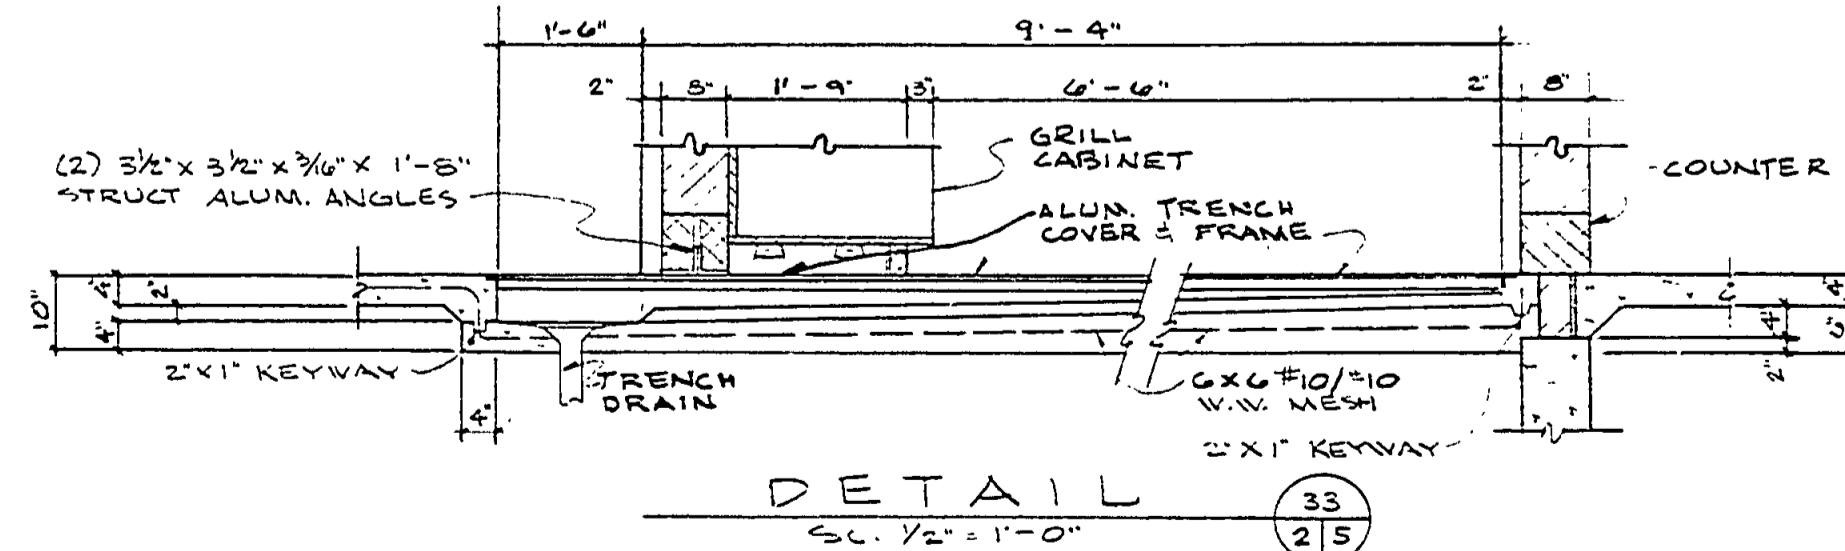


- LEGEND**
- T C.S. CAPPED STANDPIPE
 - C.O. CLEAN OUT
 - C.W. COLD WATER
 - ∇ D.C. DRAIN COCK
 - F.I.L. FILTER
 - ∇ H.B. HOSE BIBB
 - LAV. LAVATORY
 - M.S.O. SHUT-OFF VALVE
 - ⊕ TEMP. & PRESS. RELIEF VALVE
 - V.T.R. VENT THROUGH ROOF
 - W.C. WATER CLOSET
 - H.W. HOT WATER

- NOTES:**
- NO FITTINGS OR JOINTS BELOW SLAB.
 - ALL LINES SLOPED TO DRAIN COCKS & CAPPED STANDPIPES.
 - WRAP COLD WATER LINES AGAINST CONDENSATION.

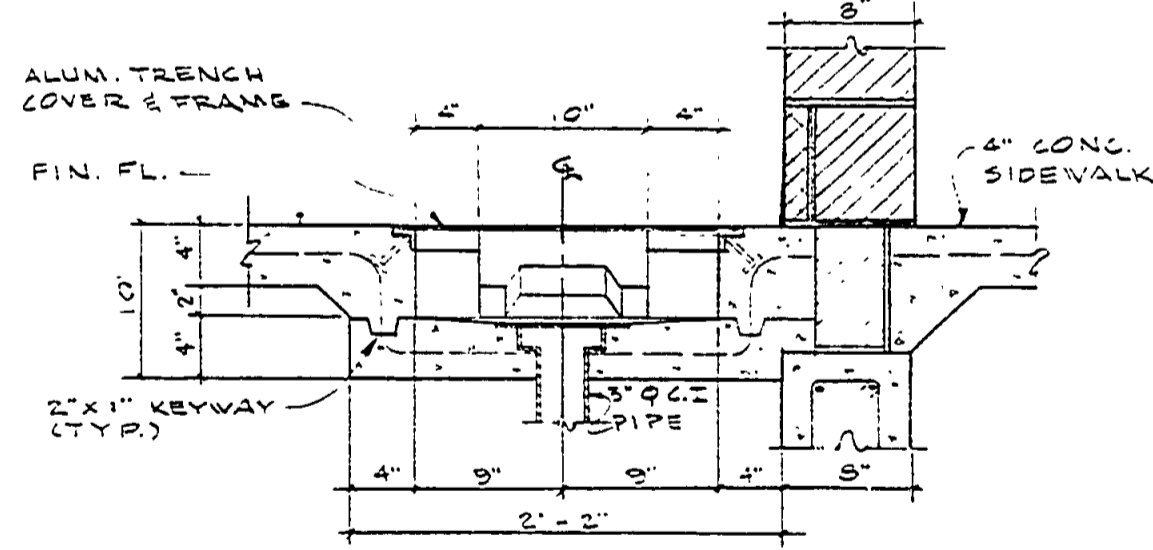

WASTE PLUMBING PLAN
1/4" = 1'-0"

WATER RISER DIAGRAM
N.T.S.

SUPPLY PLUMBING PLAN

DETAIL 32
S.C. 1/2" = 1'-0"

DETAIL 33
S.C. 1/2" = 1'-0"

SURVEYED BY	DRAWN BY S BAKUS	2/74	NO. DATE BY	REVISIONS	NO. DATE BY	REVISIONS	MICHIGAN DEPARTMENT OF NATURAL RESOURCES	MECHANICAL: WASTE PLUMBING WATER SUPPLY PLUMBING	AREA OR PARK VAN RIPER STATE PARK	PROJECT NO. 24-1224
DESIGNED BY	CHECKED BY		1.		3.				PROJECT BEACHHOUSE	SHEET 5 OF 7
DATE	DATE	DATE	2.		4.					PLAN NO. A-105