
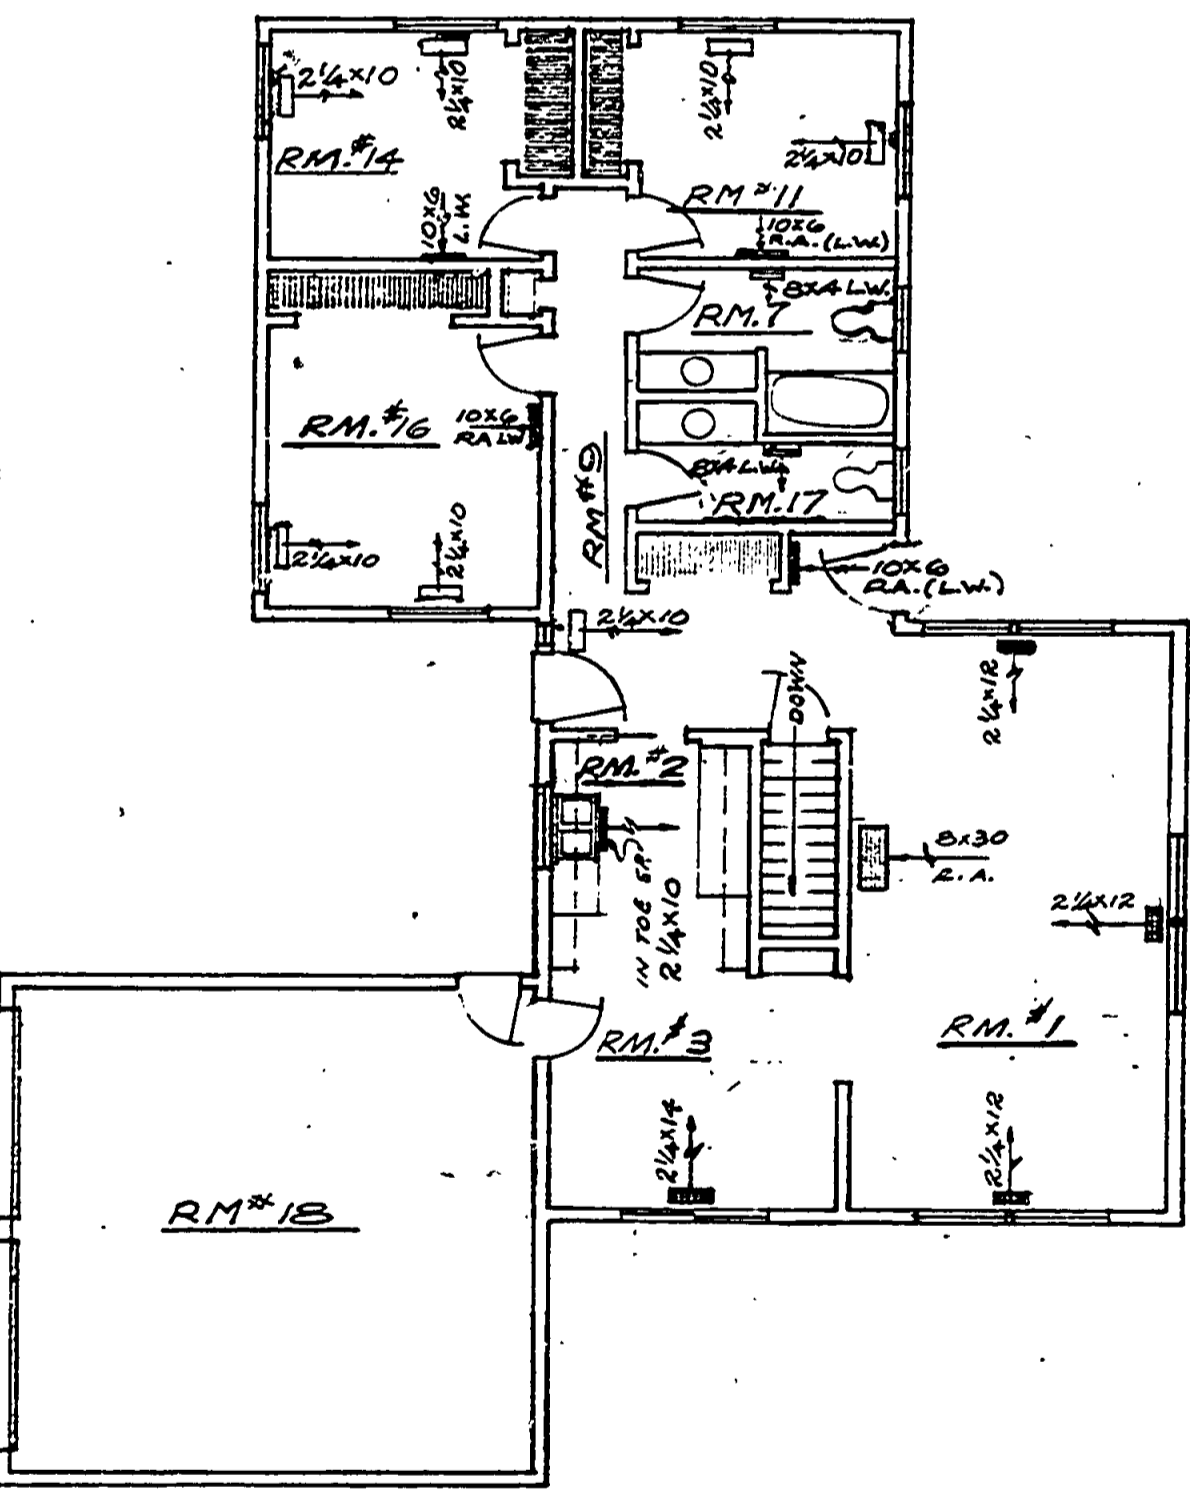
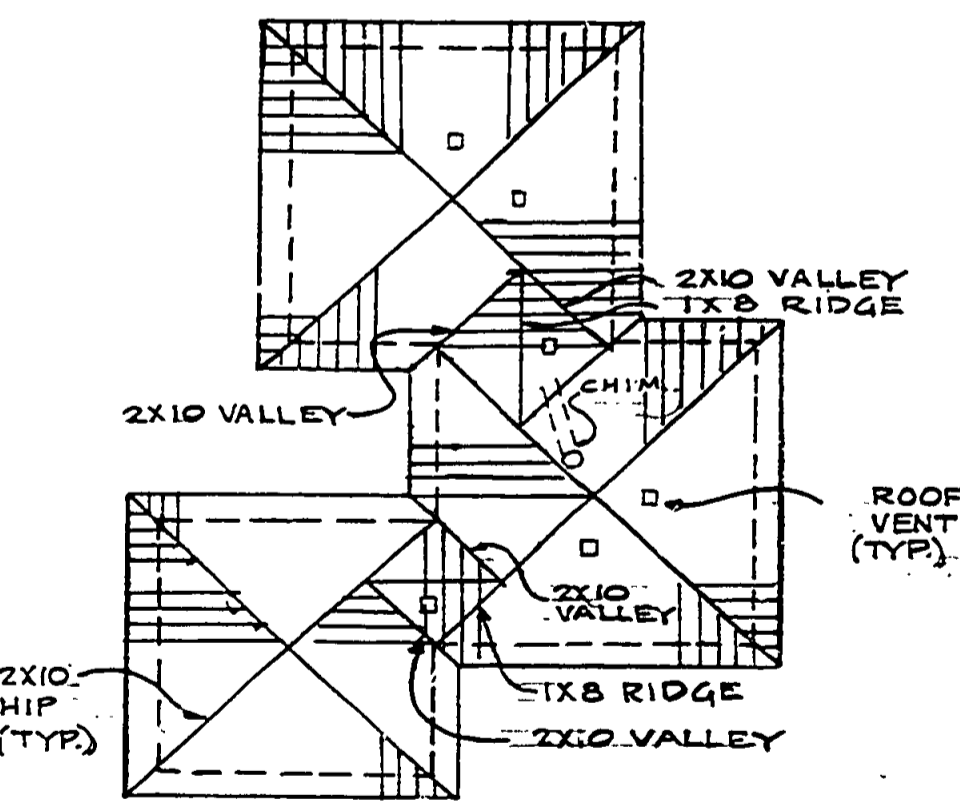
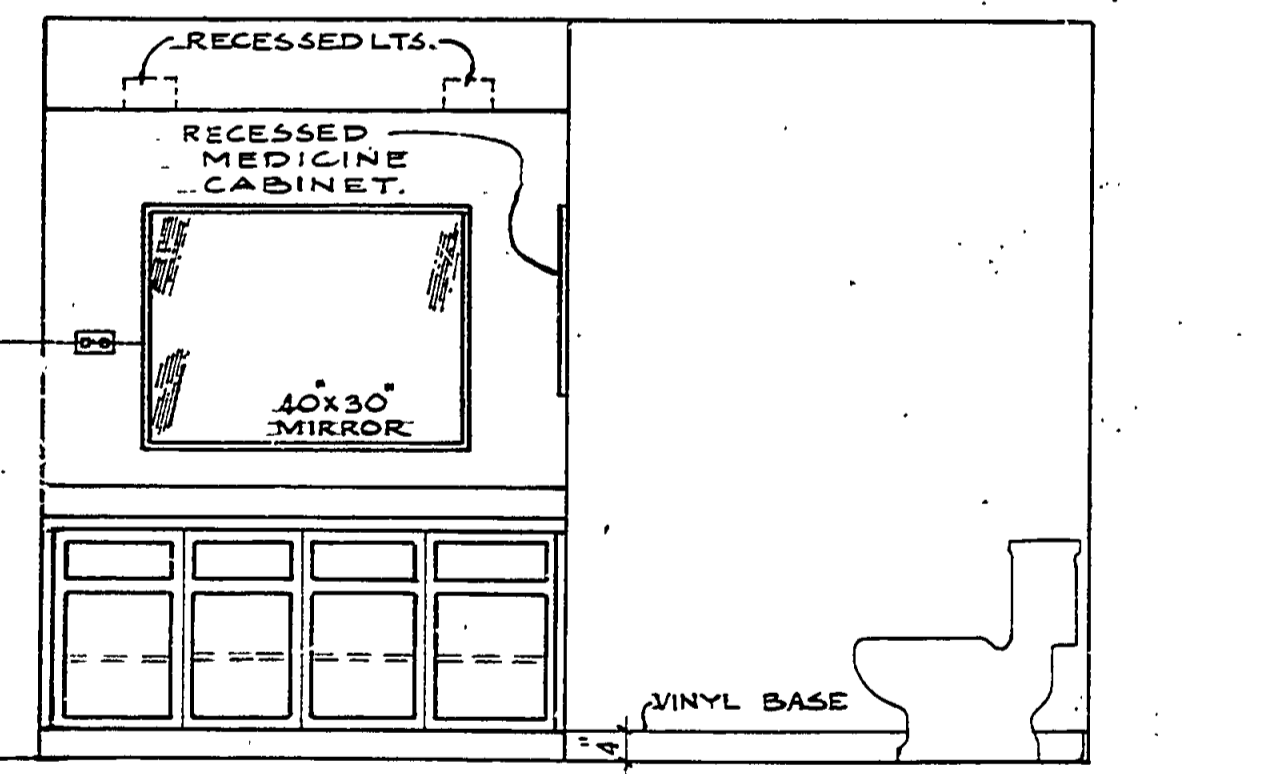
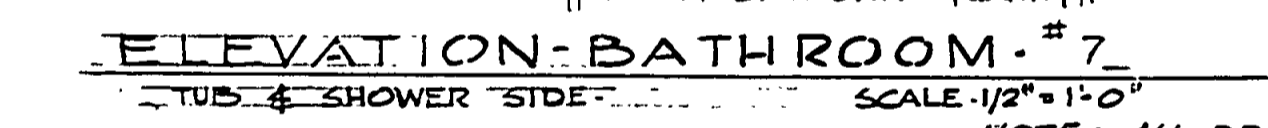
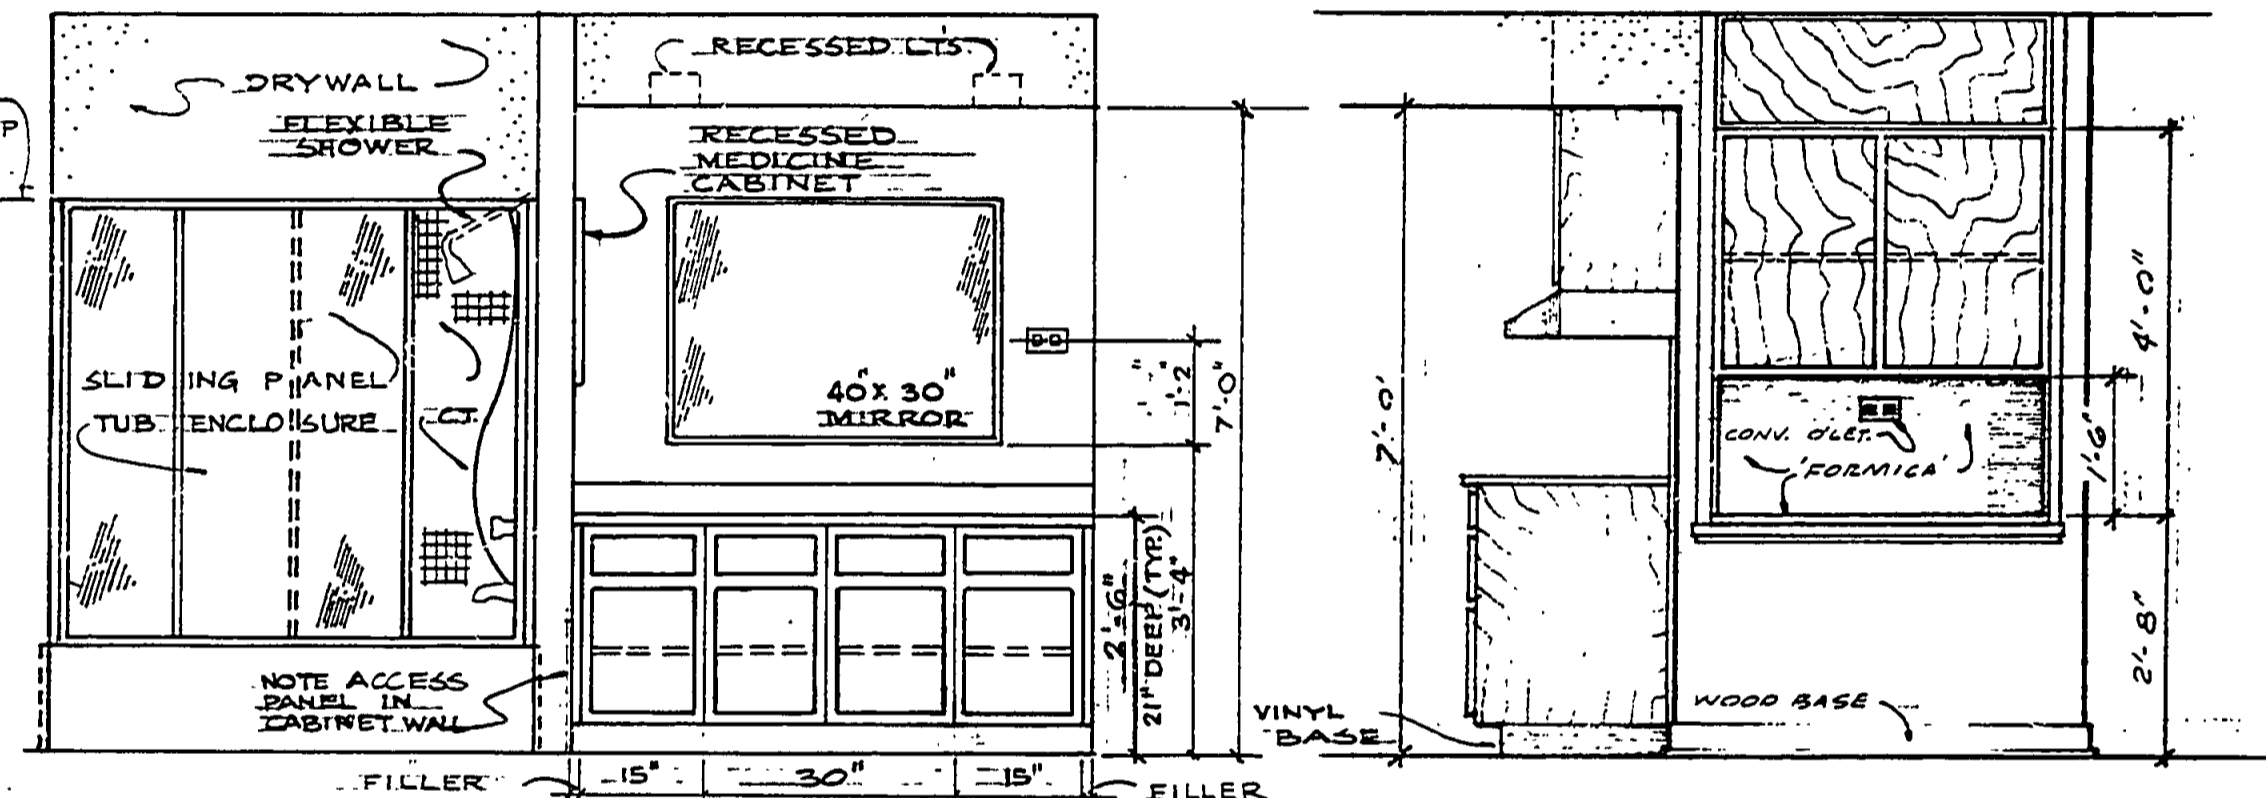
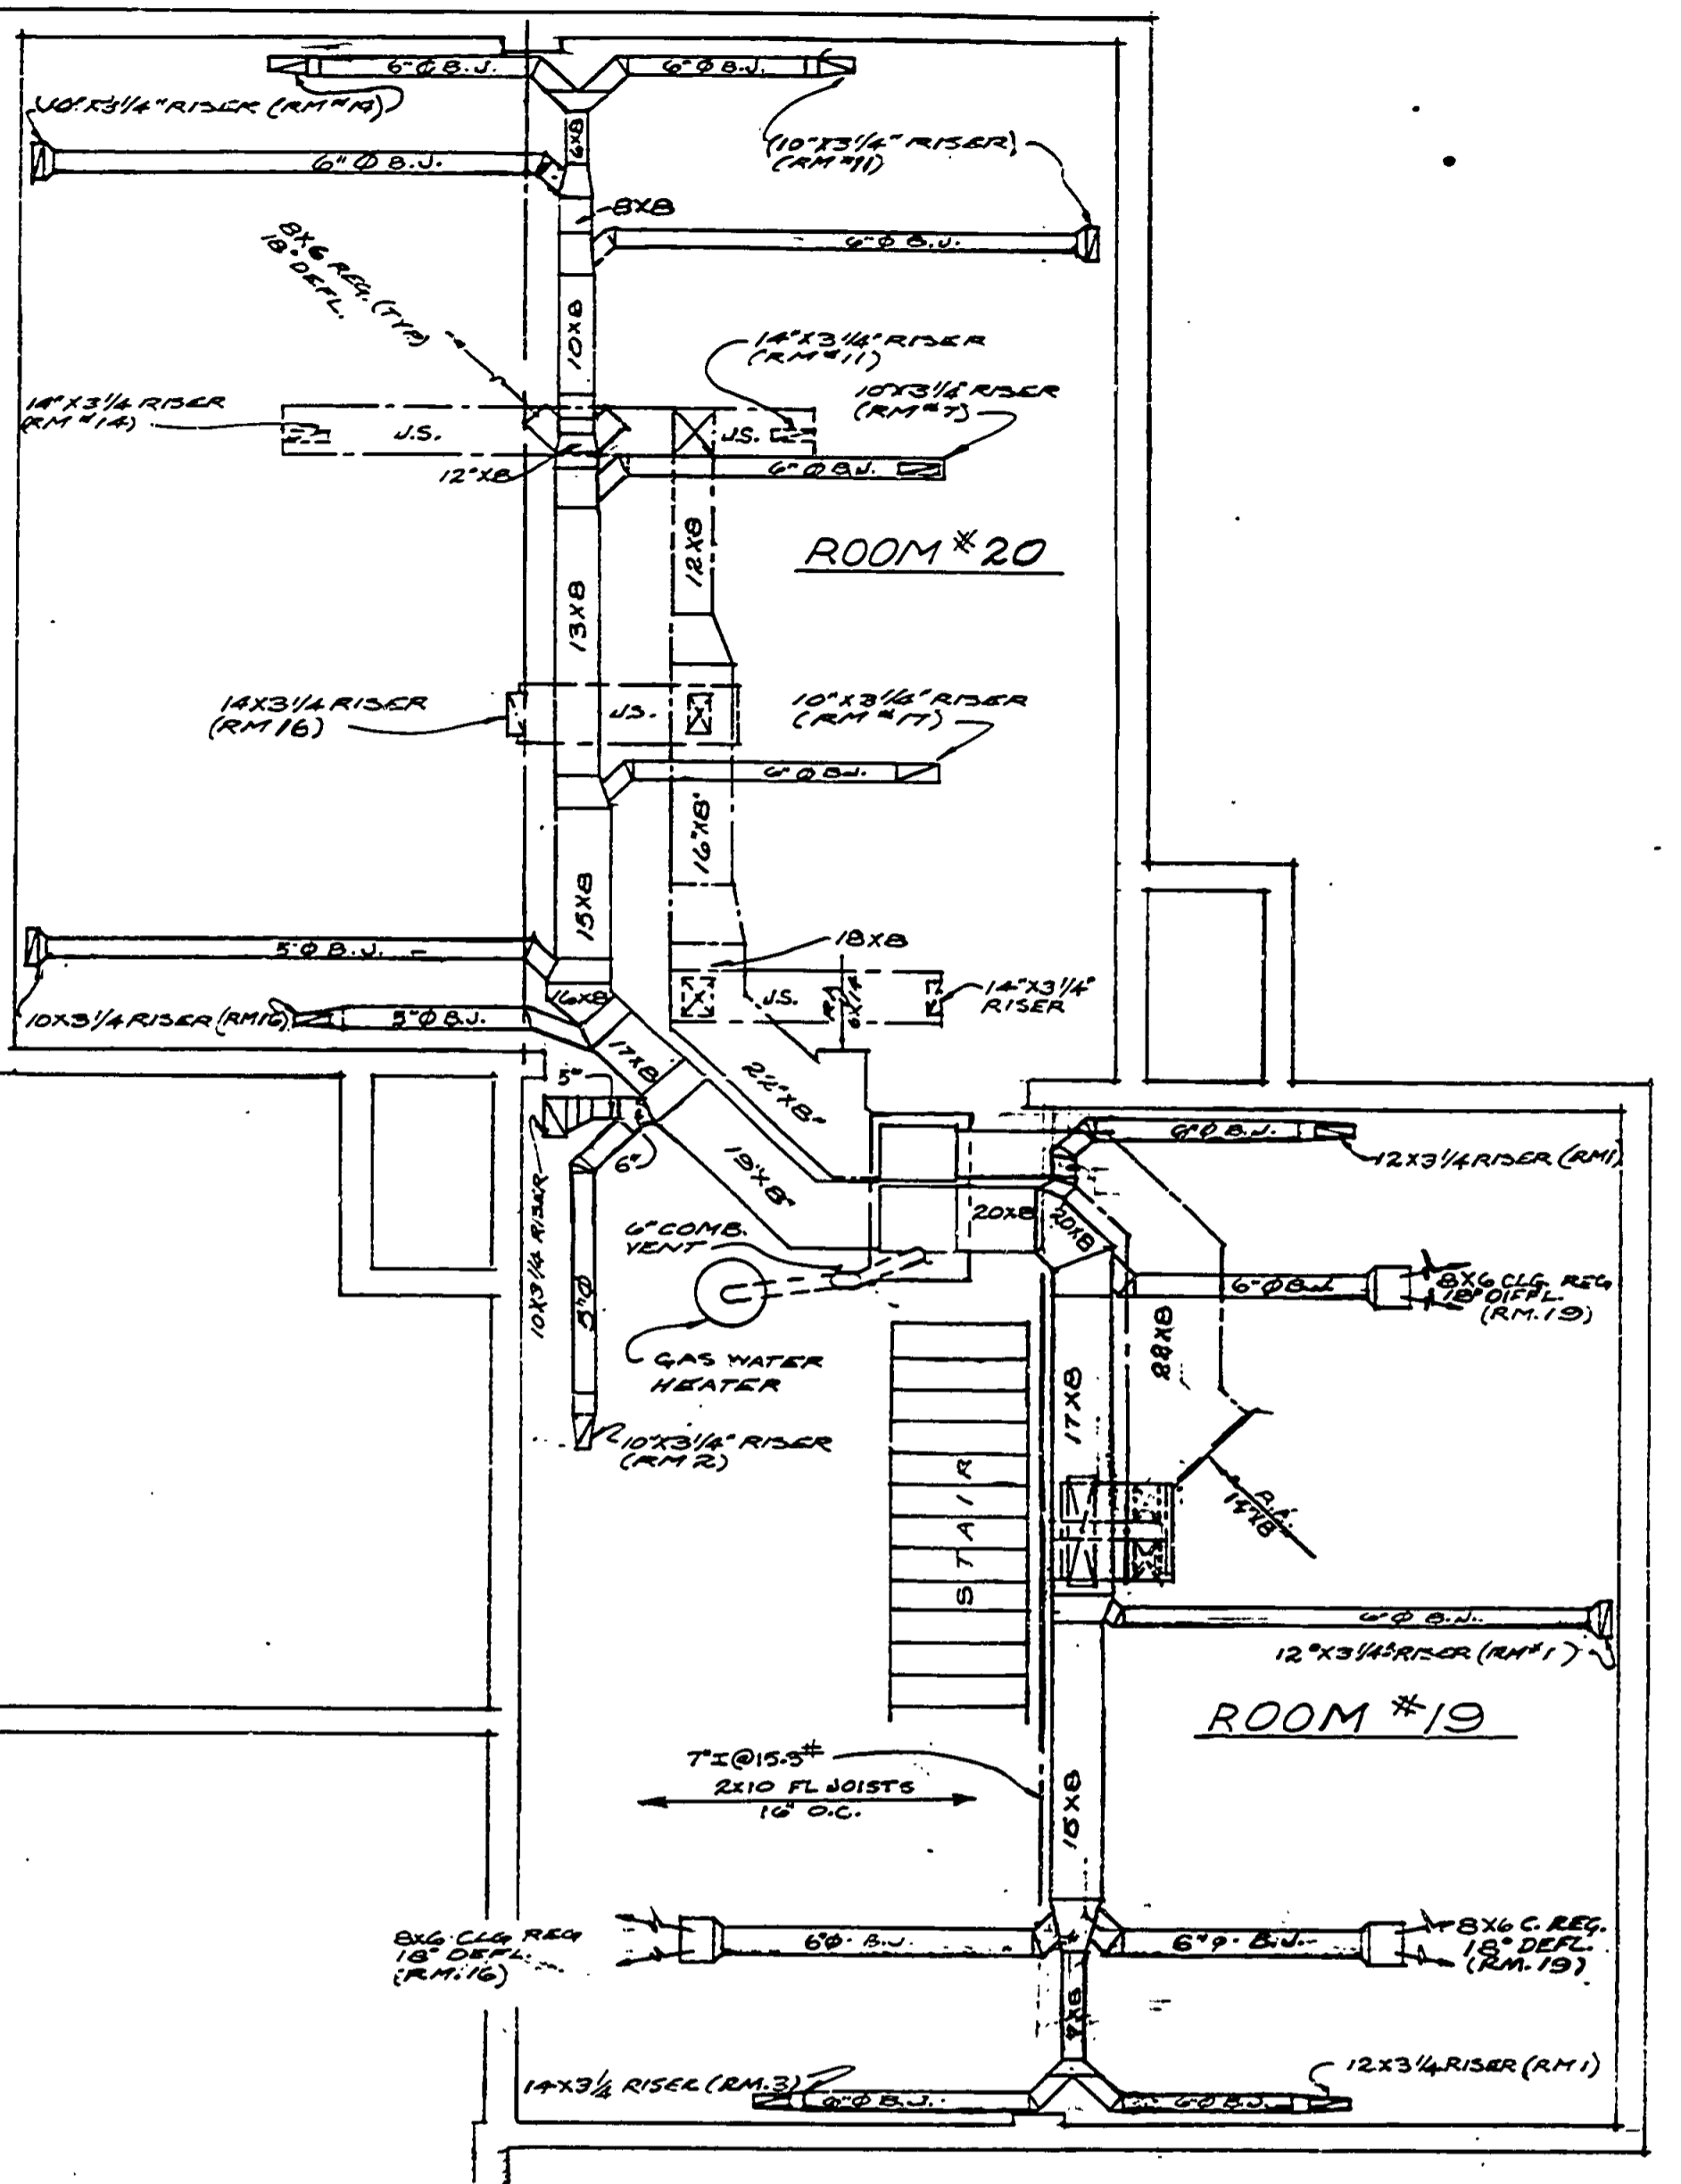
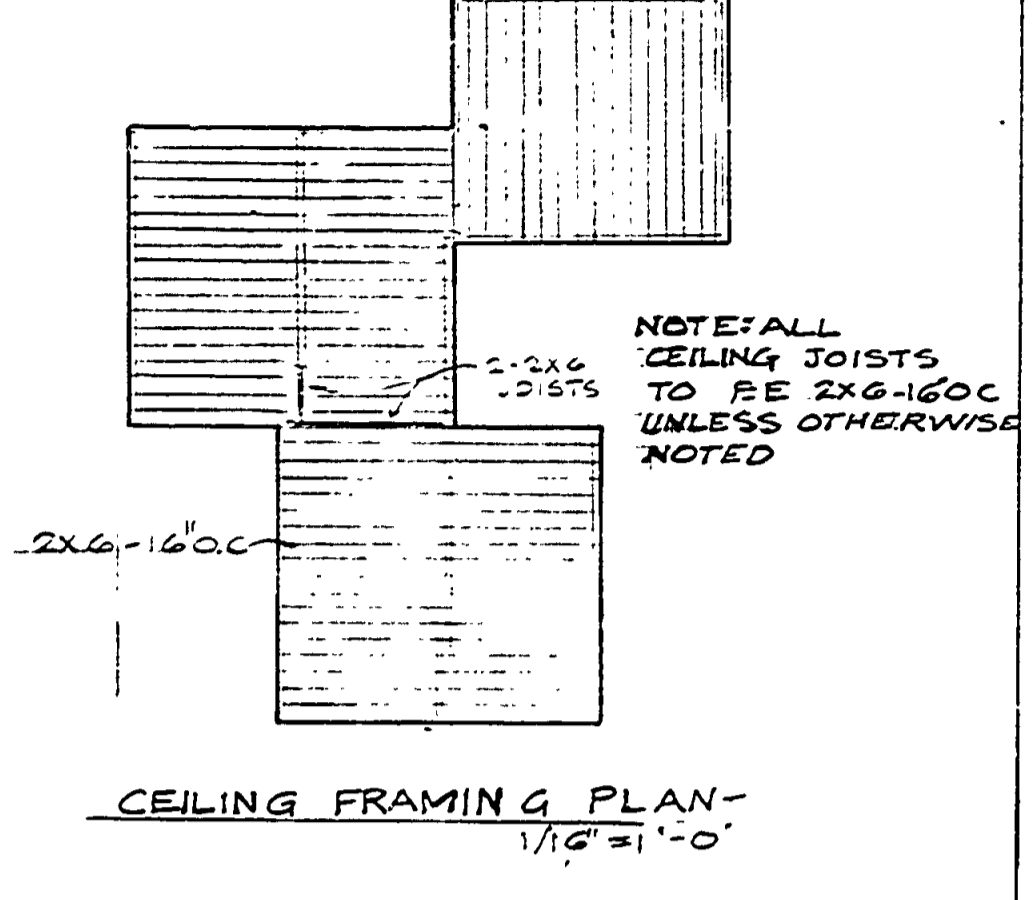


DESIGNED BY	DATE	REVIEWED	DATE	APPROVED	DATE	NO.	DATE	BY	REVISIONS	DATE	BY
DRAWN BY		ARCHITECTURAL				1			4		
CHECKED BY		ENGINEERING				2			5		
		LANDSCAPE				3			6		

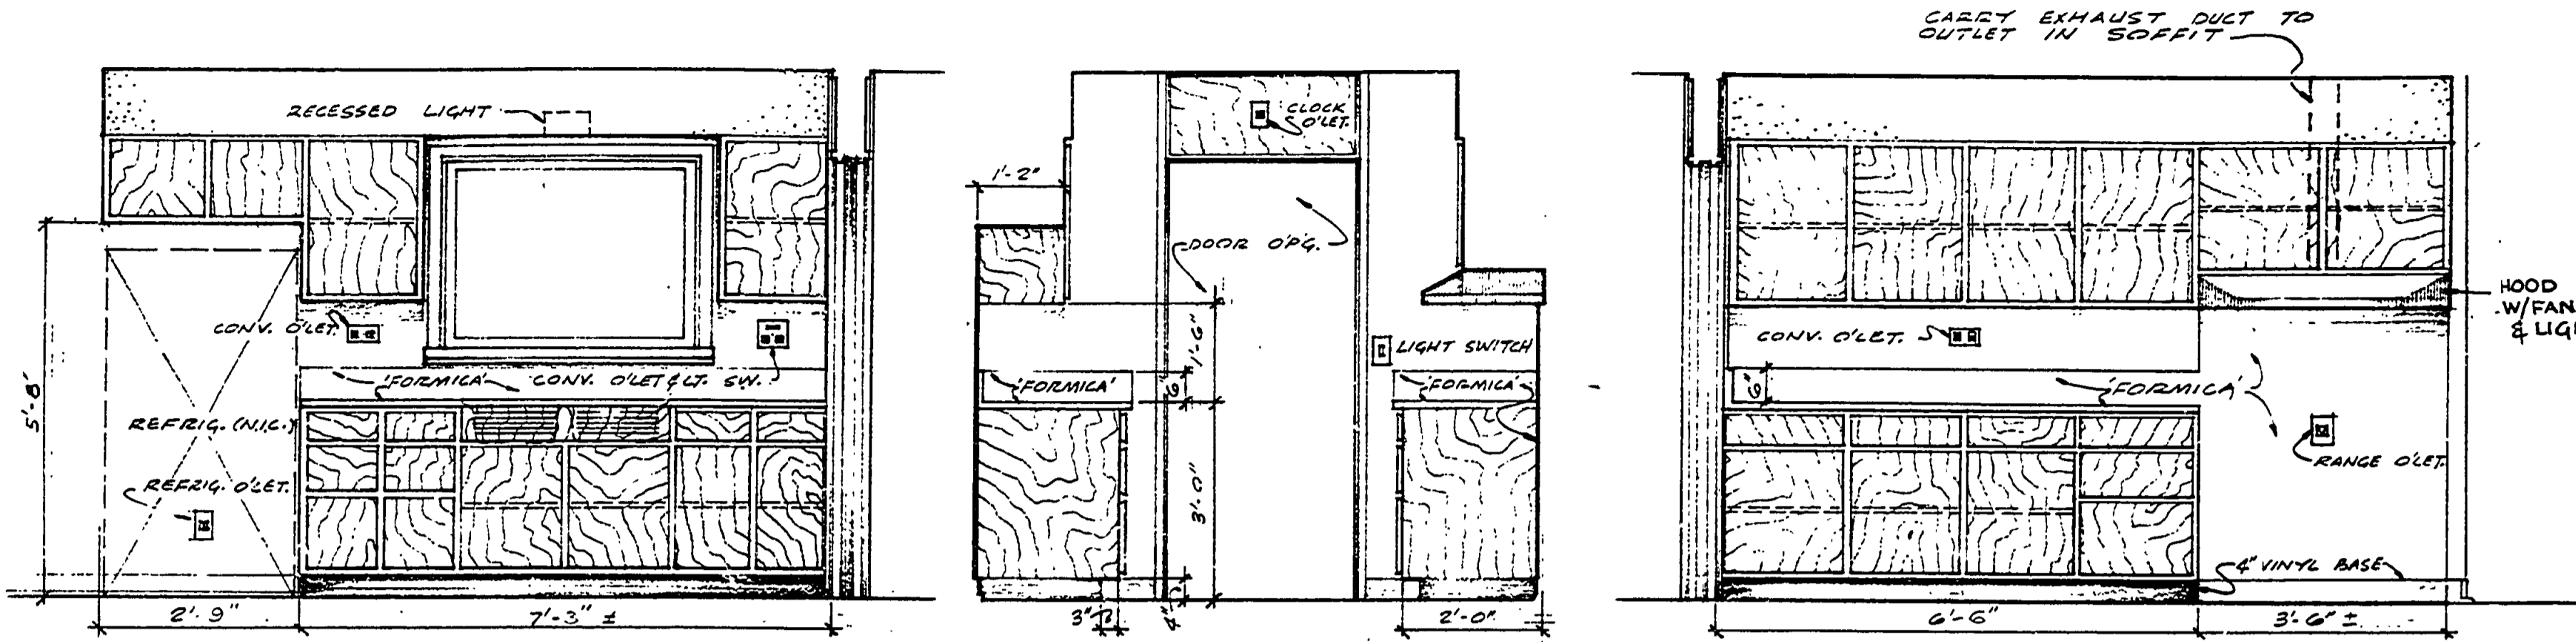

HEATING PLAN - BASEMENT
SCALE: 1/8" = 1'-0"

SYMBOLS & ABBREVIATIONS

WARM AIR RISER	---
DUCT	---
REGISTER	---
FLOOR REGISTER	---
L.W. - LOW WALL	---
CLG. - CEILING	---
RETURN AIR RISER	---
DUCT	---
INTAKE	---
DUCT CONNECTION BELOW JOIST	---
R.A. - RETURN AIR	---
L.W. - LOW WALL	---

B.W. - DUCT BETWEEN JOISTS
U.S. - JOIST SPACE USED AS RETURN DUCT

NOTE: ALL RAFTERS - 2x8-16'0.C. UNLESS OTHERWISE NOTED

PROJECT NO. 24-1123

MICHIGAN DEPARTMENT OF CONSERVATION PARKS AND RECREATION DIVISION

MUSKALLONGE LAKE S.P. MANAGERS RESIDENCE R.H.

SHEET NO. 5 OF 8

PLAN NO. 2-101