



DESIGNED BY	DATE	REVIEWED	DATE	APPROVED	DATE	NO.	DATE	BY	REVISIONS
ARCHITECTURAL	10-44	ARCHITECTURAL	11-10-51		1	1	10-44	BY	4
ENGINEERING		ENGINEERING			2	2		BY	5
LANDSCAPE		LANDSCAPE			3	3		BY	6

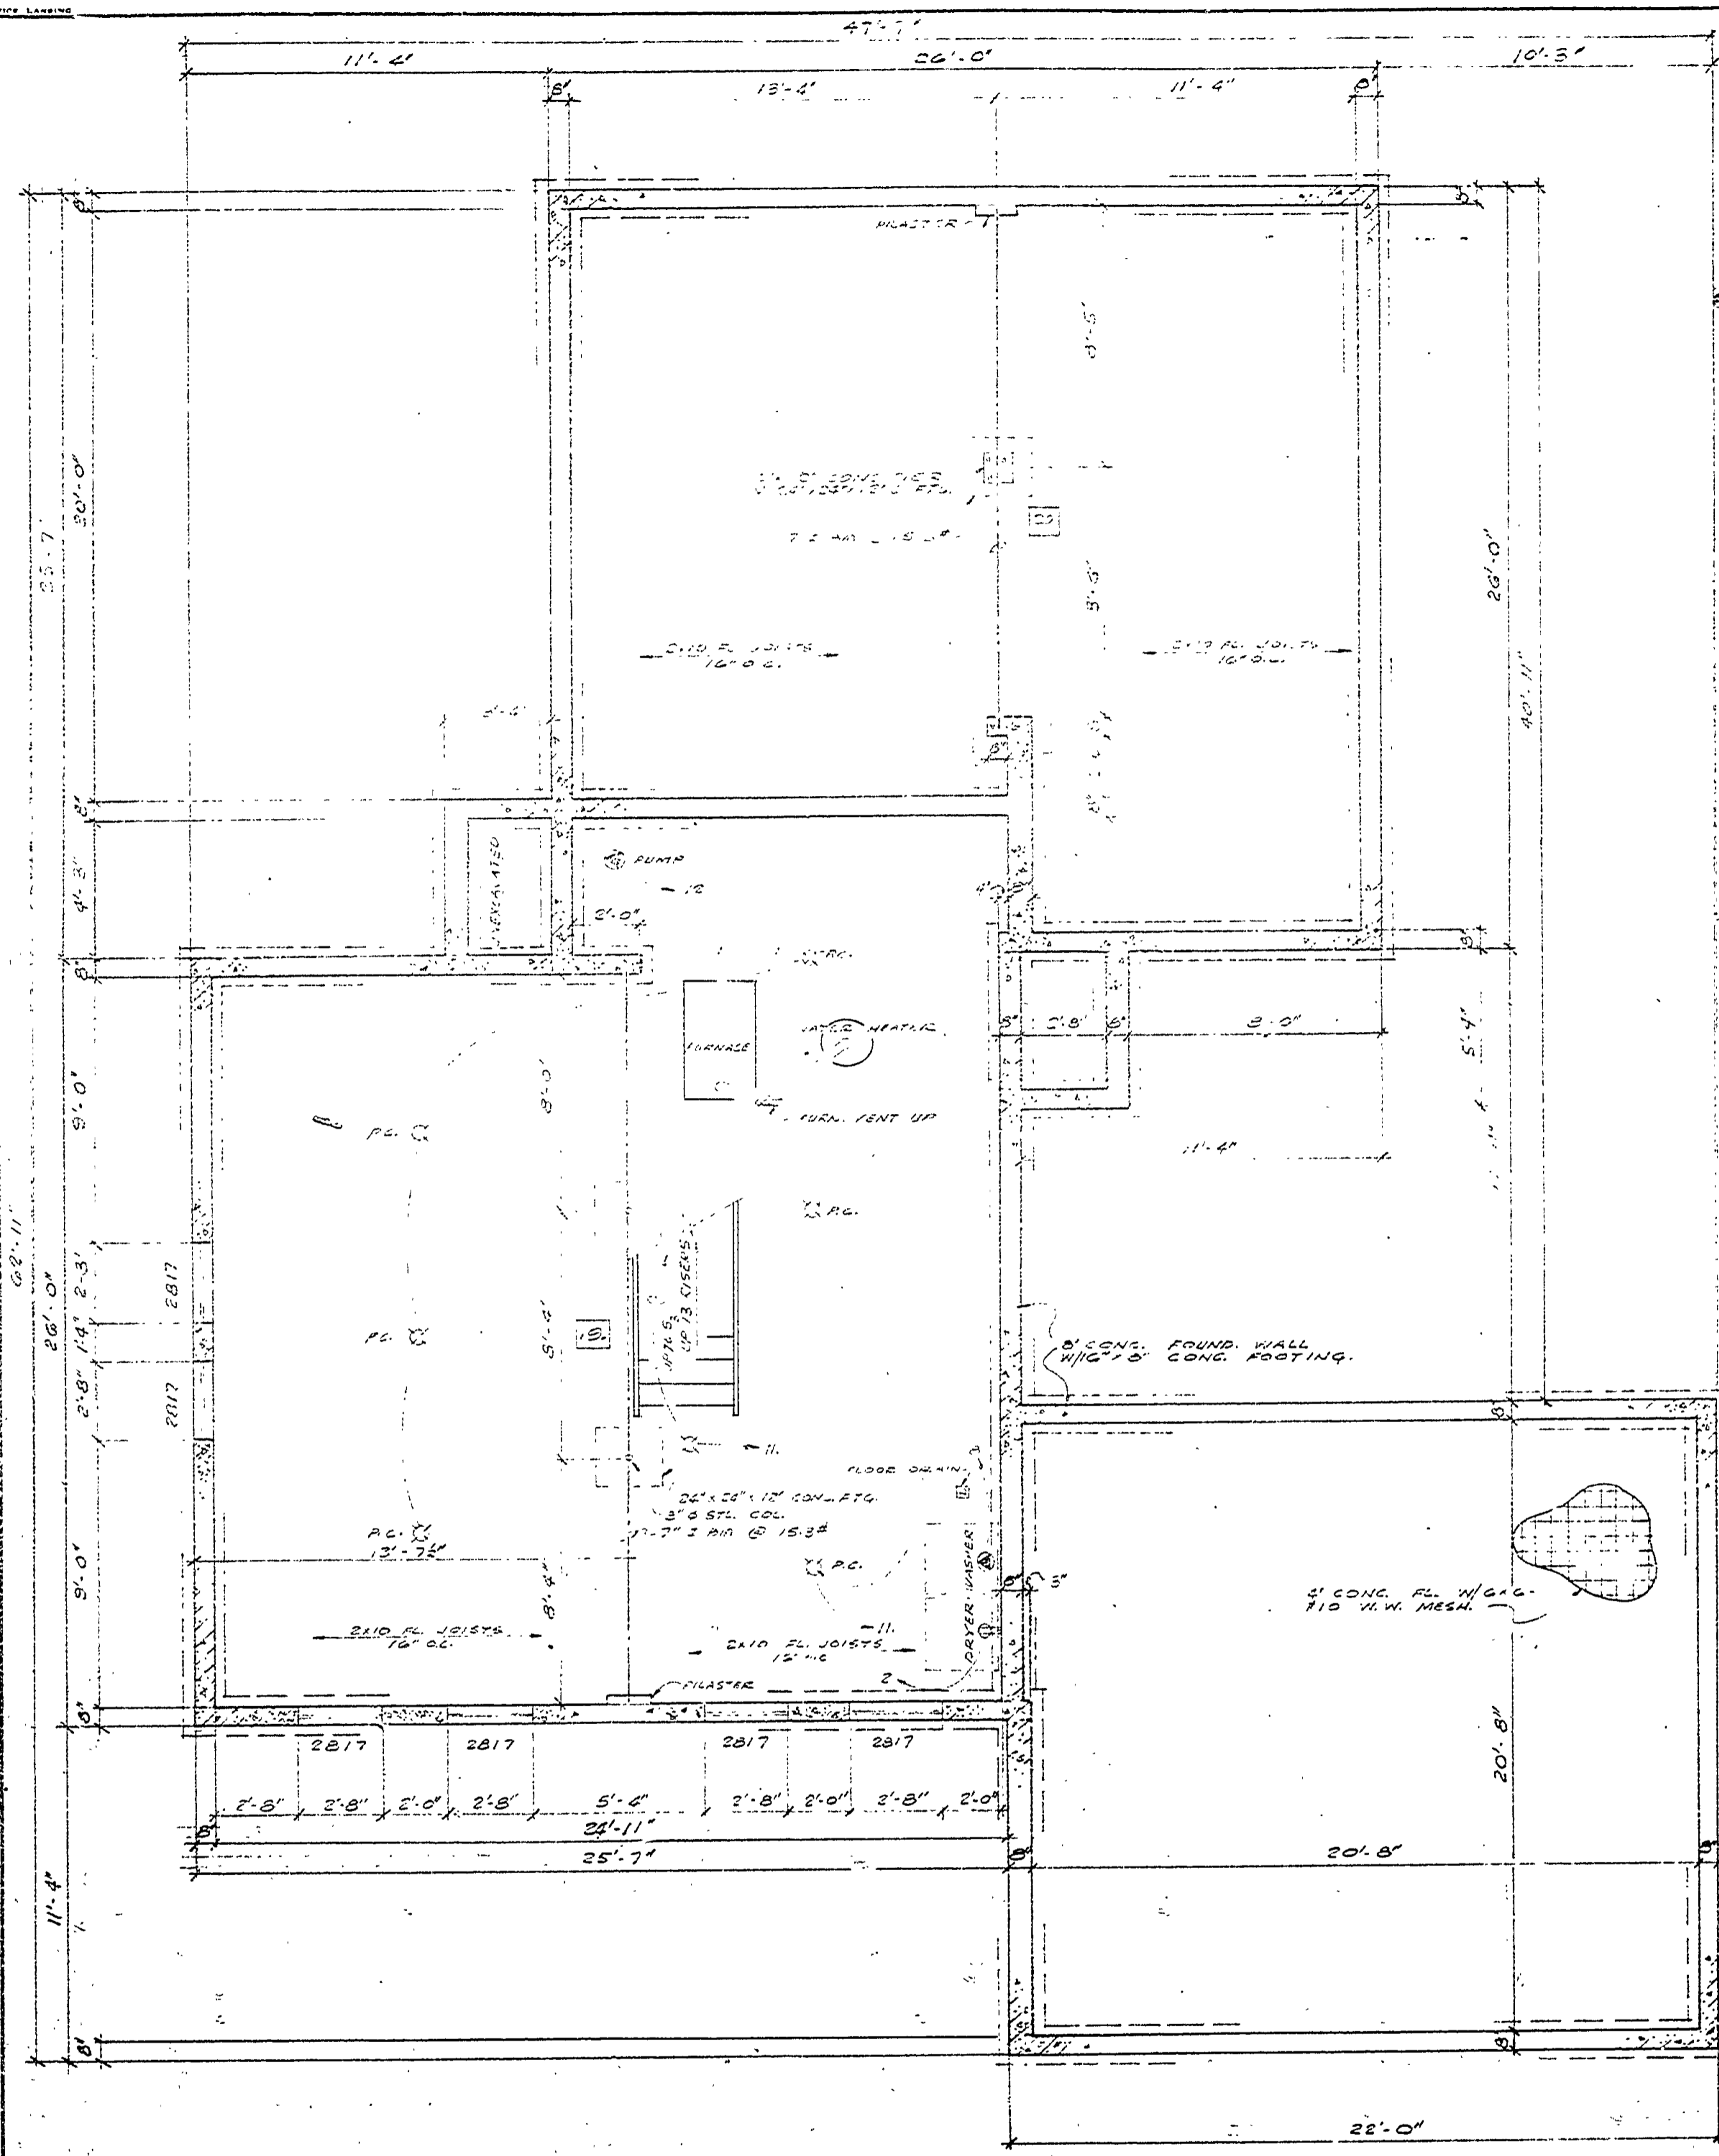


FOUNDATION PLAN
SCALE: 1/4" = 1'-0"

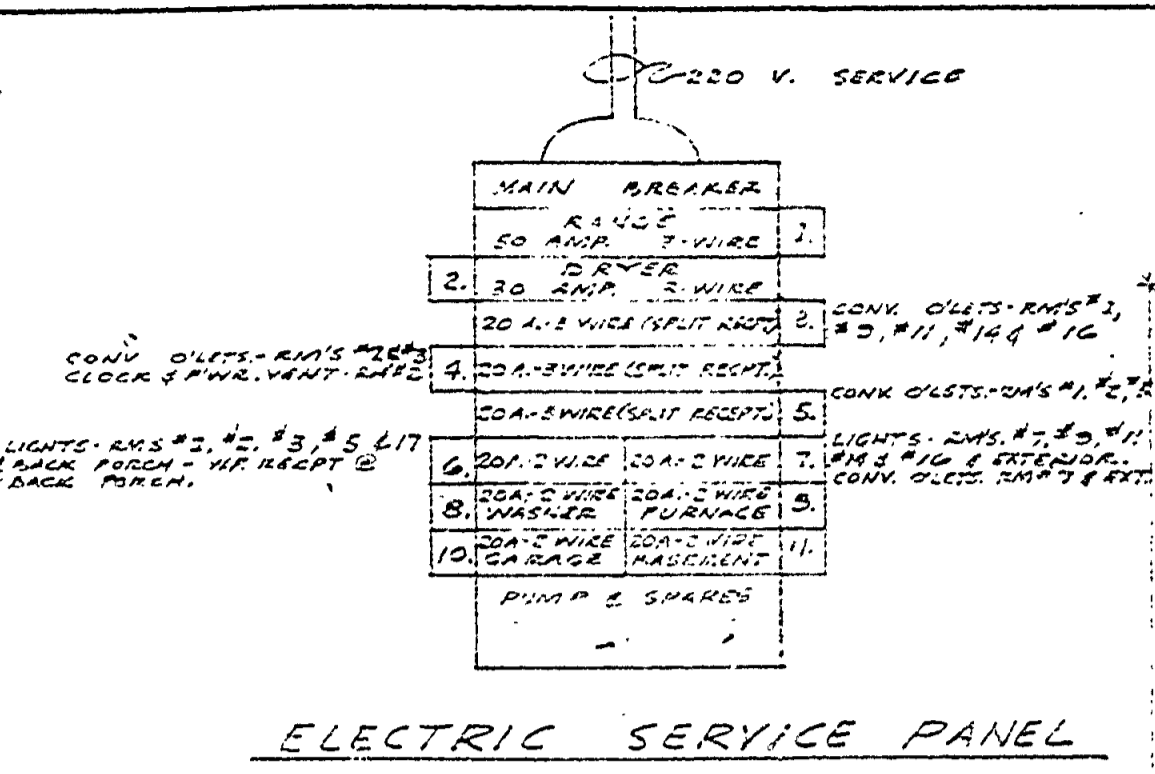


ELECTRIC SERVICE PANEL

ROOM FINISH SCHEDULE					
ROOM NUMBER	FLOOR	BASE	WALL	CEIL. TRIM	REMARKS
1 LIVING RM.					
2 KITCHEN					
3 DINING RM.					
4 BREAKING CAB.					
5 BATH					
6 BATH CLOS.					
7 BATH RM.					
8 BATHEN CLOS.					
9 BATH CLOS.					
10 BATH RM.					
11 BATH CLOS.					
12 BATH RM.					
13 GARAGE					
14 BATH STAIR					
15 BASEMENT					
16 CRAWL SPACE					

DOOR SCHEDULE					
NUMBER	DESIGNATION	TYPE	WIDTH	HEIGHT	REMARKS
1A	13'	CA			
2A	13'	CA			
3C	13'	CA			
4B	13'	CA			
5B	13'	CA			
6B	13'	CA			
7B	13'	CA			
8B	13'	CA			
9B	13'	CA			
10B	13'	CA			
11D	13'	CA			
12D	13'	CA			
13D	13'	CA			
14D	13'	CA			
15N	3'	CA			
16*	3'	CA			
17E	13'	CA			
18A	13'	CA			
19A	13'	CA			
20A	13'	CA			
21A	13'	CA			

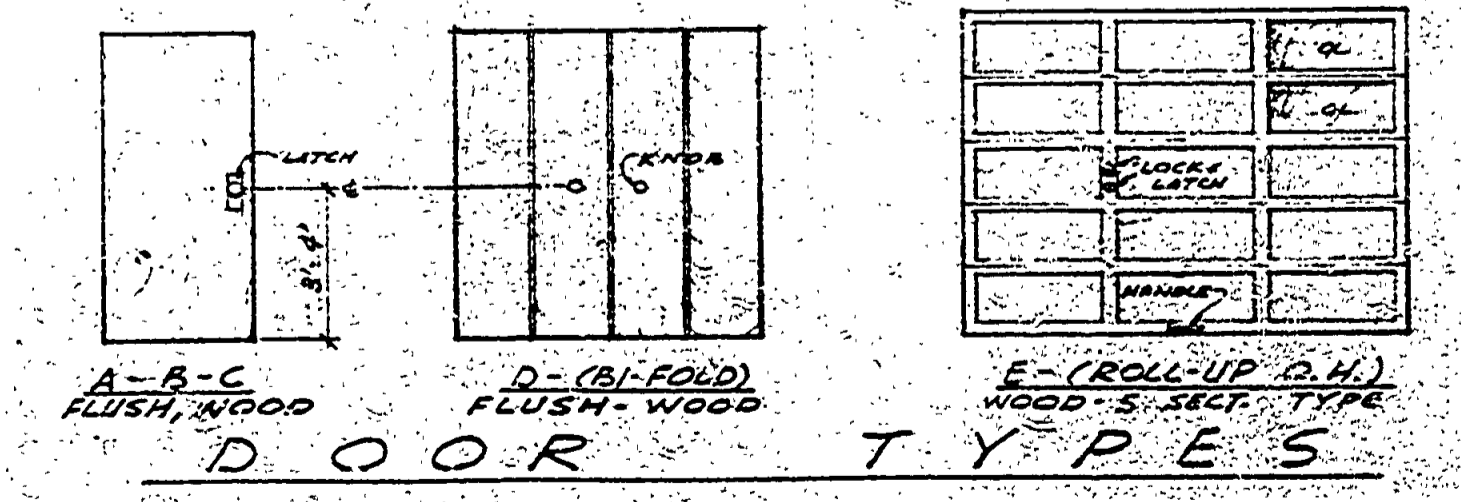

DOOR TYPES

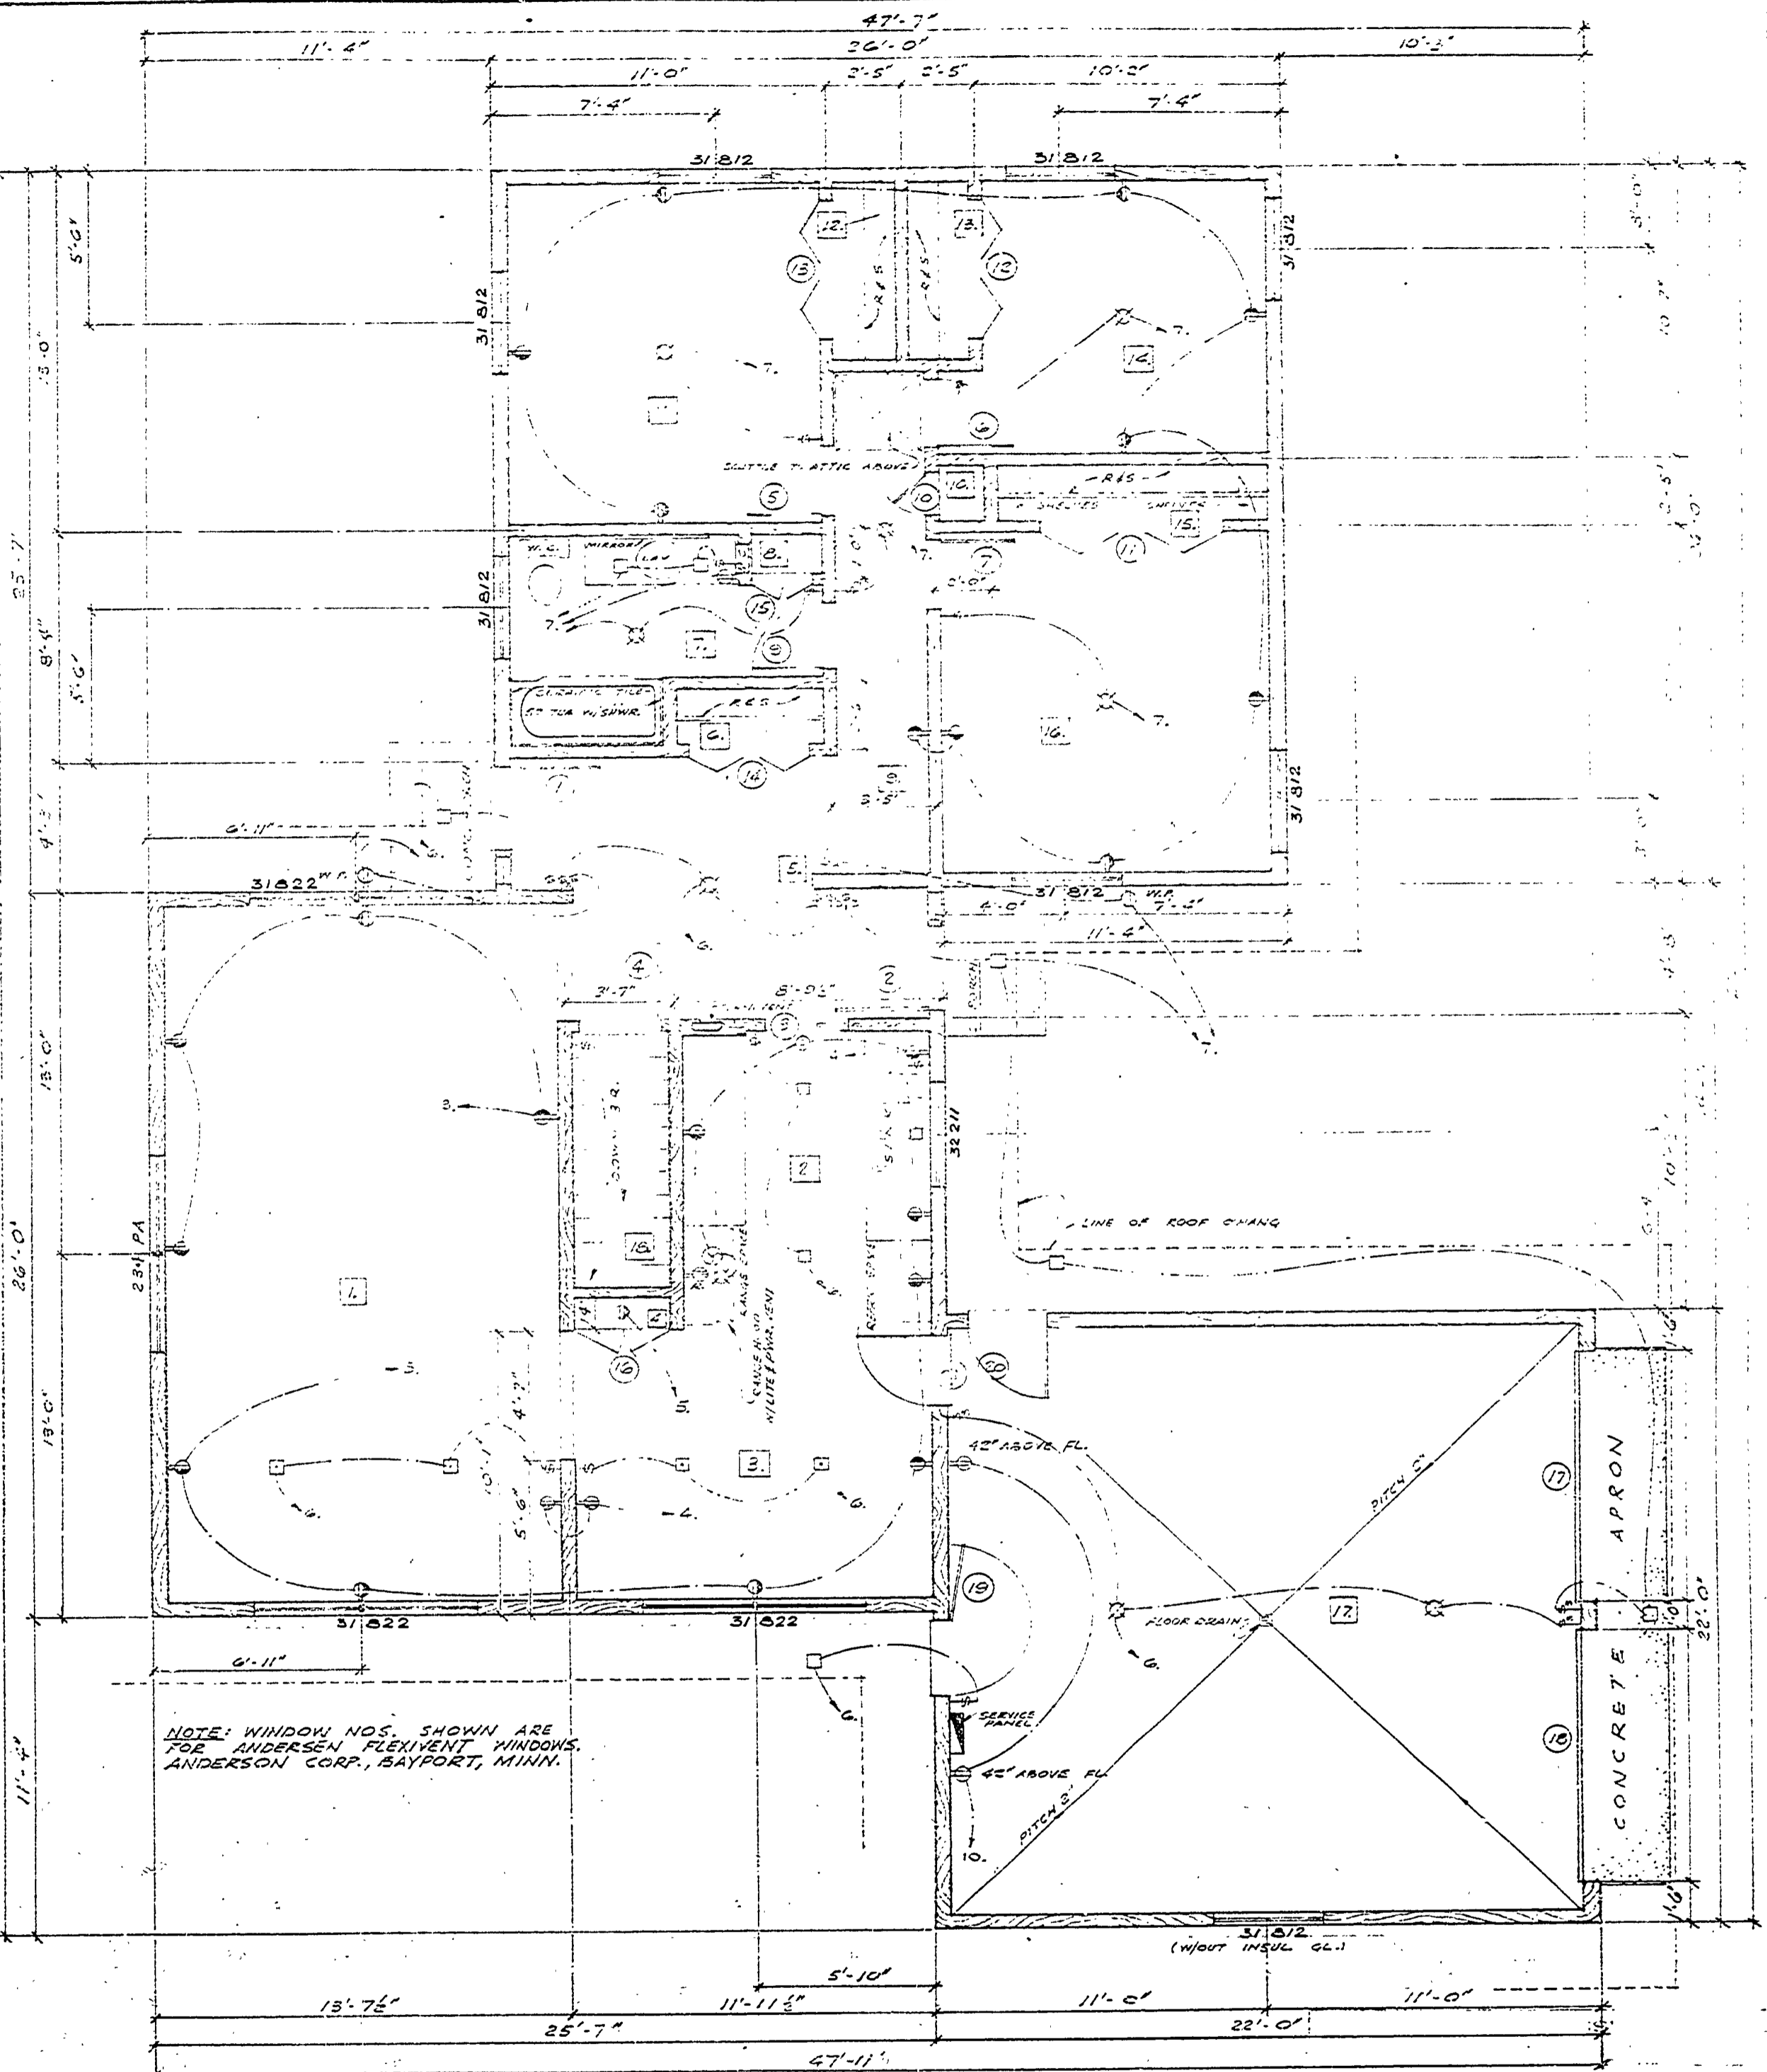

FLOOR PLAN
SCALE: 1/4" = 1'-0"

ELECTRICAL SYMBOLS	
CEILING FIXTURE (TRICESSED)	⊠
CEILING FIXTURE (RECTANG.)	⊞
CONVENIENCE OUTLET	⊕
CONV. OULET (SPLIT WIRE)	⊕
CONV. OULET (WEATHER/ROOF)	⊕
RANGE OULET	⊕
WASHER OULET	⊕
DRYER OULET	⊕
RUBBER OULET	⊕
CLOCK OULET	⊕
EXHAUST FAN	⊕
ELECT. SERVICE PANEL	⊕
PUMP OULET (IF REQ'D.)	⊕

MICHIGAN
DEPARTMENT OF CONSERVATION
PARKS AND RECREATION DIVISION

MUSKALONGE LAKE S.P.
MANAGERS RESIDENCE (L.H.)

SHEET NO. 6
OF 8
PLAN NO. A-101