




DESIGNED BY	DATE	REVIEWED	DATE	APPROVED	DATE	NO.	DATE	BY	REVISIONS
DRAWN BY	6/16/61	ARCHITECTURAL	6-11-61	<i>[Signature]</i>	6-14-61	1	6-14-61	<i>[Signature]</i>	4
CHECKED BY		ENGINEERING	6-21-61	<i>[Signature]</i>	6-21-61	2			5
		LANDSCAPE	6-19-61	<i>[Signature]</i>	6-22-61	3			6

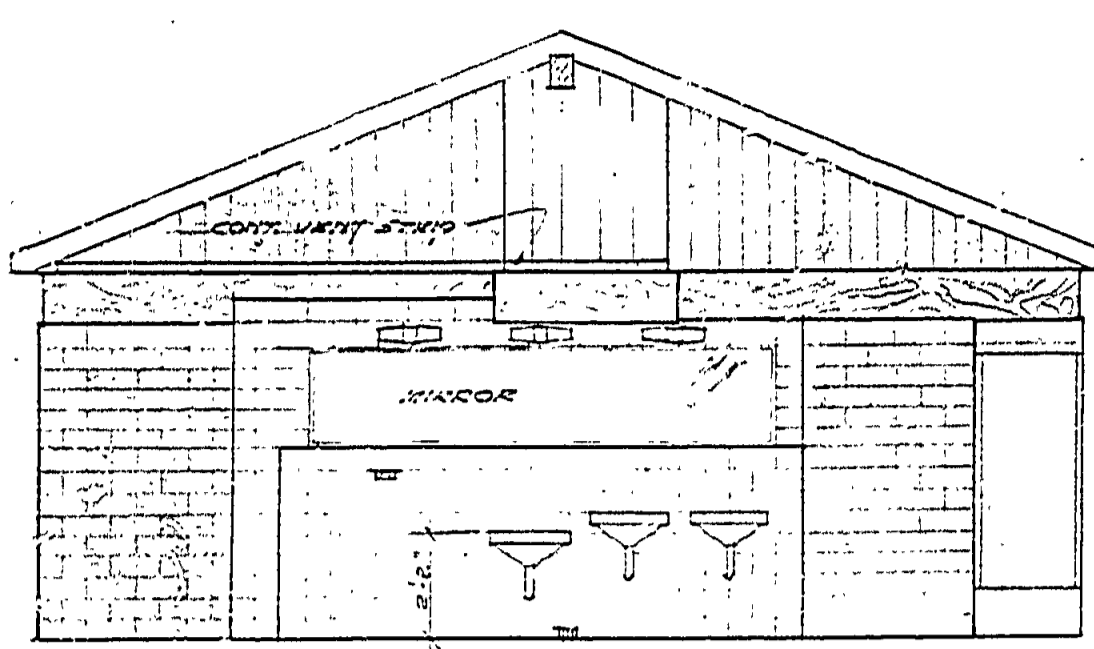


INT. ELEV. SOUTH WOMEN'S TOILET

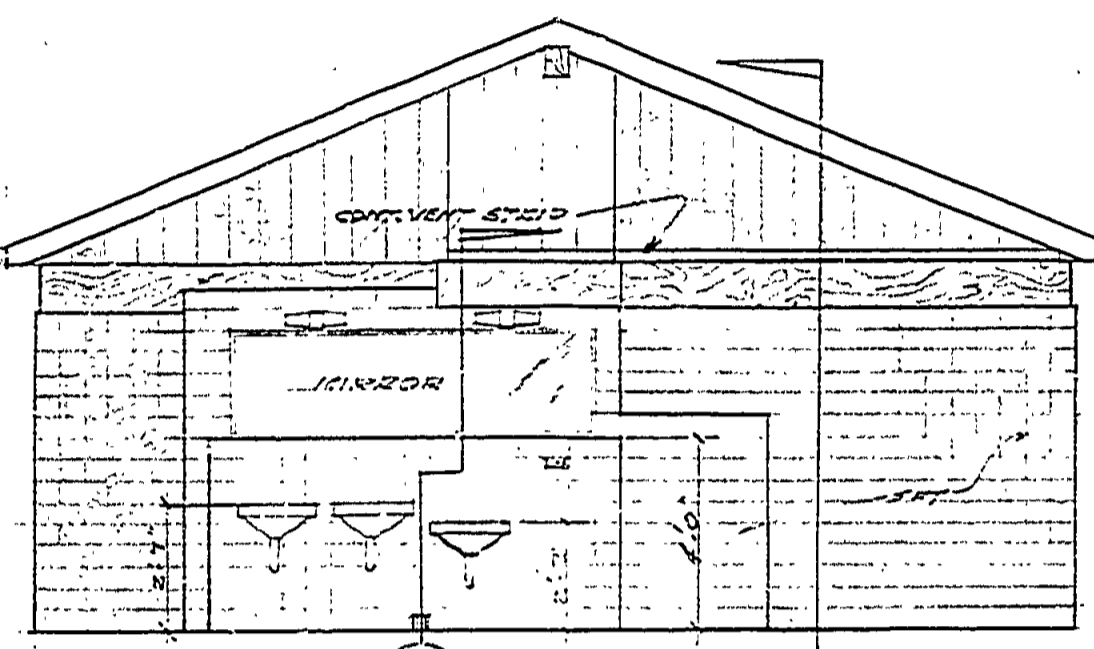


INT. ELEV. NORTH MEN'S TOILET  
SCALE 1/4"=1'-0"

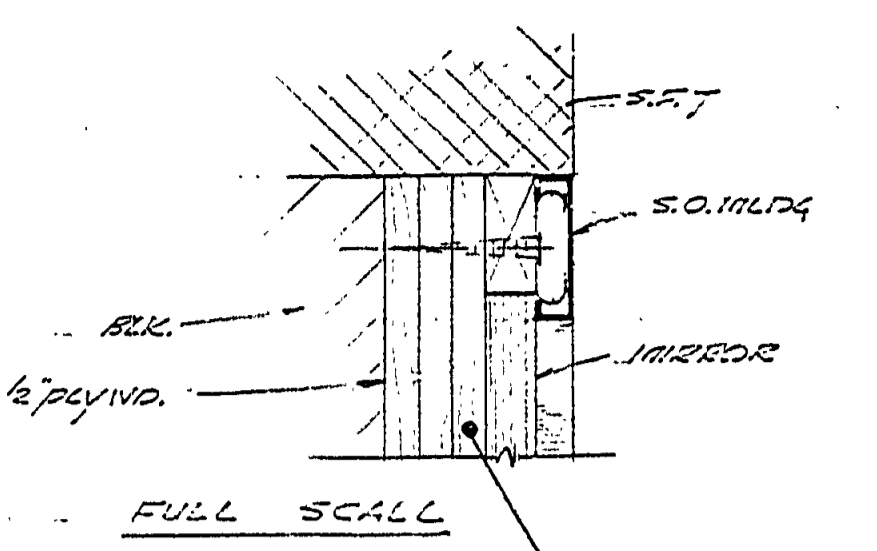


FULL SCALE

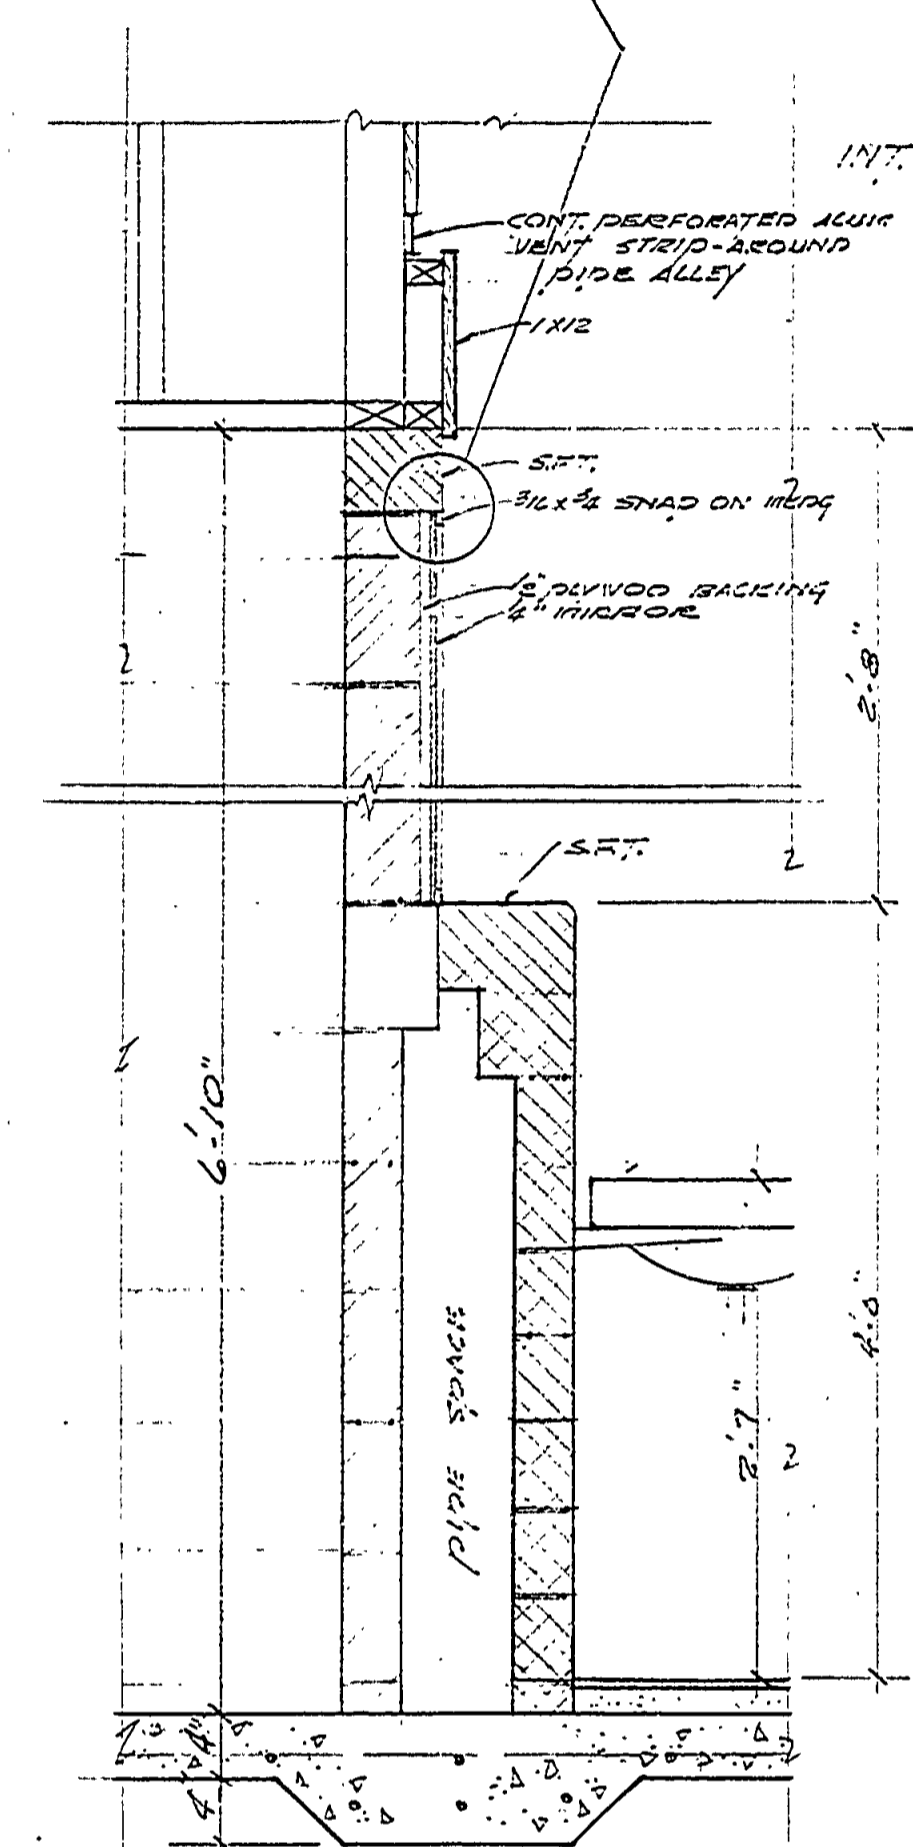


DET. 15  
2/4

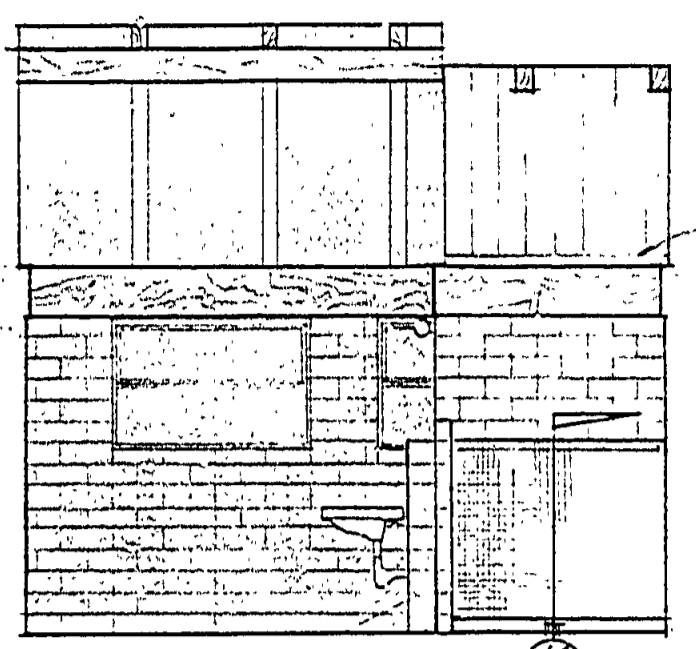


INT. ELEV. WEST MEN'S TOILET

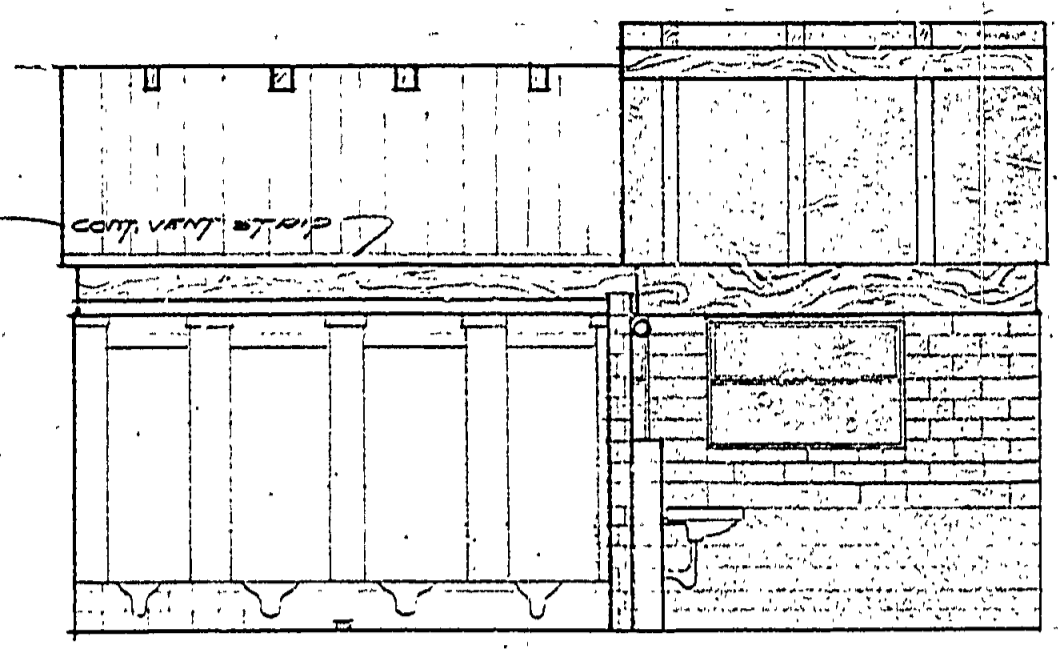


INT. ELEV. WEST WOMEN'S TOILET  
SCALE 1/4"=1'-0"

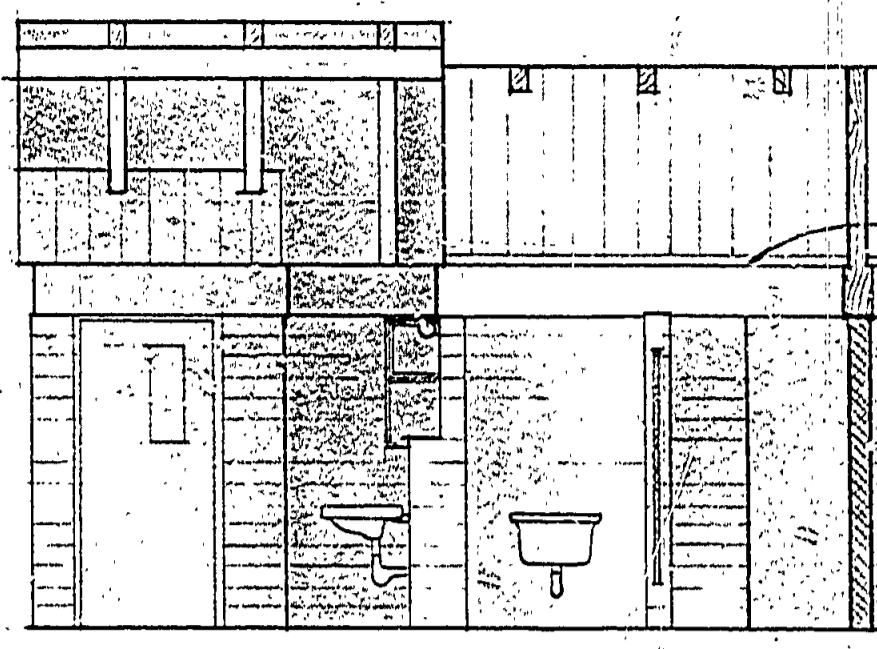


INT. ELEV. EAST WOMEN'S TOILET

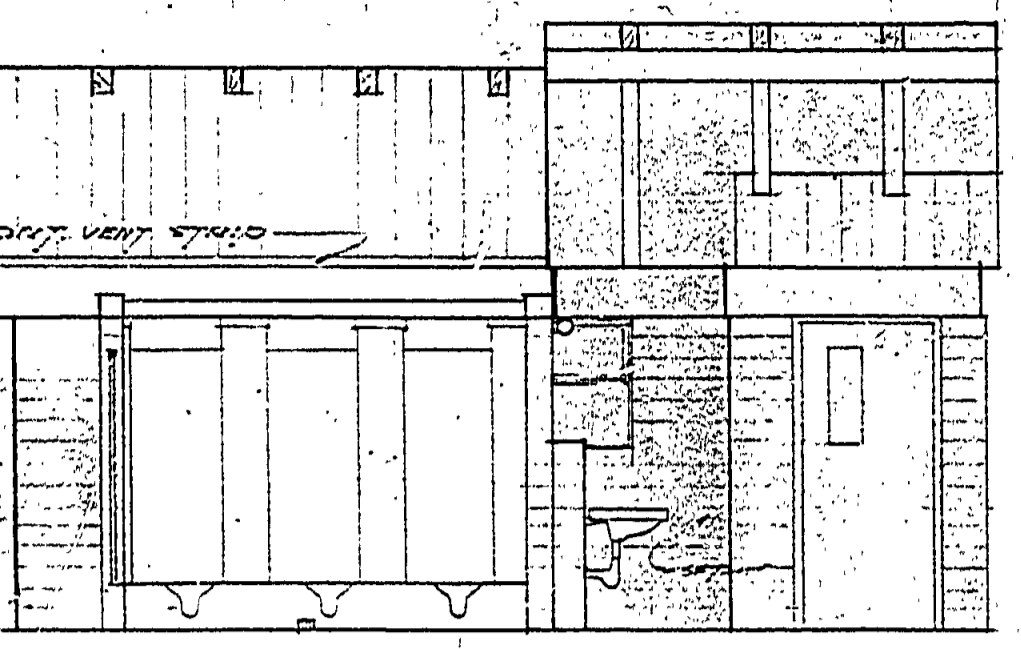


INT. ELEV. EAST MEN'S TOILET

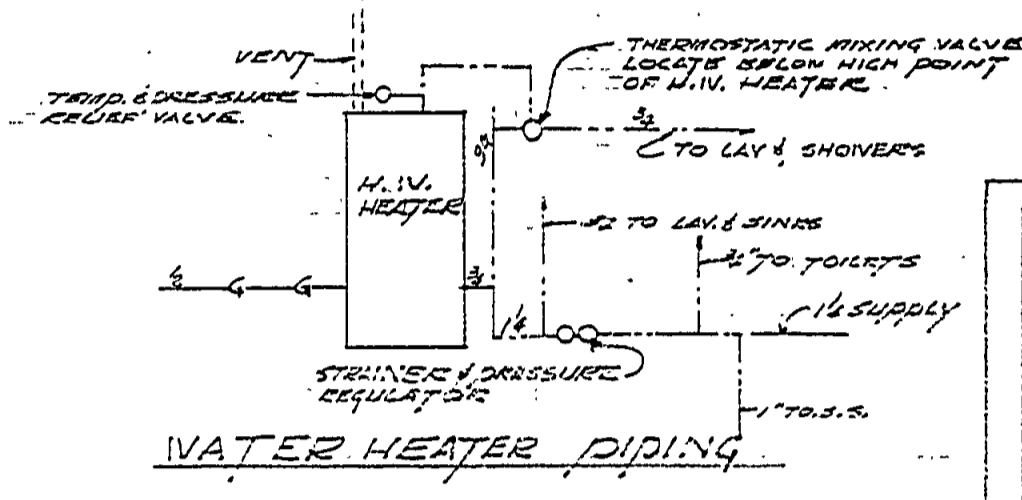


WATER HEATER PIPING

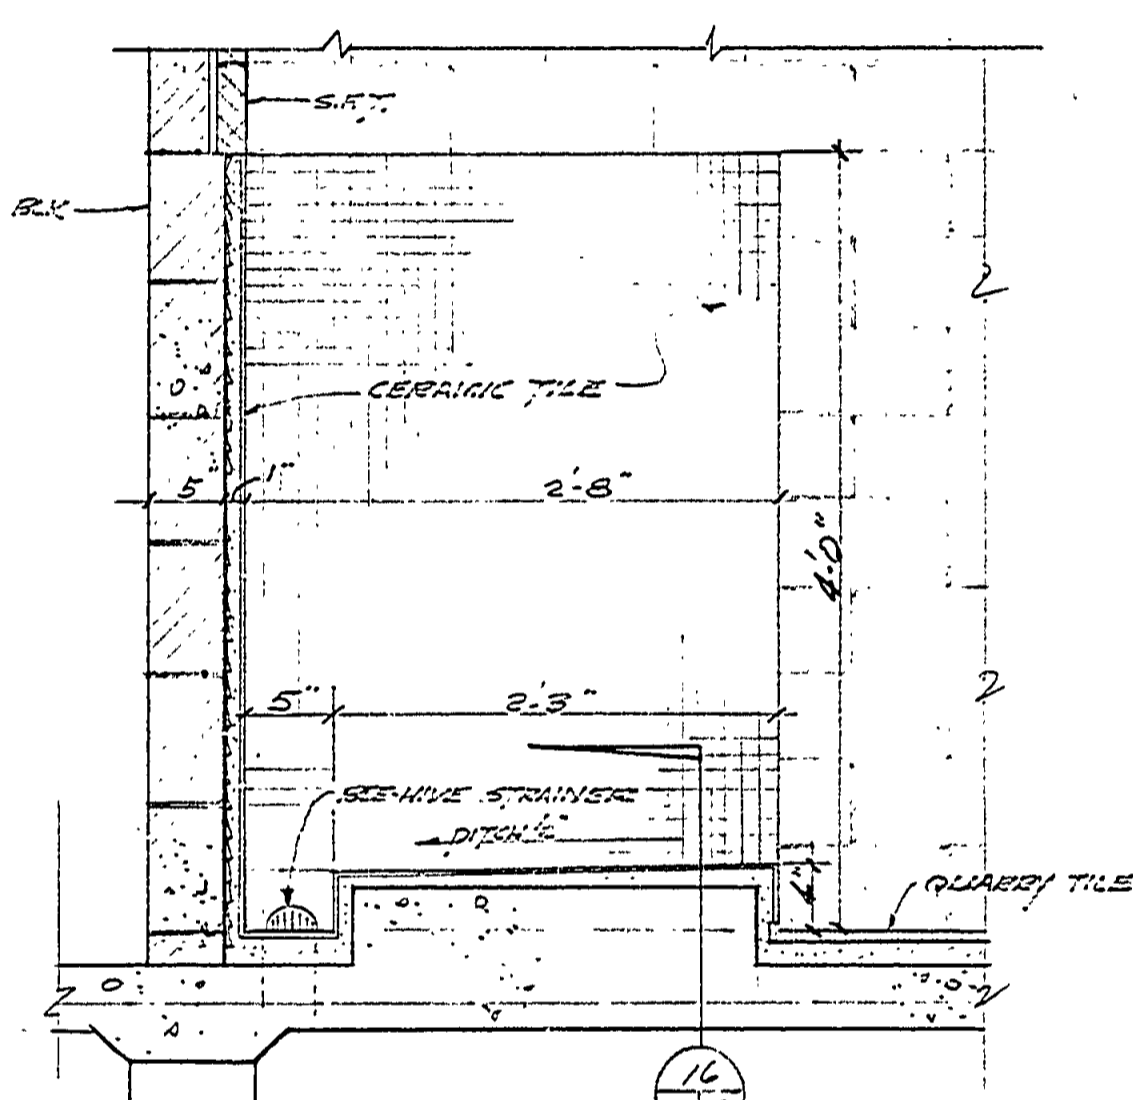


DET. 12  
2/4

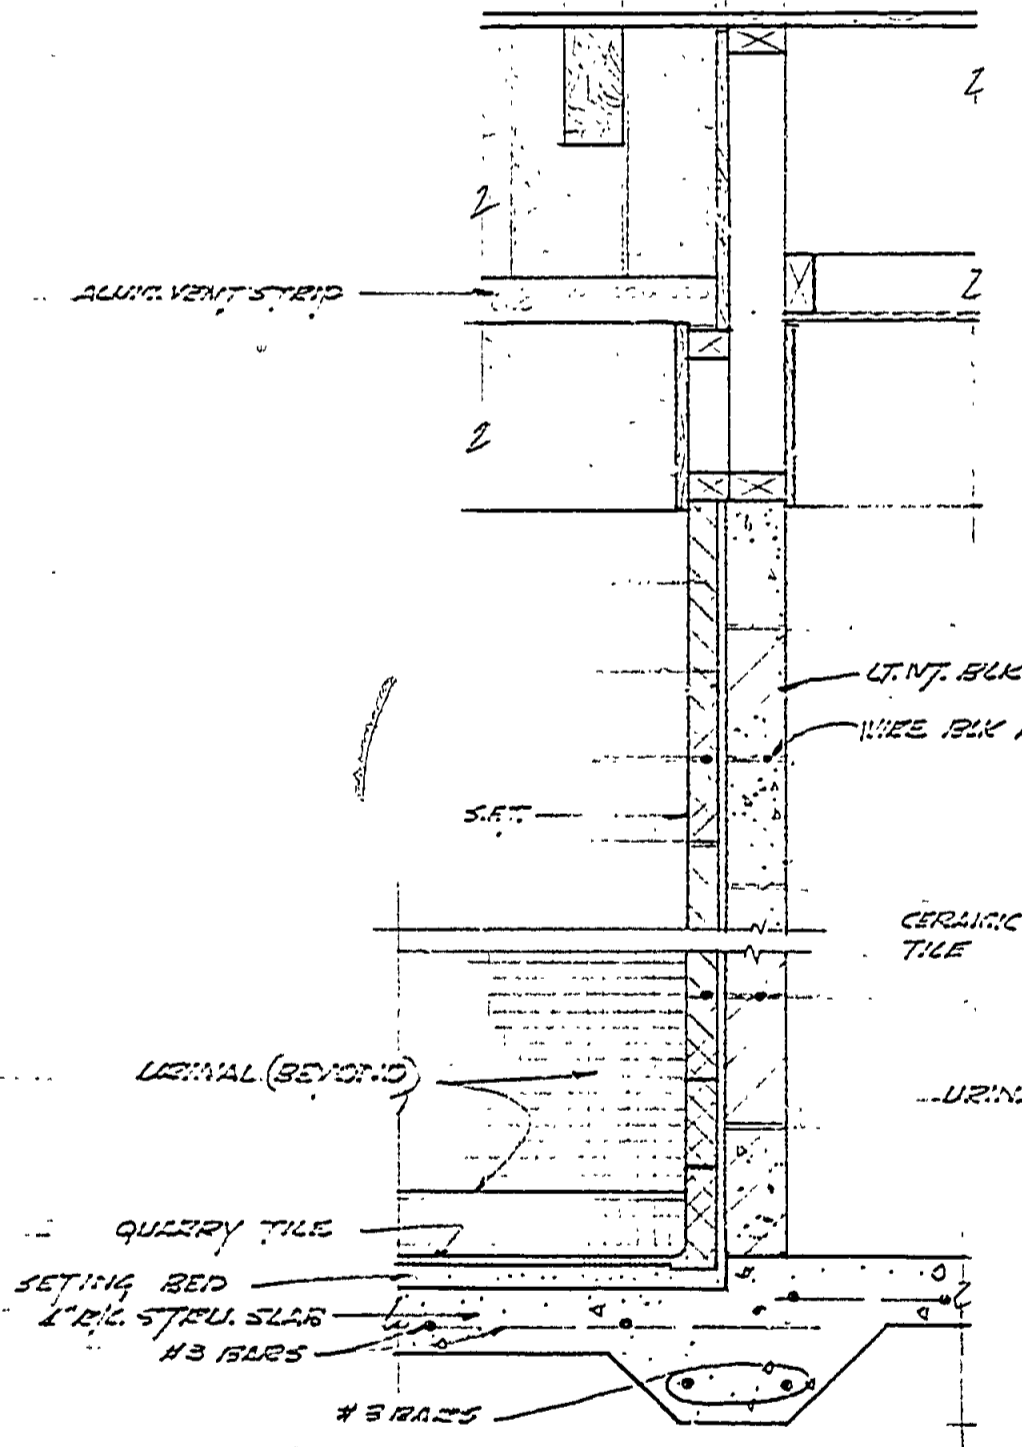


DET. 13  
2/4

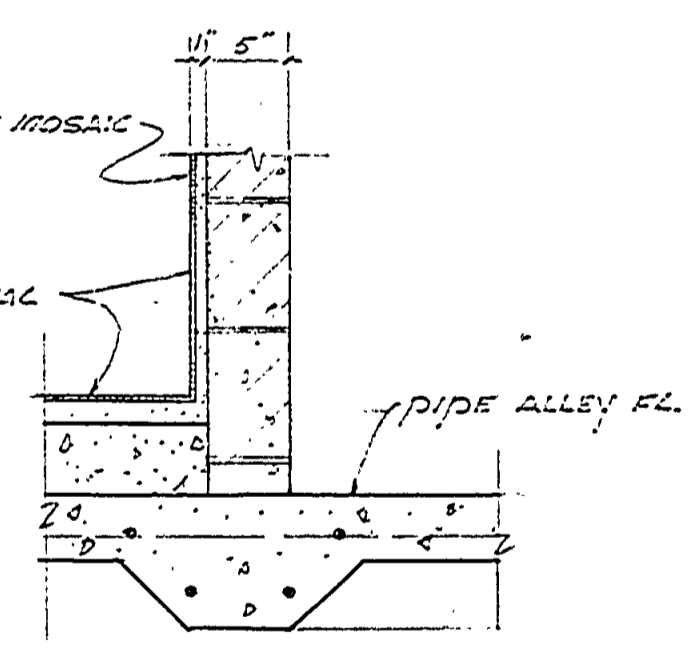


DET. @ FLOOR  
16  
2/4

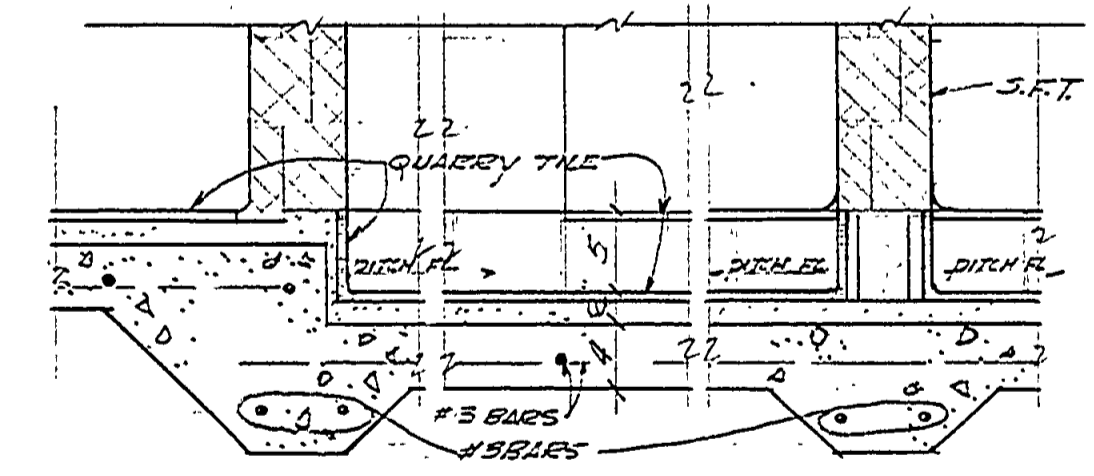


FL. DET. 17  
2/4

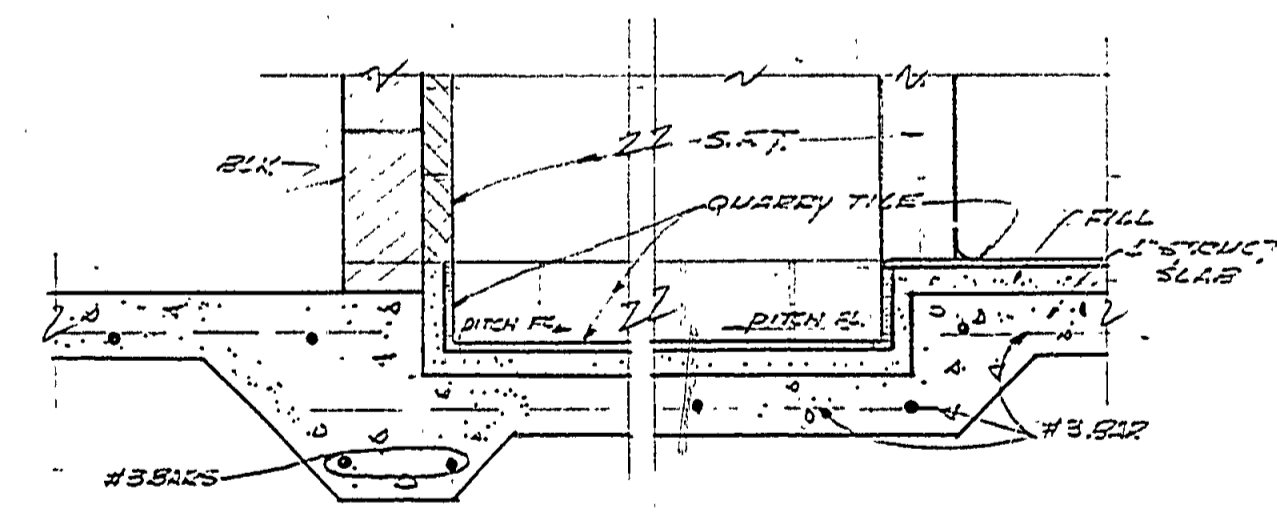

FL. DET. 18  
2/4

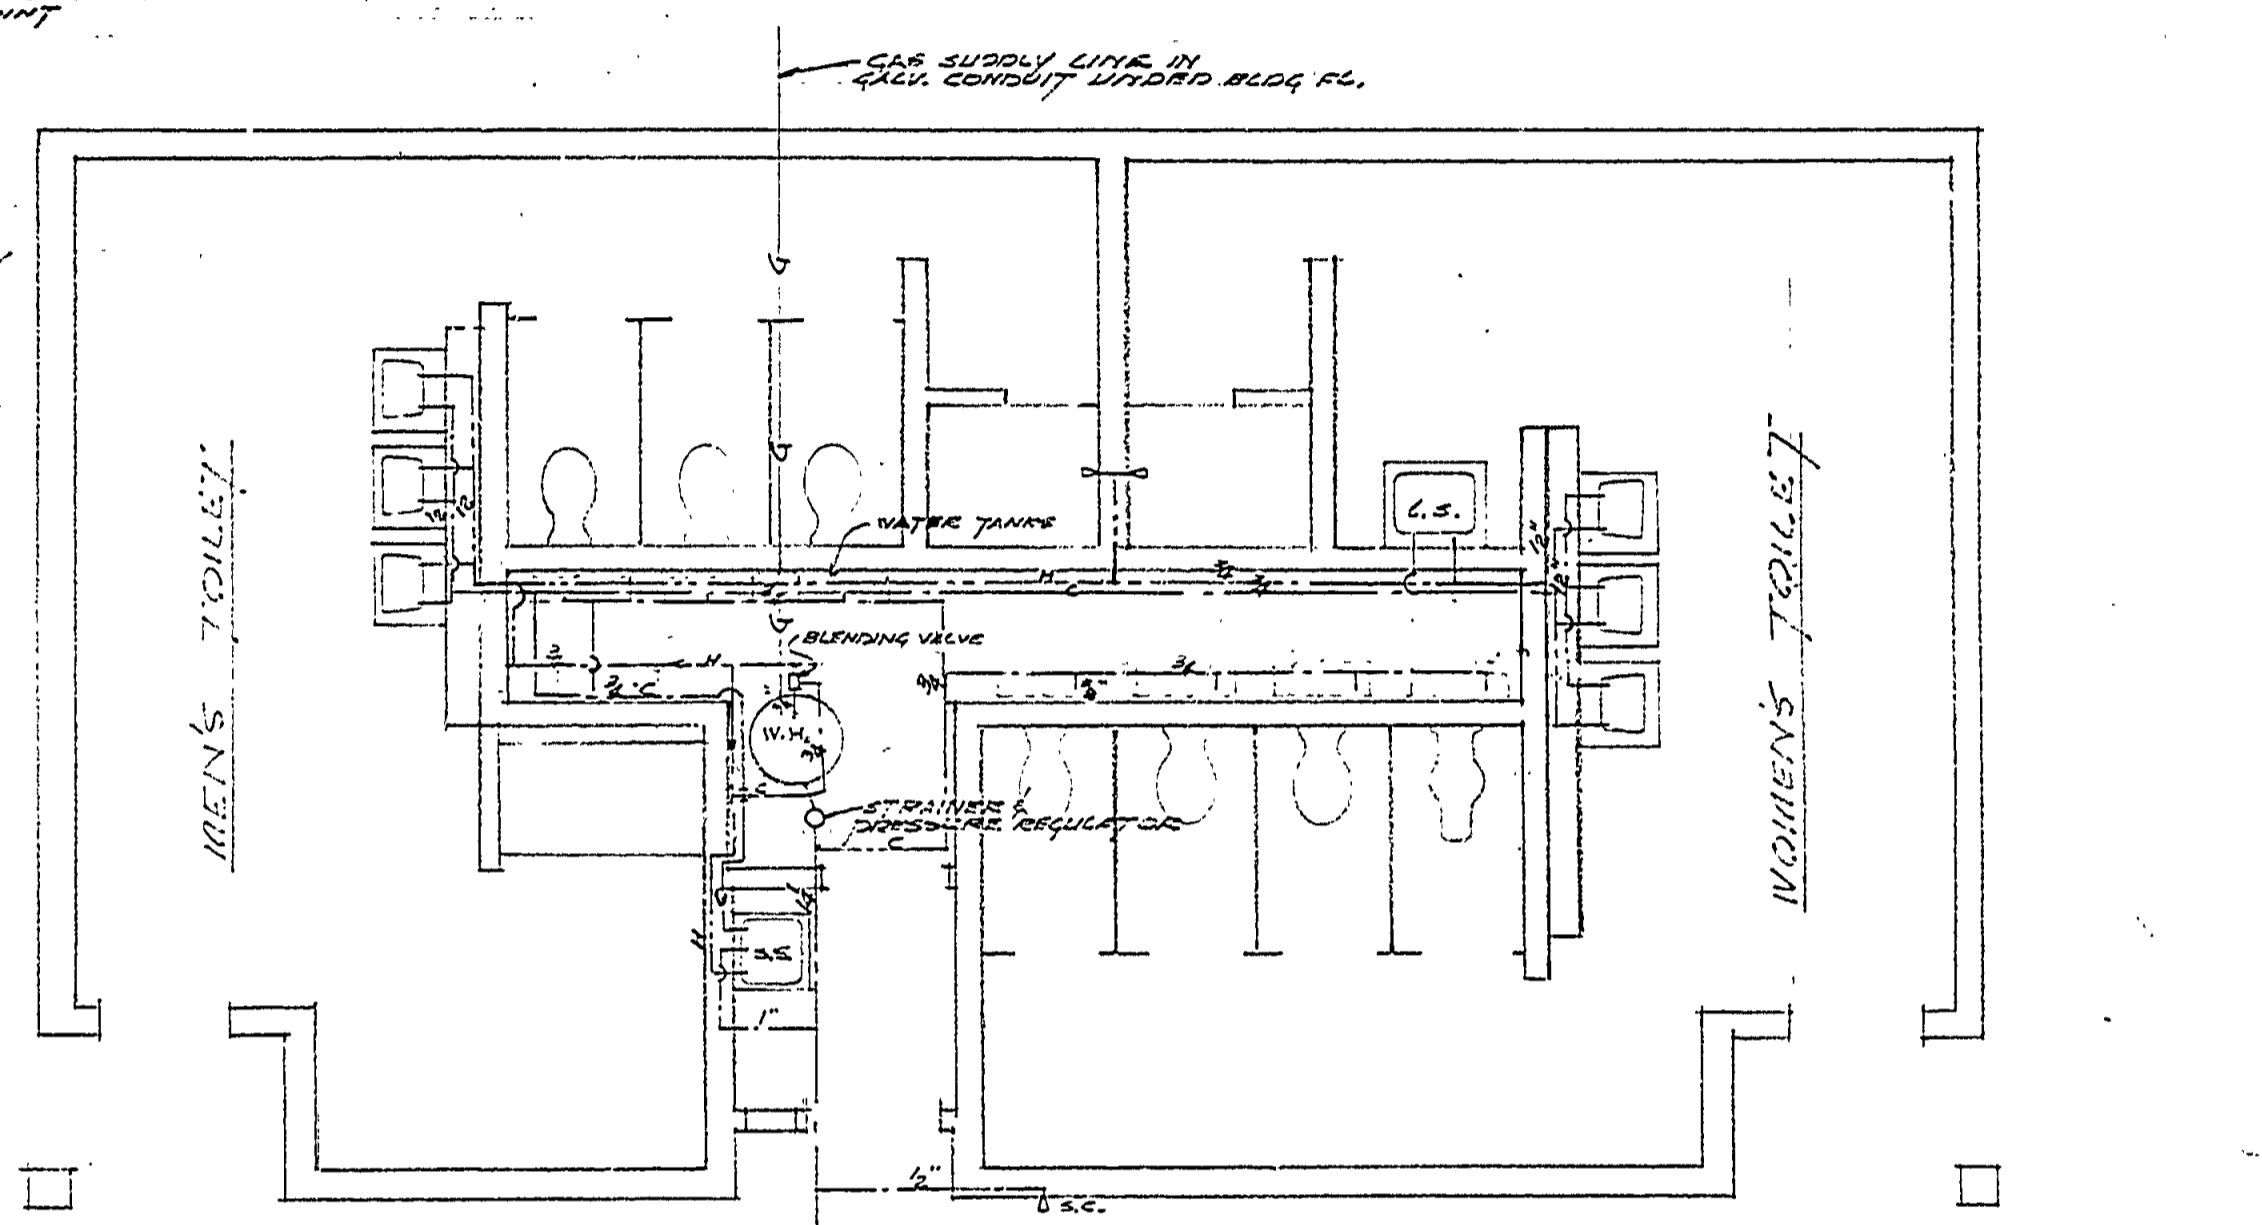

PLUMBING PLAN  
SCALE 1/4"=1'-0"

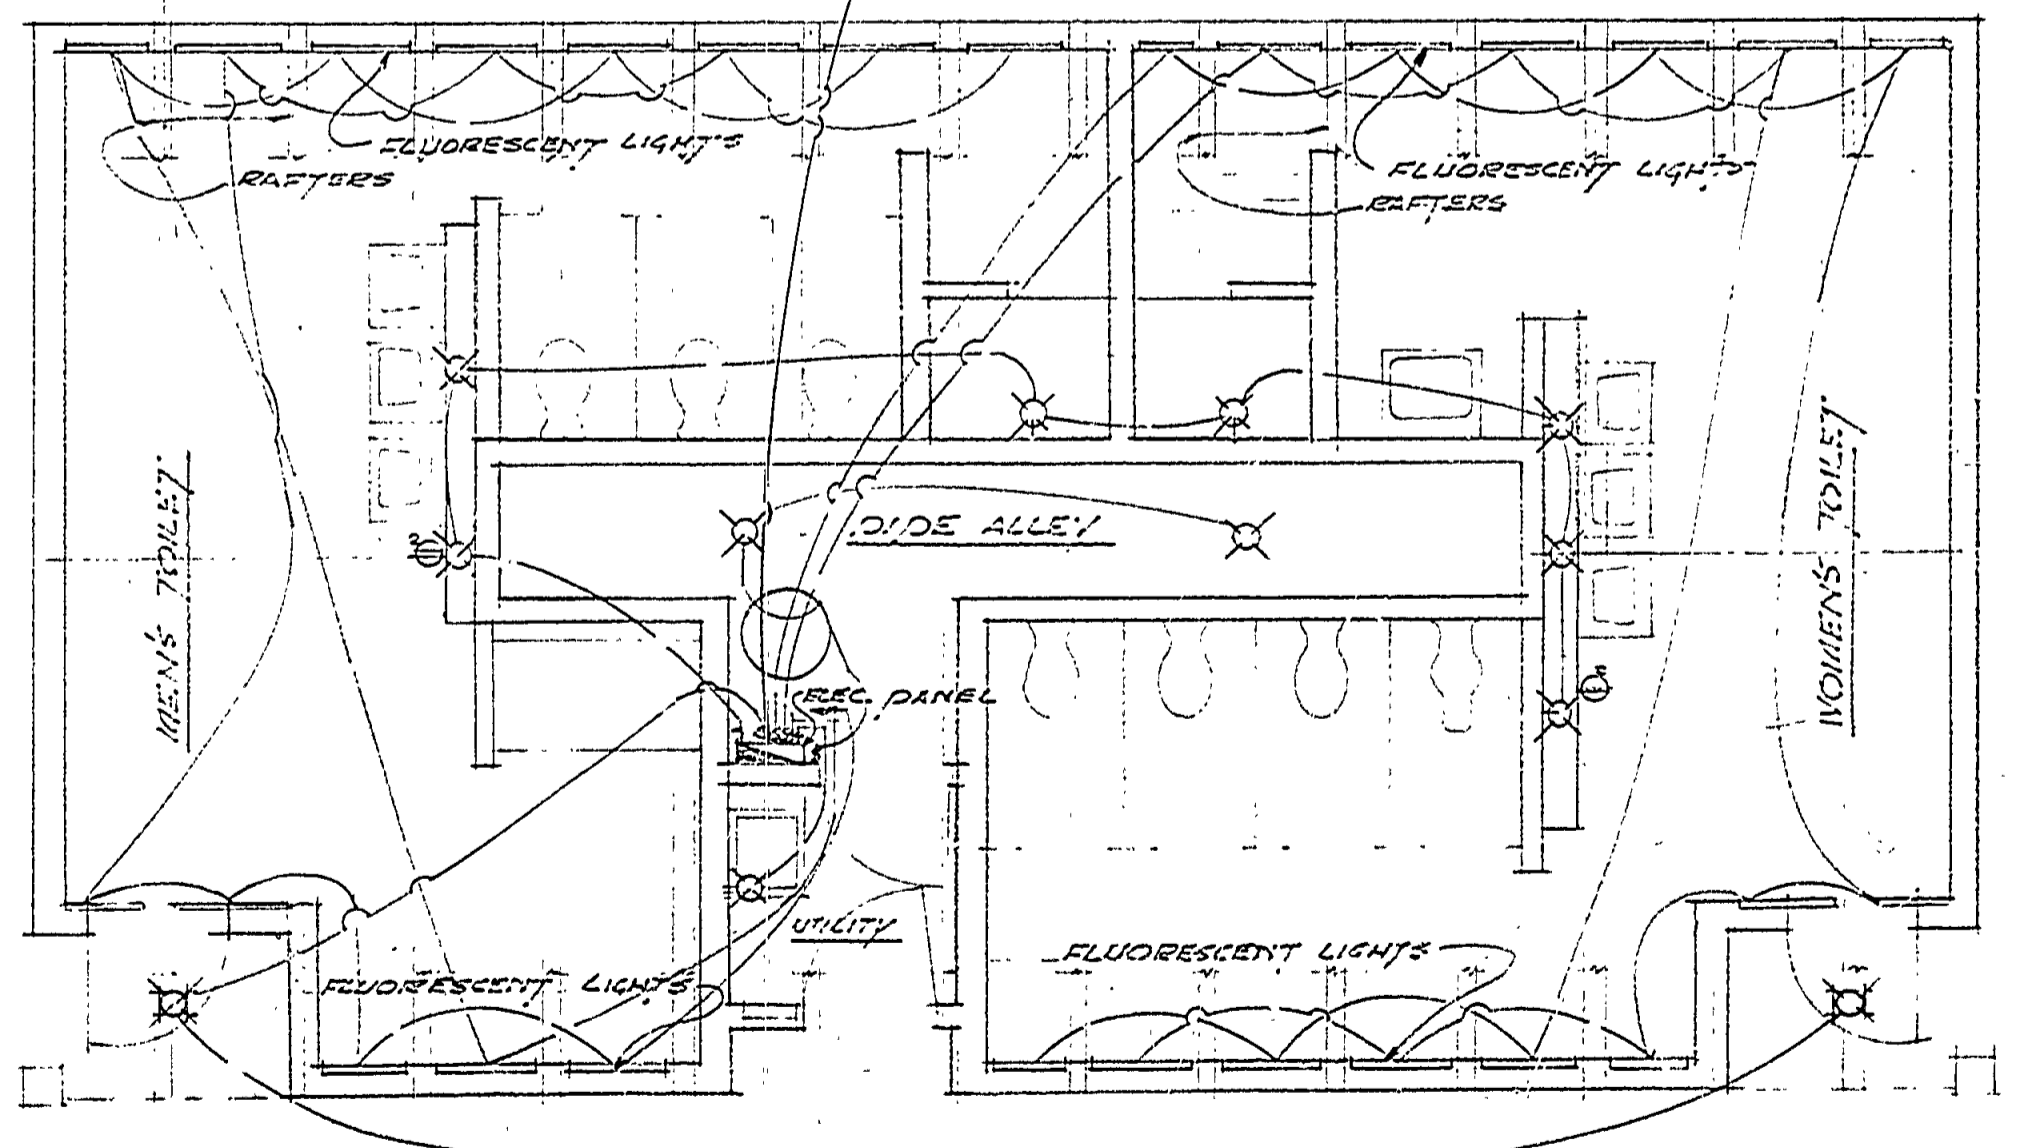

ELECTRICAL PLAN  
SCALE 1/4"=1'-0"

INTERIOR ELEVATIONS, PLUMBING & ELECTRICAL & DETAILS

MICHIGAN  
DEPARTMENT OF CONSERVATION  
PARKS AND RECREATION DIVISION

BRIMLEY STATE PARK  
TOILET & SHOWER BUILDING, #7

SHEET  
NO. 4  
OF 4

PLAN NO.  
A-105