



DRAWN BY J.W.F.	TRACED BY M.F.	CHECKED BY J.	DATE 8-12-53	REVIEWED BY SECTIONS		APPROVED BY		DATE 8-11-53	DATE 10/6/53	NO.	BY	REVISIONS		
				ARCHITECTURAL	ENGINEERING	LANDSCAPE	J.T.R.					H.C.M.	J.T.R.	4
				ASSISTANT CHIEF IN CHARGE		DATE OF DESIGN								

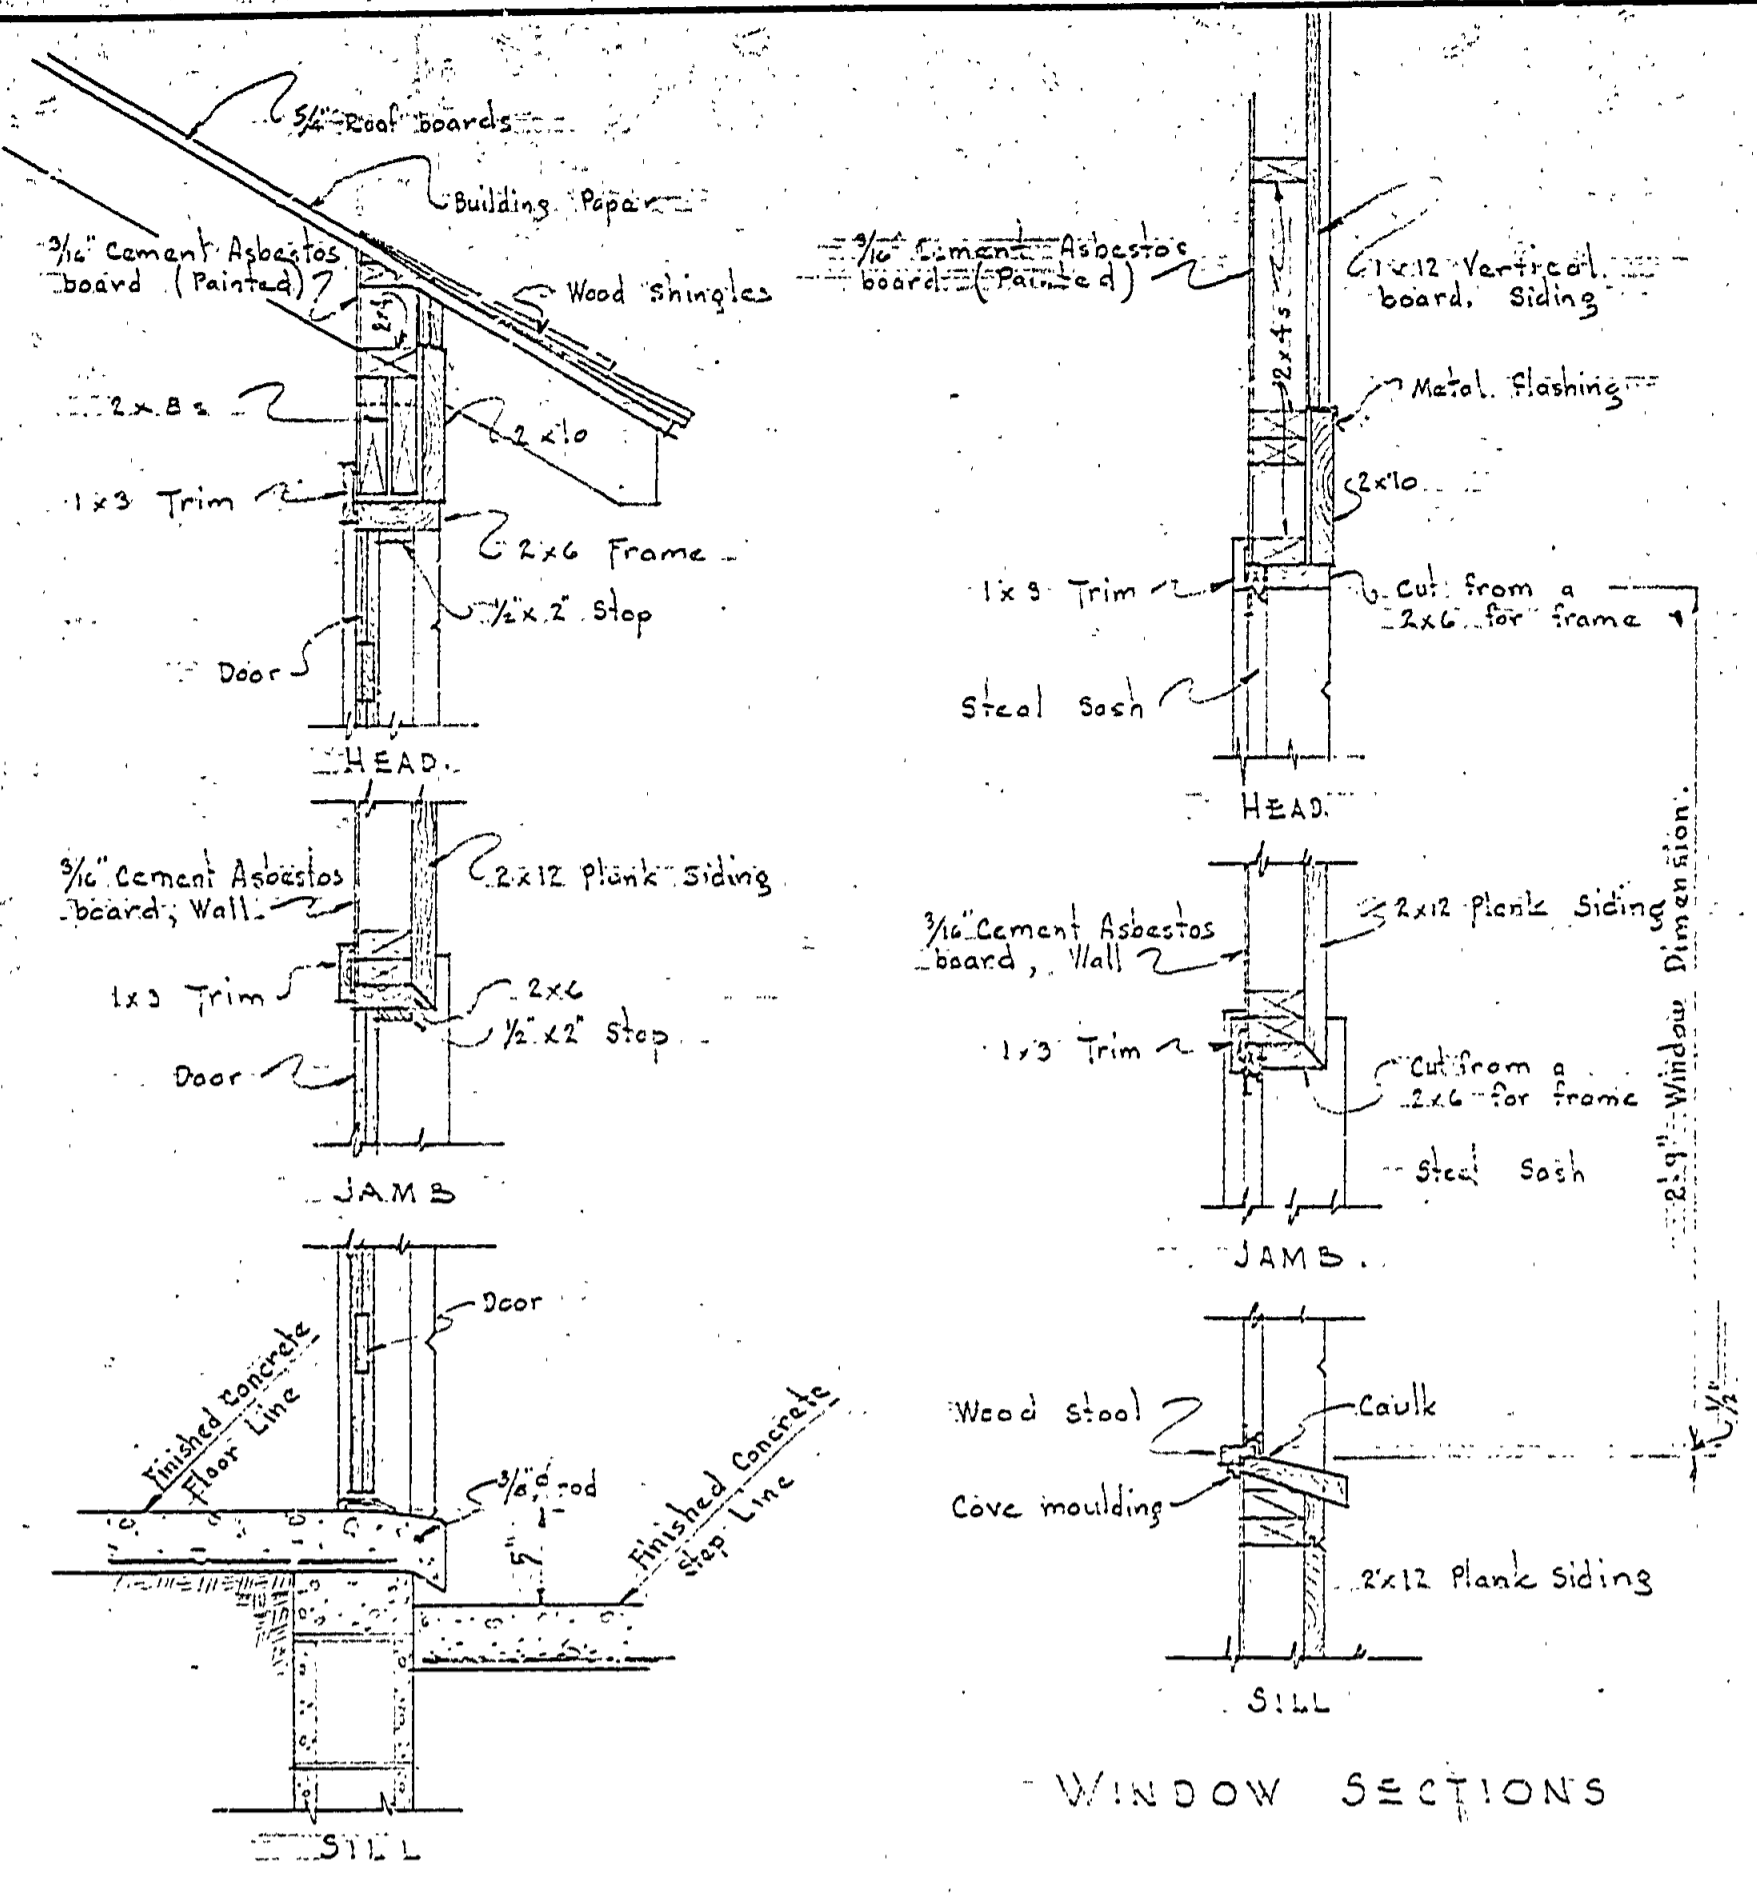


TYPICAL DETAILS  
LAUNDRY AND STORAGE ROOM  
Scale 1/4" = 1'-0"

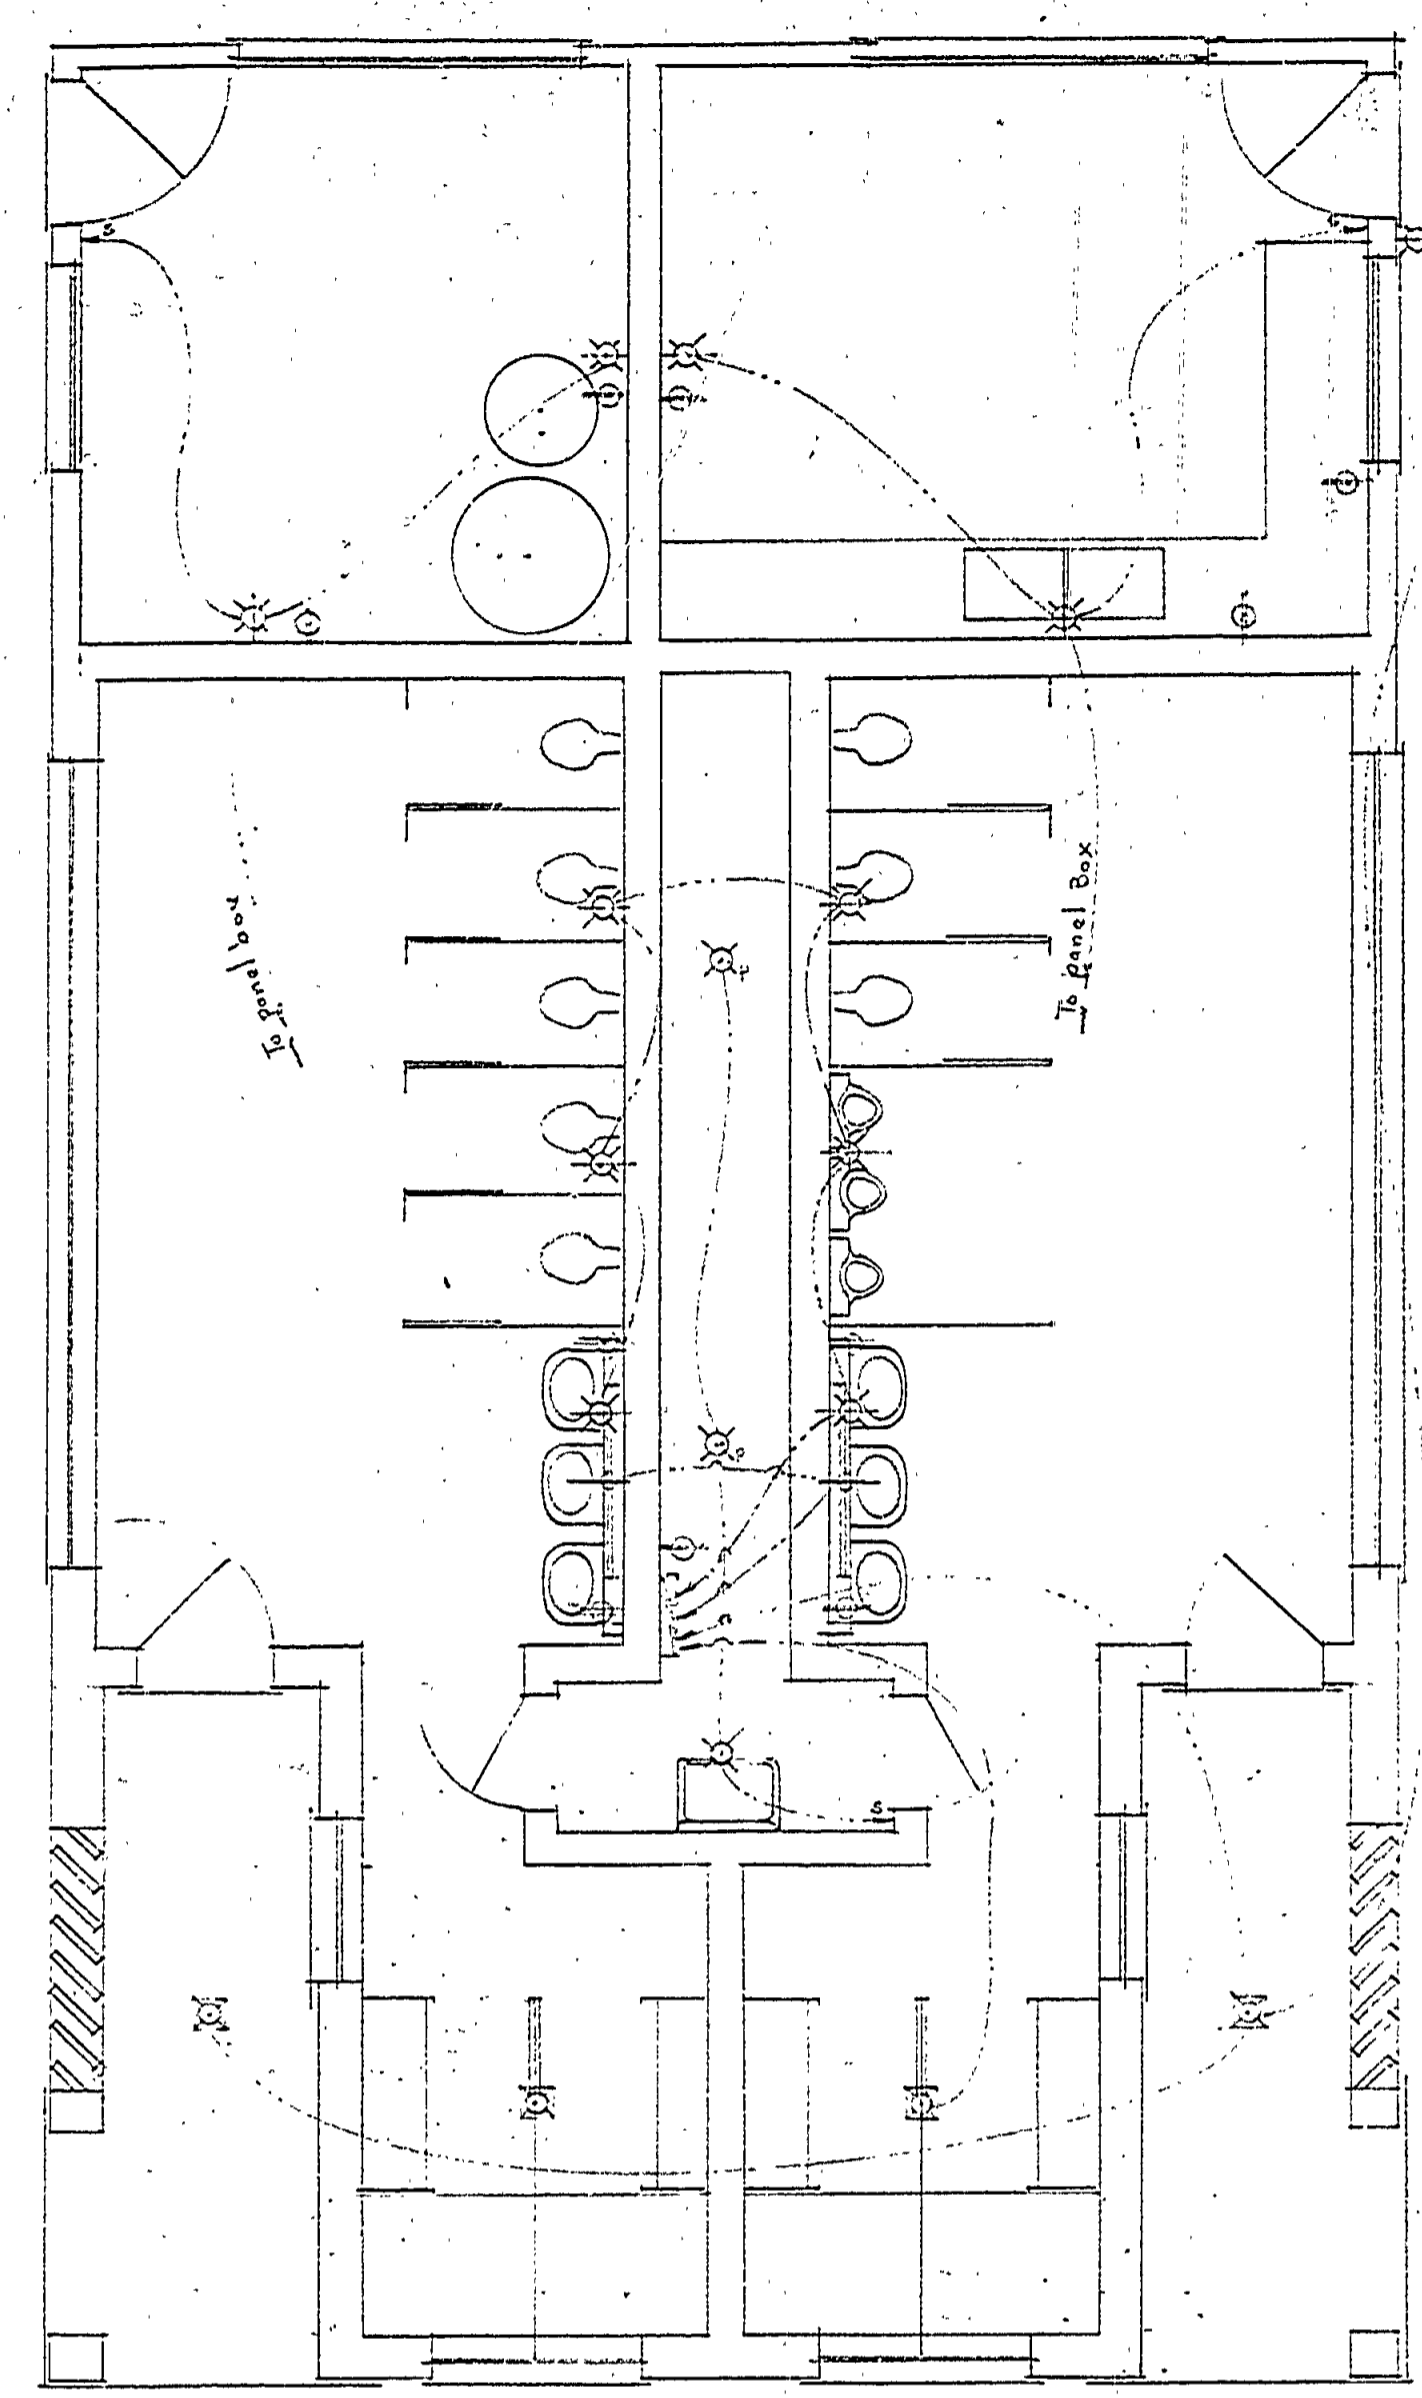


ELECTRICAL PLAN  
Scale 1/4" = 1'-0"

- ELECTRICAL SYMBOLS**
- ⊖ Recessed Fixture Outlet
  - ⊖ Bracket Light Outlet (Fixture by others)
  - ⊖ Ceiling Light Outlet
  - ⊖ Fluorescent Light fixture Outlet
  - ⊖ Duplex Receptacle Outlet
  - ⊖ Ceiling Light with switch
  - ⊖ Wire to Panel Box
  - ⊖ Single Switch
  - ⊖ Panel or Control Box

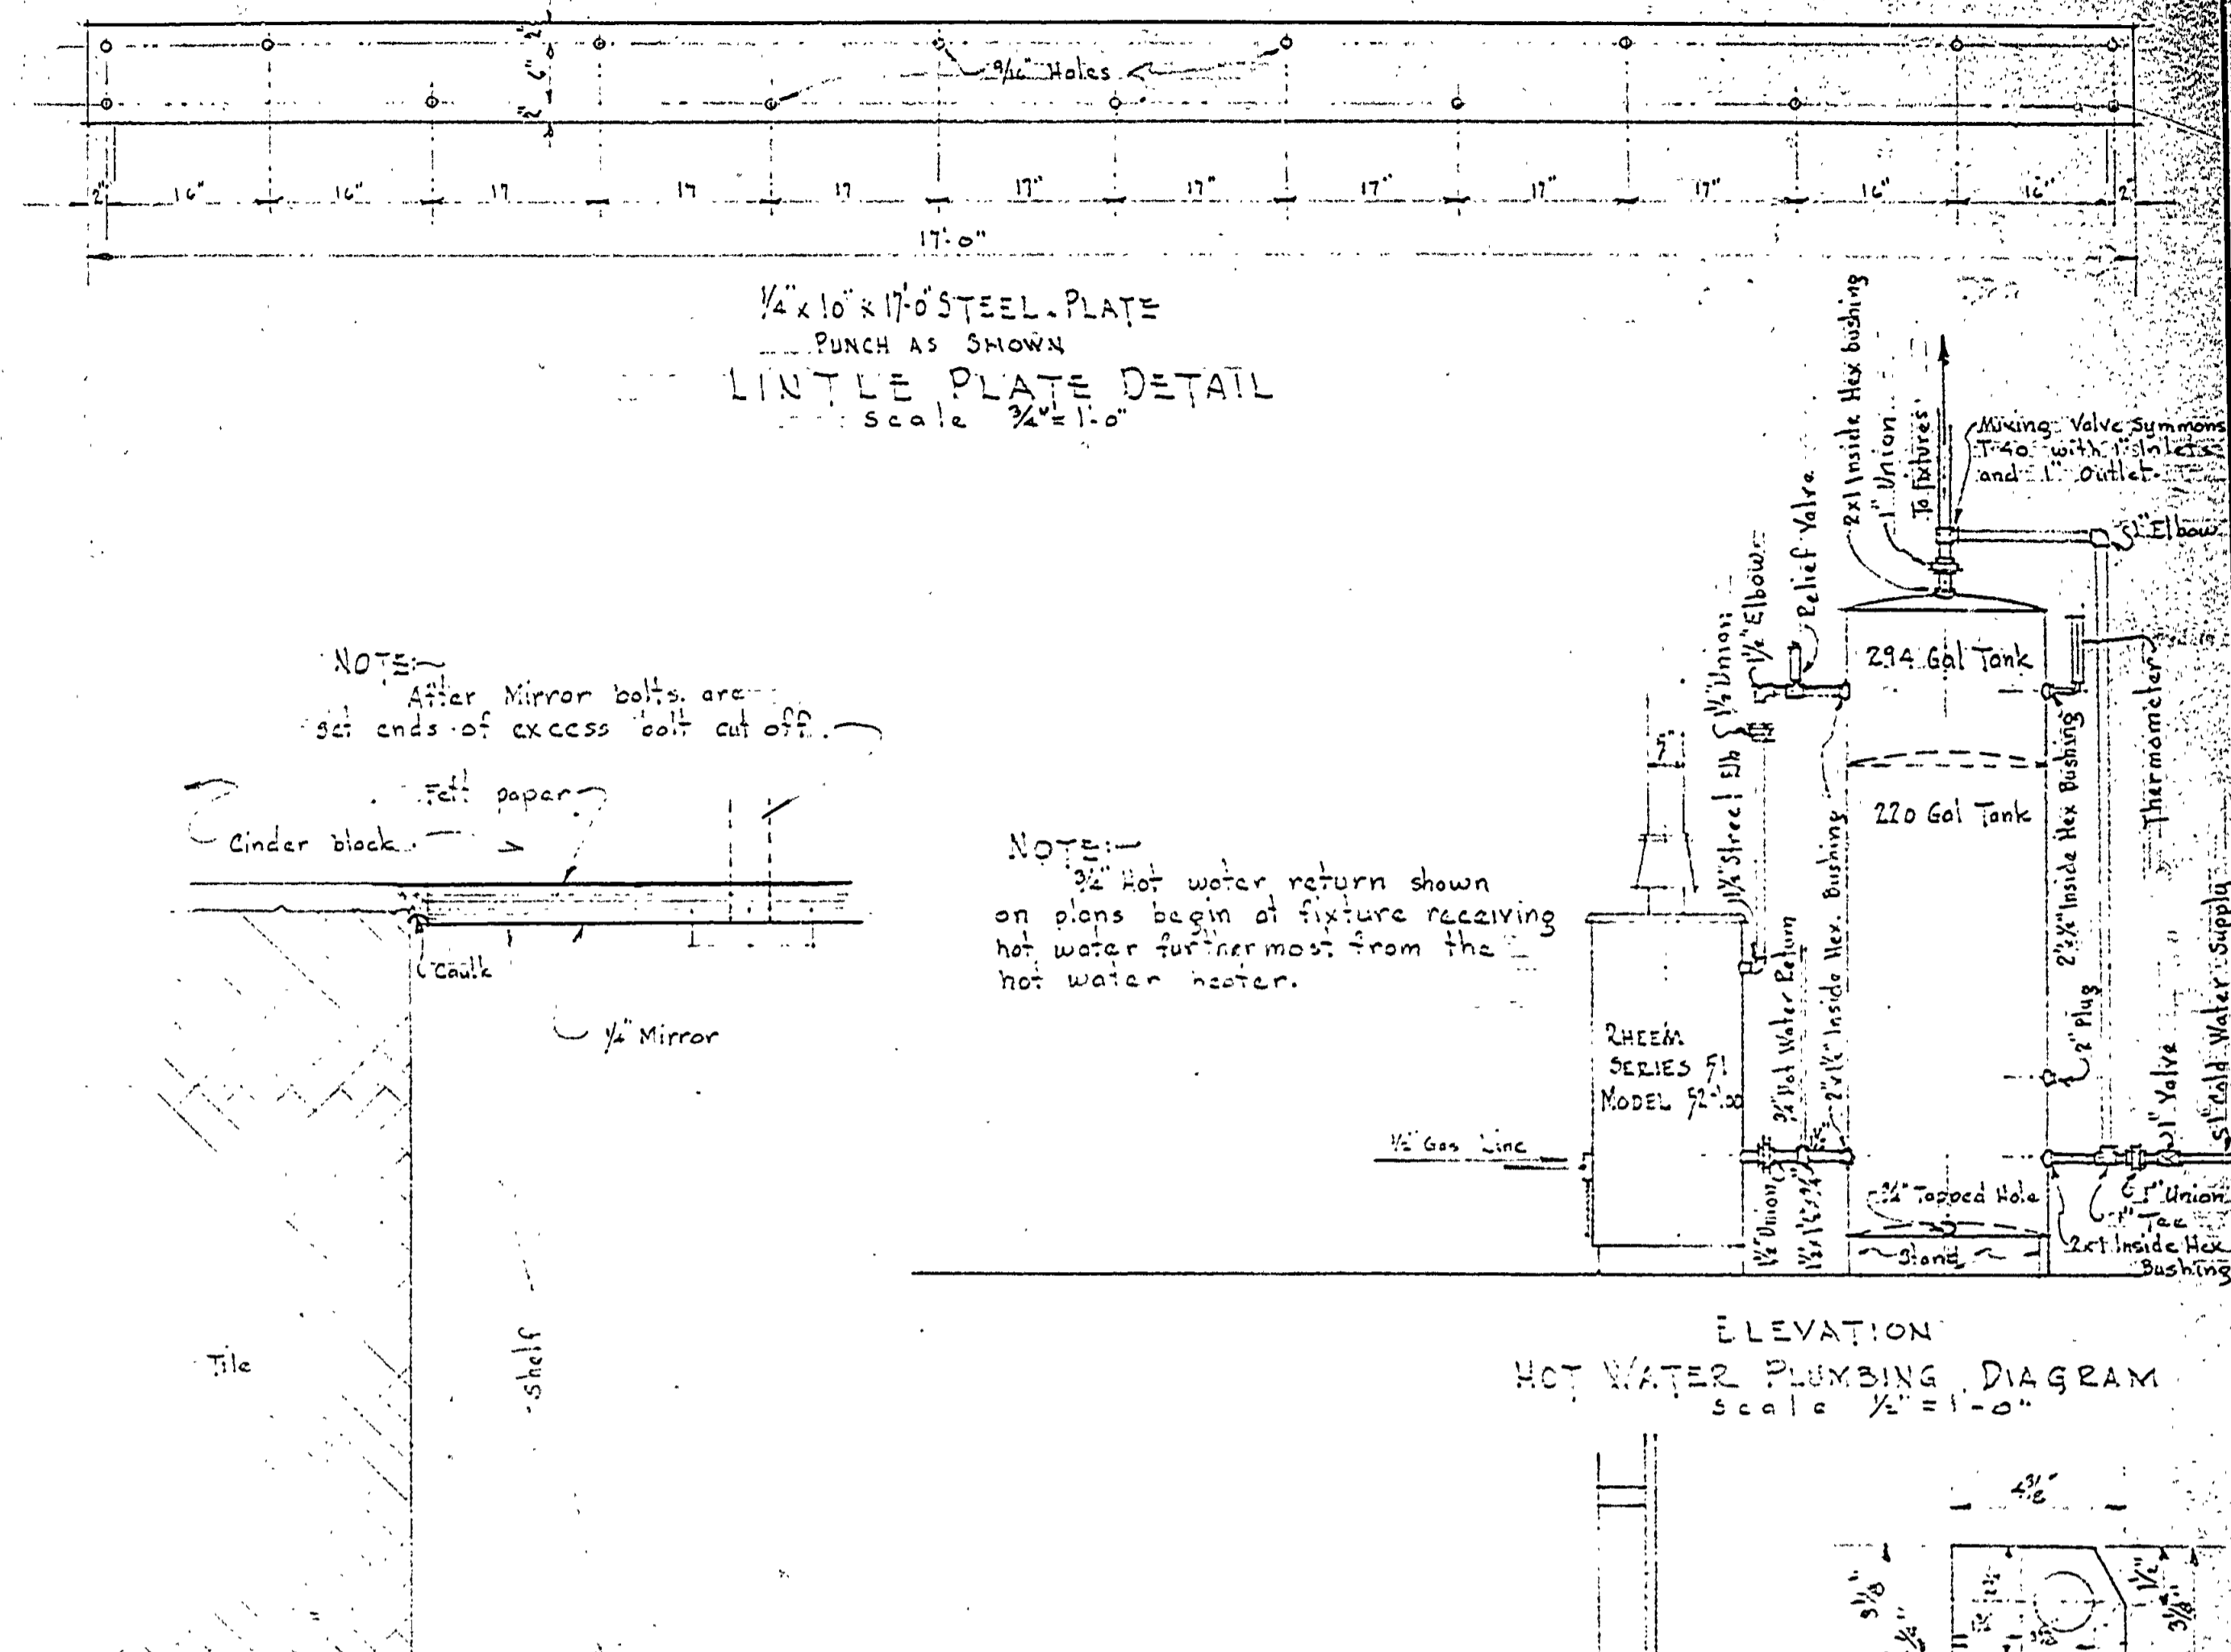


LITTLE PLATE DETAIL  
Scale 3/4" = 1'-0"

HOT WATER PLUMBING DIAGRAM  
Scale 1/4" = 1'-0"

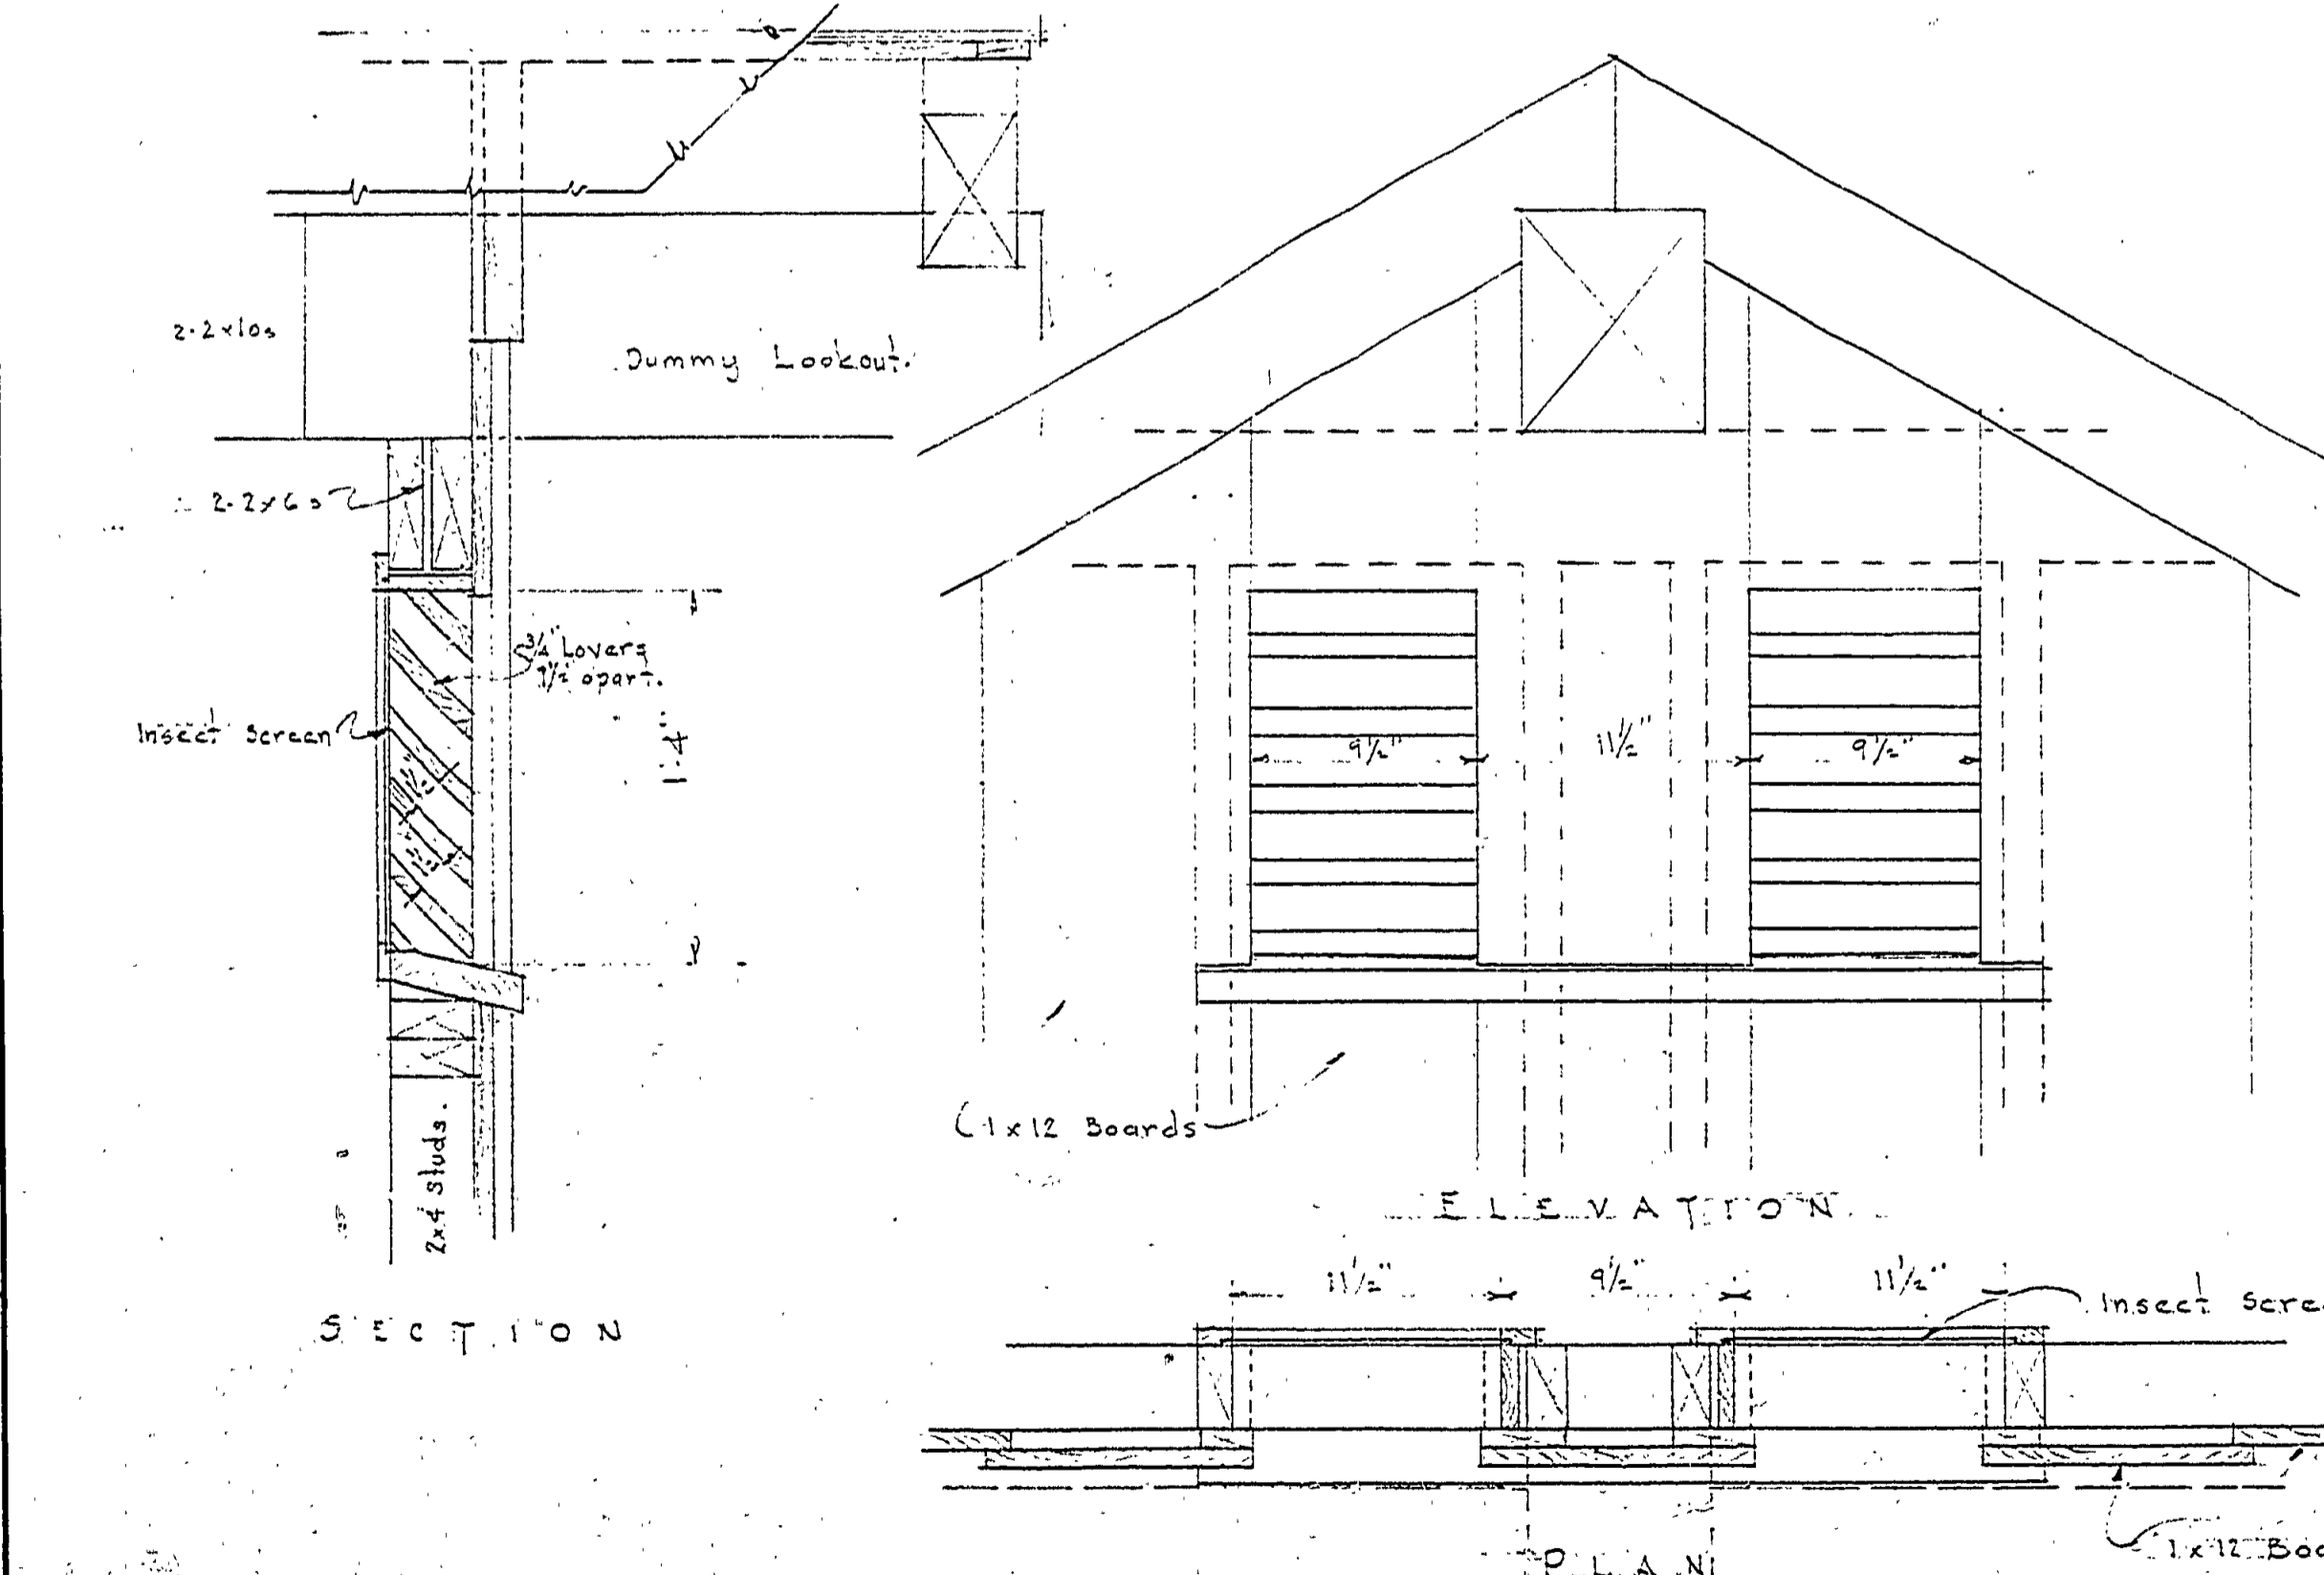

LOUVER DETAIL  
Scale 1/4" = 1'-0"


ELEVATION

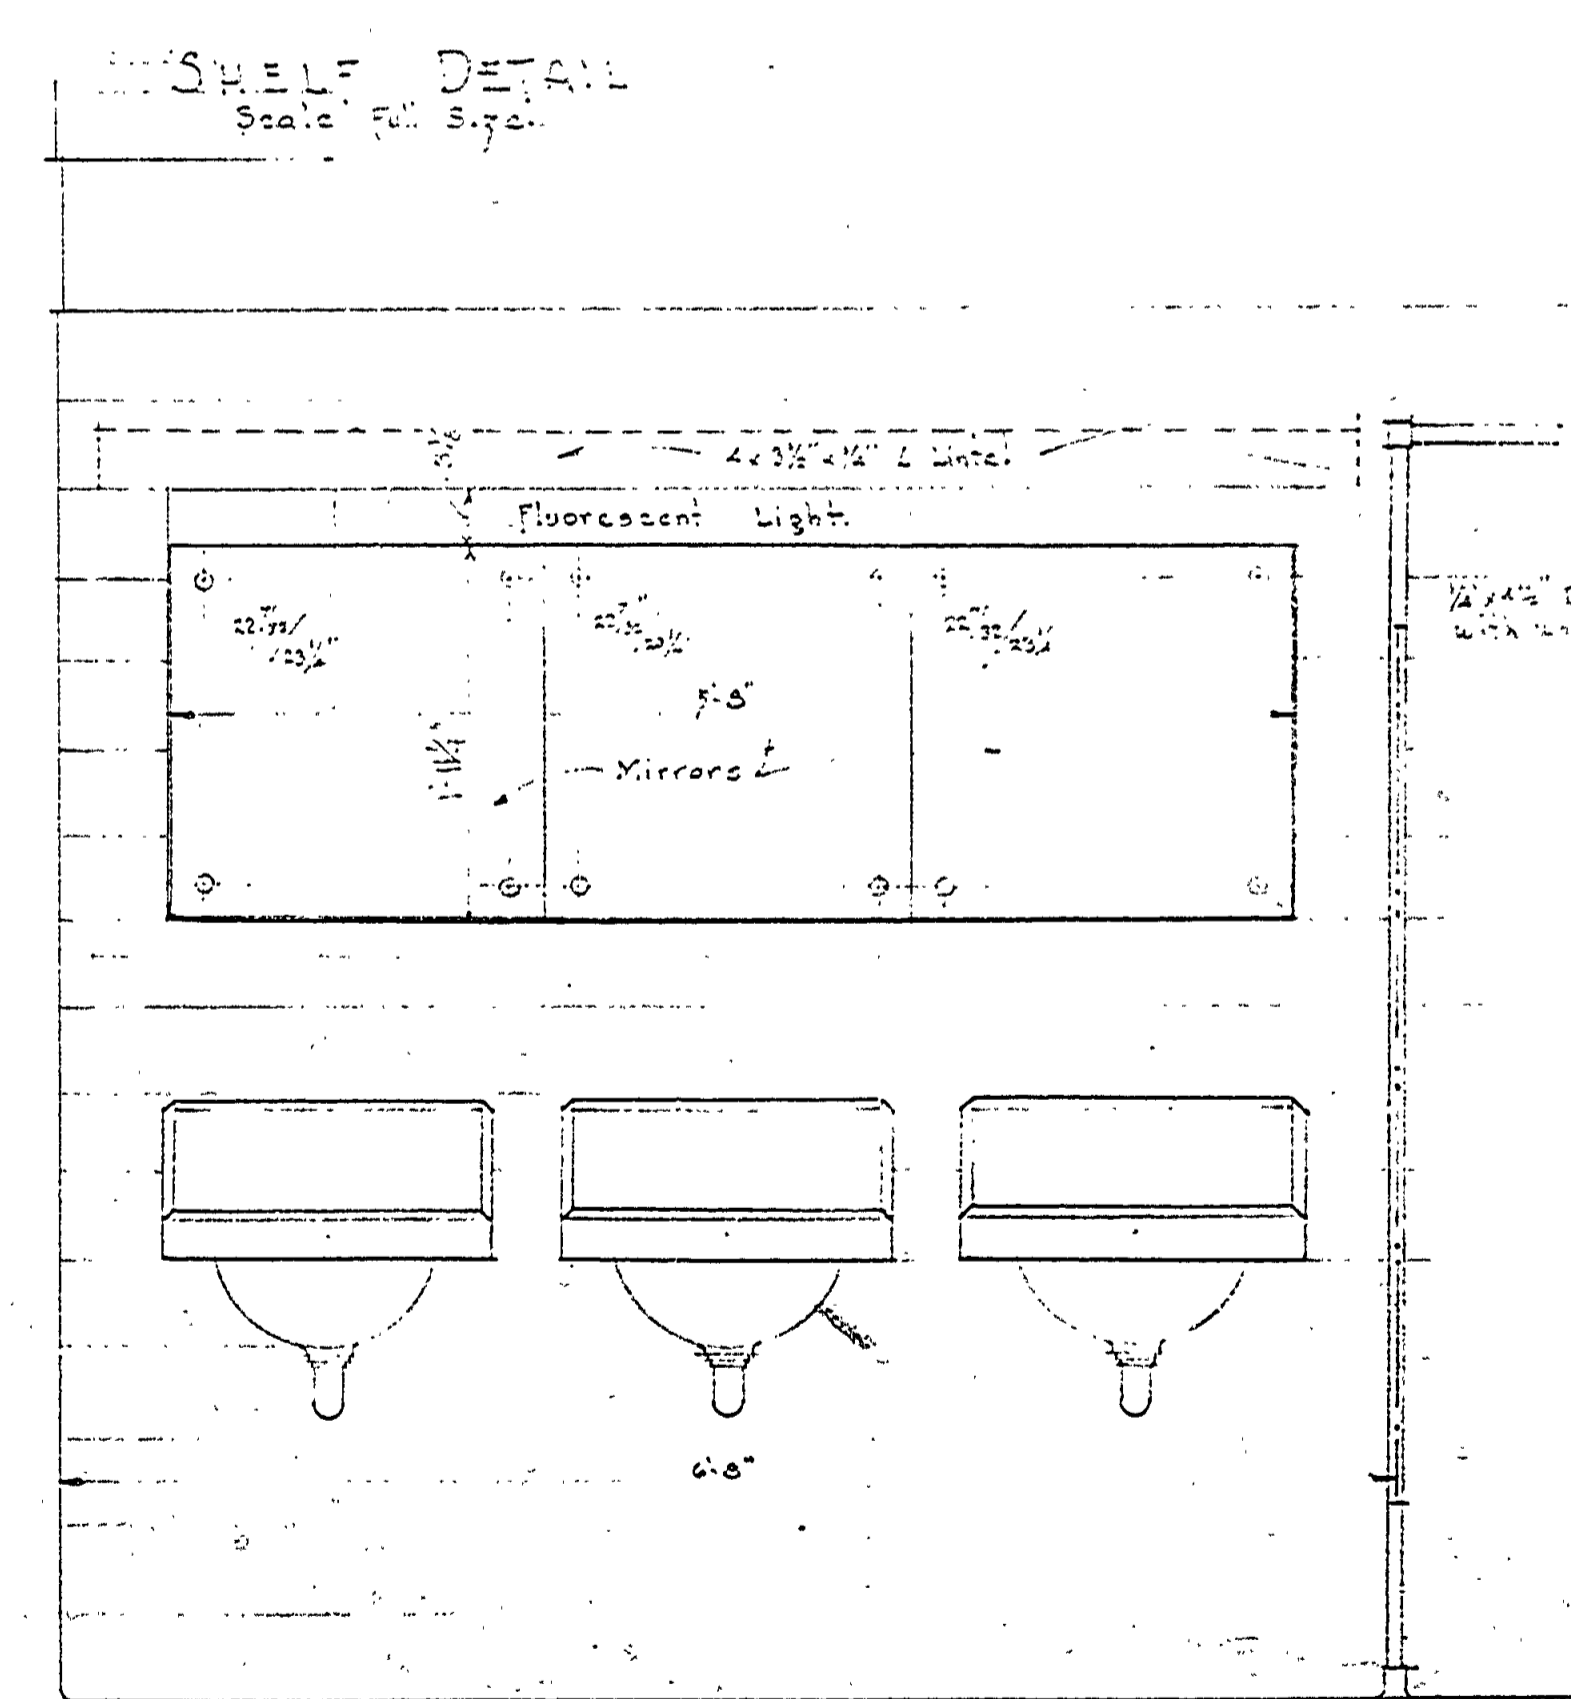

SHELF DETAIL  
Scale Full Size

ELEVATION

TYPICAL MIRROR DETAIL  
Scale 1/4" = 1'-0"

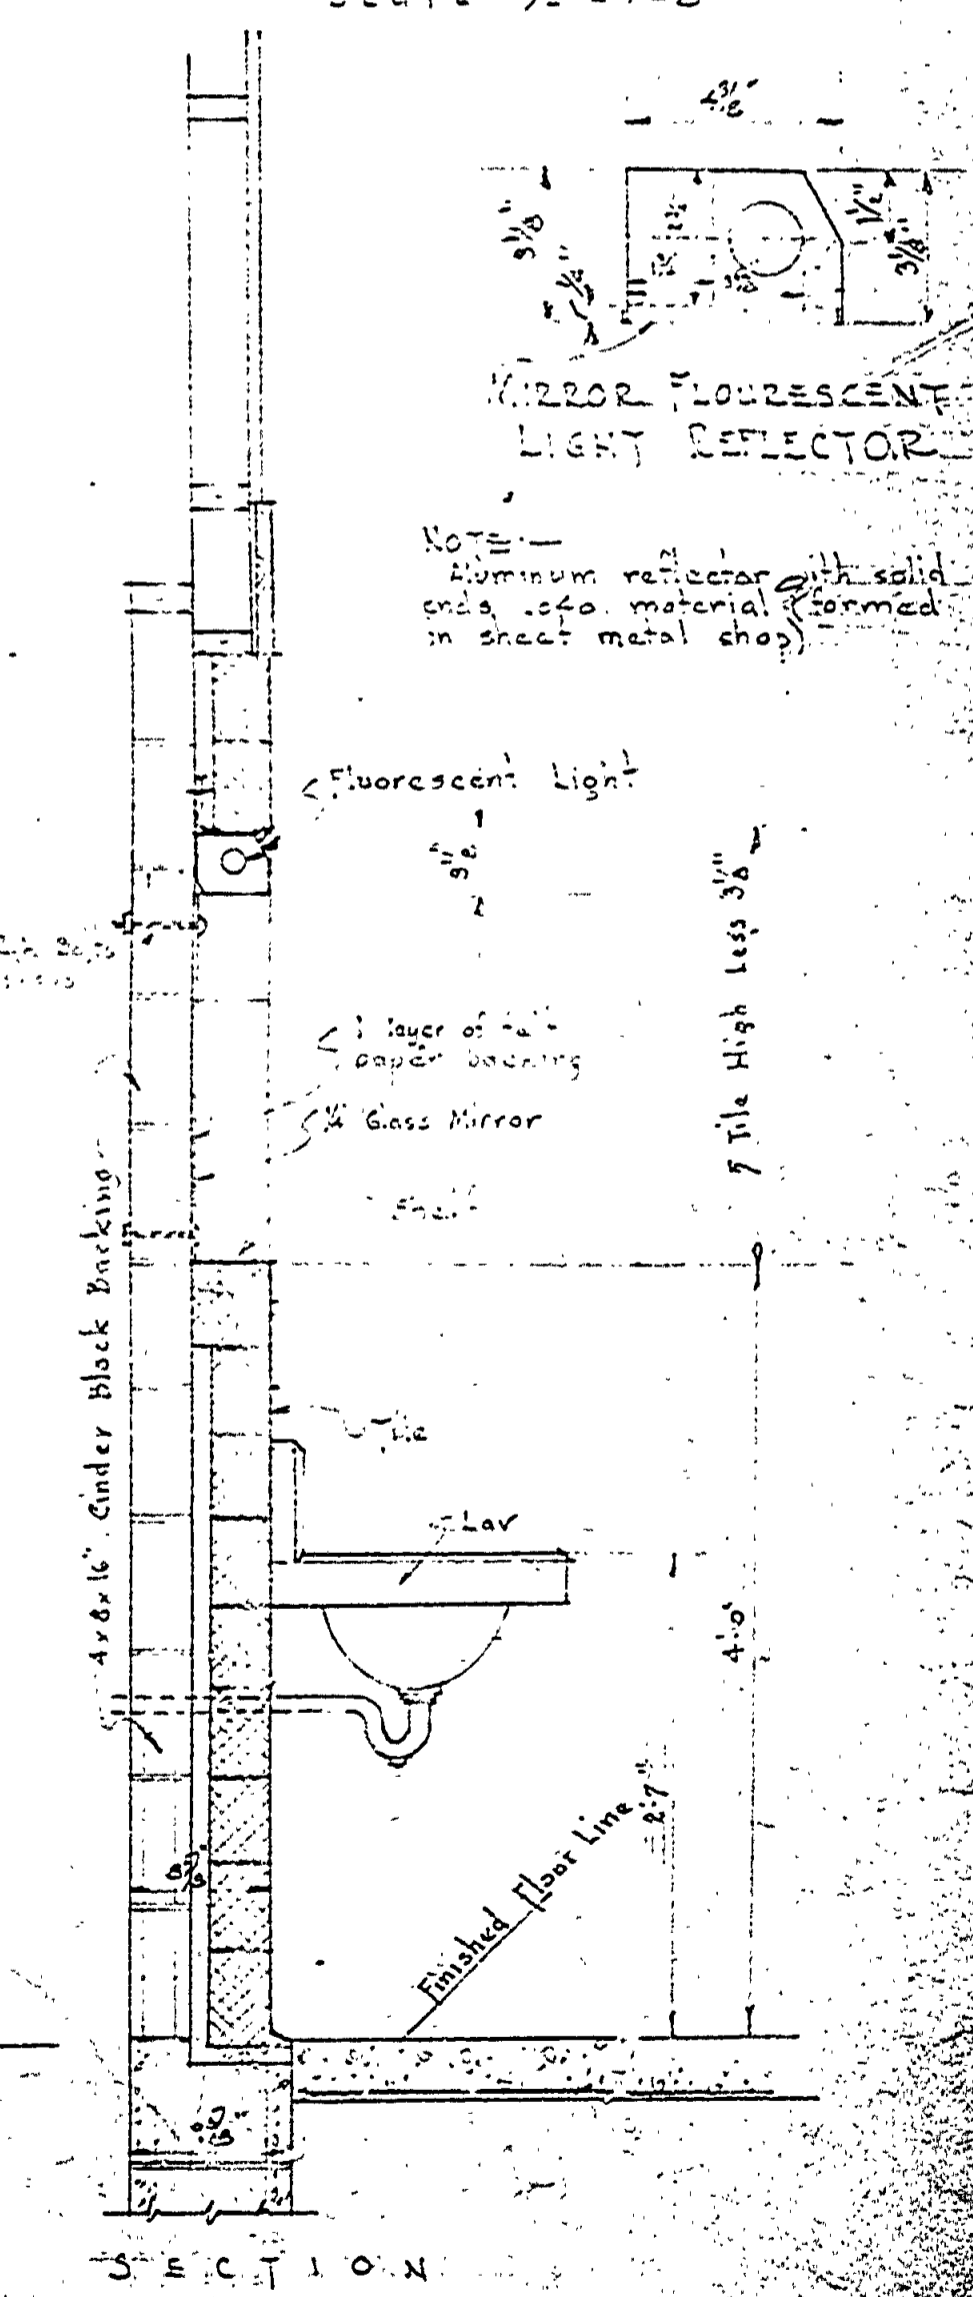

MIRROR FLUORESCENT LIGHT REFLECTOR

SECTION