





DESIGNED BY	DRAWN BY	CHECKED BY	DATE	REVIEWED	DATE	APPROVED
W.D.G.	W.D.G.	W.D.G.	1/24/41	W.D.G.	1/24/41	W.D.G.
ARCHITECTURAL	ENGINEERING	LANDSCAPE	1/24/41	1/24/41	1/24/41	1/24/41
NO. 1	NO. 2	NO. 3	NO. 4	NO. 5	NO. 6	NO. 7
1-1-41	1-1-41	1-1-41	1-1-41	1-1-41	1-1-41	1-1-41
U.S.G. Bldg. Plan. Div.						
REVISIONS	DATE	BY	NO.	DATE	BY	NO.
4						
5						
6						

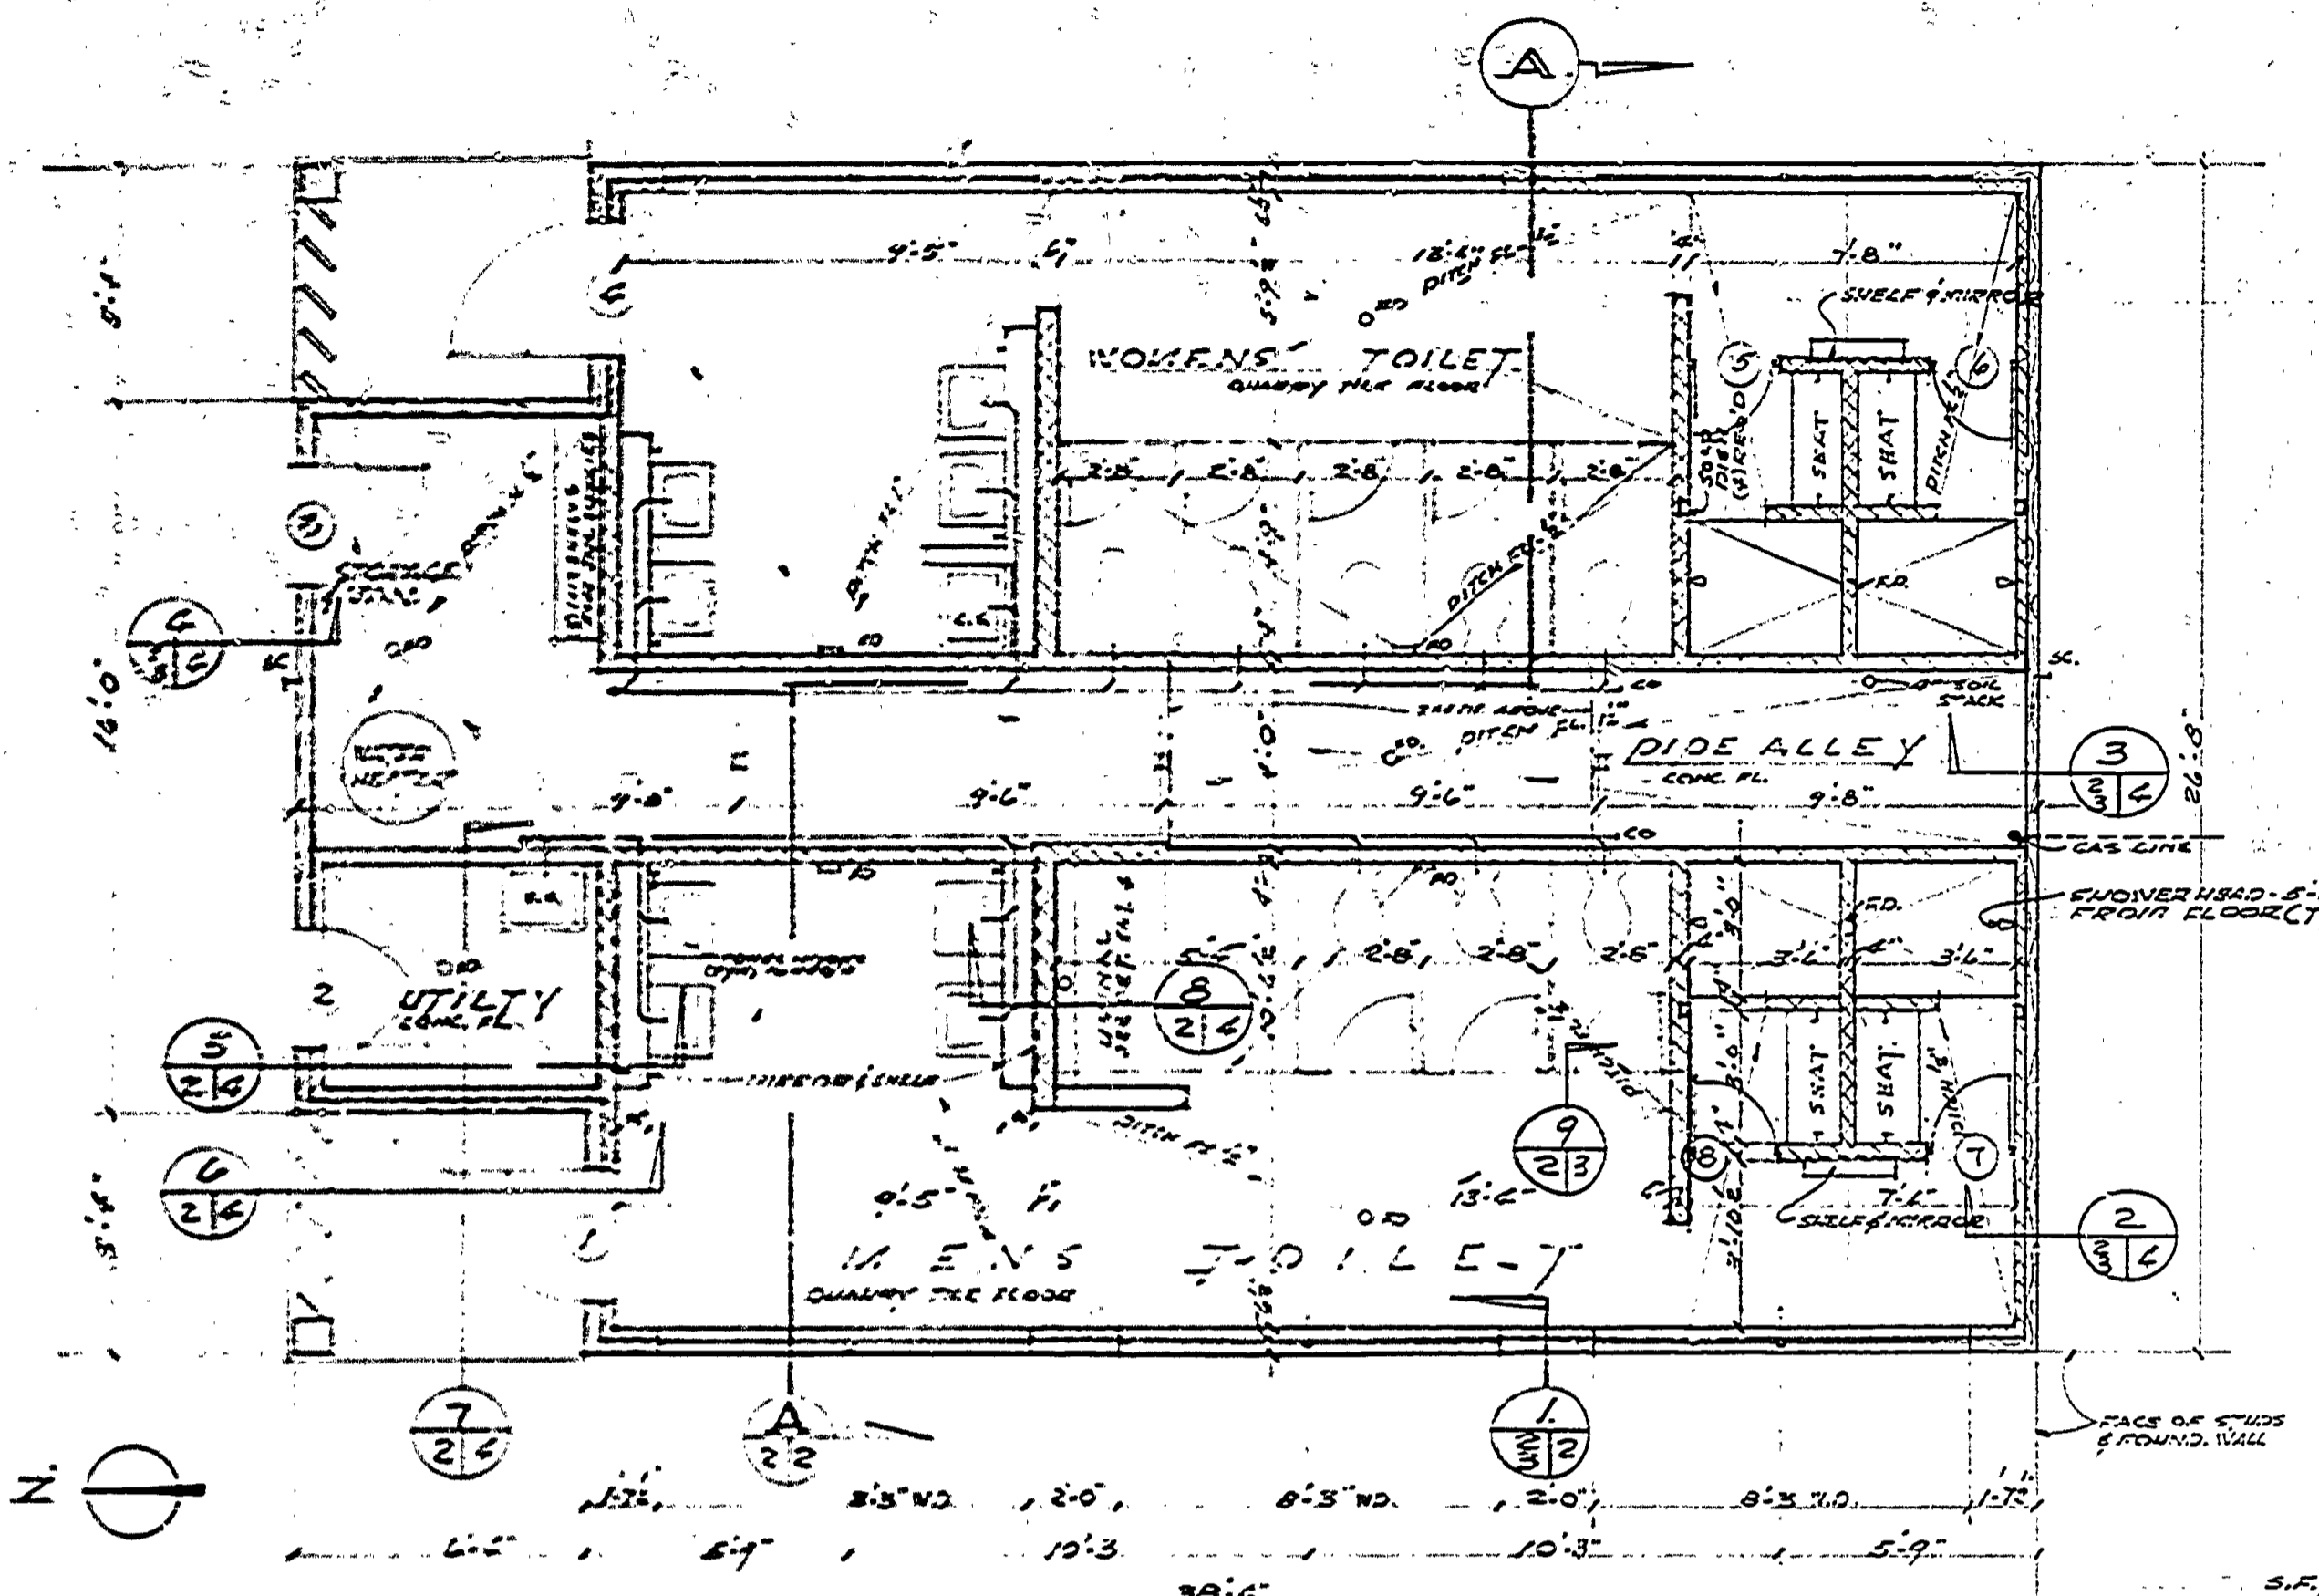


FLOOR PLAN
Scale 1/4\"/>

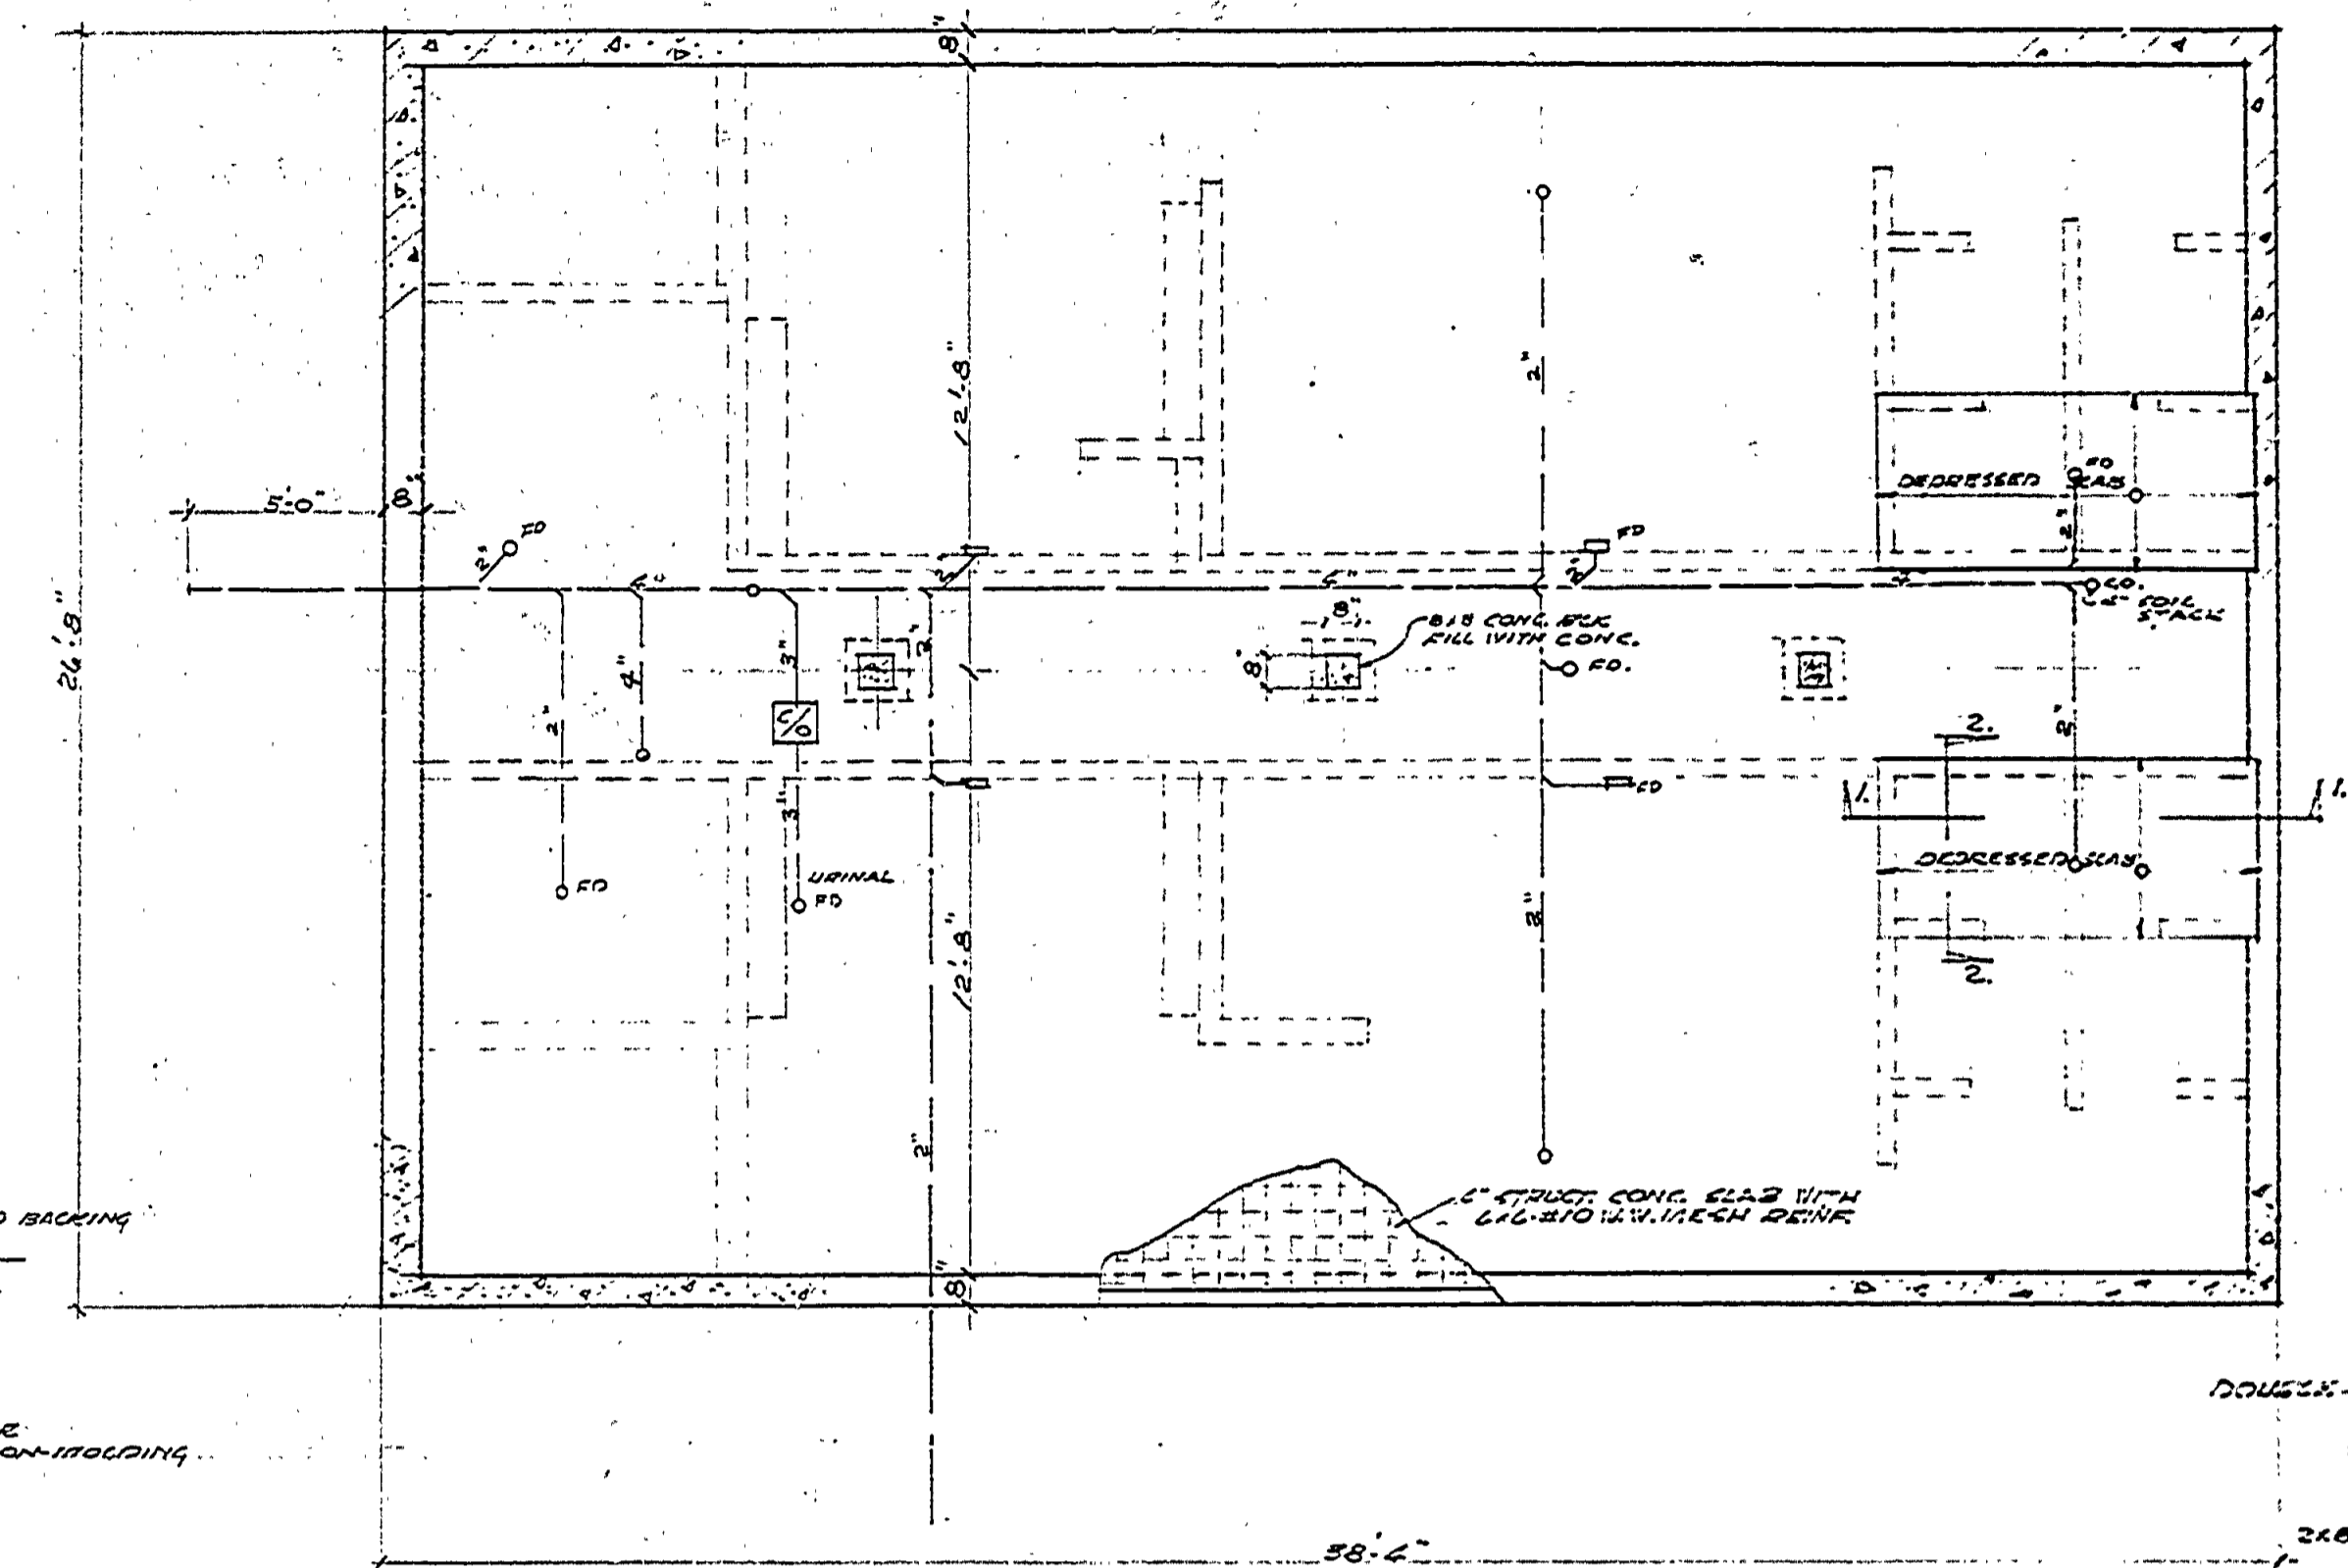

FOUNDATION AND PLUMBING PLAN
Scale 1/4\"/>

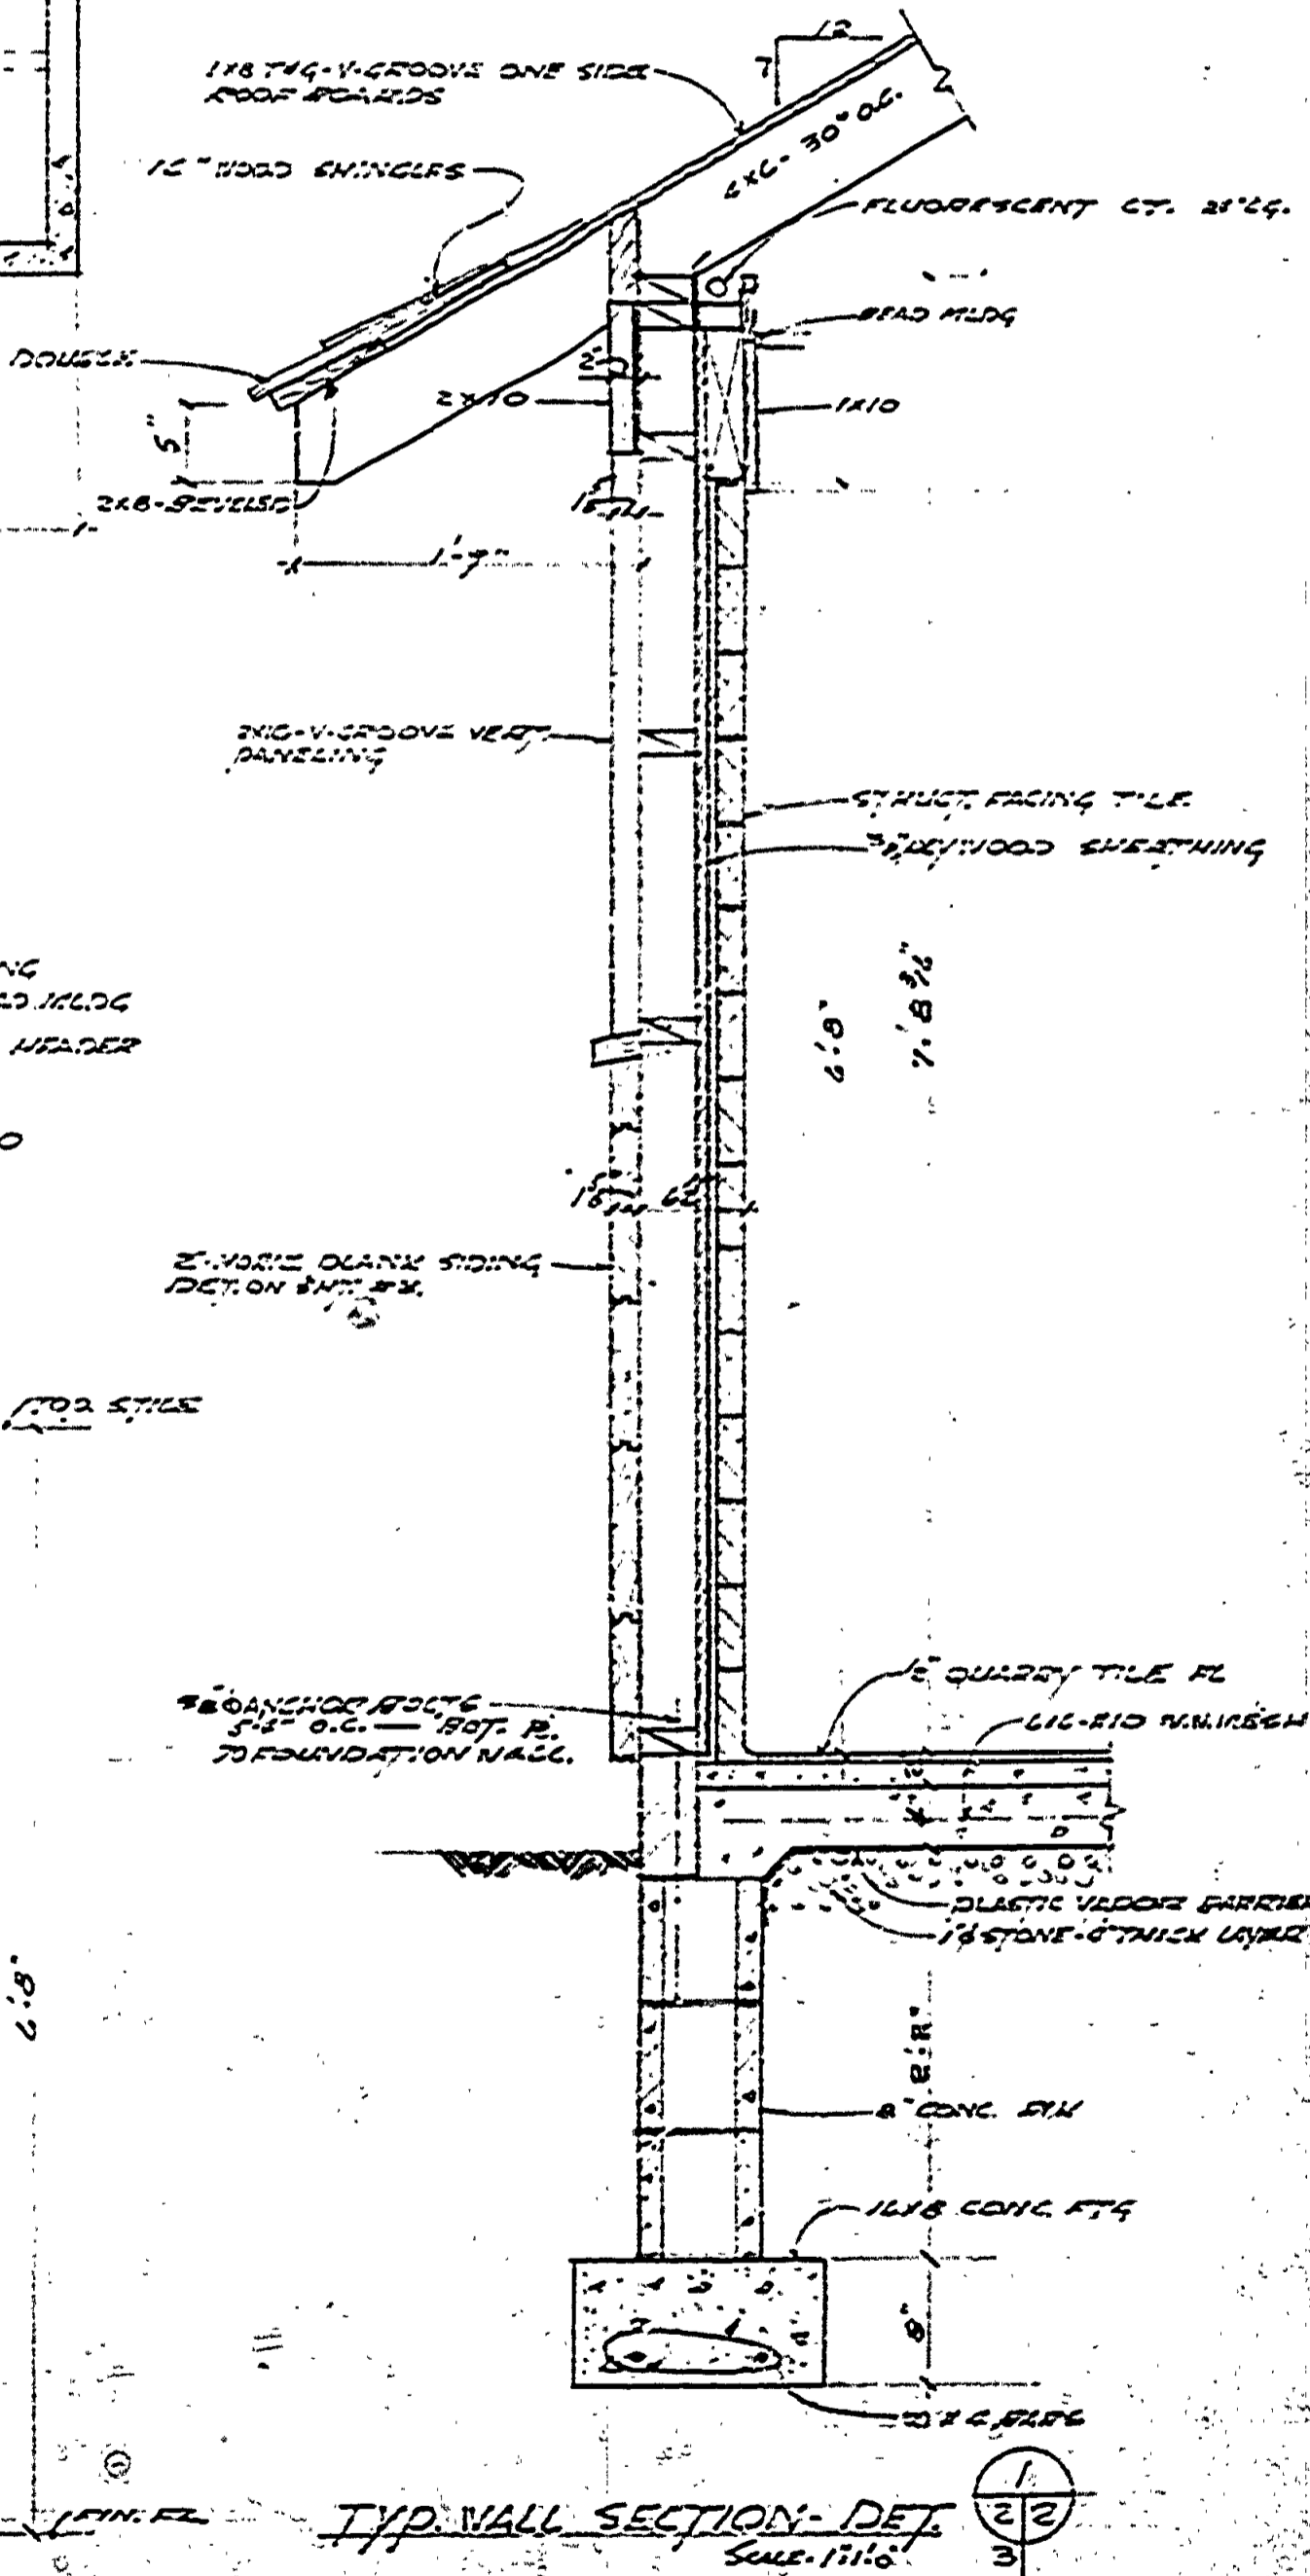
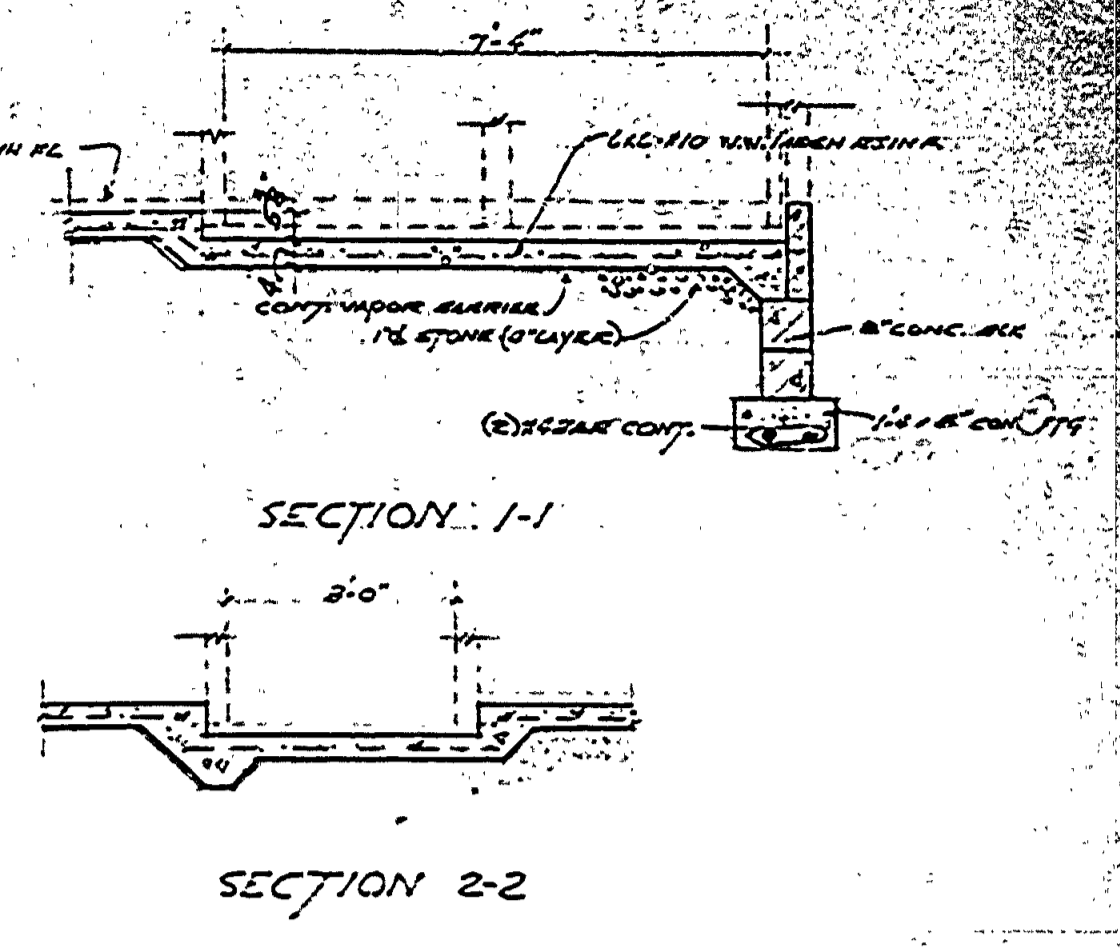


DET. SHELF & MIRROR (SHOWERS)
Scale 1/2\"/>

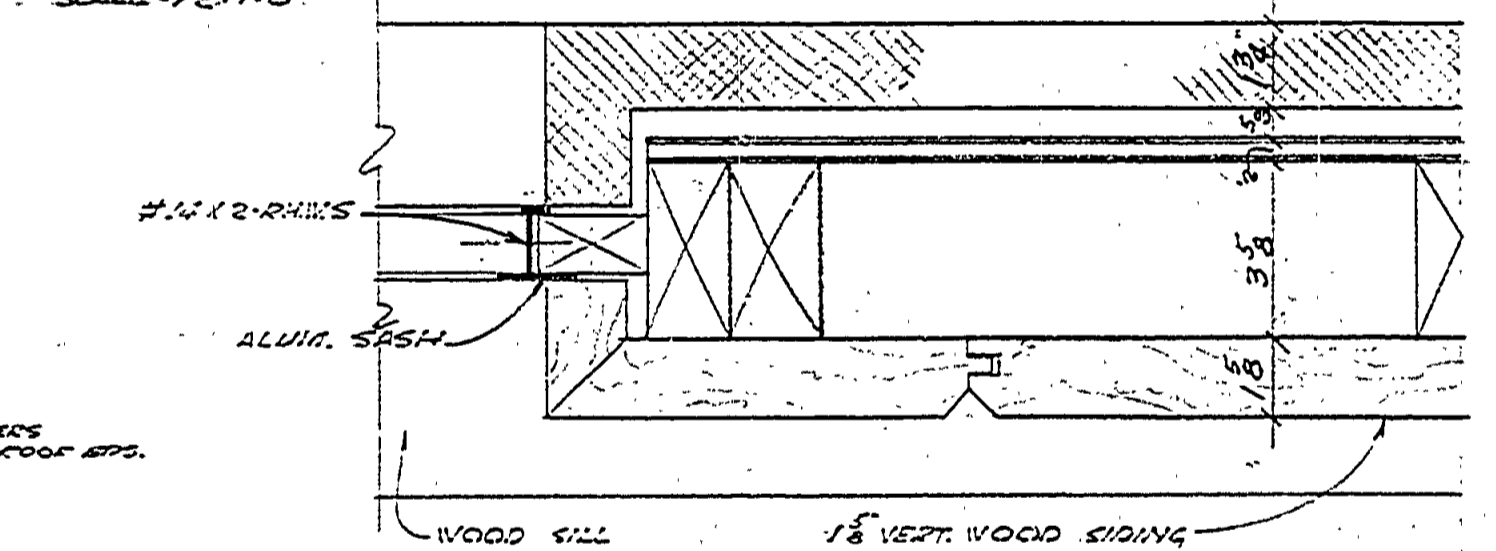


JAMB DET
Scale 5/16\"/>

HEAD DET
Scale 5/16\"/>

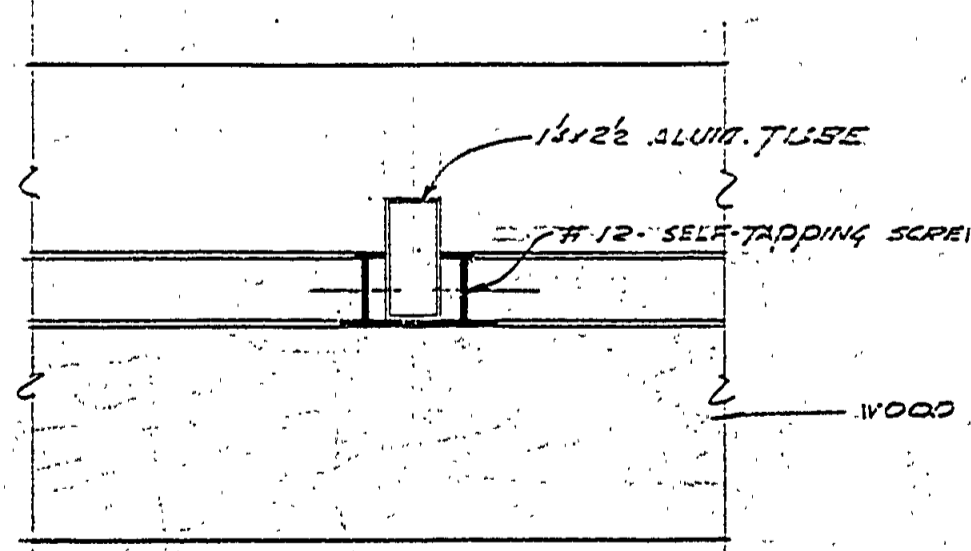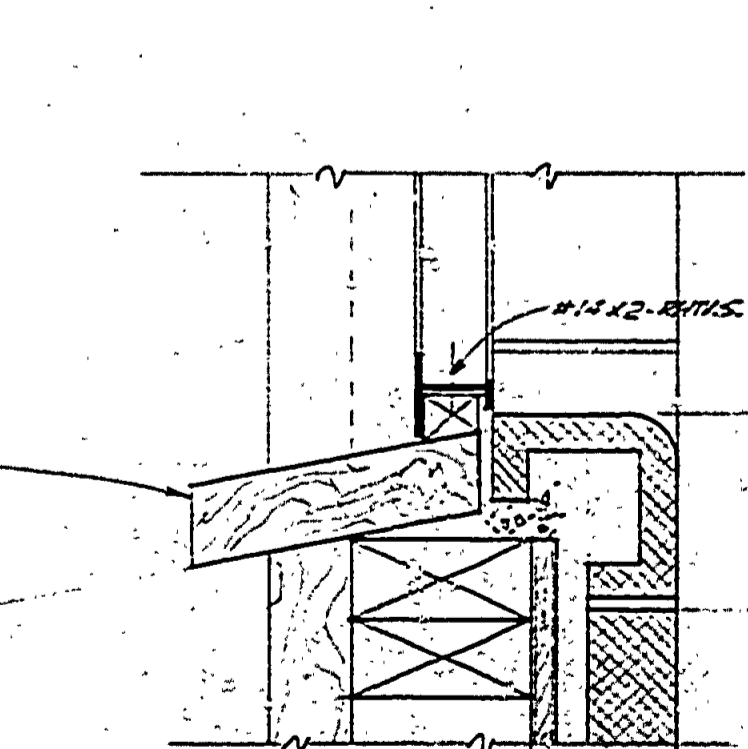


MULLION DET
Scale 5/16\"/>

 SILL DET
Scale 5/16\"/>



V.I.N.D.O.W. DETAILS

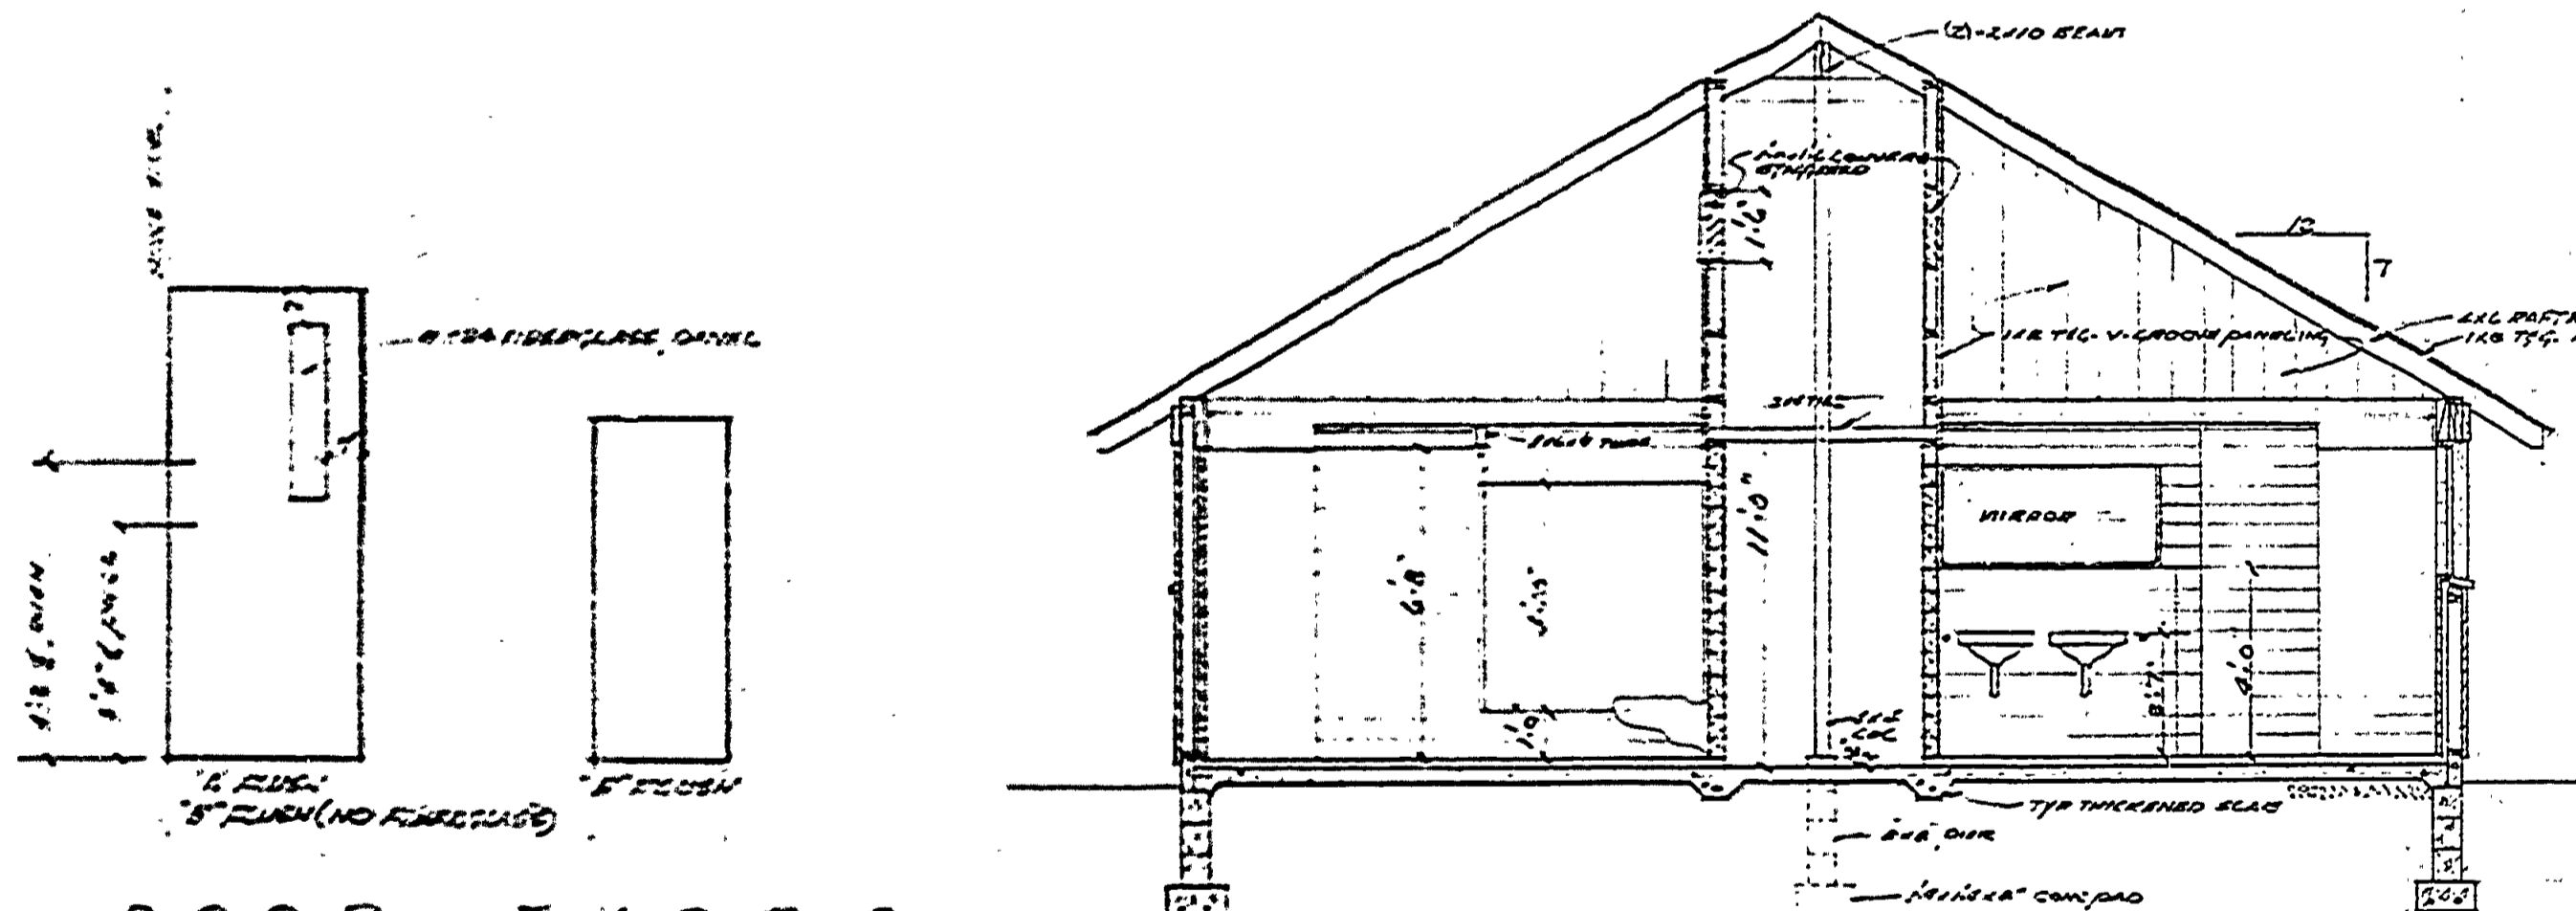

SECTION AA

FINISH	SCHEDULE										REMARKS	
	ROOF	WALL	WALL	WALL	WALL	WALL	WALL	WALL	WALL	WALL		
POOR												
WOMEN'S TOILET ROOM												
WOMEN'S SHOWER ROOM												
WOMEN'S SHOWER ROOM												
WOMEN'S SHOWER ROOM												
UTILITY ROOM												
HIDE ALLEY												

DESIGNATION	TYPE	SIZE	REMARKS	
			NO.	DESCRIPTION
1	A	16 22 69		FLUSH - SOLID CORE
2	A	16 22 69		"
3	B	16 22 69		"
4	A	16 22 69		"
5	S	17 12 62		TO MATCH TOILET
6	B	17 12 62		"
7	B	17 12 62		"
8	B	17 12 62		"

MICHIGAN DEPARTMENT OF CONSERVATION PARKS AND RECREATION DIVISION

INTERLOCHEN STATE PARK TOILET AND SHOWER BUILDING
SHEET NO. 2 OF 5
PLAN NO. A-108