

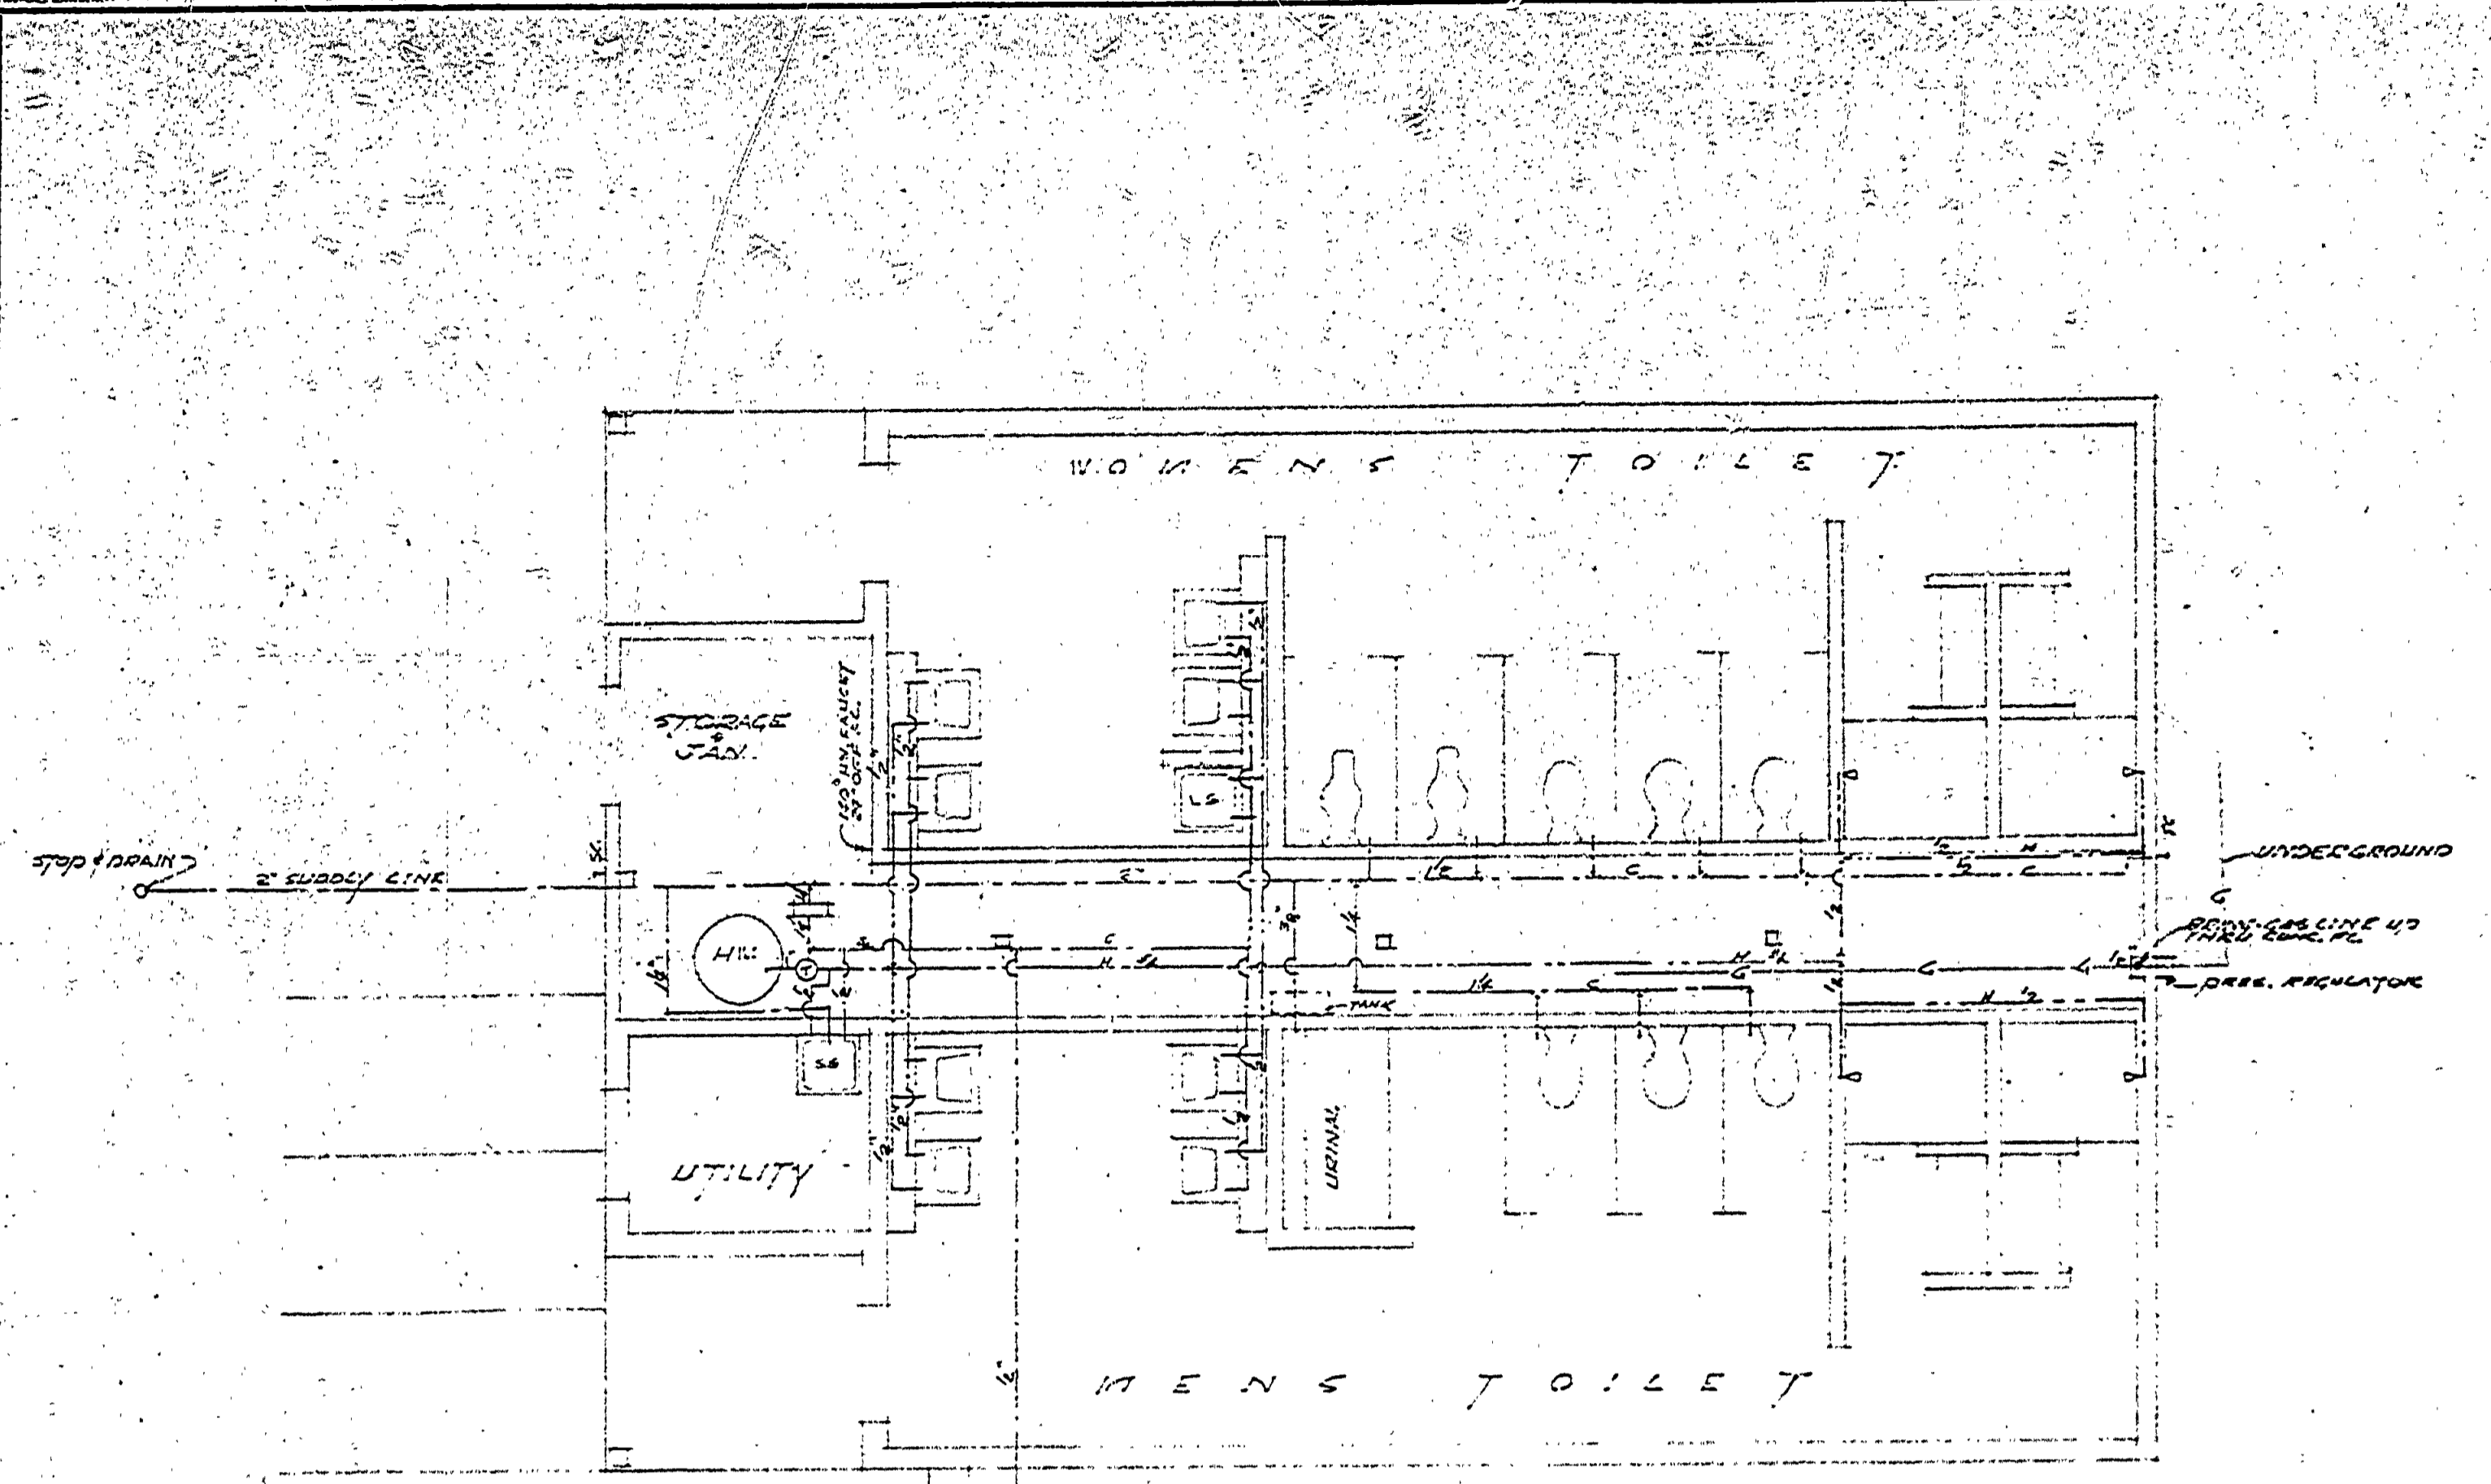



DATE	BY	REVISIONS
1-10-51	W.P.	1
1-23-51	W.P.	2
1-25-51	W.P.	3
3-20-51	W.P.	4
		5
		6

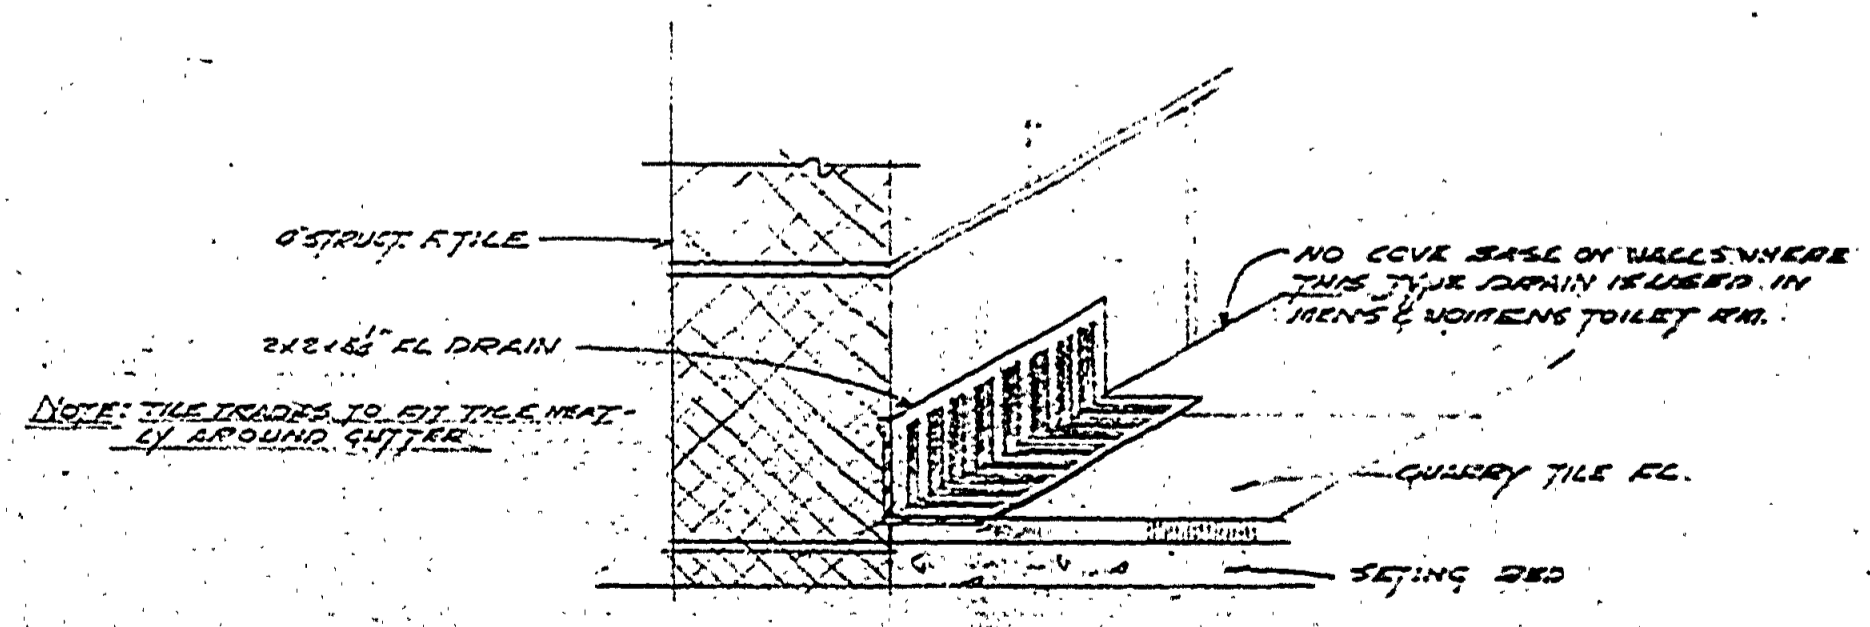


PLUMBING PLAN

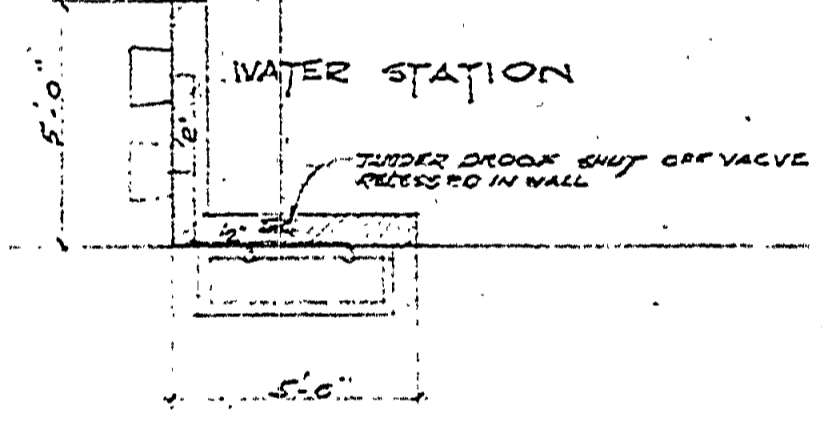


DET. OF GUTTER TYPE FL. DRAIN (REV'D)

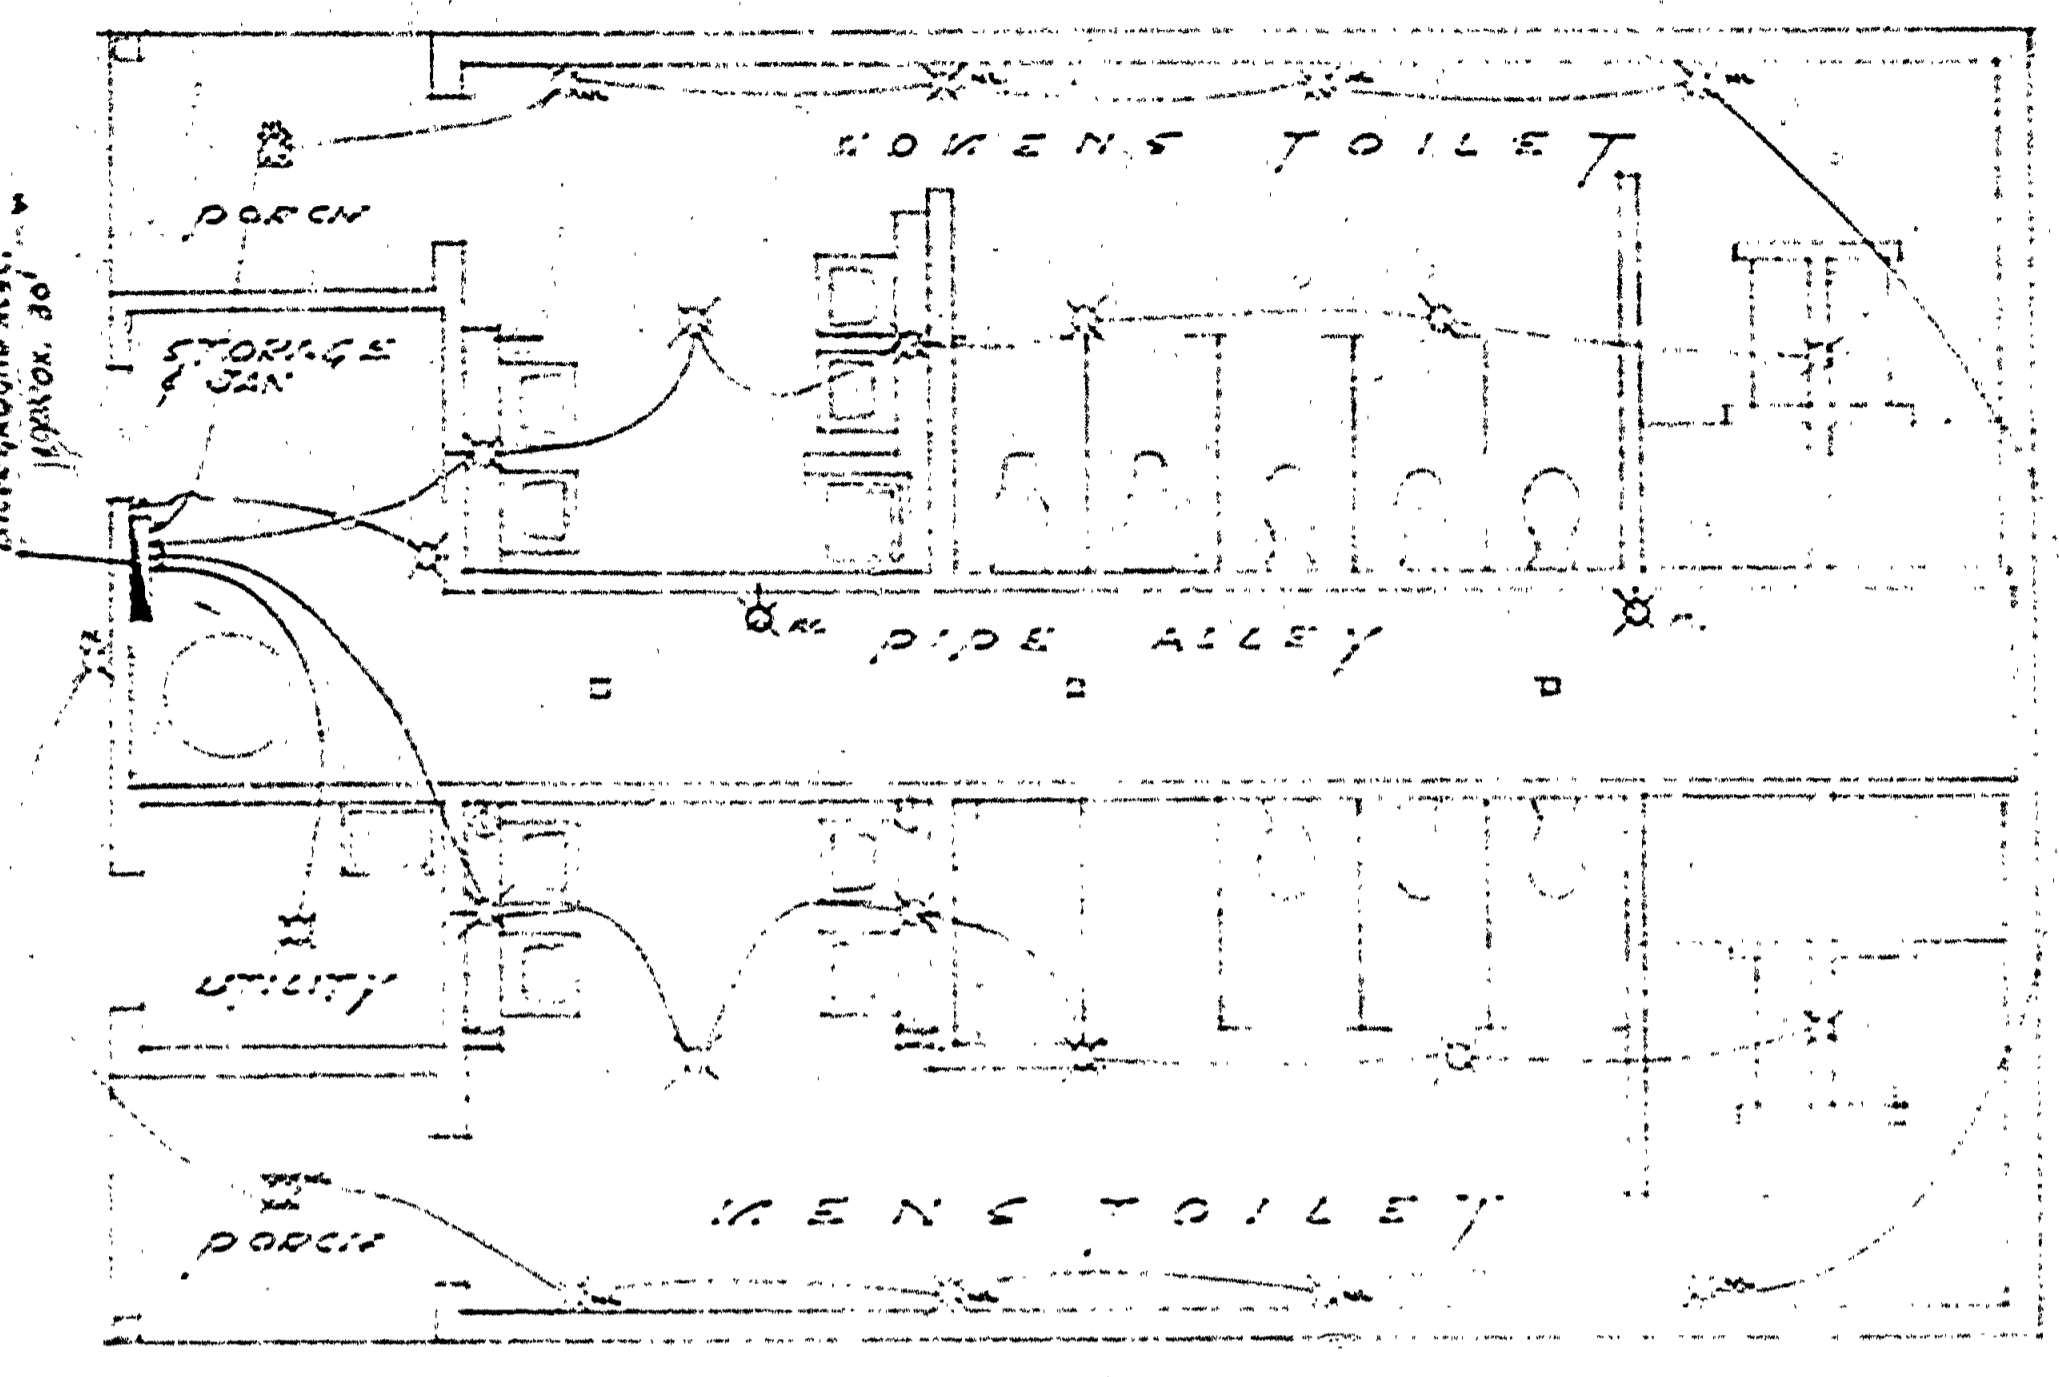


ELECTRICAL PLAN

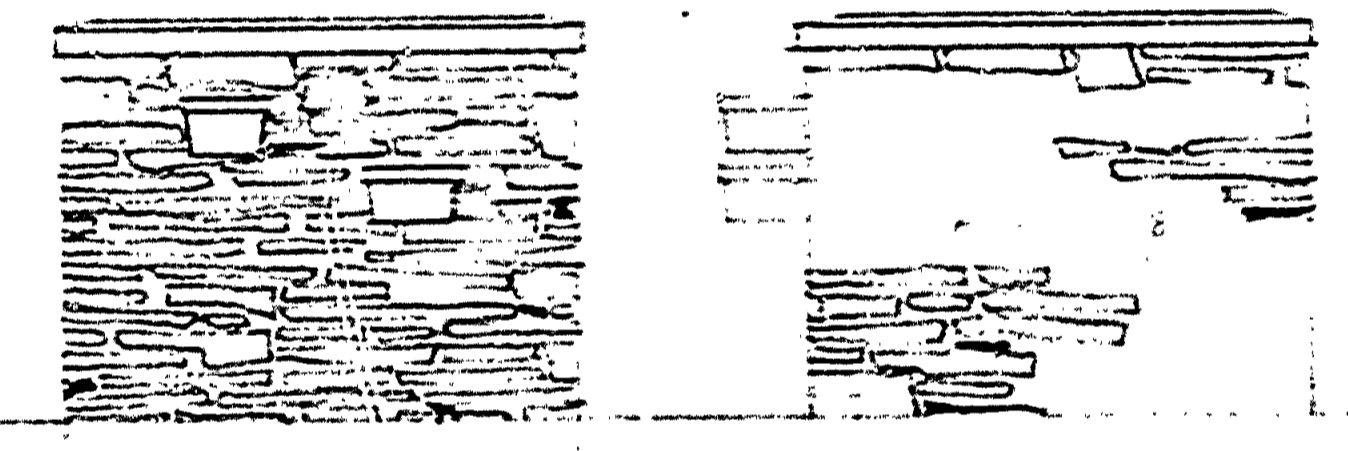


WATER STATION ELEVATIONS

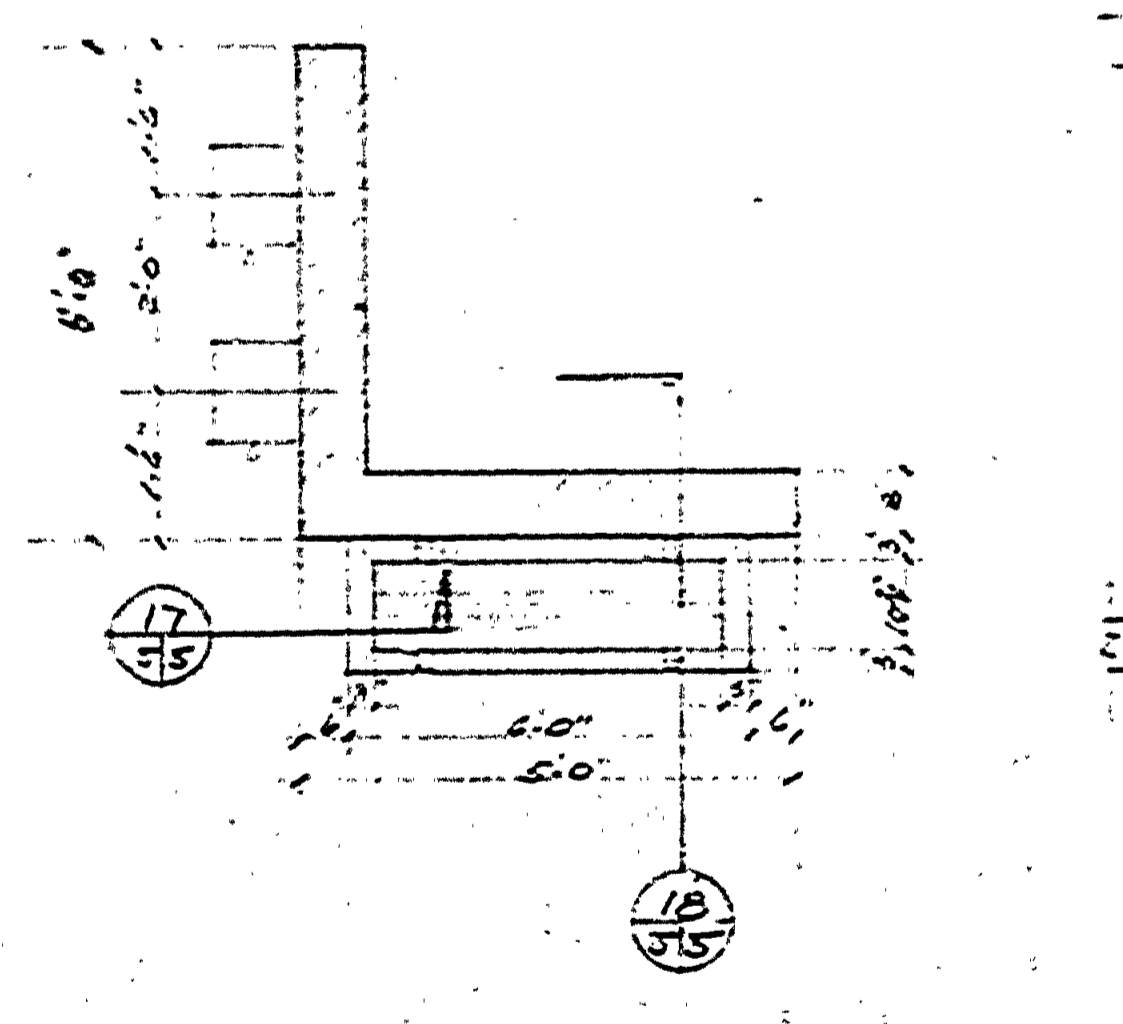


PLAN SECTION-WATER STATION

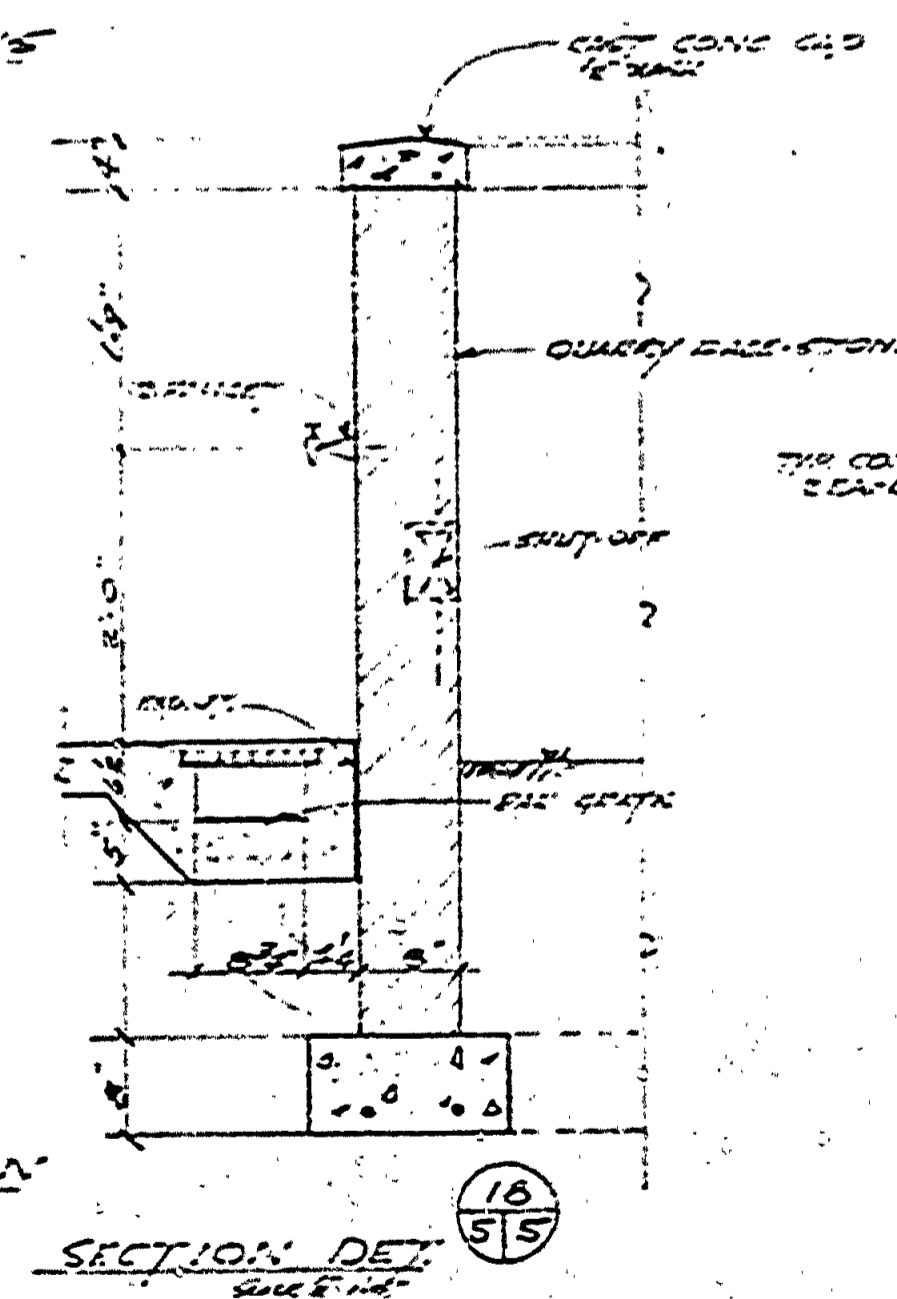

SECTION DET.

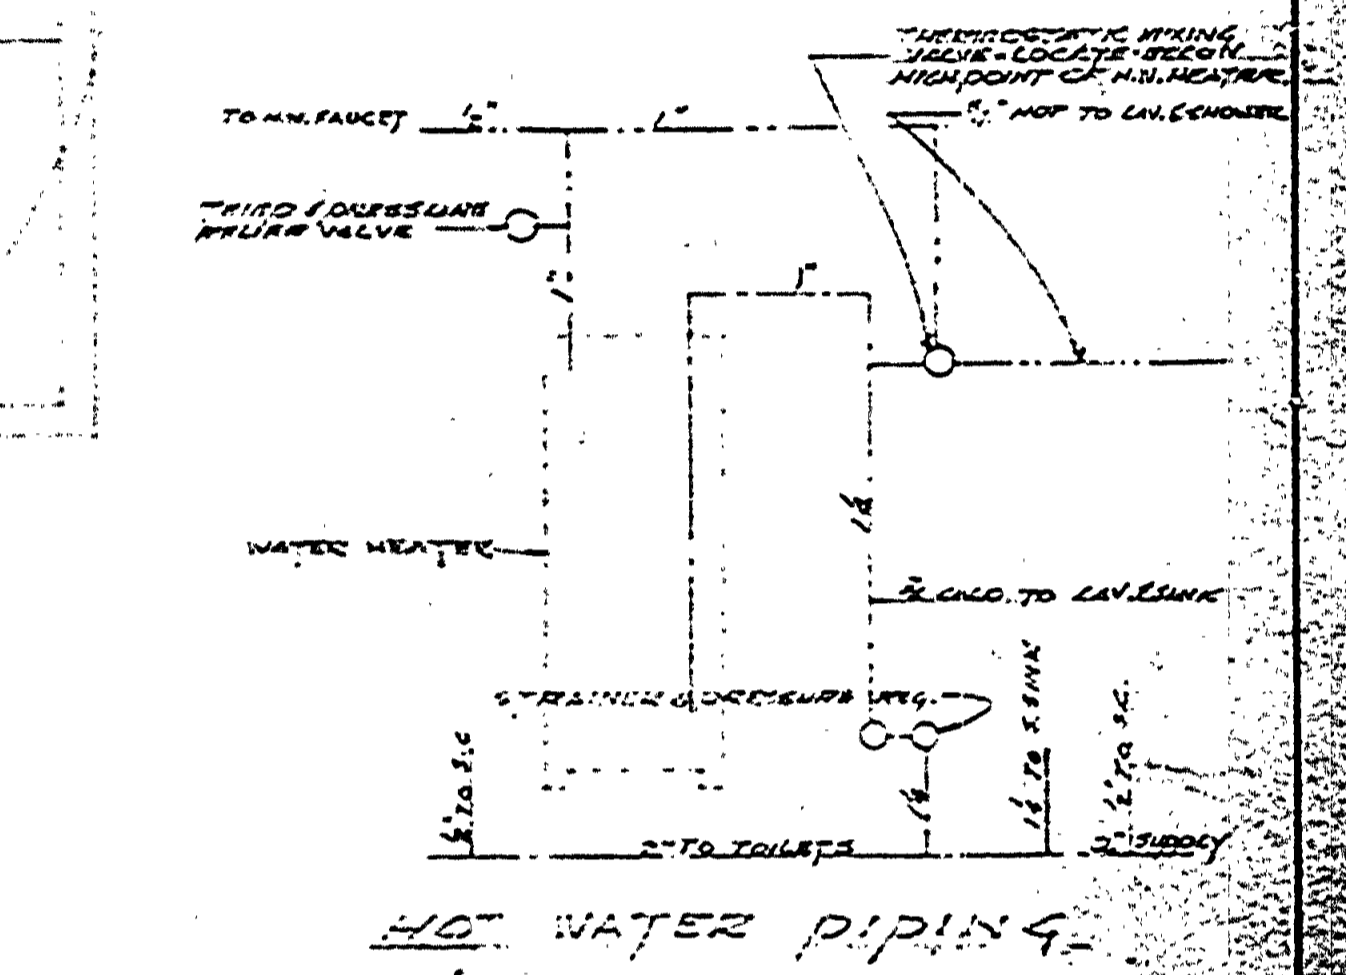

HIGH WATER PIPING

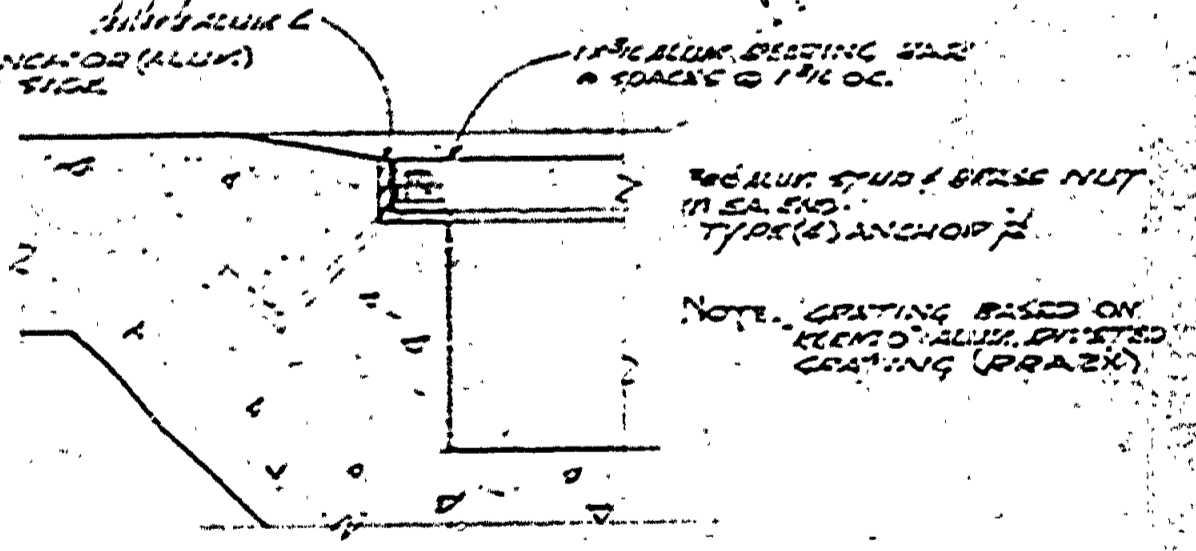

SECTION DET.

MICHIGAN DEPARTMENT OF CONSERVATION PARKS AND RECREATION DIVISION

ELECTRICAL-PLUMBING-DETAILS

INTELOCHEN STATE PARK TOILET AND SHOWER BUILDING

SHEET NO. 5	PLAN NO. 1108
-------------	---------------