

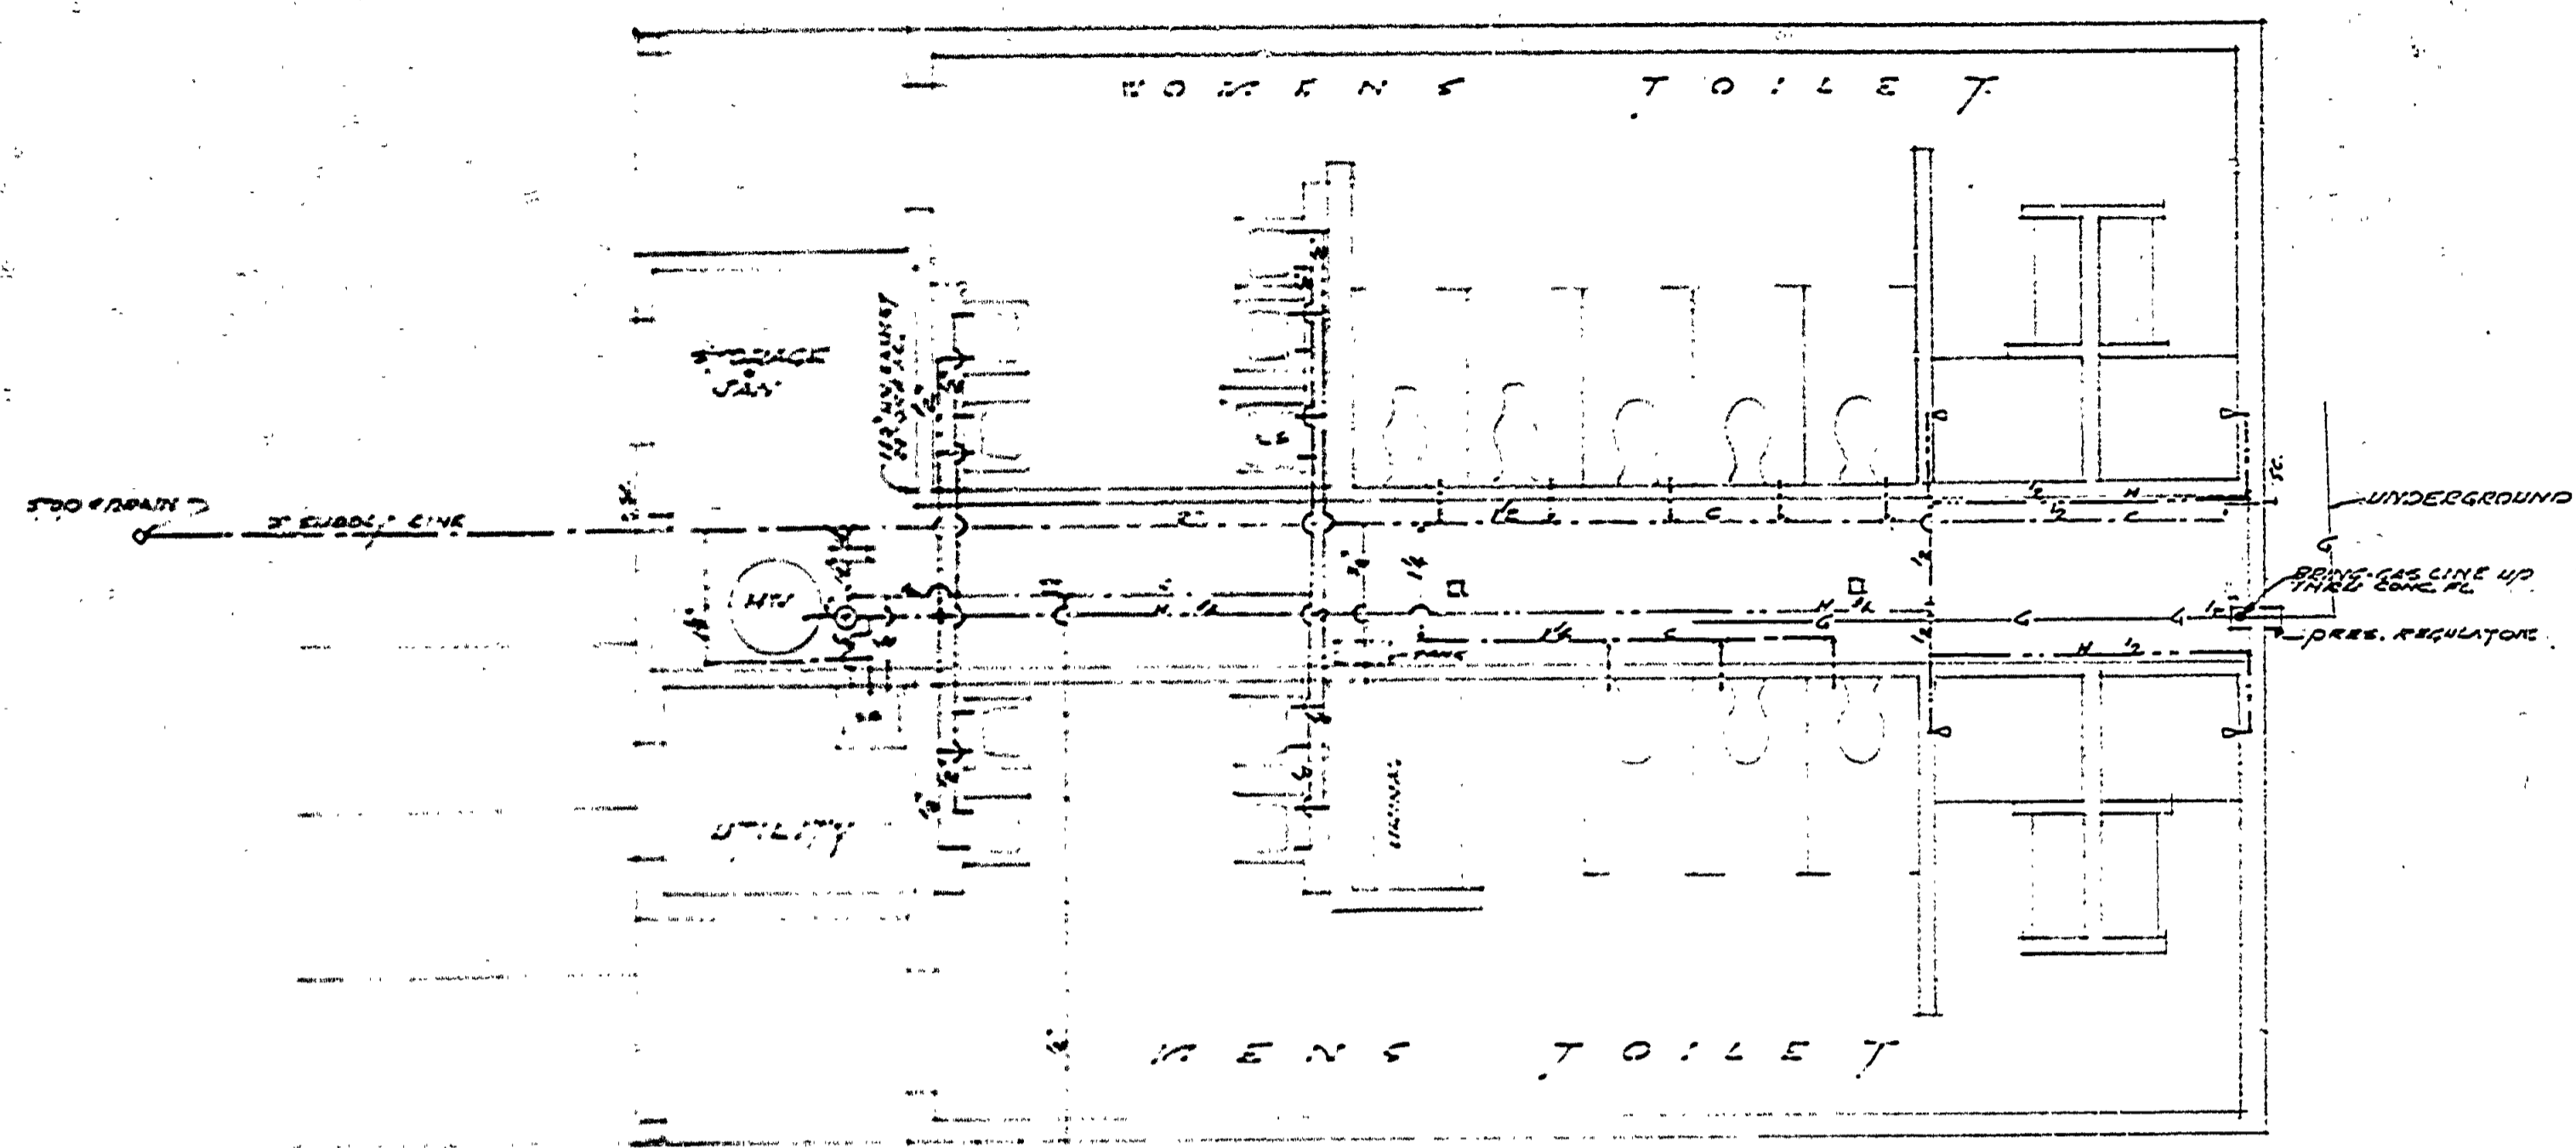



DESIGNED BY	DRAWN BY	CHECKED BY	DATE	REVIEWED	DATE	APPROVED	DATE NO.	DATE BY	REVISIONS	DATE BY
W.H.G.	W.H.G.	W.H.G.	1-11-51	ARCHITECTURAL	1-11-51	[Signature]	1	1-11-51	4	1-11-51
			1-11-51	ENGINEERING	1-11-51	[Signature]	2	1-11-51	5	1-11-51
			1-11-51	LANDSCAPE	1-11-51	[Signature]	3	1-11-51	6	1-11-51

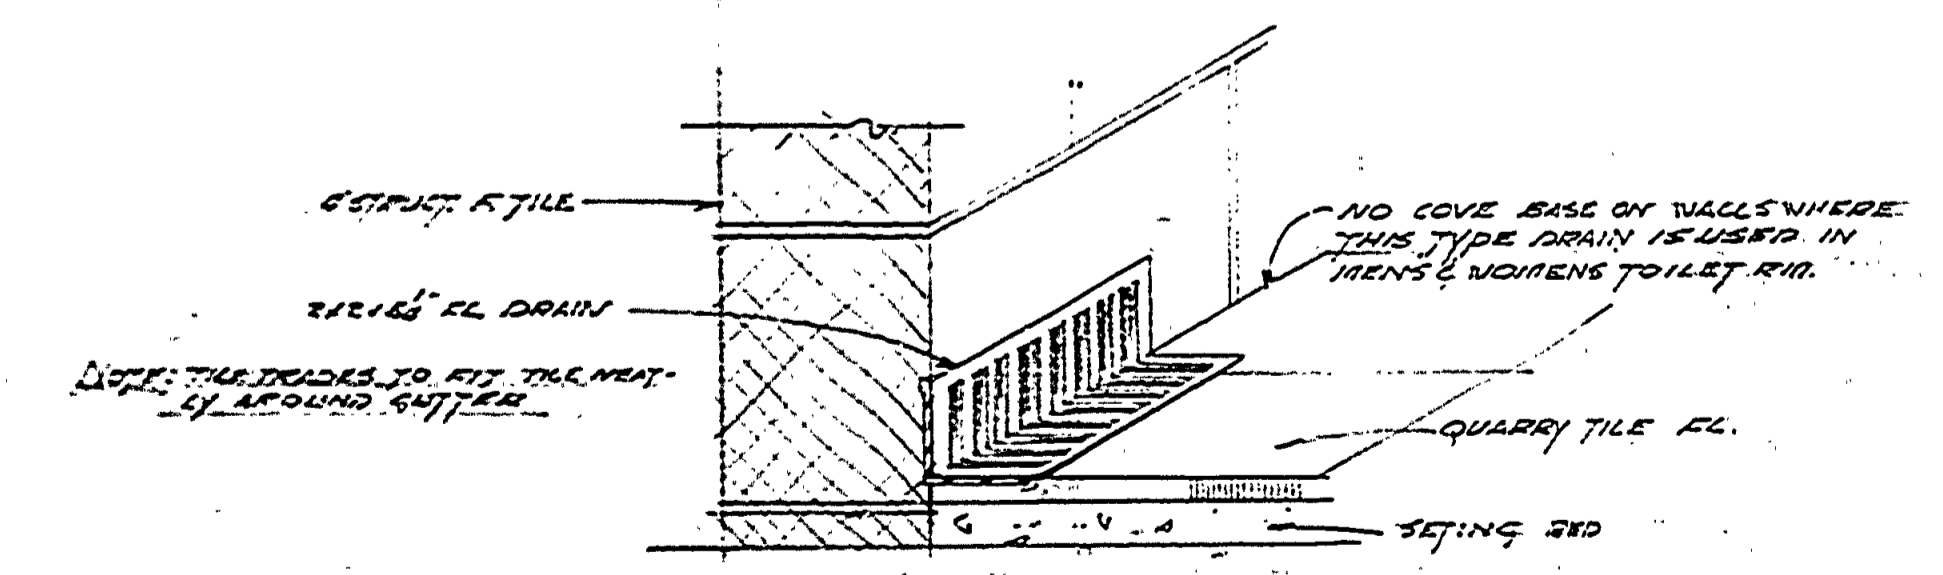


PLUMBING PLAN

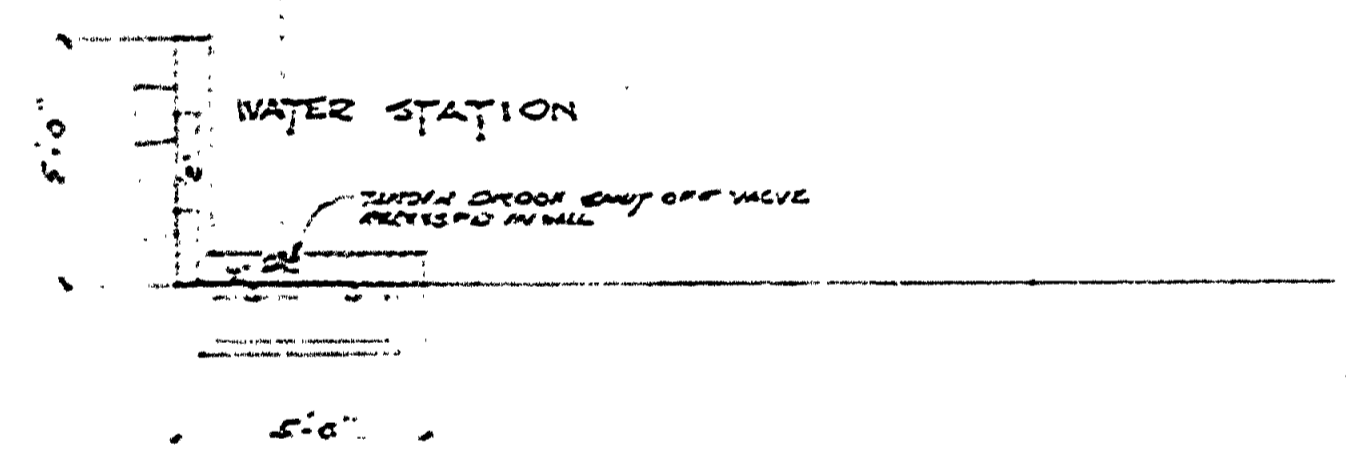


DET. OF GUTTER TYPE FL. DRAIN (AREA 10)

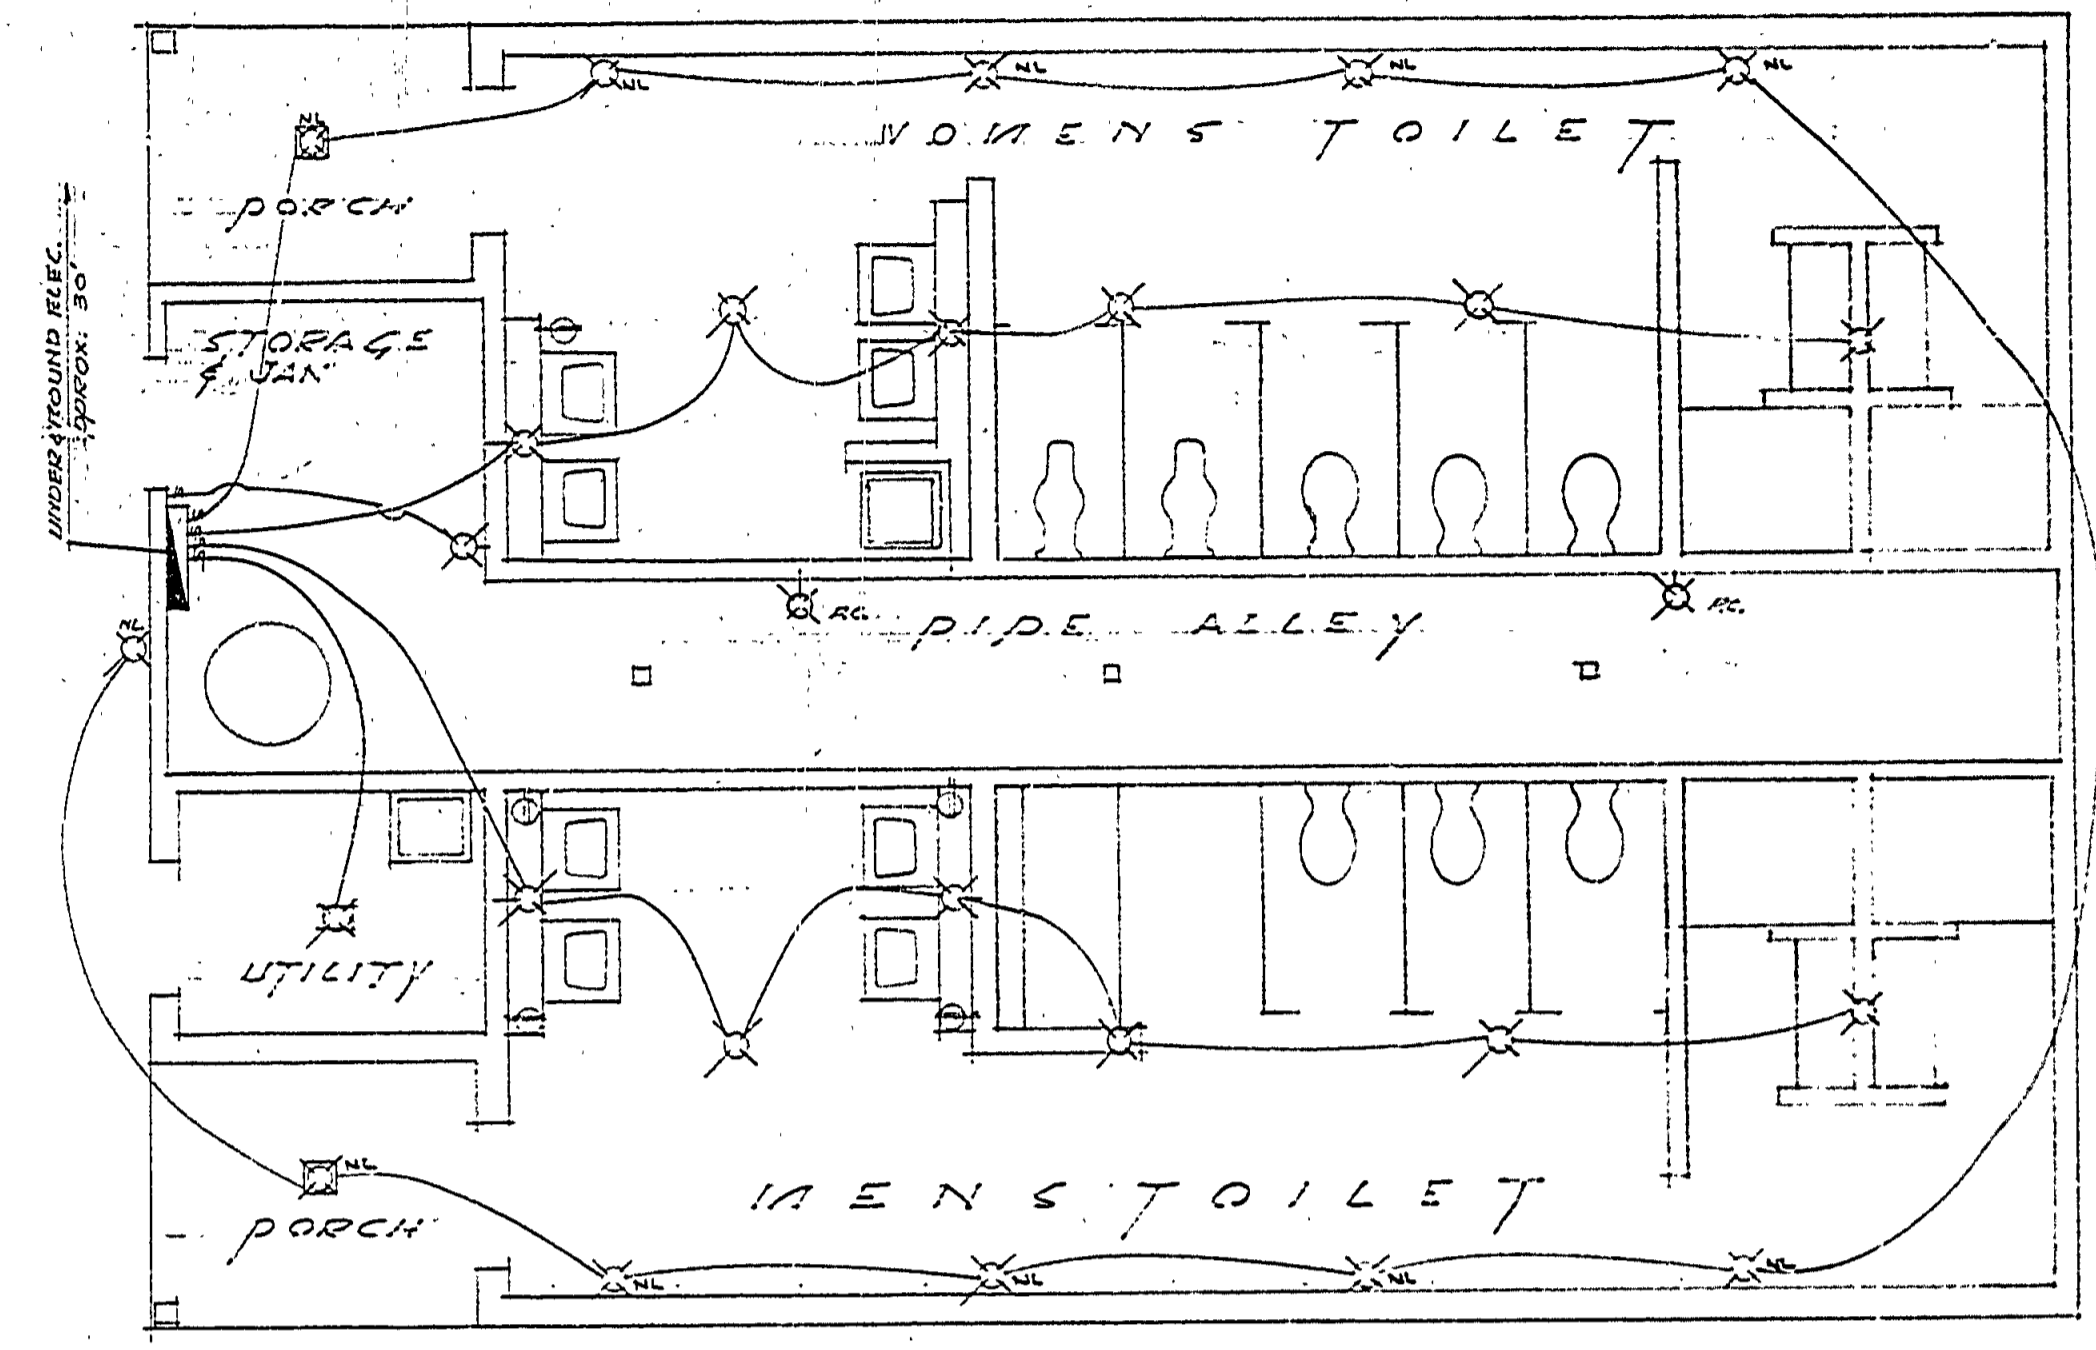


ELECTRICAL PLAN

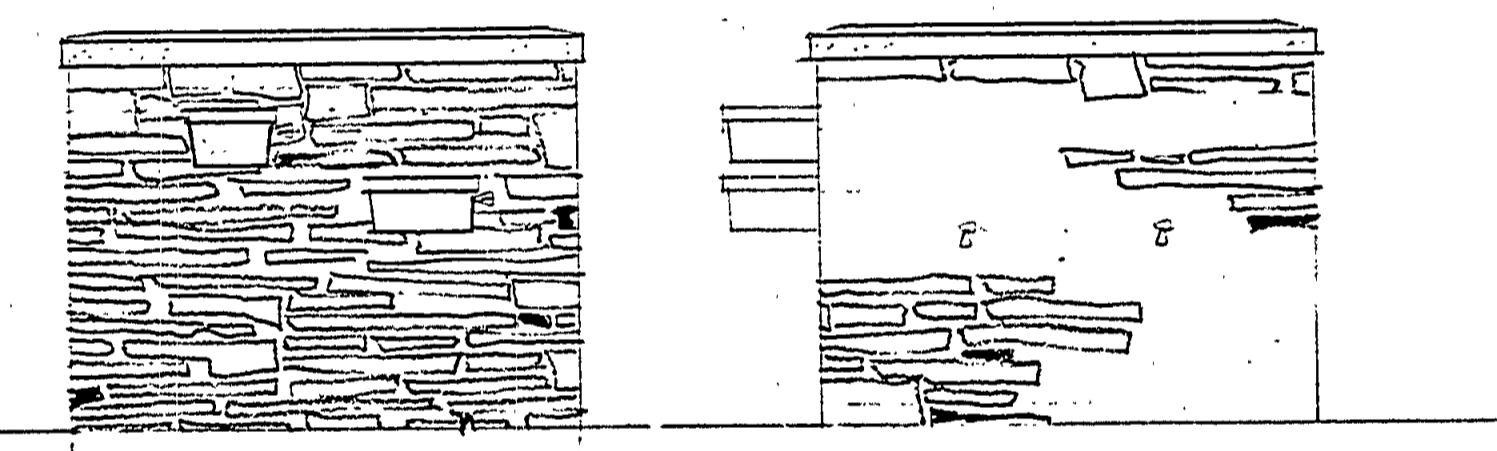


WATER STATION ELEVATIONS

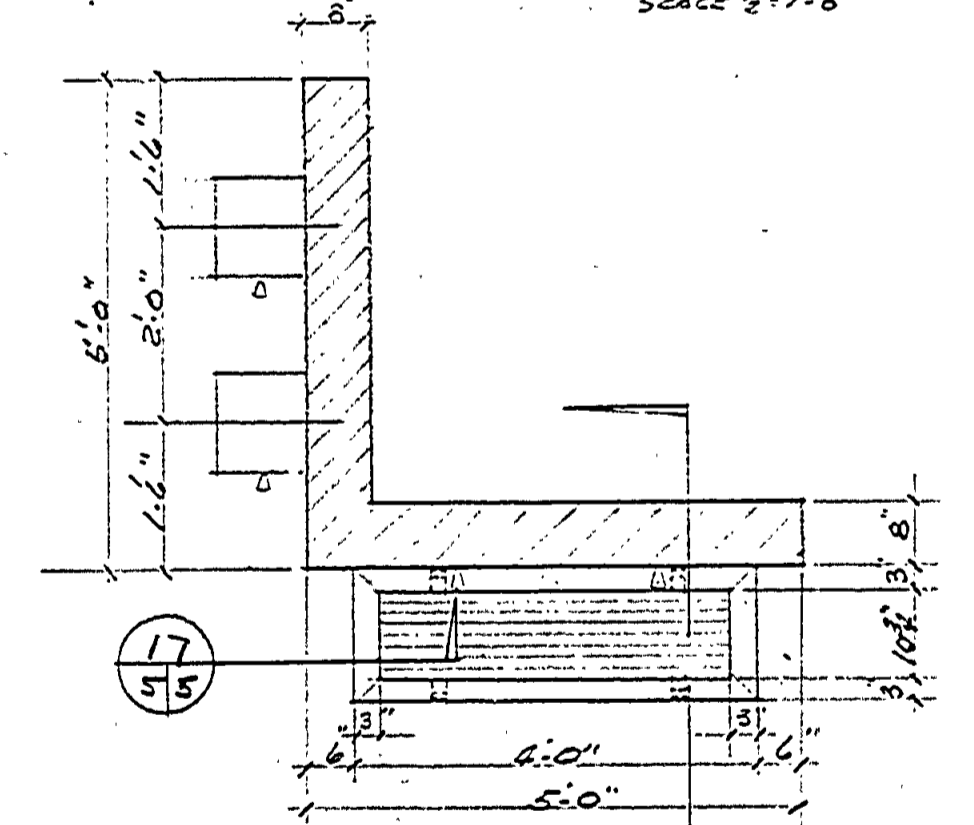


PLAN SECTION-WATER STATION

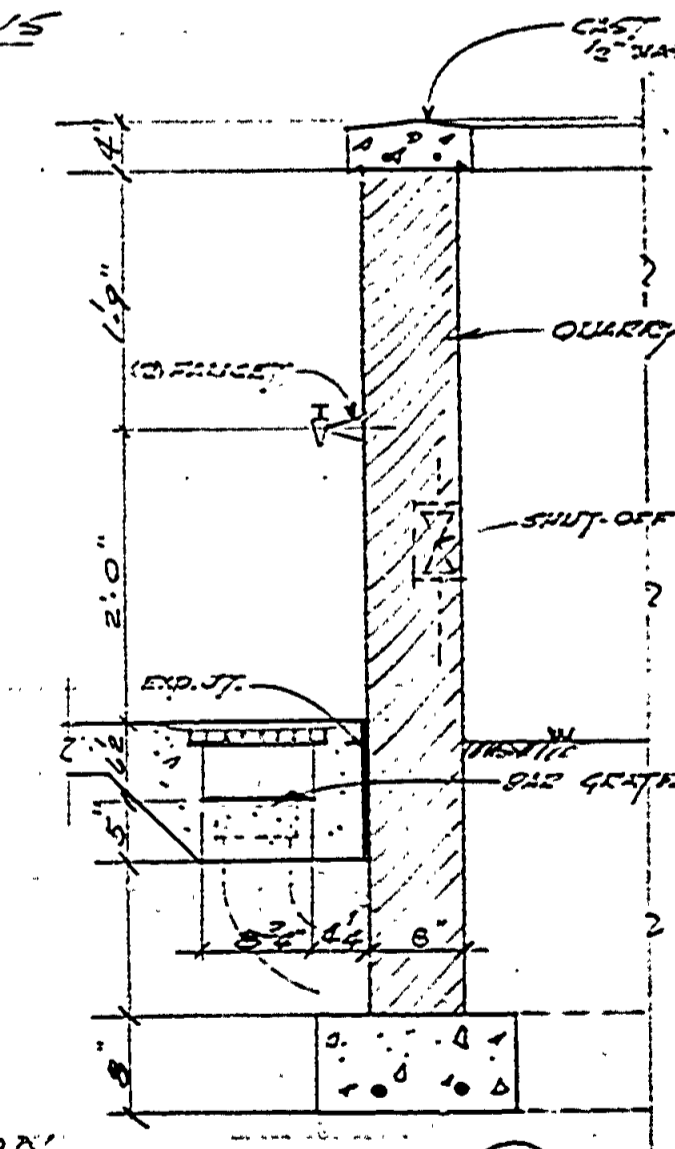

SECTION DET.

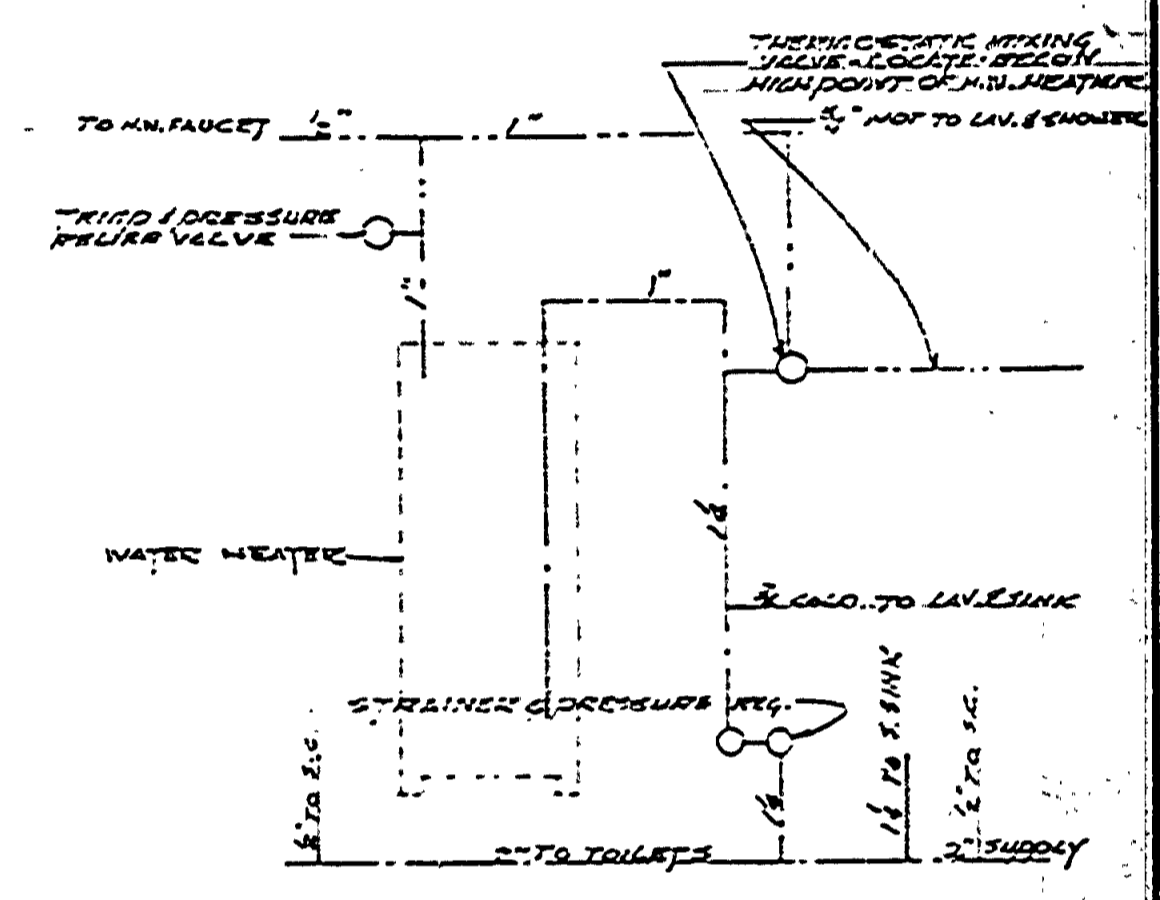

HOT WATER PIPING

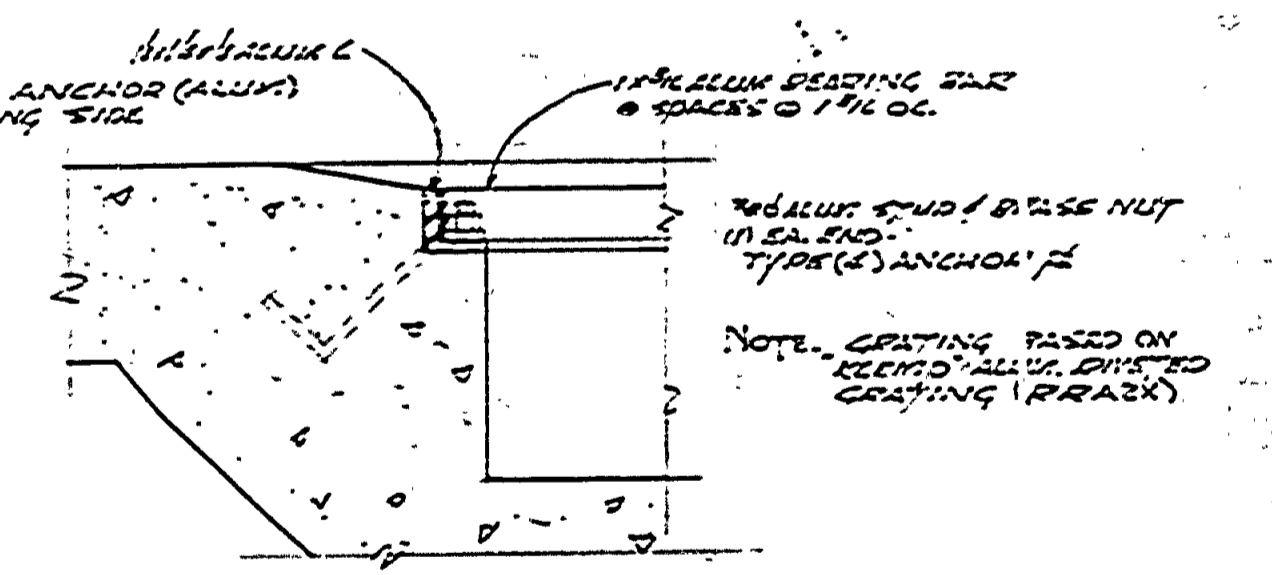

SECTION DET.

ELECTRICAL-PLUMBING-DETAILS		PLAN NO.	
INTERLOCHEN STATE PARK		NO. 5	1A/108
TOILET AND SHOWER BUILDING		OF 5	

MICHIGAN DEPARTMENT OF CONSERVATION PARKS AND RECREATION DIVISION