


TOILET AND SHOWER BUILDING

P. H. HOEFT STATE PARK


PROJ. NO. 975-34-61

Richard Edward Pyle
CHIEF, PARKS & RECREATION DIVISION


DESIGNED BY	DATE	REVIEWED	DATE	APPROVED	DATE	NO.	DATE	BY	REVISIONS
W. J. G.	2/11/61	ARCHITECTURAL	2/11/61			1			4
W. C. P.	7/24/61	ENGINEERING	8/2/61			2			5
M. C.	8/11/61	LANDSCAPE	8/23/61	<i>Richard E. Pyle</i>	8-23-61	3			6

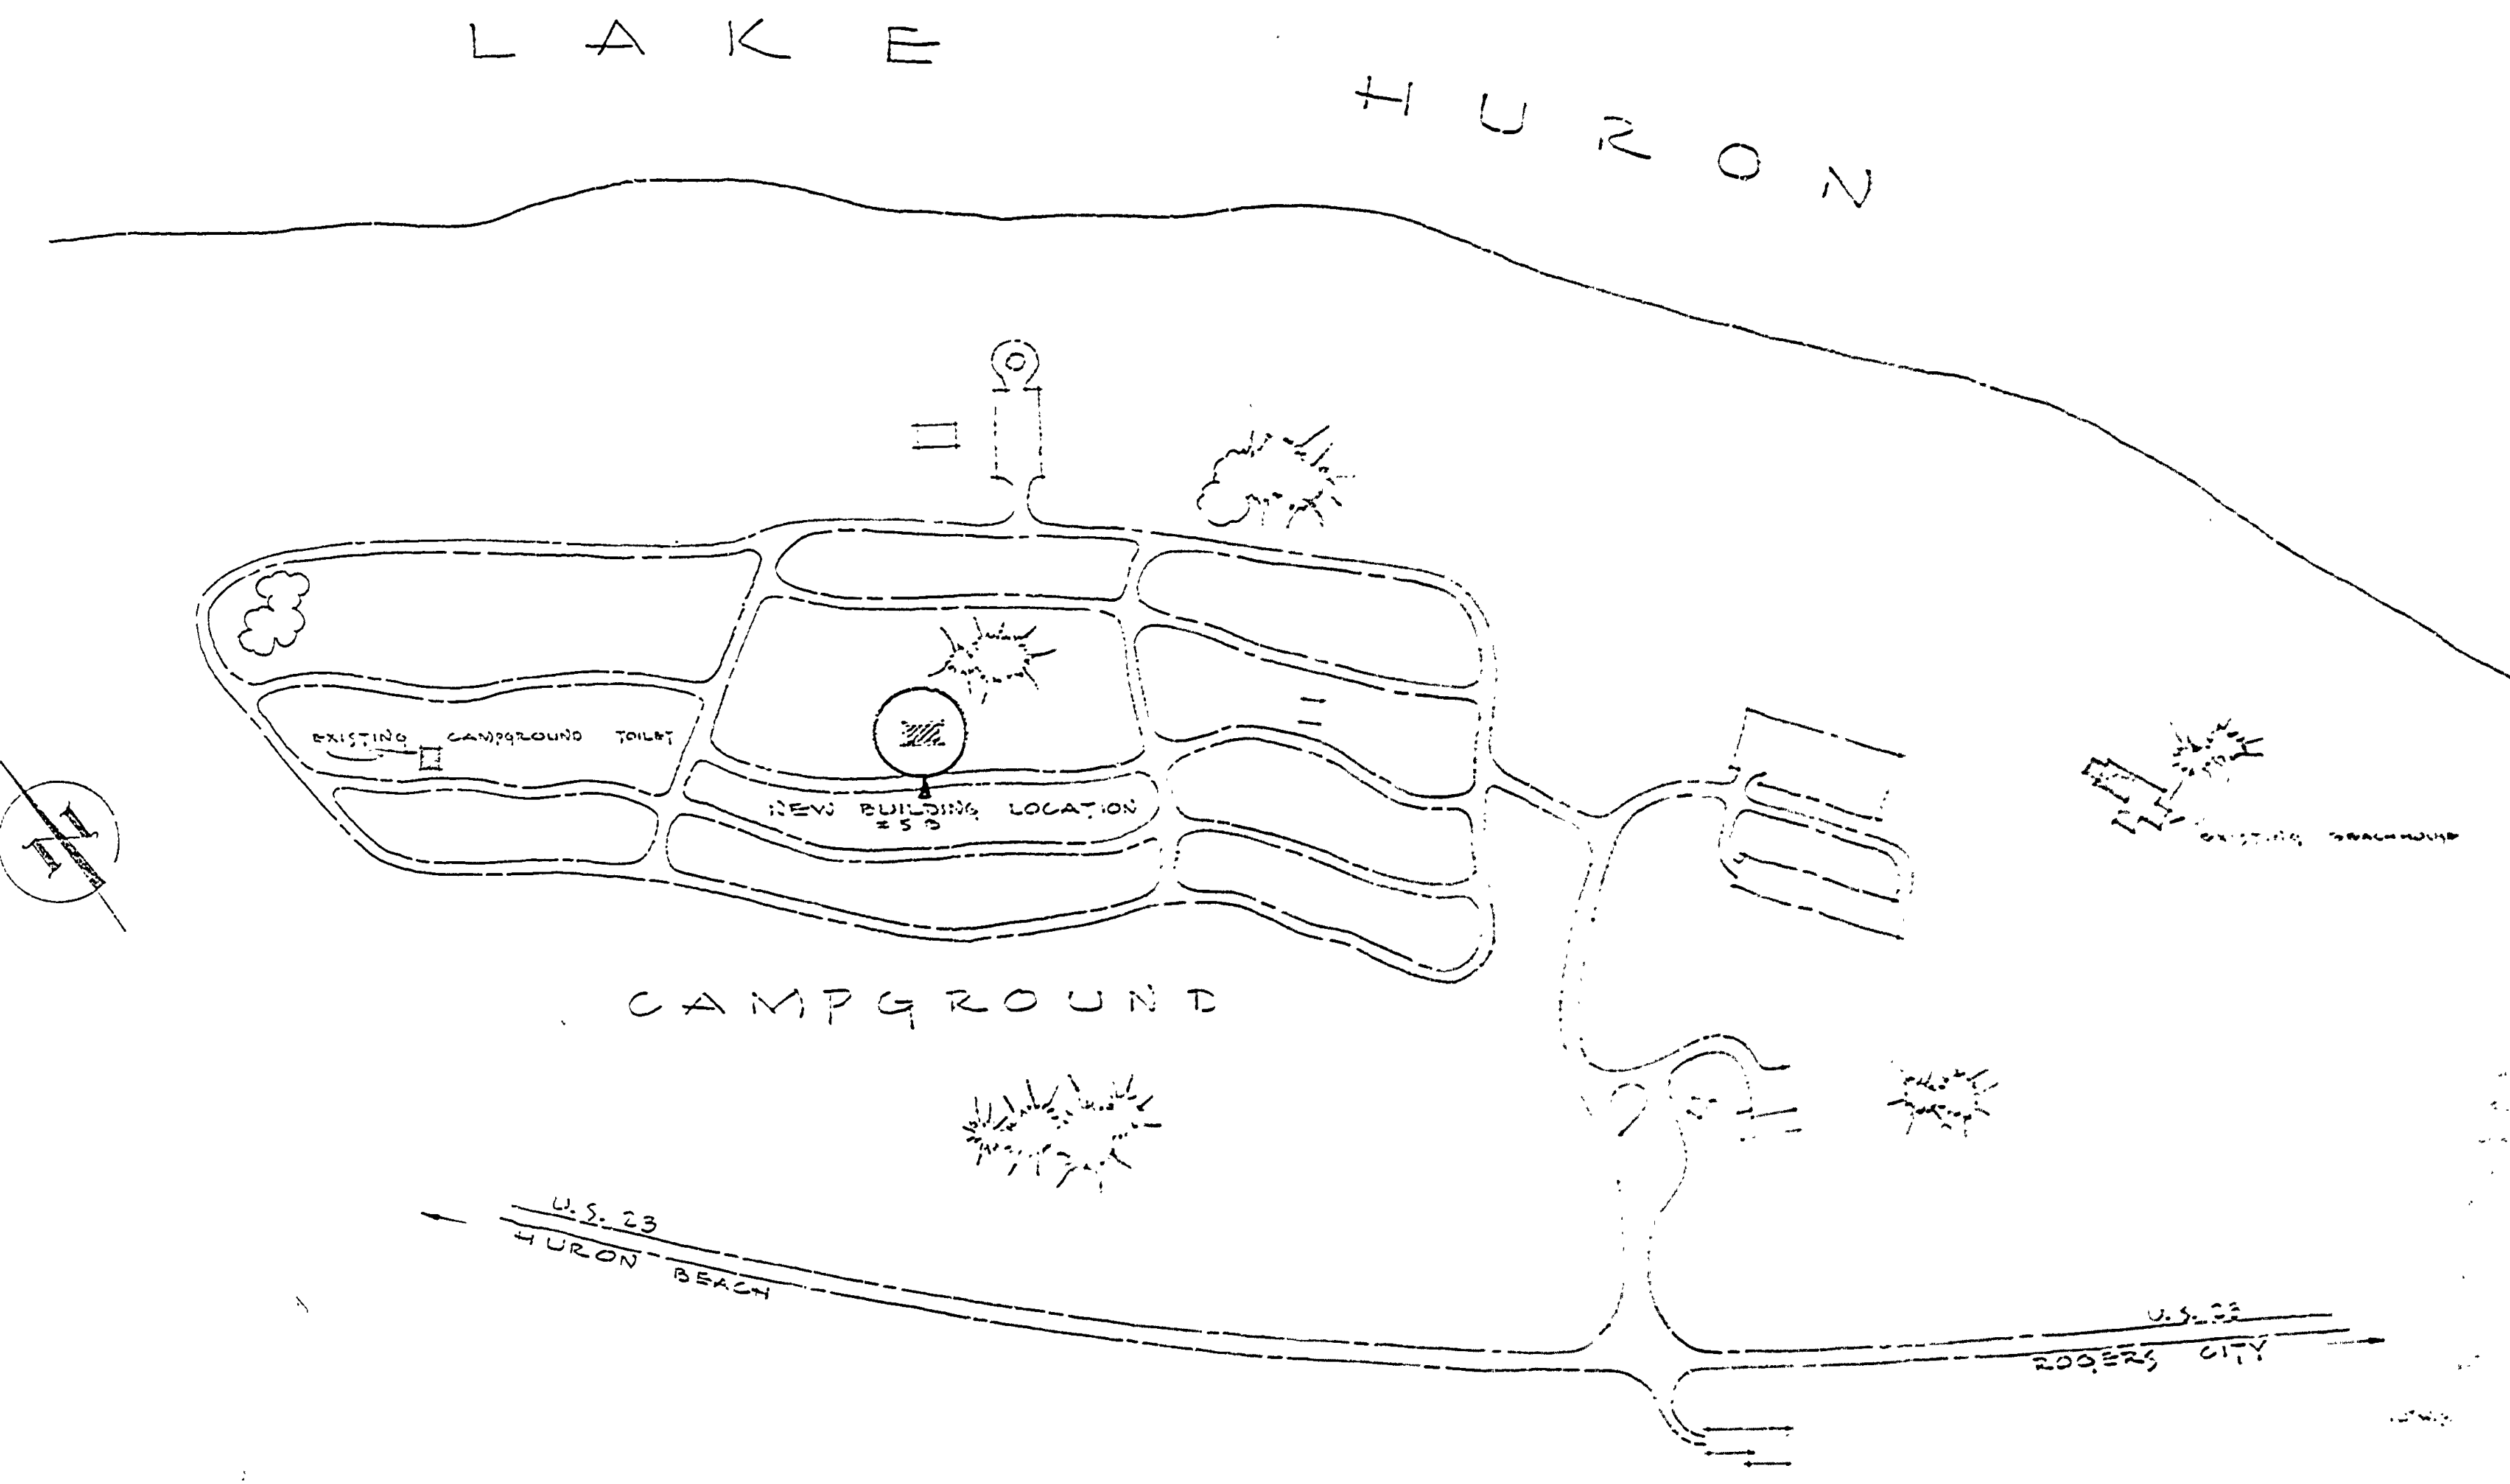

BUILDING LOCATION PLAN
SCALE: 1 INCH = 200 FEET

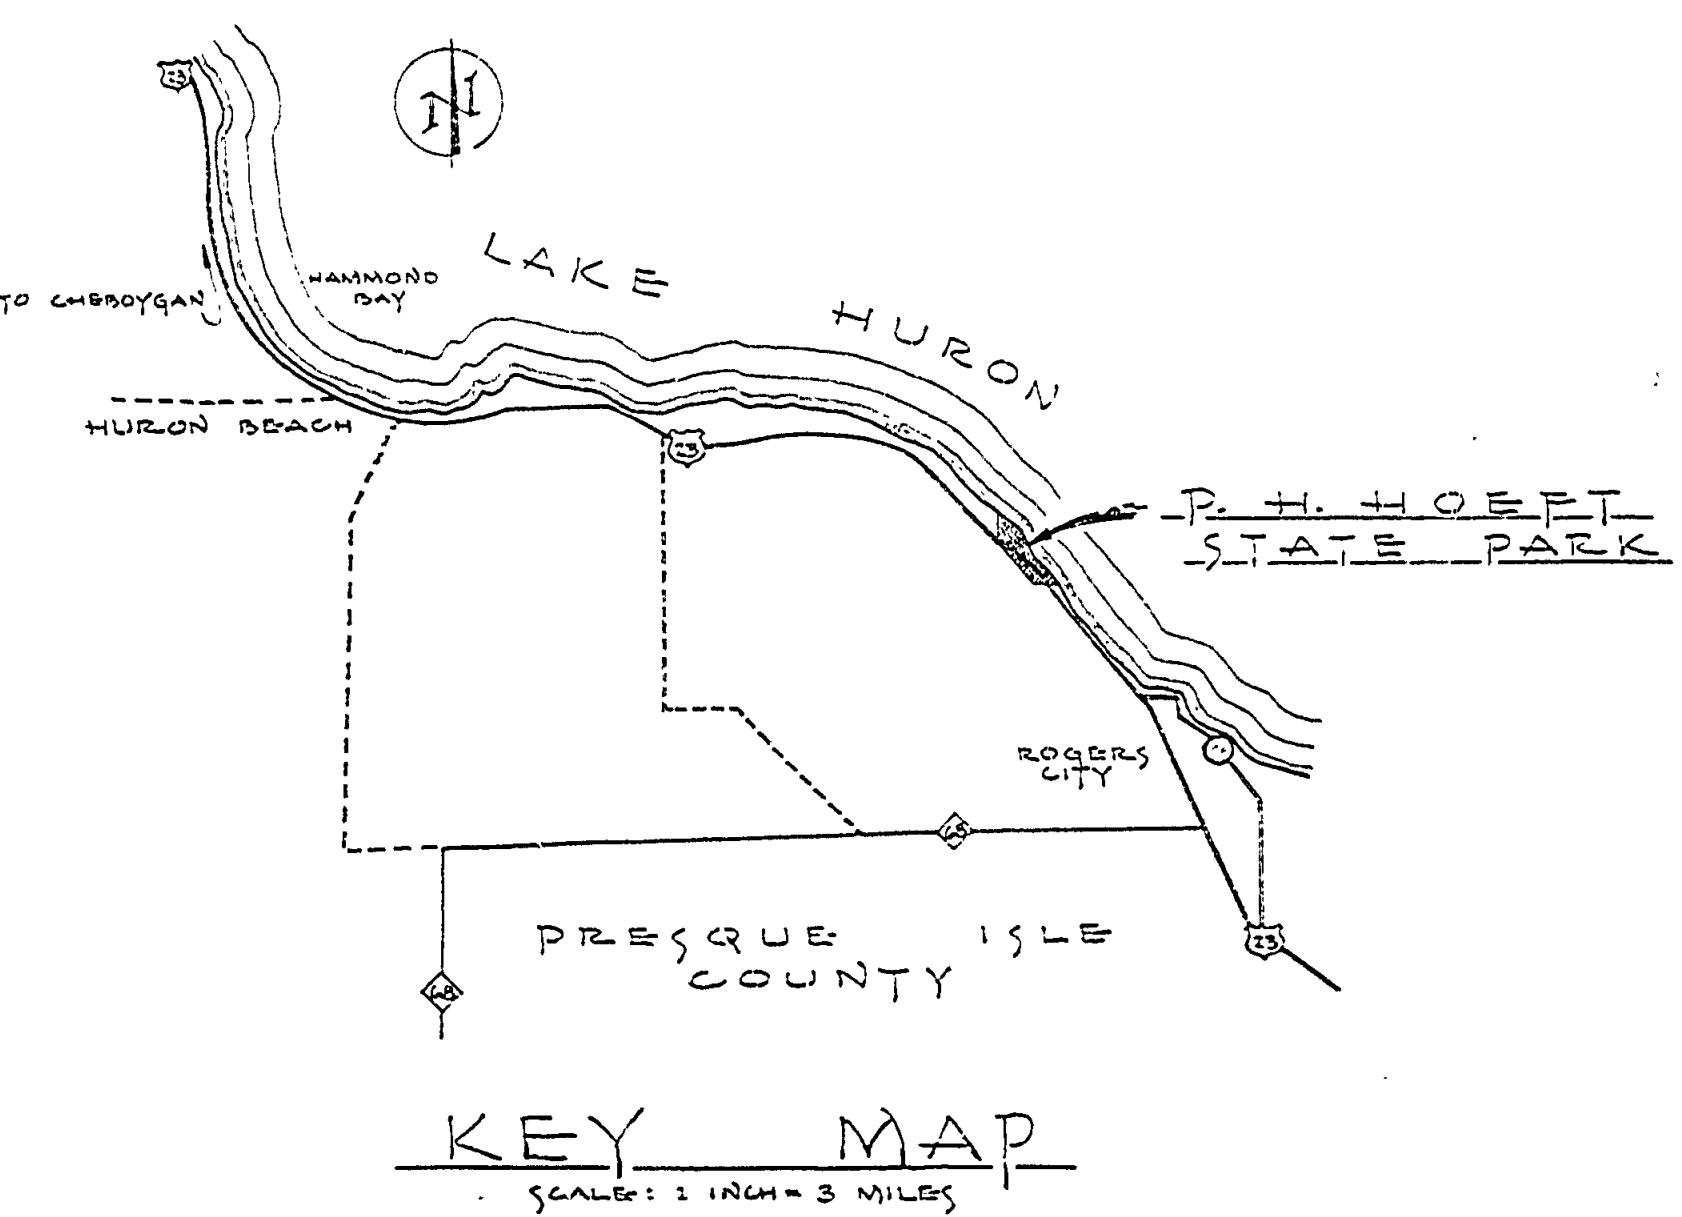

DRAWING SCHEDULE		TITLE
PLAN NO. (SHEET NO.)		
A-105 1		COVER SHEET
A-105 2		FOUNDATION & PLUMBING PLAN
A-105 3		FLOOR PLAN - SECTIONS - DETAILS
A-105 4		ELEVATIONS - DETAILS
A-105 5		INTERIOR ELEV. - DETAILS - ELECT. PLAN

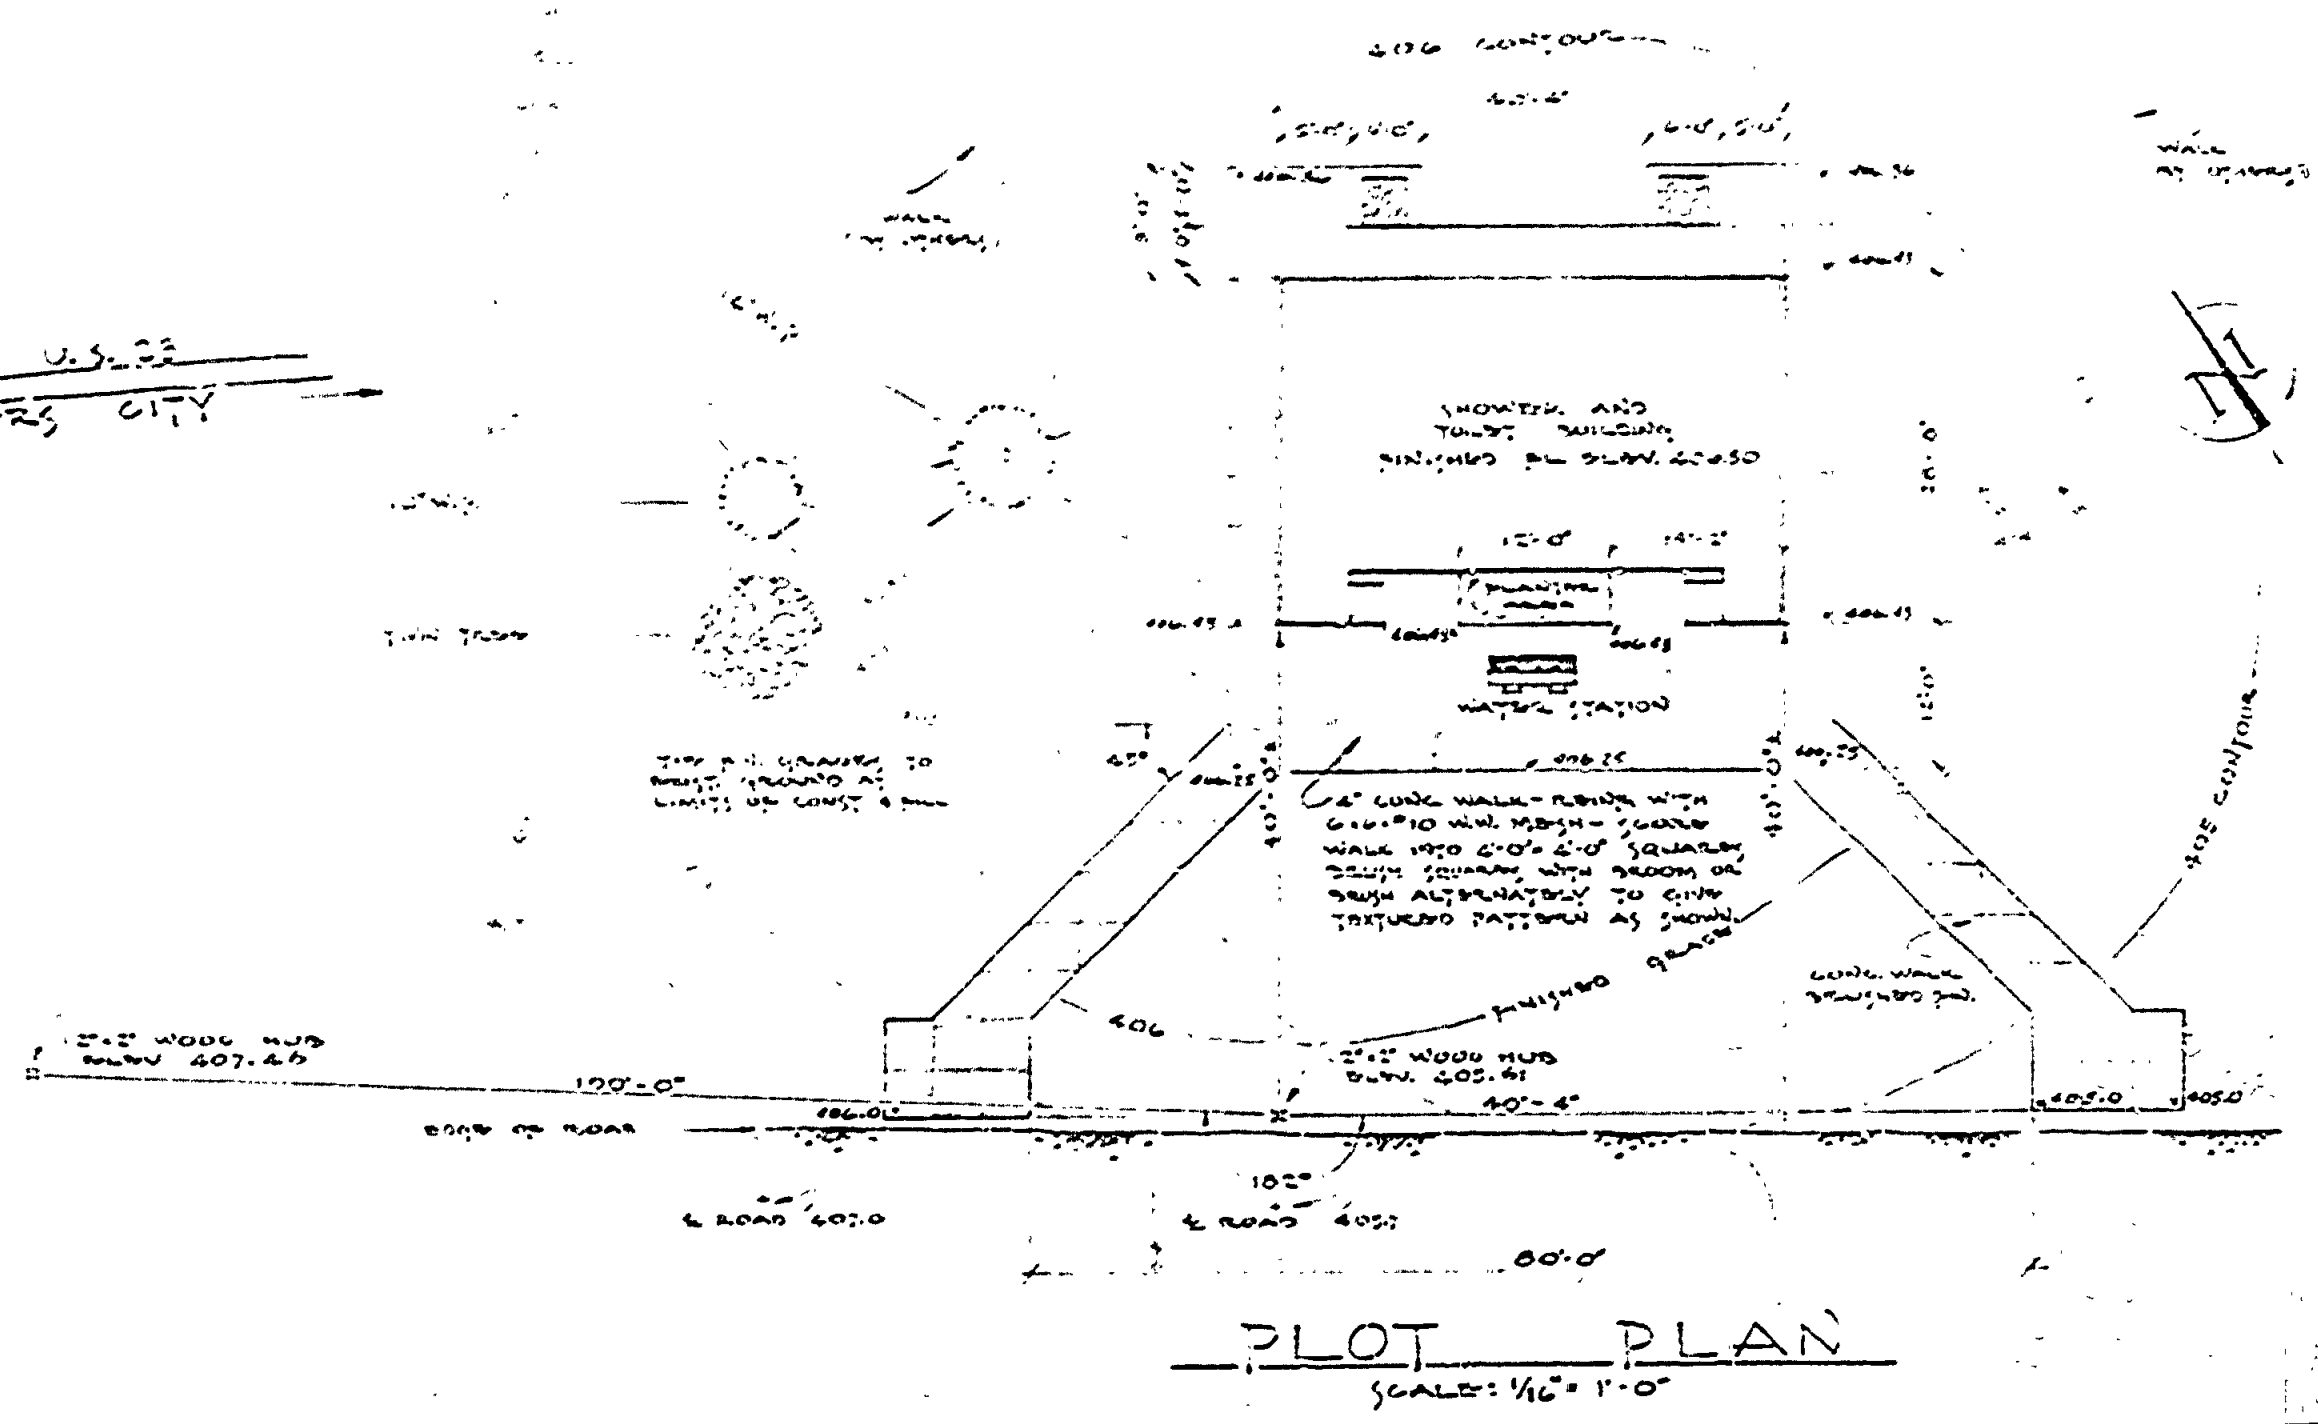

MICHIGAN
DEPARTMENT OF CONSERVATION
PARKS AND RECREATION DIVISION

P. H. HOEFT STATE PARK
TOILET AND SHOWER BUILDING #58

SHEET
NO. 1
OF 5

PLAN NO.
A-105