




DATE	REVIEWED	DATE	APPROVED	NO.	DATE	BY	REVISIONS
5-17-41	ARCHITECTURAL	8-1-41	[Signature]	1	8-17-41	W.C.	1
8-17-41	ENGINEERING	8-17-41	[Signature]	2	8-17-41	W.C.	2
8-17-41	LANDSCAPE	8-17-41	[Signature]	3	8-17-41	W.C.	3
				4			4
				5			5
				6			6

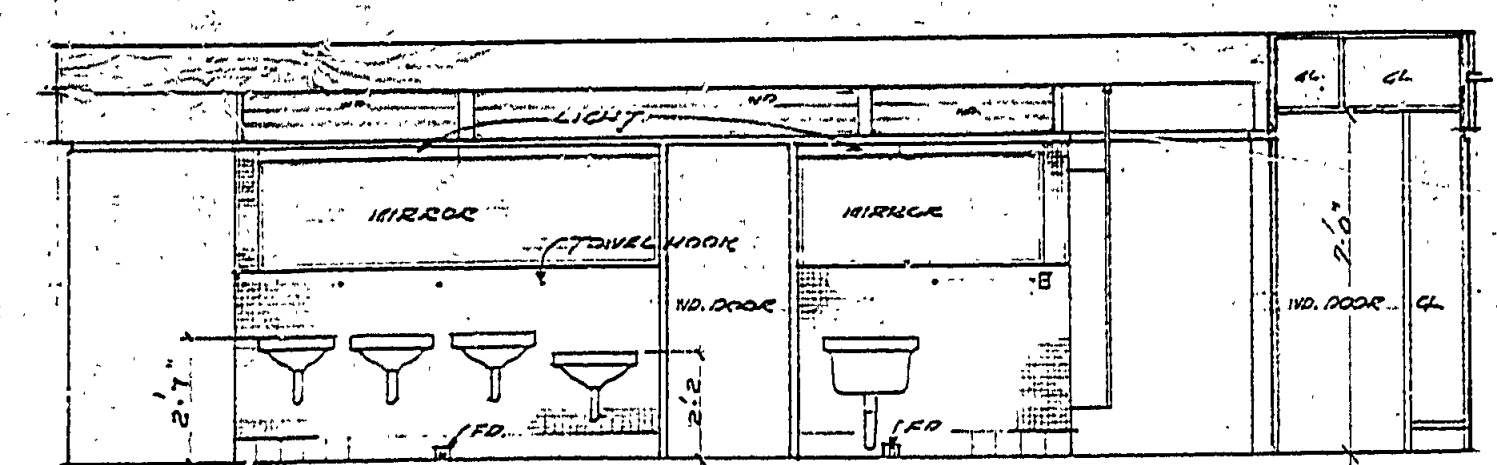


EAST INTERIOR ELEV. - WOMEN'S TOILET

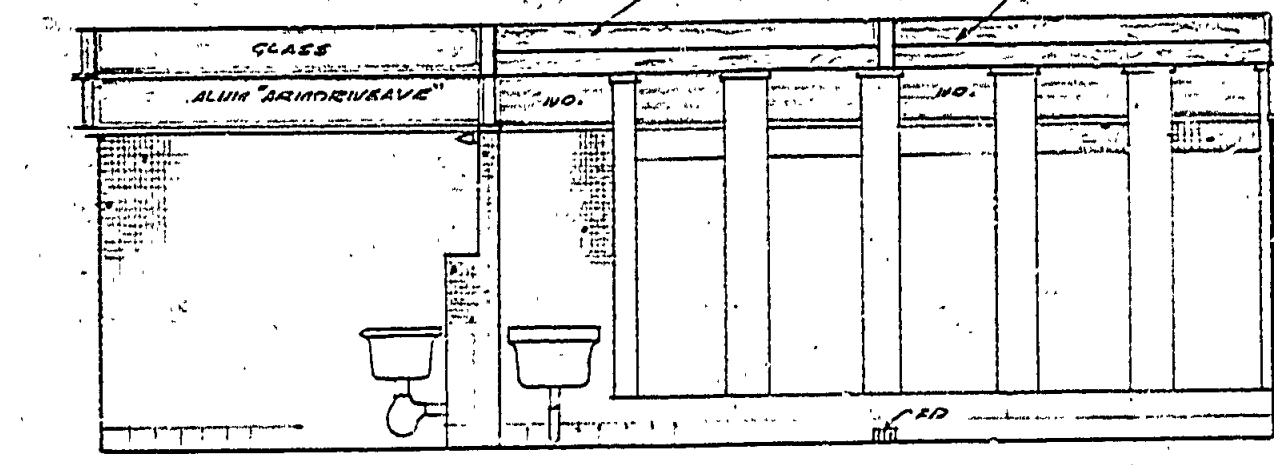


NORTH INTERIOR ELEV. - WOMEN'S TOILET

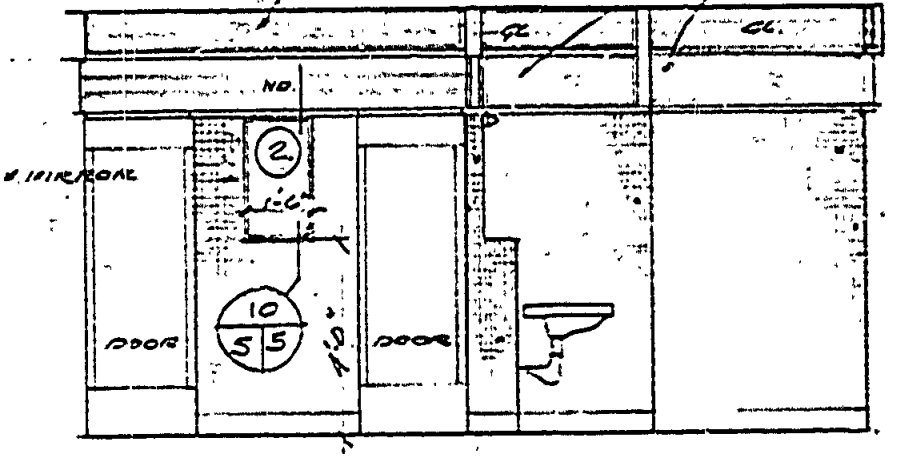


SOUTH INT. ELEV. - WOMEN'S TOILET

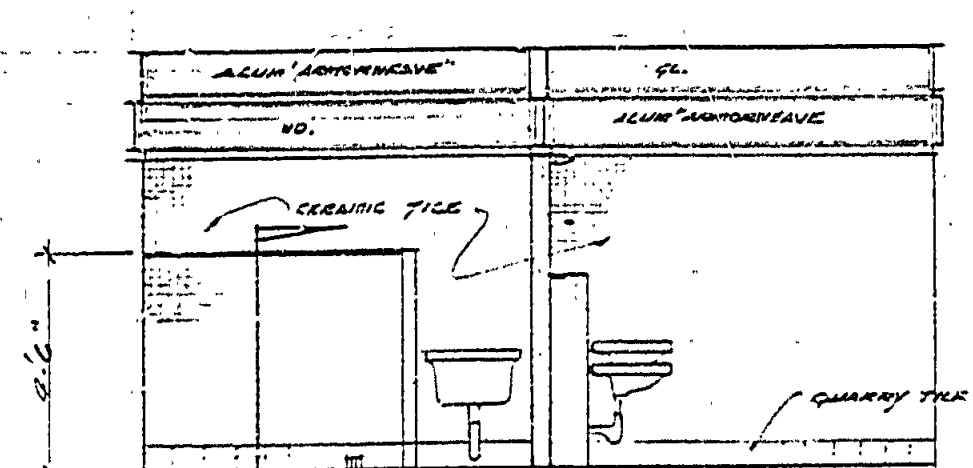


NORTH INT. ELEV. MEN'S TOILET

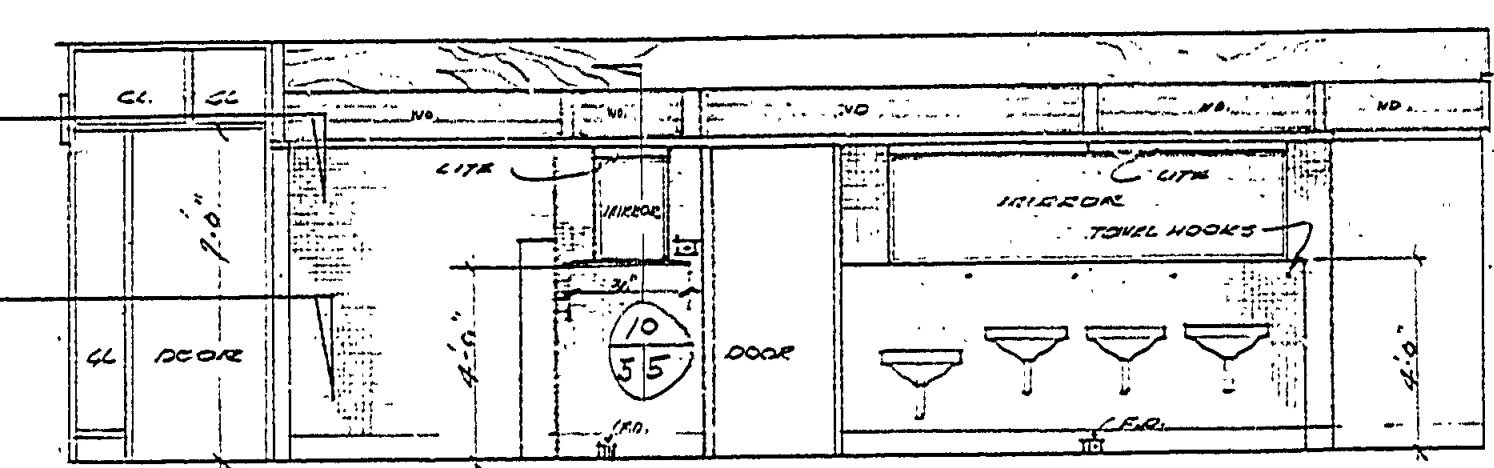


WEST INTERIOR ELEVATION - MEN'S TOILET

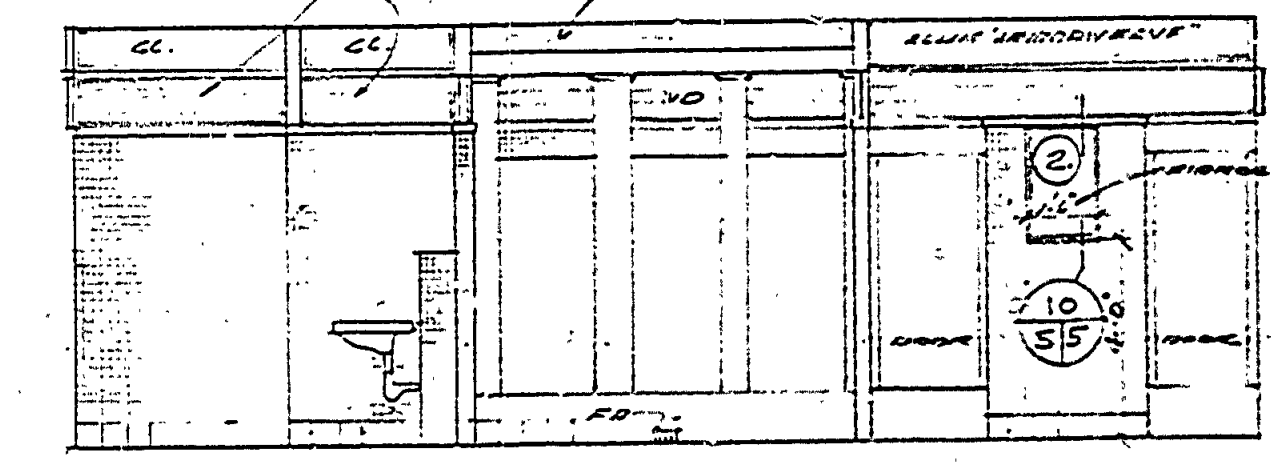


SOUTH INTERIOR ELEV. - MEN'S TOILET

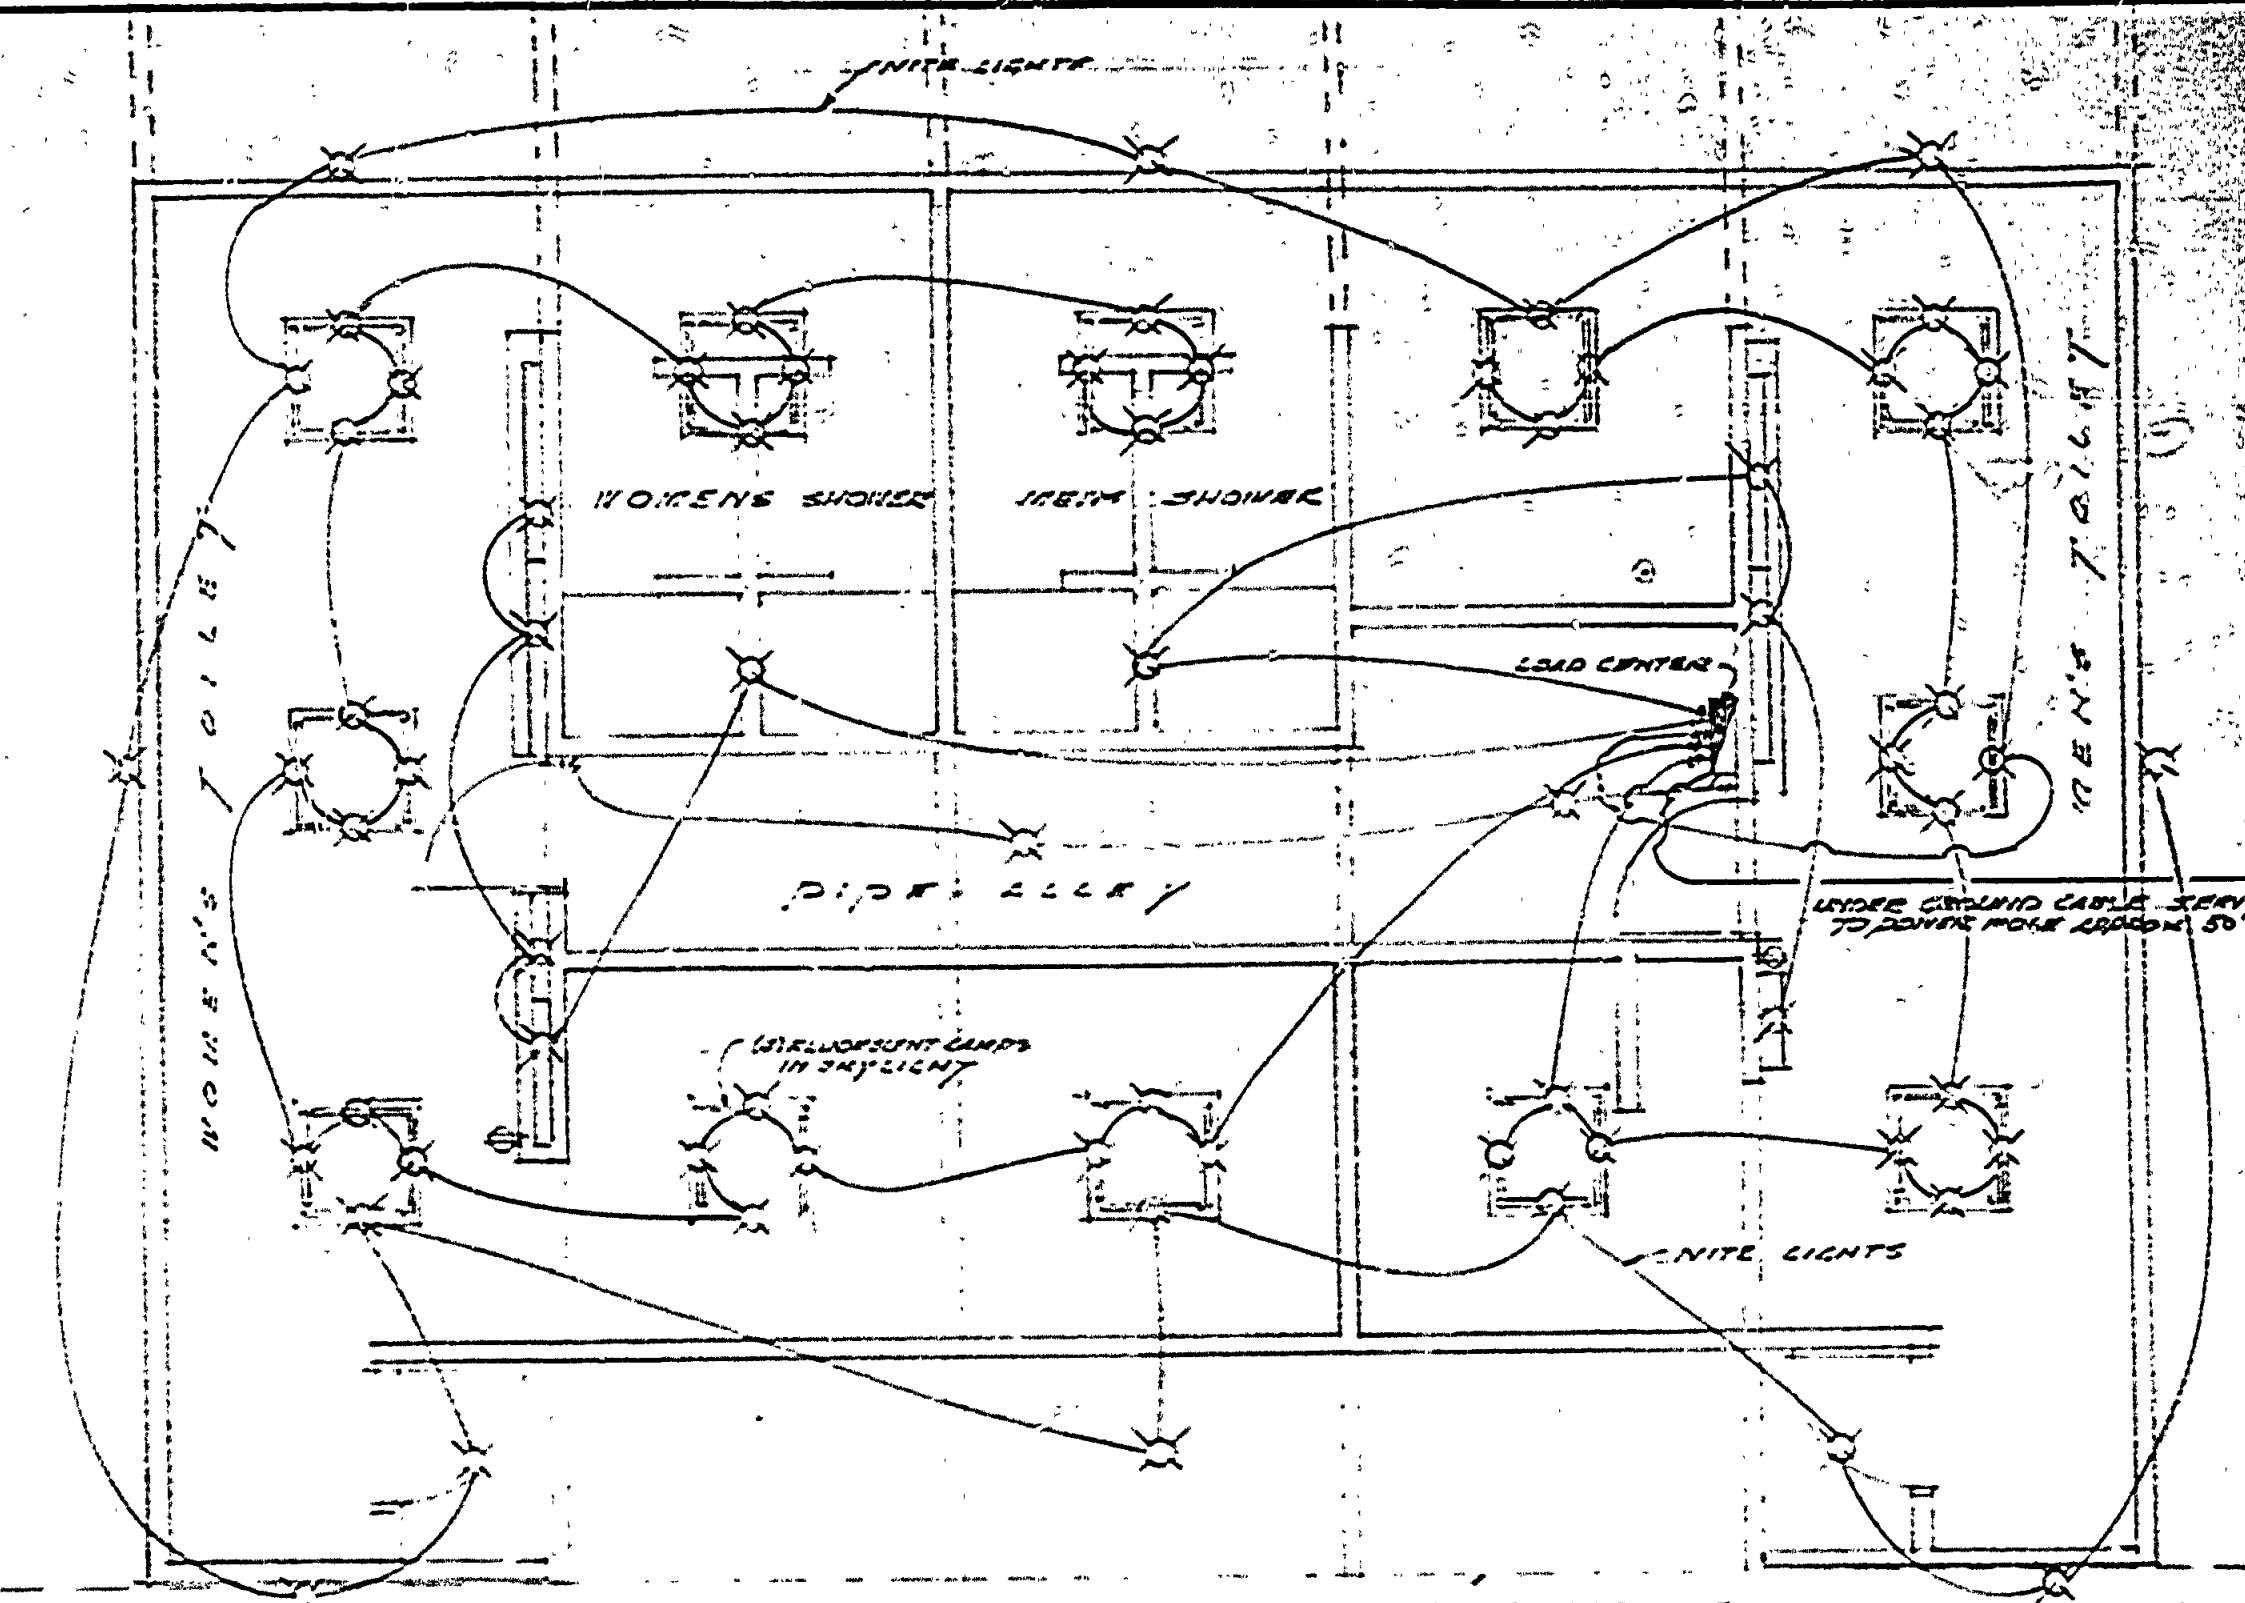


ELECTRICAL LIGHTING PLAN

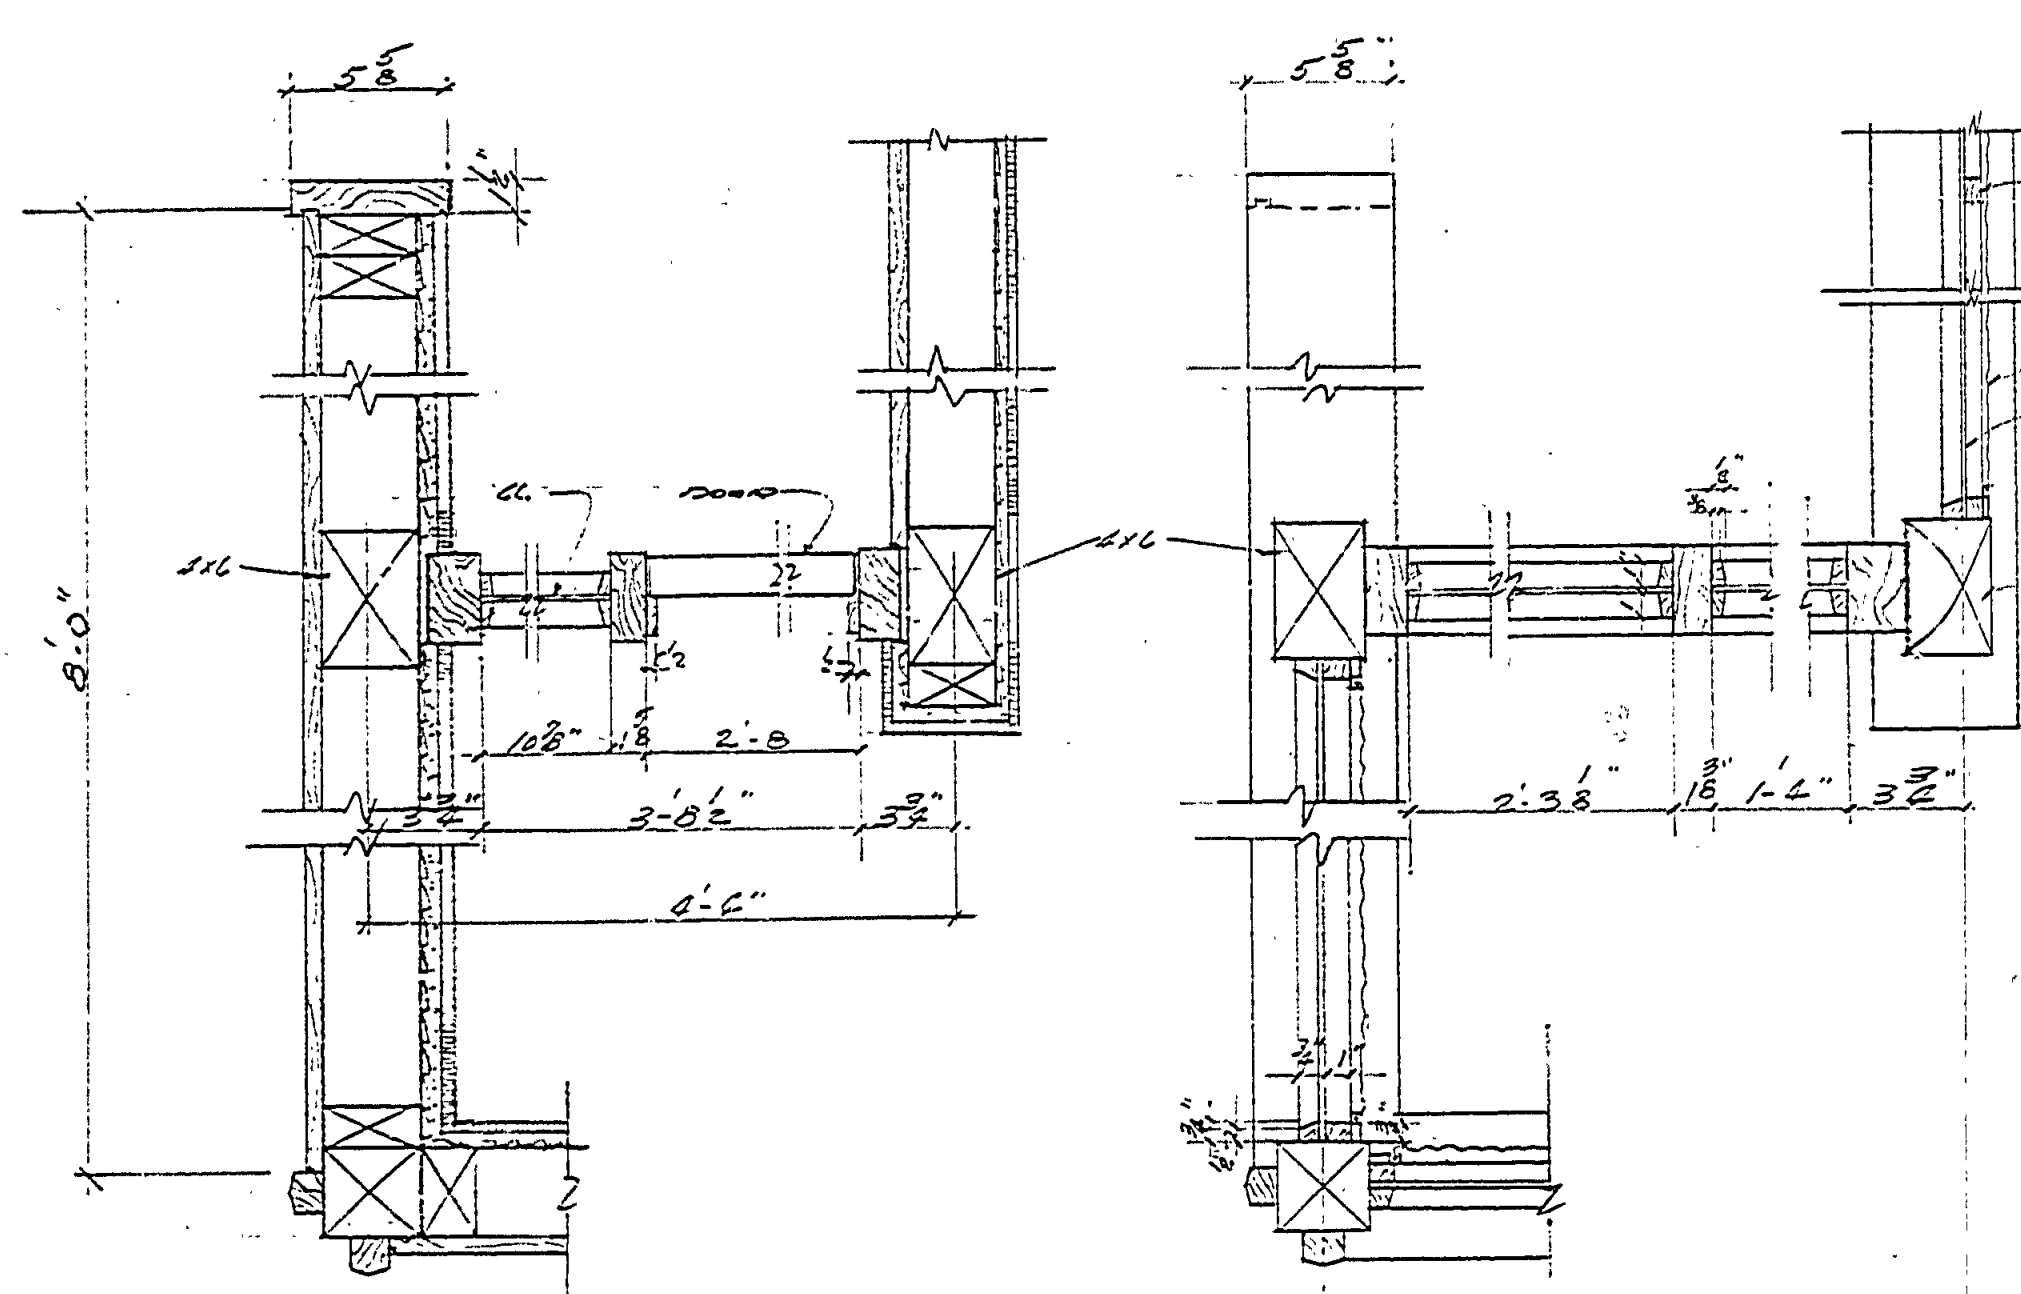


ENTRANCE DET. 9/55

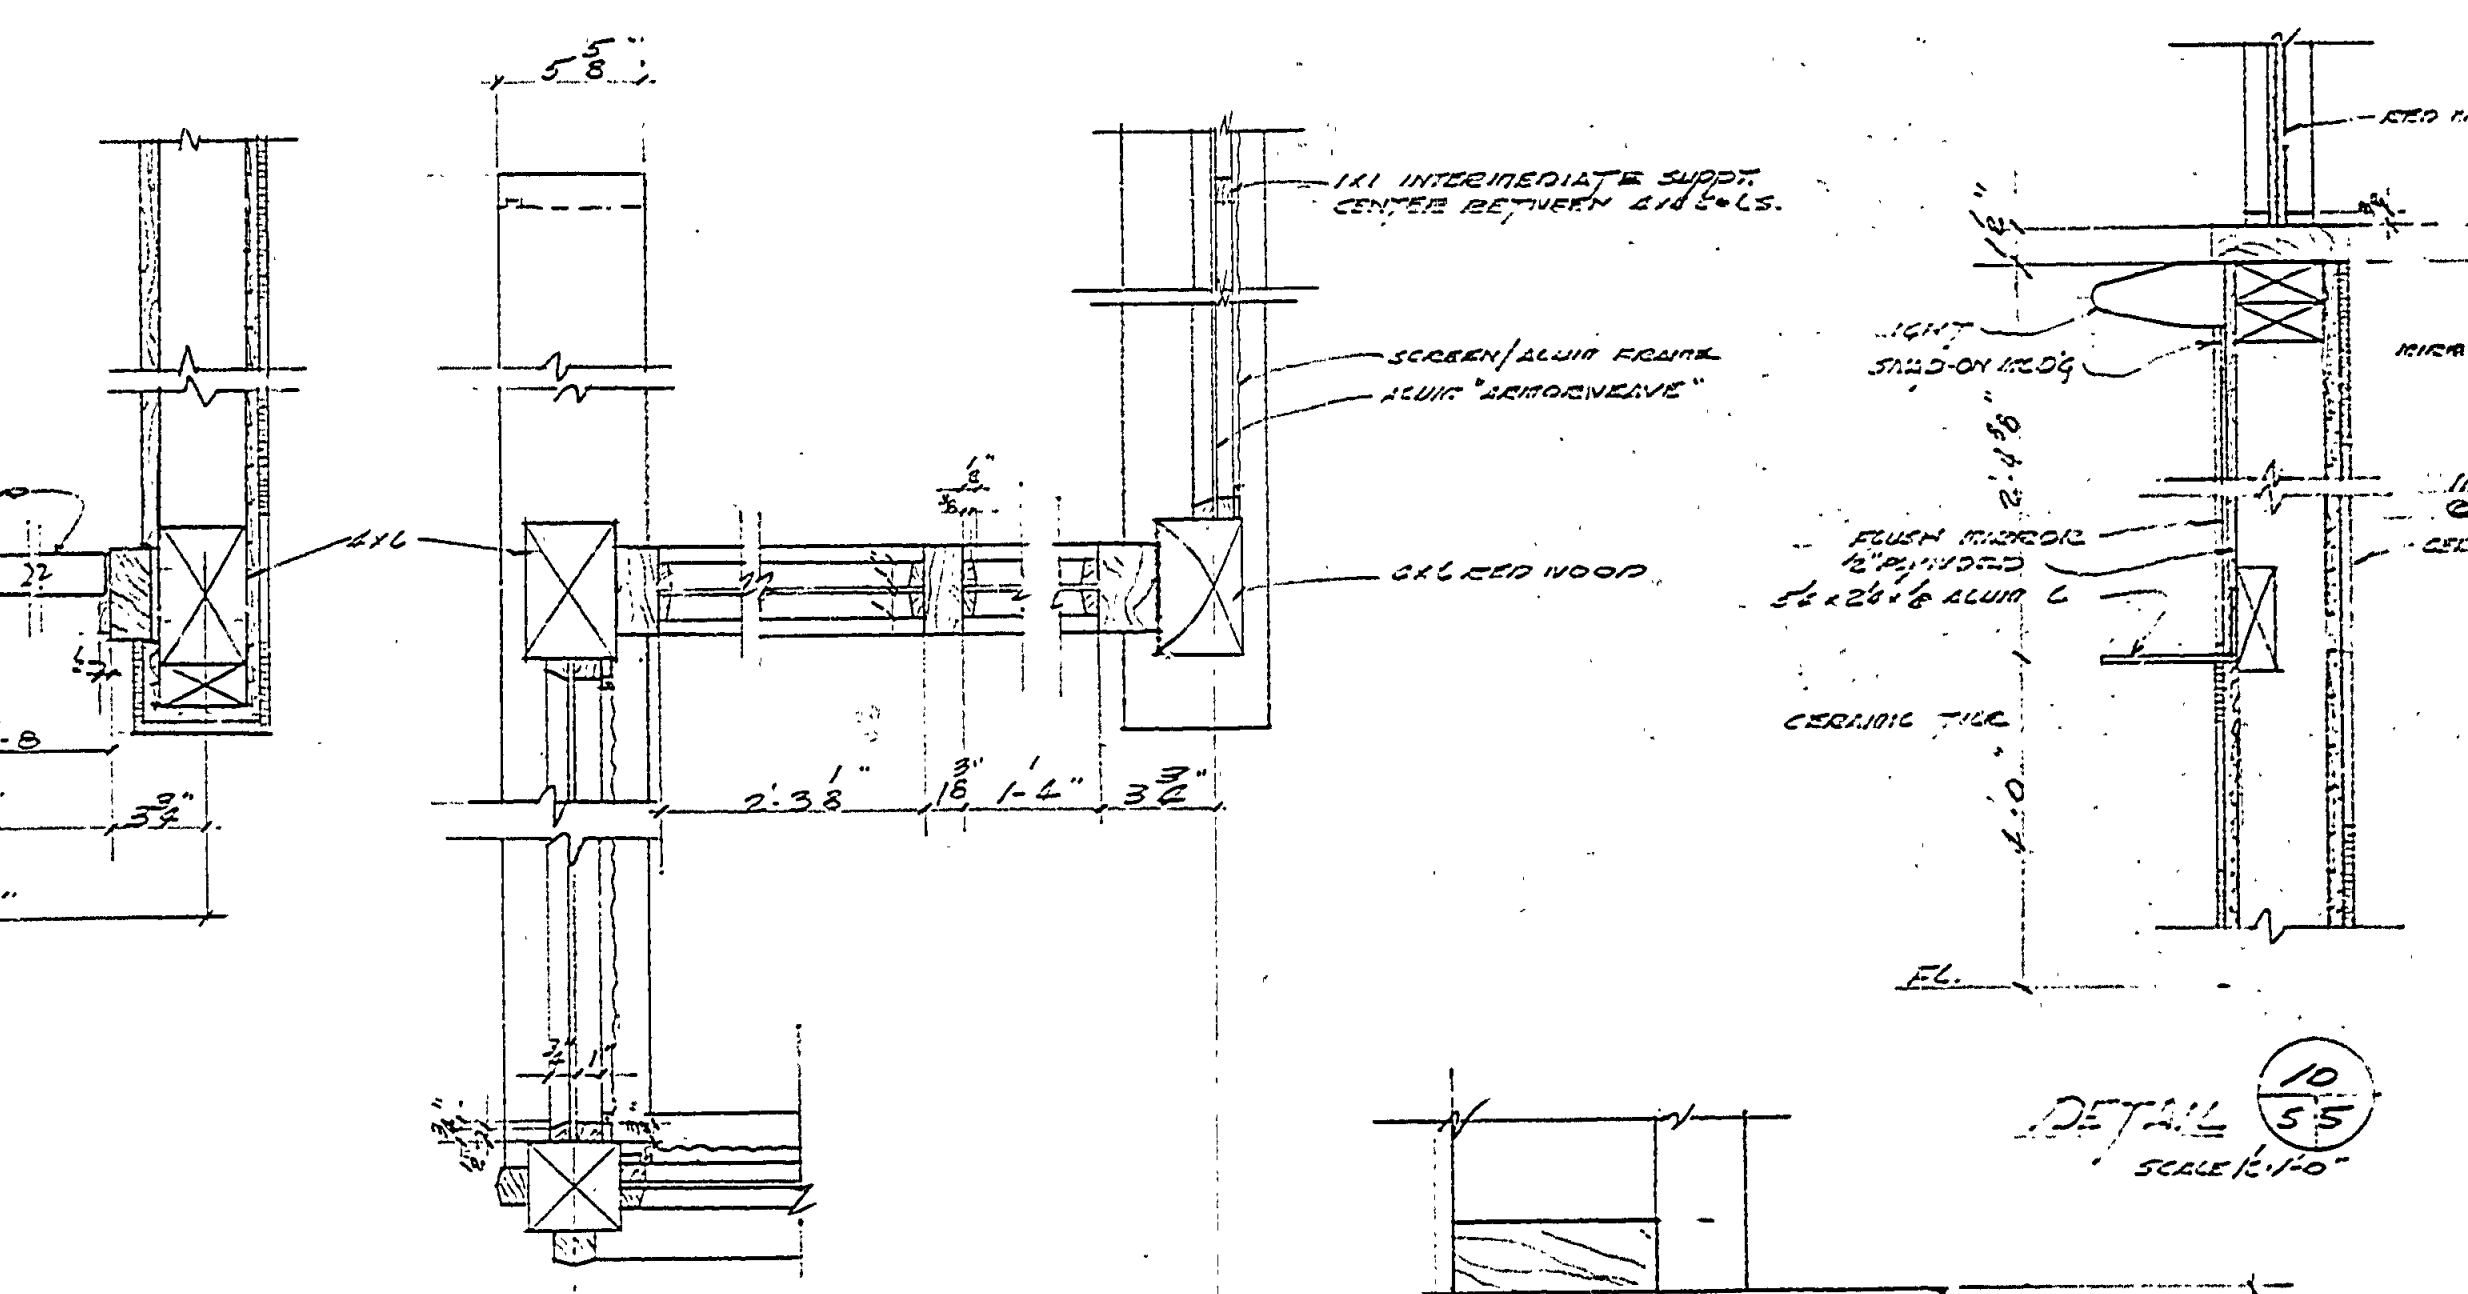


ENTRANCE DET. 6/55

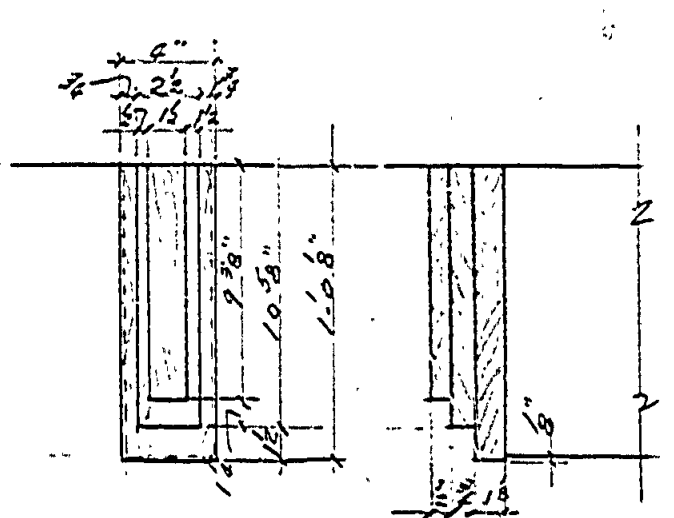


DET. END OF BOX BEAMS

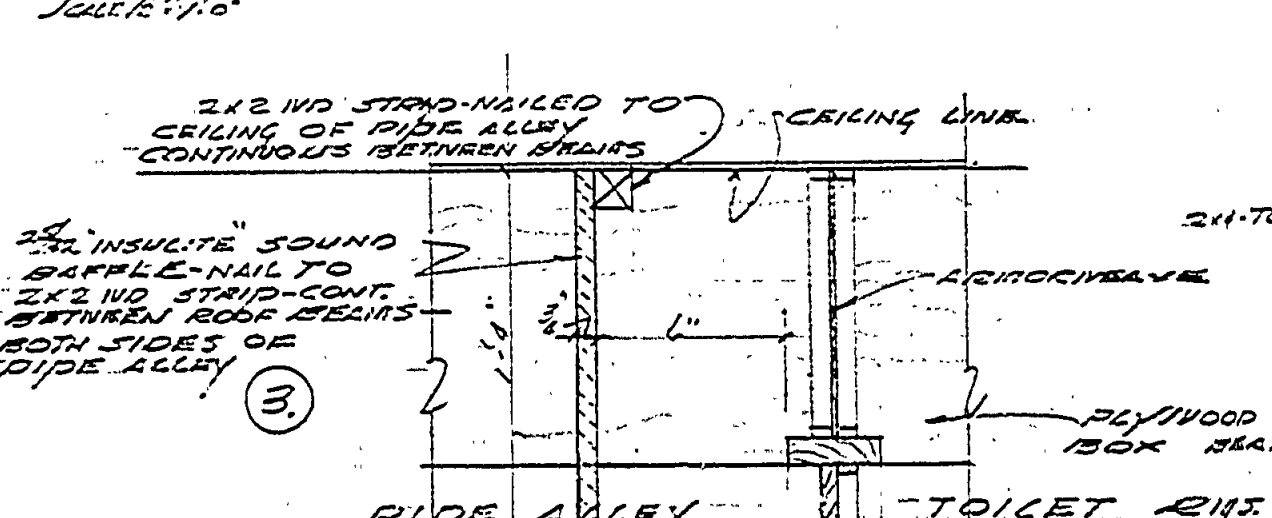


DET. "SOUND BAFLE"

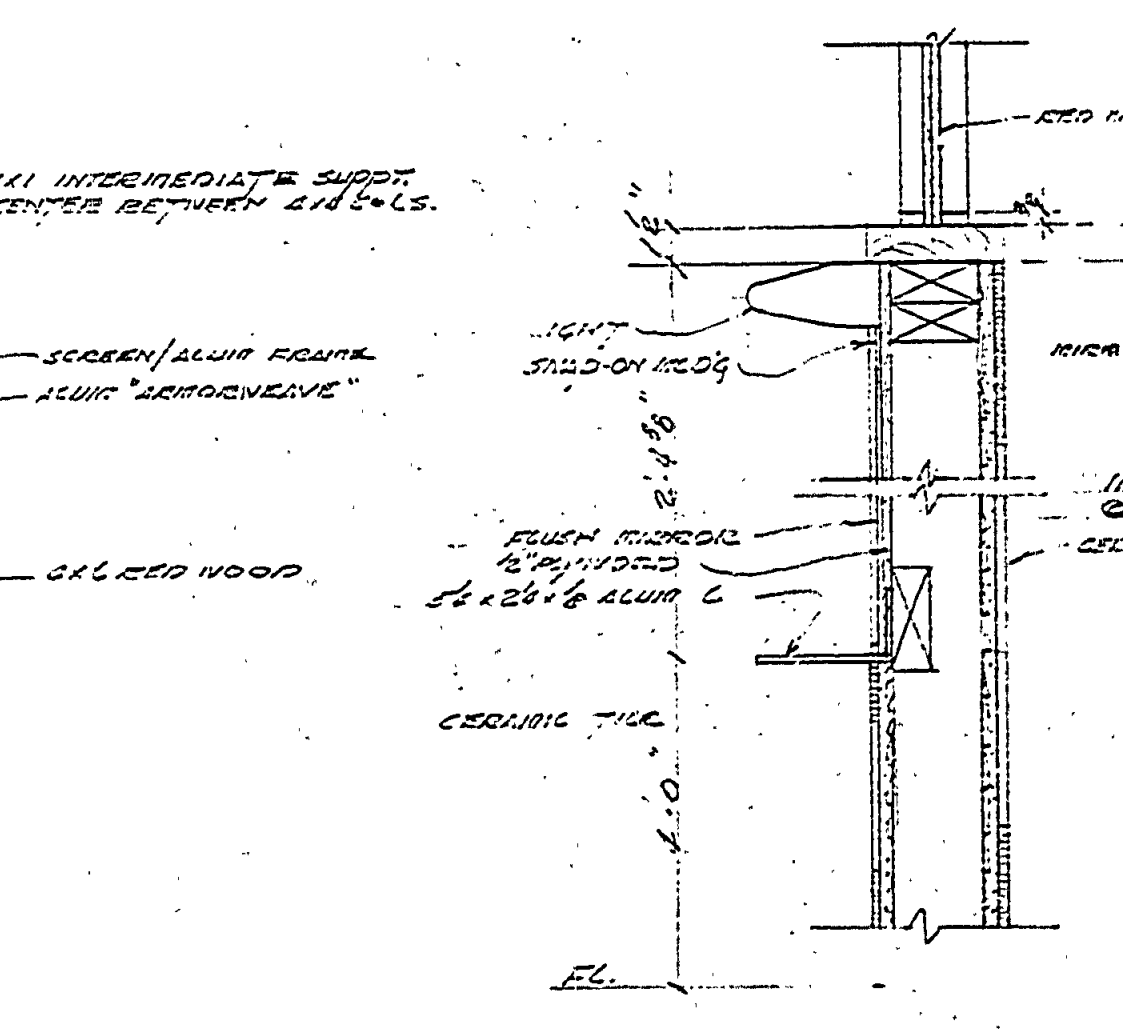

MIRROR & LIGHT DETAIL

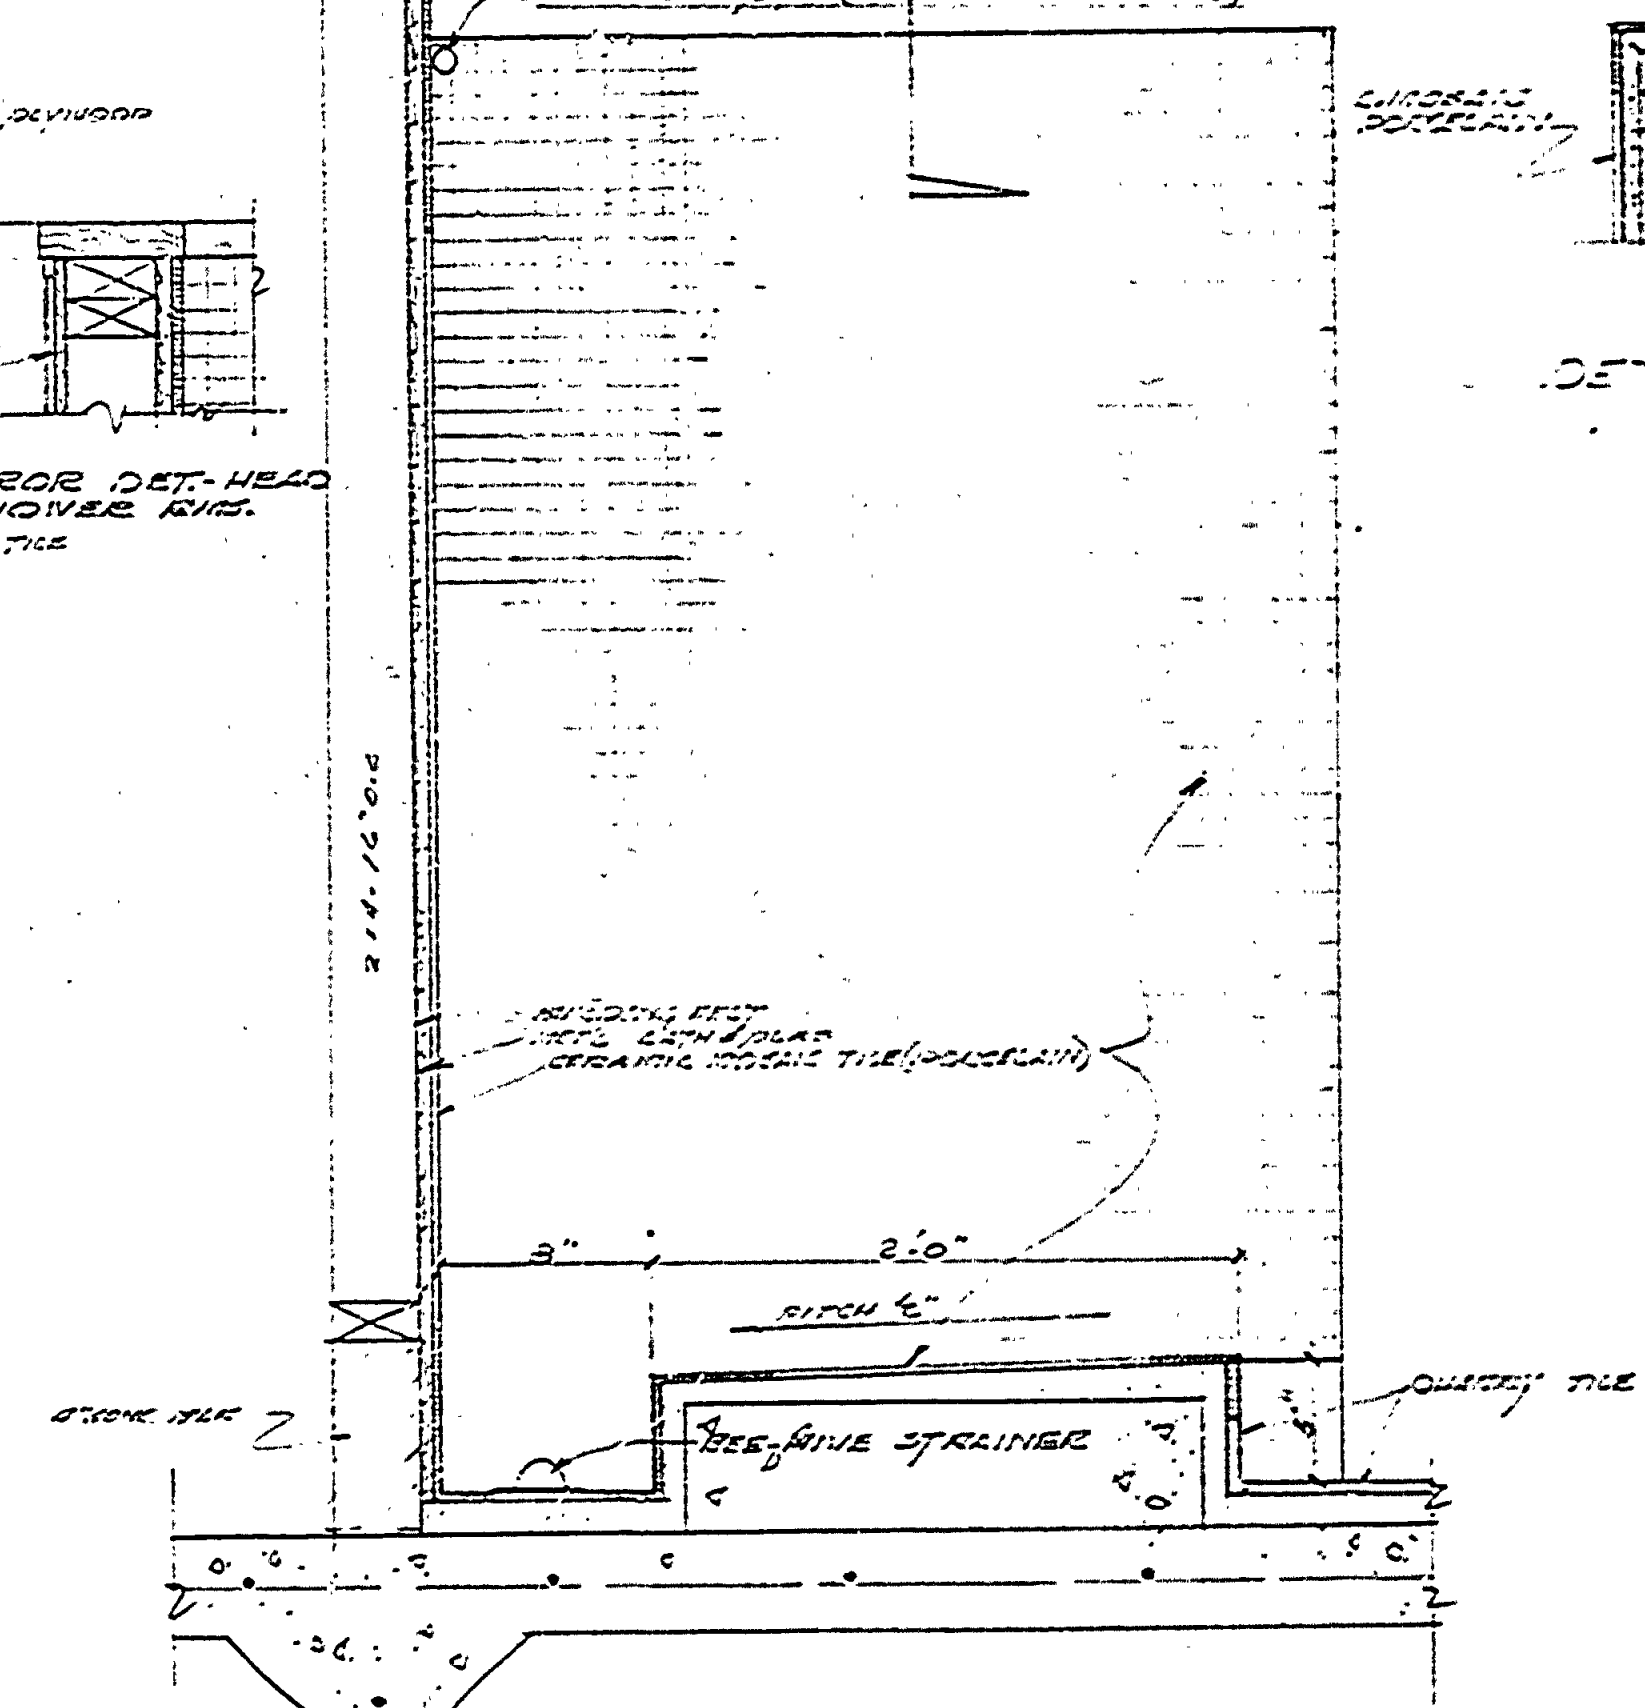

DETAIL URINAL 7/55

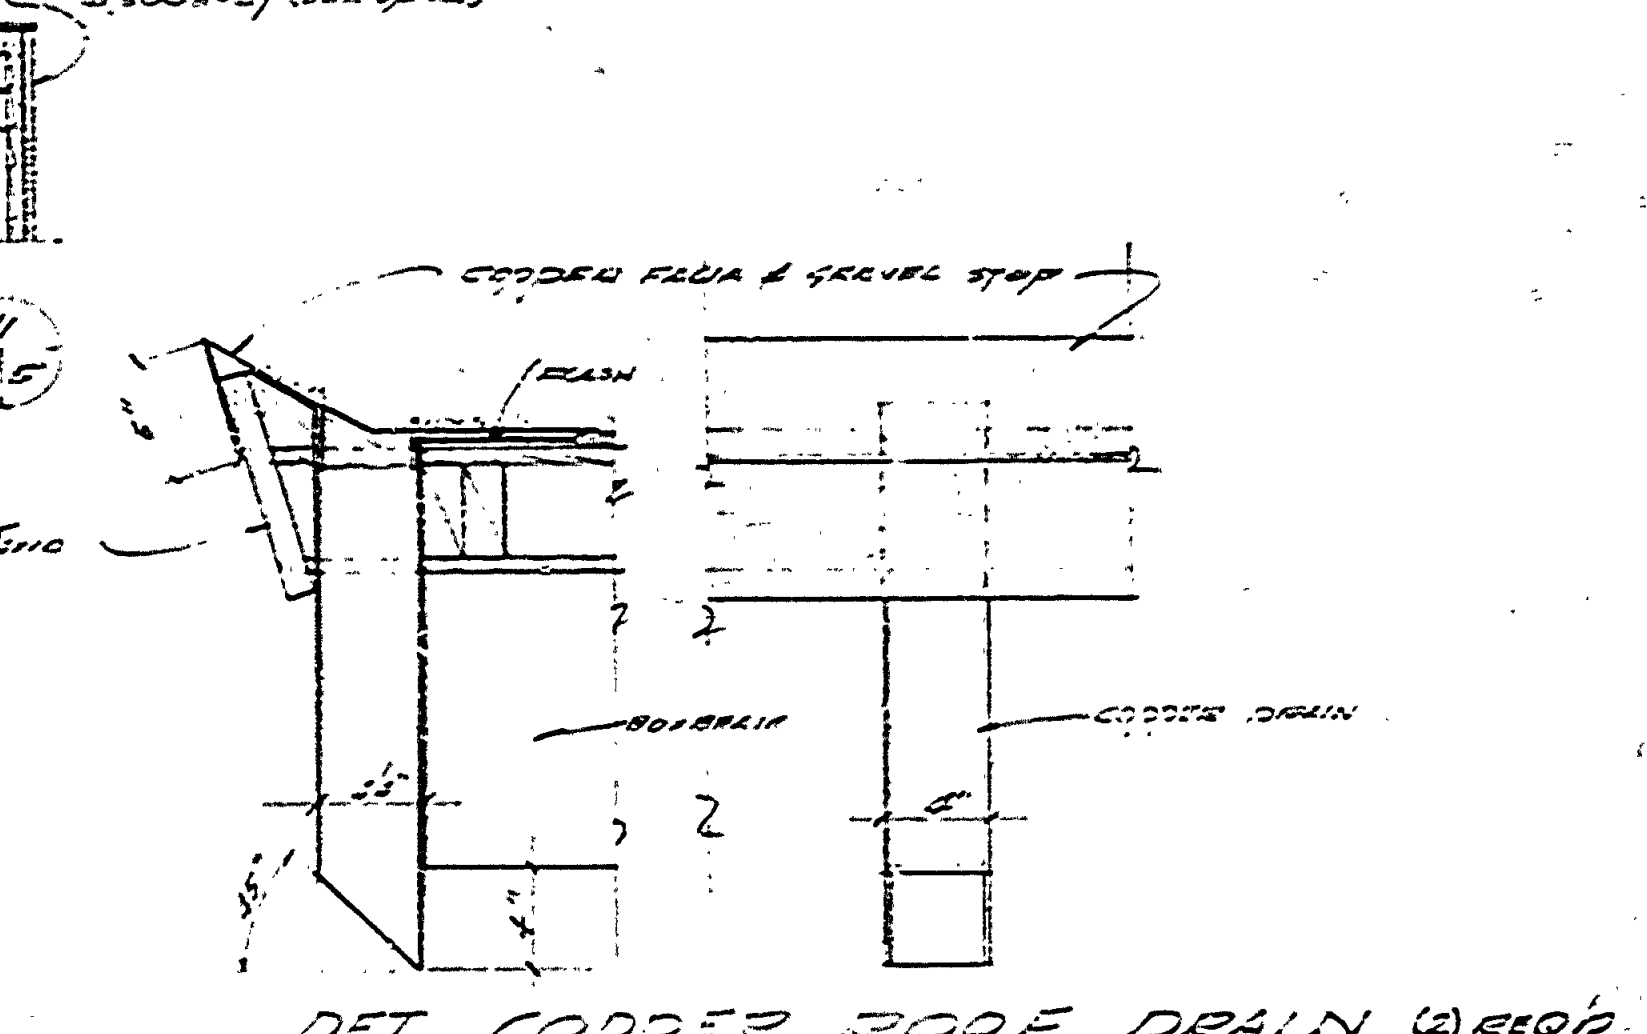

DET. COPPER ROOF DRAIN 10/55

DESIGNATION	TYPE	SIZE	REMARKS
1	A	110 1/2 x 210 7/8	SOLID CORE
2	A	110 1/2 x 210 7/8	"
3	A	110 1/2 x 210 7/8	"
4	A	110 1/2 x 210 7/8	"
5	B	110 1/2 x 210 7/8	GLASS/TOILET
6	B	110 1/2 x 210 7/8	"
7	B	110 1/2 x 210 7/8	"
8	B	110 1/2 x 210 7/8	"

ROOM DESIGNATION	FLOOR	WALLS	WOOD TRIM	WOOD CEILING	REMARKS
WOMEN'S TOILET ROOM	...	...	...	...	
WOMEN'S TOILET ROOM	...	...	...	...	
WOMEN'S SHOWER	...	...	...	...	
WOMEN'S SHOWER	...	...	...	...	
PIPE ALLEY	...	...	...	...	

MICHIGAN DEPARTMENT OF CONSERVATION PARKS AND RECREATION DIVISION

D.H. HOEFT STATE PARK TOILET AND SHOWER BUILDING - #58 SHEET NO. 5 OF 5 PLAN NO. A-105