




DESIGNED BY	DATE	REVIEWED BY SECTIONS	DATE	APPROVED BY	DATE	REVISIONS	DATE	BY
ENGINEERED BY	3-7-54	J.P.R.	3-12-54	H.C.M.	3-12-54	1	3-12-54	J.P.R.
ENGINEERING						2		
LANDSCAPE						3		
						4		
						5		
						6		

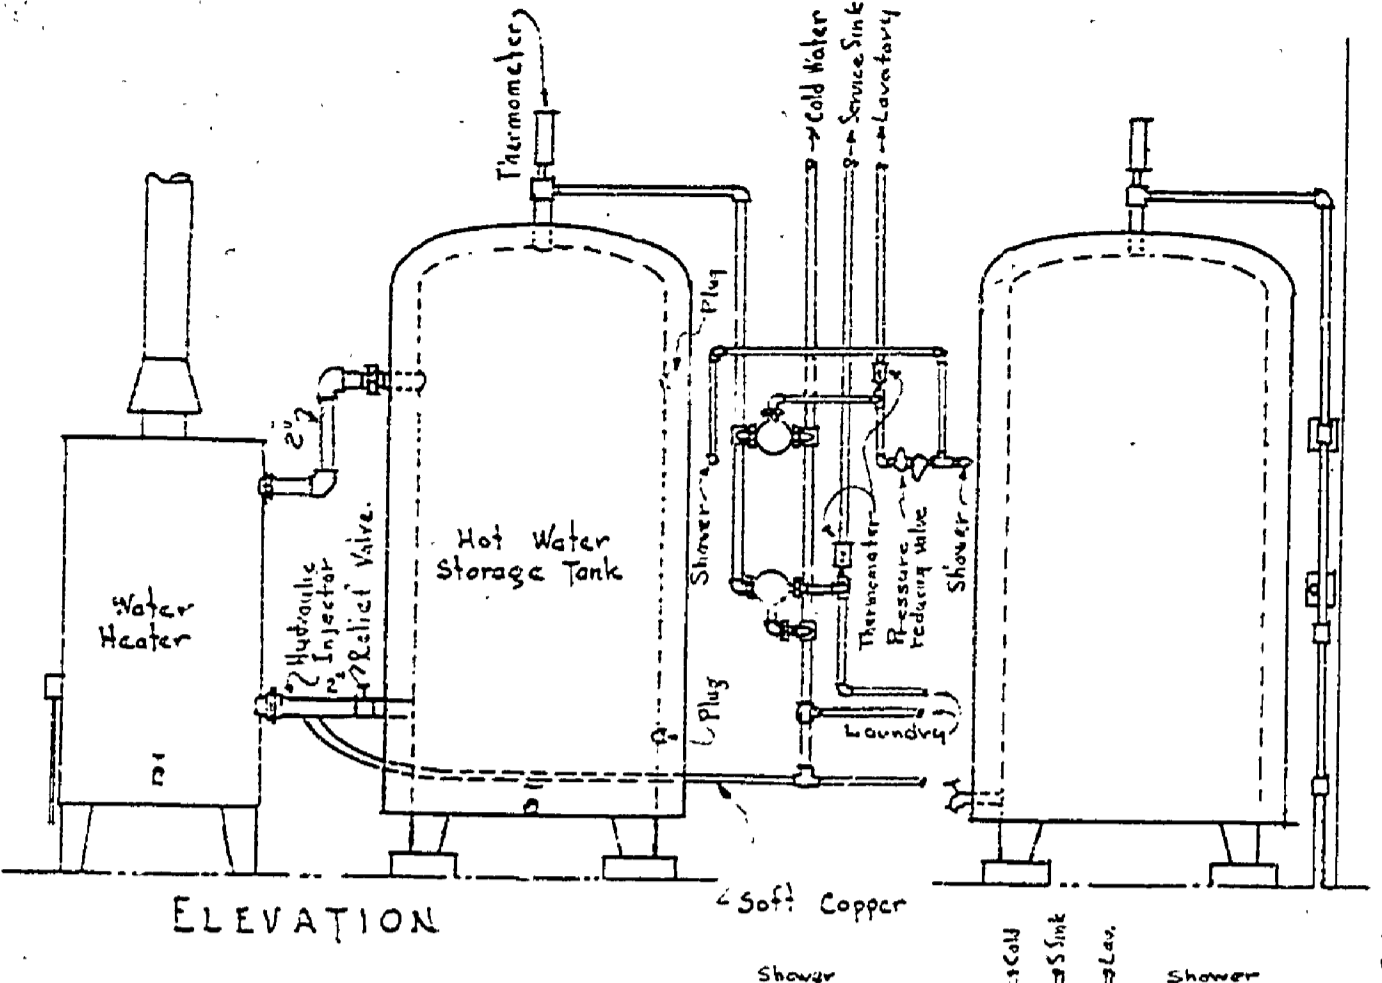


NOTE: Heater inlet and cold water storage outlet to be set level with each other.

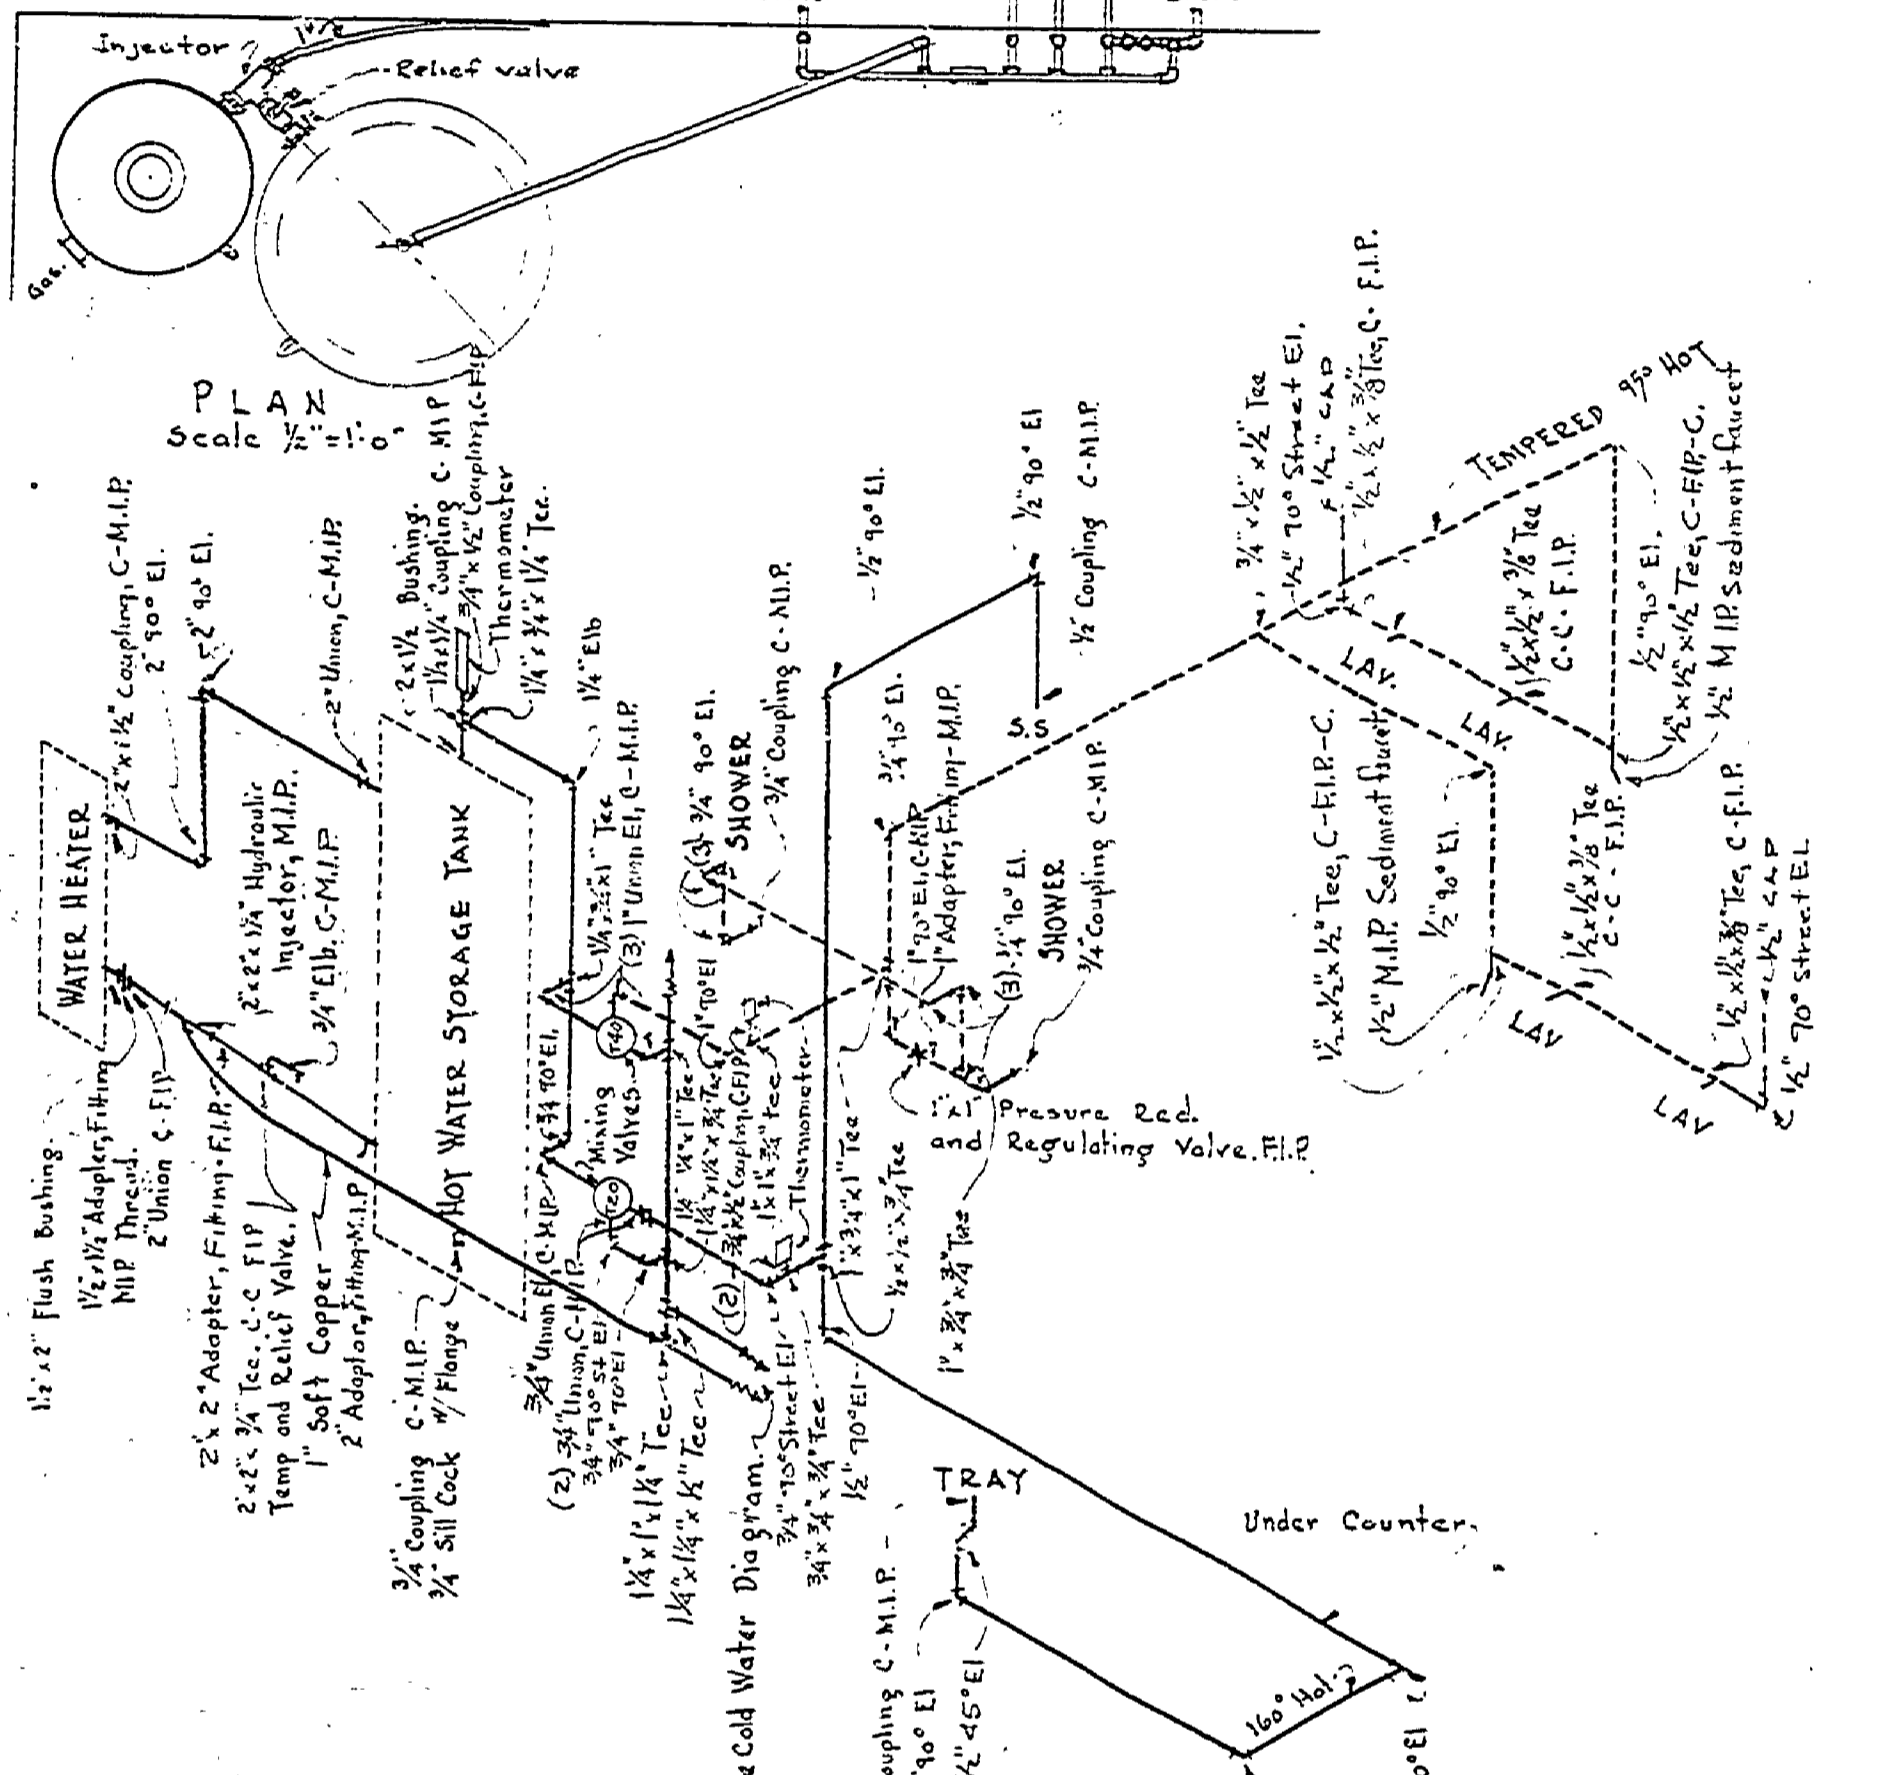


HOT WATER PIPE LAYOUT
No Scale.

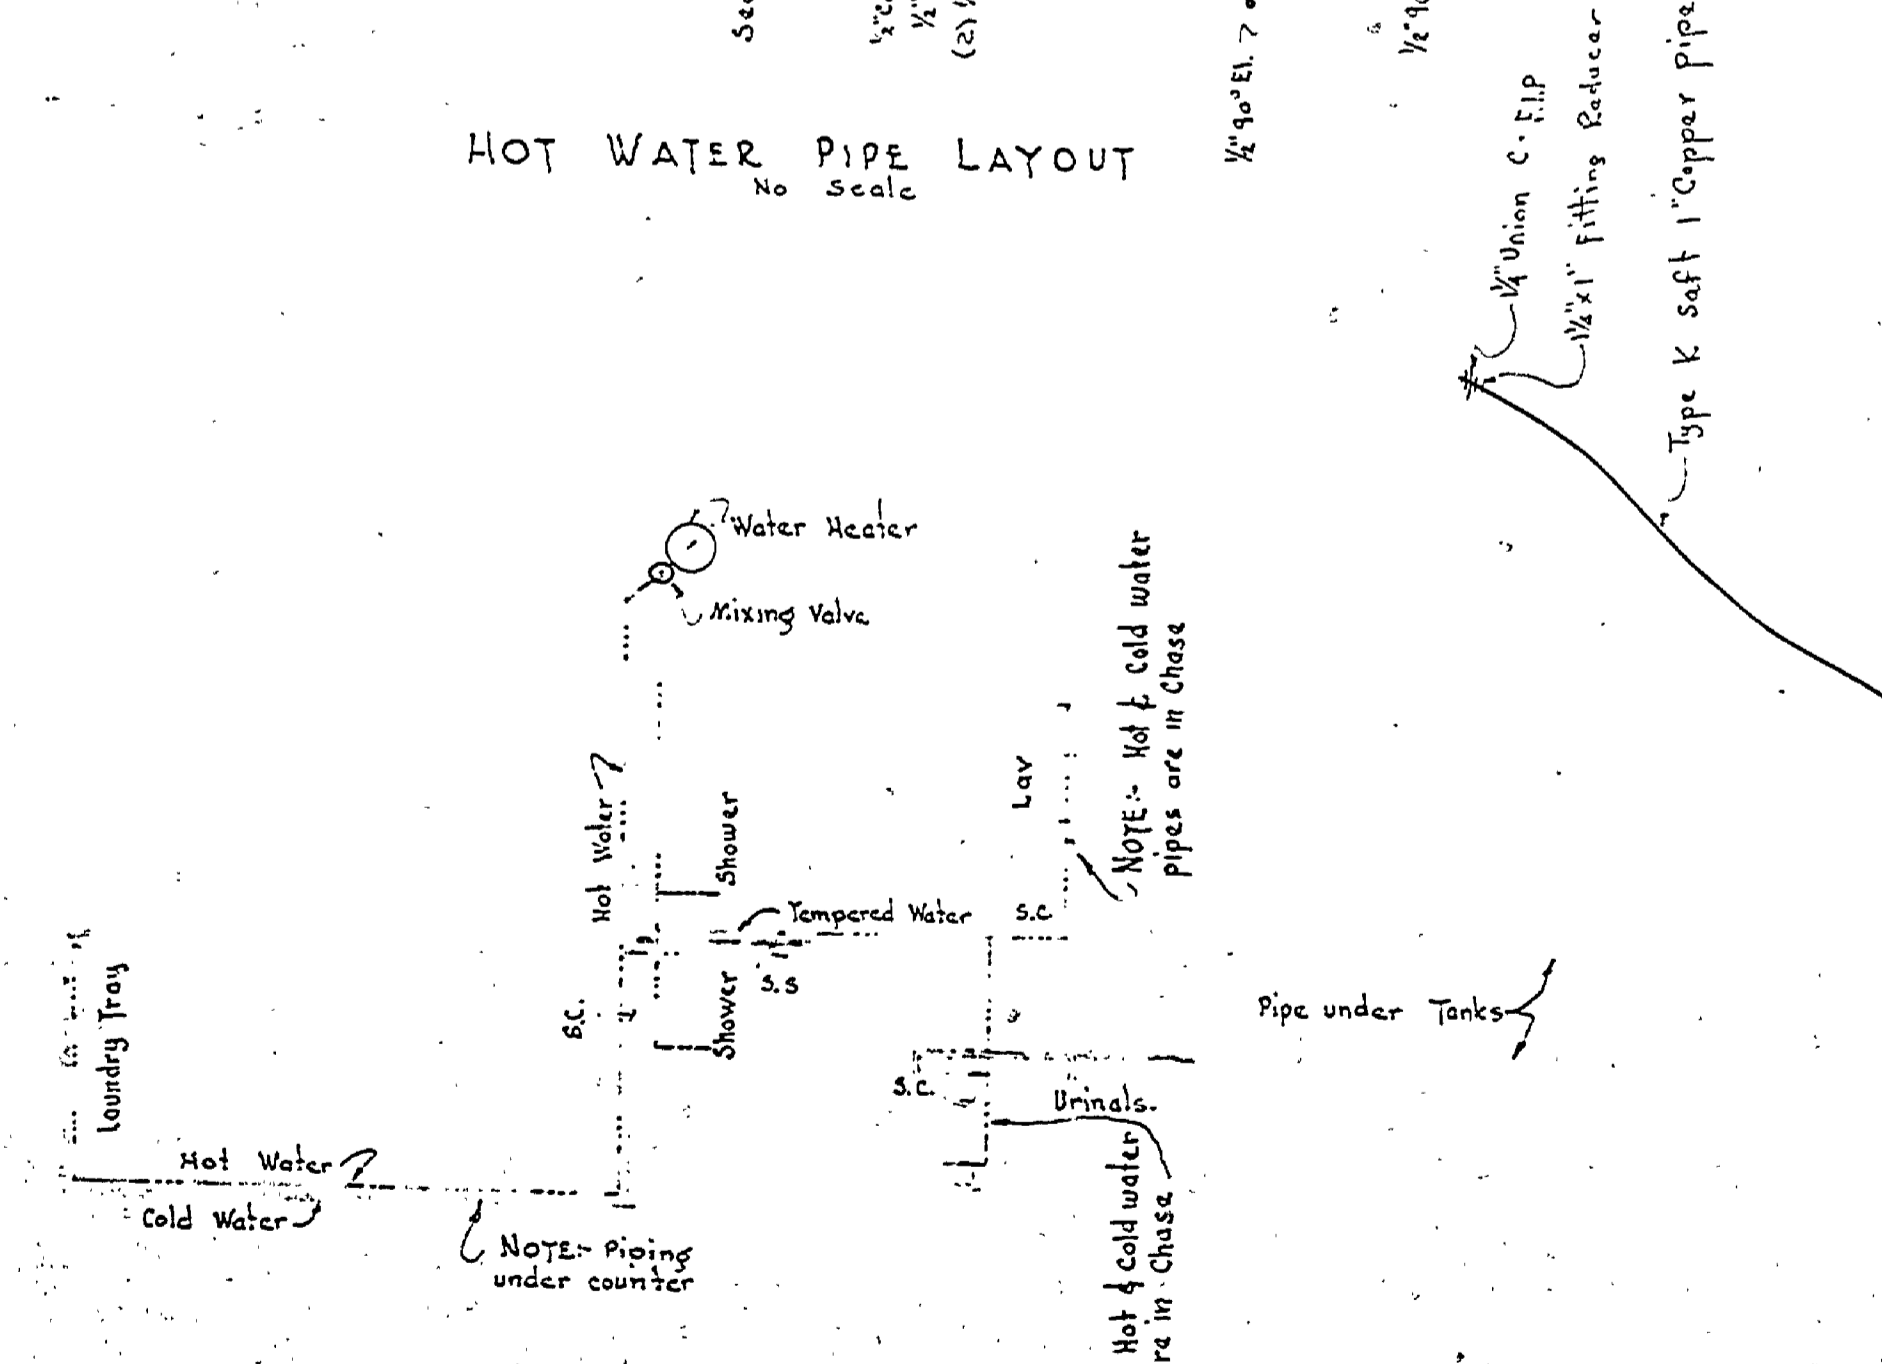

PLAN VIEW OF WATER PIPES
Scale 1/4" = 1'-0"

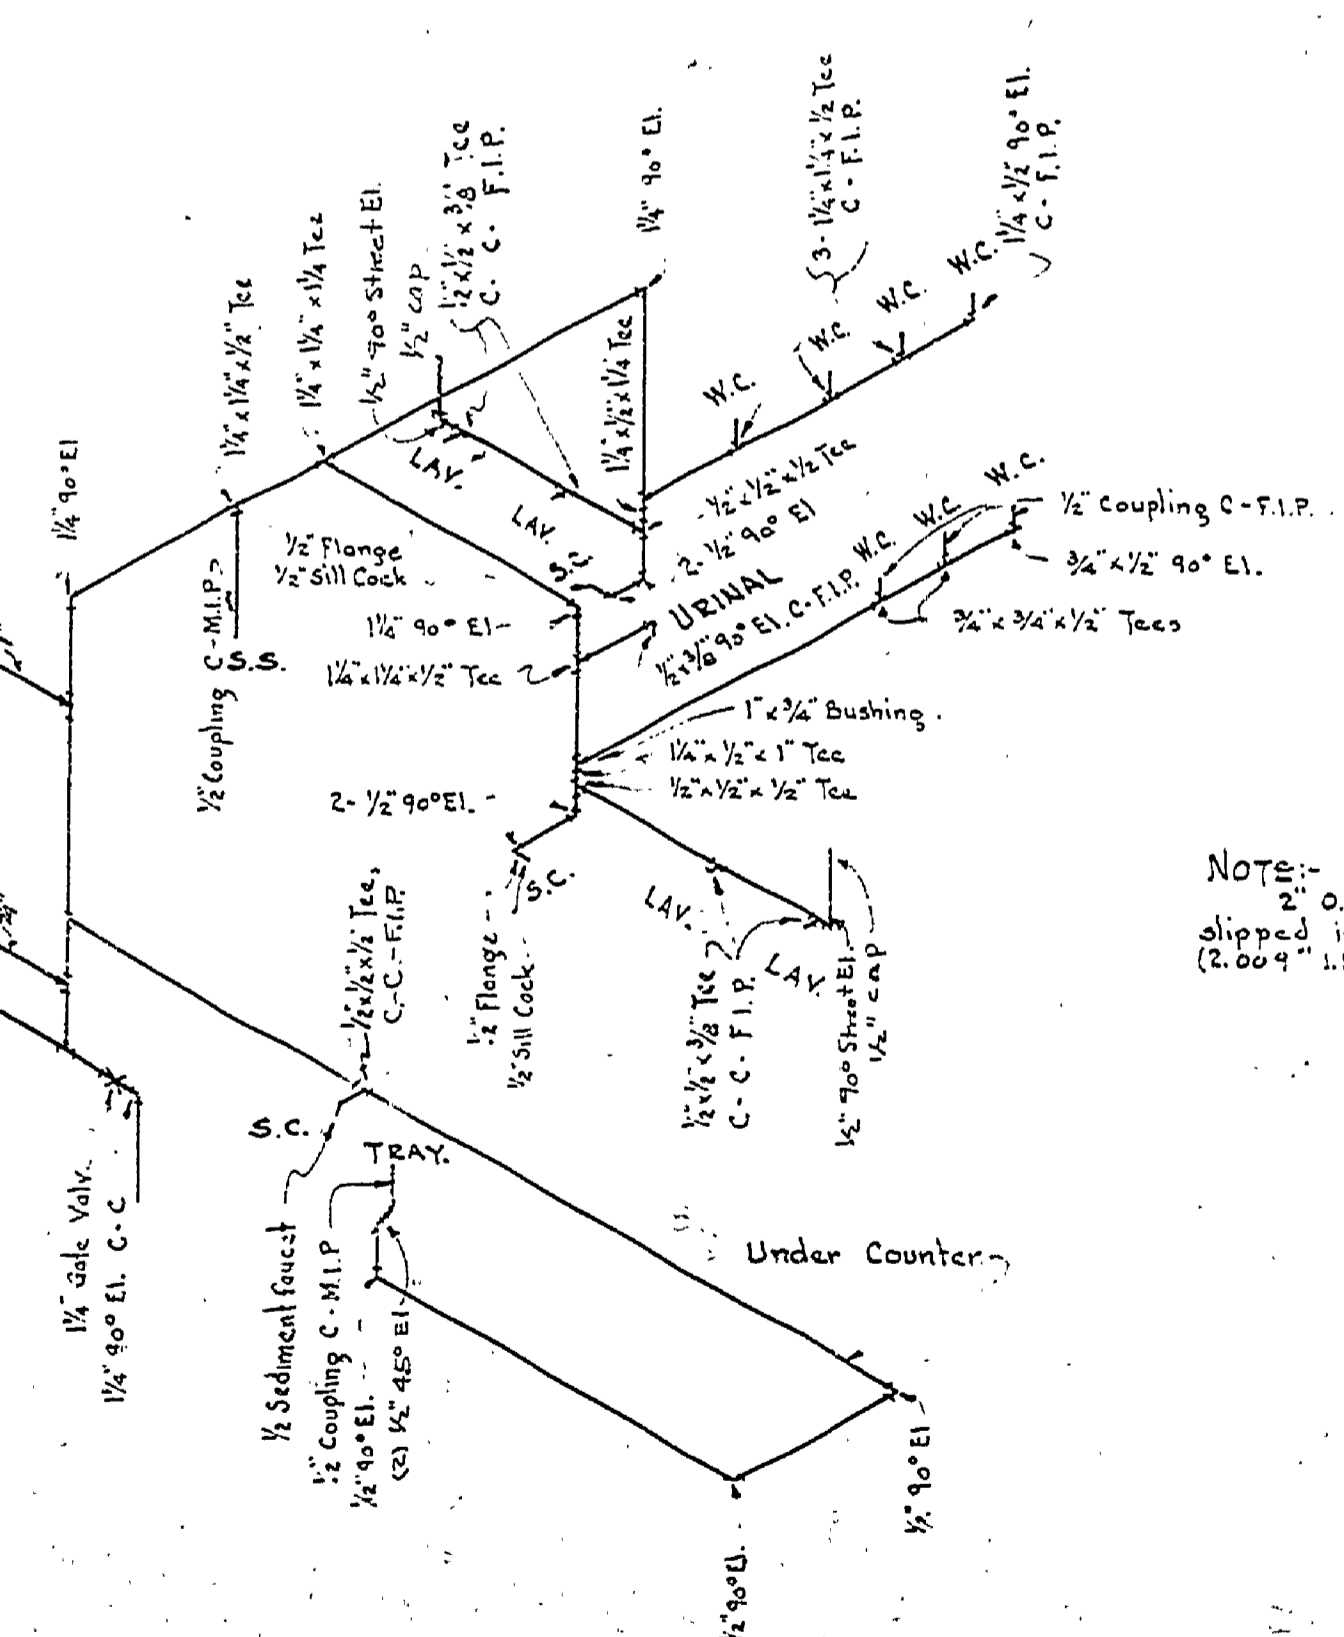


COLD WATER PIPE LAYOUT
No Scale.

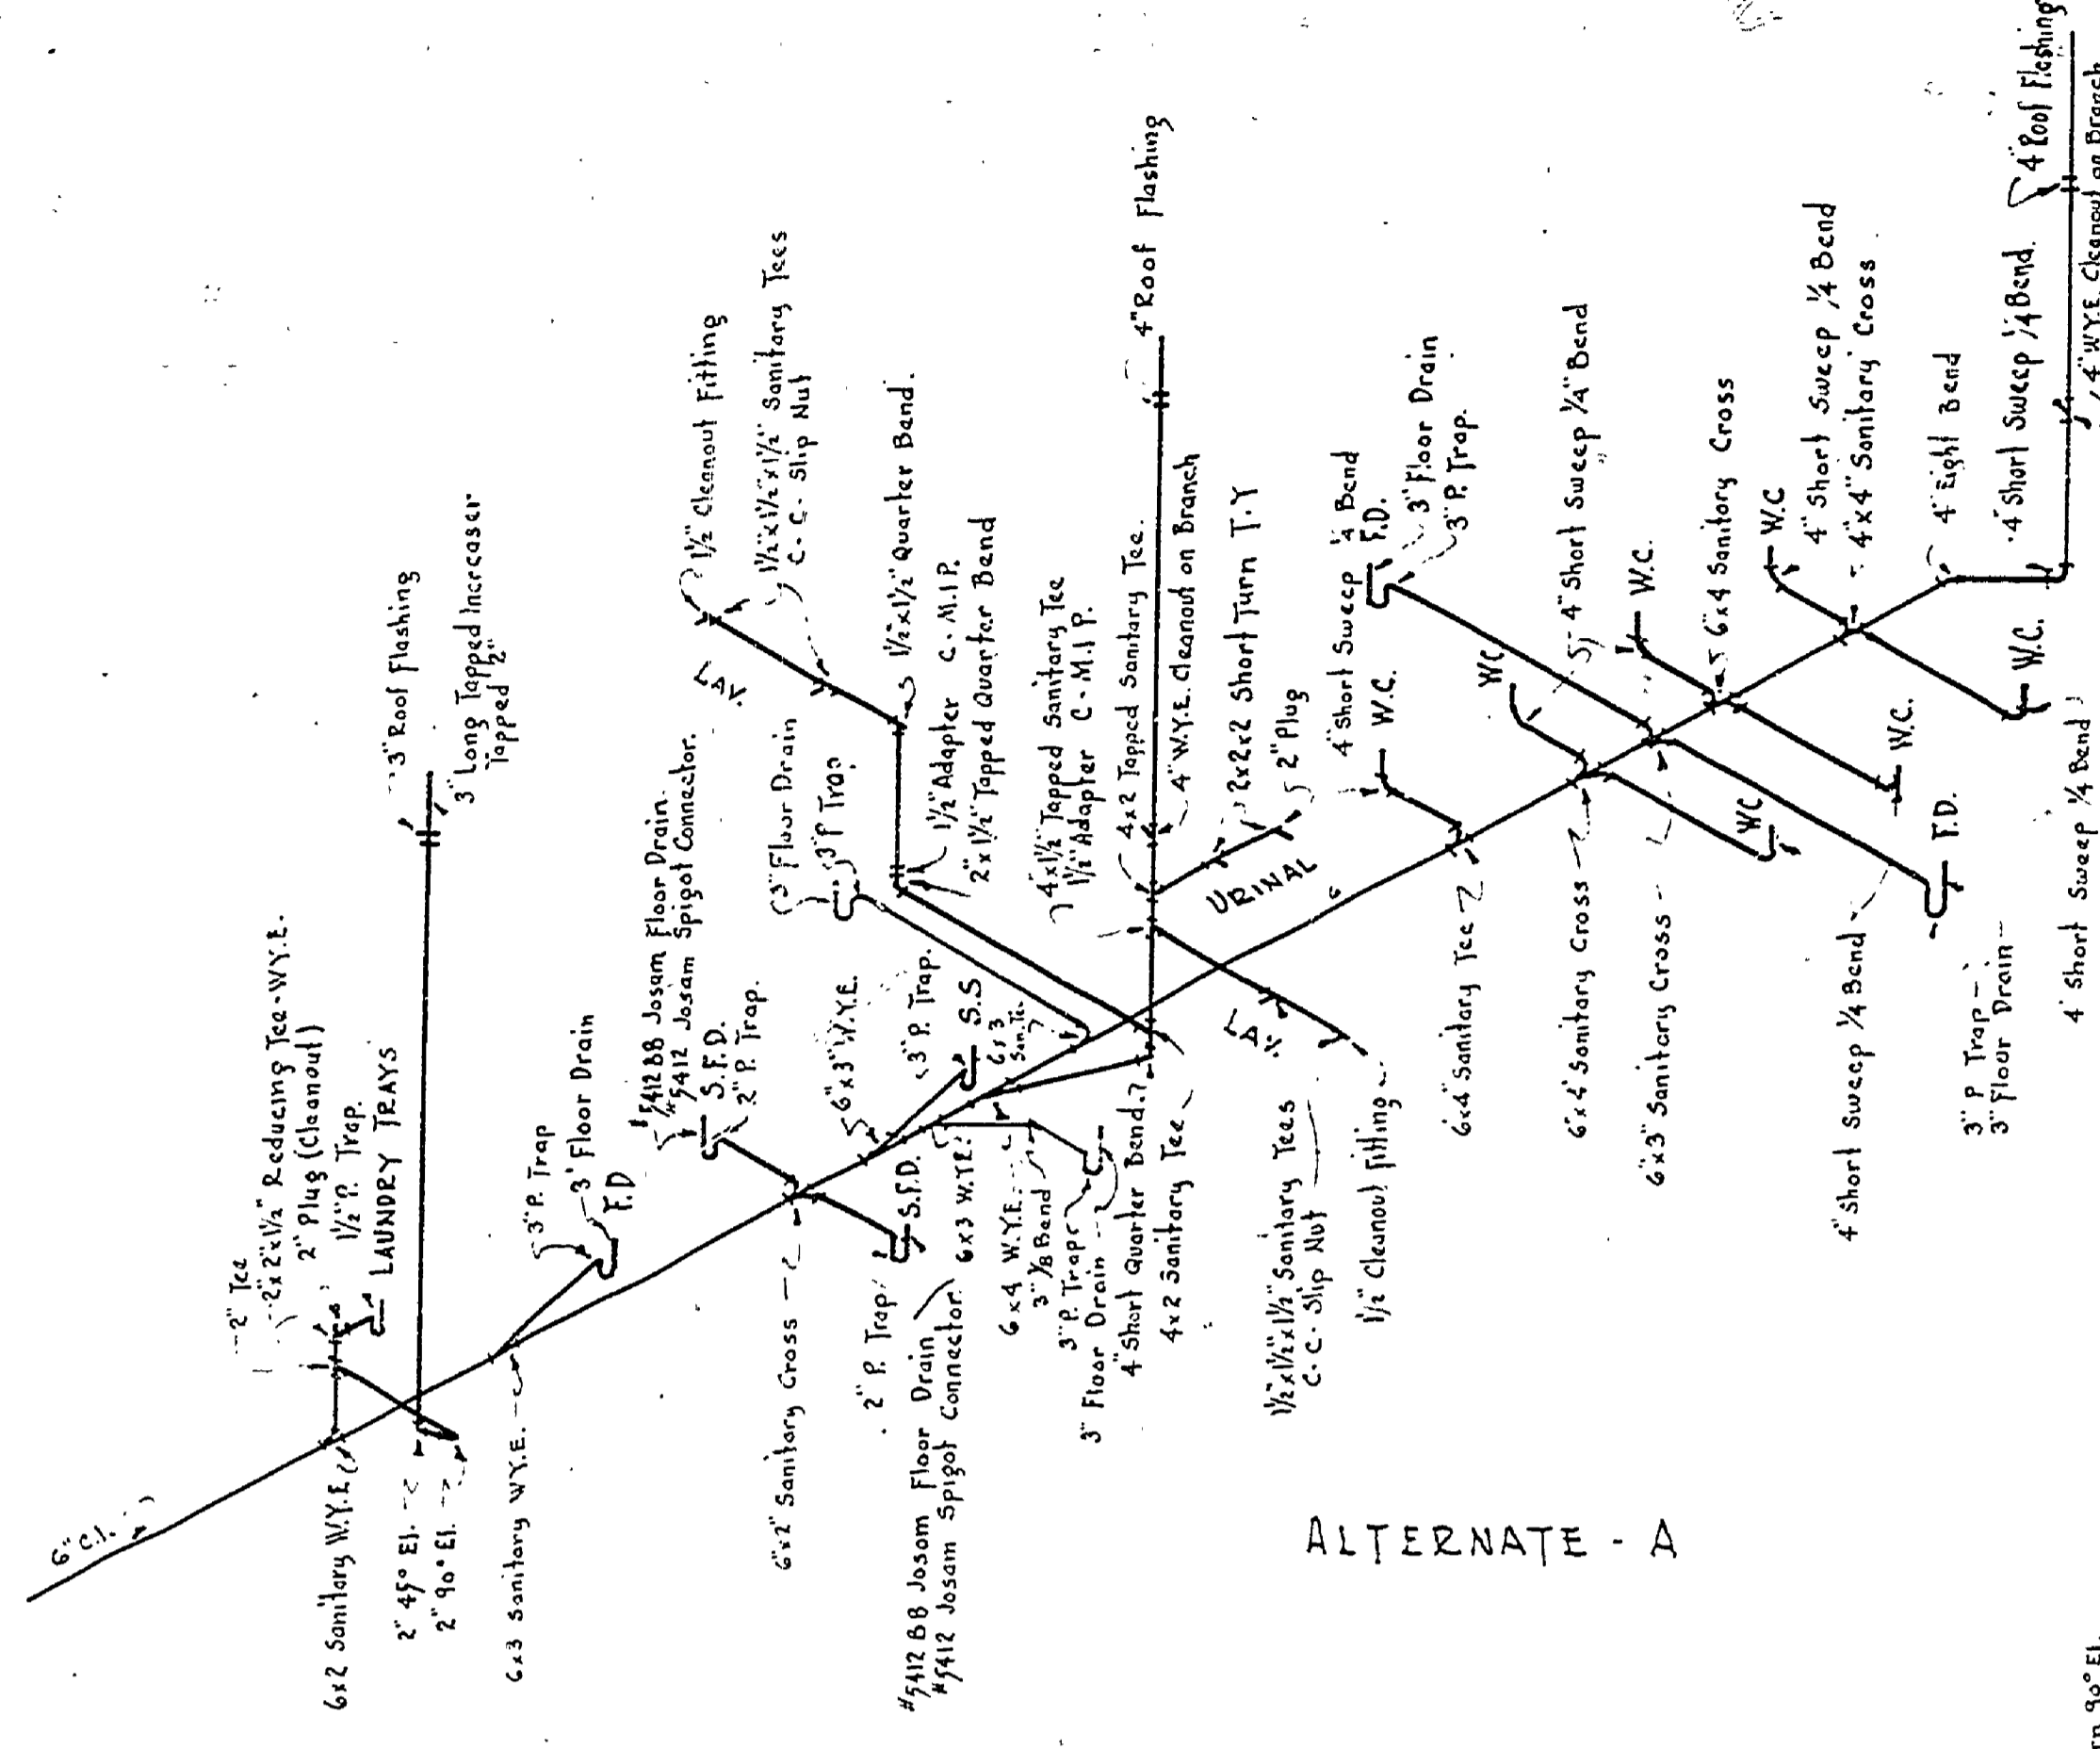


ALTERNATE - A

DRAINAGE PIPING DIAGRAM
No Scale.

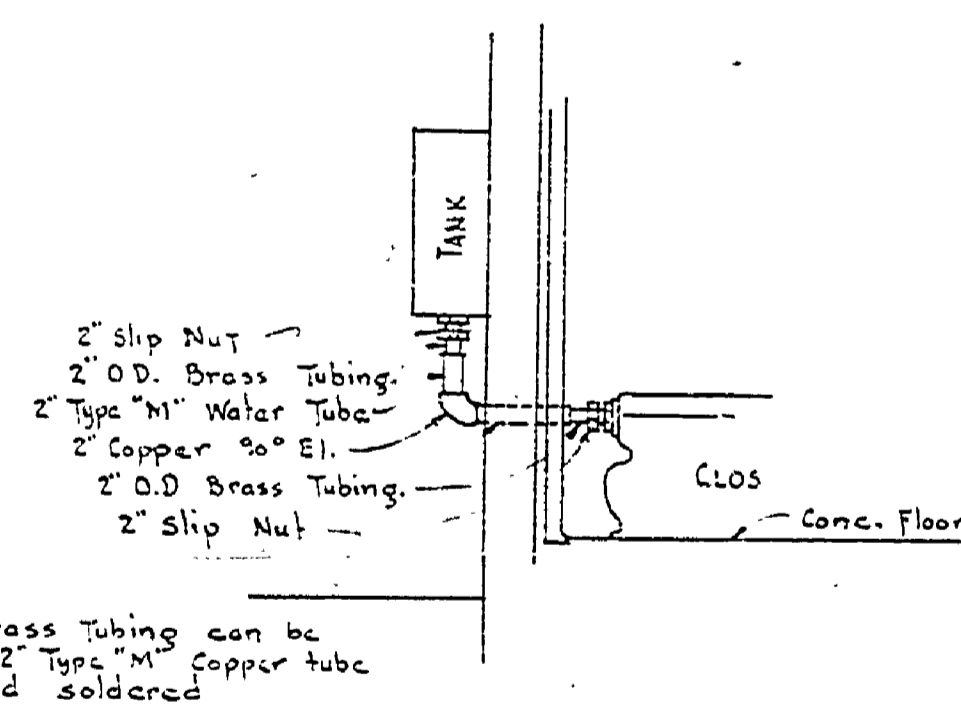


NOTE: 2" O.D. Brass Tubing can be shipped into a 2" M copper tube (2" I.D.) and soldered.

- ELECTRICAL SYMBOLS:
- ceiling Light Outlet
 - Recessed Ceiling Light Outlet
 - Lamp Holder with Pull Switch
 - Wall Bracket Light Outlet
 - Fluorescent Lampholder
 - Duplex Convenience Outlet
 - Special Outlet
 - Single Switch
 - Panel Box

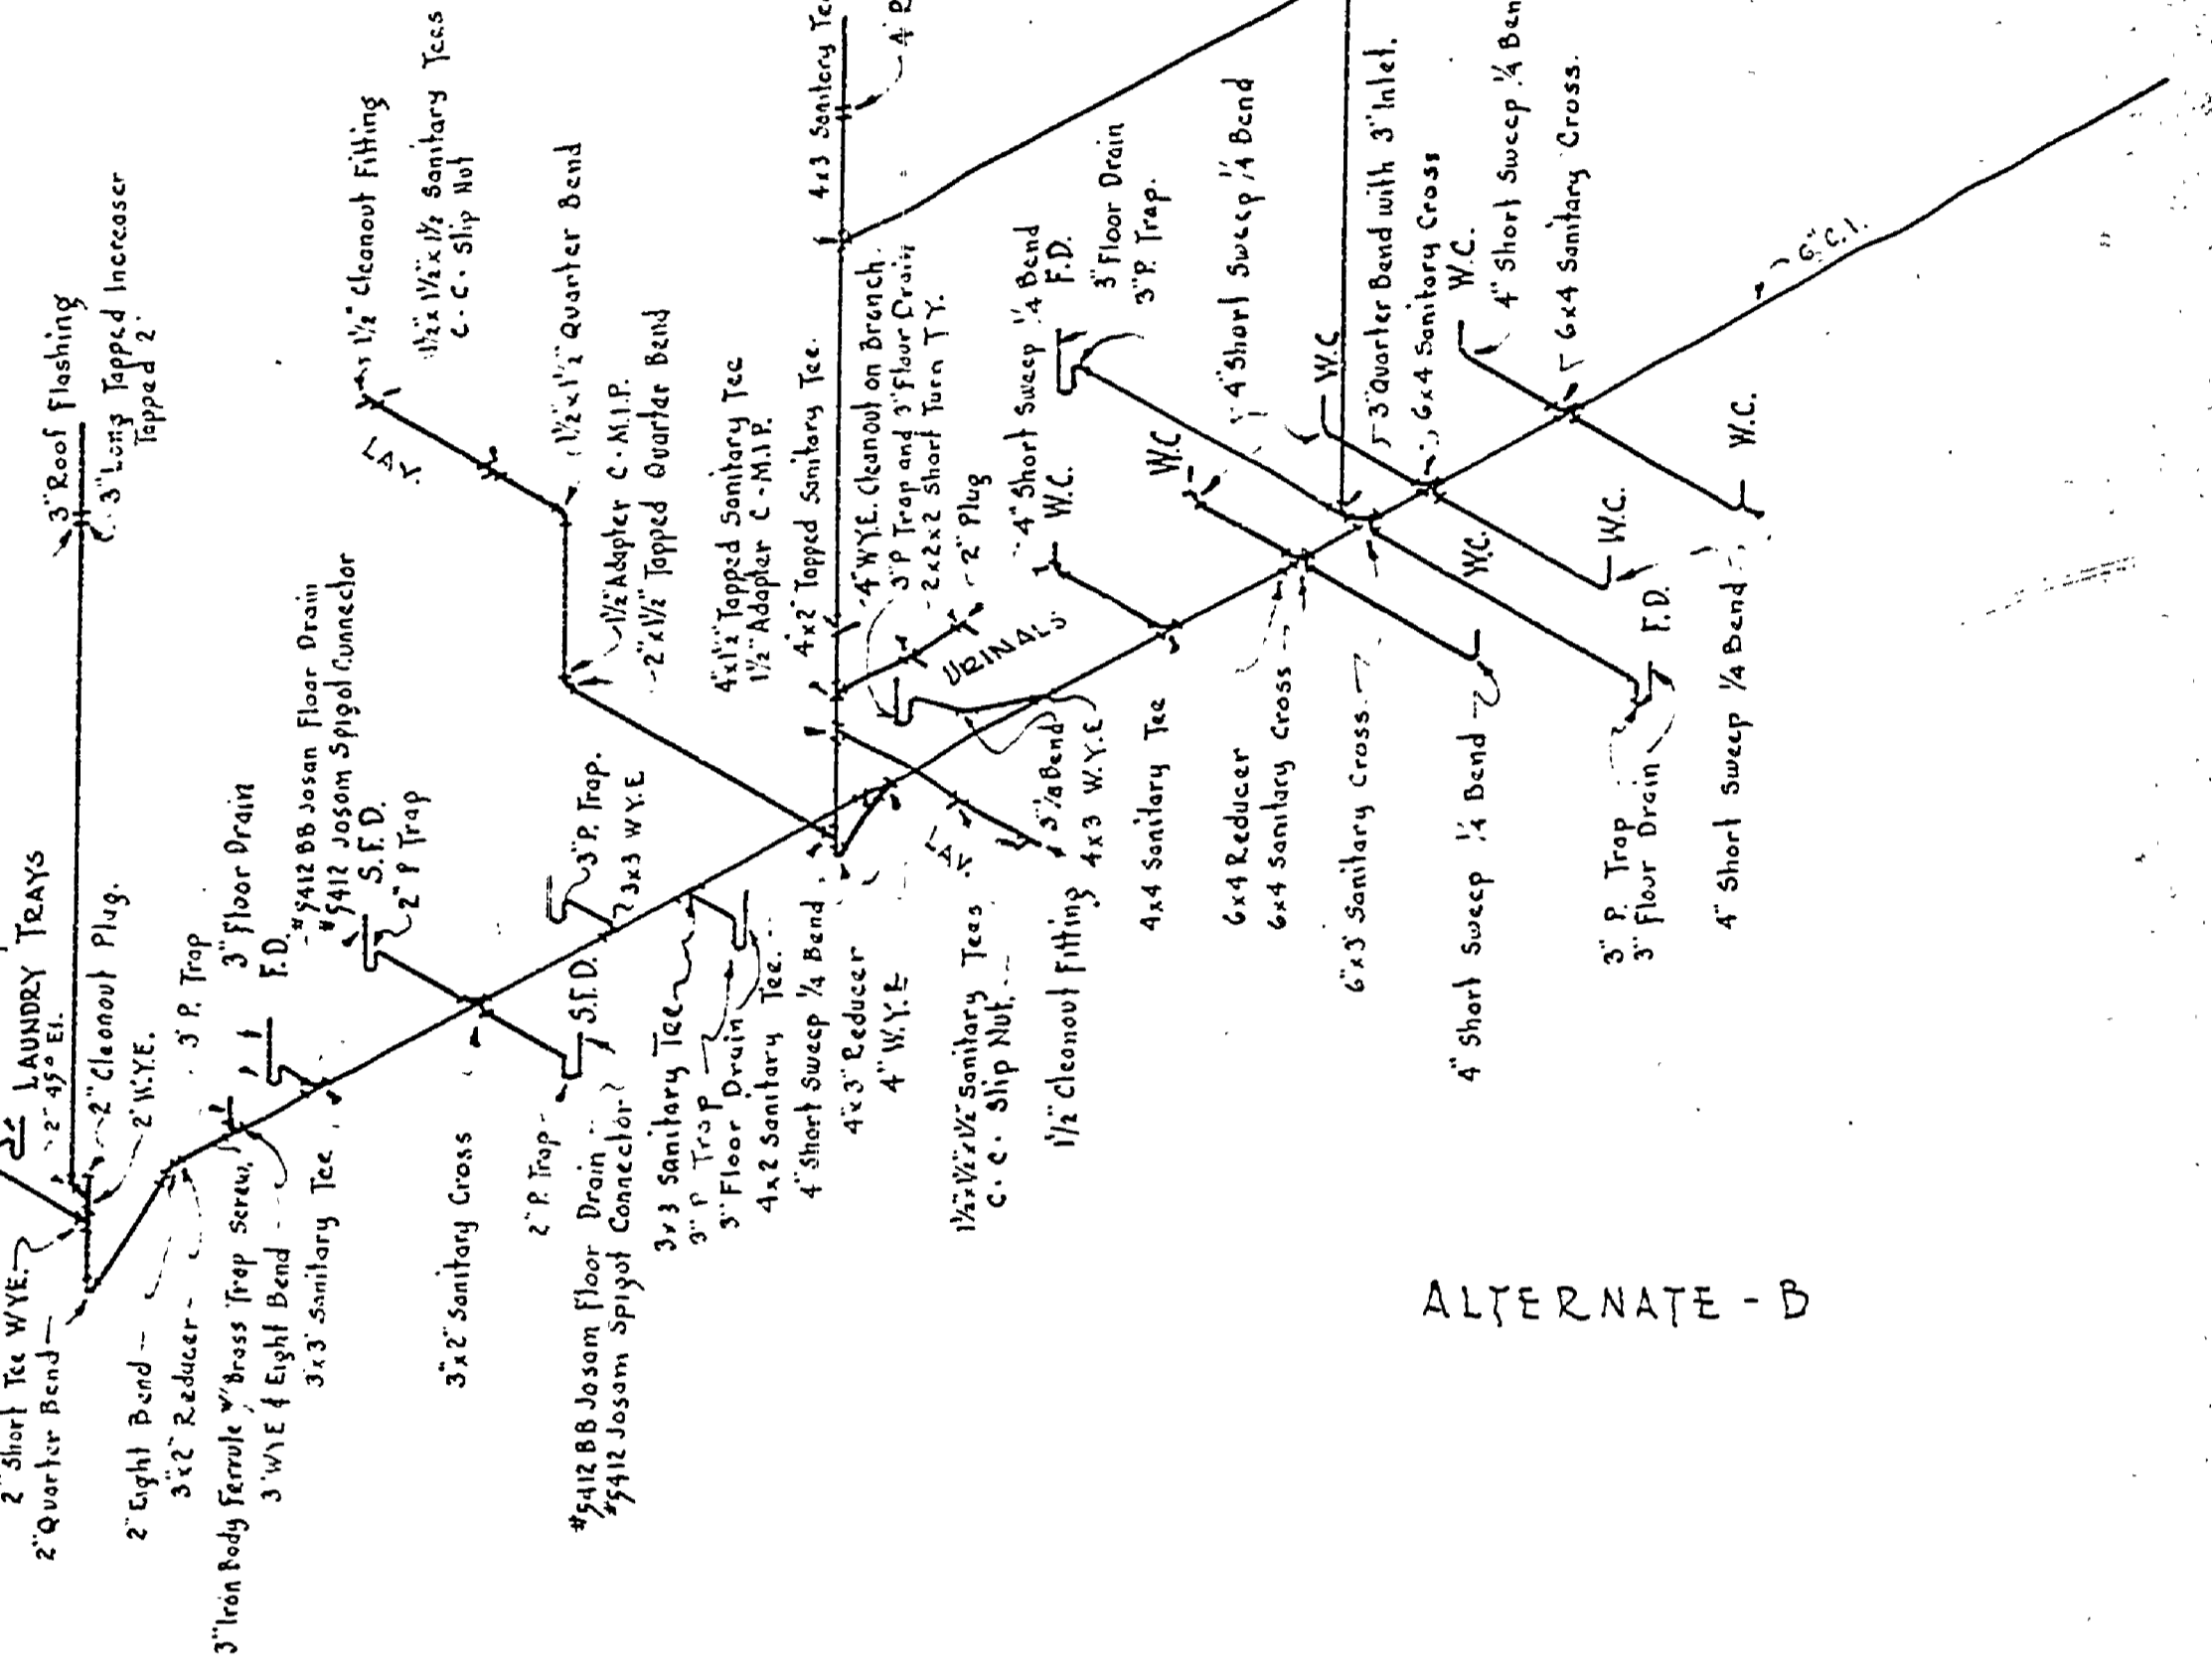

ALTERNATE - B

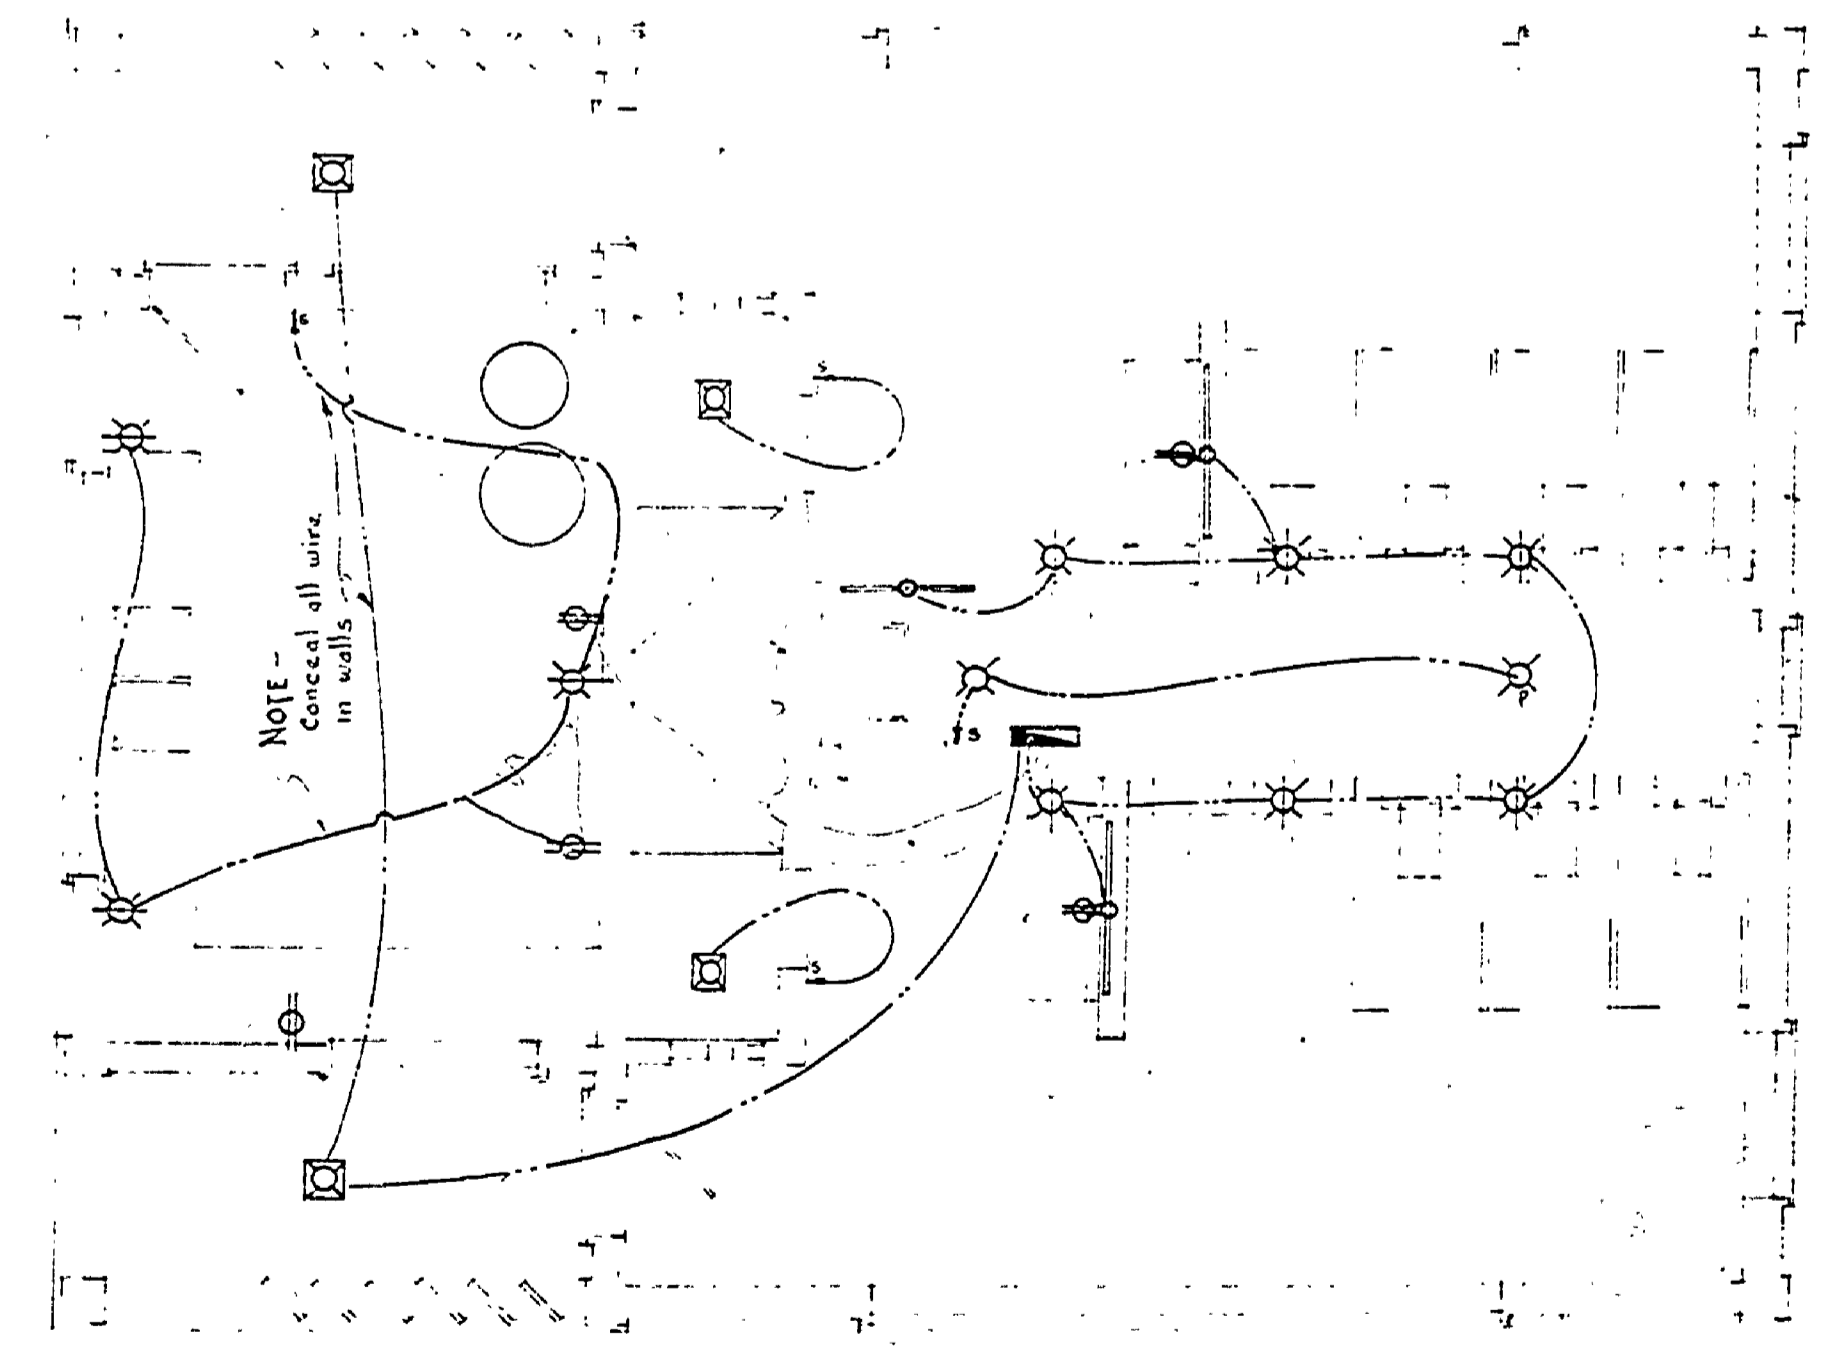

ELECTRICAL LAYOUT
Plan Scale 1/4" = 1'-0"