
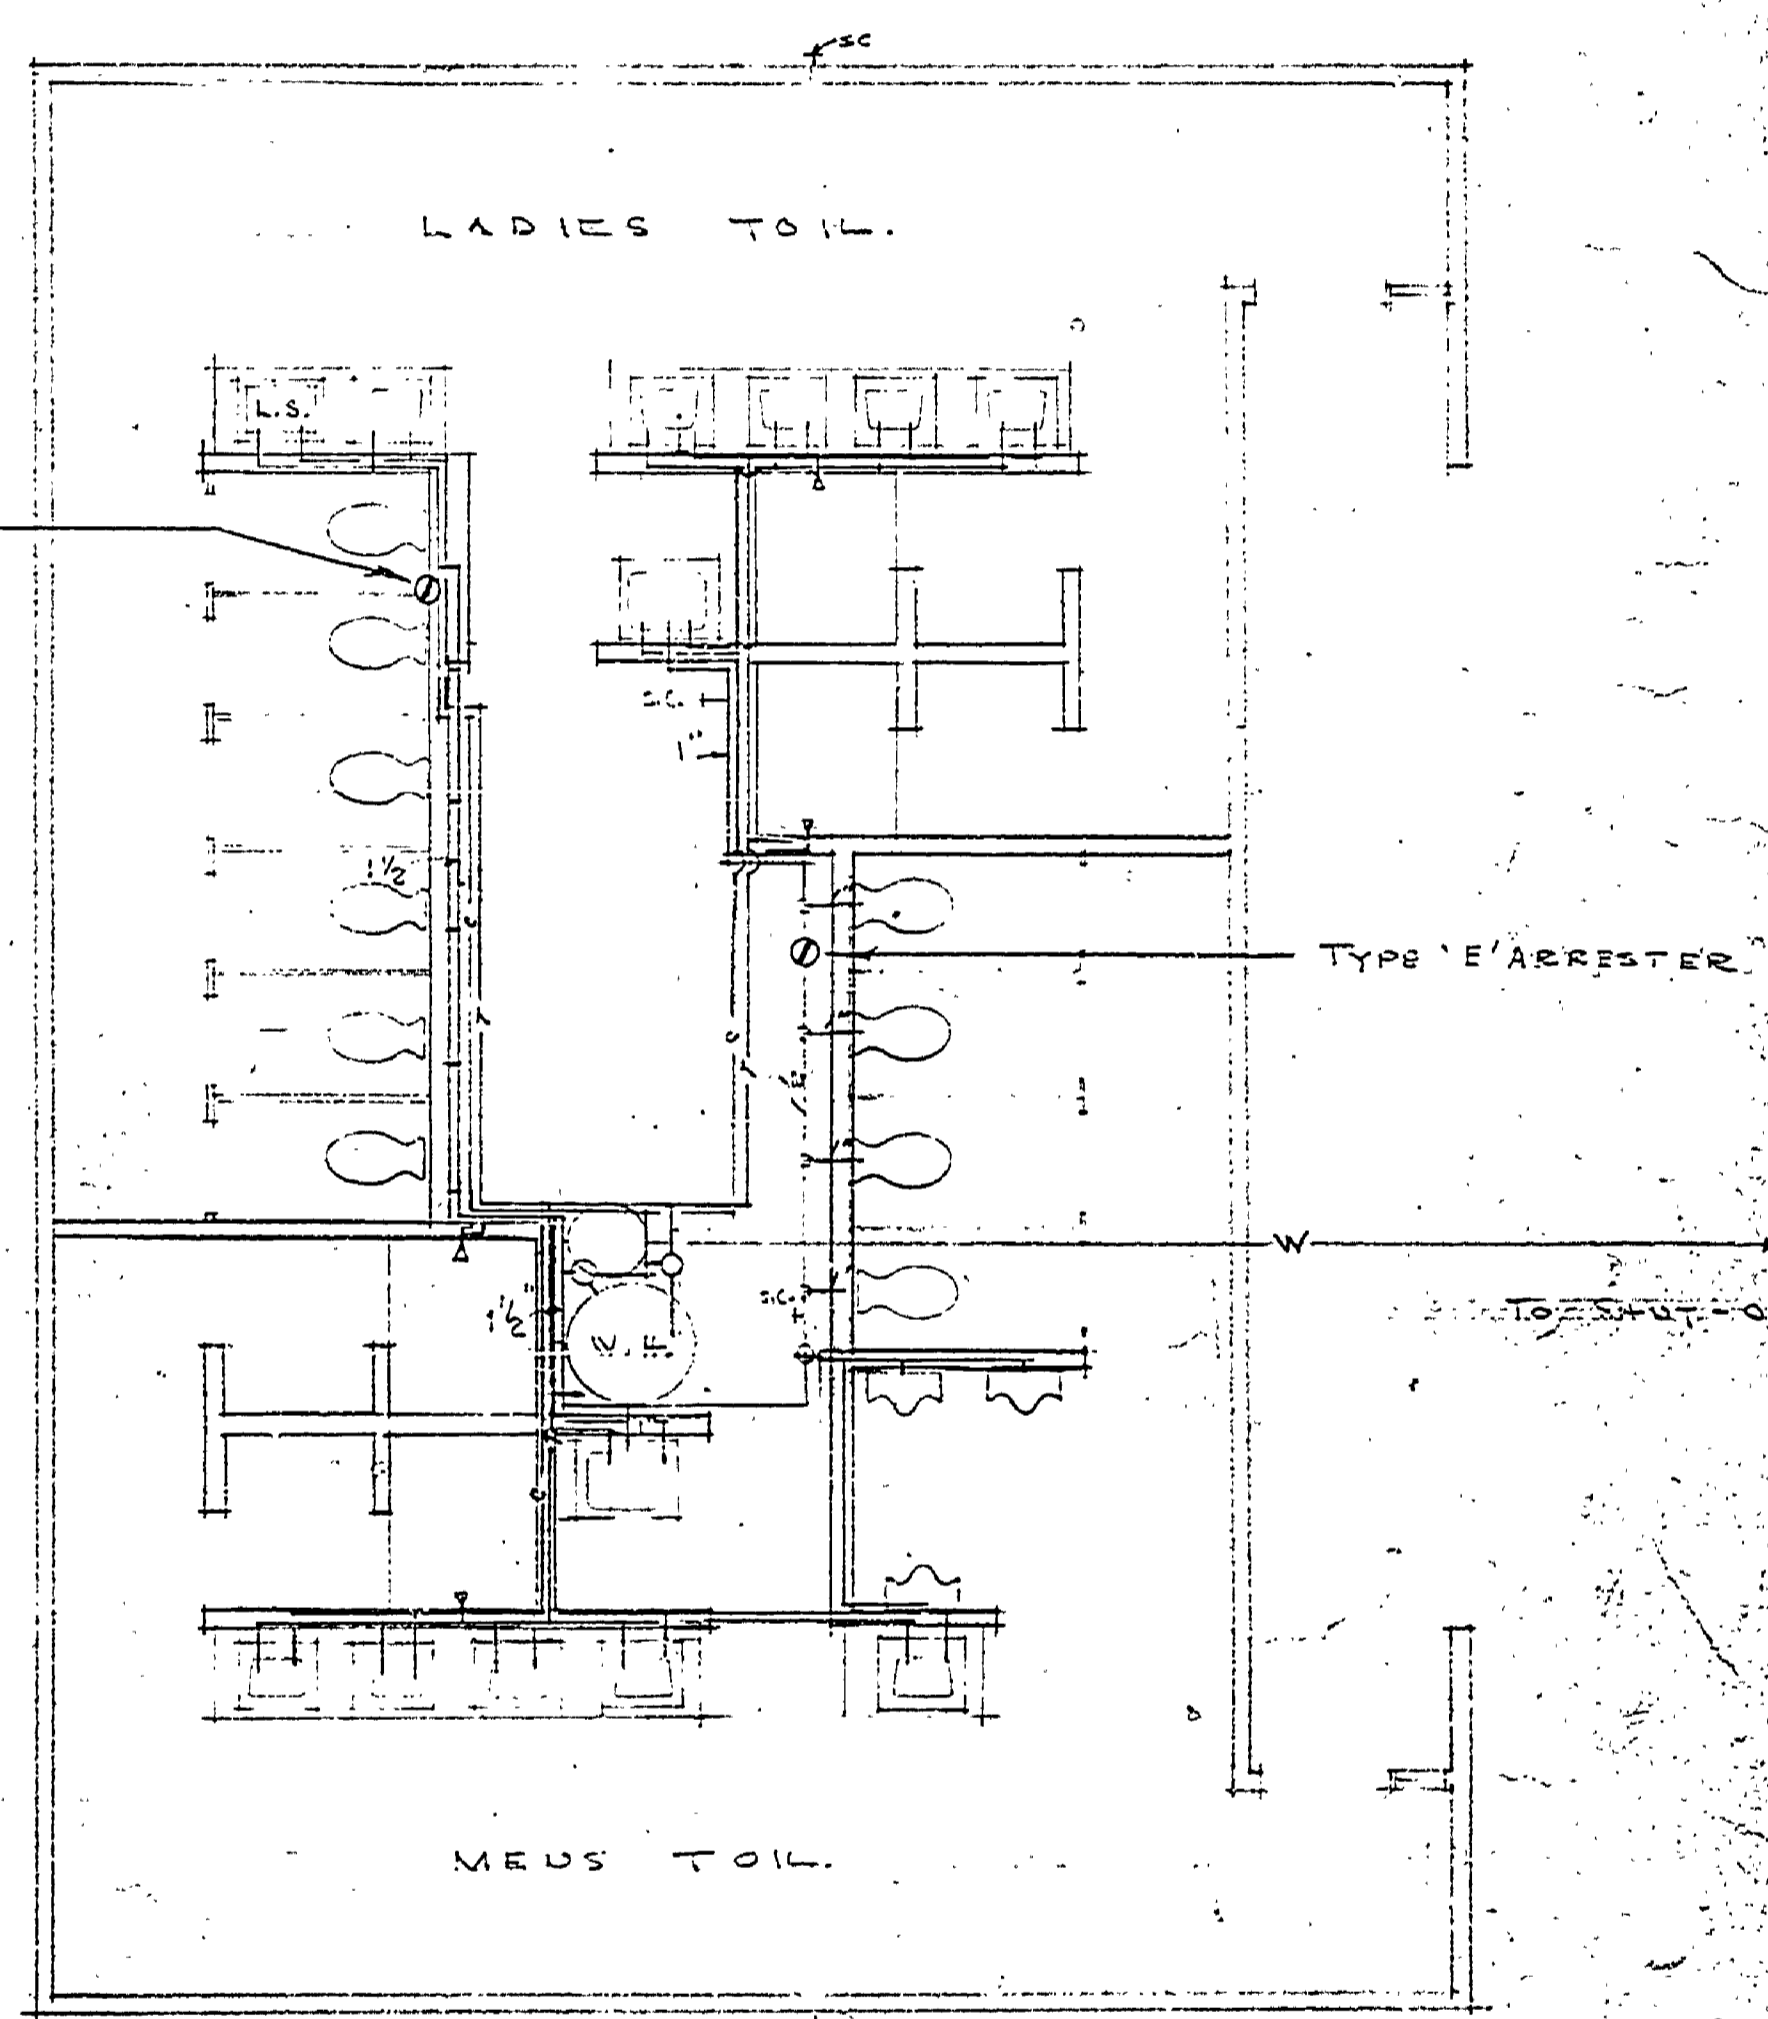
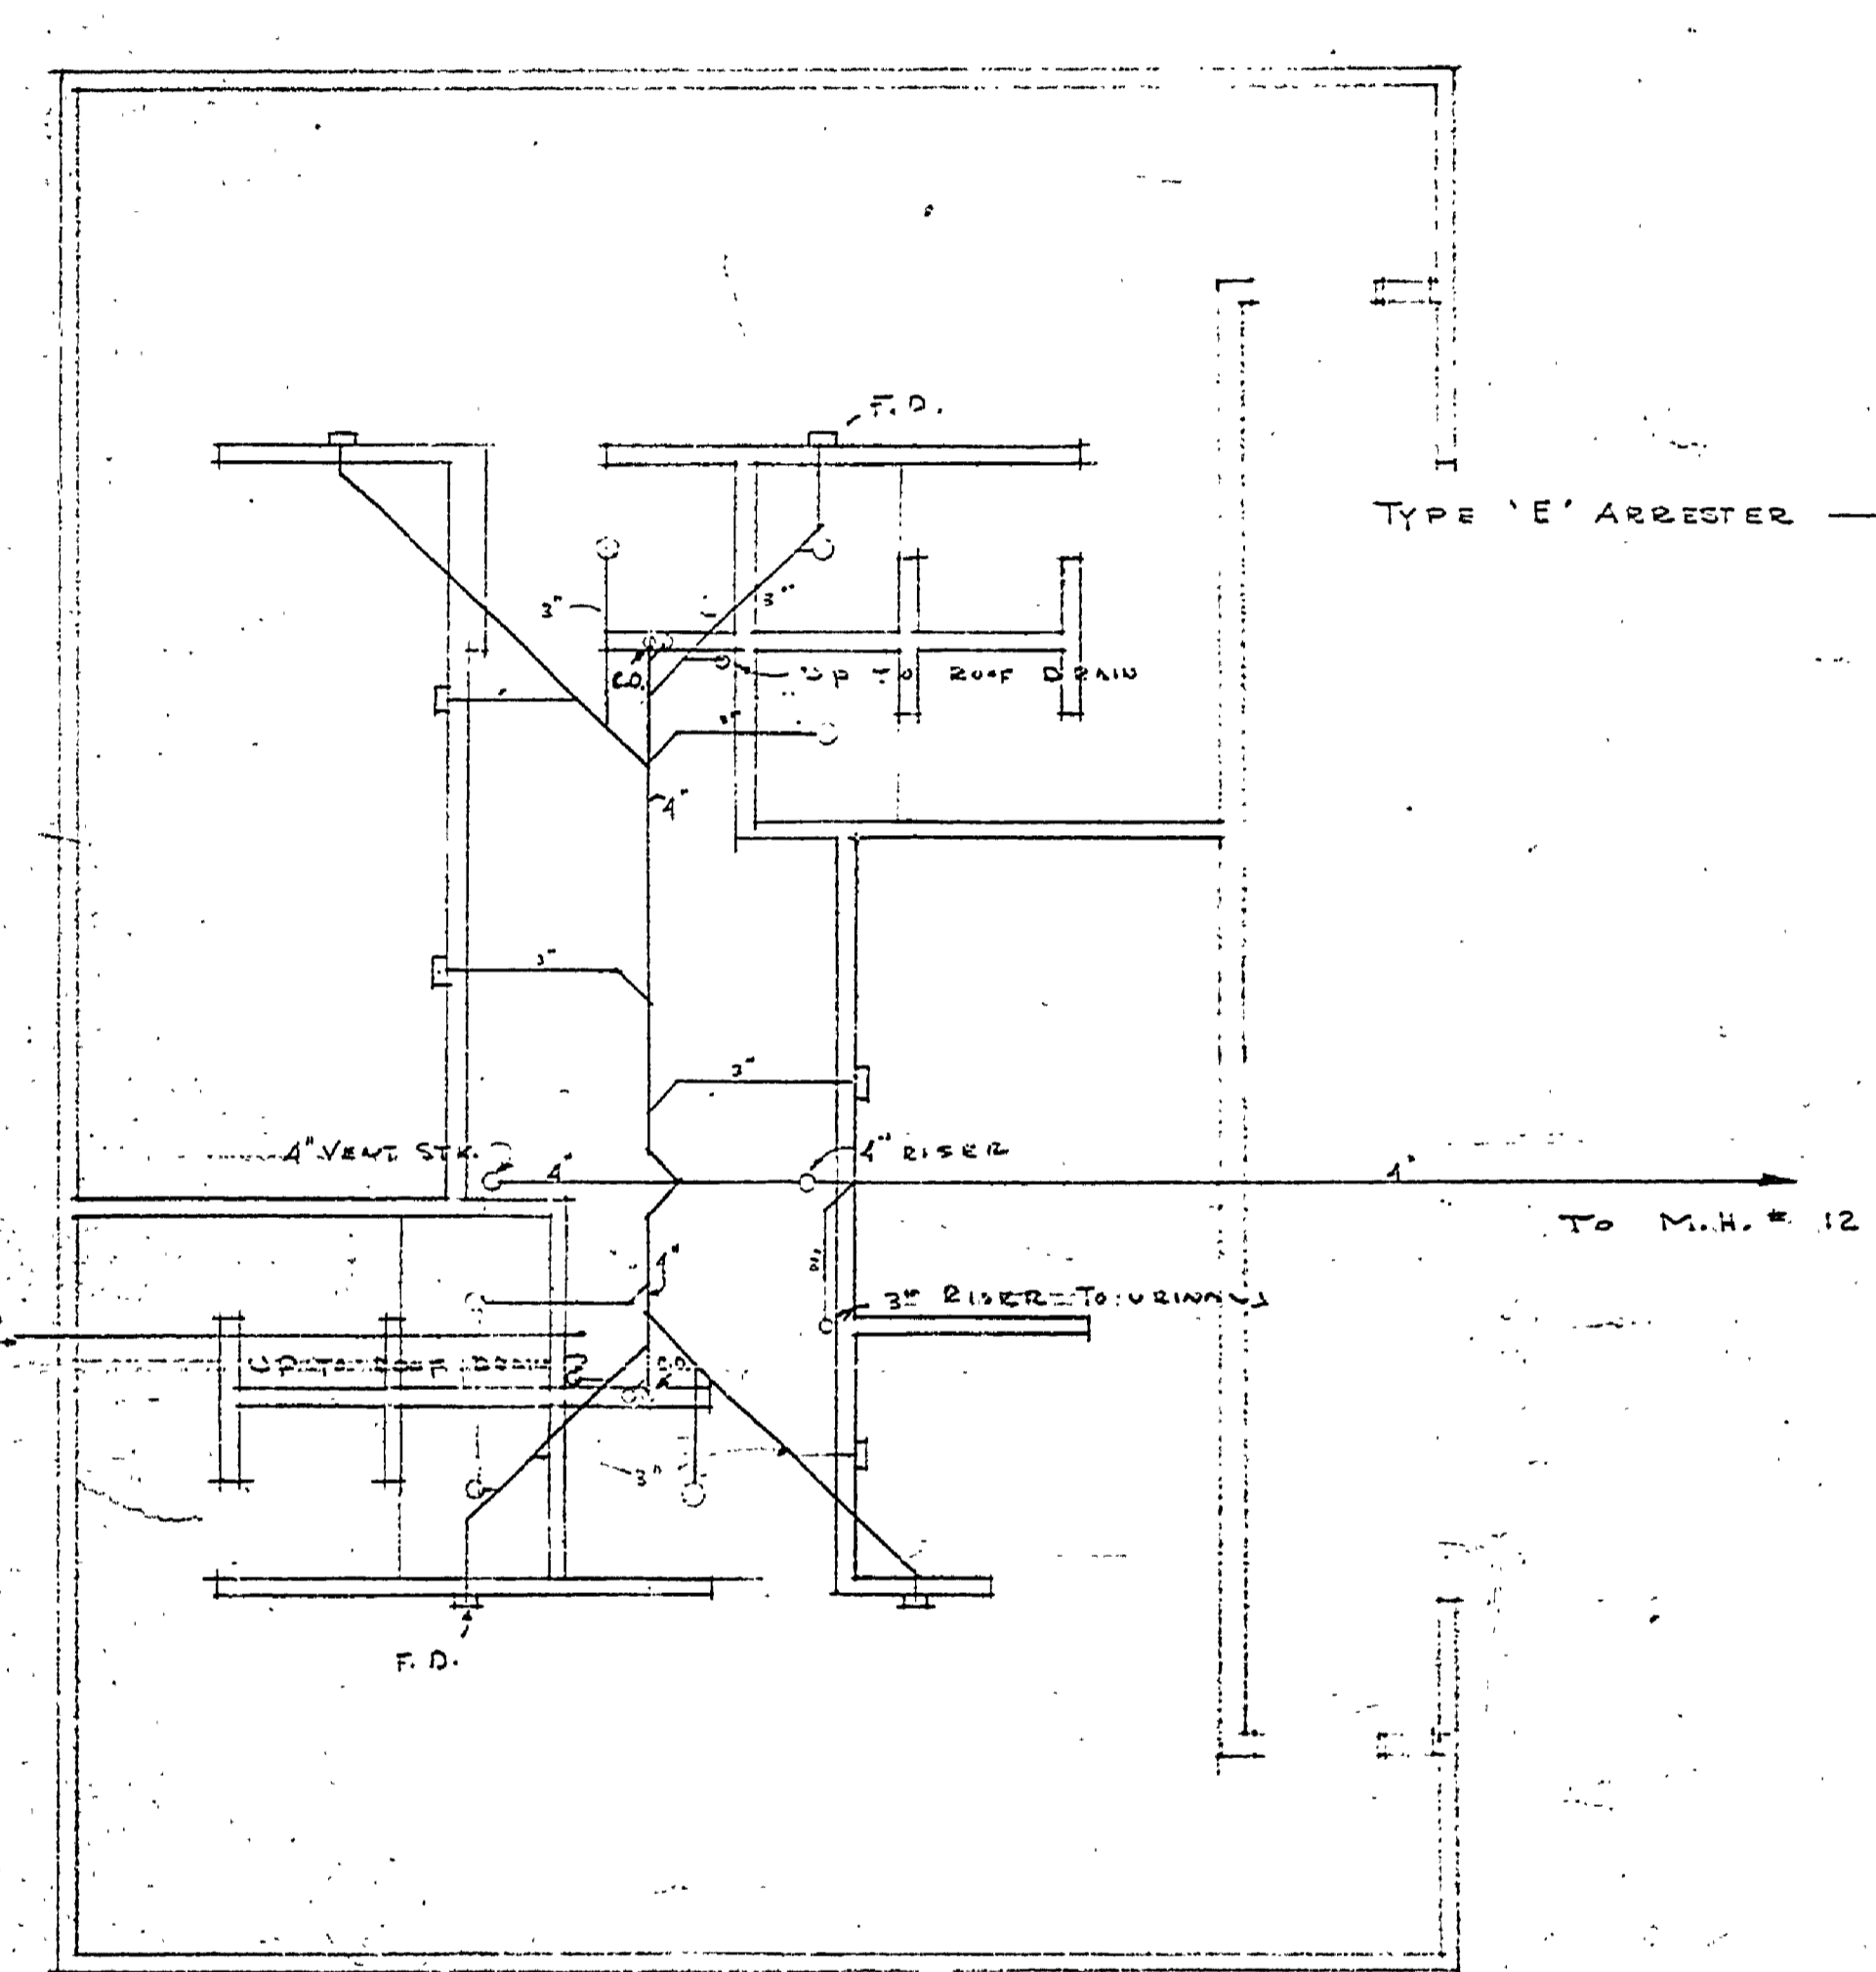
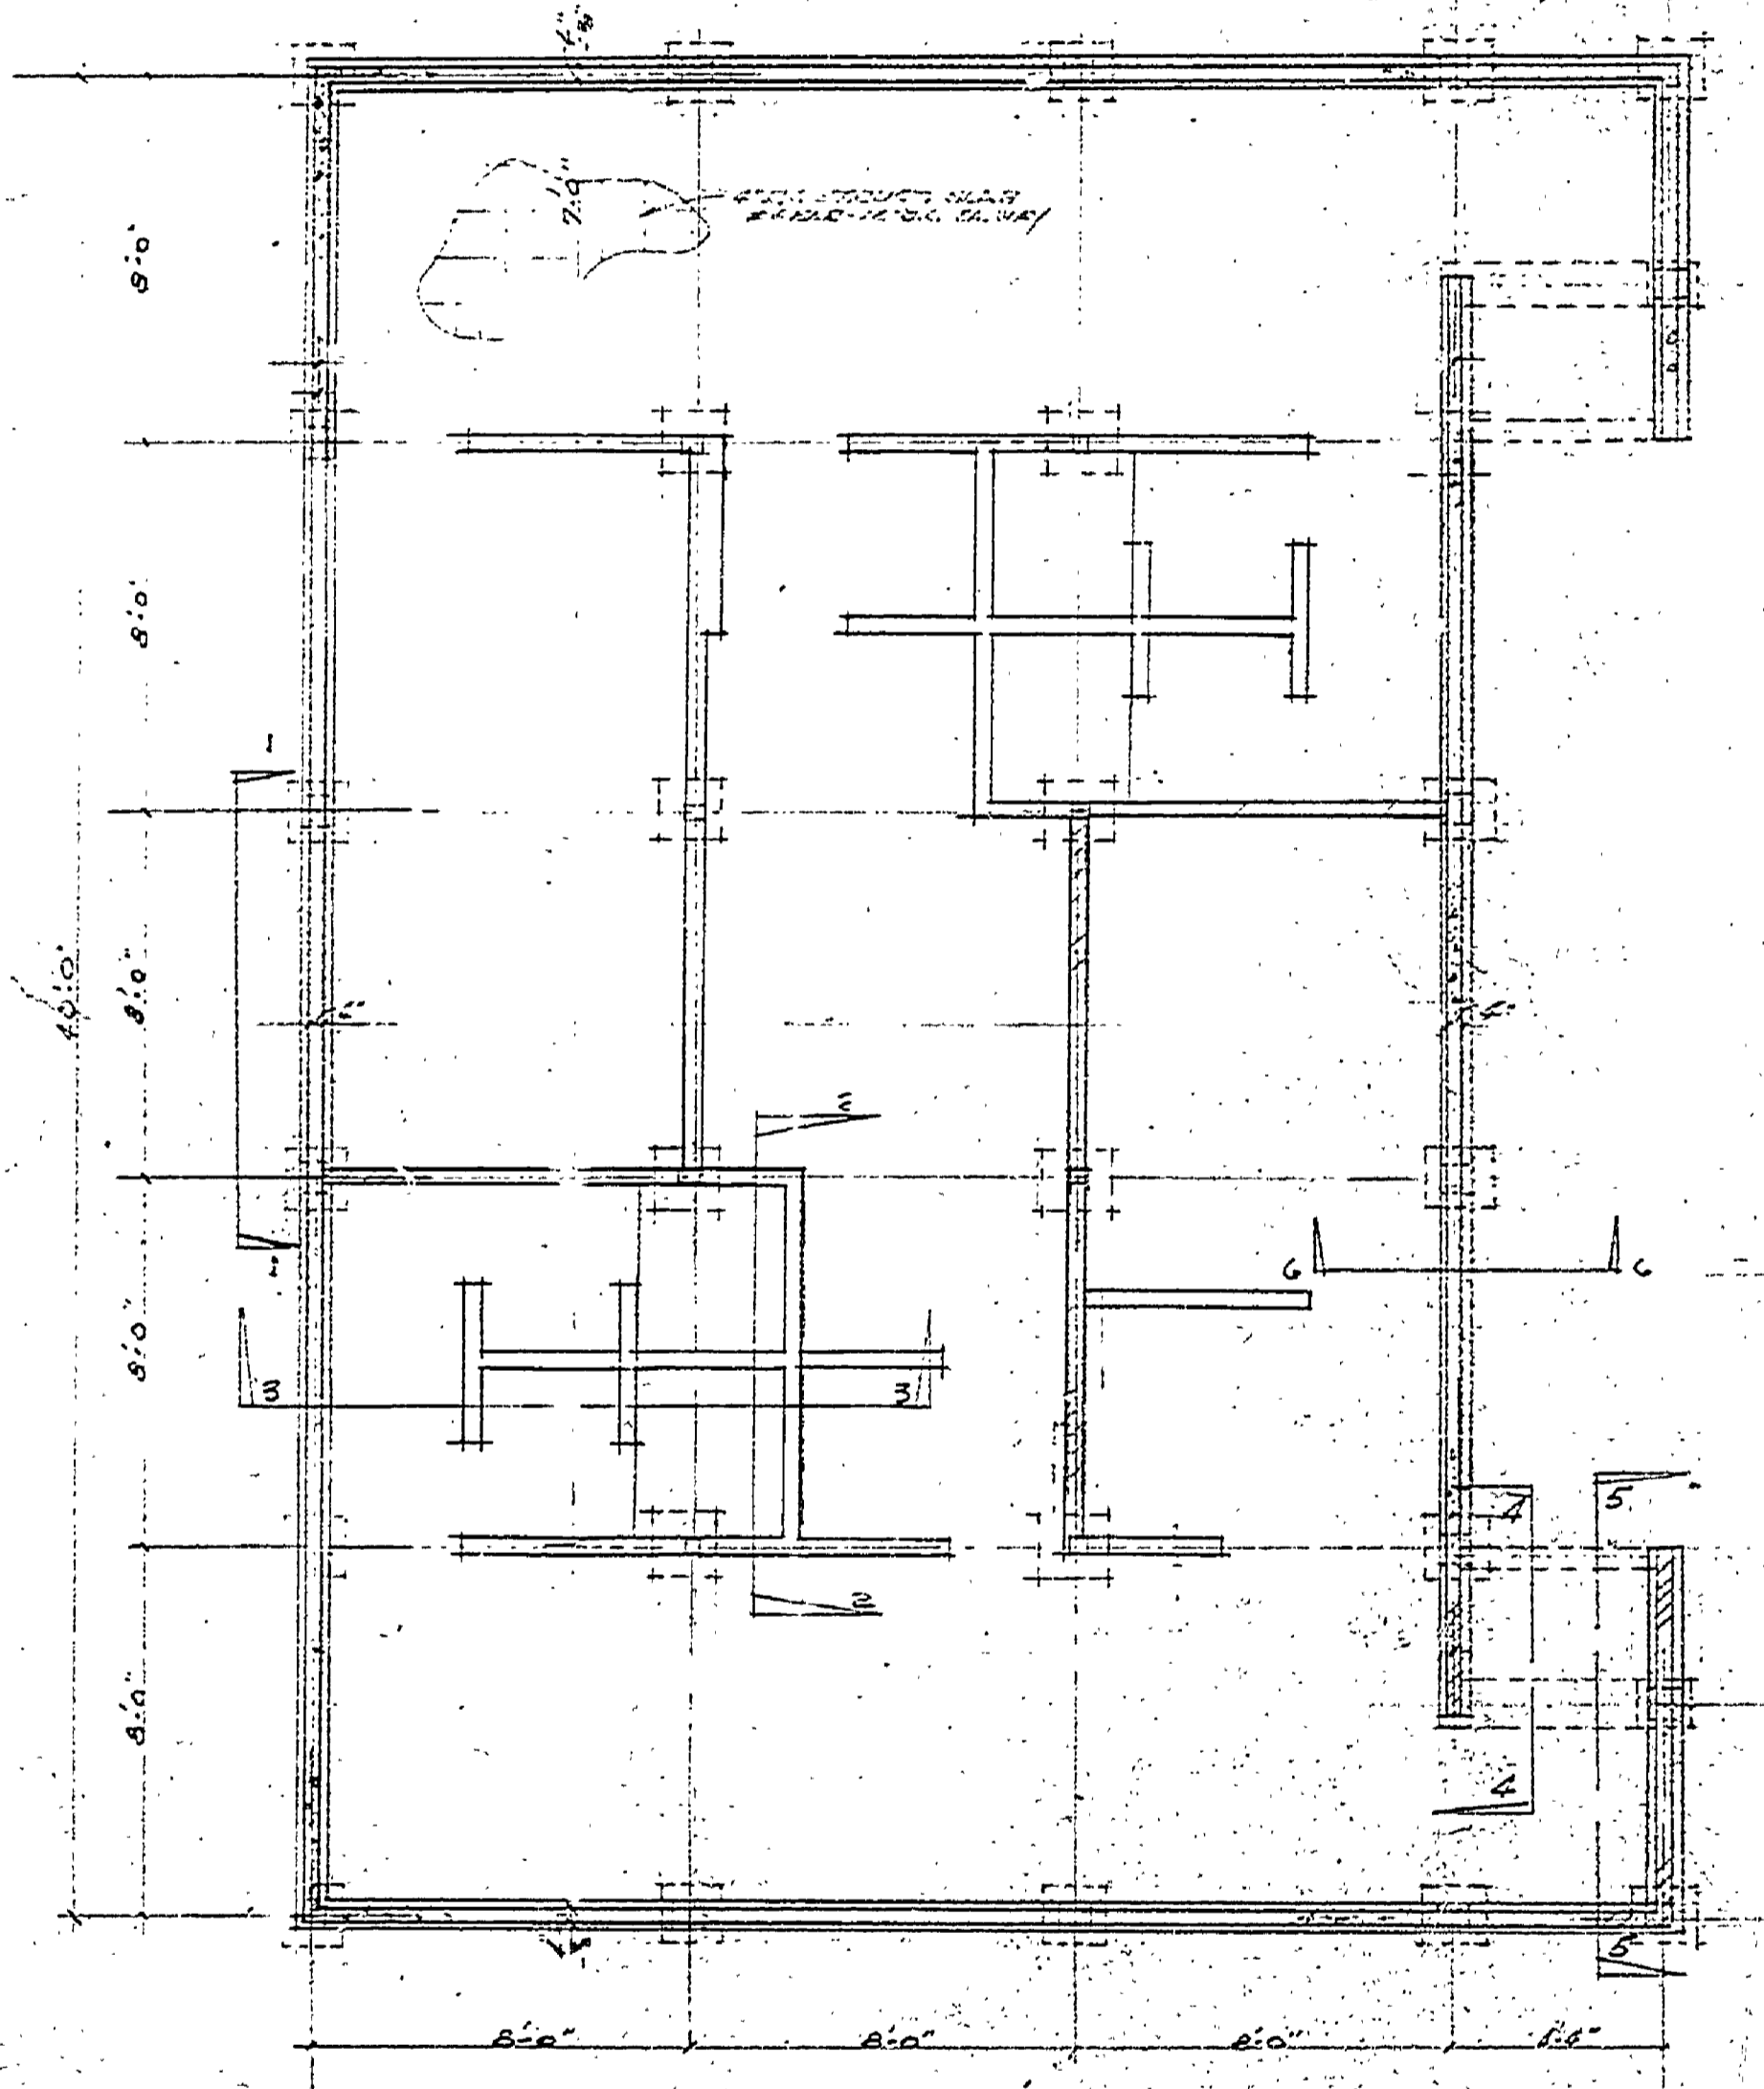


DESIGNED BY	DATE	REVIEWED	DATE	APPROVED	DATE	NO.	DATE BY	REVISIONS	DATE BY
W.A.C.	3-20-61	ARCHITECTURAL	3-11-61	<i>[Signature]</i>	12-05	1	R.V.B.	4	
DRAWN BY	3-20-61	ENGINEERING	3-11-61	<i>[Signature]</i>	2	2		5	
CHECKED BY	3-20-61	LANDSCAPE	3-12-61	<i>[Signature]</i>	3	3		6	

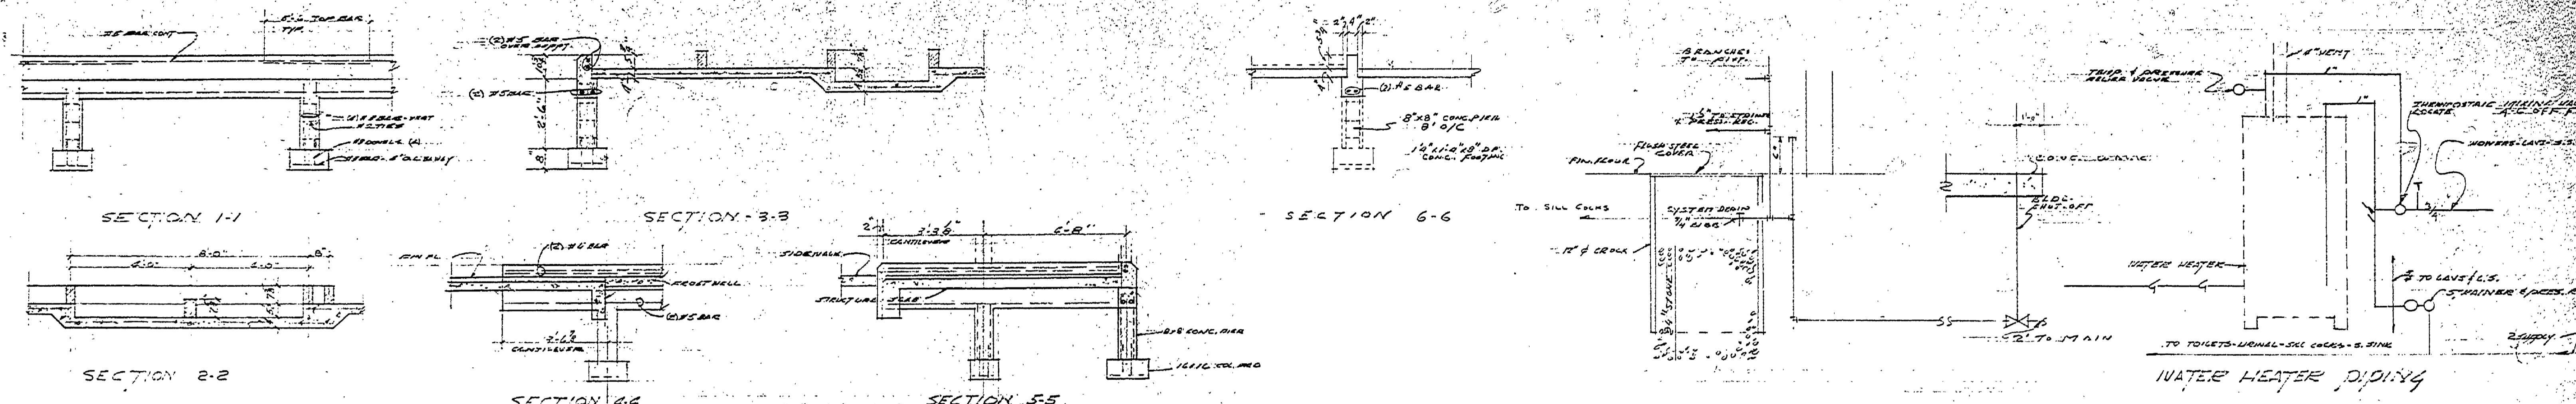

FOUNDATION PLAN

PLUMBING PLAN

PLUMBING PLAN

MICHIGAN
DEPARTMENT OF CONSERVATION
PARKS AND RECREATION DIVISION

FOUNDATION PLAN - PLUMBING PLANS
ALOHA STATE PARK
TOILET & SHOWER BUILDING #8
SHEET NO. 2 OF 5
PLAN NO. A-102