

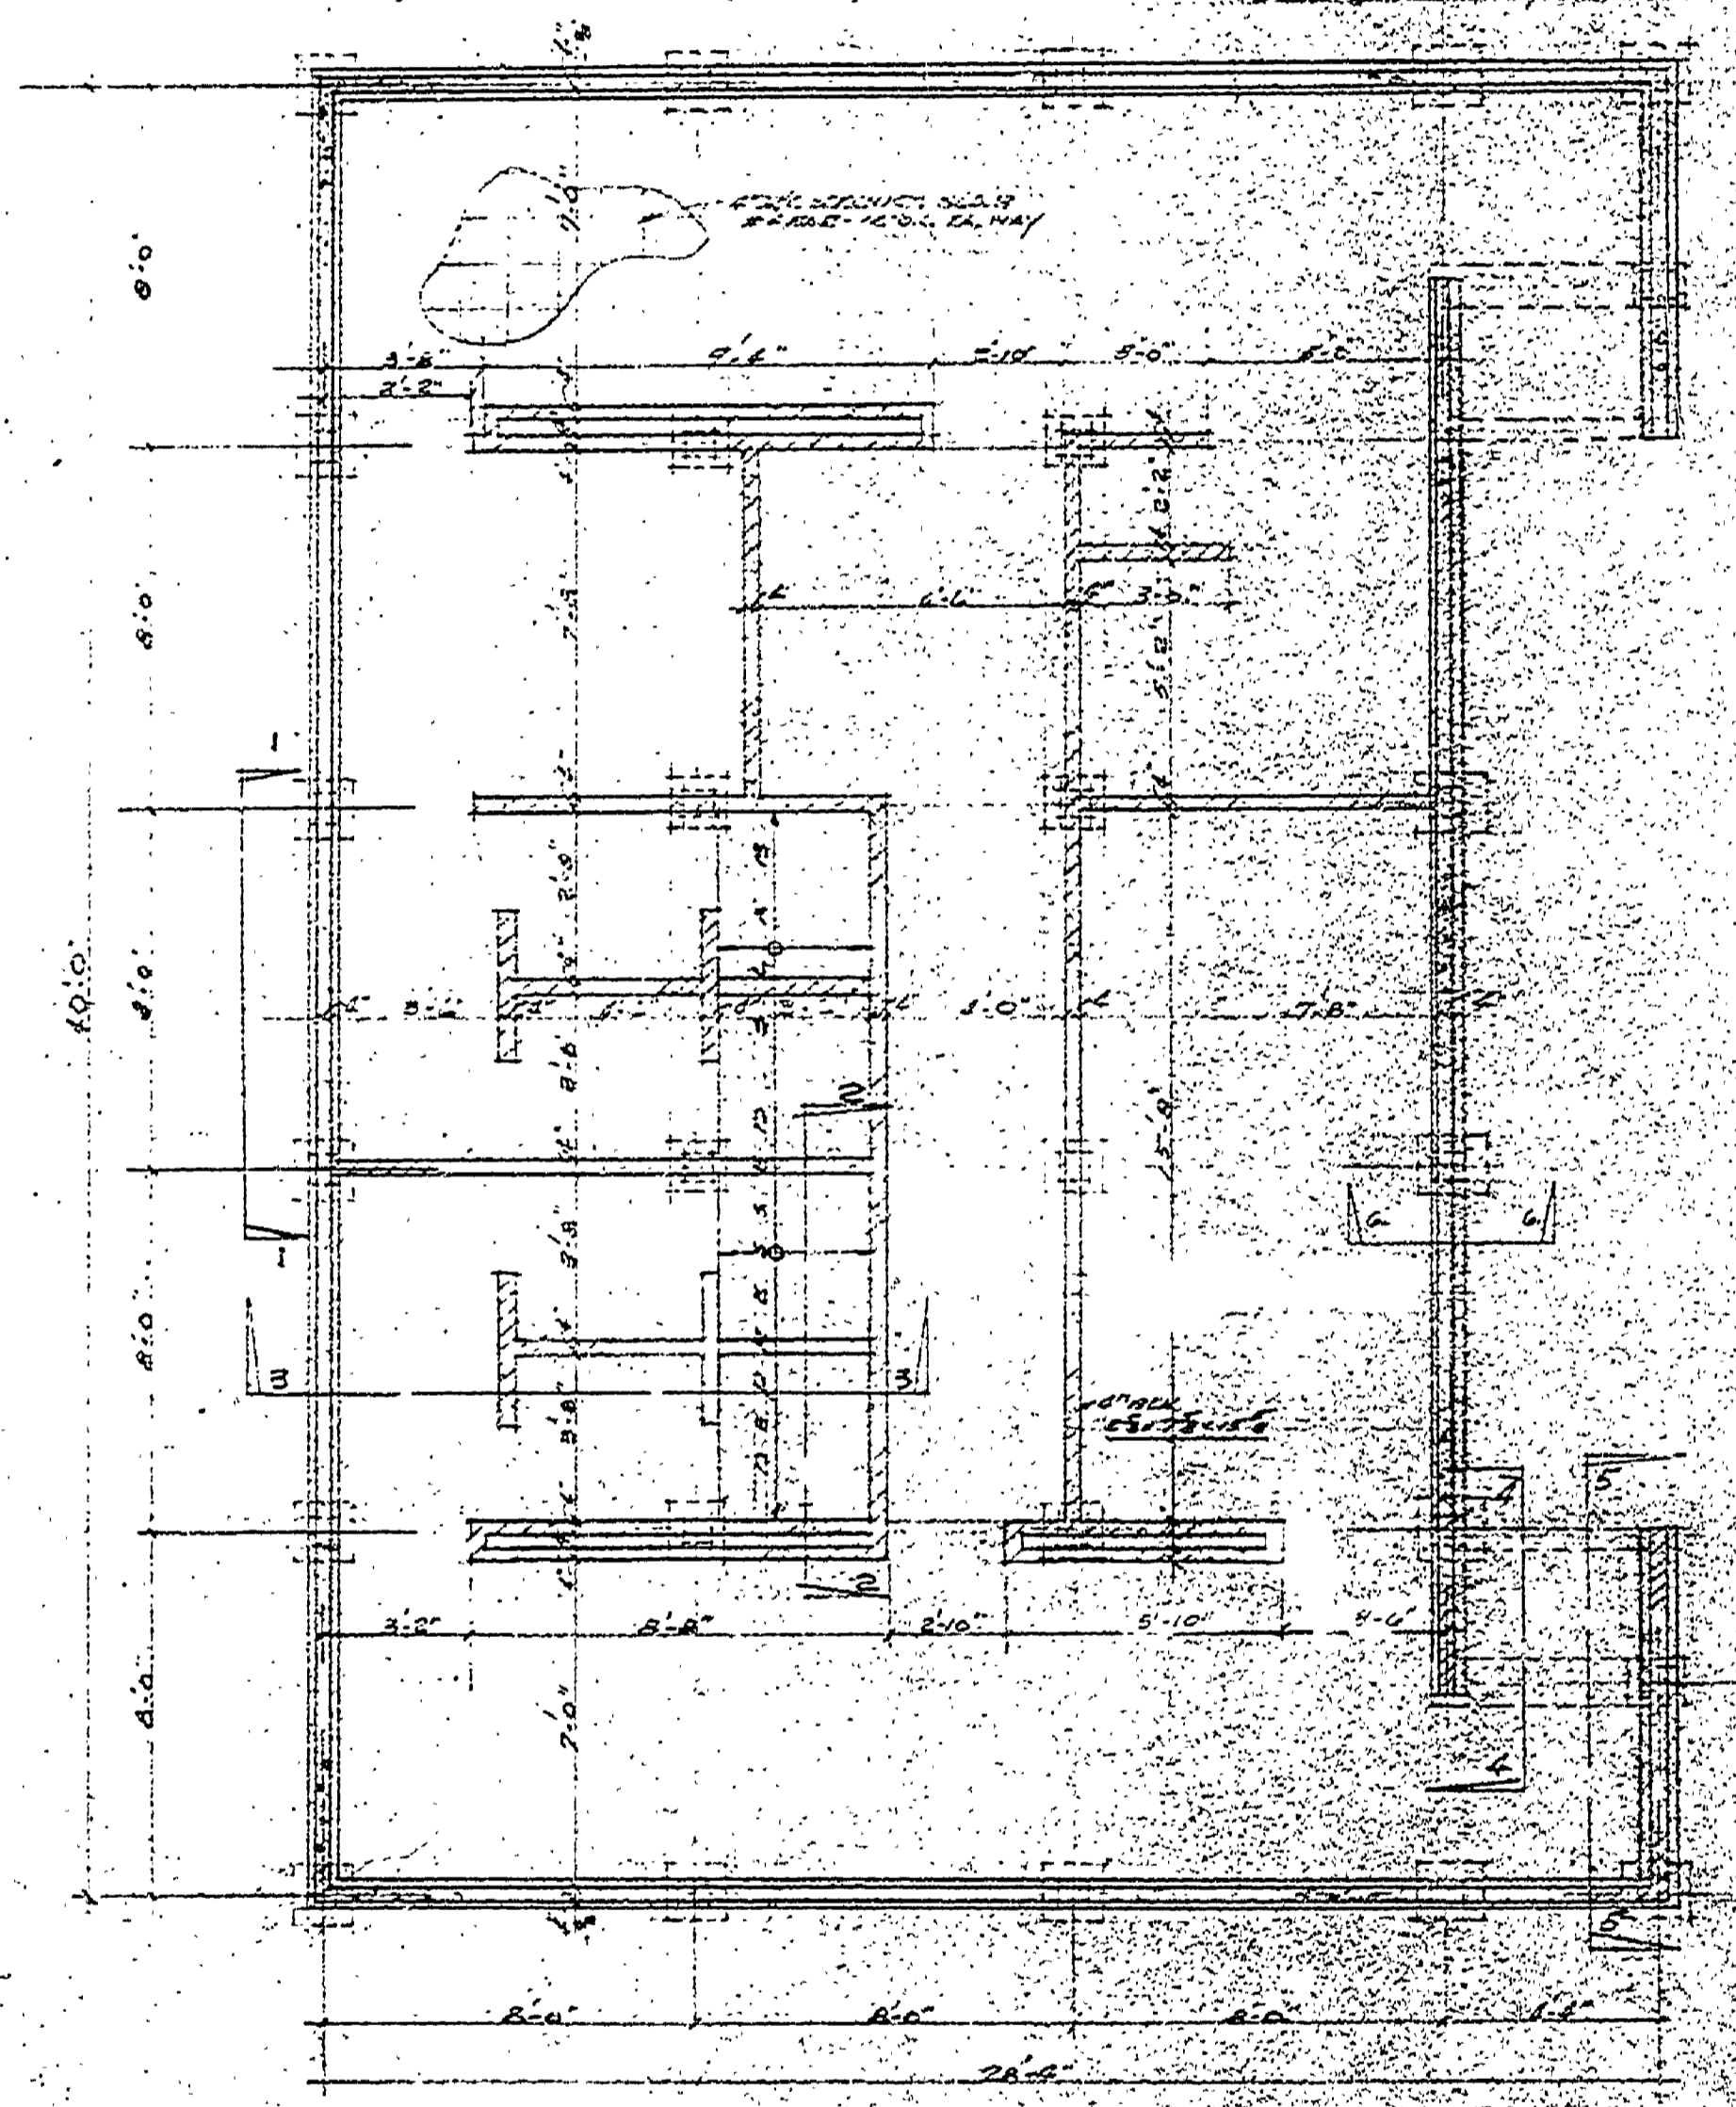



DESIGNED BY	DATE	REVIEWED	DATE	APPROVED	DATE NO.	DATE BY	REVISIONS
W.M.G.		ARCHITECTURAL			1	12-5-55	ADDED WATER, HARNER, ARRESTER
DRAWN BY		ENGINEERING			2		
CEB		LANDSCAPE			3	3-12-53	
CHECKED BY					4		
MLC					5		
					6		

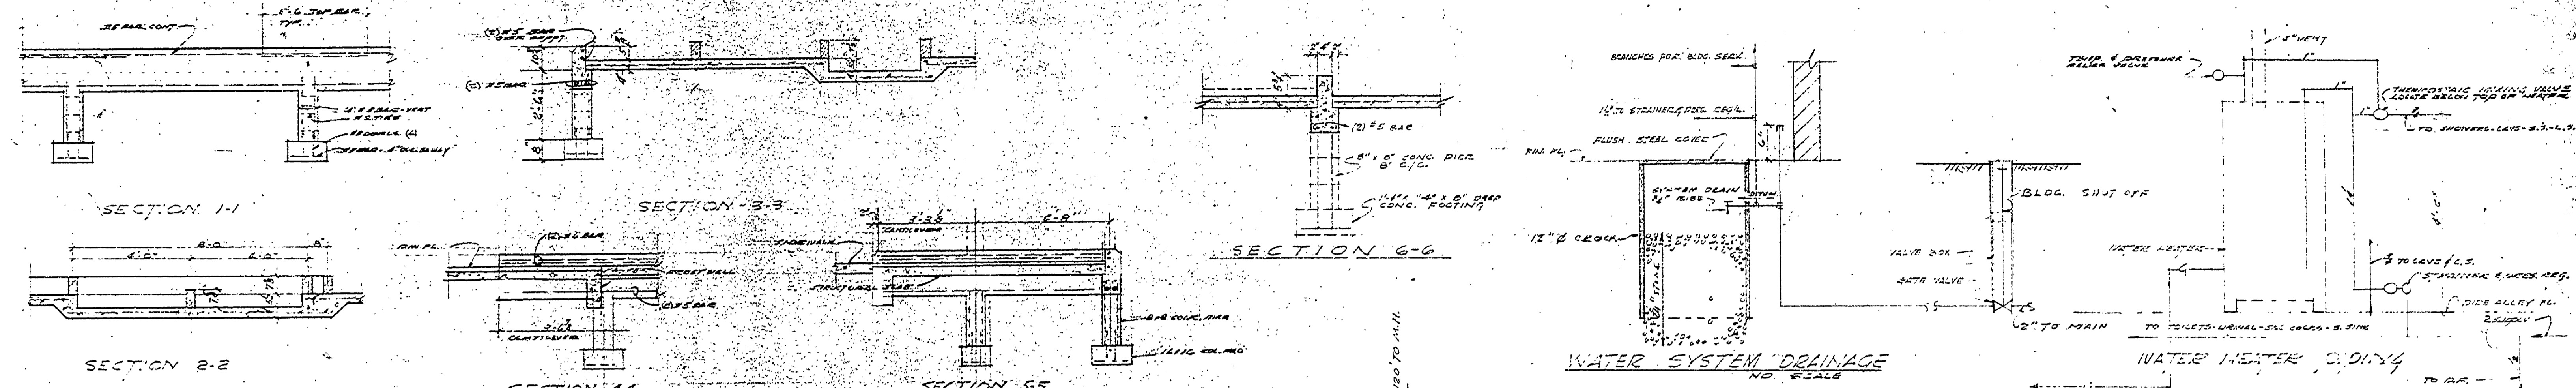

FOUNDATION PLAN

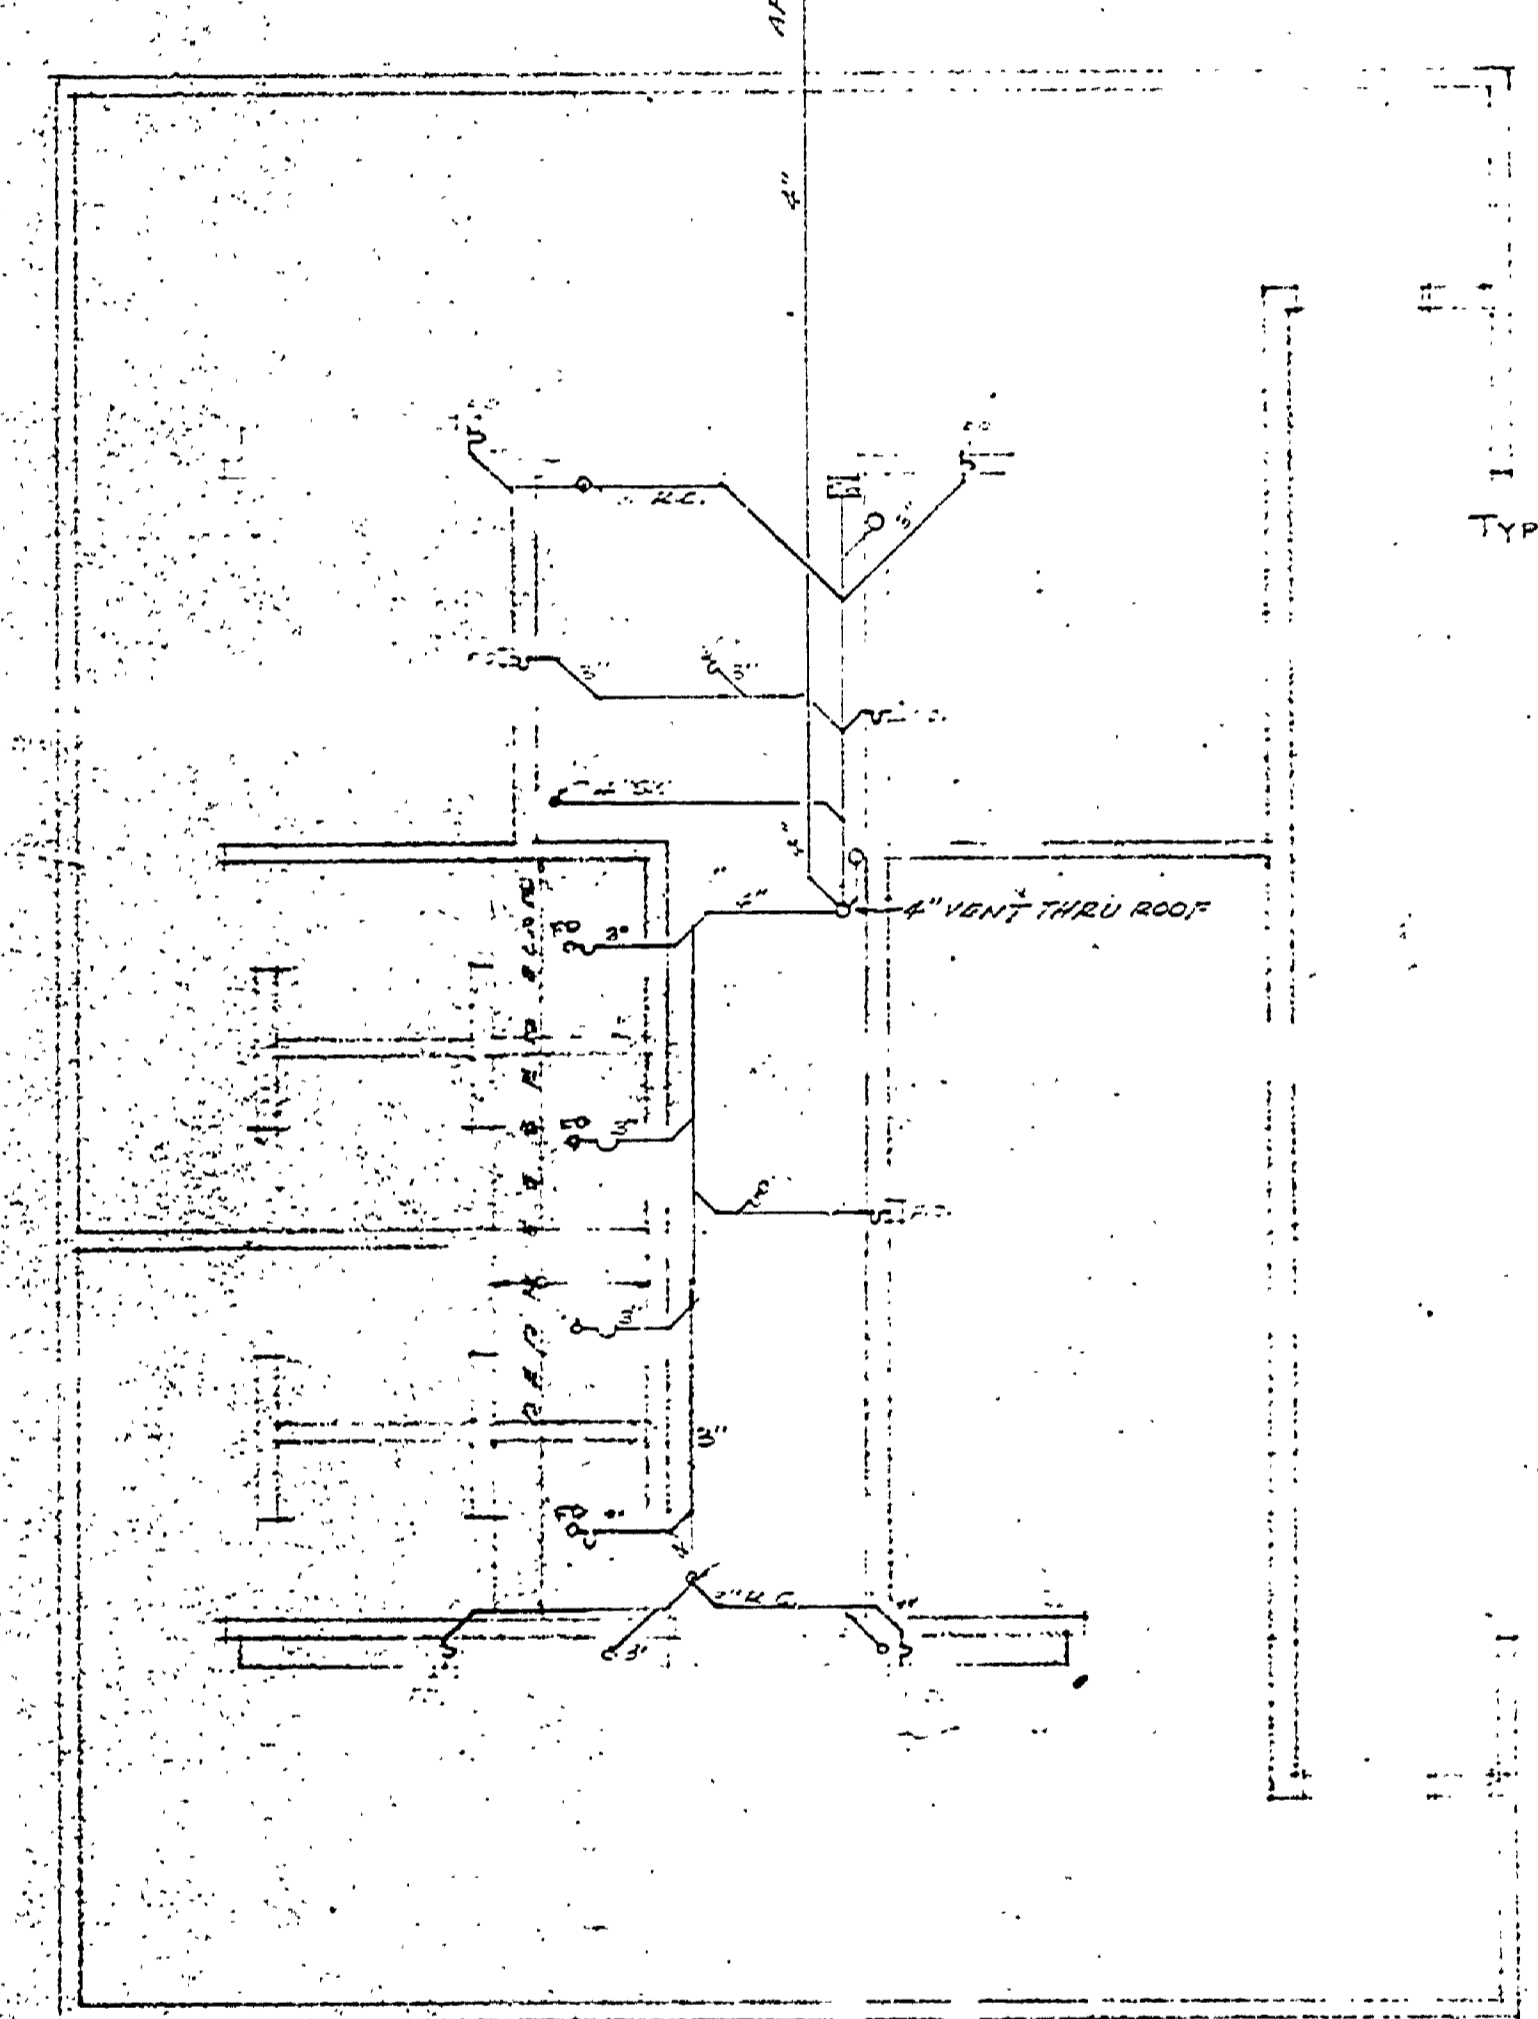

UNDERGROUND PLUMBING PLAN

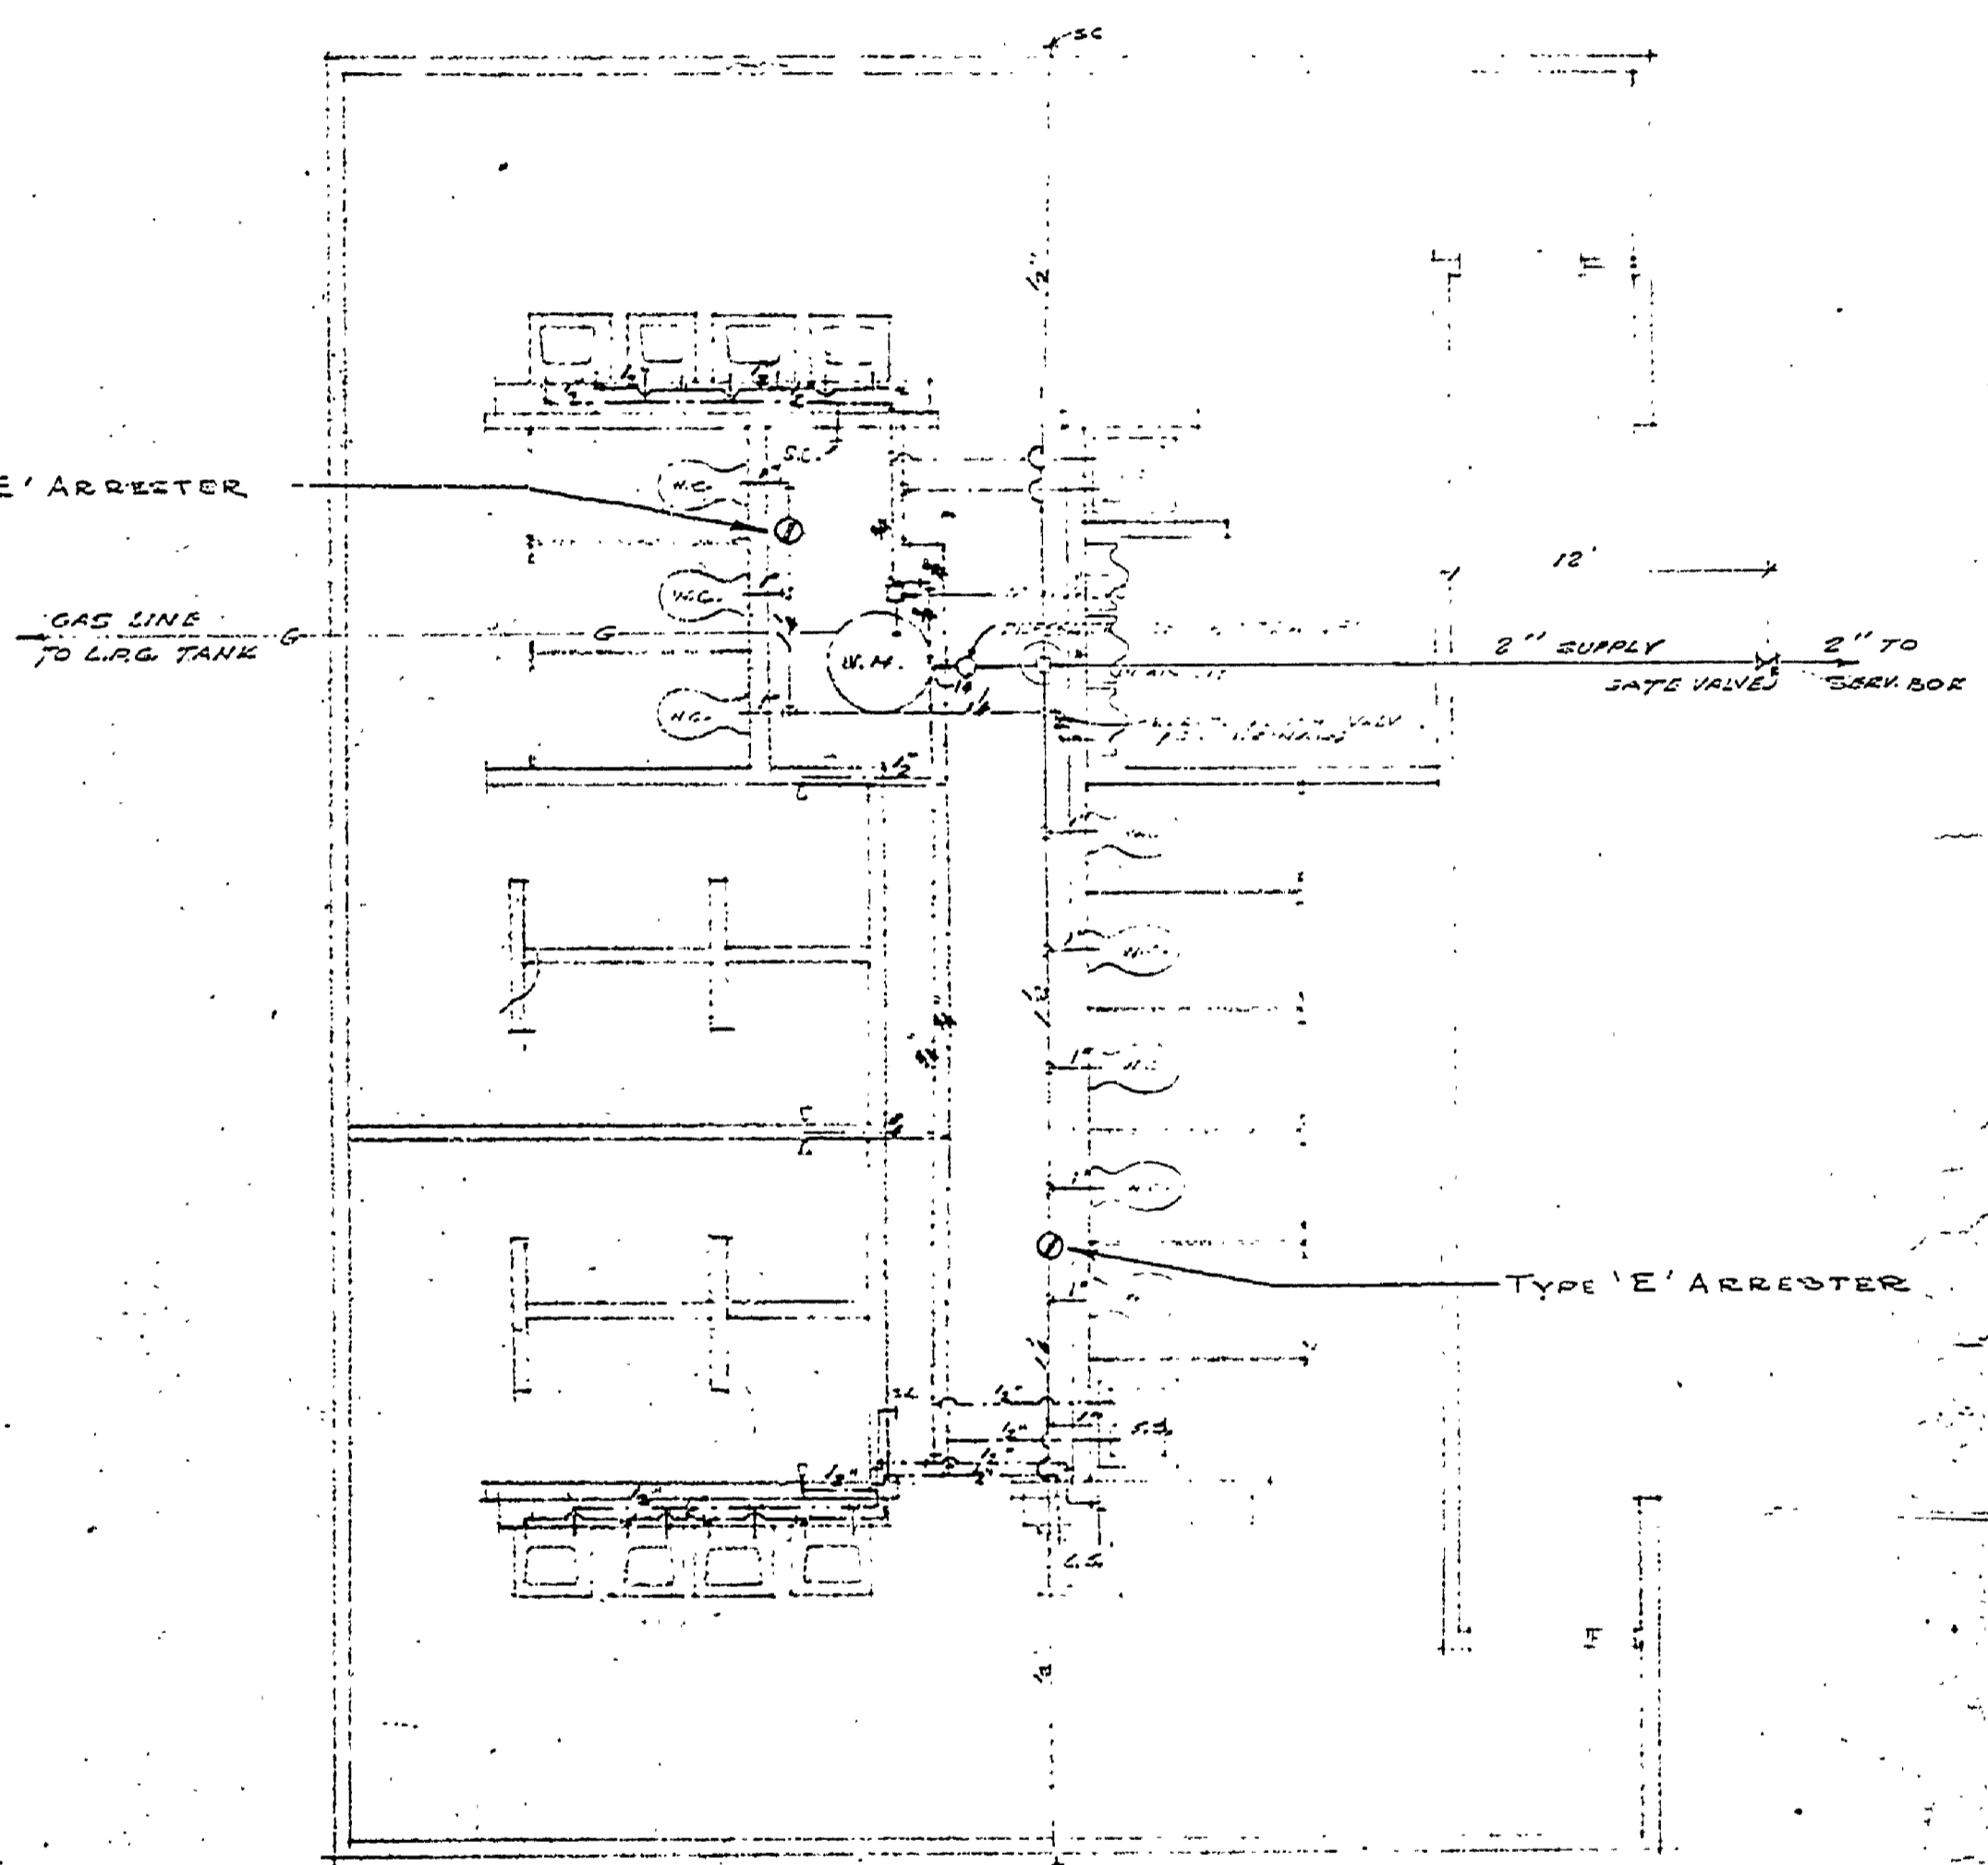

FIRST FLOOR PLUMBING PLAN

MICHIGAN DEPARTMENT OF CONSERVATION PARKS AND RECREATION DIVISION

FOUNDATION PLAN - PLUMBING PLANS
ALPHA STATE PARK
TOILET AND SHOWER BUILDING - 7

SHEET NO. 3 OF 5 PLAN NO.