




DATE	REVIEWED	DATE	APPROVED	DATE	NO.	DATE	BY
7-17-61	ARCHITECTURAL	7-17-61	[Signature]	1	1	7-17-61	
8-17-61	ENGINEERING	8-17-61	[Signature]	2	2	8-17-61	
8-17-61	LANDSCAPE	8-17-61	[Signature]	3	3	8-17-61	
				4	4		
				5	5		
				6	6		

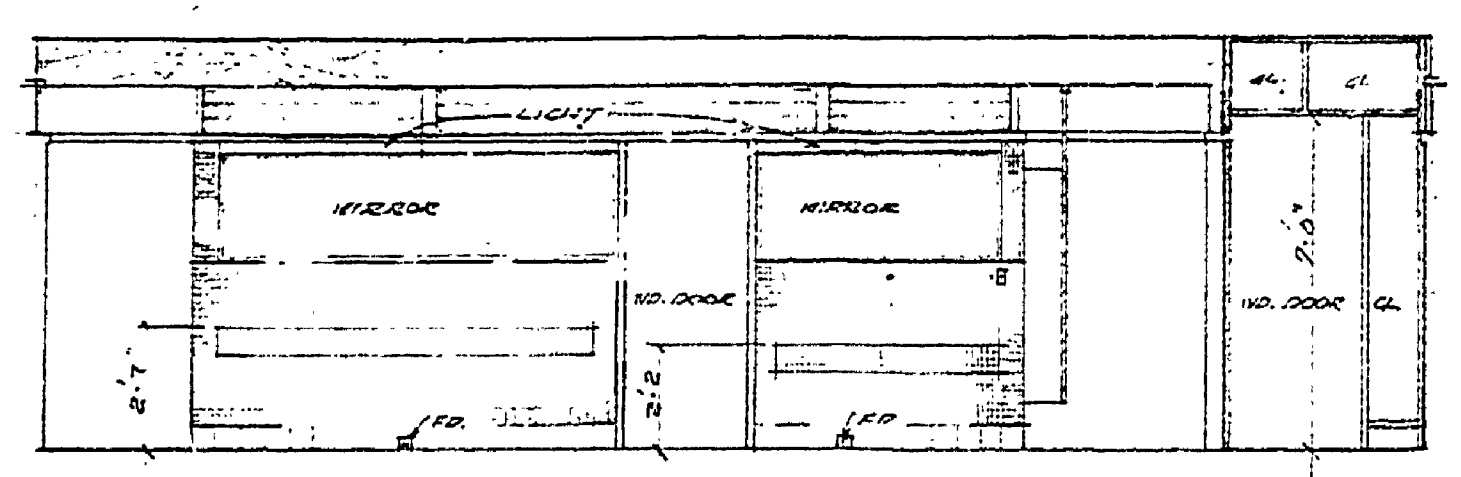


NORTH INTERIOR ELEV - WOMEN'S TOILET

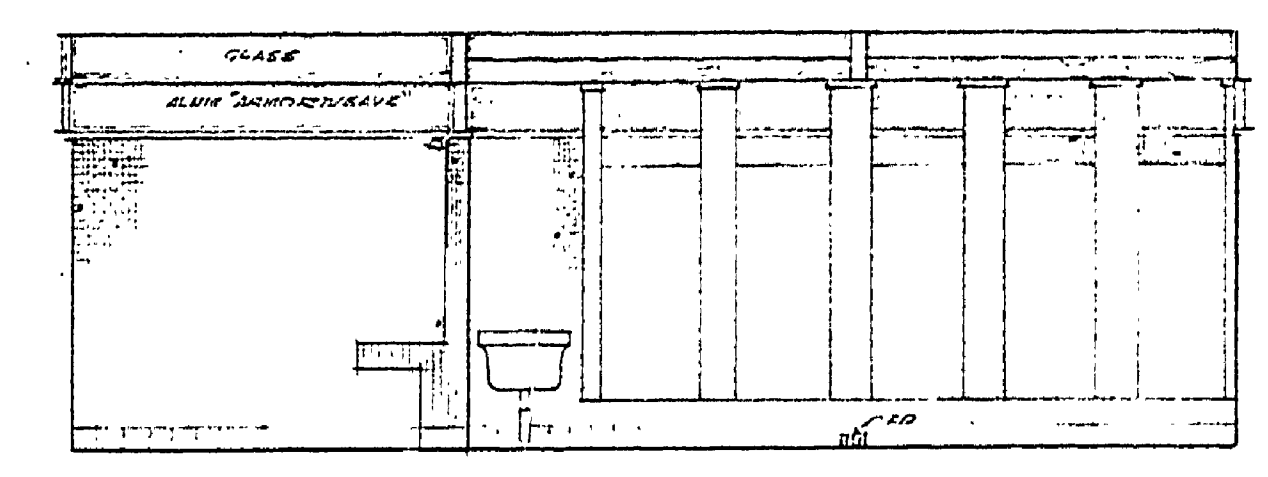


SOUTH INTERIOR ELEV - WOMEN'S TOILET

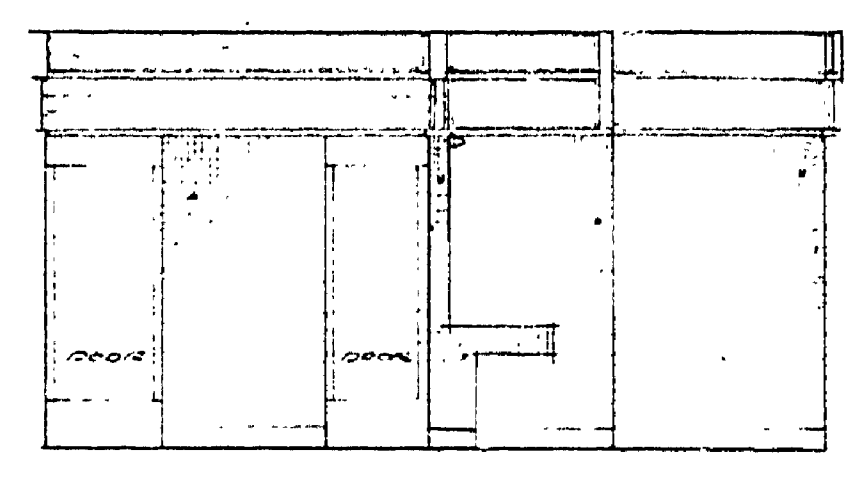


NORTH INT. ELEV - WOMEN'S TOILET

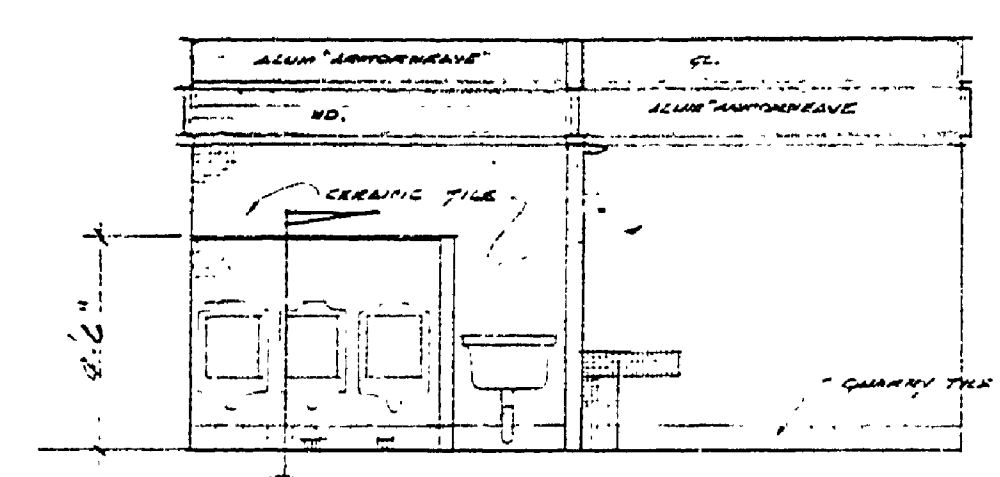


SOUTH INT. ELEV. WOMEN'S TOILET

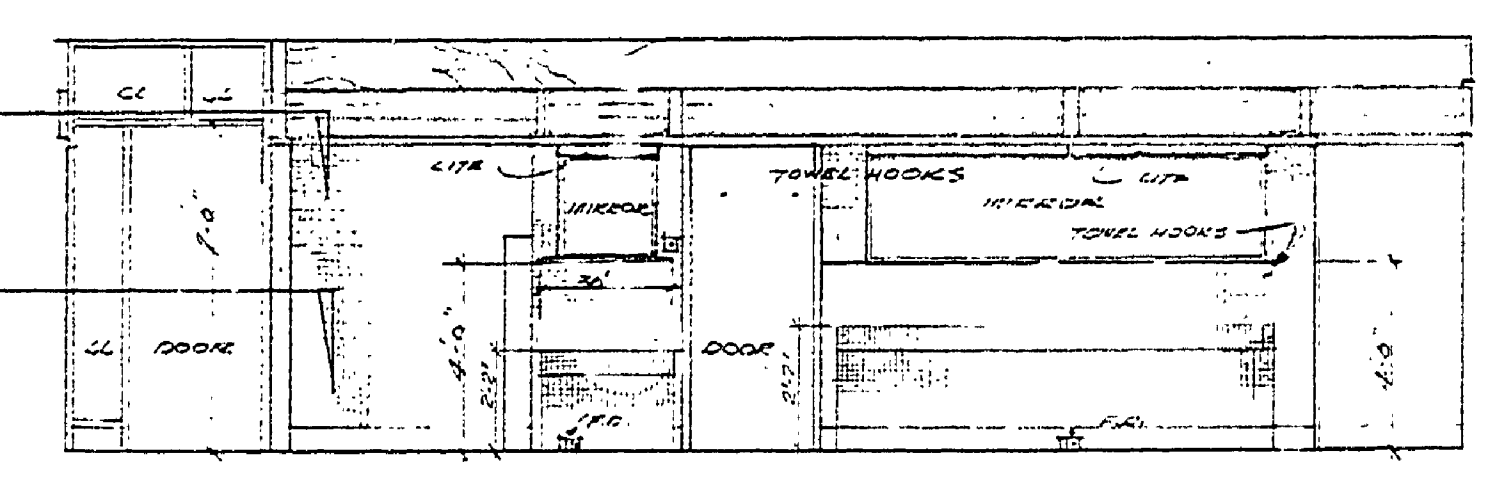


EAST INTERIOR ELEVATION - MEN'S TOILET

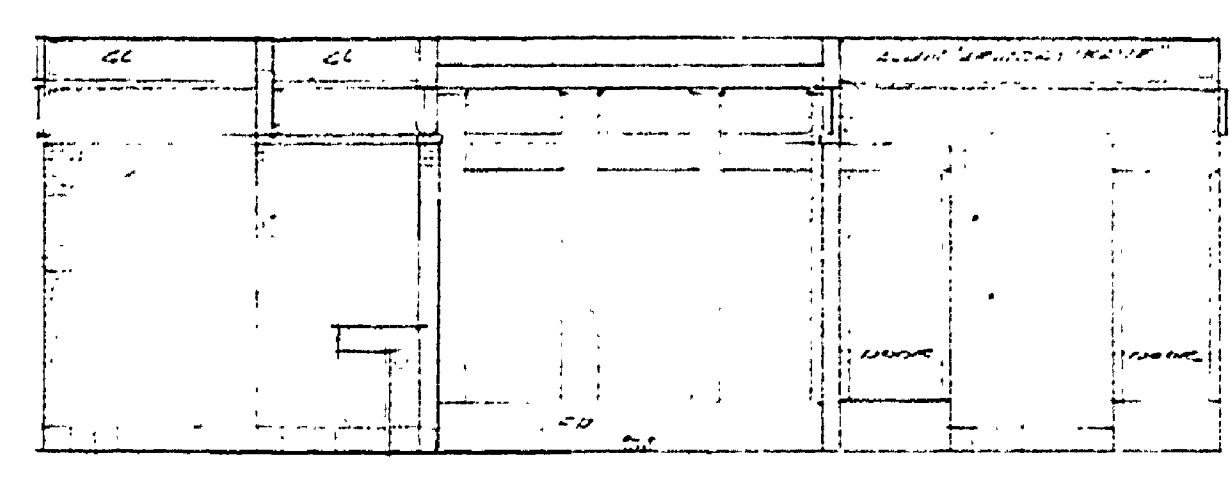


NORTH INTERIOR ELEV. MEN'S TOILET

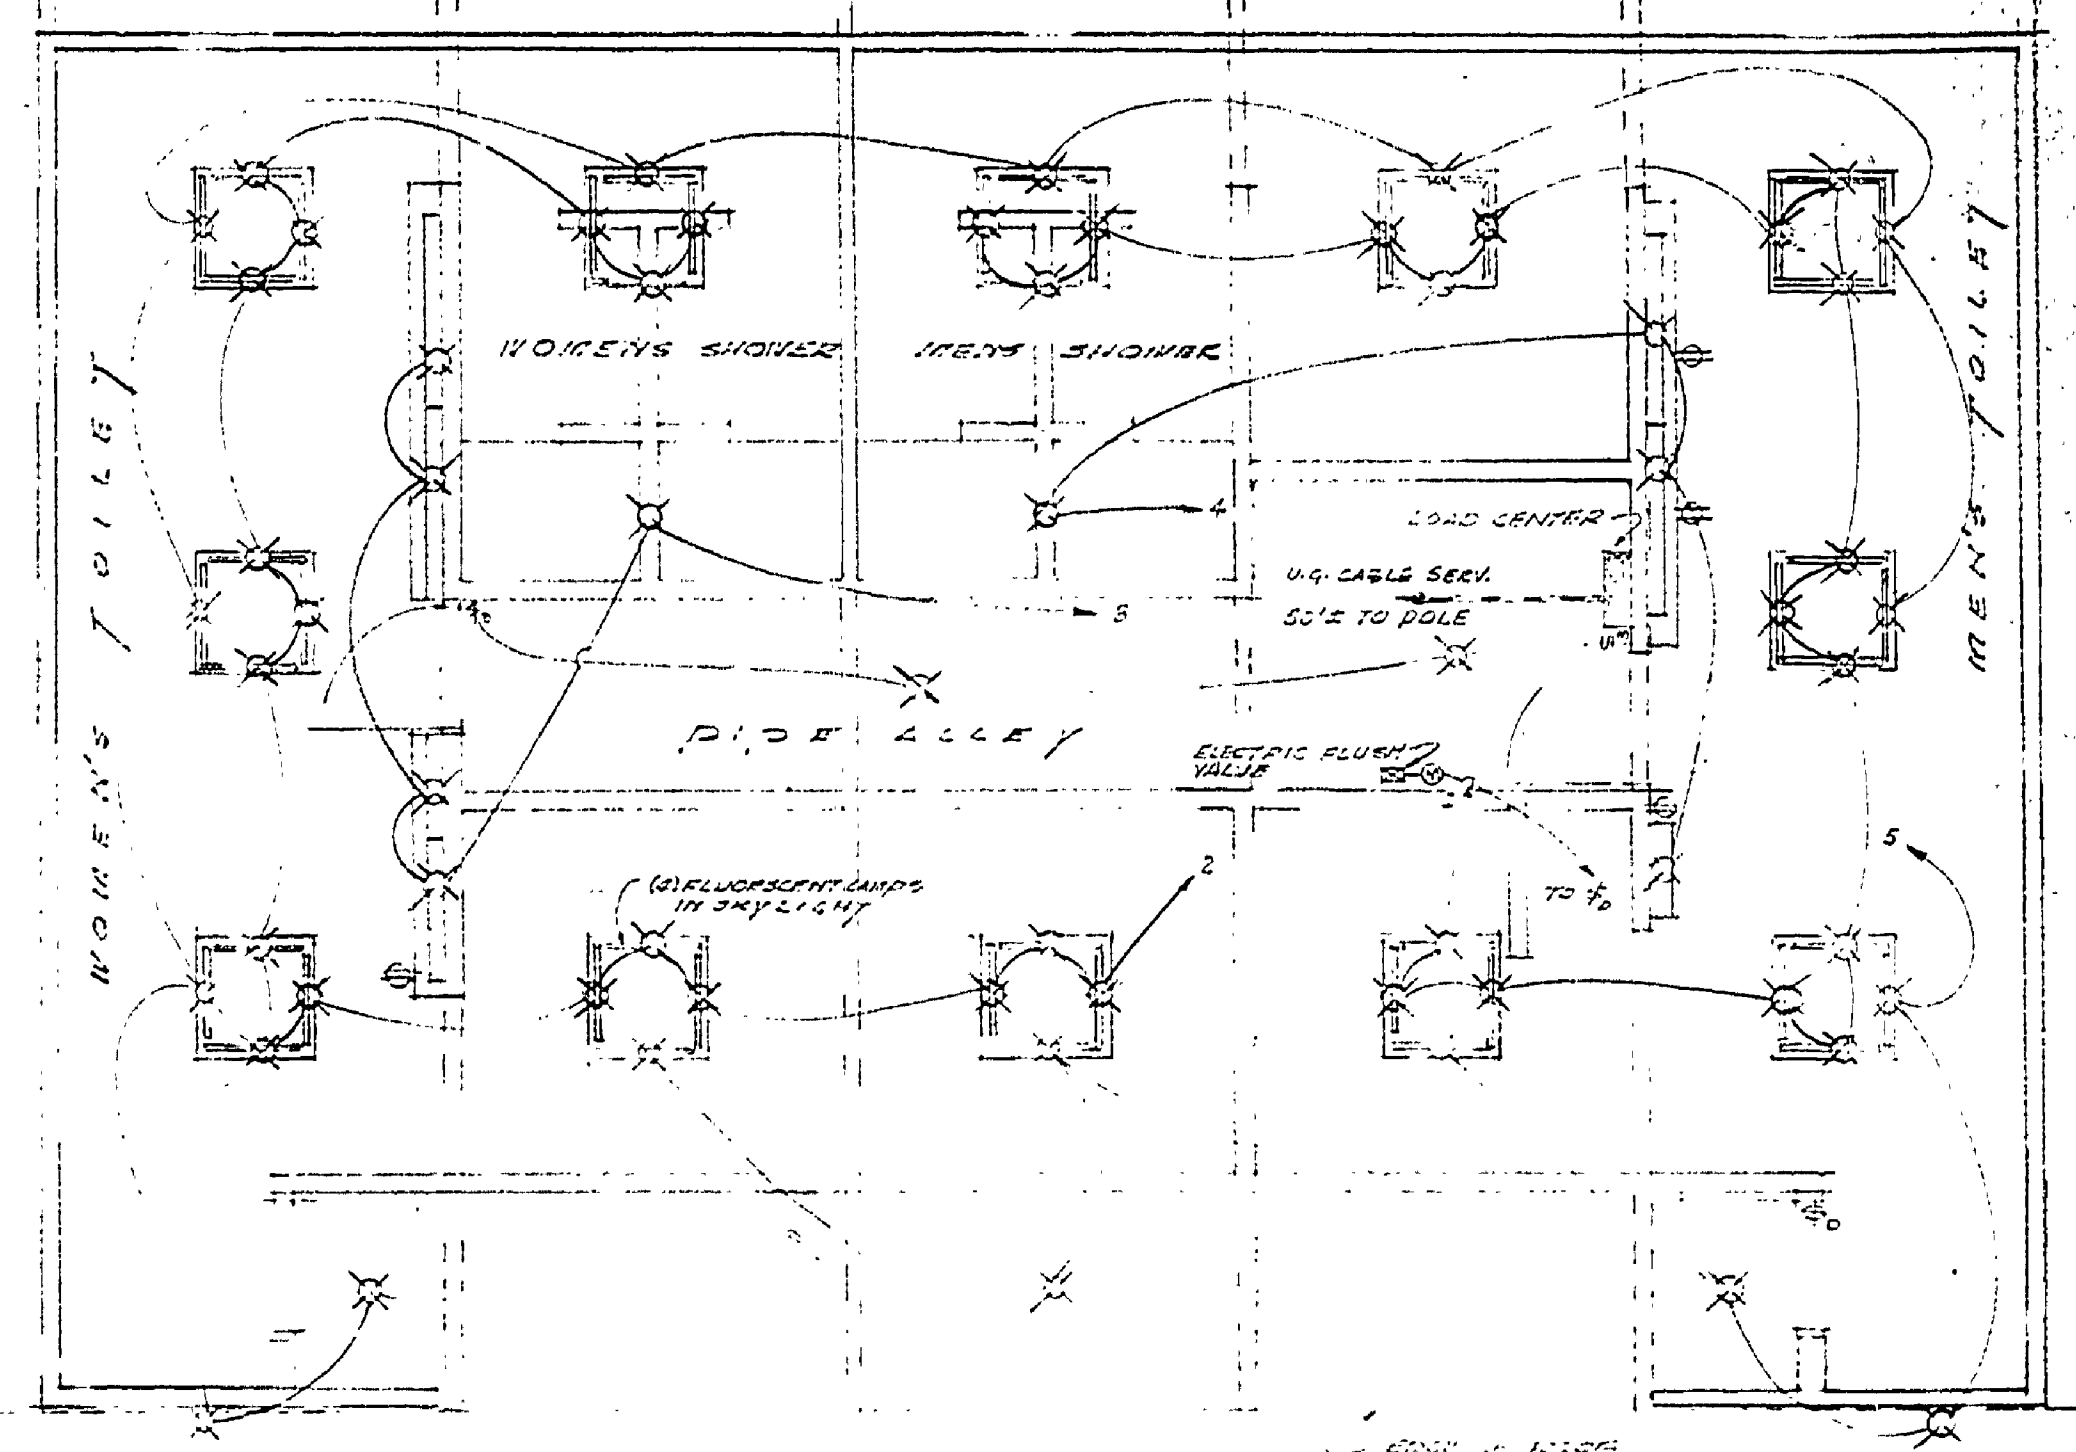


ELECTRICAL LIGHTING PLAN

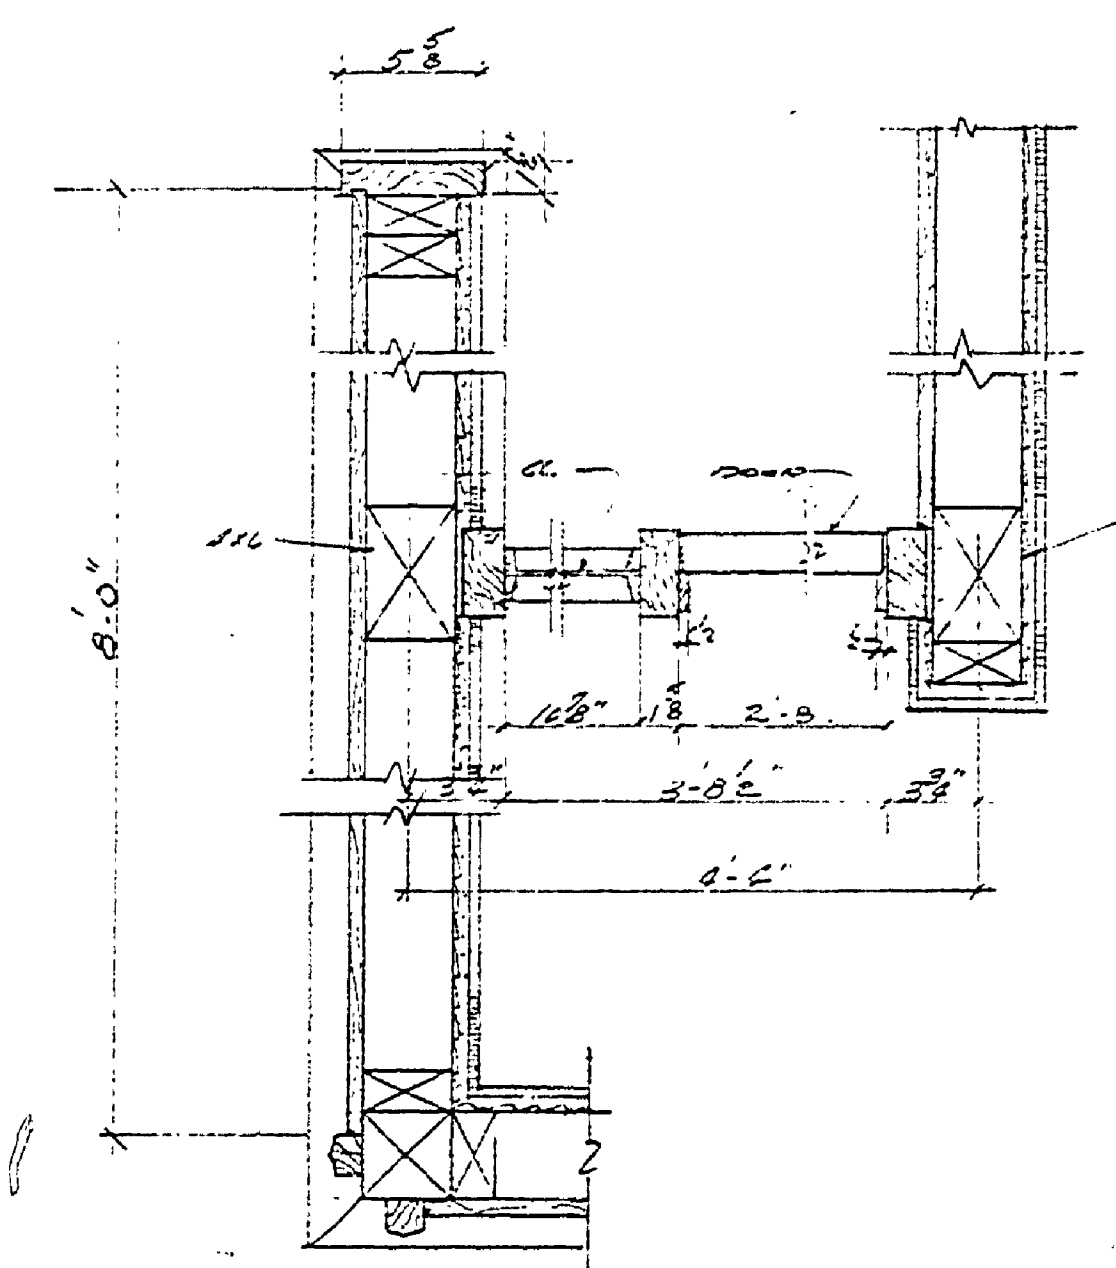


ENTRANCE DET. SCALE 1/4" = 1'-0"

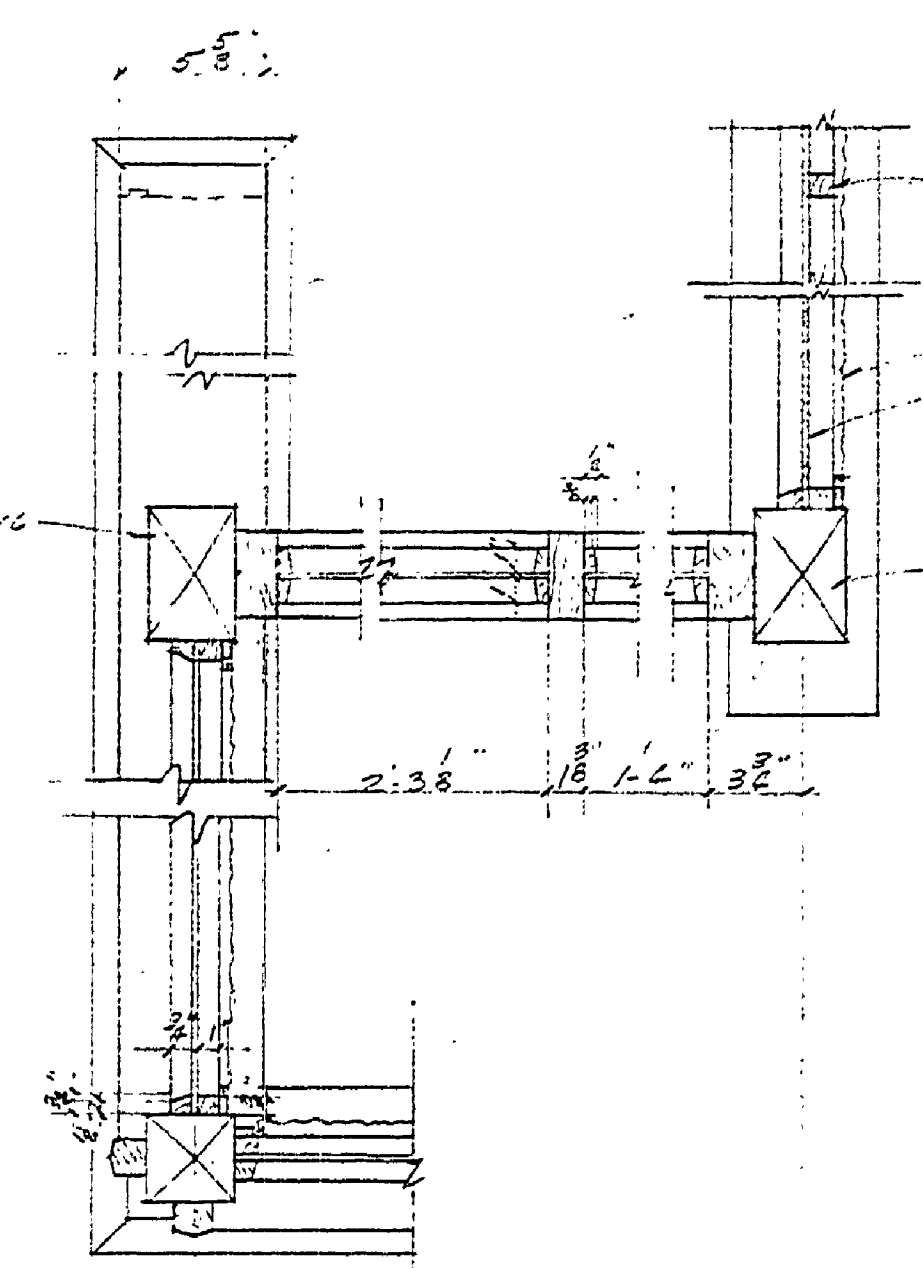


ENTRANCE DET. SCALE 1/4" = 1'-0"

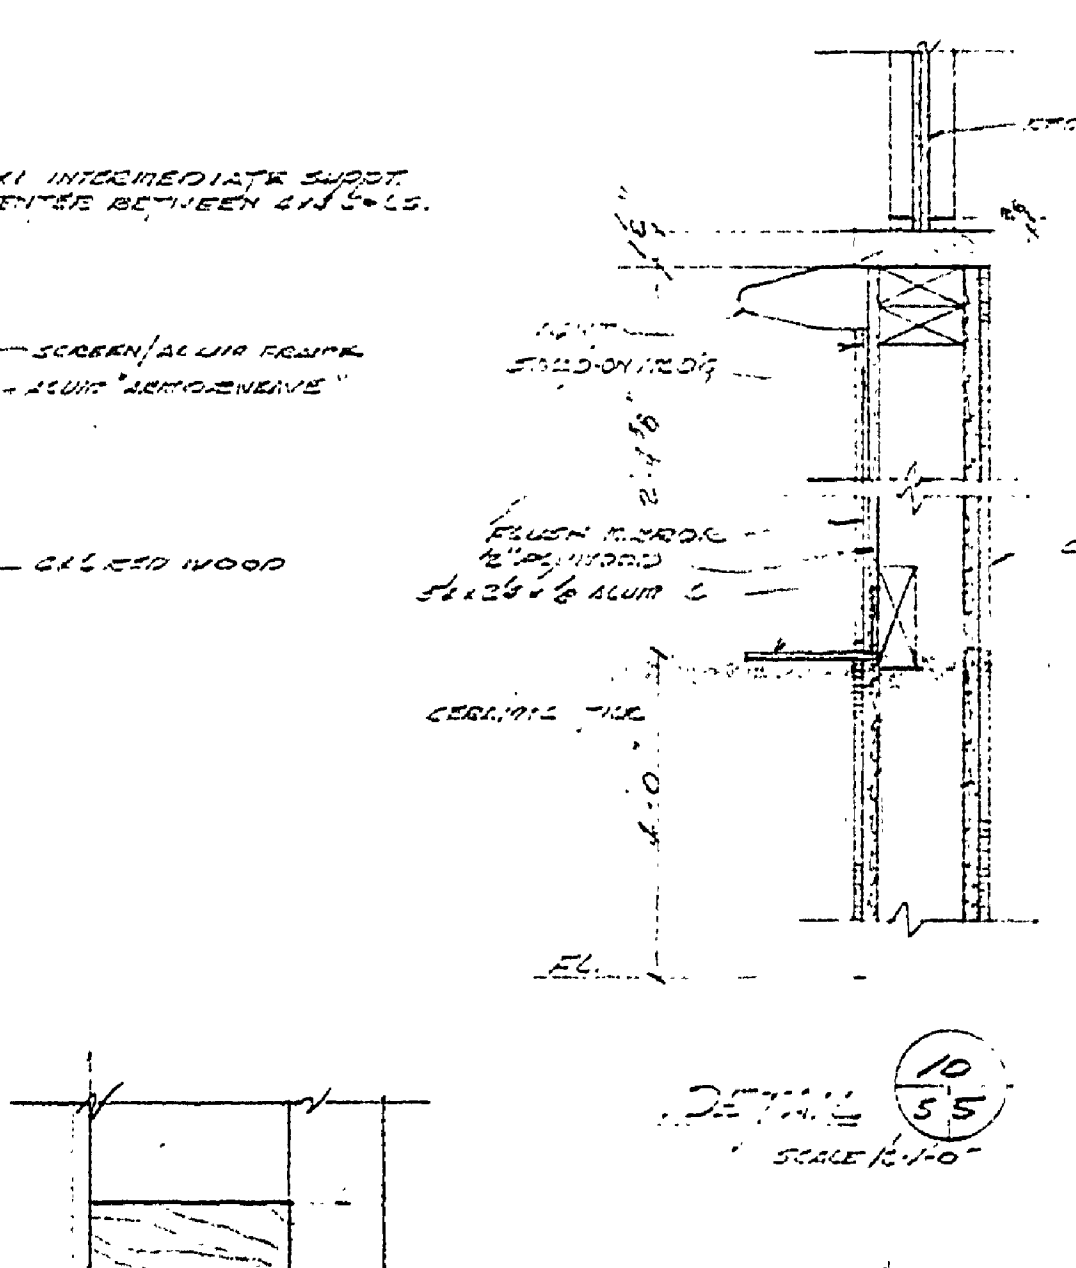

MIRROR & LIGHT DETAIL FULL SIZE

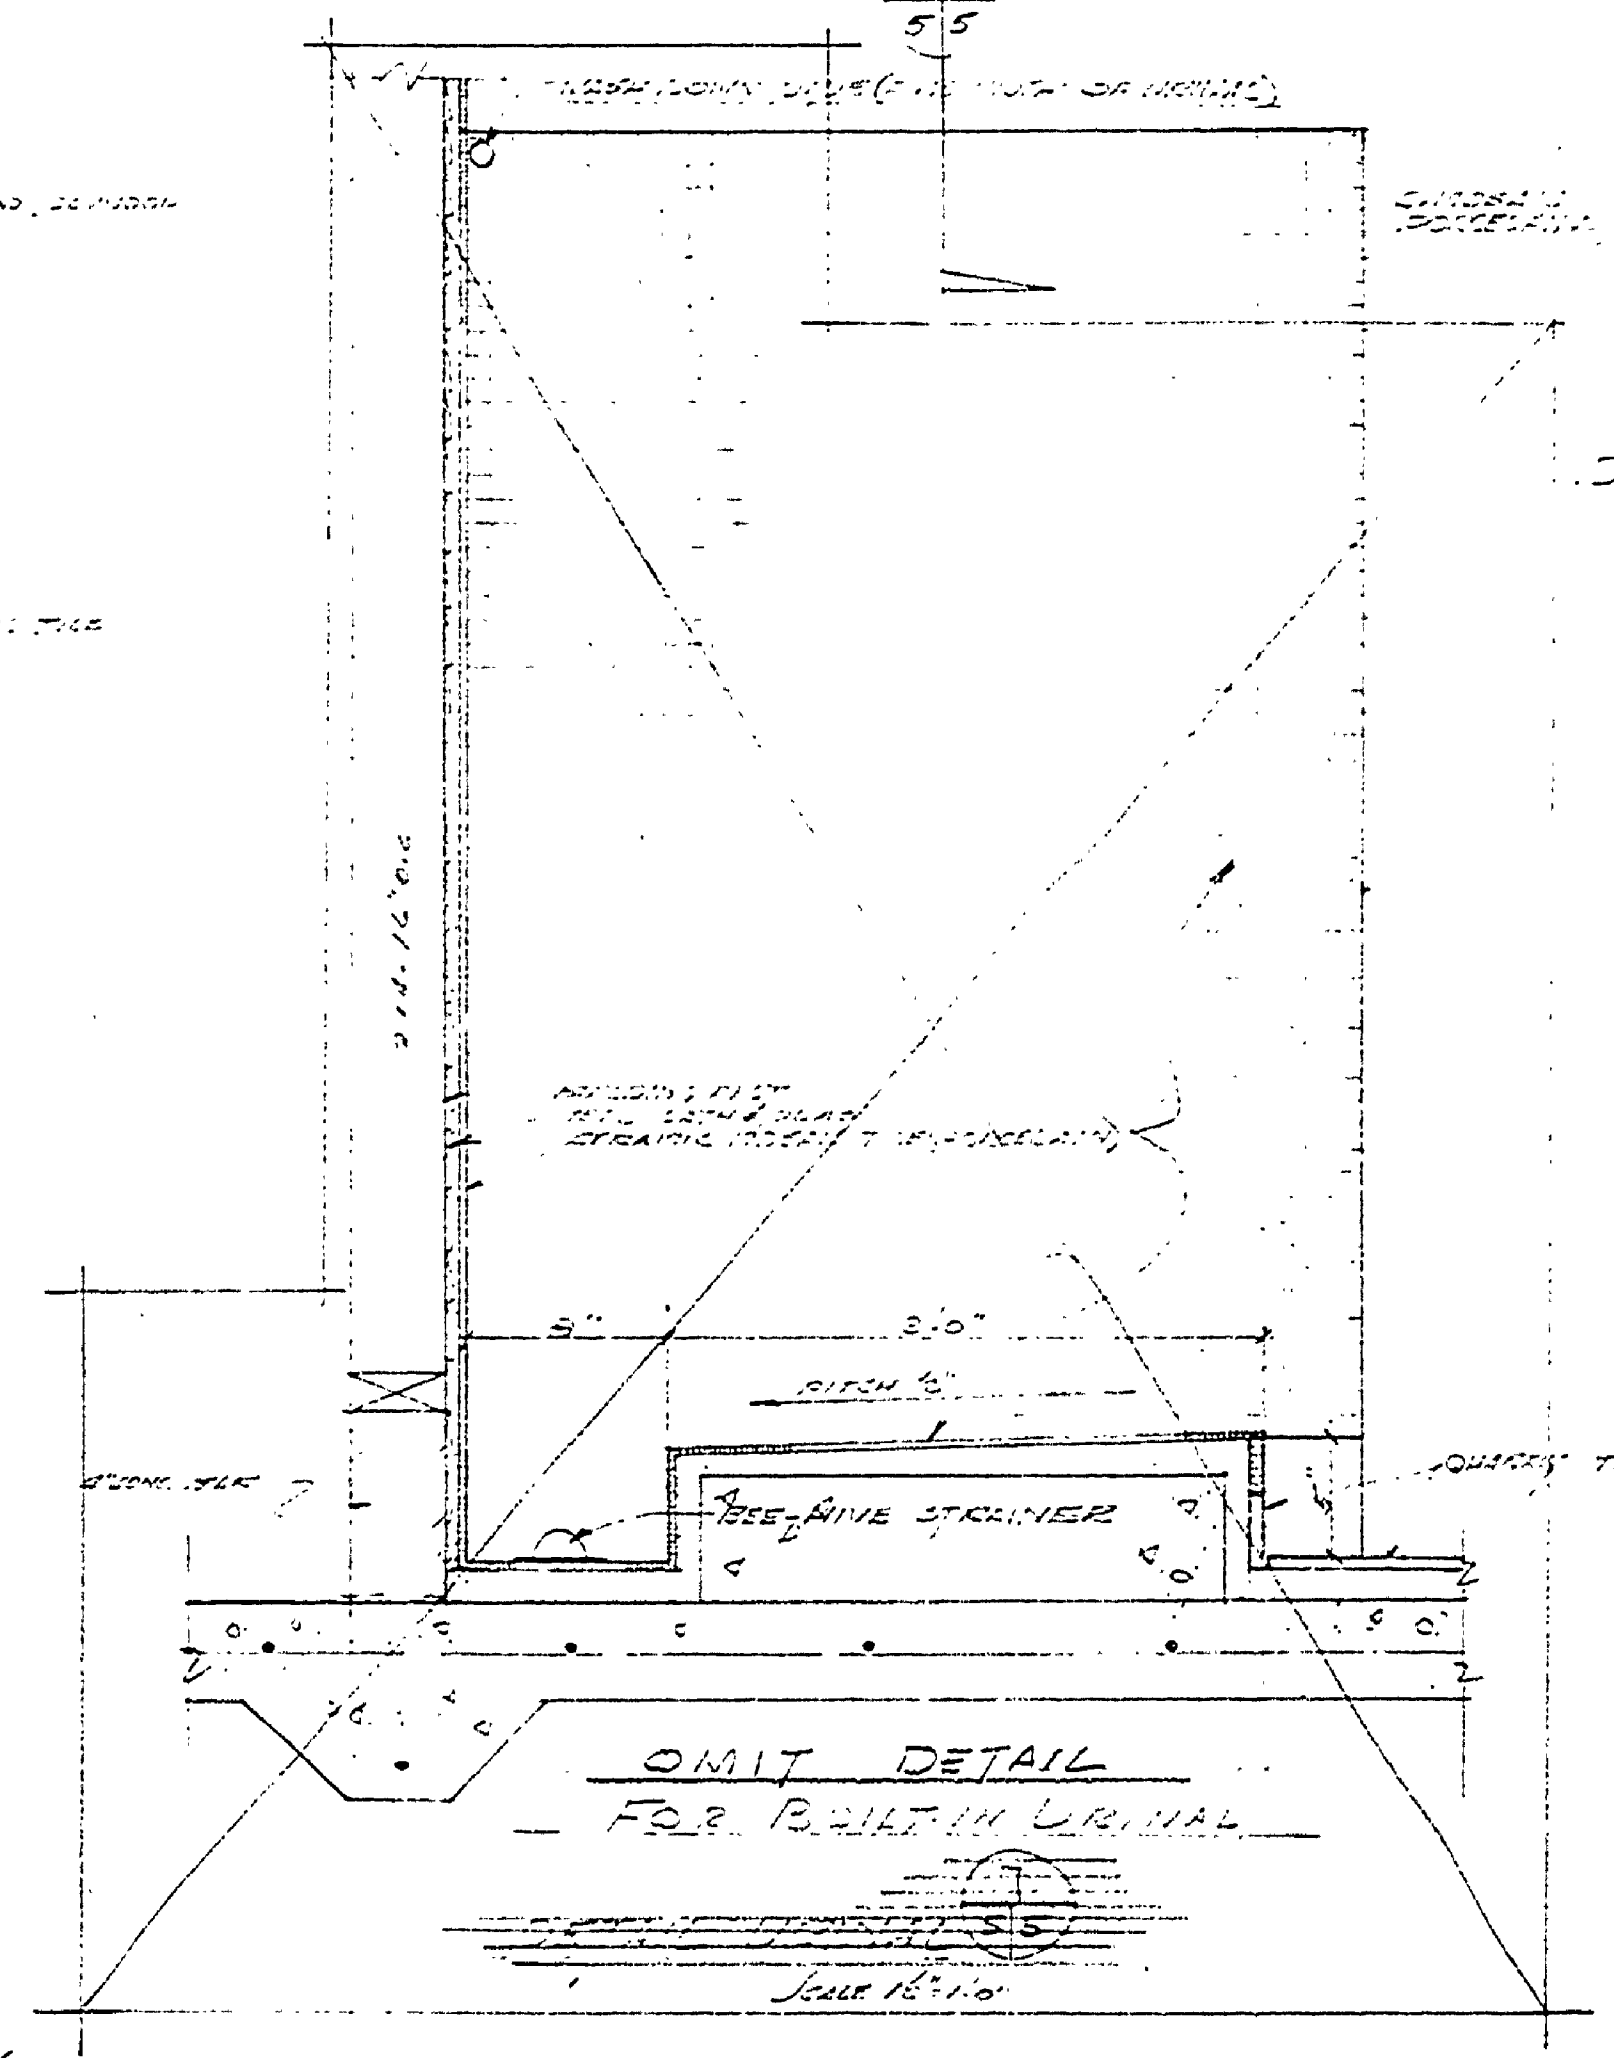

OMIT DETAIL FOR BUILDING URINAL

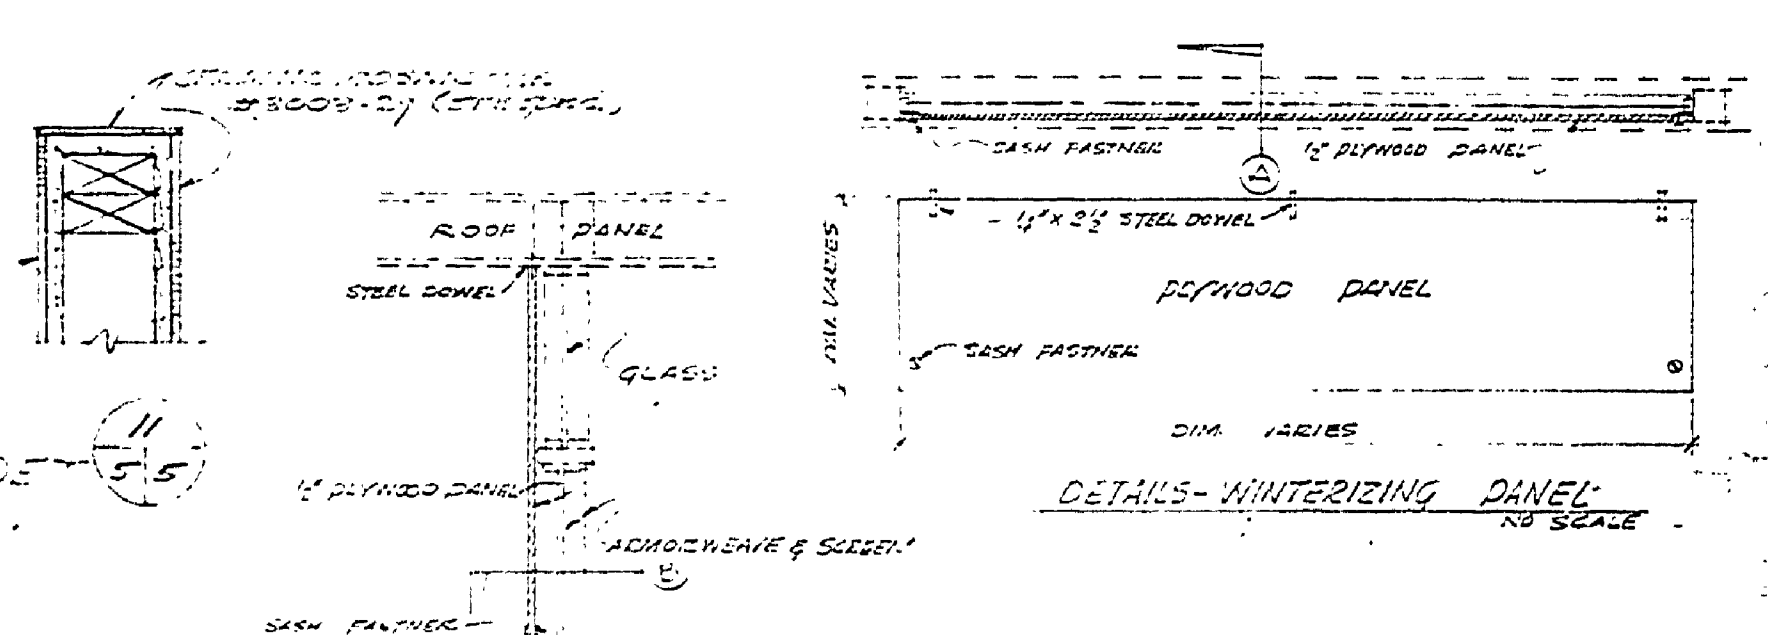

WINTERIZING PANEL SCHEDULE (FOR GASH & LOUVER OPENINGS)

TYPE	NO.	REQD.	WIND.	WIND.	HT.	REMARKS
A	3	4"	108"	20"		CUT TO FIT
B	6	"	708"	110"		
C	2	"	198"	20"		
D	2	"	108"	110"		
E	2	"	108"	110"		
F	2	"	108"	210"		
G	2	"	108"	210"		

DOOR SCHEDULE

NO.	TYPE	WIND.	WIND.	HT.	REMARKS
1	A	1/2"	20"	110"	POUR EDGE
2	A	1/2"	20"	110"	
3	A	1/2"	20"	110"	
4	A	1/2"	20"	110"	
5	B	1"	110"	210"	POUR/FRONT PANEL
6	B	1"	110"	210"	
7	B	1"	110"	210"	
8	B	1"	110"	210"	

FINISH SCHEDULE

ROOM DESIGNATION	WALLS	FLOORS	CEILING	REMARKS
WOMEN'S TOILET ROOM	•	•	•	
WOMEN'S TOILET HALL	•	•	•	
WOMEN'S SHOWER	•	•	•	
WOMEN'S SHOWER	•	•	•	
SIDE ALLEY	•	•	•	

MICHIGAN DEPARTMENT OF CONSERVATION PARKS AND RECREATION DIVISION

A LOHA STATE PARK TOILET AND SHOWER BUILDING # 749 SHEET NO. 5 OF 5 PLAN NO. 1101-100