




DESIGNED BY	DATE	REVIEWED	DATE	APPROVED	DATE	NO.	DATE	BY
W.D.	2/1/41	M.W.	2/1/41	<i>[Signature]</i>	2/1/41	1		
DRAWN BY		ARCHITECTURAL				2		
CHECKED BY		ENGINEERING				3		
		LANDSCAPE				4		
						5		
						6		

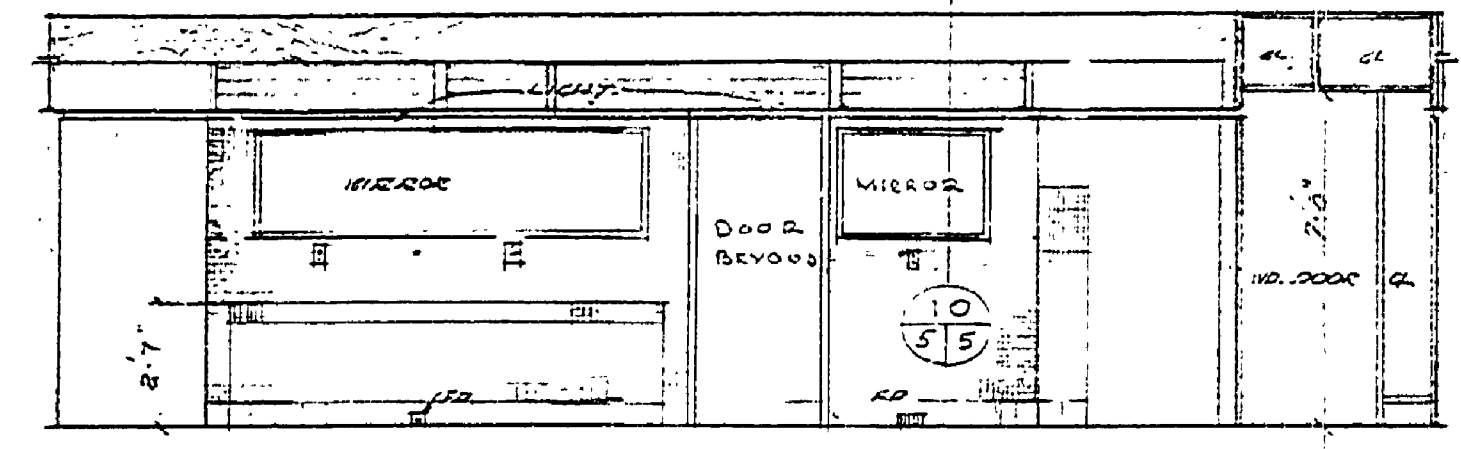


INTERIOR ELEV. - MEN'S TOILET

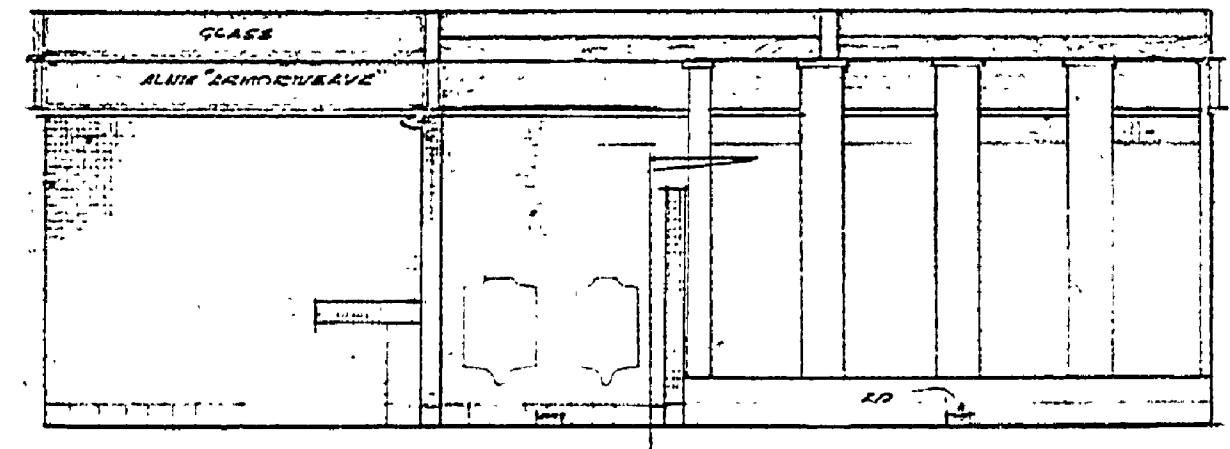


INTERIOR ELEV. - MEN'S TOILET

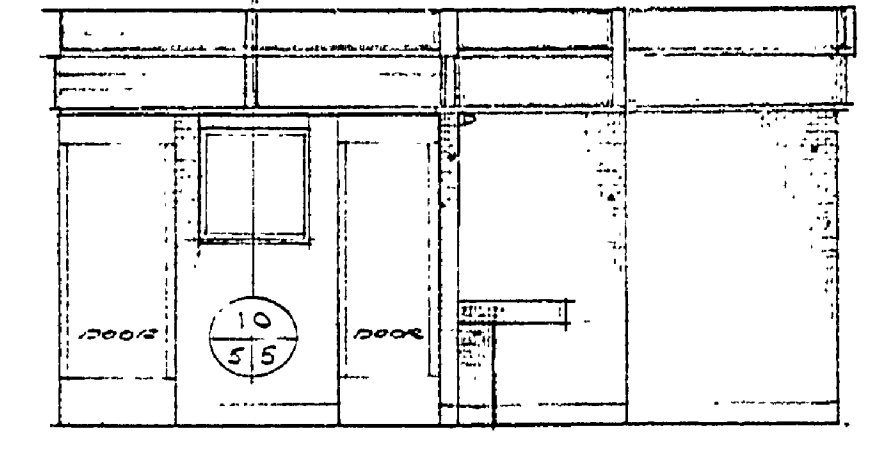


INT. ELEV. - MEN'S TOILET

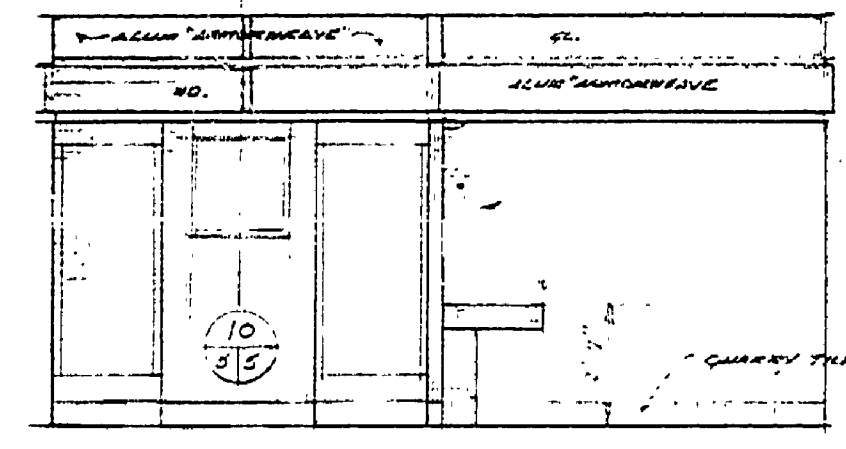


INT. ELEV. WOMEN'S TOIL.

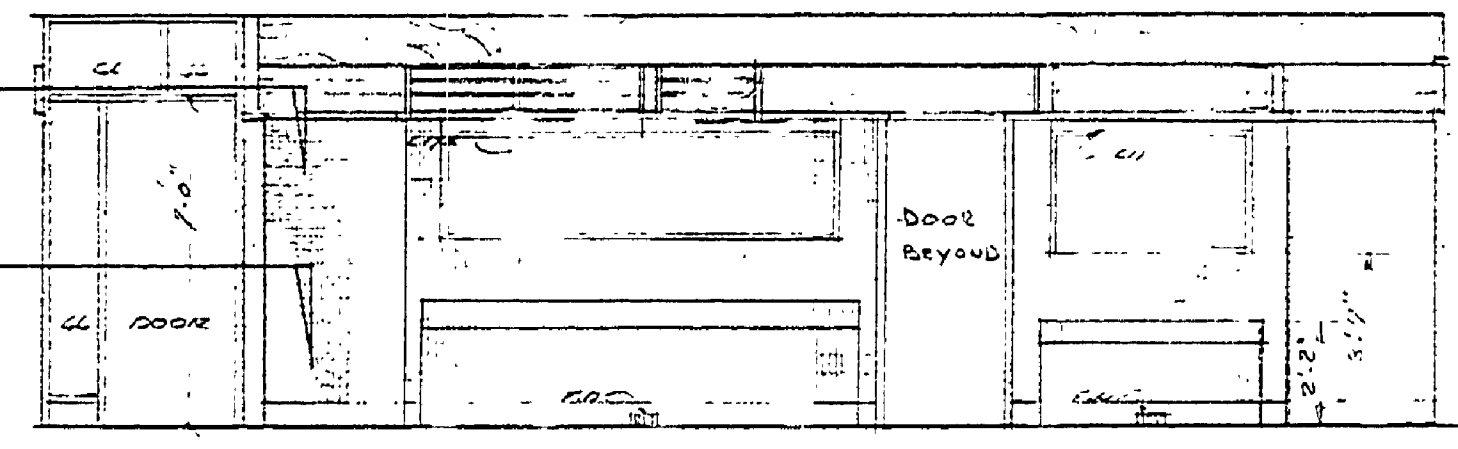


INTERIOR ELEVATION - WOMEN'S TOILET

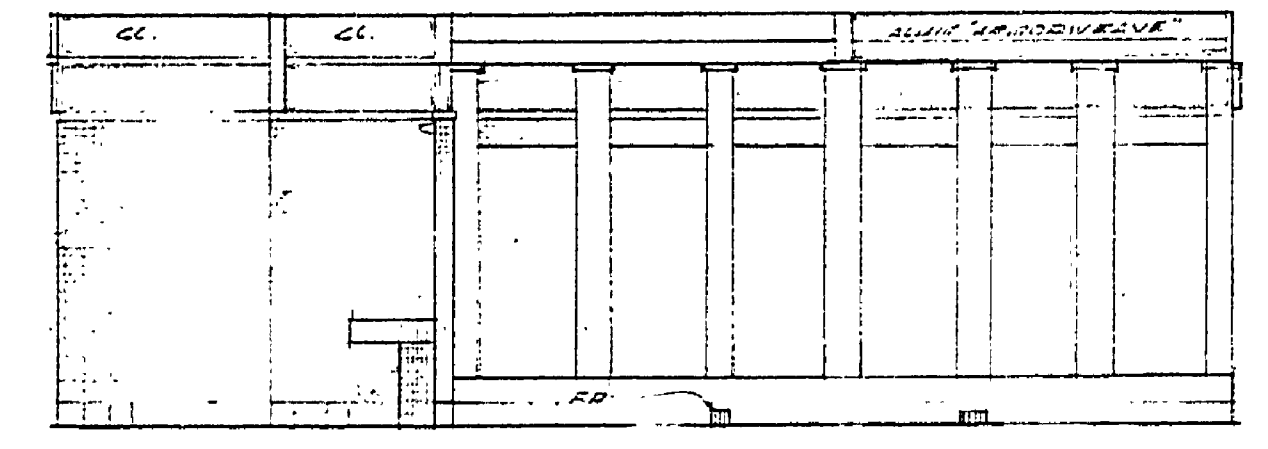

INTERIOR ELEV. - WOMEN'S TOILET

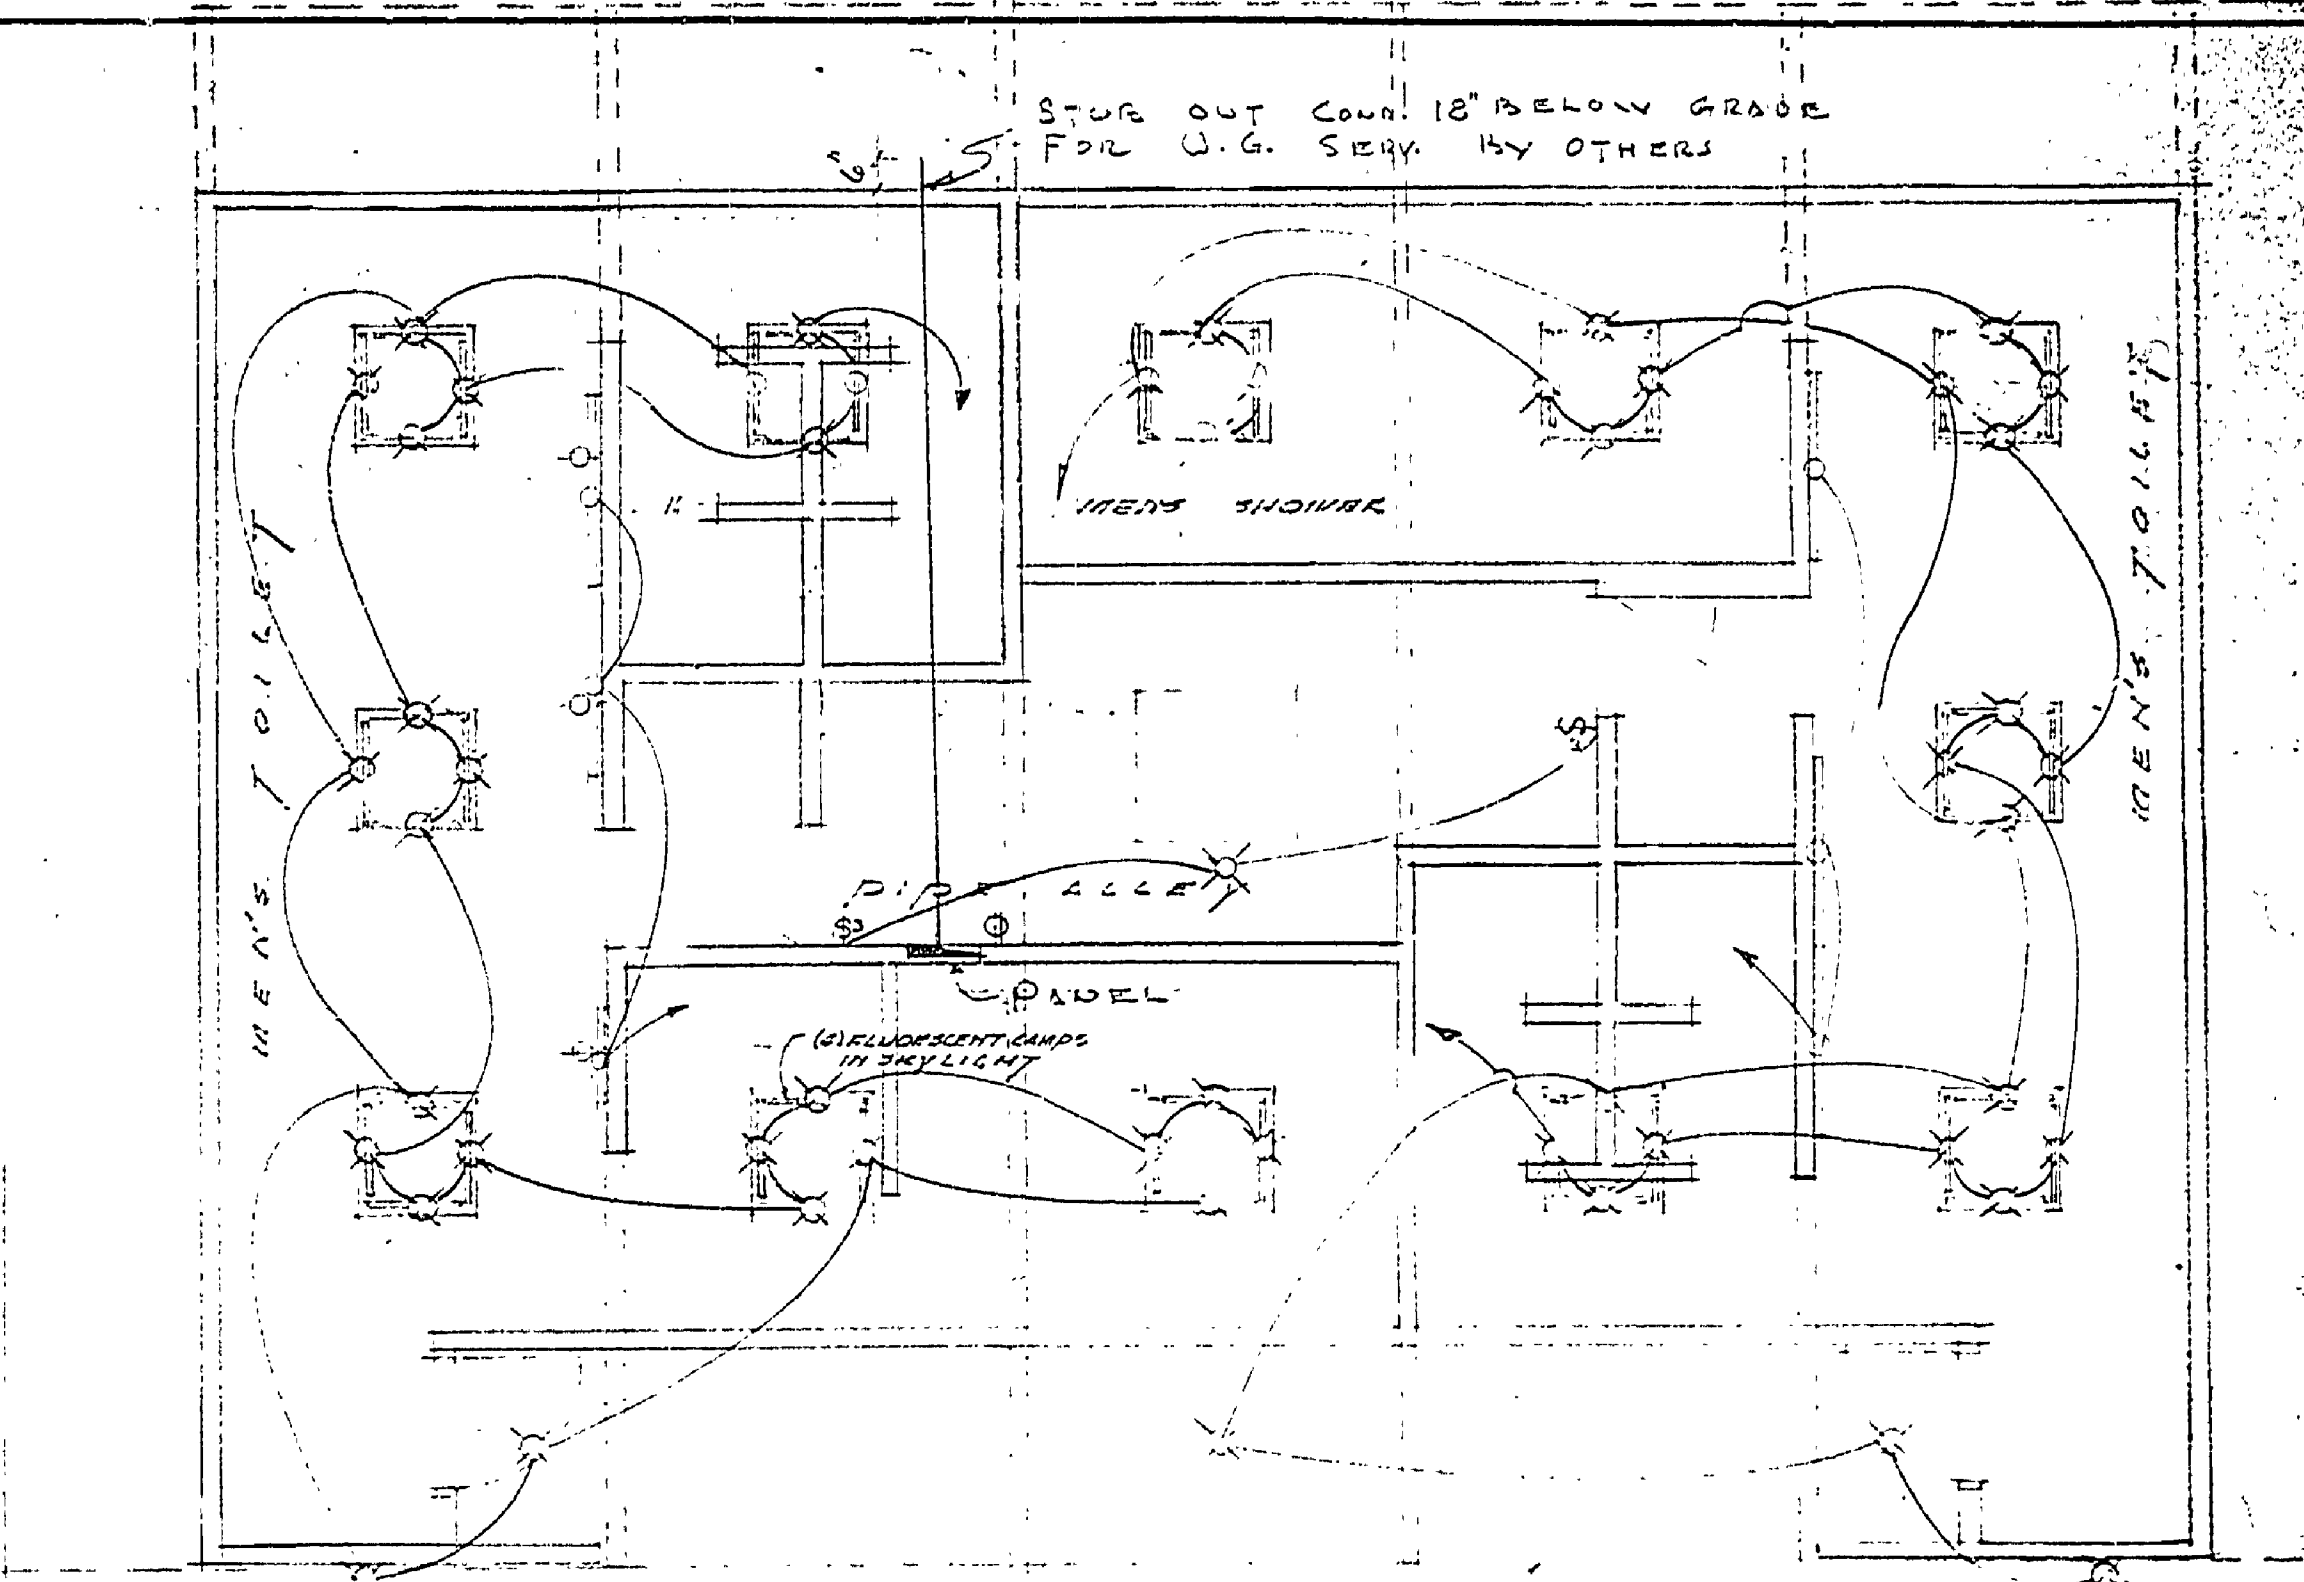


ELECTRICAL LIGHTING PLAN

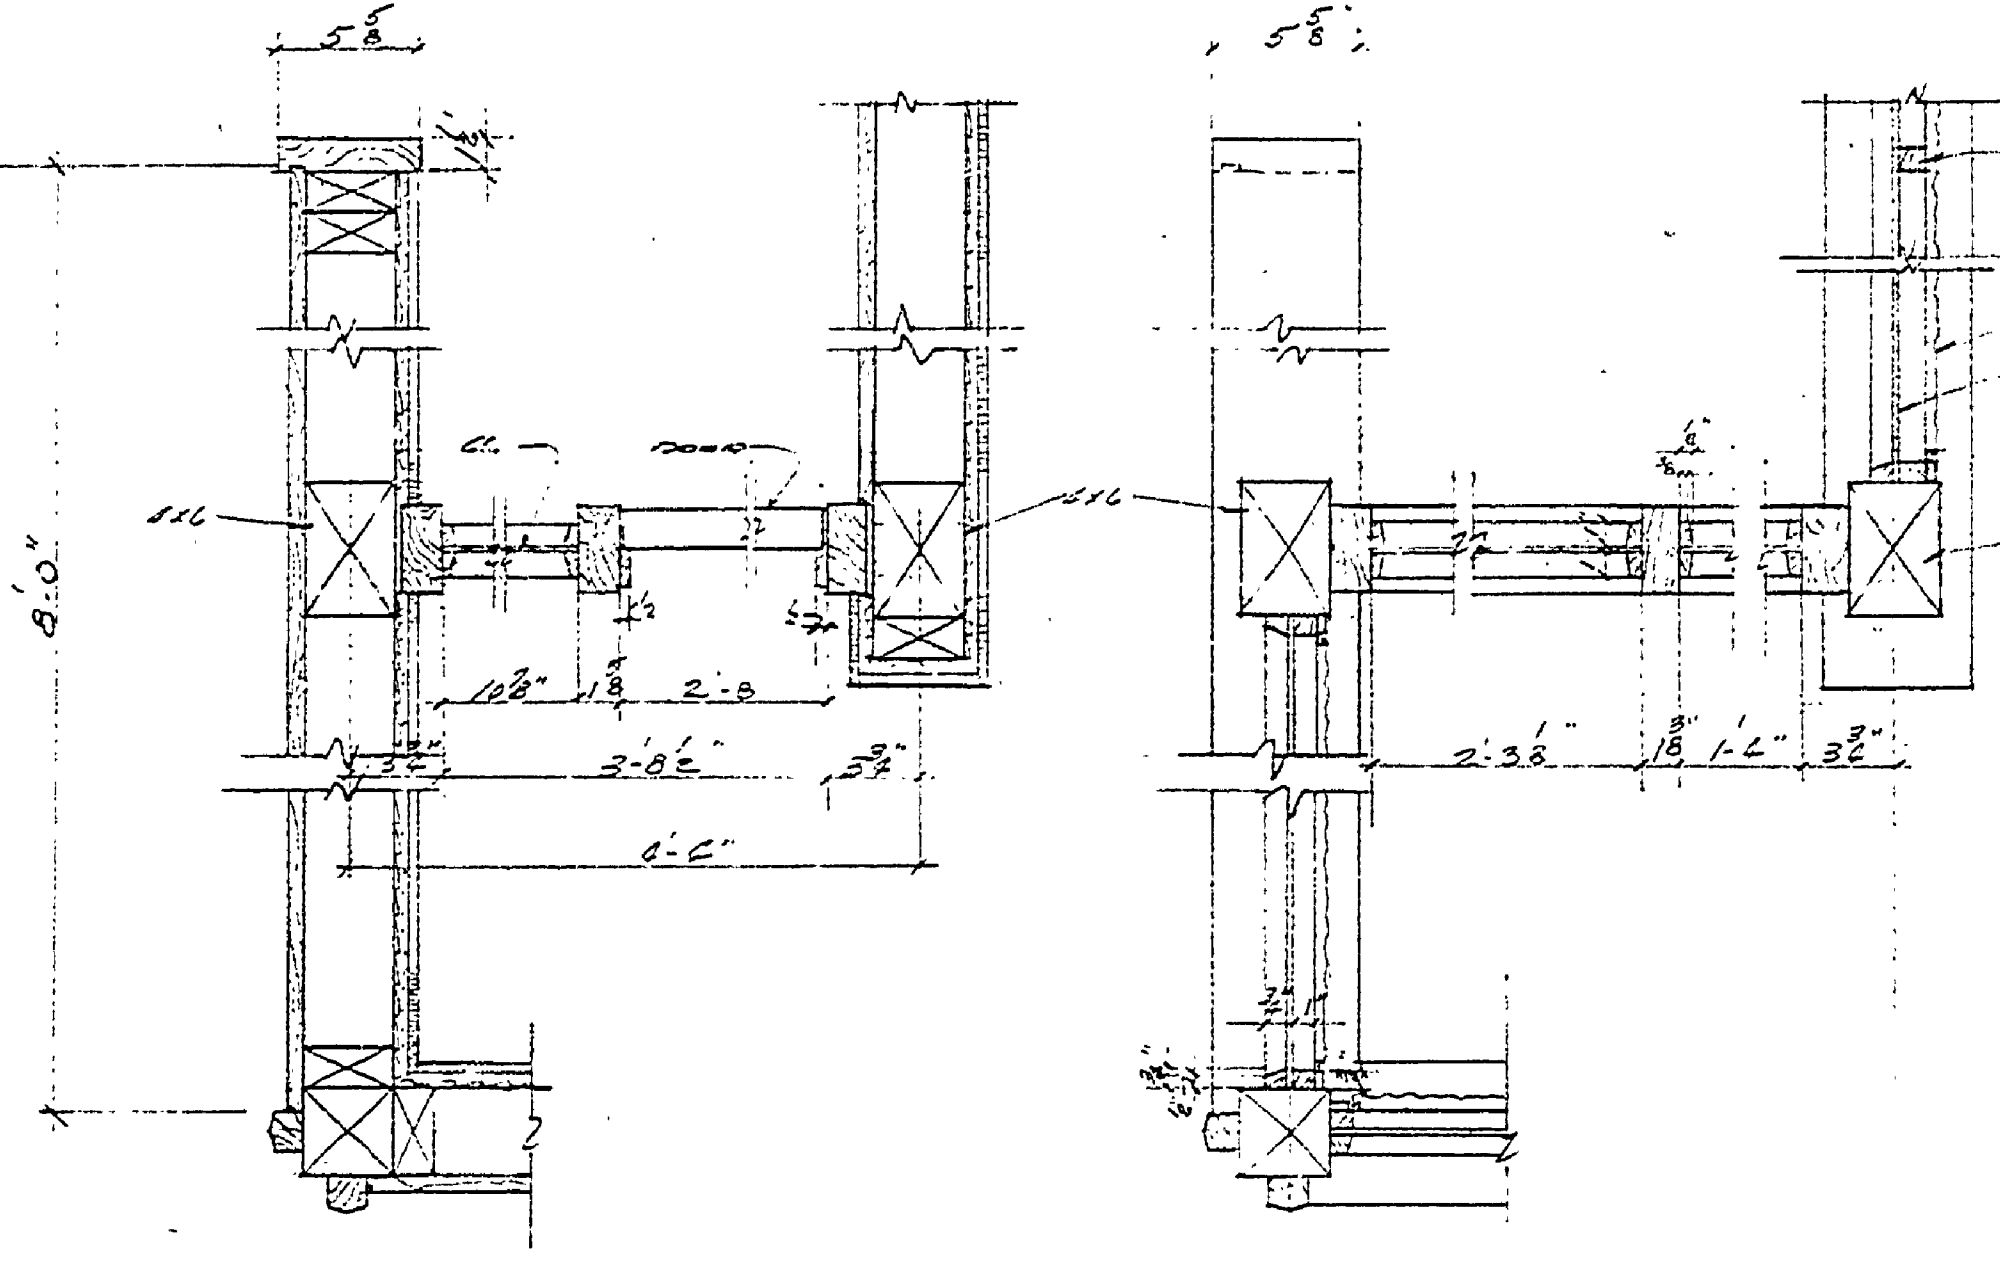


ENTRANCE DET.


ENTRANCE DET.

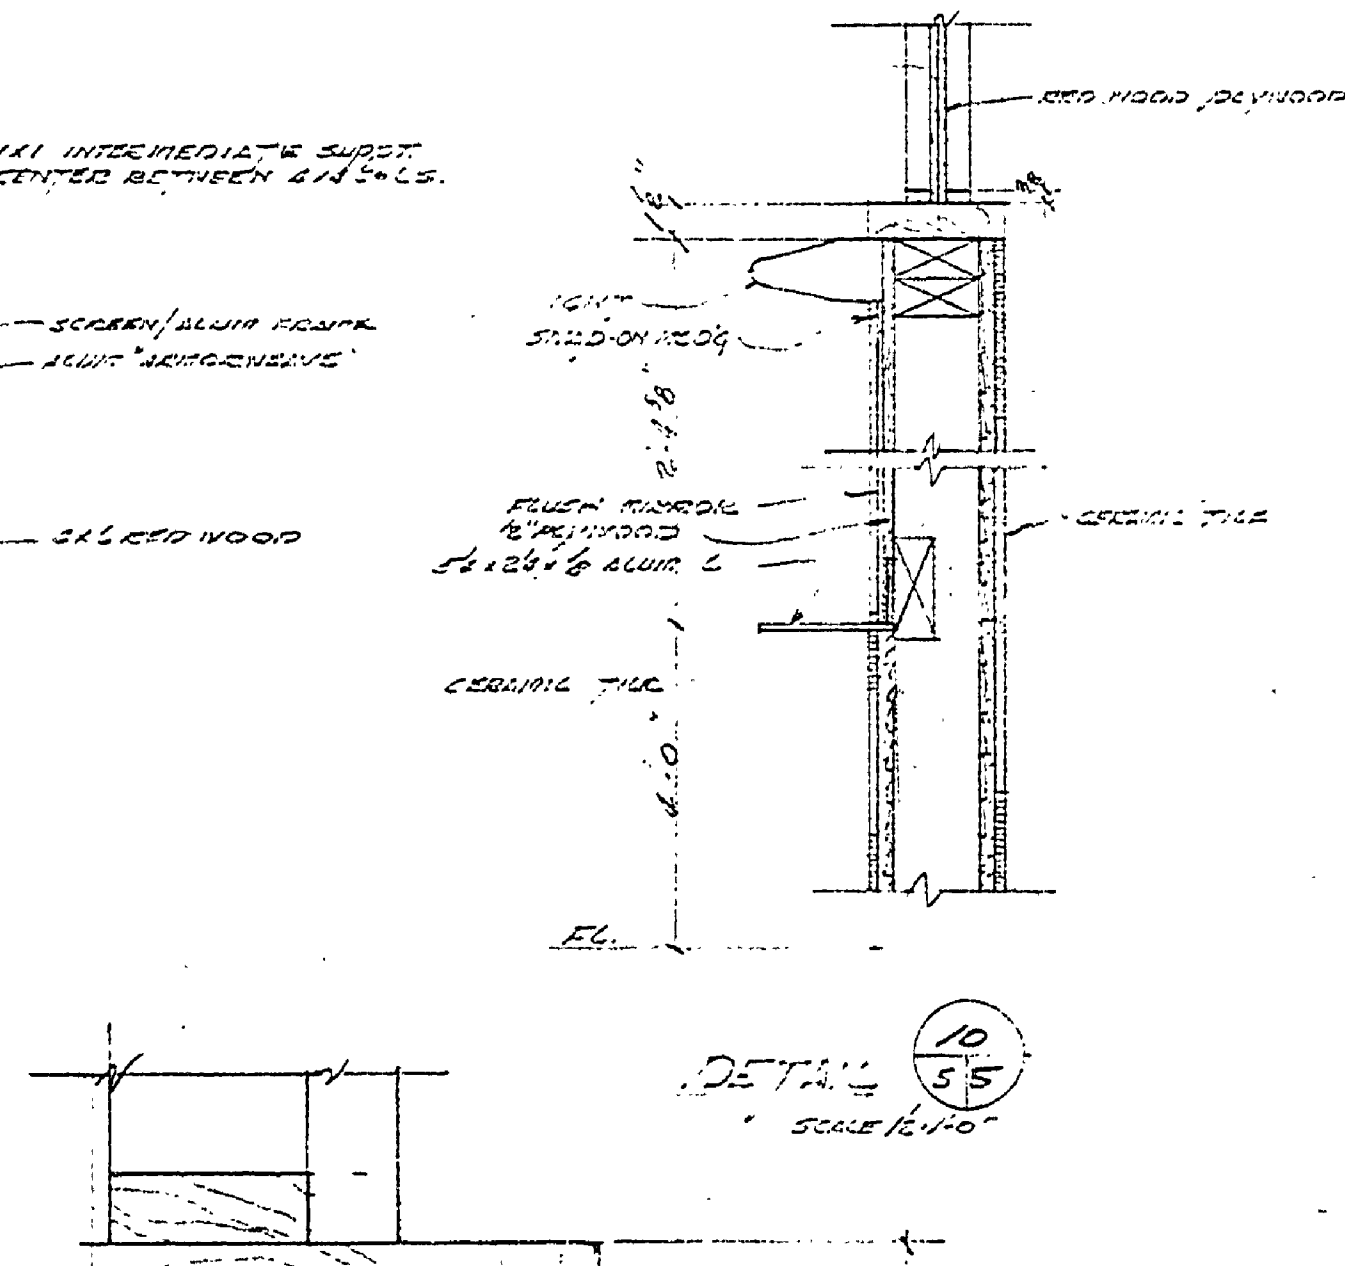

MIRROR & LIGHT DETAIL

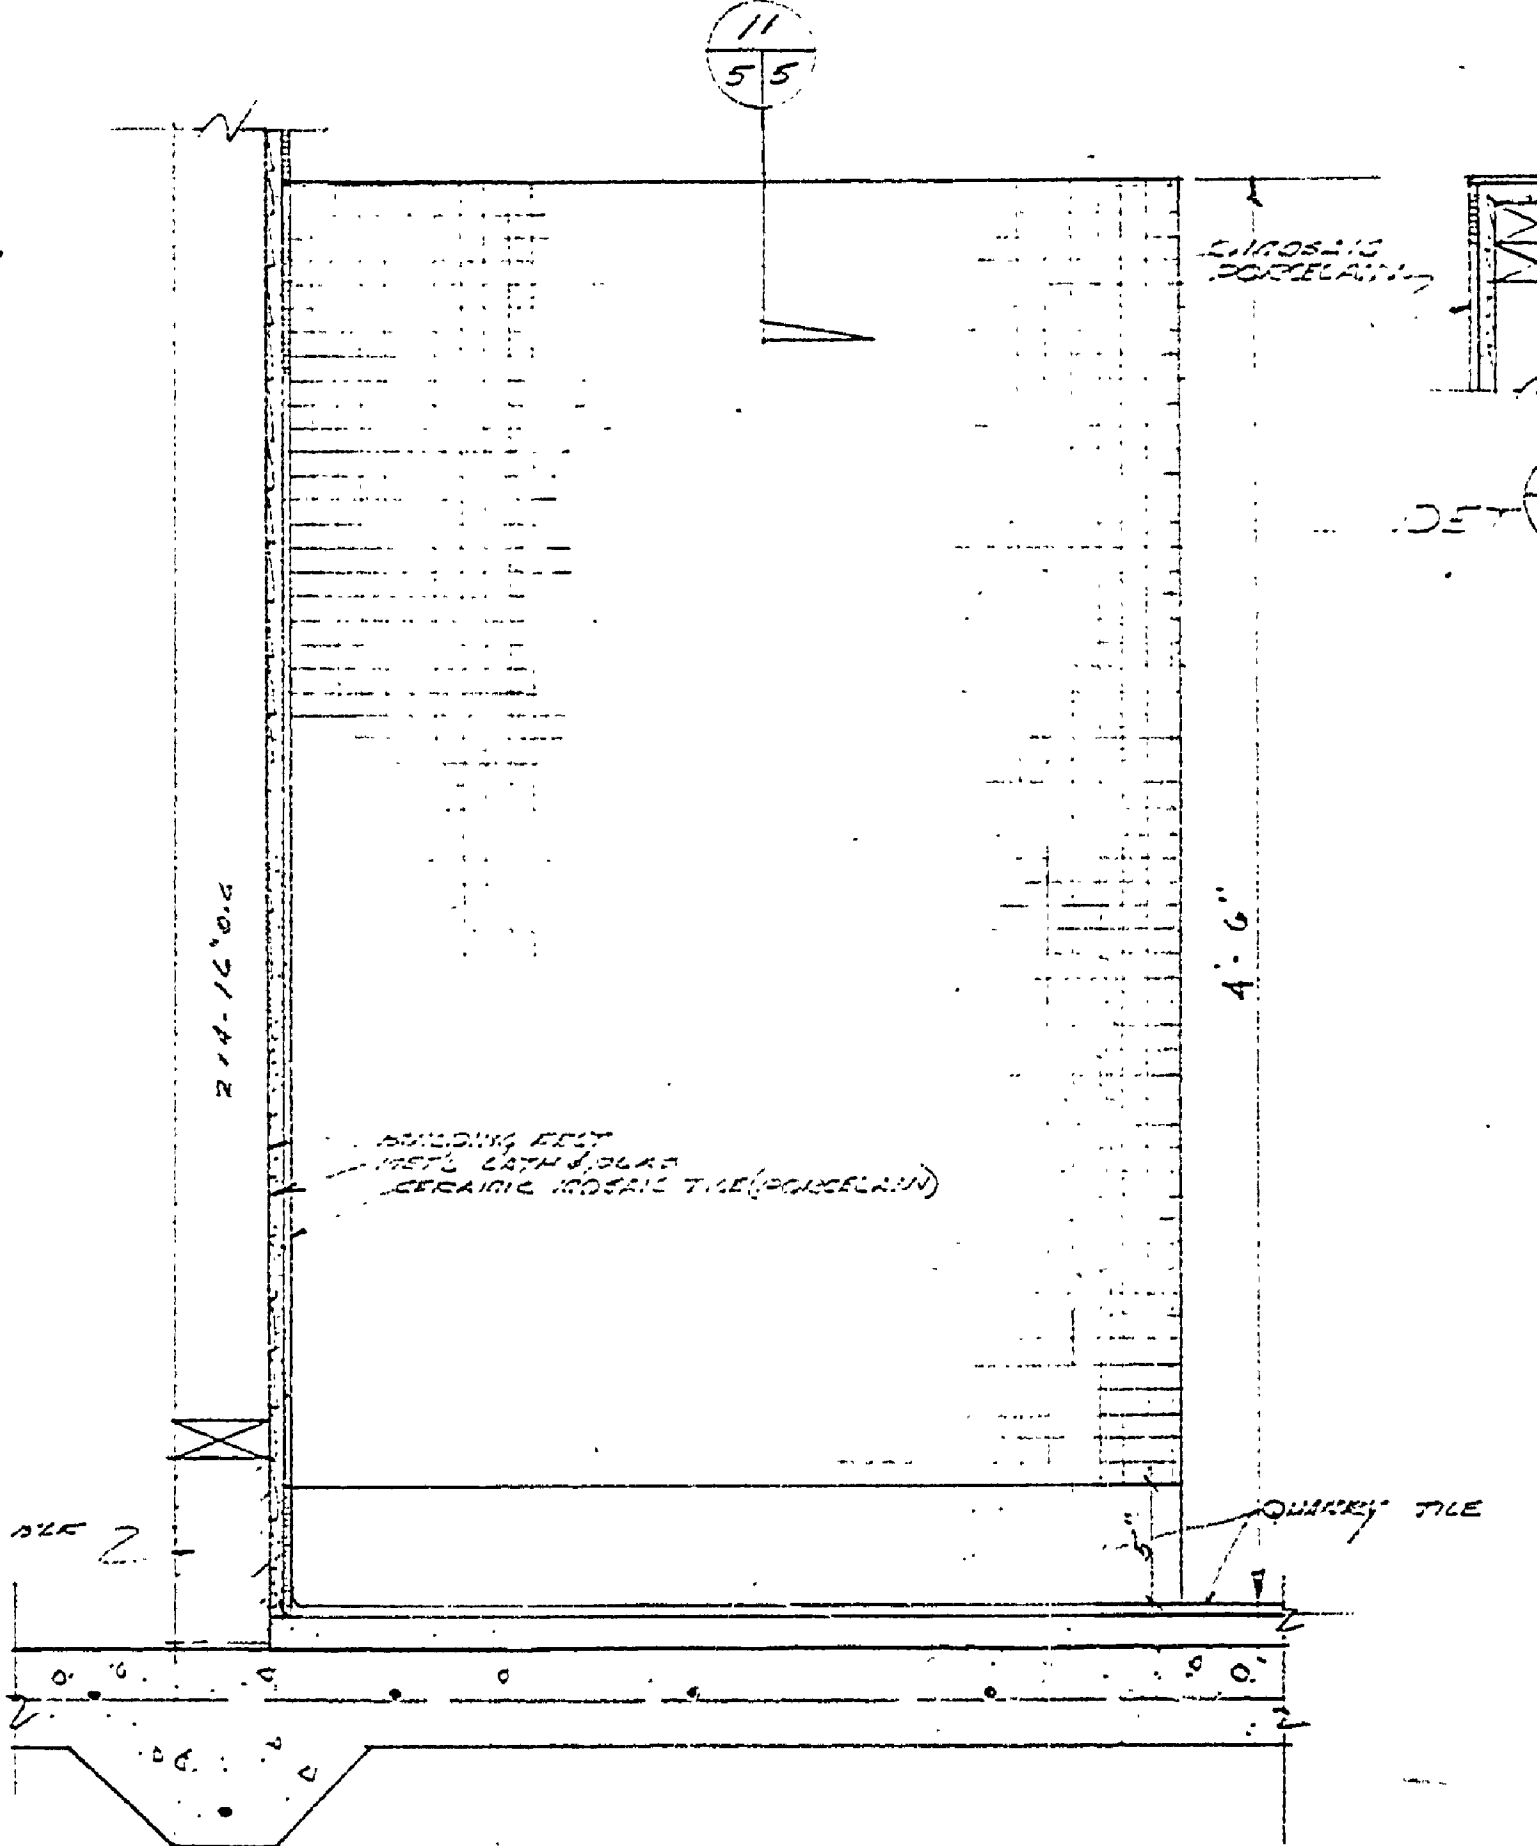

DETAIL URINAL

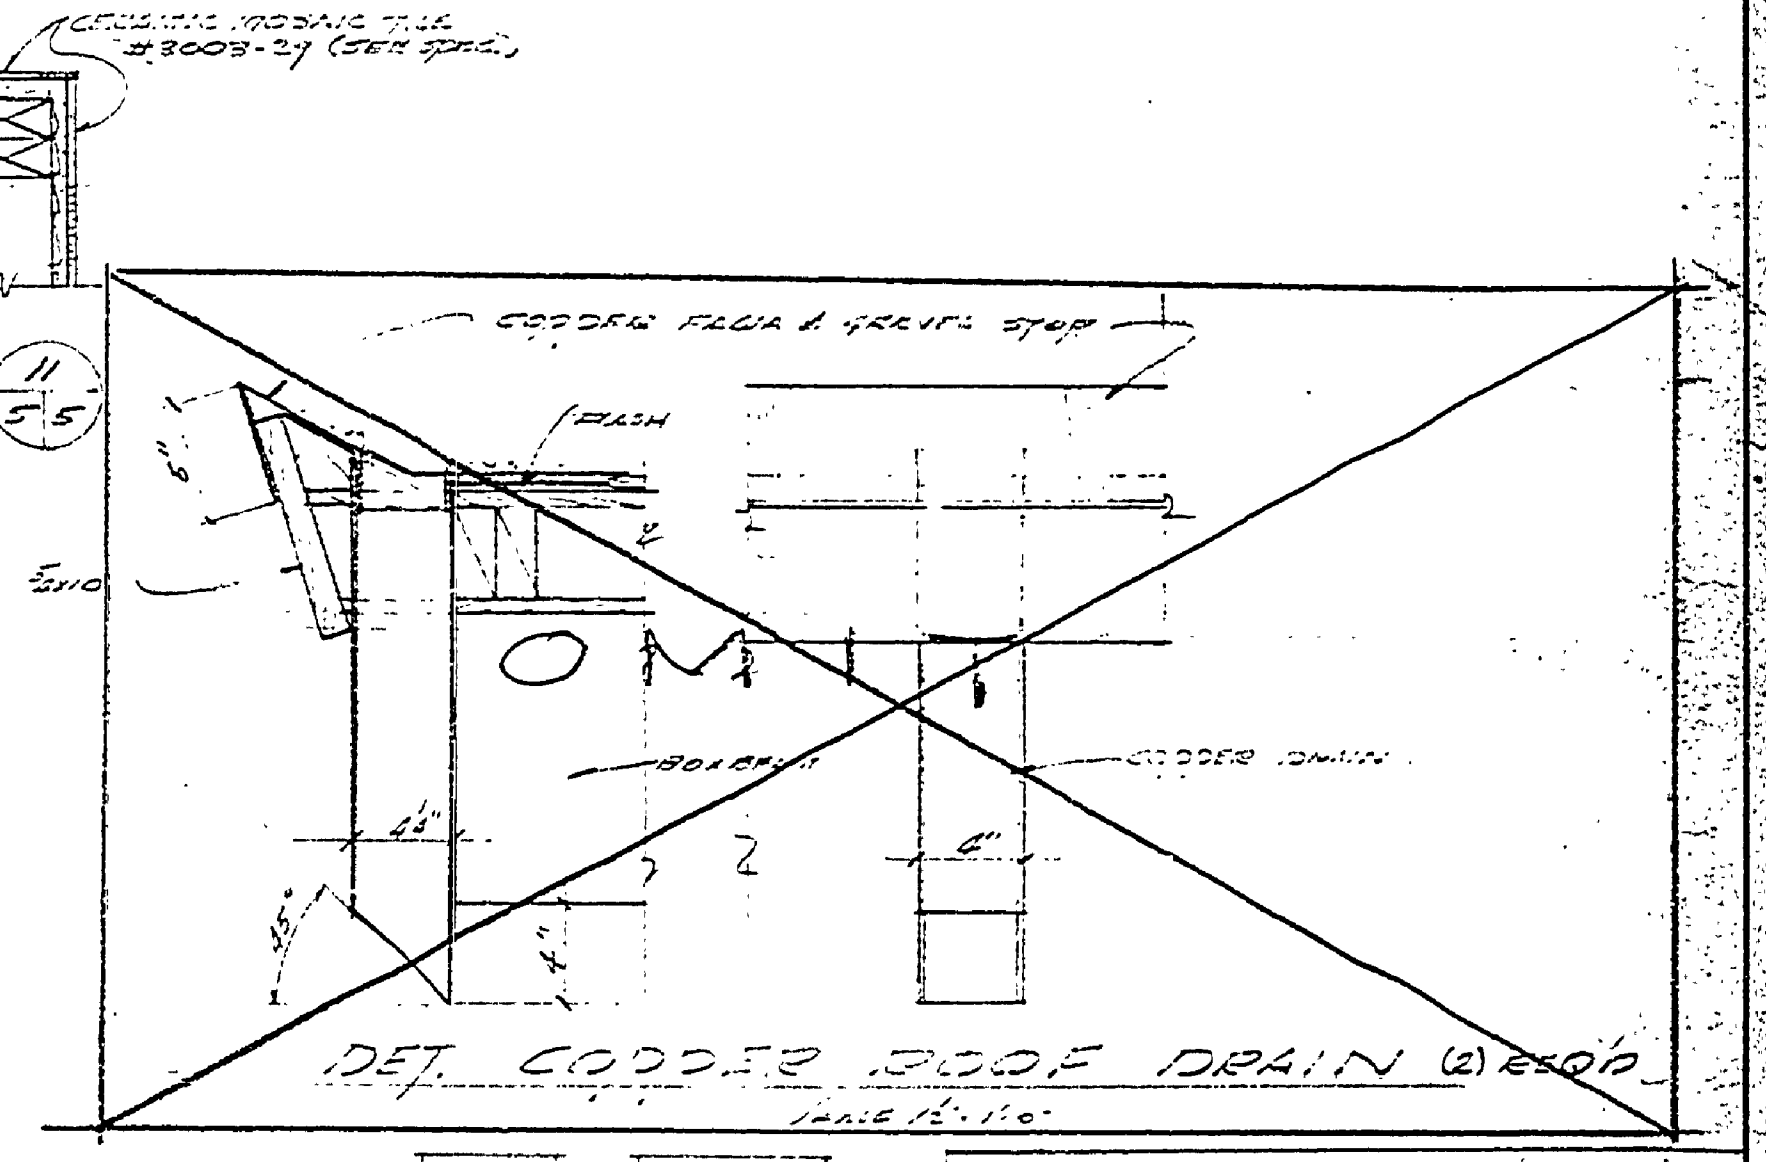

DET. COVE BASE DRAIN

NO.	TYPE	SIZE	REMARKS
1	A	1/2 2/2	SPED CODE
2	L	1/2 2/2	"
3	L	1/2 2/2	"
4	L	1/2 2/2	"
5	B	1/2 2/2	"
6	B	1/2 2/2	"
7	B	1/2 2/2	"
8	B	1/2 2/2	"

ROOM DESIGNATION	FLOOR	WALLS	CEILING	REMARKS
MEN'S TOILET ROOM				
WOMEN'S TOILET ROOM				
MEN'S SHOWERS				
WOMEN'S SHOWERS				
TOILET ALLEY				

MICHIGAN DEPARTMENT OF CONSERVATION PARKS AND RECREATION DIVISION

ALOHA STATE PARK TOILET & SHOWER BUILDING #8

SHEET NO. 5 OF 5 PLAN NO. A-102