

# PICNIC AREA TOILET

## TAHQAMENON FALLS STATE PARK

PROJECT NO. 975-11-C2


*William J. Jones*  
CHIEF - PARKS & RECREATION DIVISION

DRAWN BY <i>J. W. F.</i>	CHECKED BY <i>J. W. F.</i>	DATE	REVISIONS		
			NO.	DATE	BY
			1		
			2		
			3		
			4		
			5		
			6		

APPROVED BY  
*H. C. [Signature]*  
ASSISTANT CHIEF IN CHARGE  
DATE *20 March 59*

REVIEWED BY SECTIONS  
ARCHITECTURAL  
ENGINEERING  
LANDSCAPE

DATE

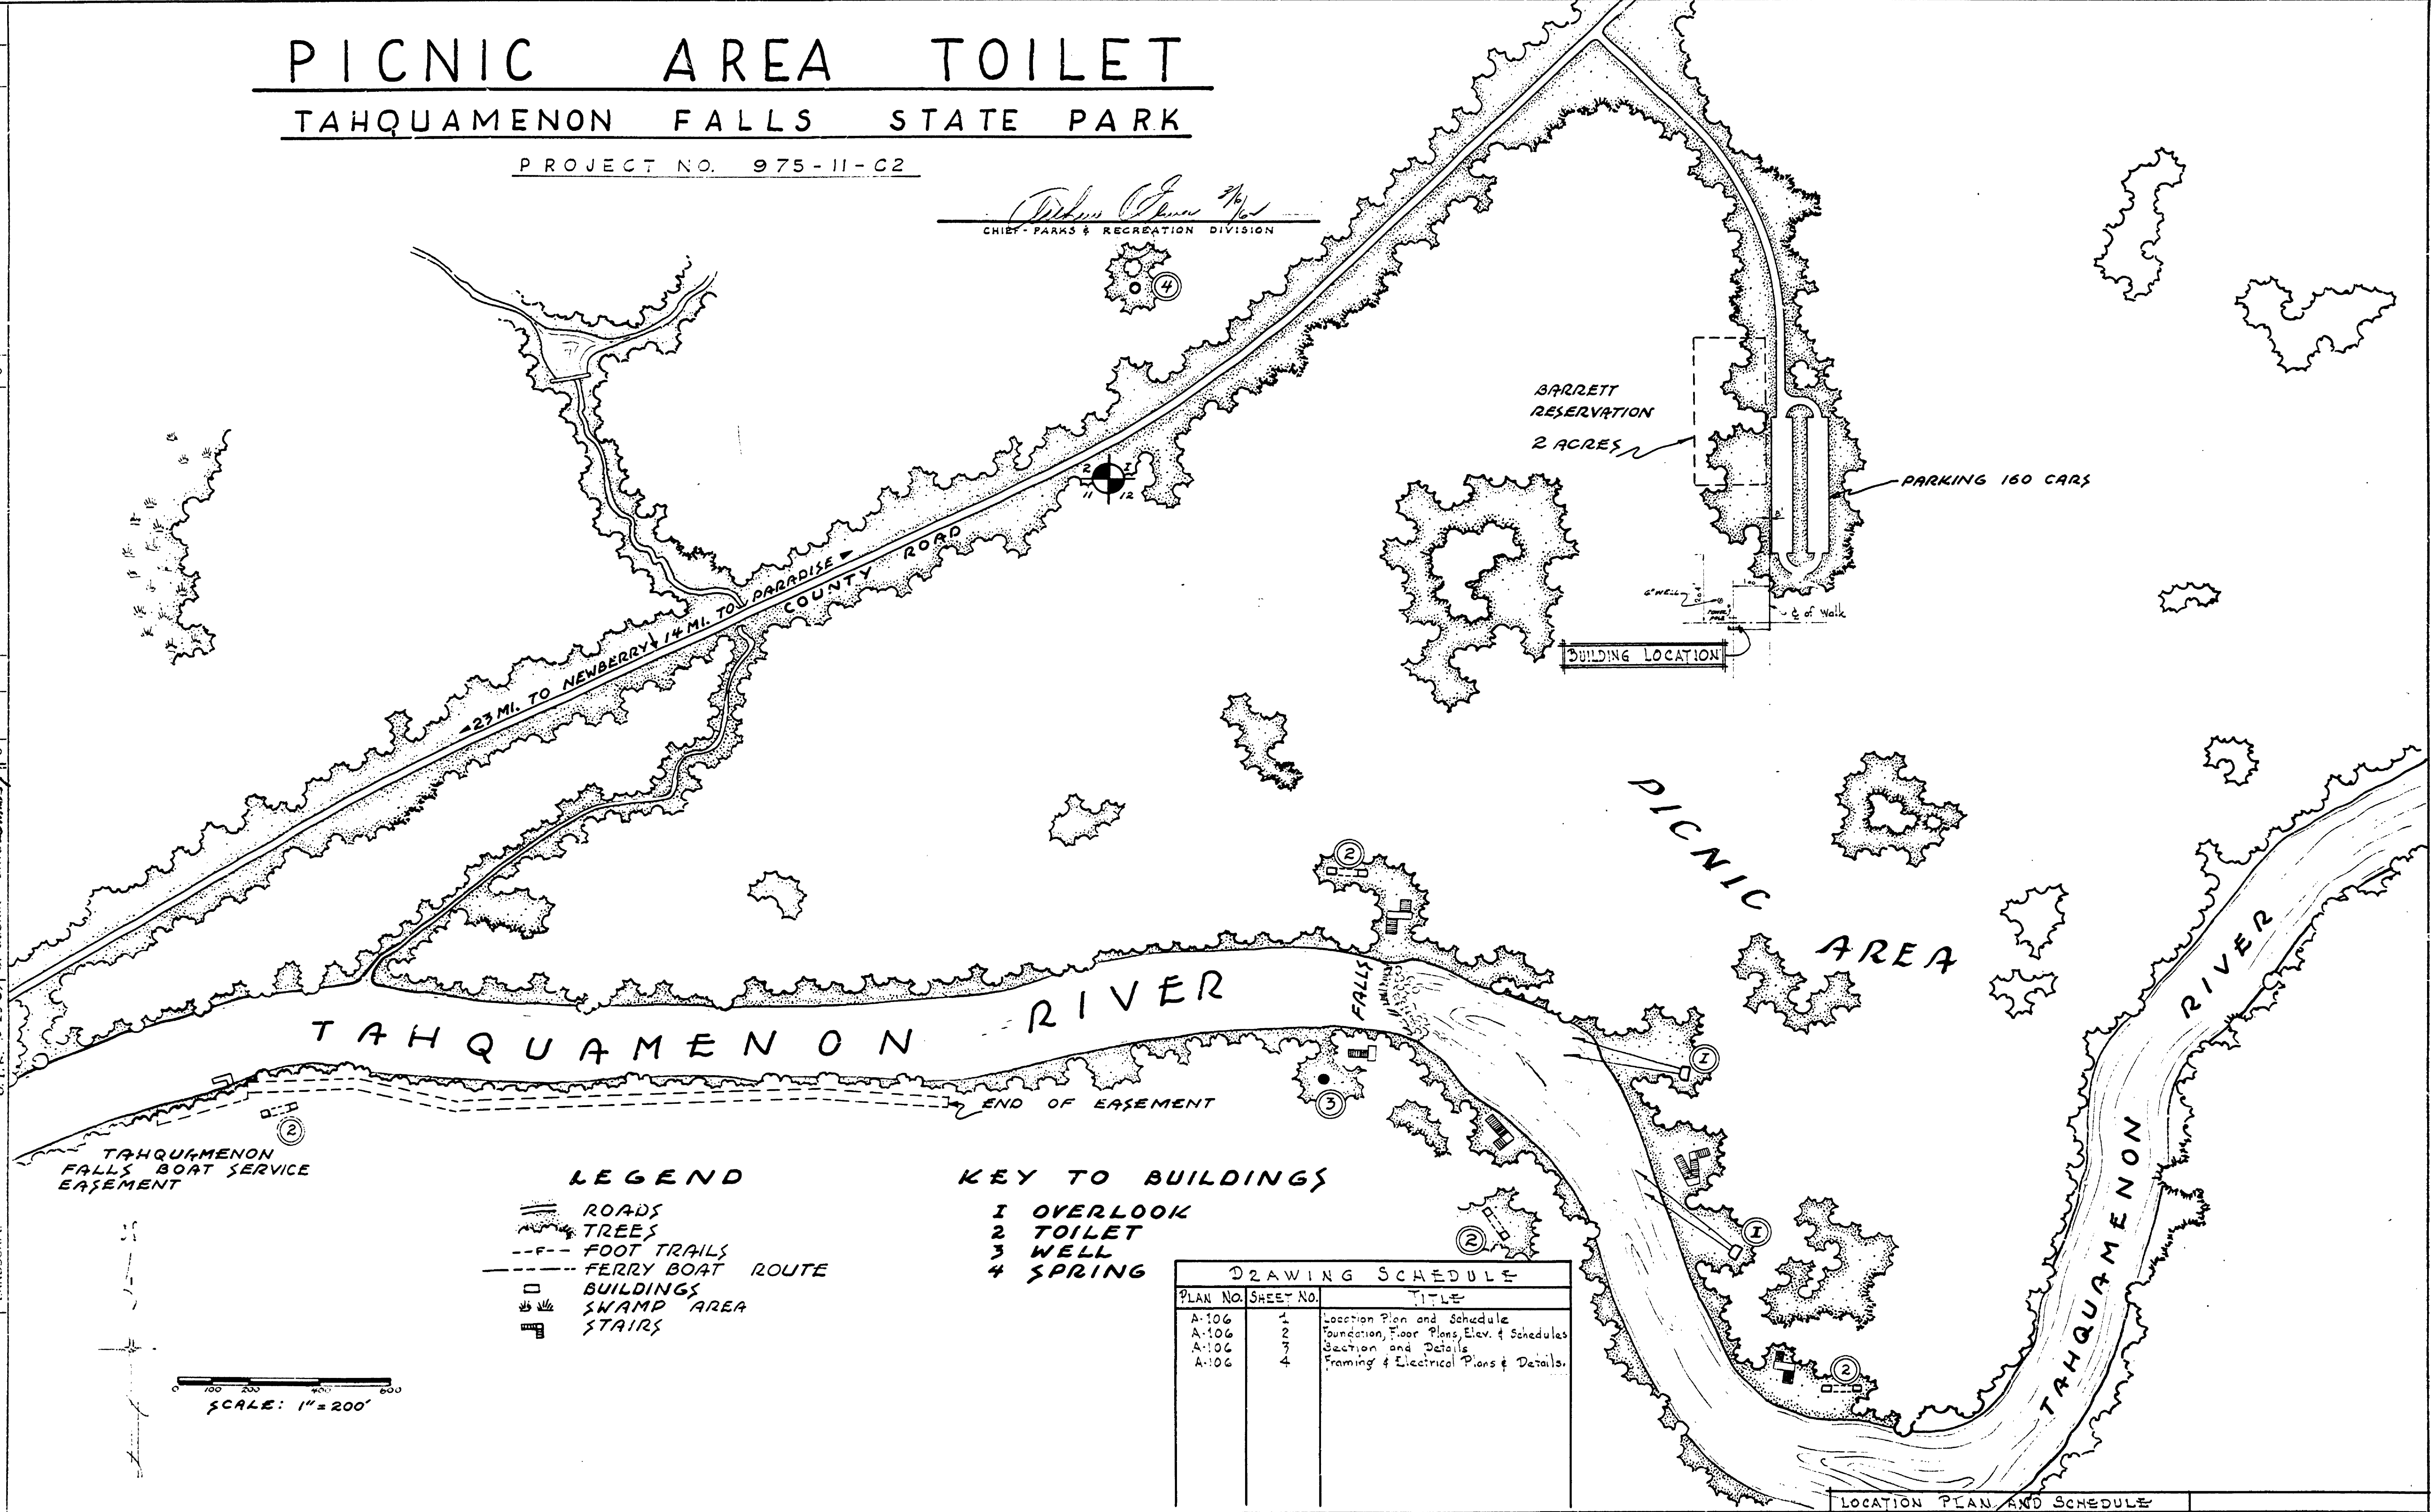

TAHQAMENON FALLS BOAT SERVICE EASEMENT

- LEGEND**
- ROADS
  - TREES
  - FOOT TRAILS
  - FERRY BOAT ROUTE
  - BUILDINGS
  - SWAMP AREA
  - STAIRS

- KEY TO BUILDINGS**
- 1 OVERLOOK
  - 2 TOILET
  - 3 WELL
  - 4 SPRING

DRAWING SCHEDULE		
PLAN NO.	SHEET NO.	TITLE
A-106	1	Location Plan and Schedule
A-106	2	Foundation, Floor Plans, Elev. & Schedules
A-106	3	Section and Details
A-106	4	Framing & Electrical Plans & Details

SCALE: 1" = 200'

MICHIGAN DEPARTMENT OF CONSERVATION  
PARKS AND RECREATION DIVISION

LOCATION PLAN AND SCHEDULE	SHEET NO. 1	PLAN NO. A-106
TAHQAMENON FALLS STATE PARK UPPER FALLS PICNIC AREA TOILET	OF 4	