




DRAWN BY E. J. P.	CHECKED BY A.C.P. 22 Dec 57 C.J.R. 12-22-57	DATE 12-22-57	REVIEWED BY SECTIONS		APPROVED BY <i>[Signature]</i> ASSISTANT CHIEF IN CHARGE OF DESIGN DATE 1-3-58
			ARCHITECTURAL	LANDSCAPE	
			ENGINEERING		
			NO.	DATE	BY
			1		
			2		
			3		
			4		
			5		
			6		

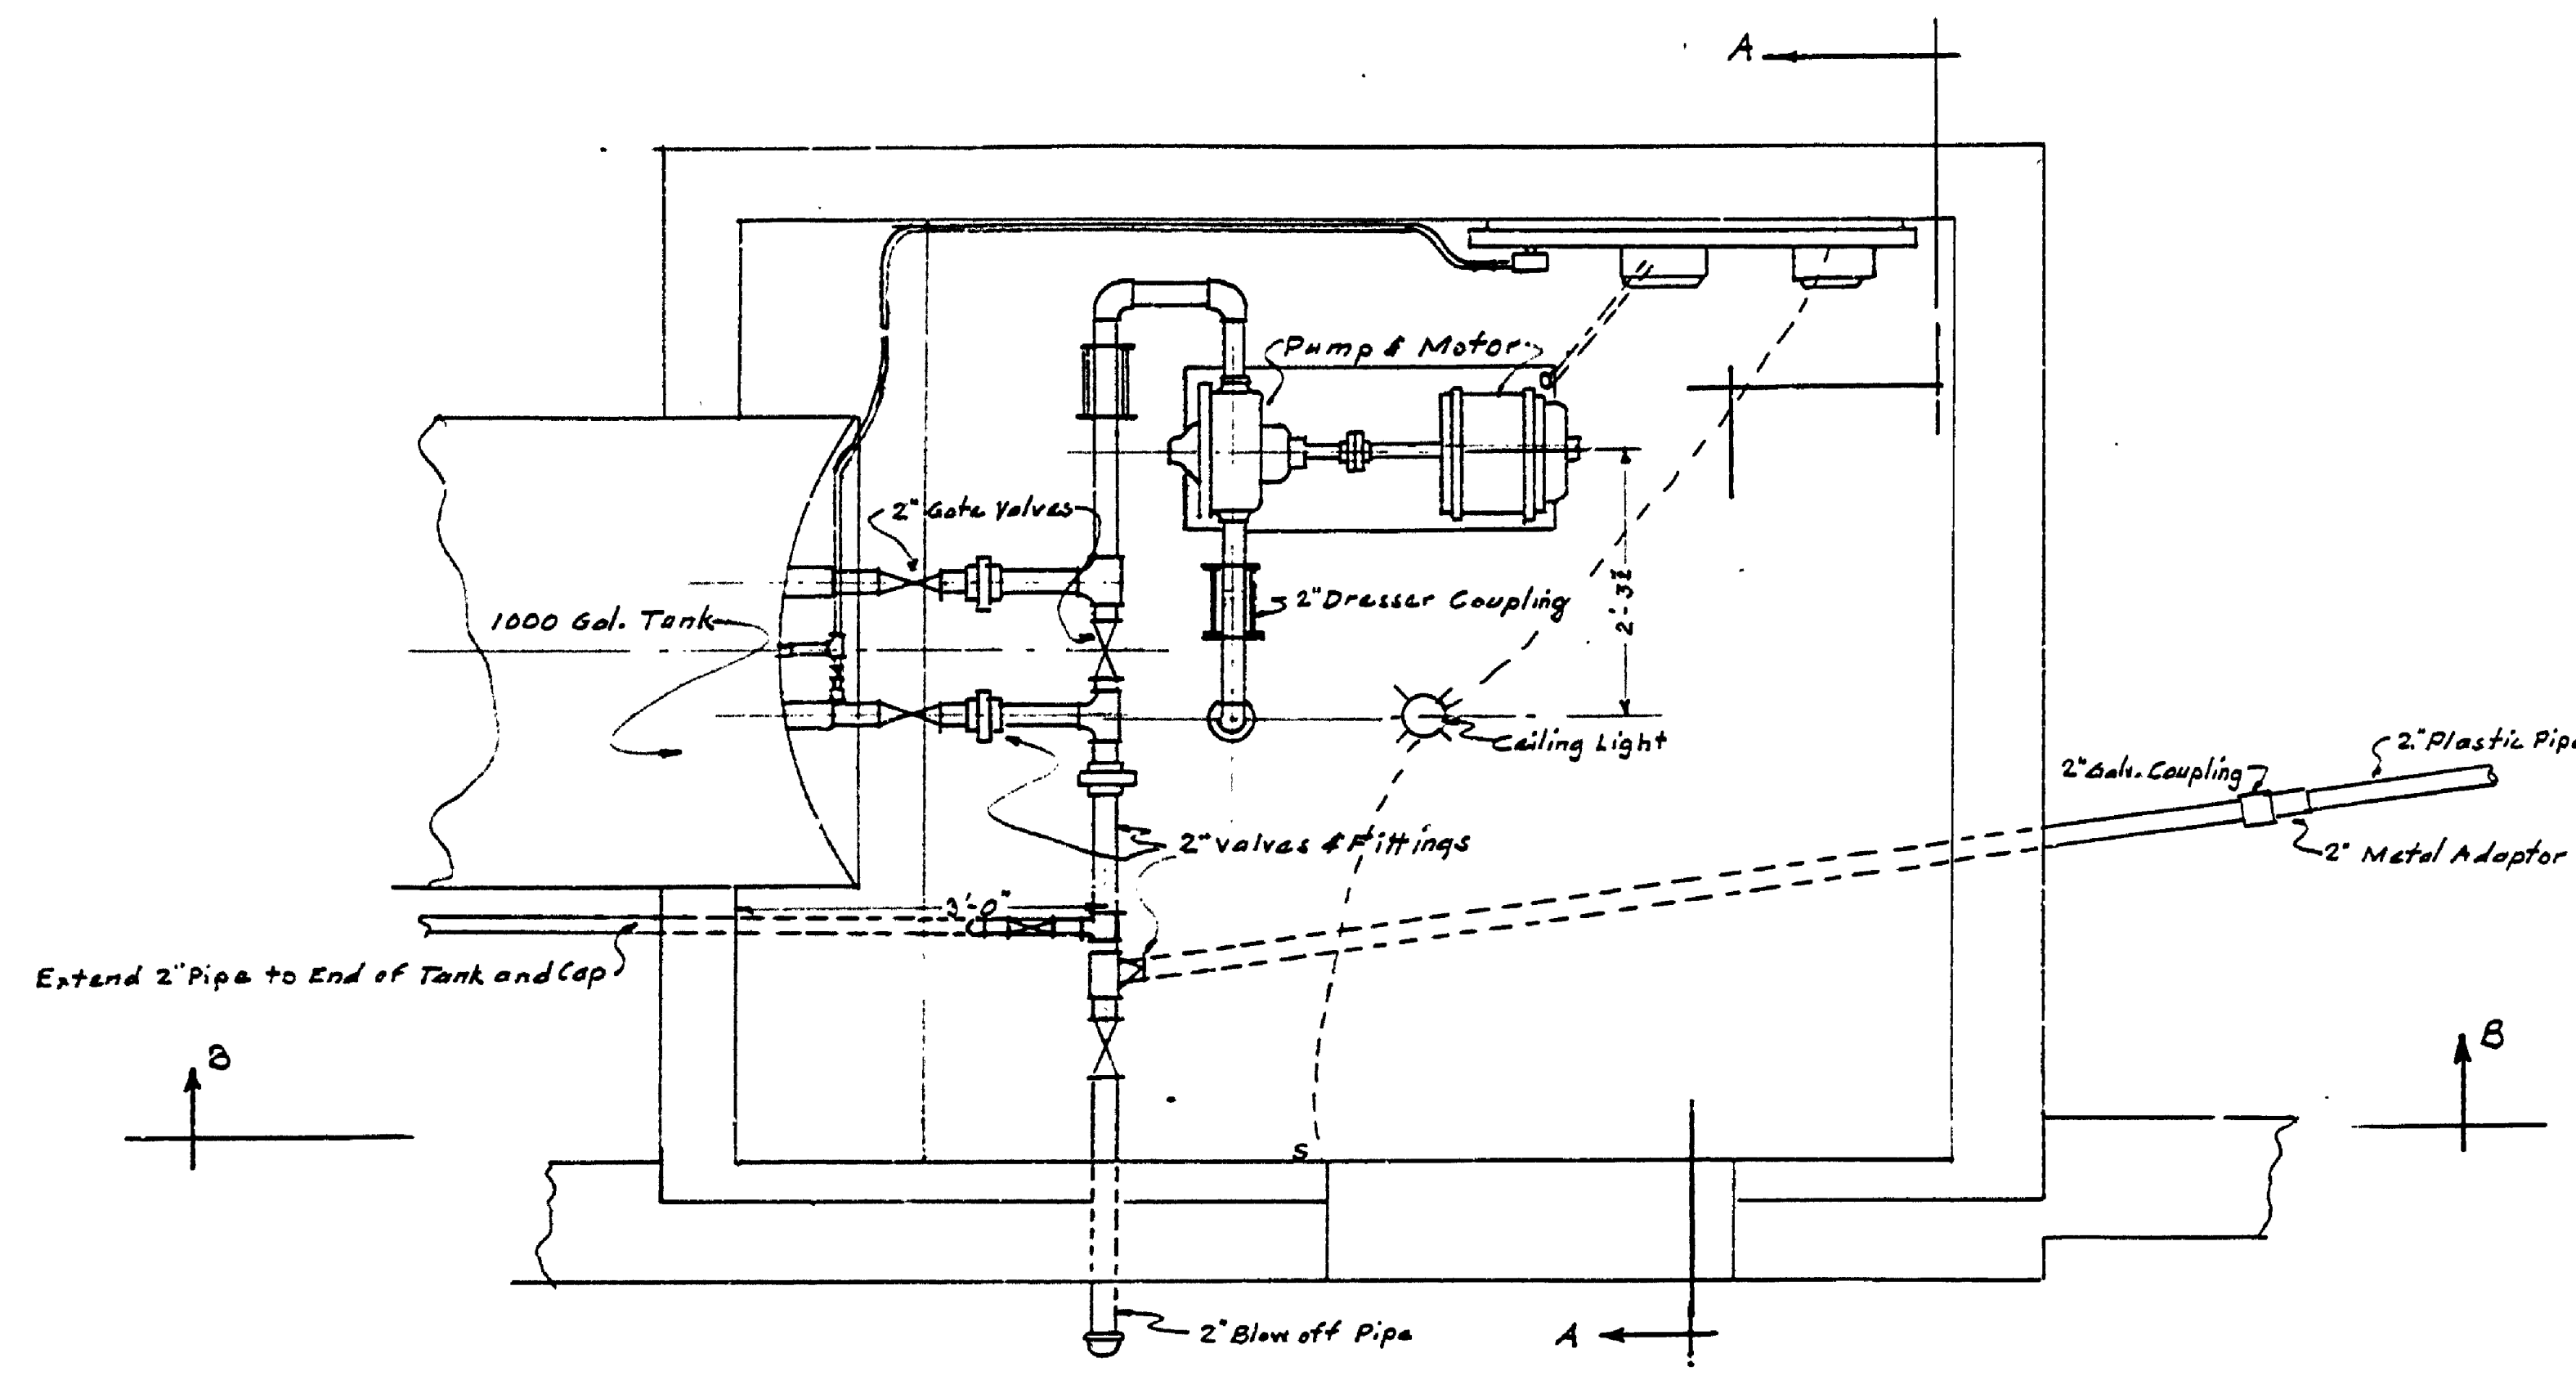


PLAN OF MECHANICAL LAYOUT
SCALE 3/4"=1'-0"

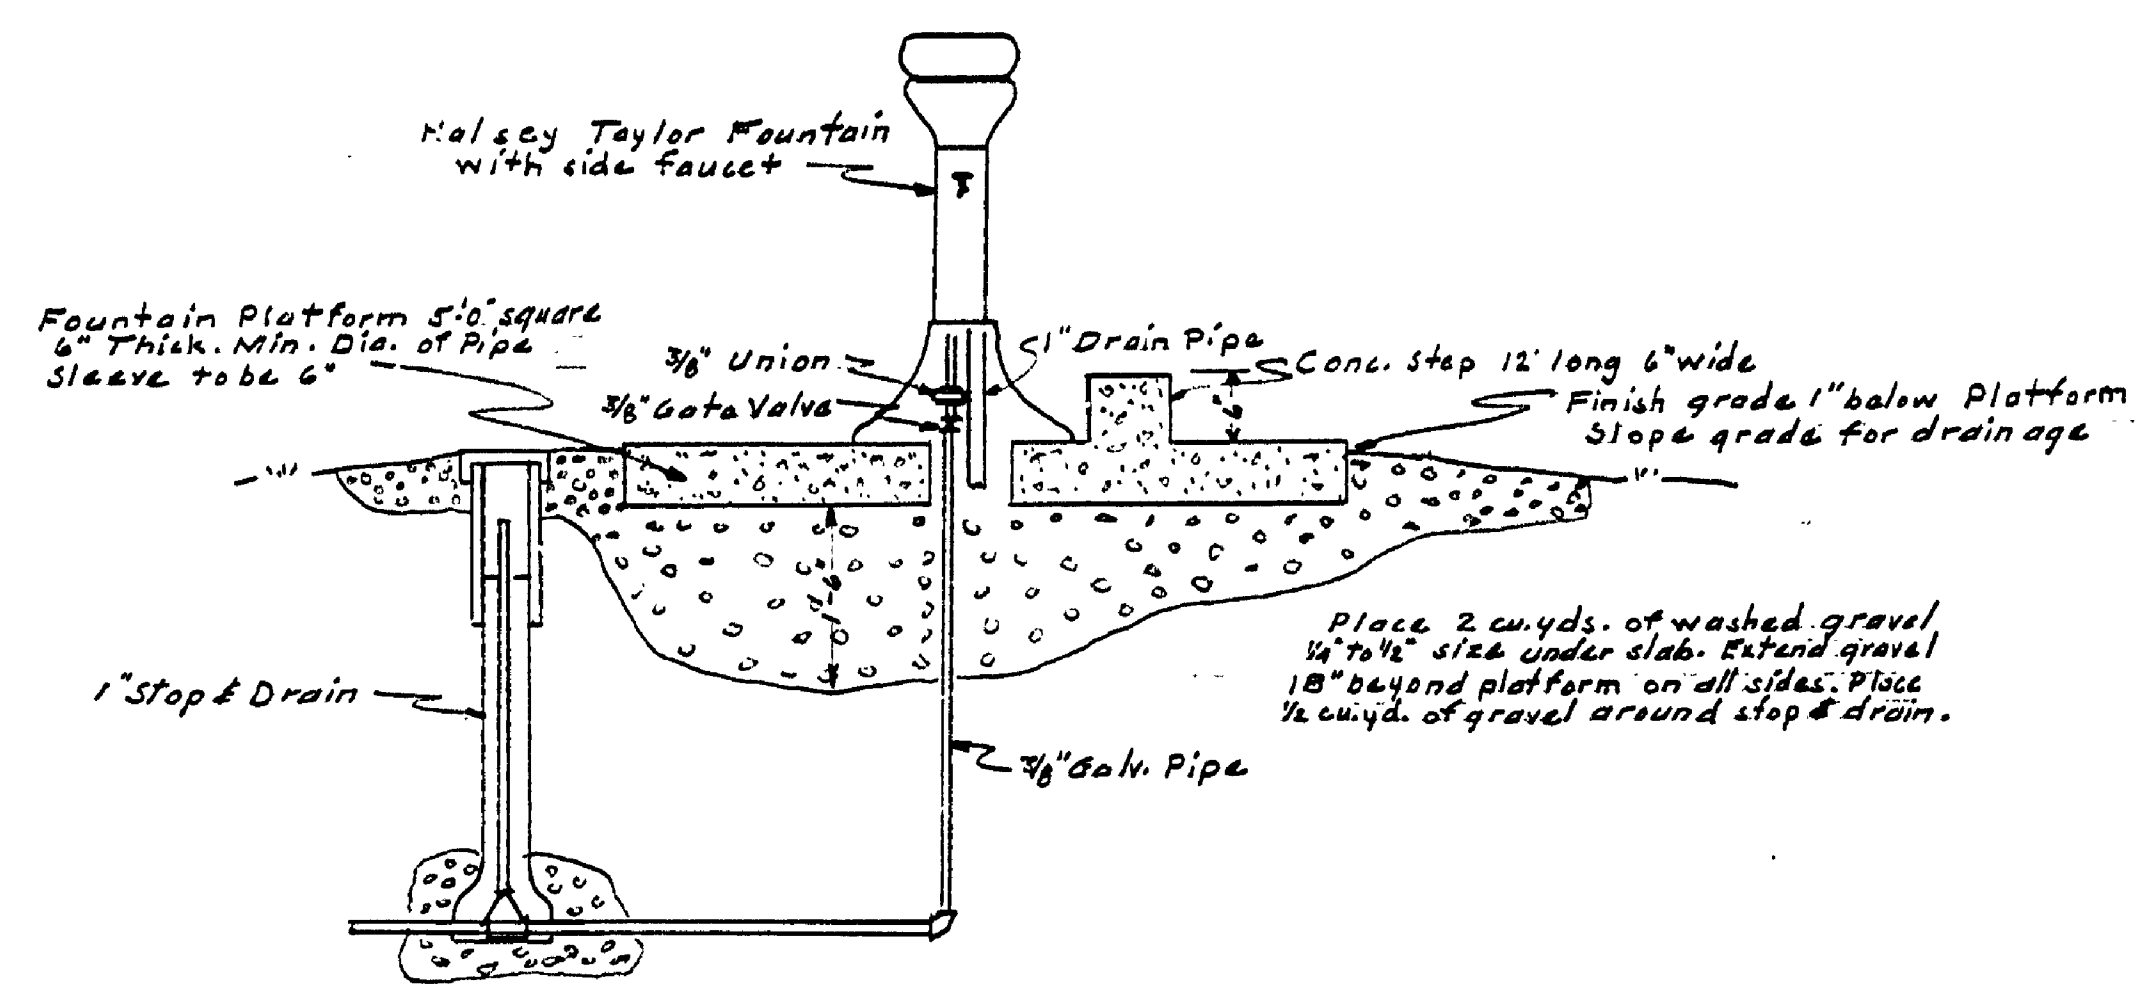

DRINKING FOUNTAIN
Not to scale

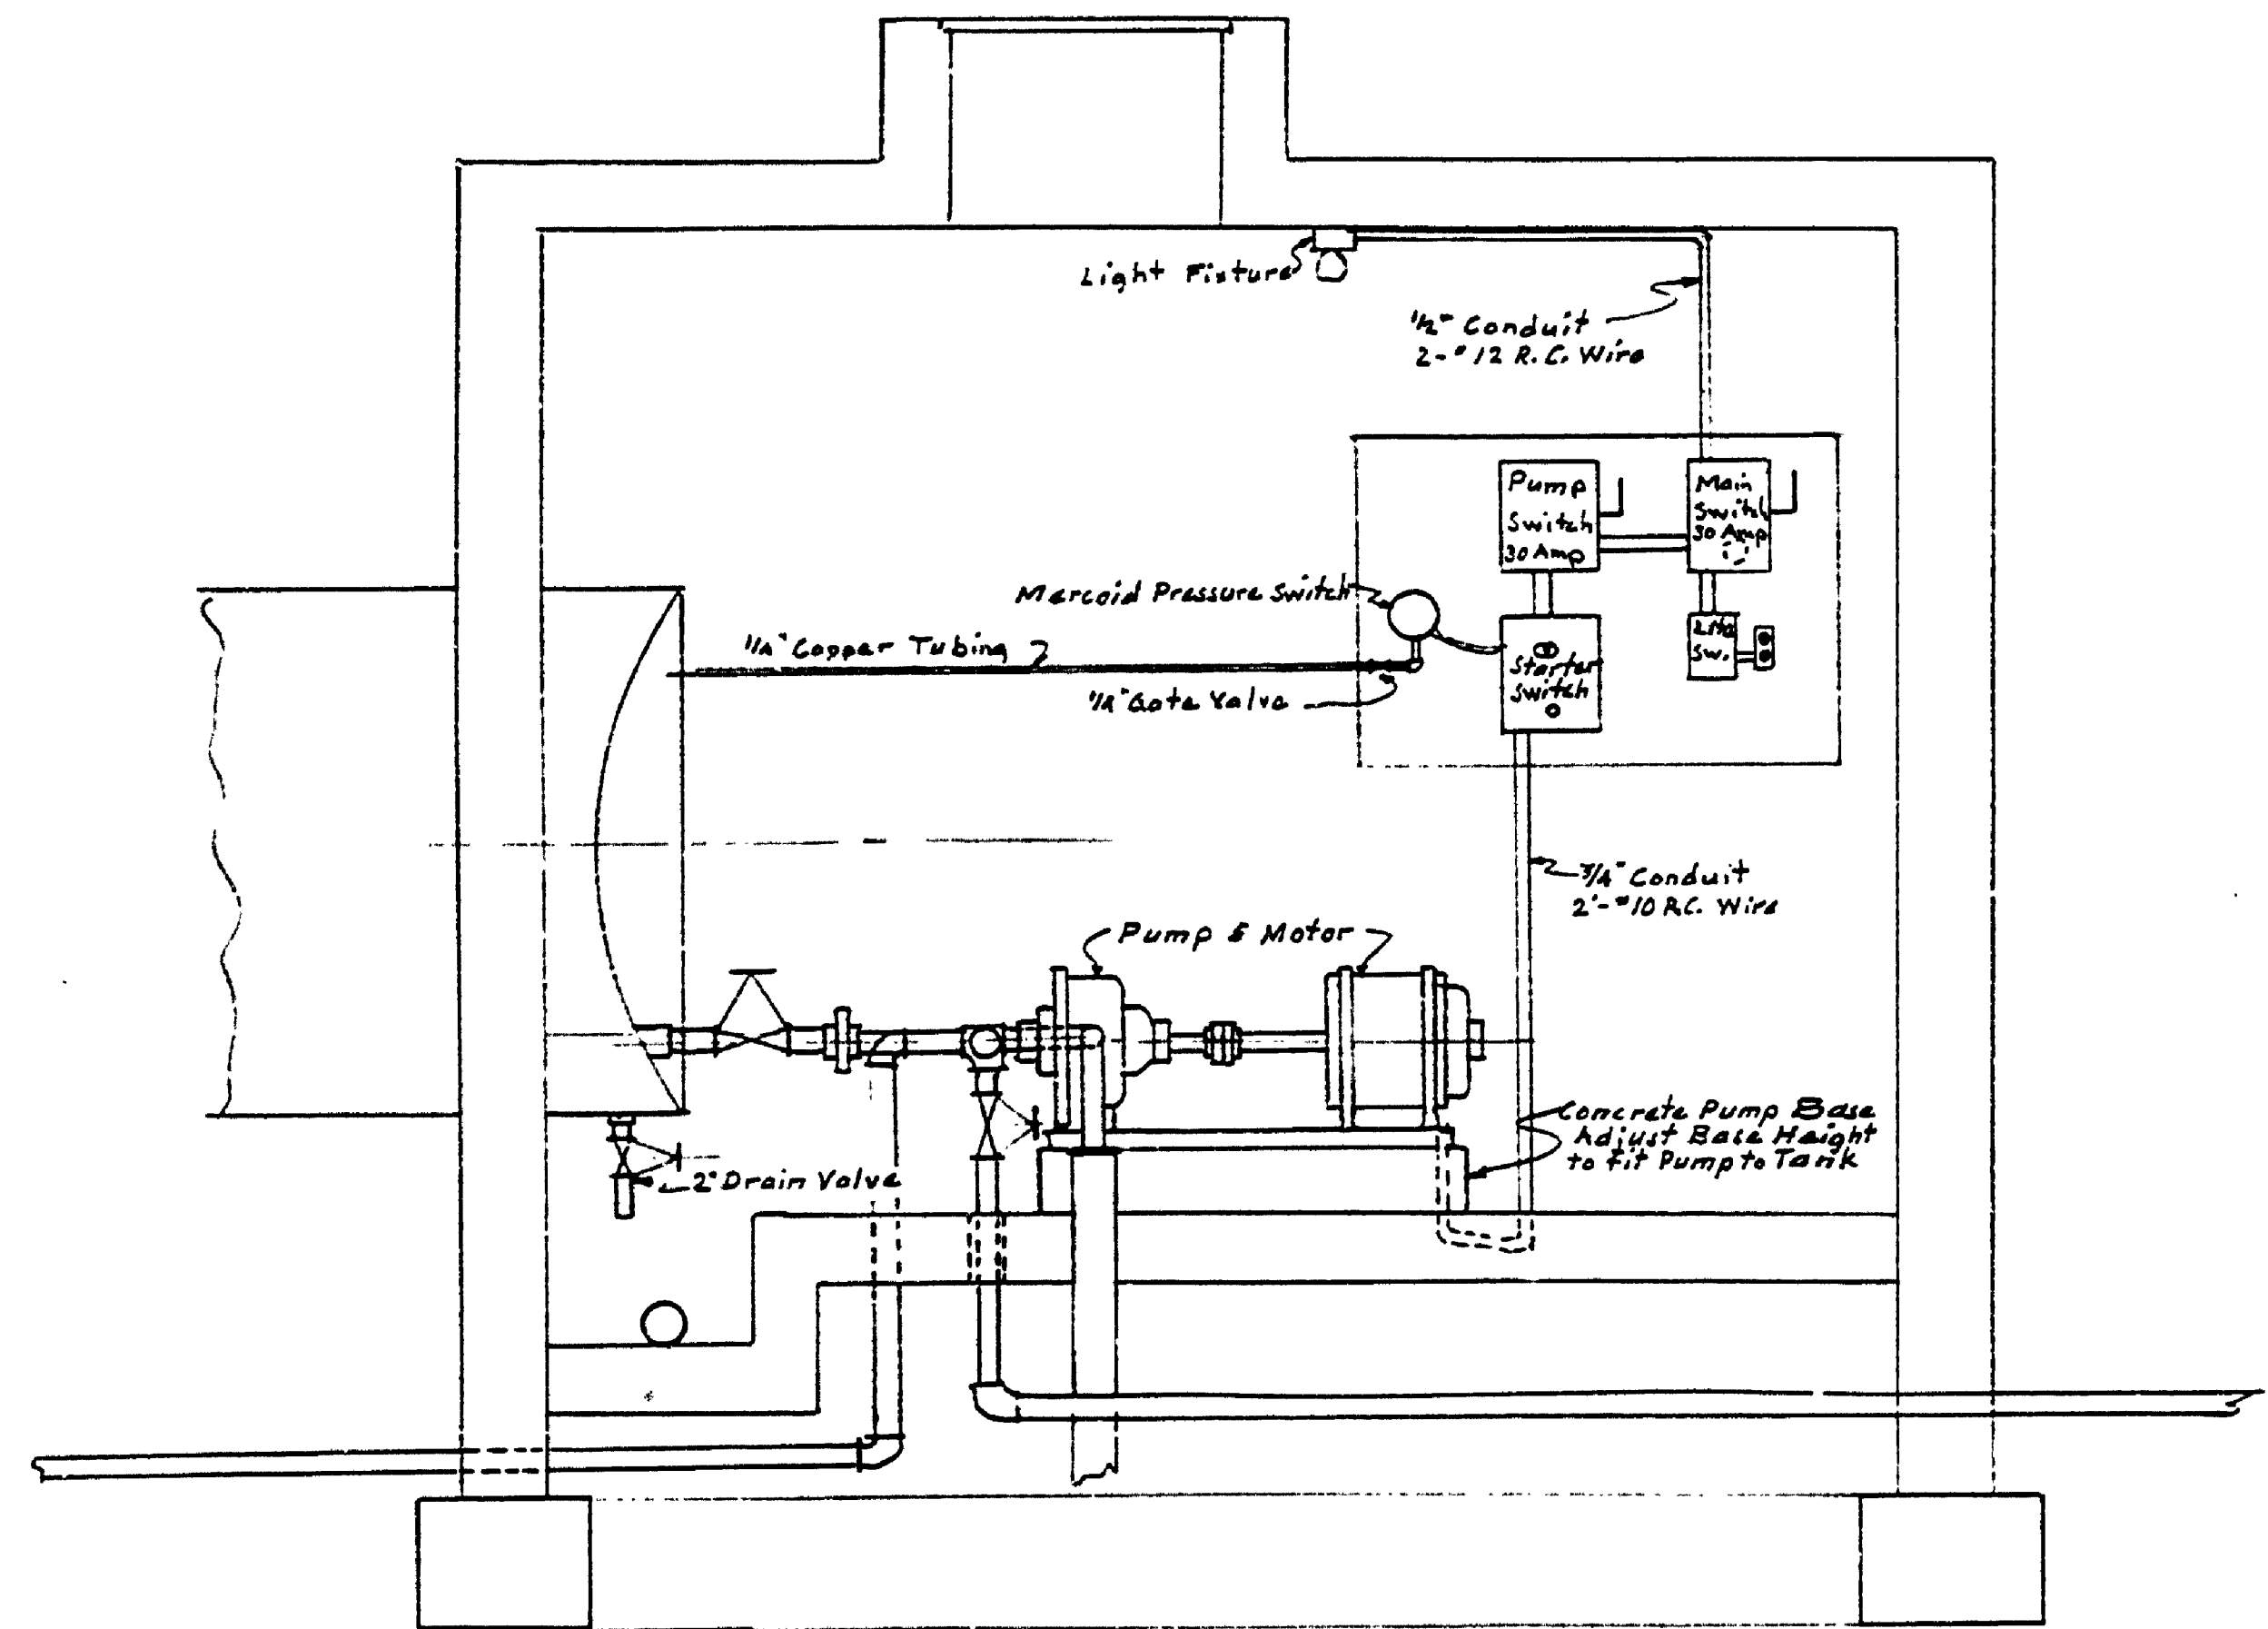

SECTION B-B
SCALE 3/4"=1'-0"

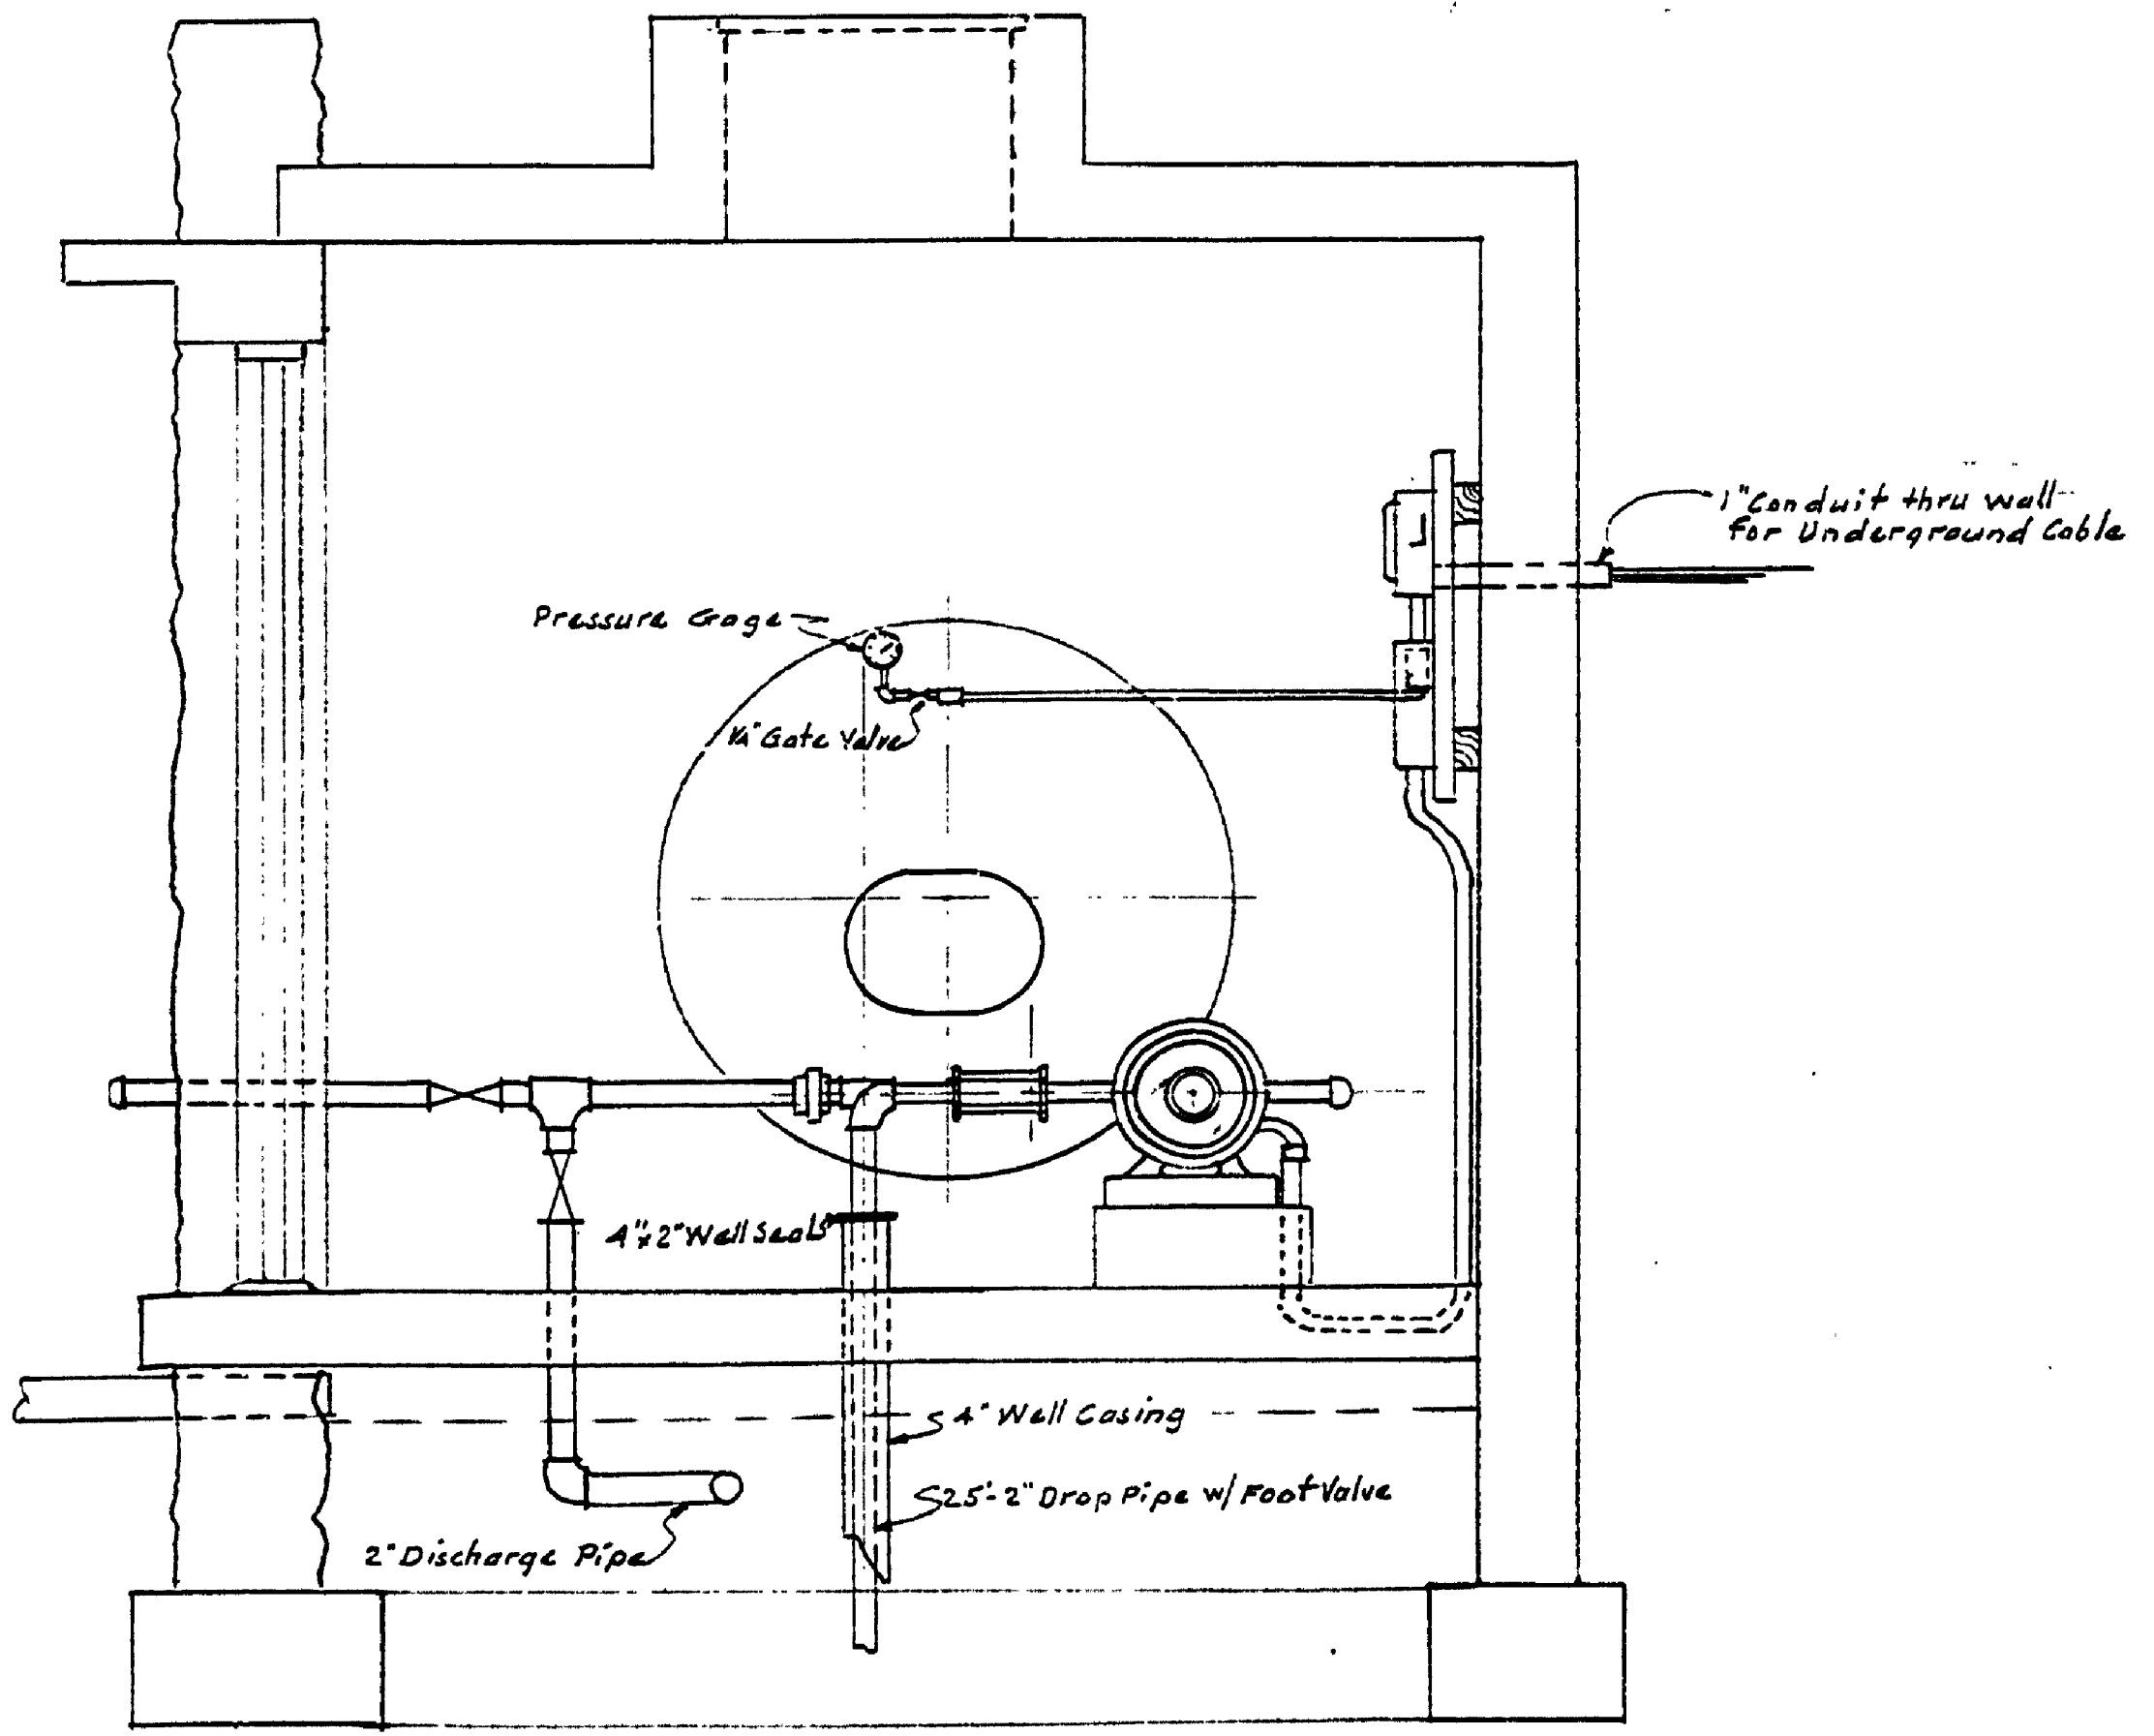

SECTION A-A
SCALE 3/4"=1'-0"

MECHANICAL DETAILS

MICHIGAN
DEPARTMENT OF CONSERVATION
PARKS AND RECREATION DIVISION

TAHUQUAMON FALLS STATE PARK
LOWER FALLS PICNIC AREA WATER
SCALE AS SHOWN

SHEET
NO. 2
OF 2
PLAN NO.
E-109