

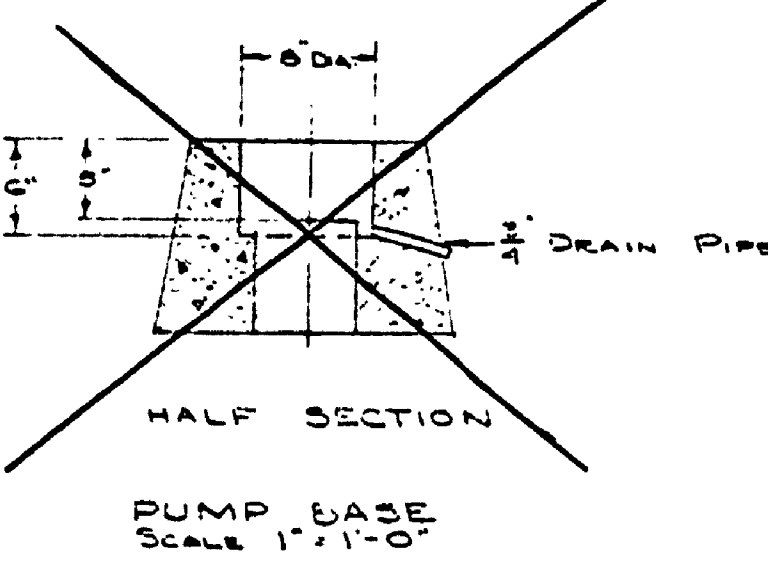
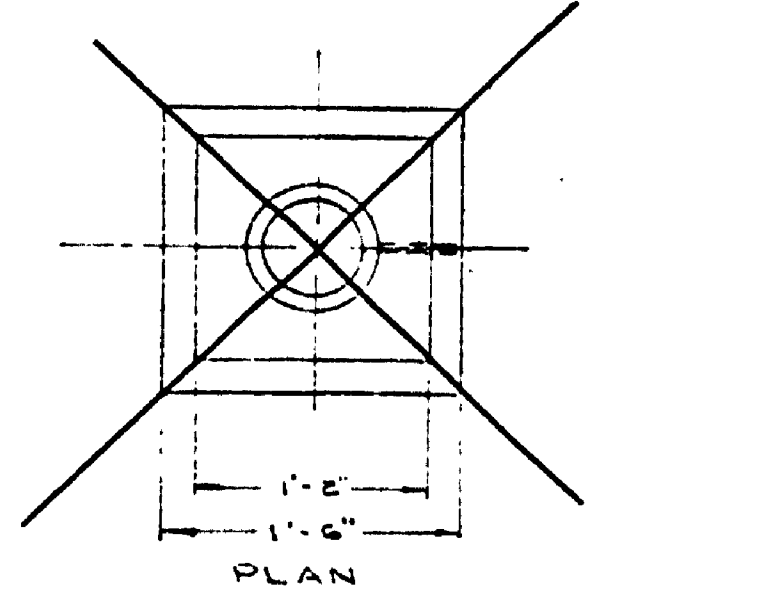
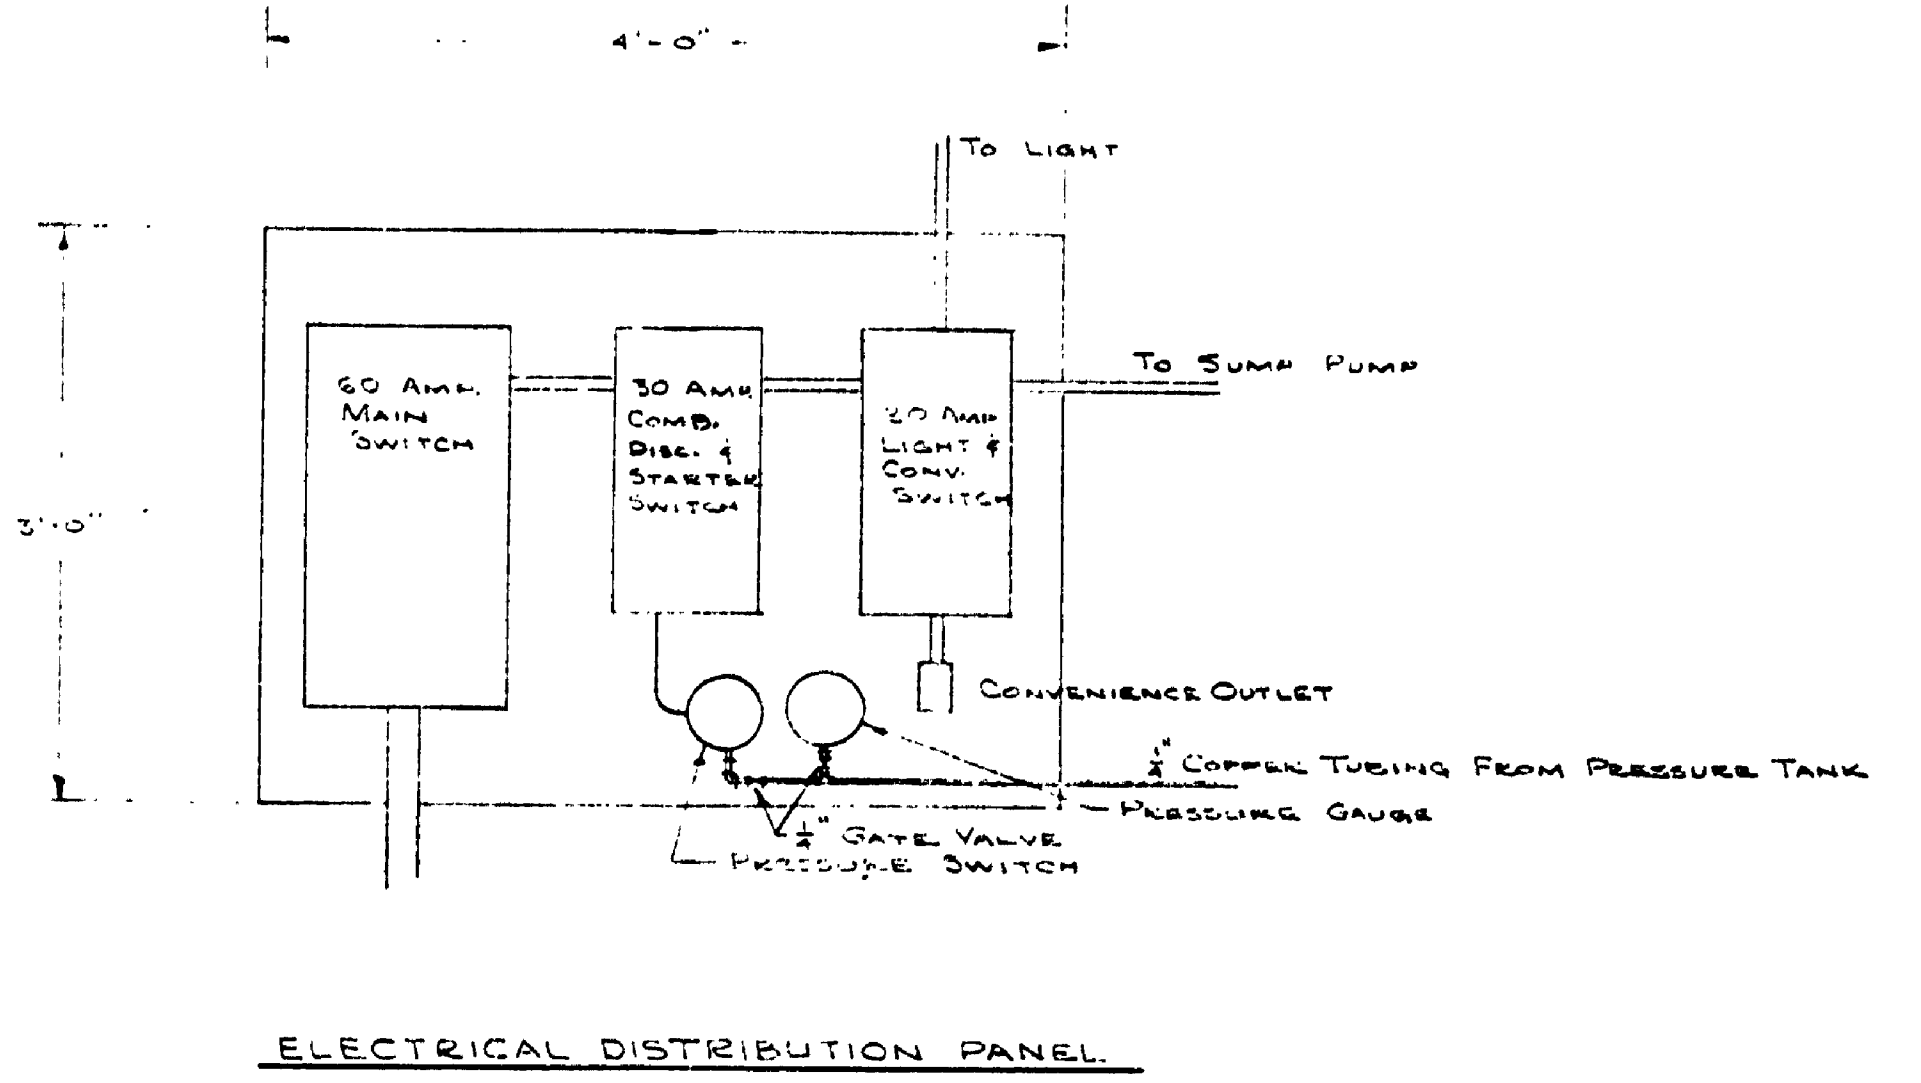
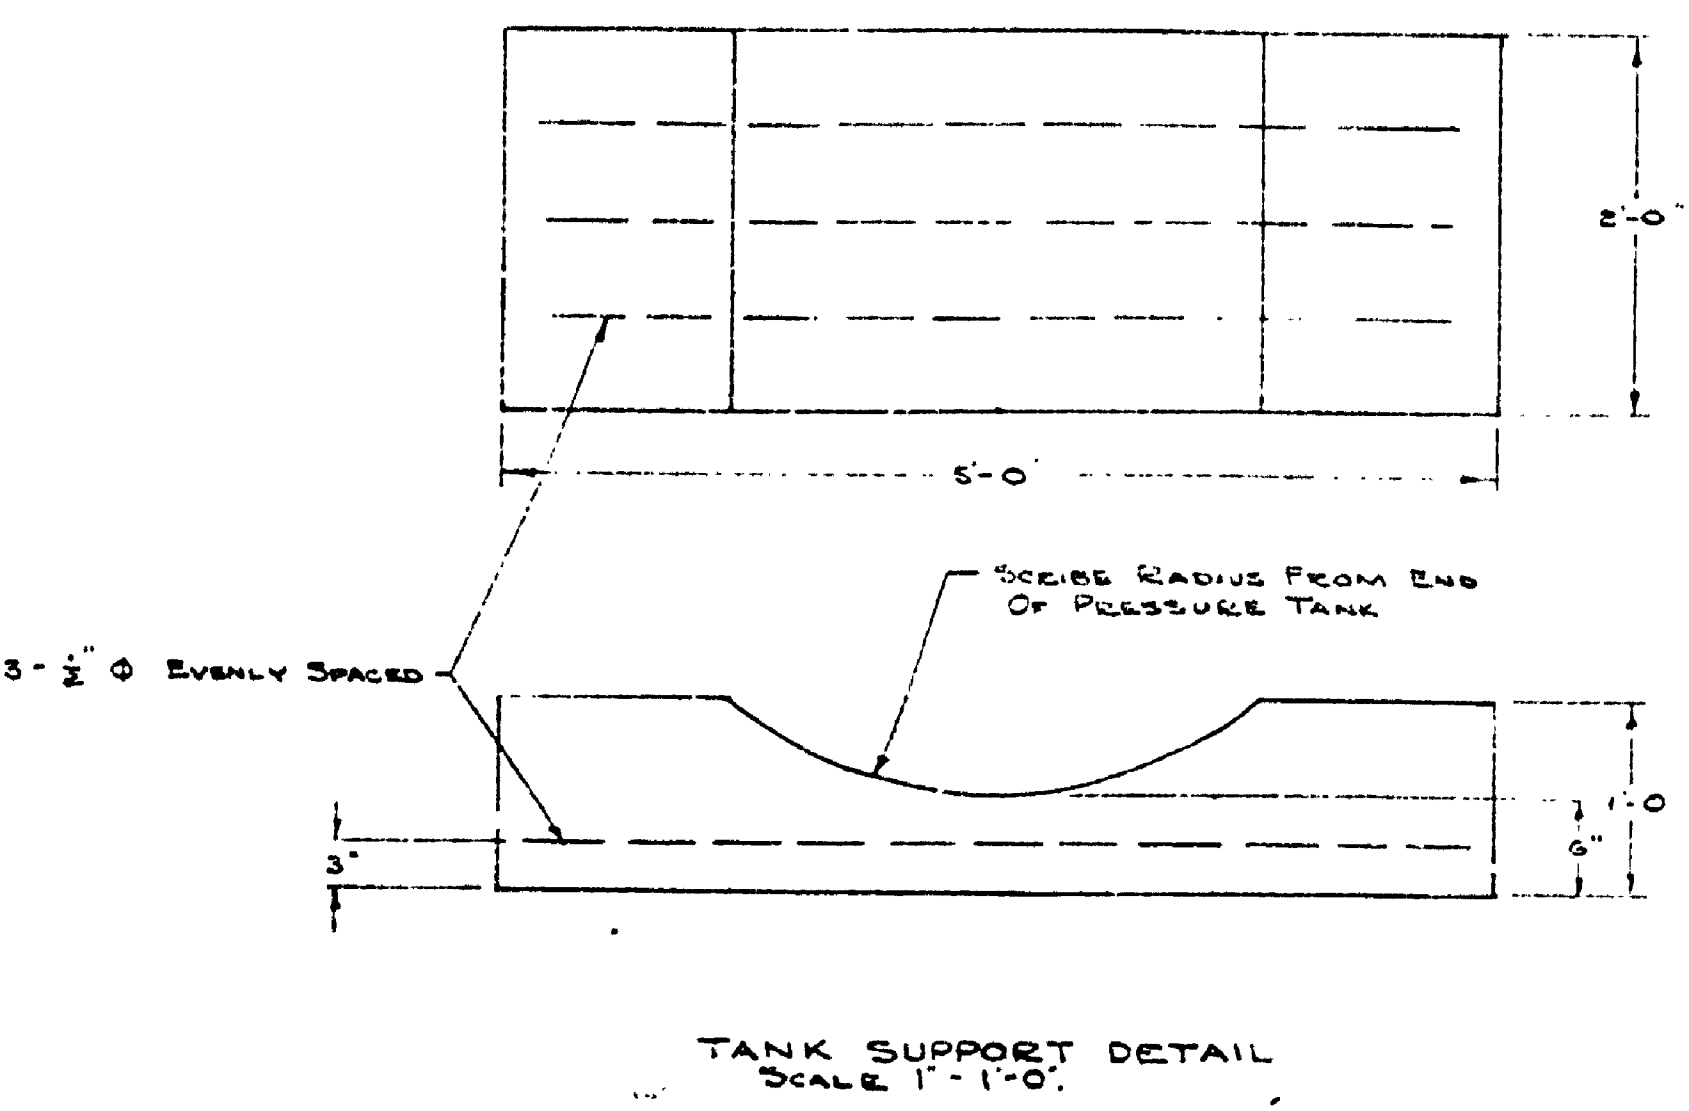
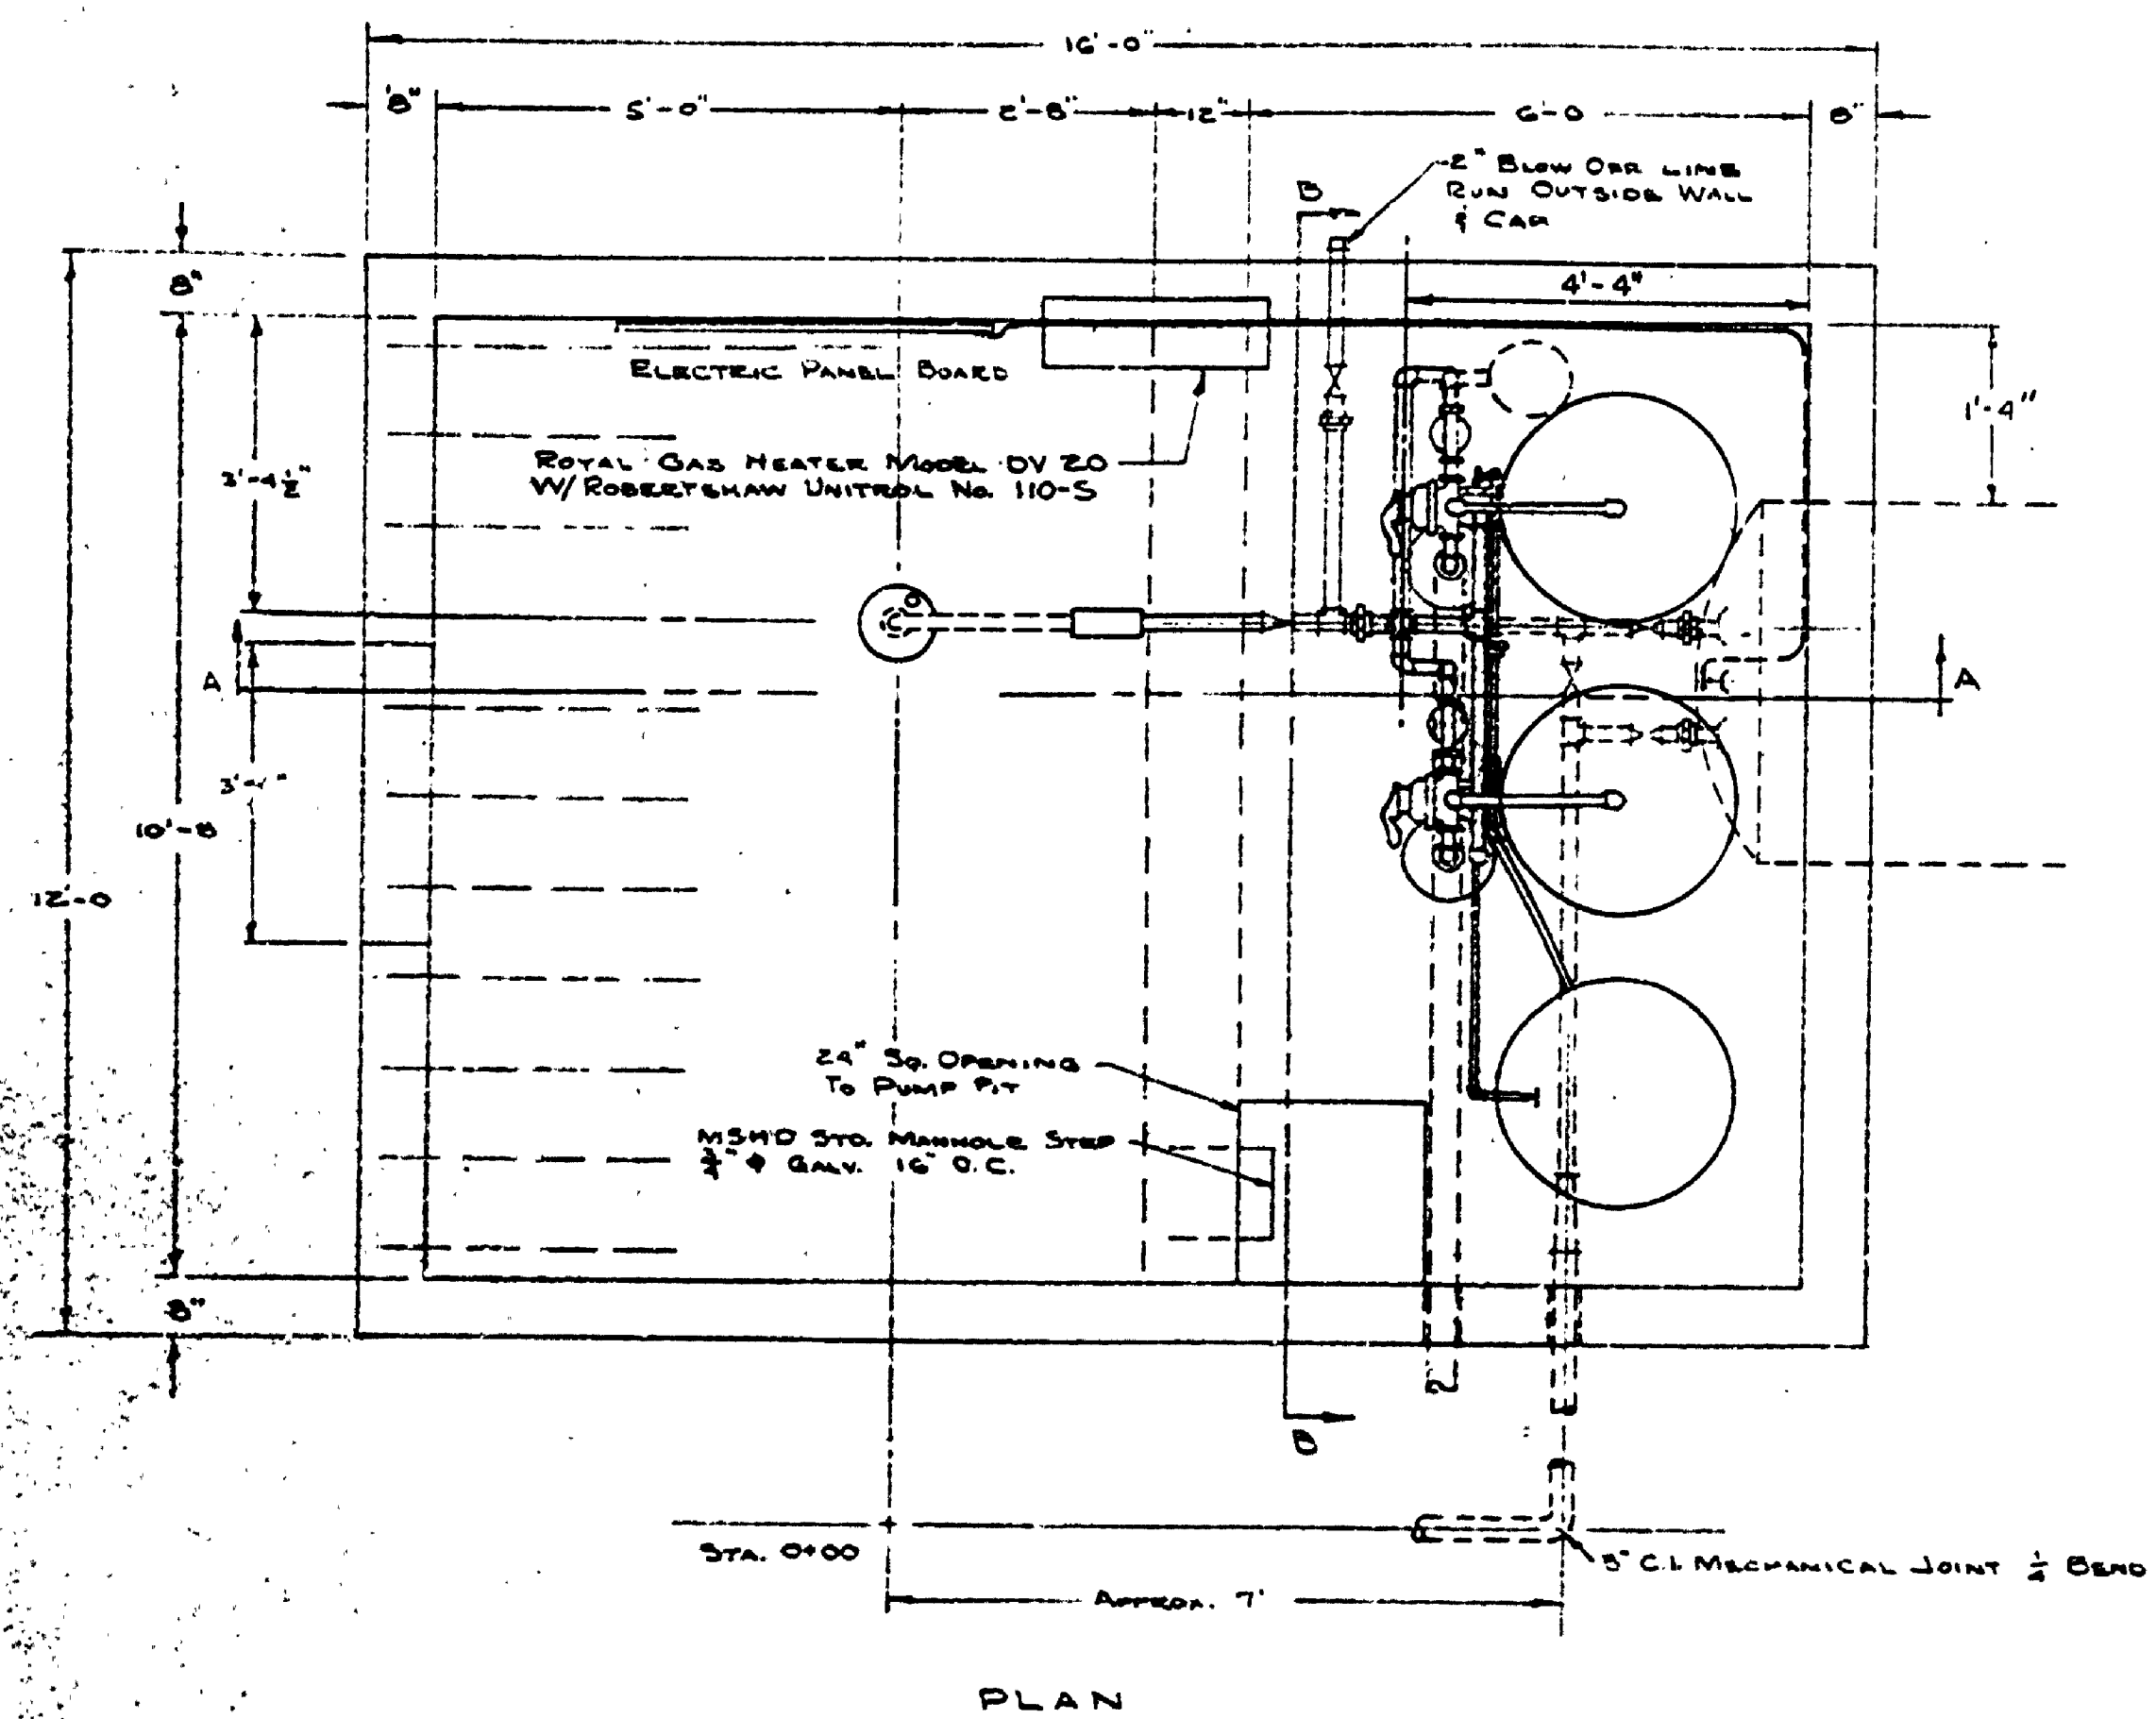


DATE	REVIEWED	DATE	APPROVED	DATE	NO.	DATE	BY	REVISIONS
11-21-51	W.J.F.	11-21-51		1	1	11/21/51	W.J.F.	1
12-1-51	J. VERA	12-1-51		2	2	12/1/51	J. VERA	2
12-1-51	C.S.P.	12-1-51		3	3	12/1/51	C.S.P.	3
12-1-51	LANDSCAPE	12-1-51		4	4	12/1/51	LANDSCAPE	4
				5	5			5
				6	6			6

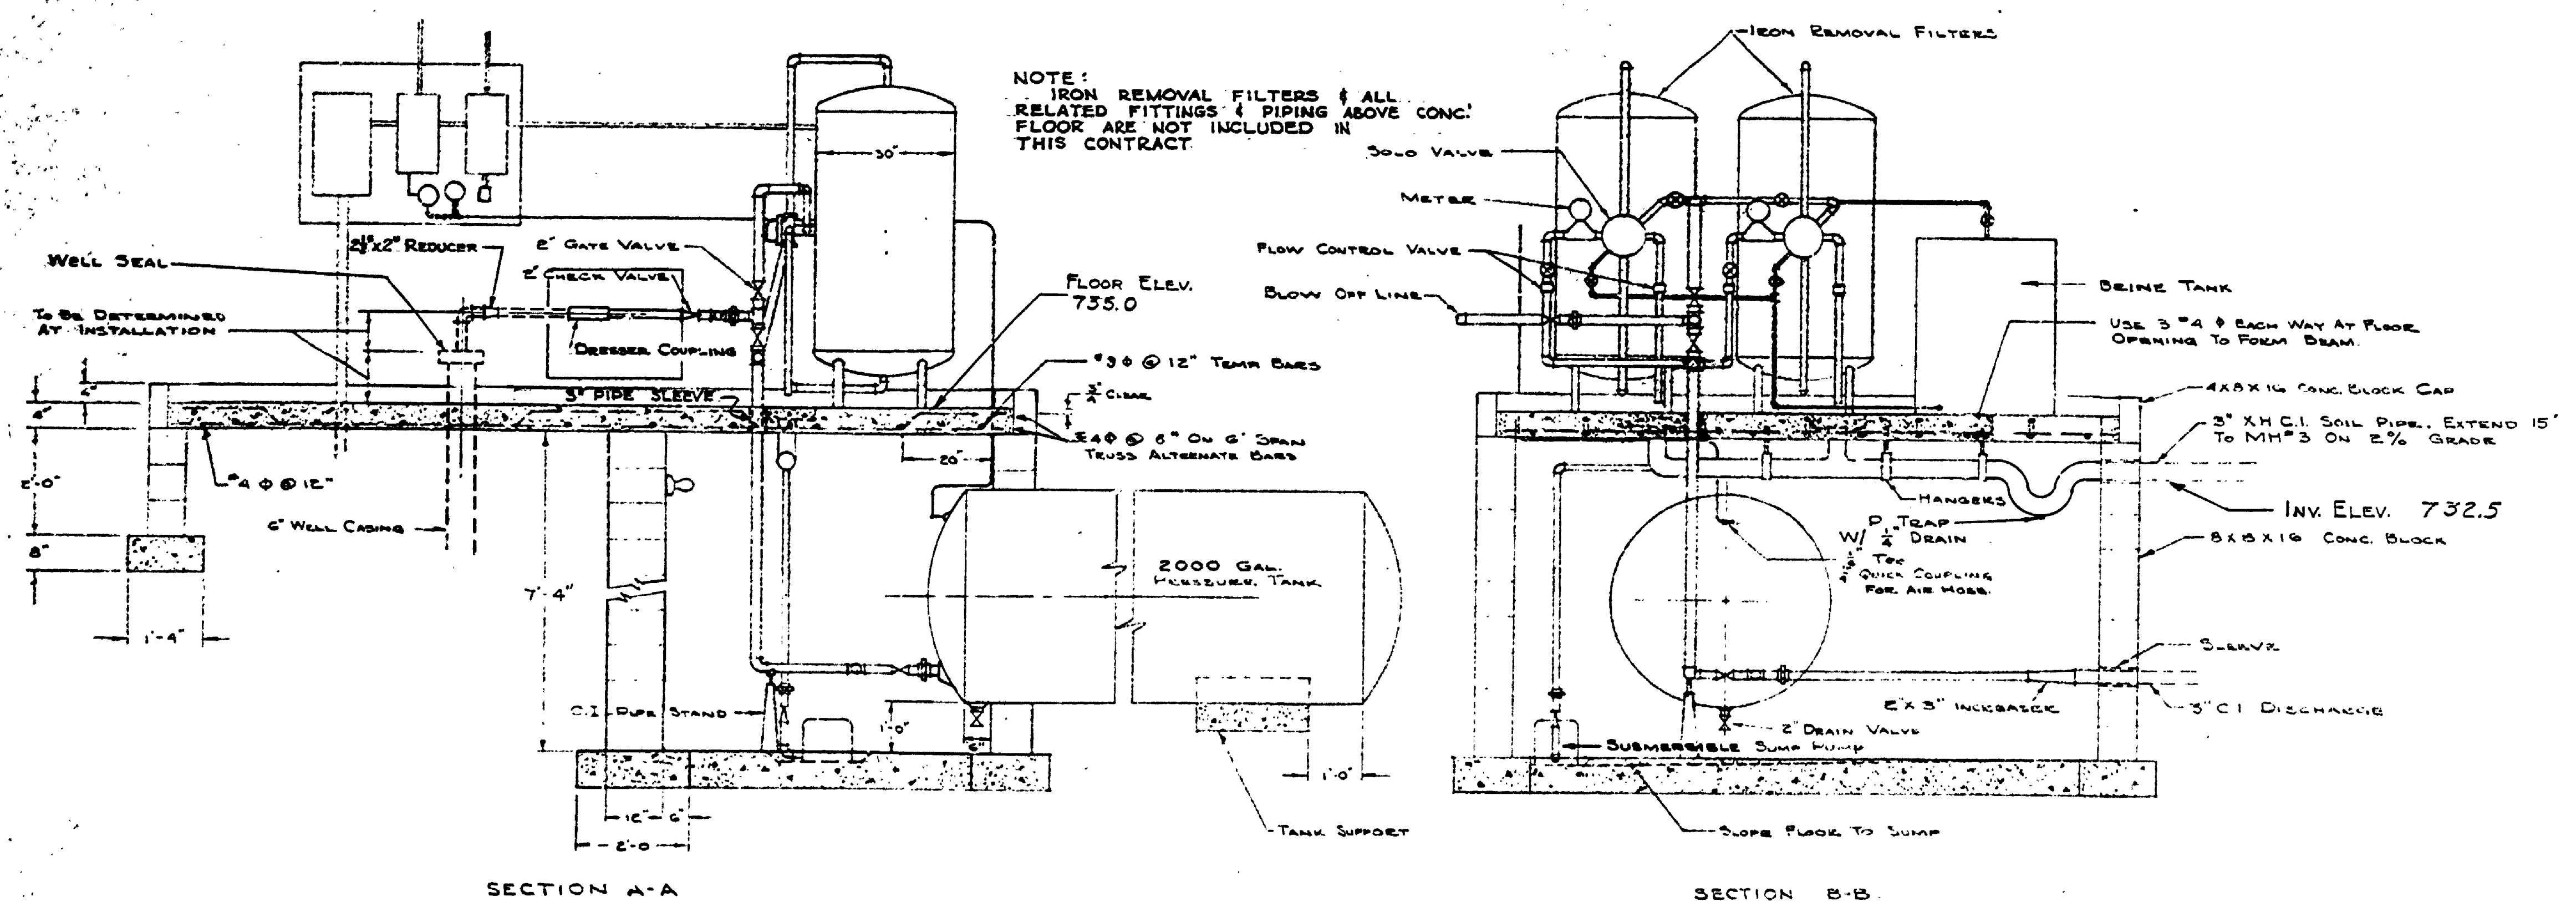

~~NOTE: DUMP PUMPING 2\"/>~~

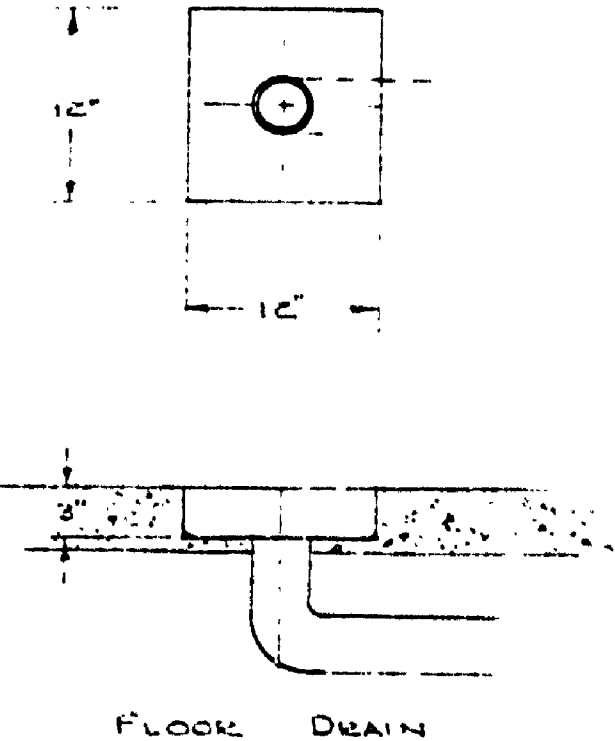

NOTE: IRON REMOVAL FILTERS & ALL RELATED FITTINGS & PIPING ABOVE CONC. FLOOR ARE NOT INCLUDED IN THIS CONTRACT.

PUMPHOUSE PIPING AND FOUNDATION PLAN

MICHIGAN DEPARTMENT OF CONSERVATION PARKS AND RECREATION DIVISION

TAHOUMENON FALLS STATE PARK LOWER FALLS CAMPGROUND WATER DISTRIBUTION SYSTEM

SHEET NO. 13 OF 18

PLAN NO. E-117