




DESIGNED BY	REVIEWED	DATE	APPROVED	DATE	NO.	DATE BY	REVISIONS	DATE BY
DRAWN BY	ARCHITECTURAL				1		4	
CHECKED BY	ENGINEERING				2		5	
	LANDSCAPE				3		6	

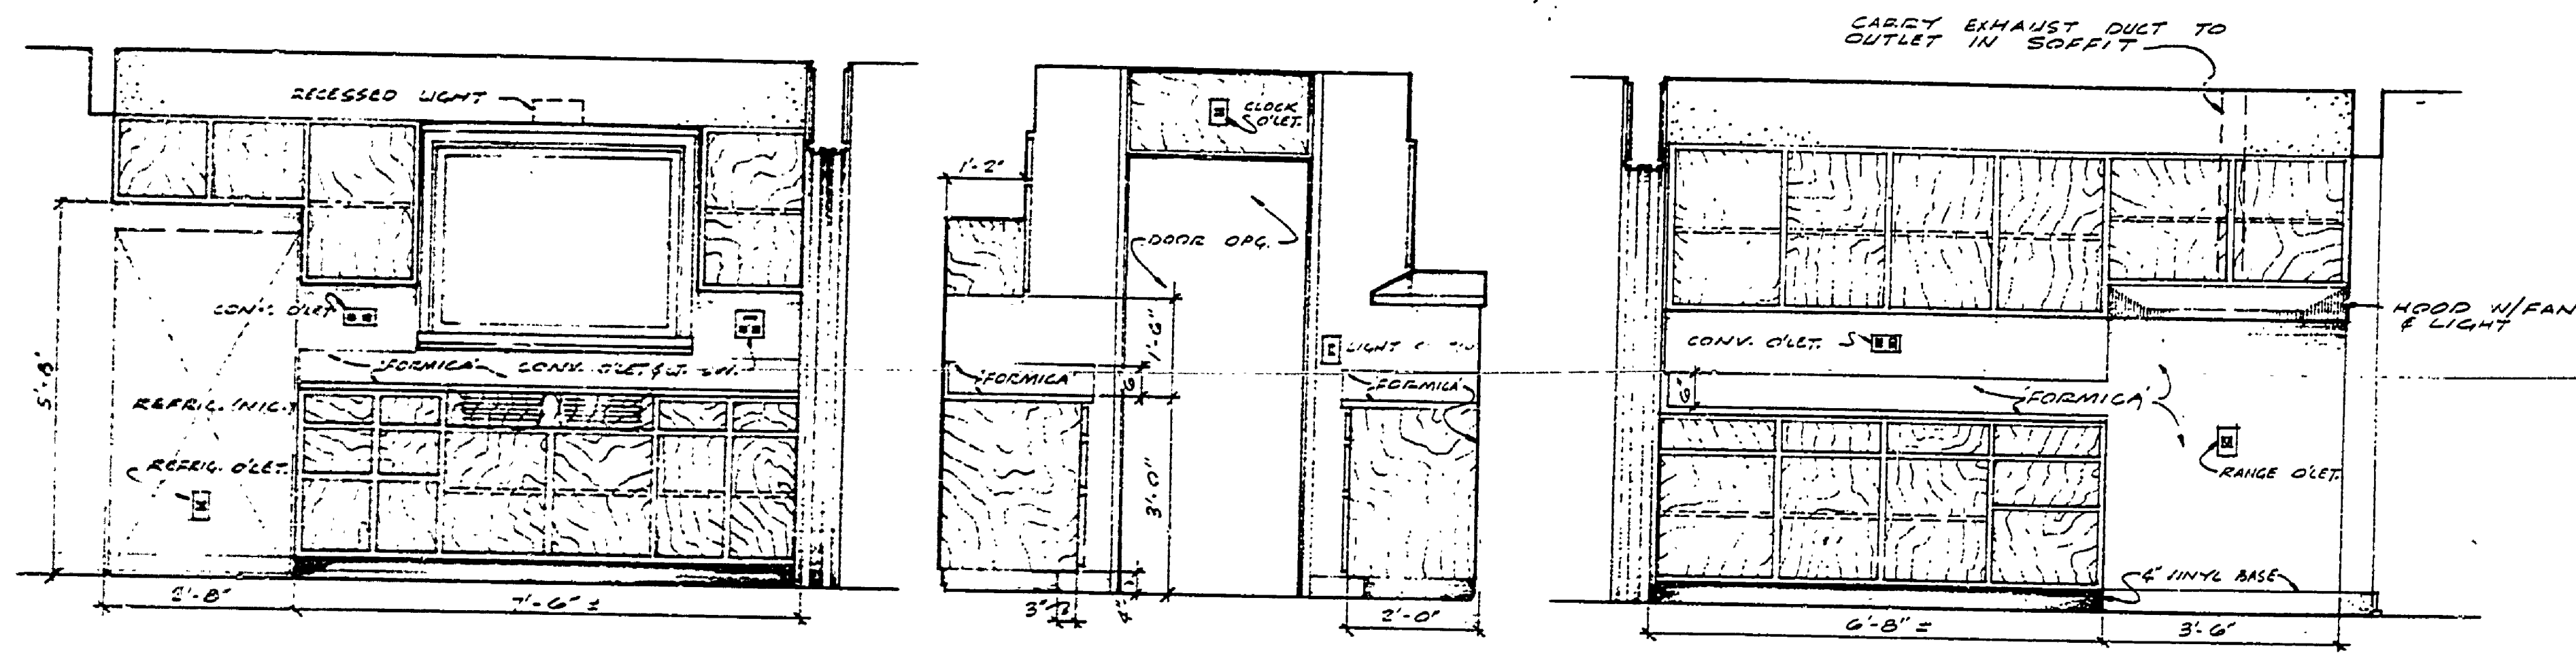


KITCHEN CASES
SCALE = 1/2" = 1'-0"

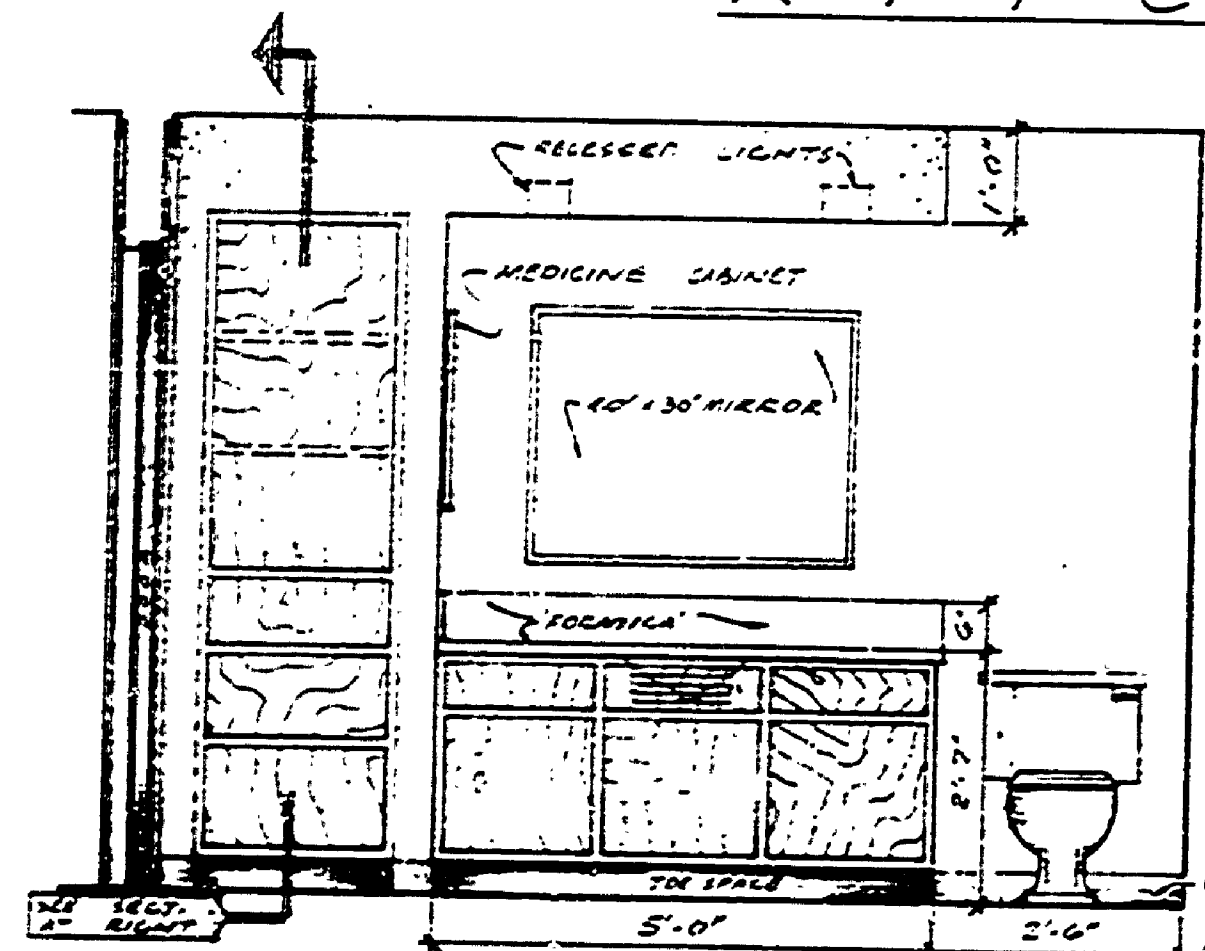

ELEVATION - BATHROOM
SCALE = 1/2" = 1'-0"

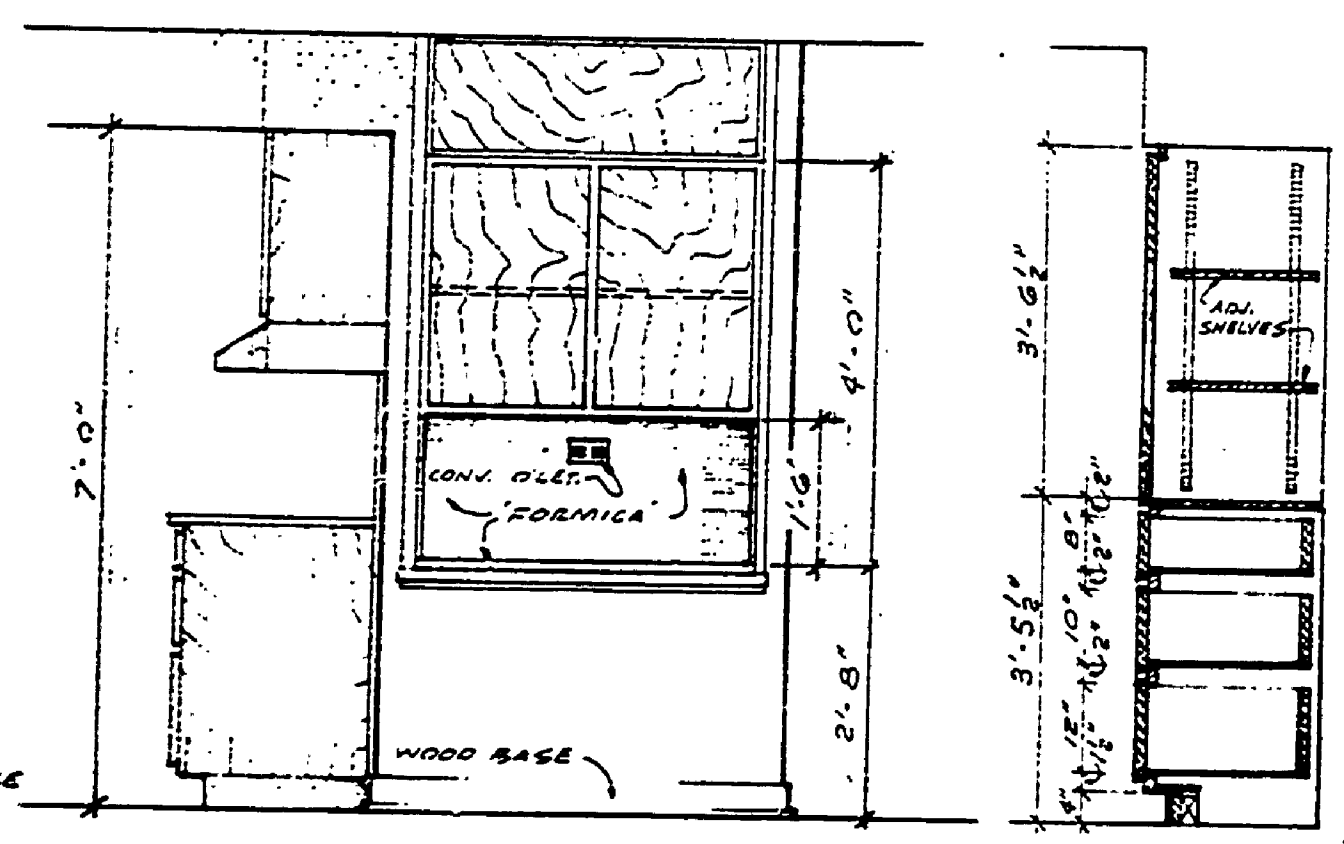


ELEV. - CHINA CAB. (IN DINING RM.) SCALE = 1/2" = 1'-0"
SECT. - LINEN SCALE = 1/2" = 1'-0"

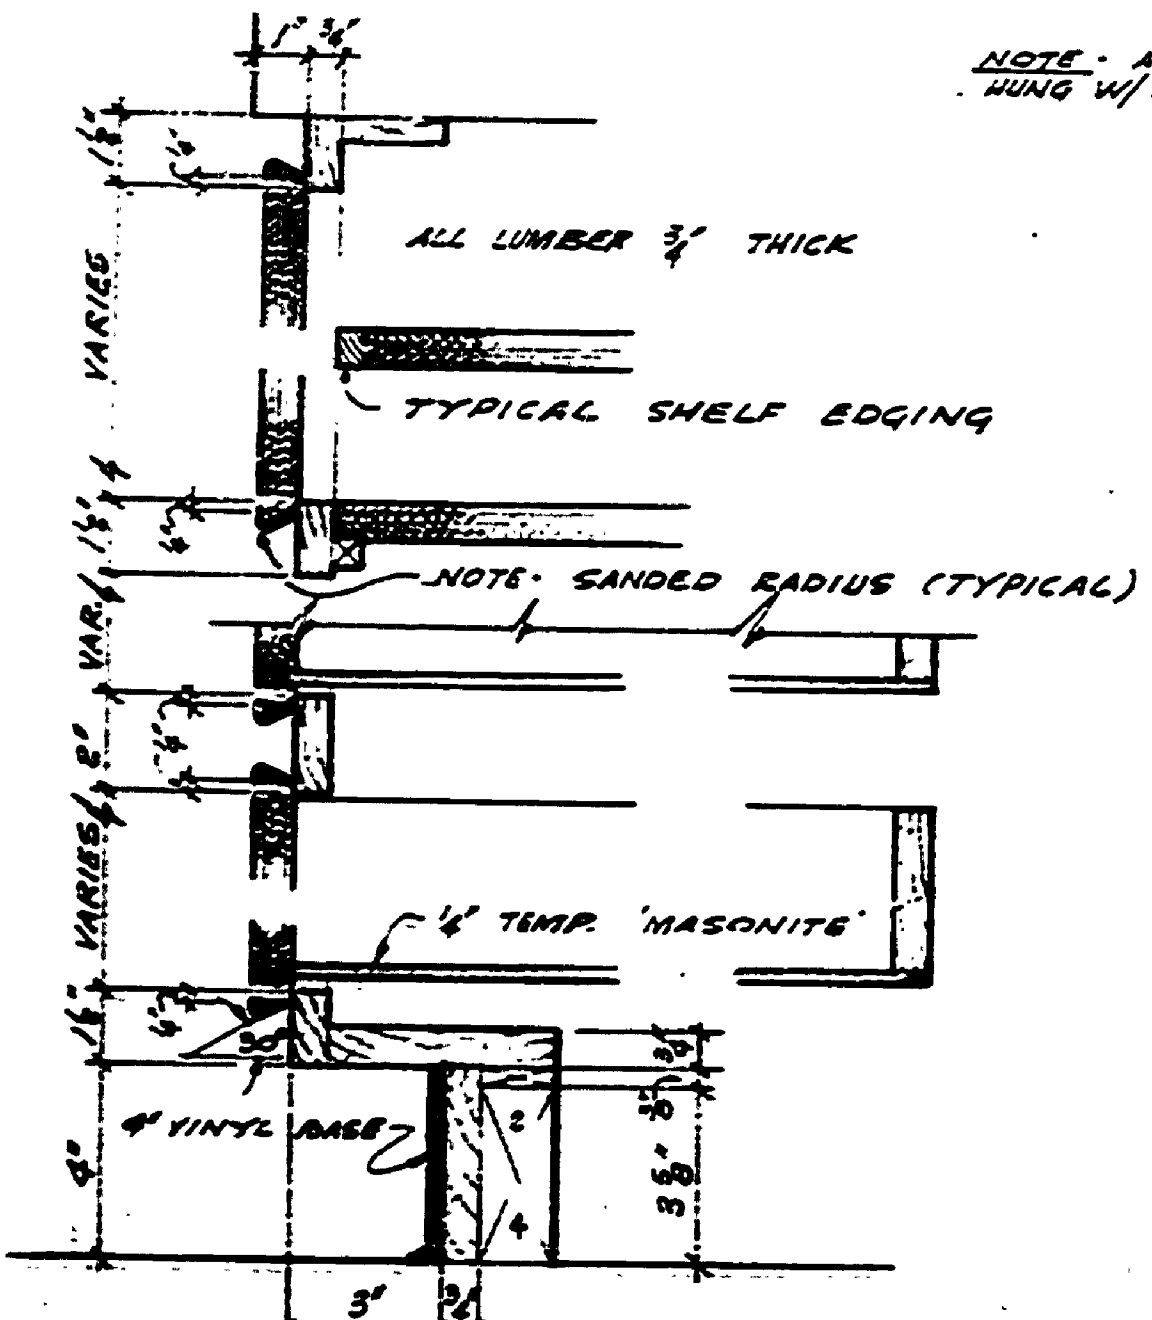


CABINET DETAILS
SCALE = 5/8" = 1'-0"


NOTE: ALL DRAWERS TO BE HUNG W/ EXTENSION SLIDES (SEE SPEC.)

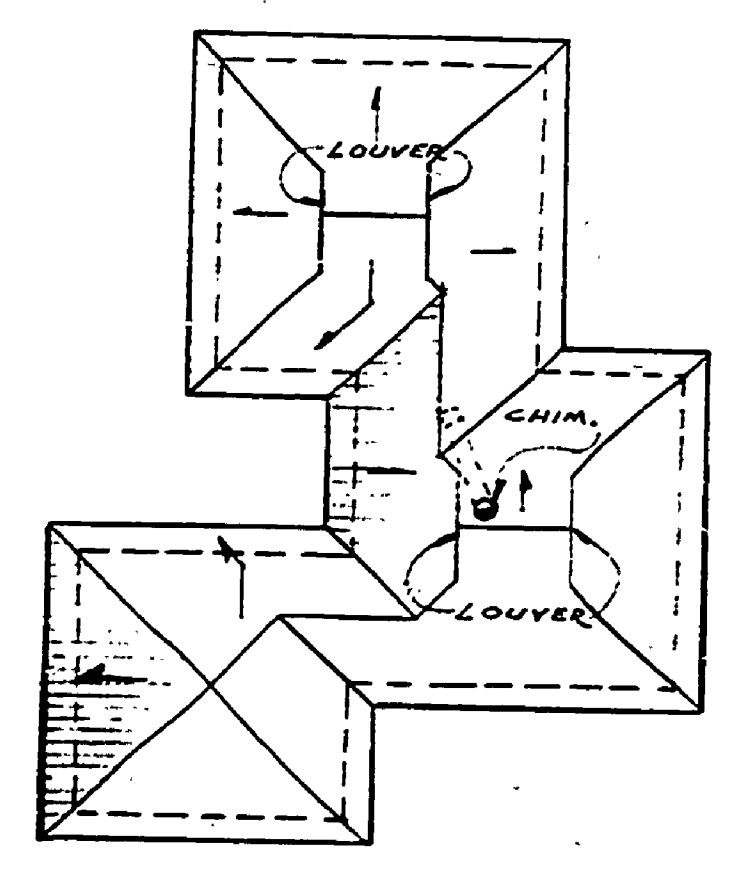

ROOF PLAN

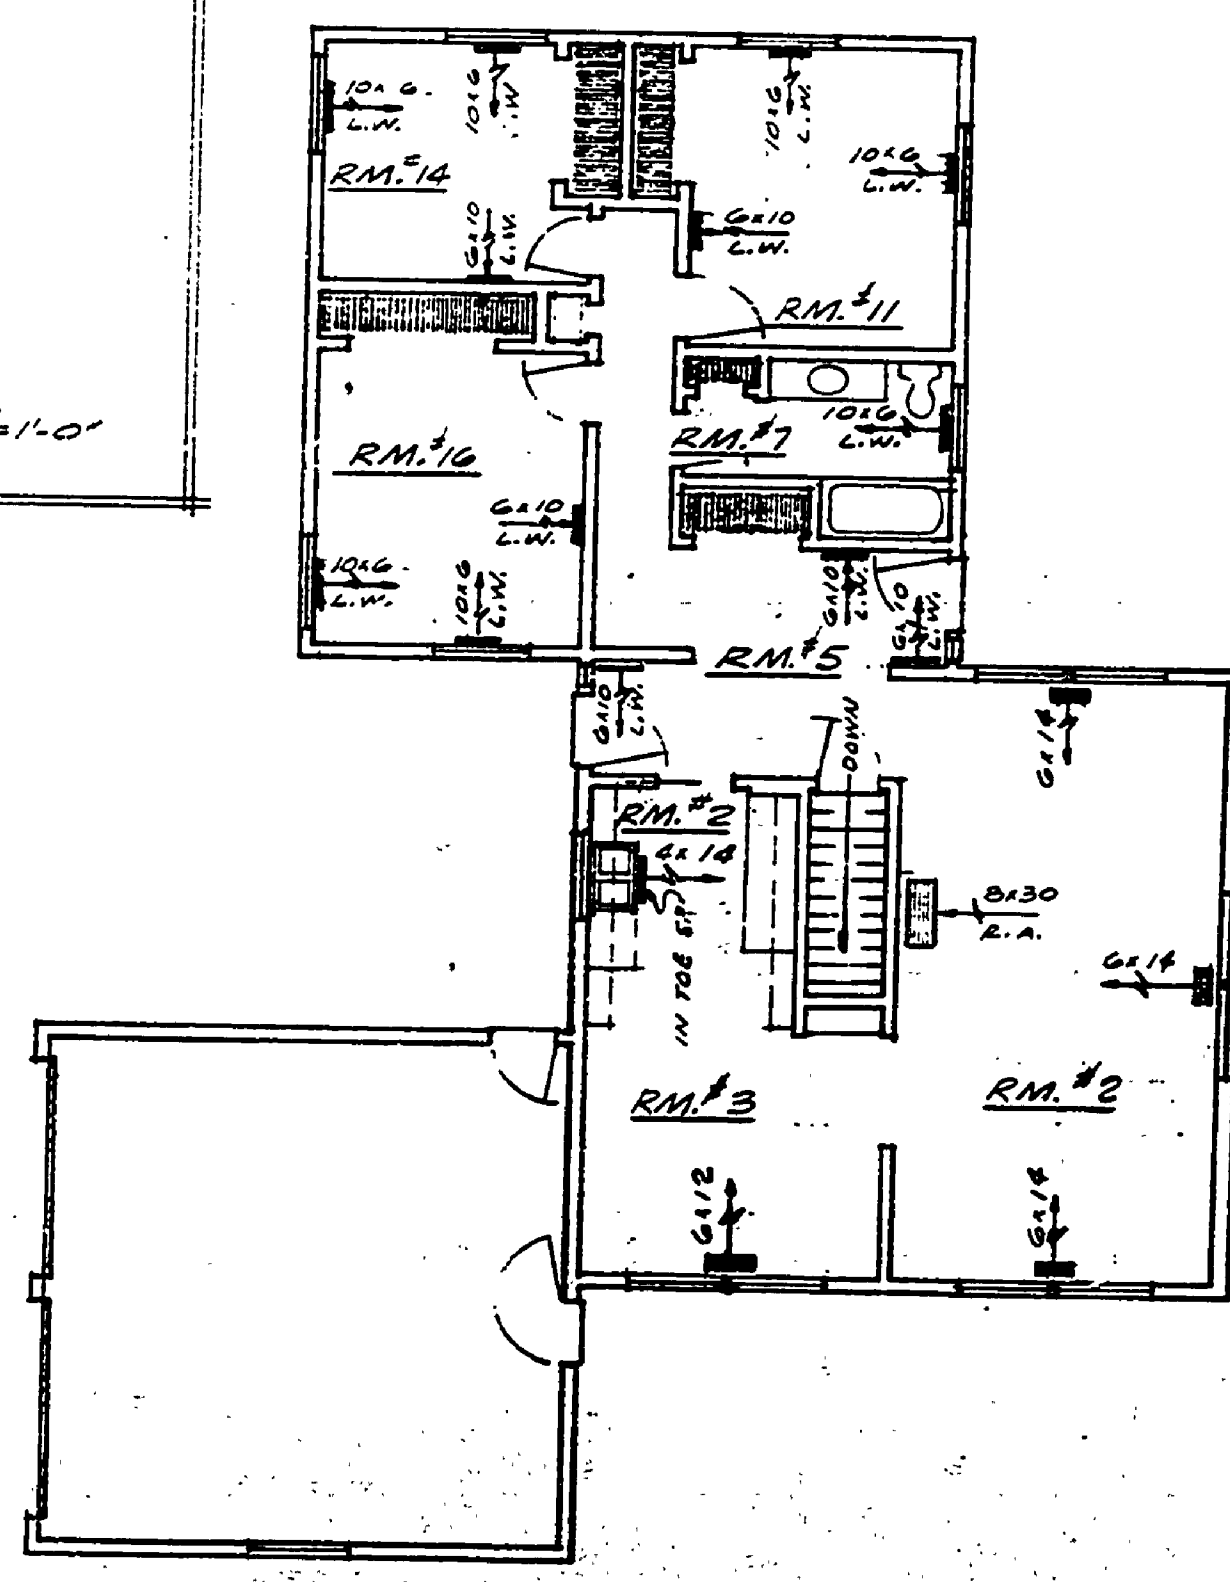

HEATING - FIRST FL. PLAN
SCALE = 1/8" = 1'-0"

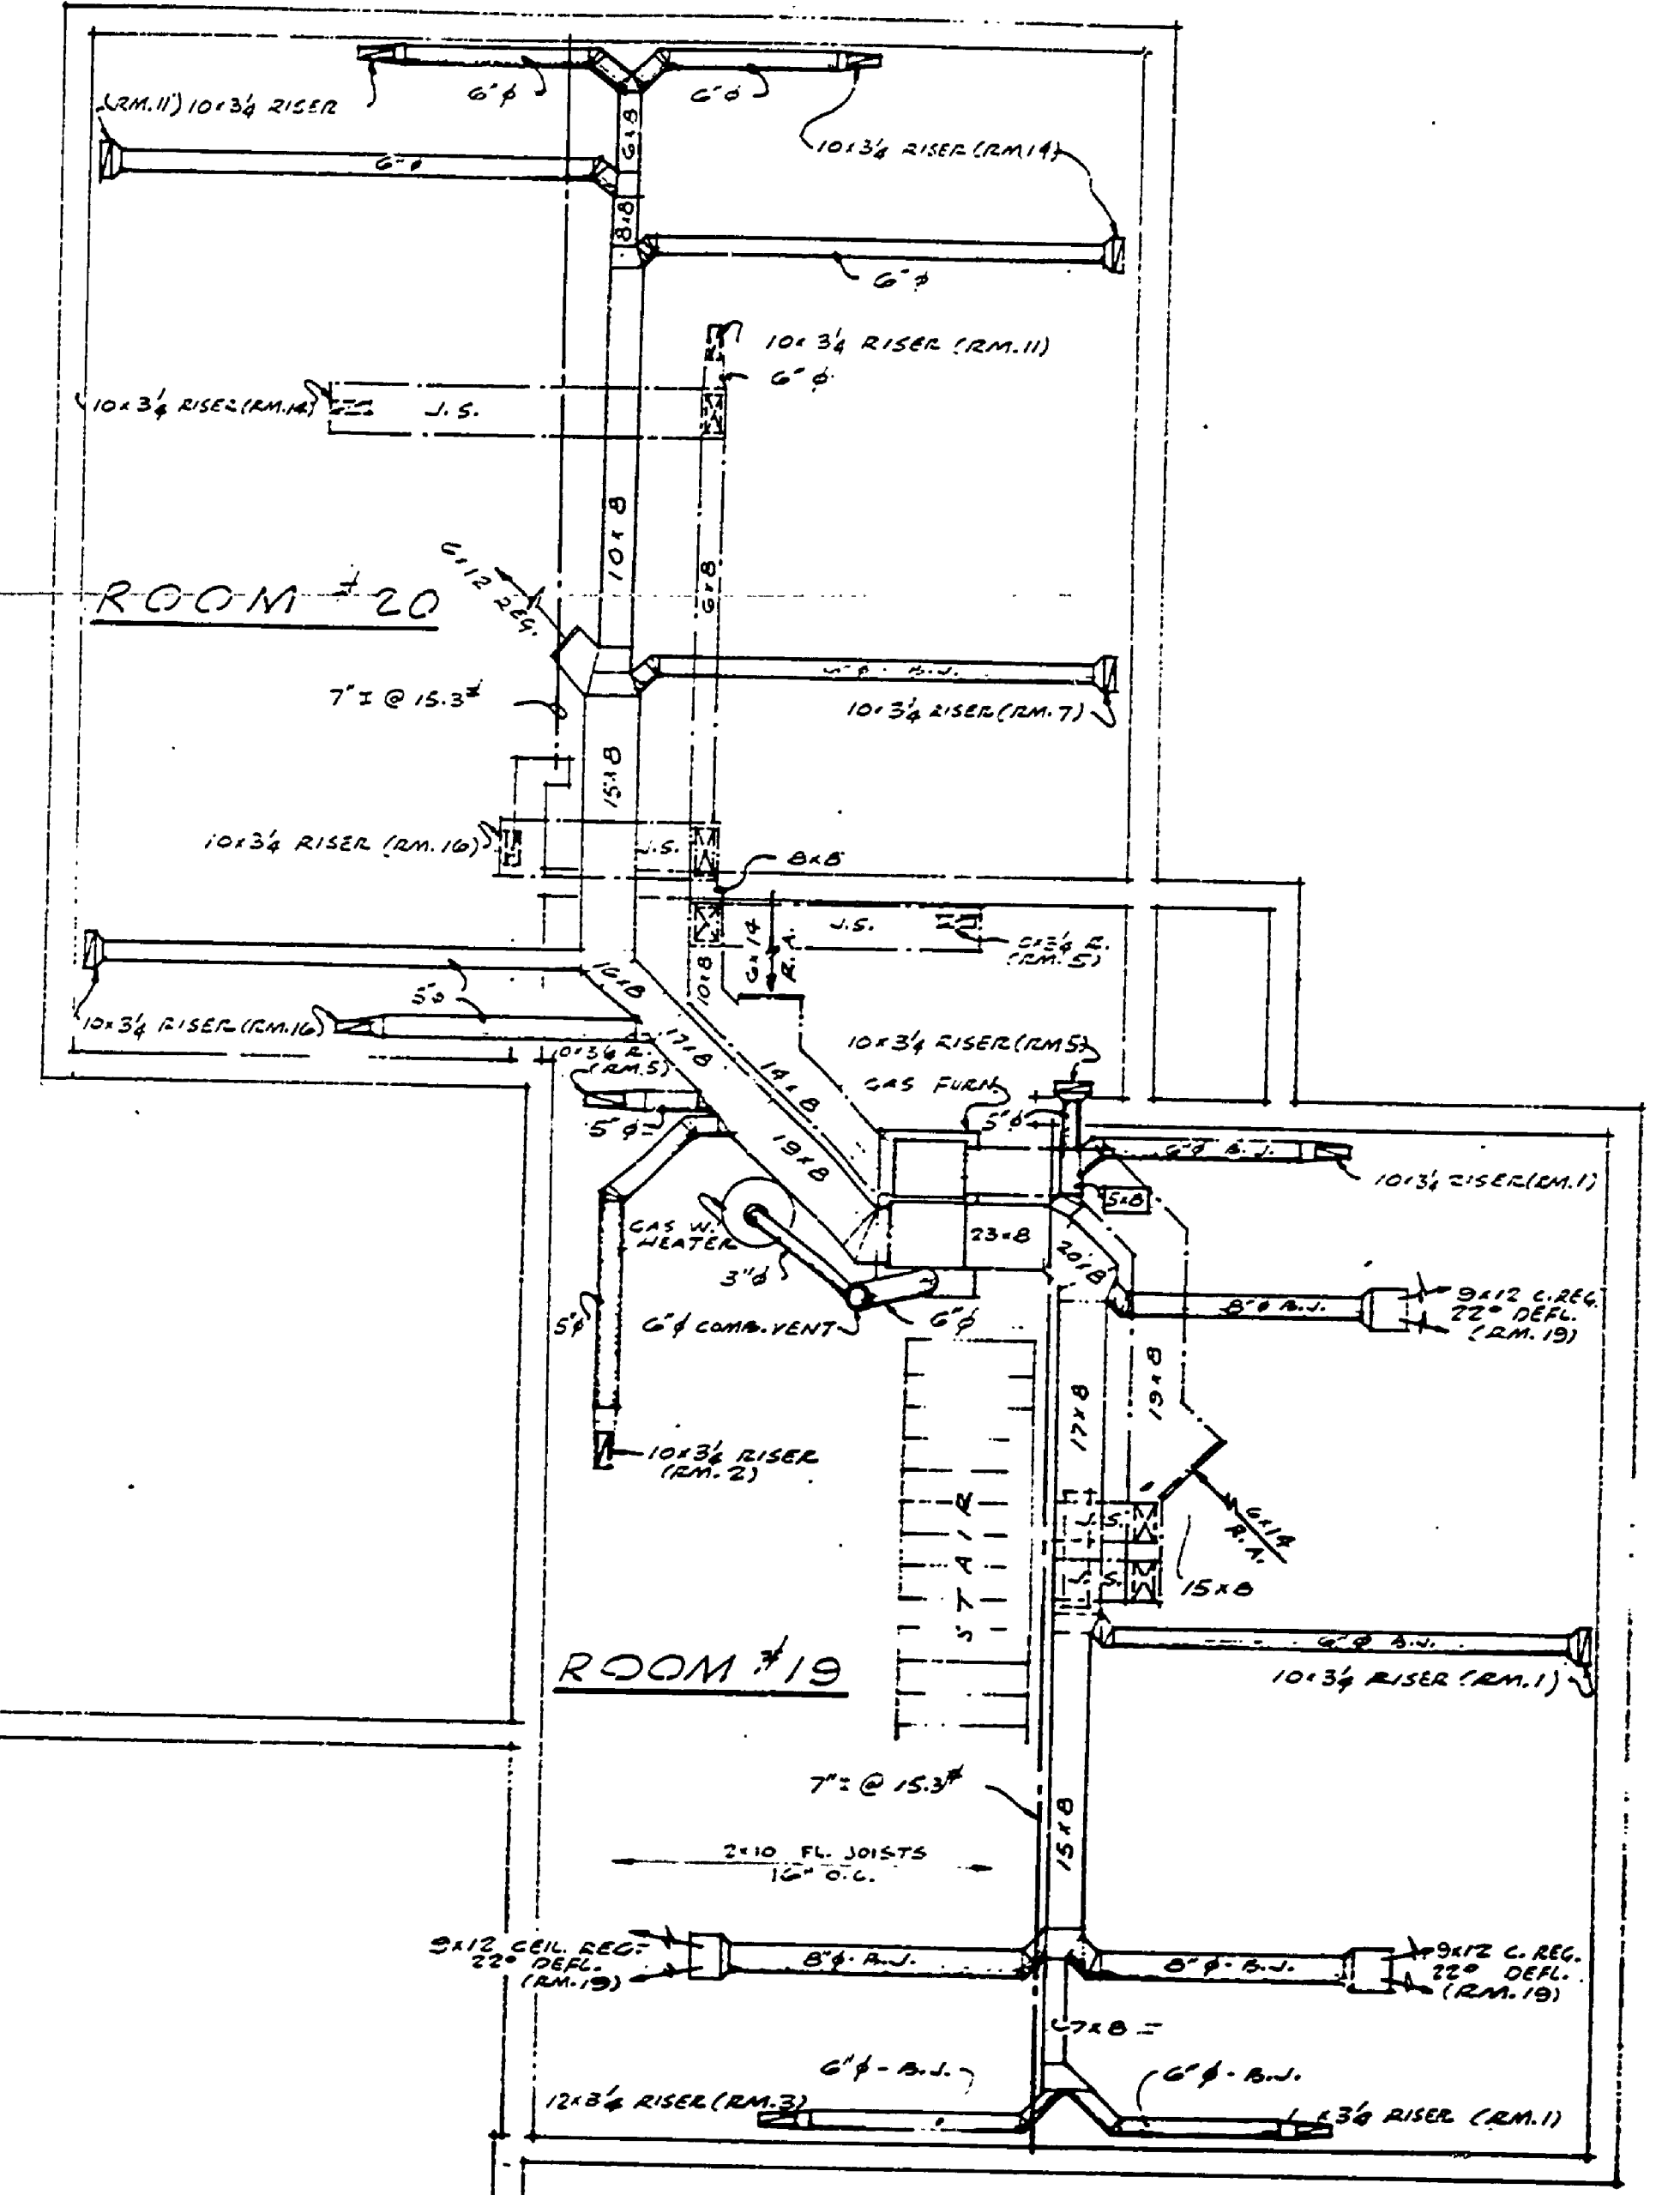

HEATING PLAN - BASEMENT
SCALE = 1/8" = 1'-0"

SYMBOLS & ABBREVIATIONS

WARM AIR	RISER	DUCT	REGISTER	FLOOR REGISTER	L.W. - LOW WALL	CLG. - CEILING
RETURN AIR	RISER	DUCT	INTAKE	DUCT CONNECTION BELOW JOIST	R.A. - RETURN AIR	L.W. - LOW WALL

R.A. - DUCT BETWEEN JOISTS
L.W. - JOIST SPACE USED AS RETURN DUCT