




DESIGNED BY	DATE	REVIEWED	DATE	APPROVED	DATE	NO.	DATE	BY	REVISIONS	DATE	BY
W. N. G.		ARCHITECTURAL				1		W. N. G.	4		
DRAWN BY		ENGINEERING				2		W. N. G.	5		
CHECKED BY		LANDSCAPE				3		W. N. G.	6		

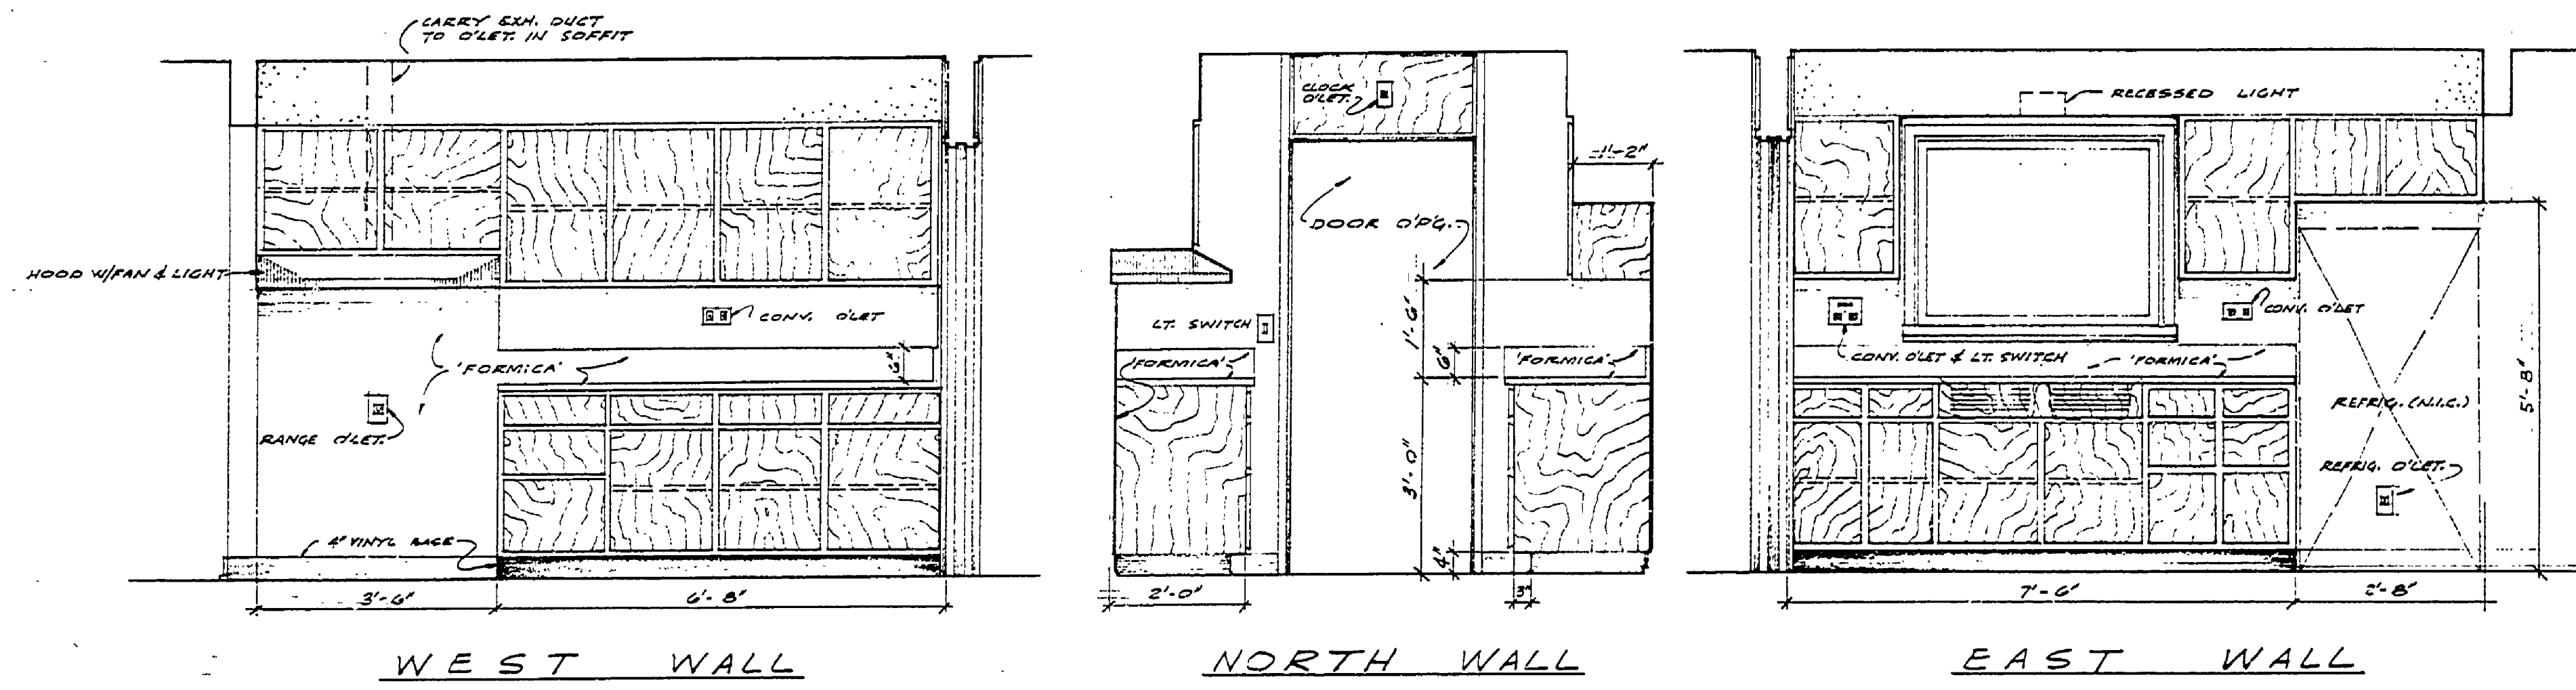

WEST WALL NORTH WALL EAST WALL  
KITCHEN CASES  
SCALE - 1/2" = 1'-0"

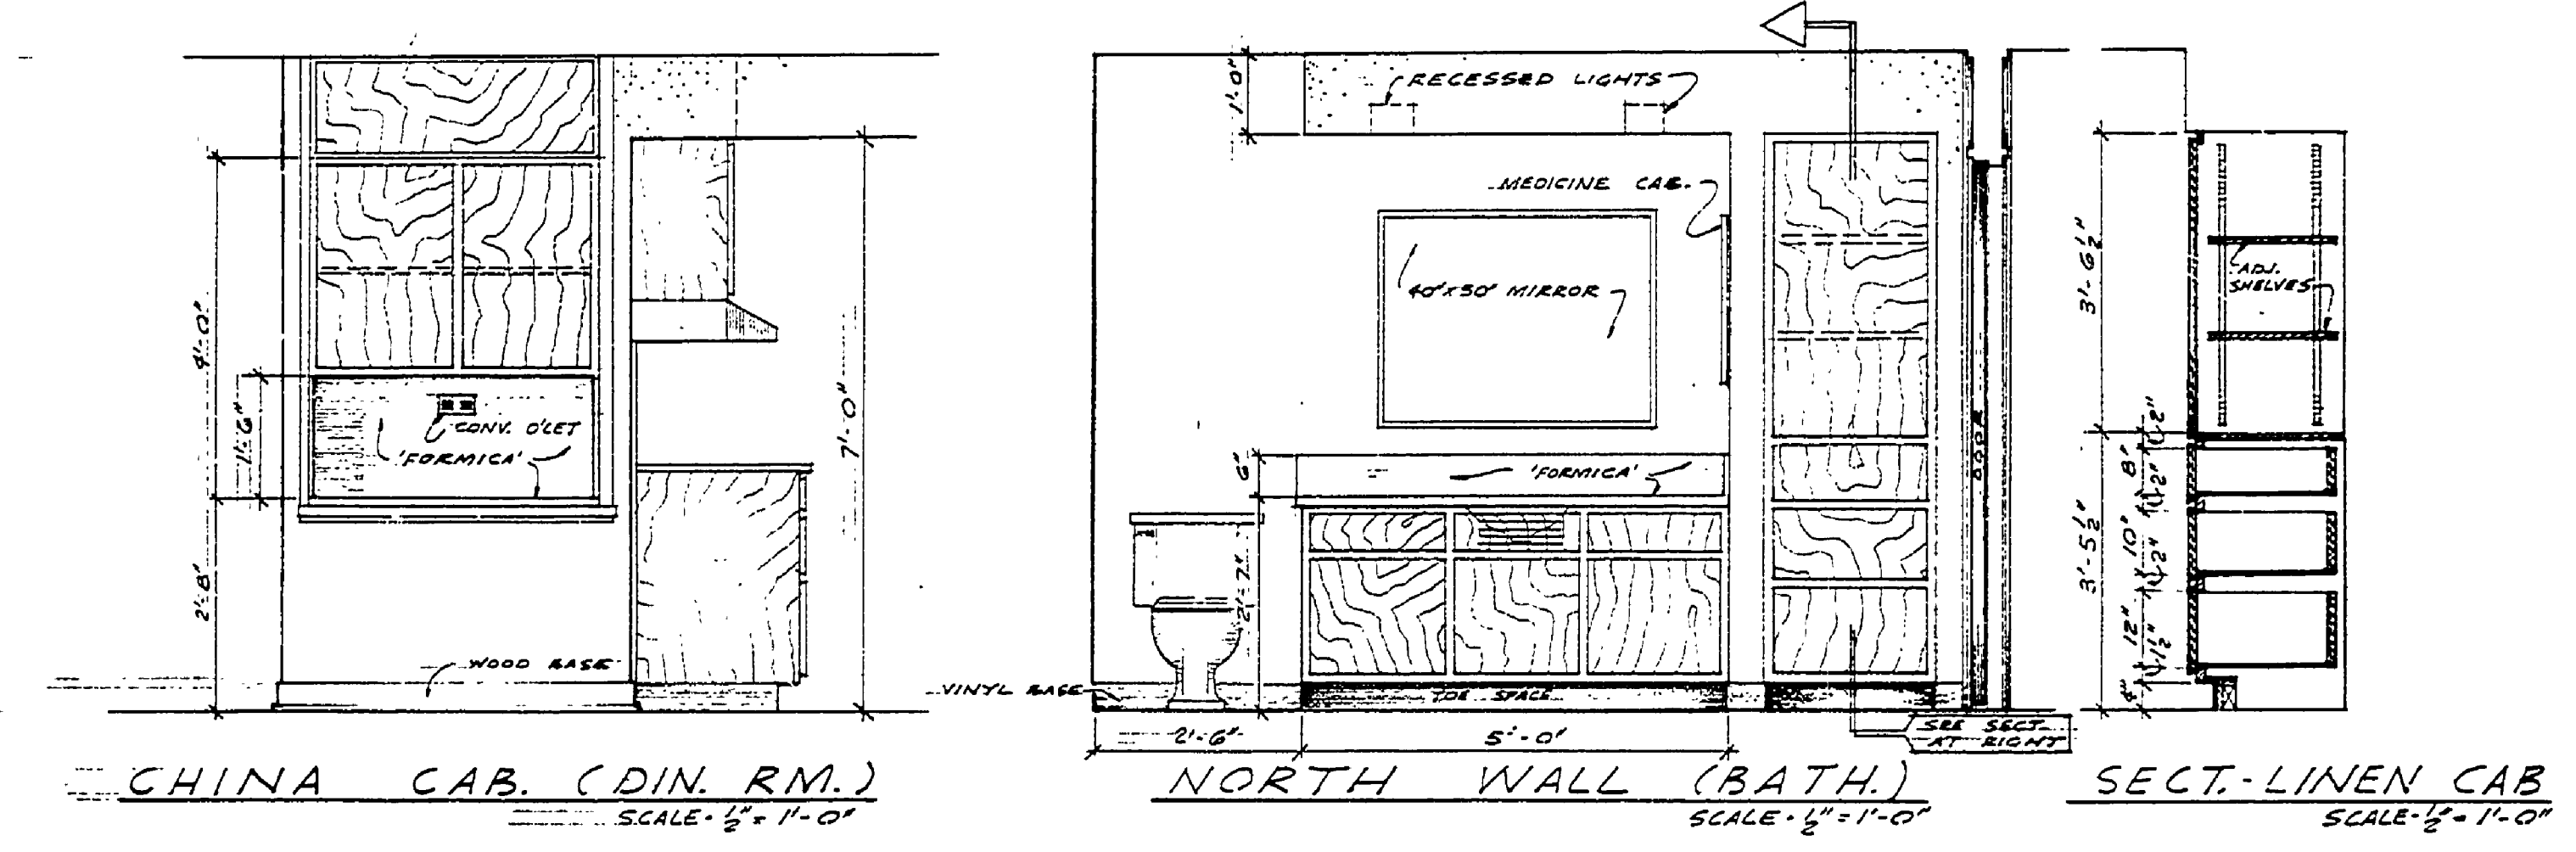


CHINA CAB. (DIN. RM.) NORTH WALL (BATH) SECT.-LINEN CAB  
SCALE - 1/2" = 1'-0"

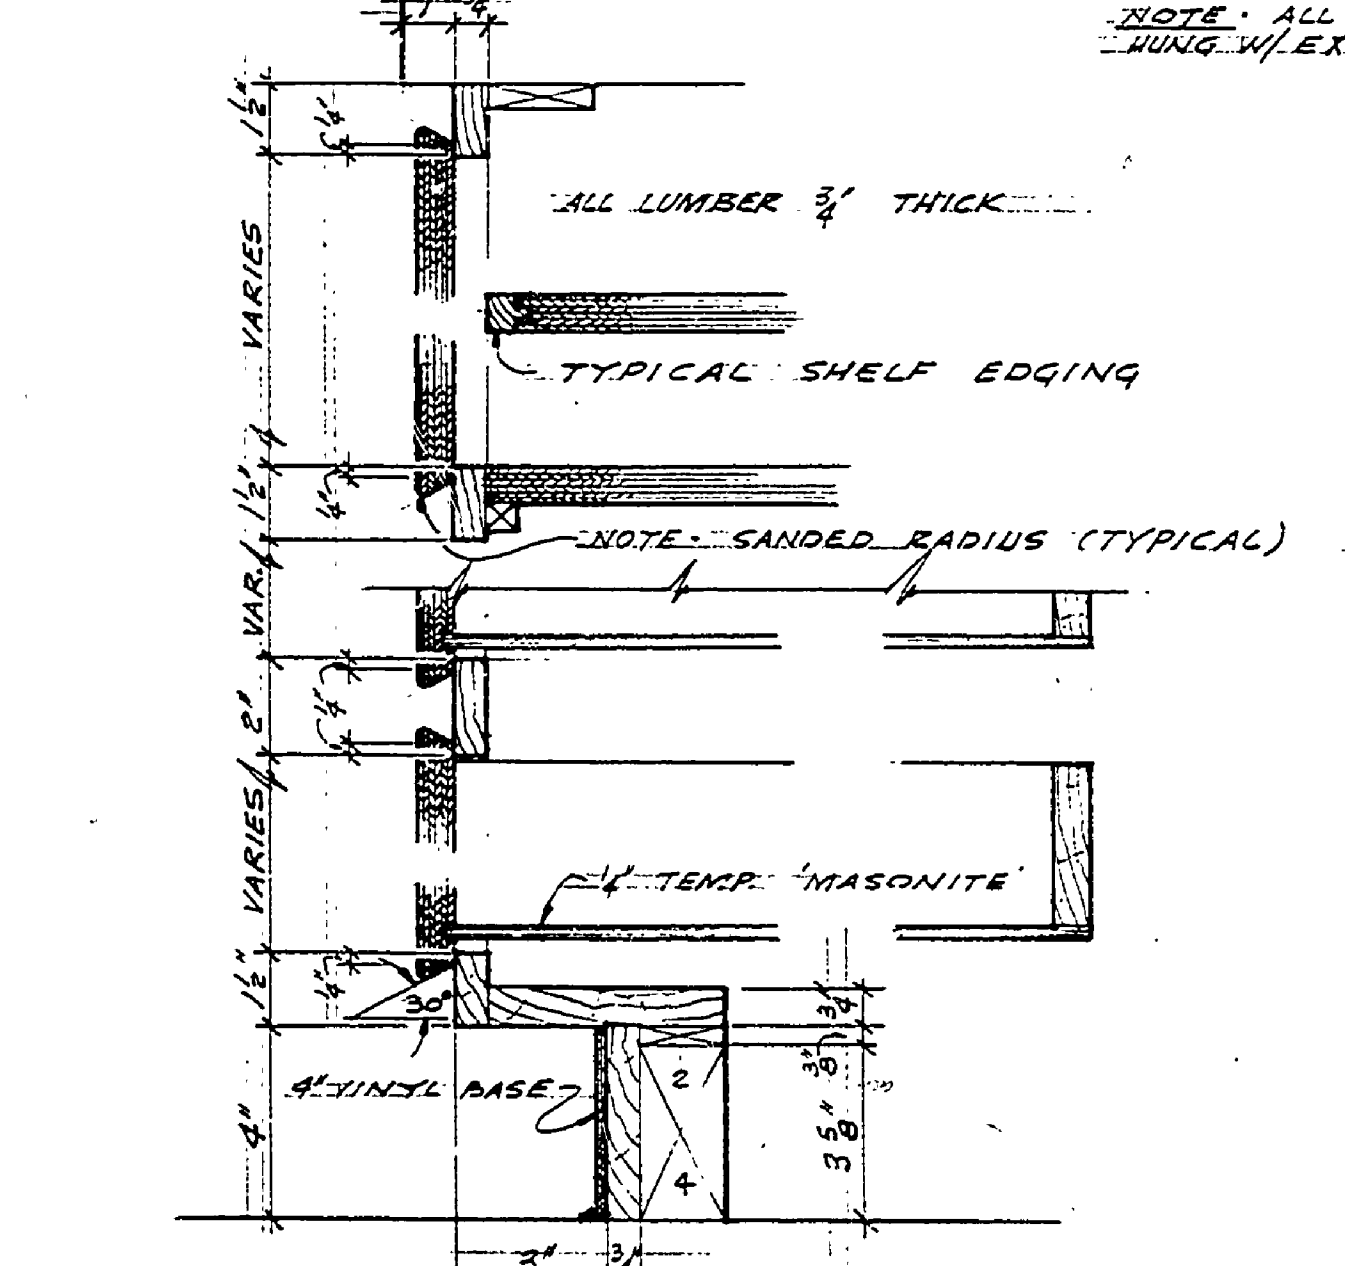


CABINET DETAILS  
SCALE - 3/8" = 1'-0"


NOTE: ALL DRAWINGS TO BE HUNG W/ EXTENSION SLIDES (SEE SPEC)

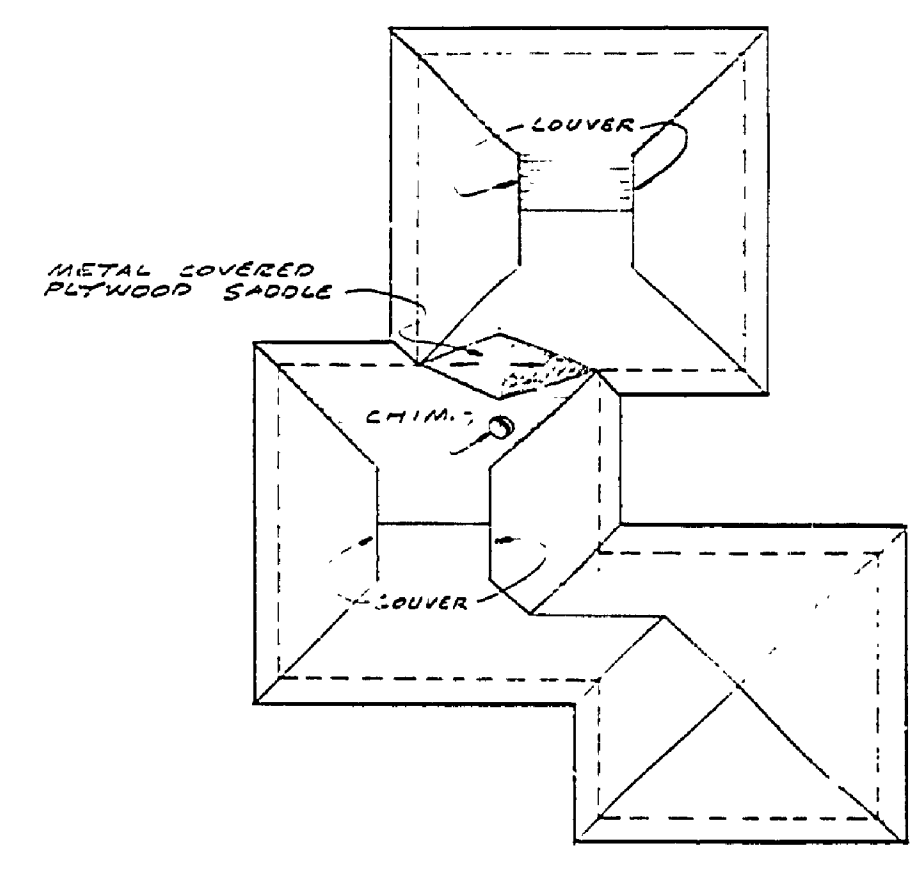

ROOF PLAN  
NO SCALE

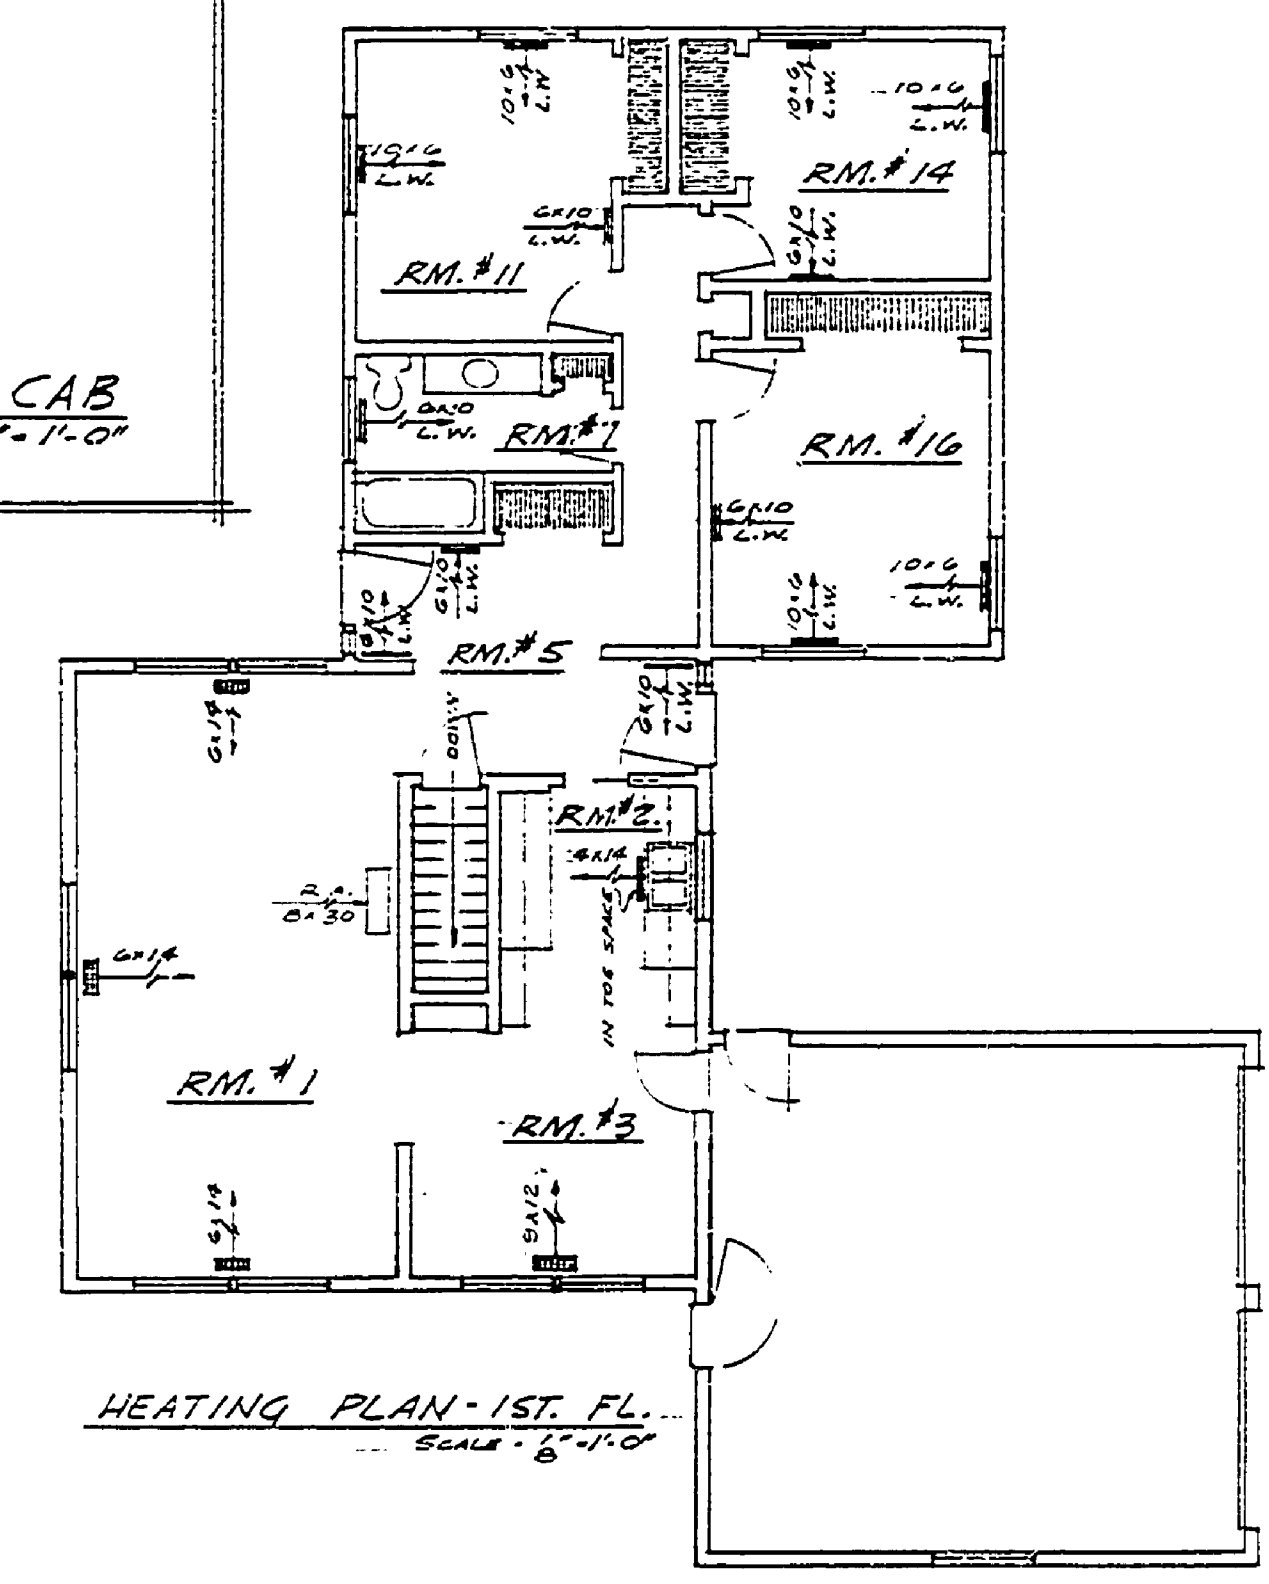

HEATING PLAN - 1ST FL.  
SCALE - 1/8" = 1'-0"

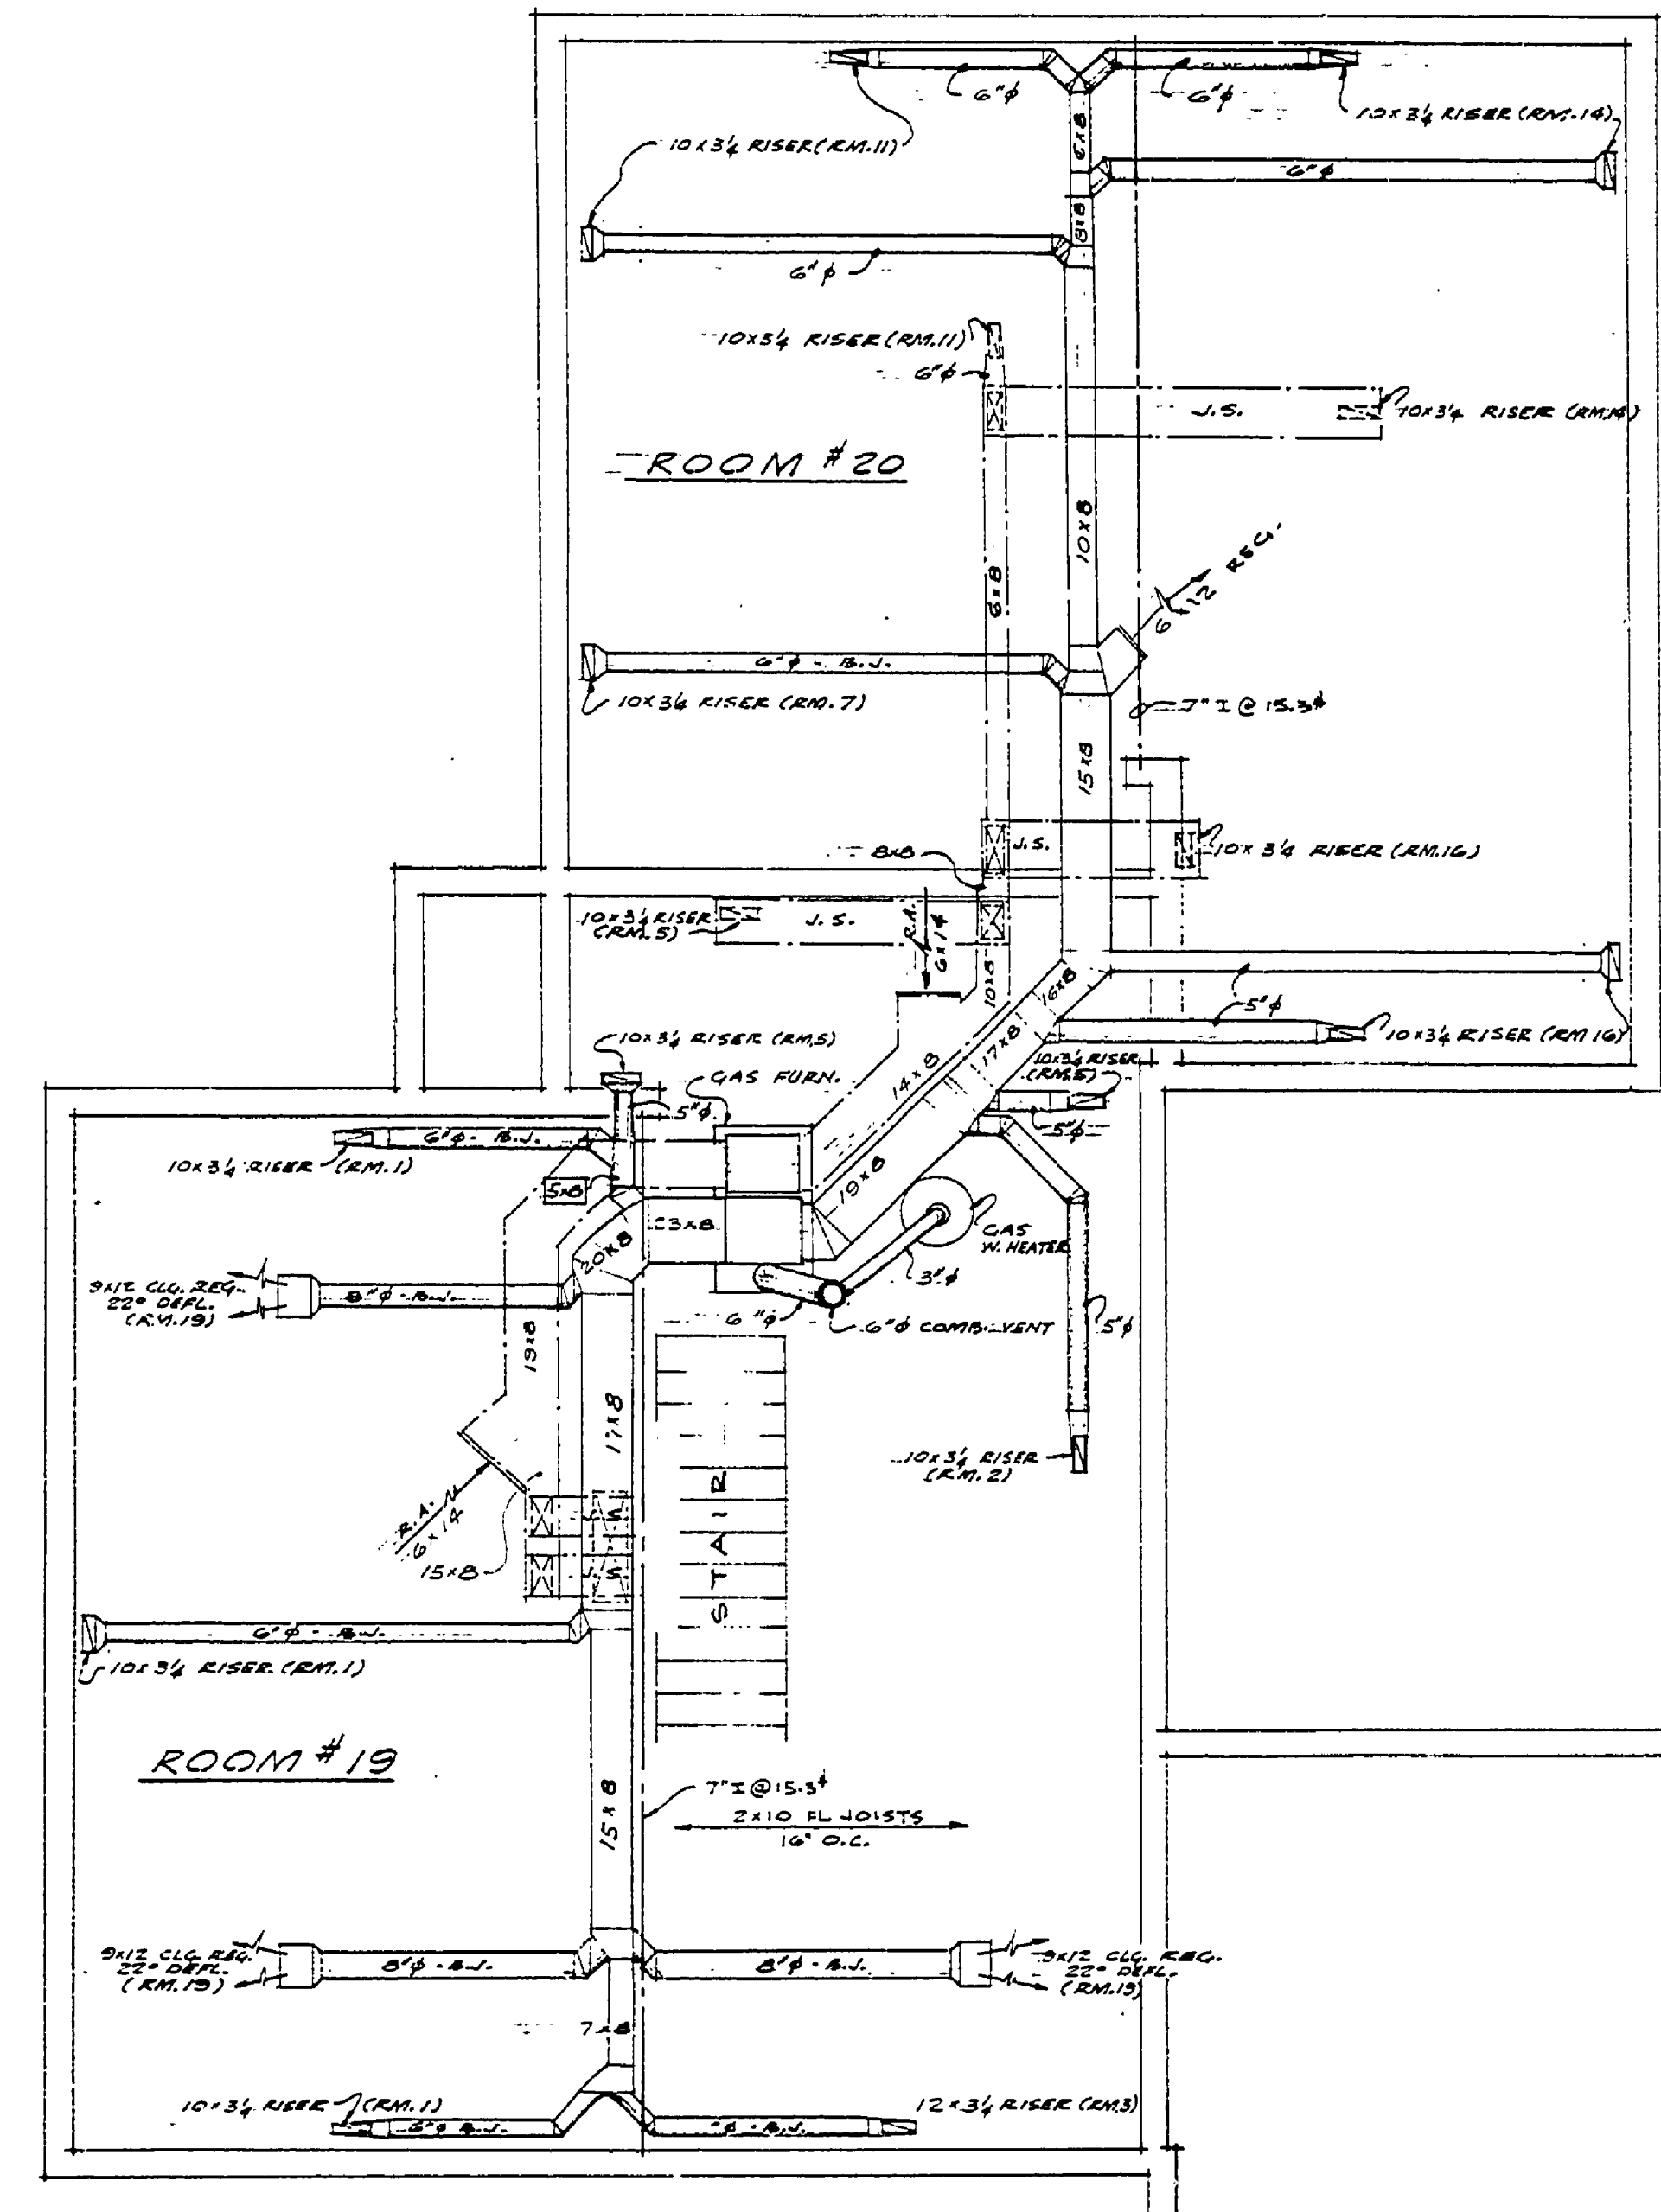

HEATING PLAN - BASEMENT  
SCALE - 1/8" = 1'-0"

**SYMBOLS & ABBREVIATIONS**

WARM AIR  
 RISER  
 DUCT  
 REGISTER  
 FLOOR REGISTER  
 L.W. - LOW WALL  
 C.L.G. - CEILING

RETURN AIR  
 RISER  
 DUCT  
 INTAKE  
 DUCT CONNECTION BELOW JOIST  
 R.A. - RETURN AIR  
 L.W. - LOW WALL

B.W. - DUCT BETWEEN JOISTS  
 J.S. - JOIST SPACE USED AS RETURN DUCT

CONSERVATION COMMISSION APPROVAL	
BY: _____	DATE: _____
RECOMMENDED FOR APPROVAL:	DESIGN
FOR APPROVAL:	DESIGNER _____ DATE _____
RECOMMENDED FOR APPROVAL:	IN CHARGE OF DESIGN _____ DATE _____
SECTION APPROVAL	
BY: _____	DATE: _____
SECTION CHIEF	
MICHIGAN DEPARTMENT OF CONSERVATION	
APPROVED:	CHIEF ENGINEER _____ DATE _____
PLAN No. _____	PROJECT NUMBER _____ SHEET _____ OF _____