
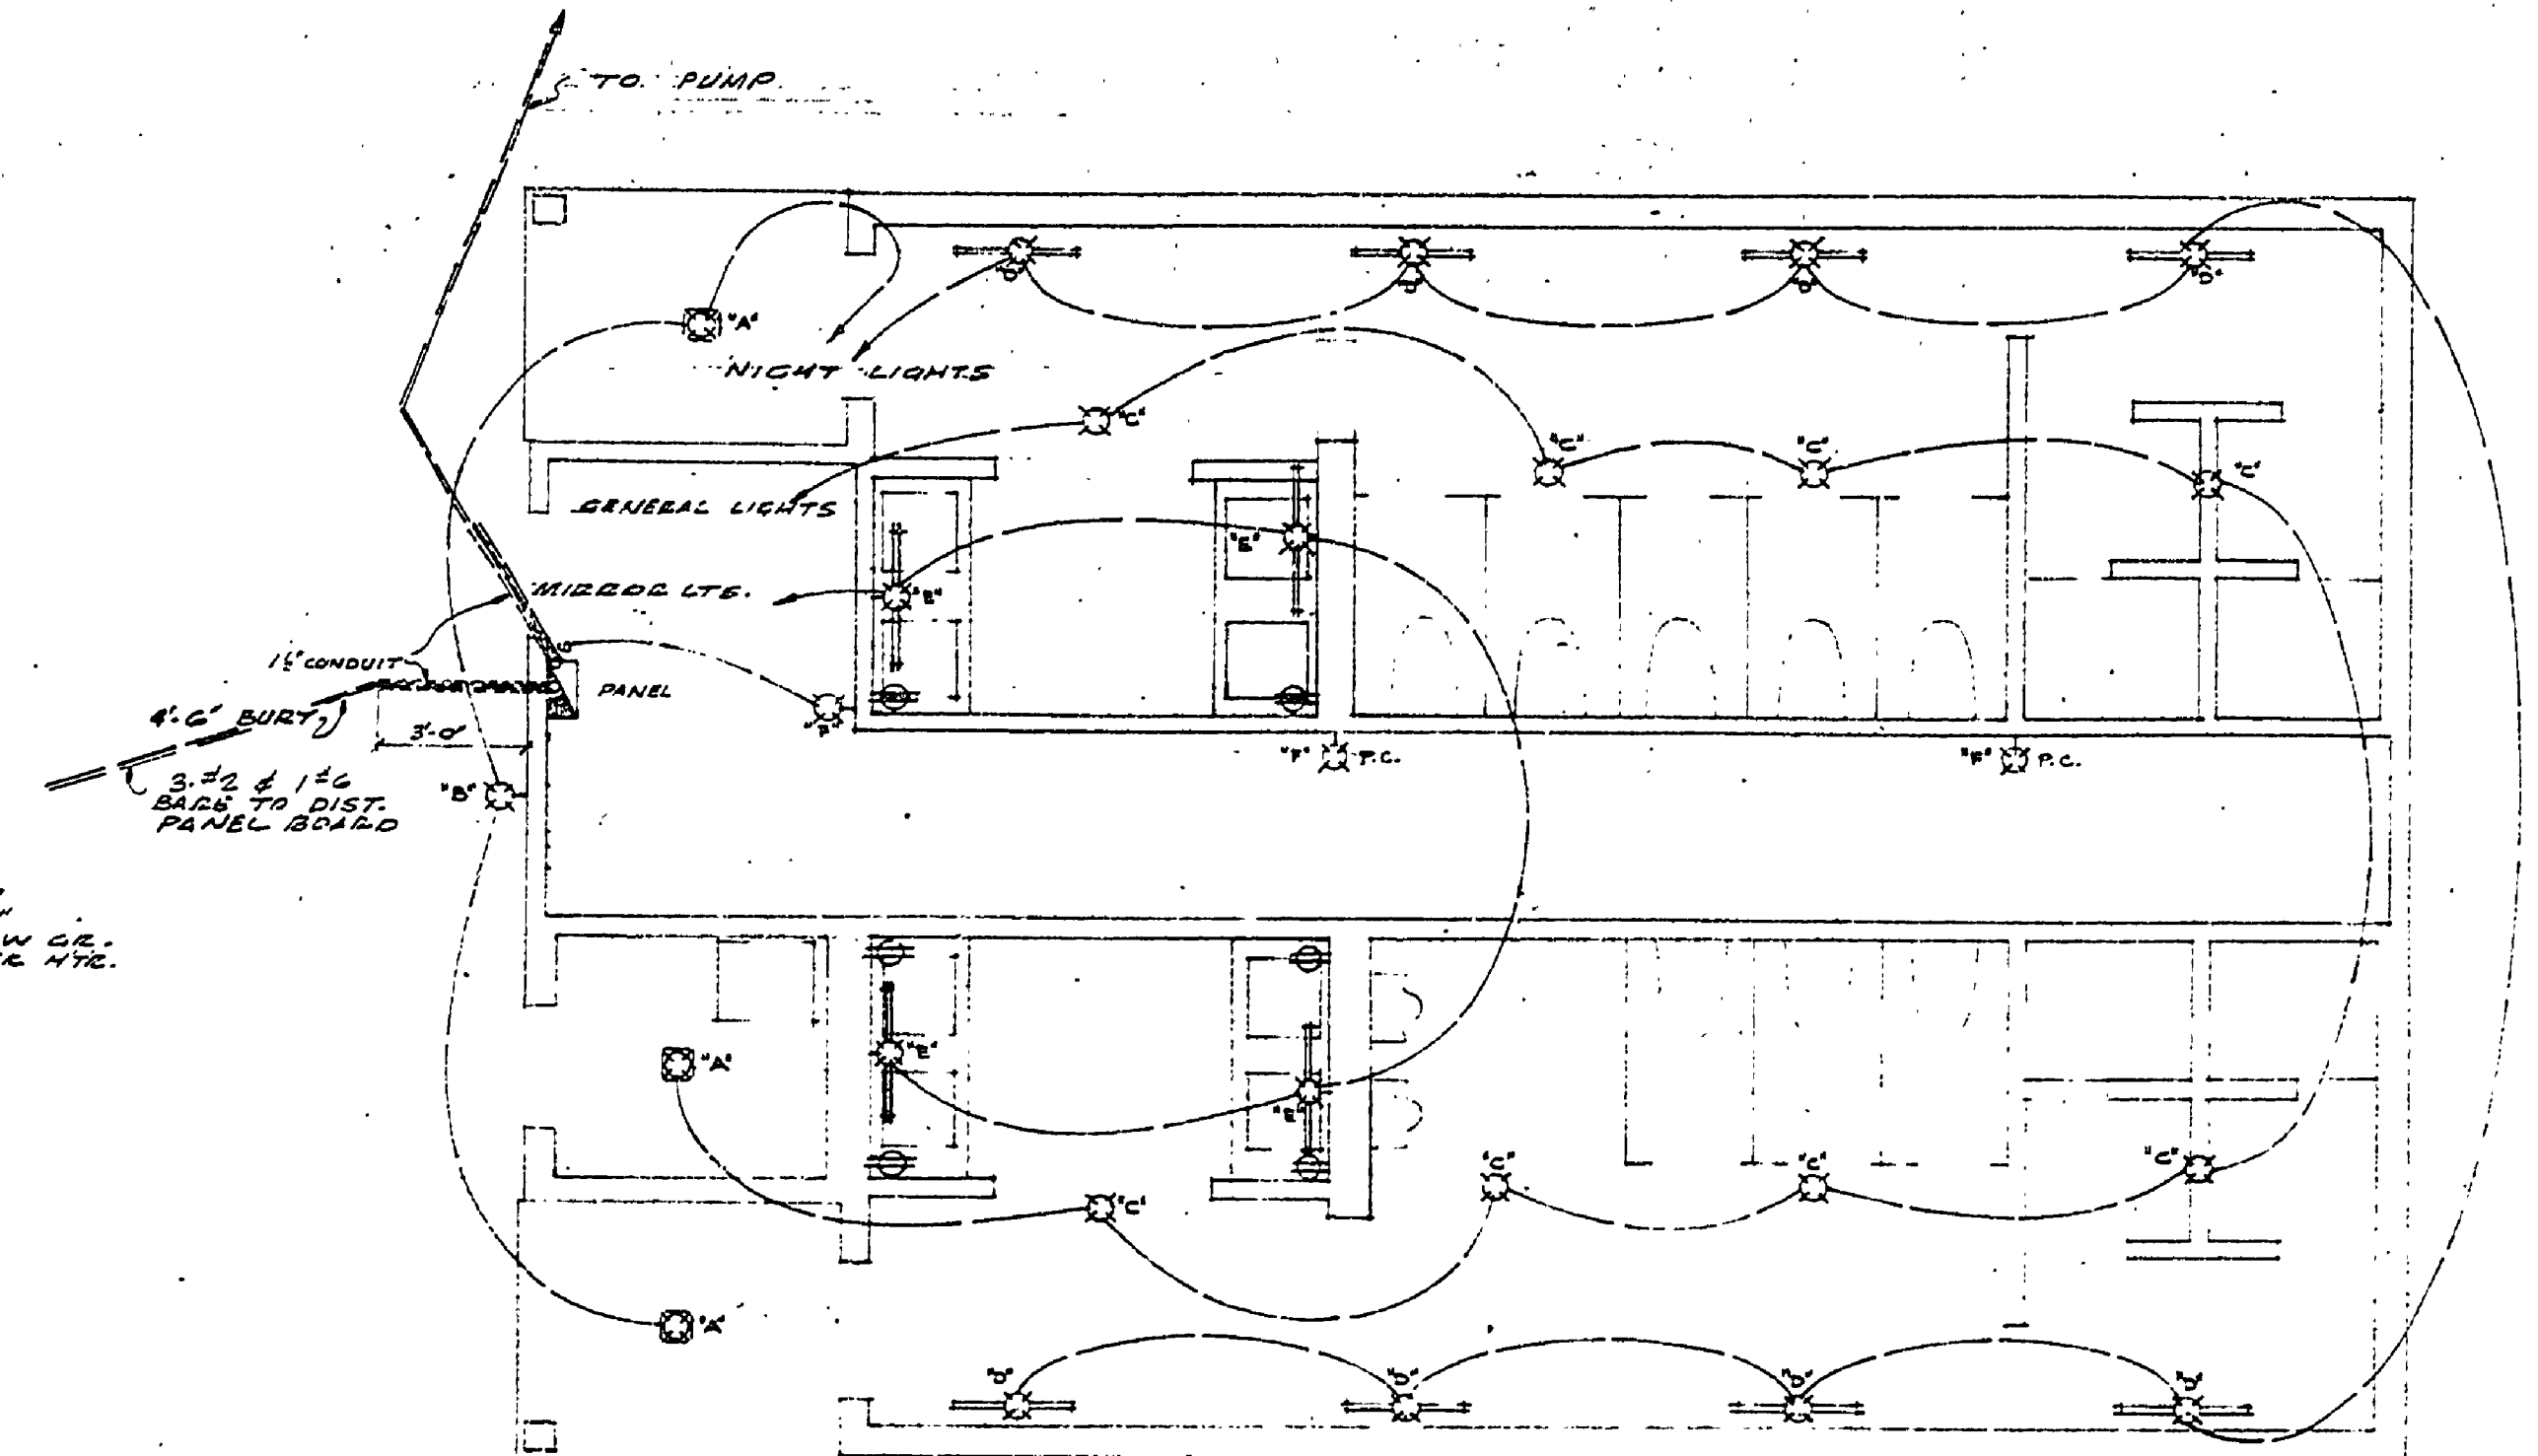



DATE	REVIEWED	DATE	APPROVED	DATE	NO.	DATE	REVISIONS	DATE	BY
10-27	ARCHITECTURAL ENGINEERING	10-27	LANDSCAPE	1	1	1	4		
				2	2	2	5		
				3	3	3	6		

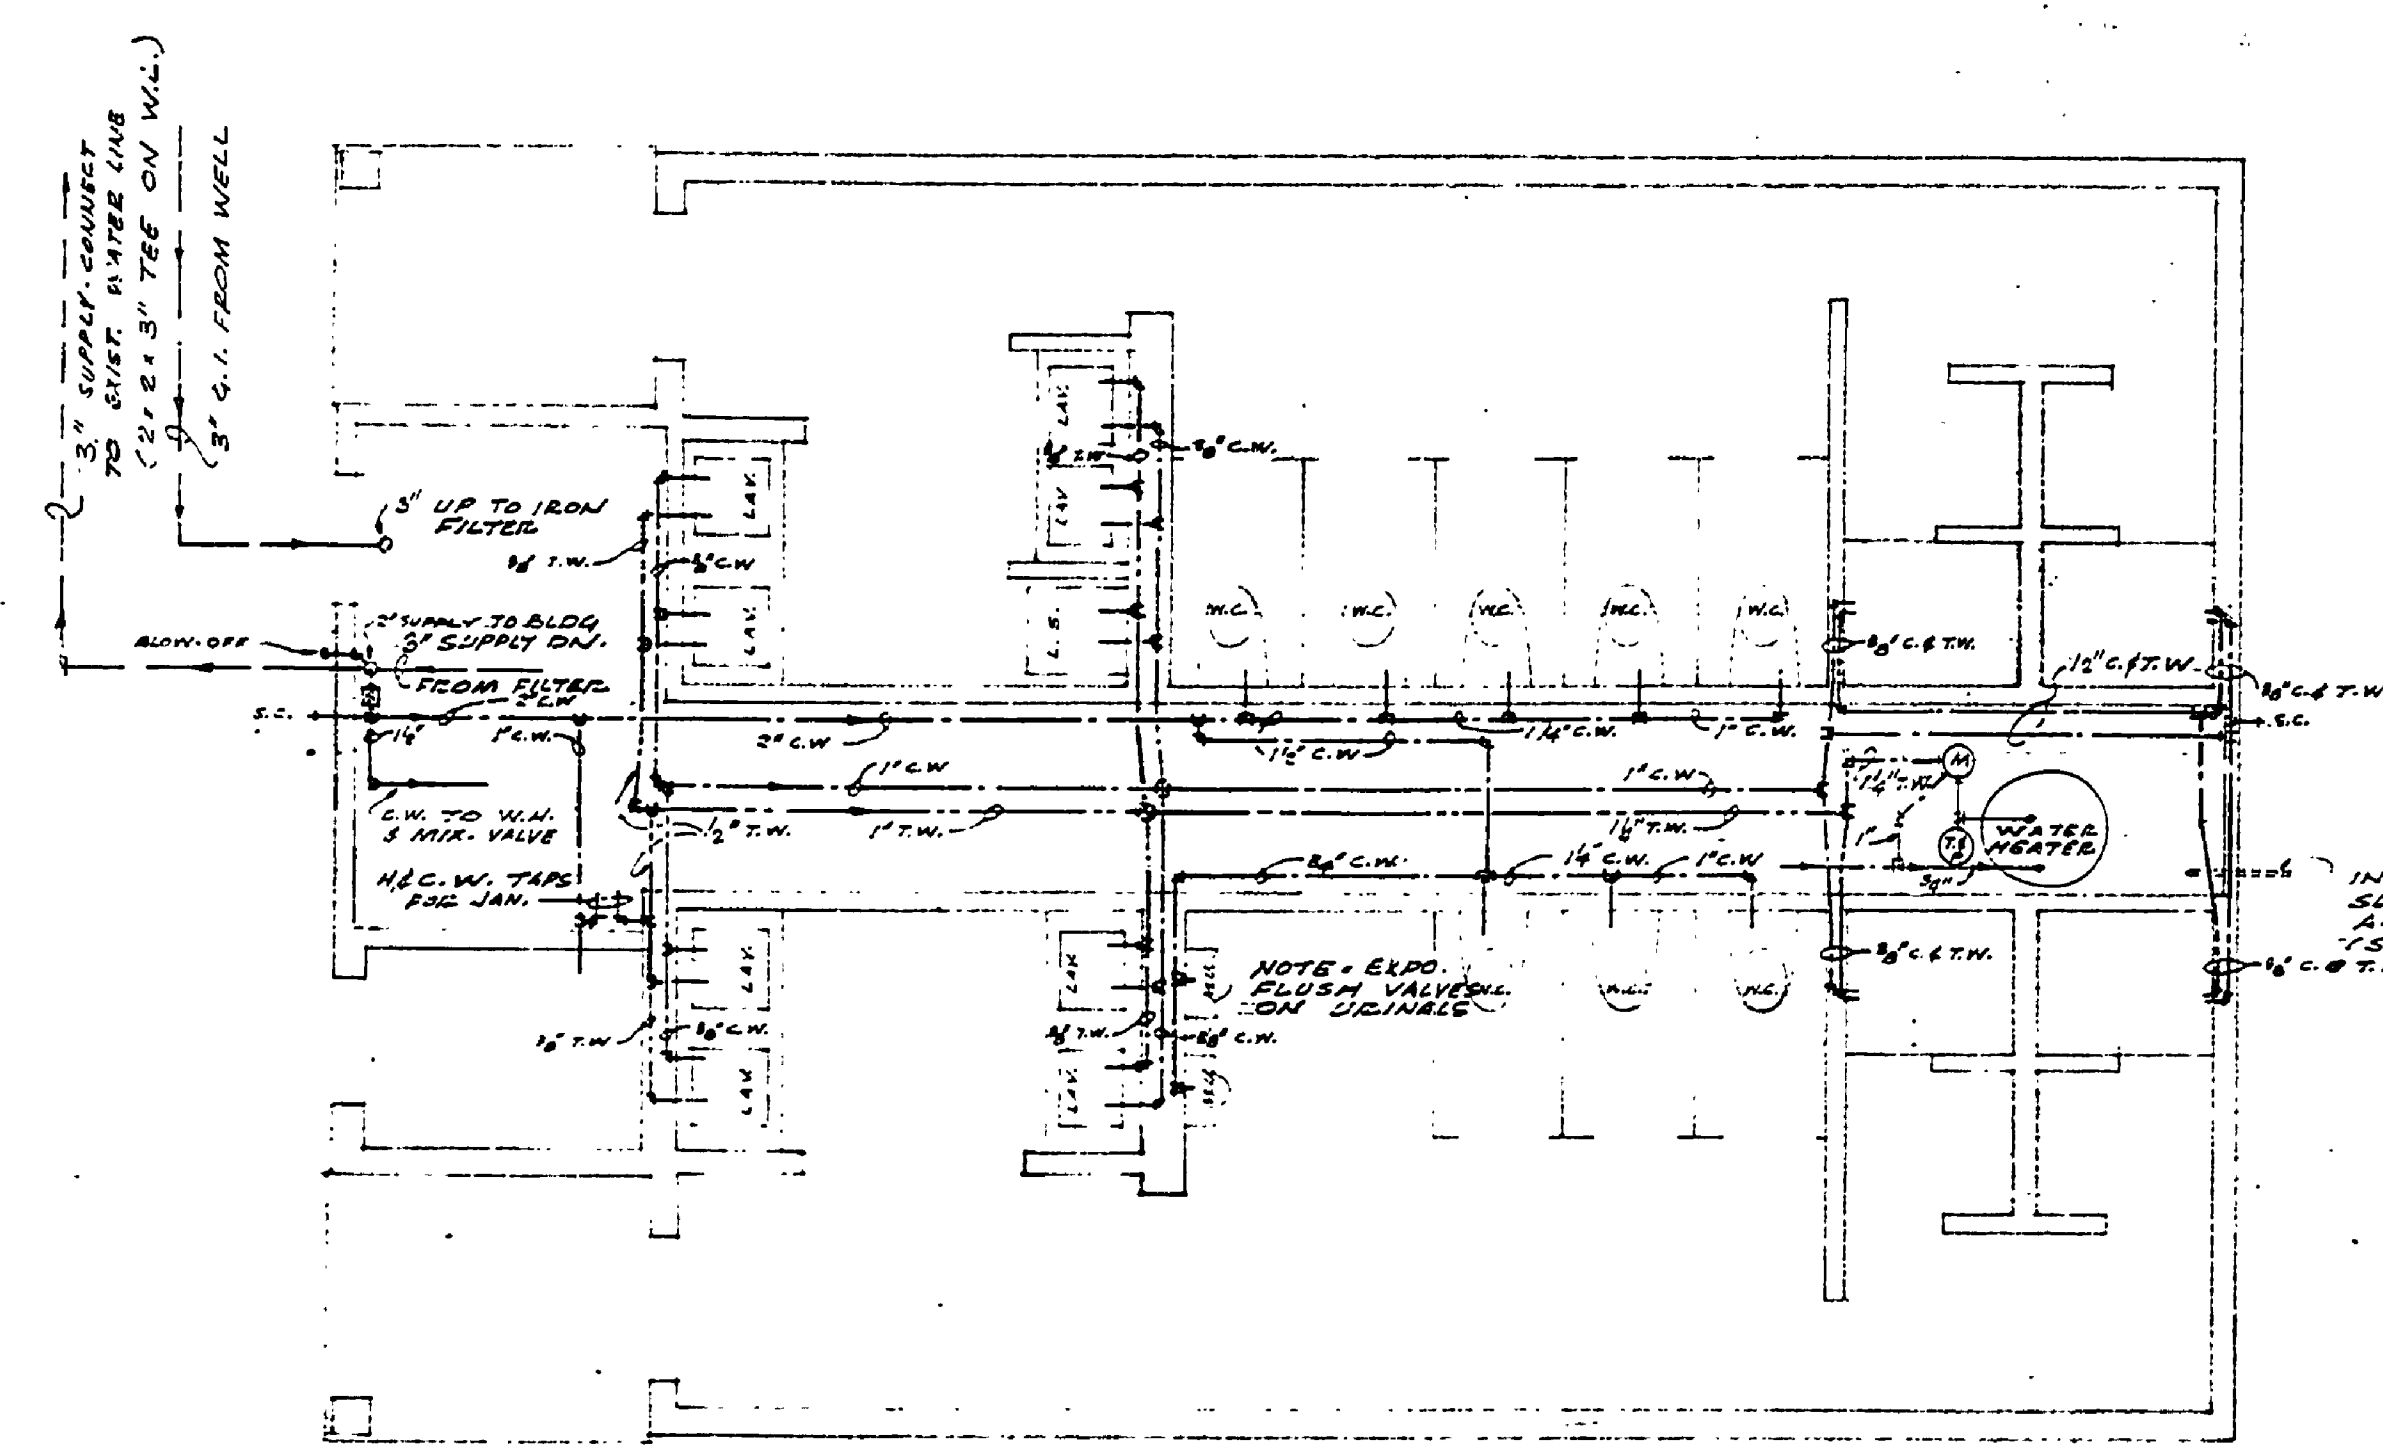


**PLUMBING FL. PLAN**  
(WATER)

**ELECTRICAL PLAN**


**SYMBOLS**  
 COLD WATER  
 TEMPERED WATER  
 STRAINER  
 THERMO. MIX. VALVE  
 THERMOMETER & T. & P. RELIEF VALVE

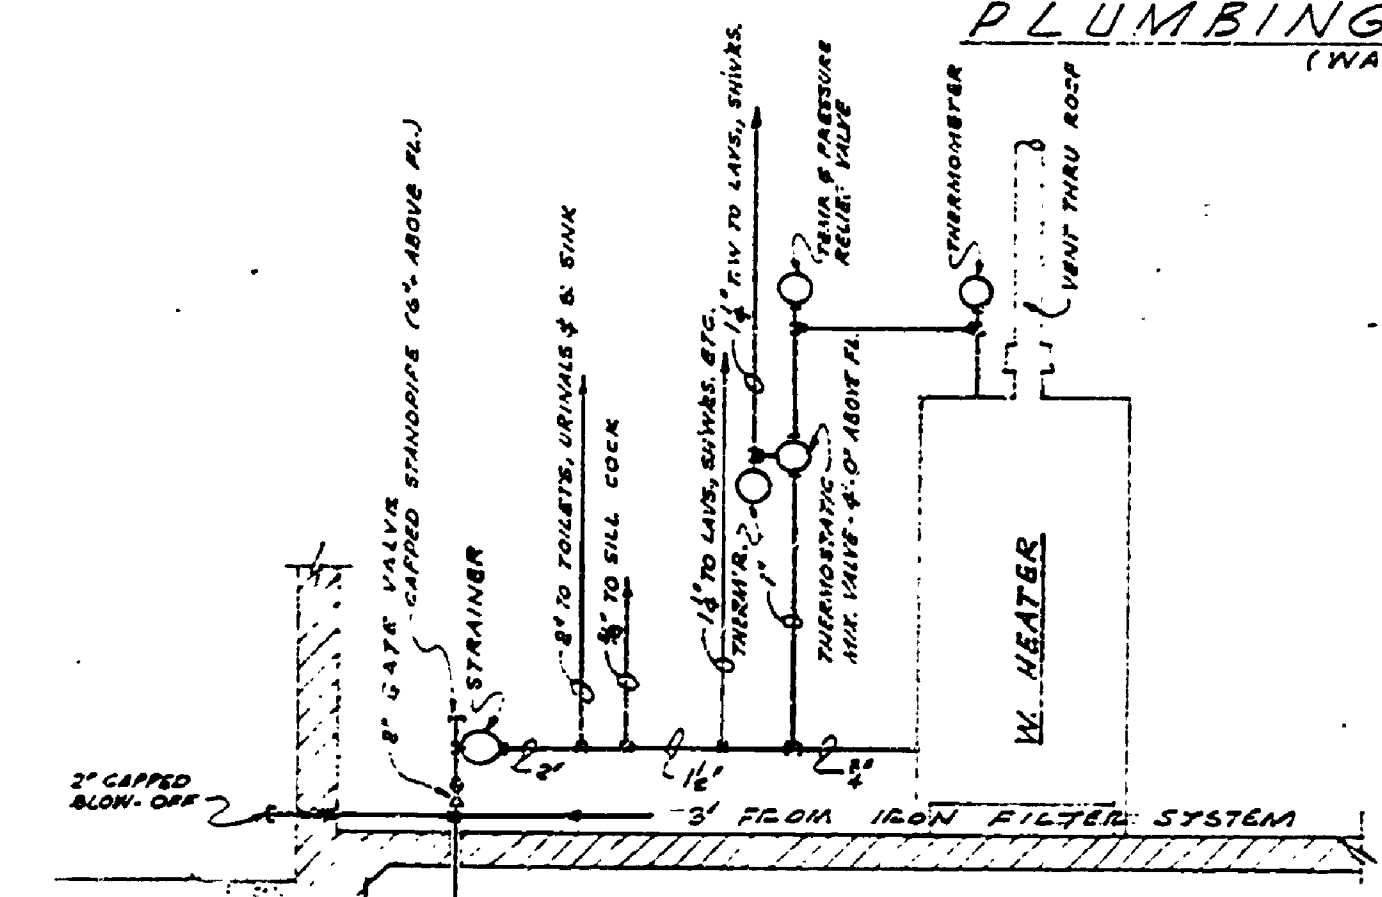


**HEATER & WATER SYSTEM DRAINAGE DIAGRAM**  
NO SCALE

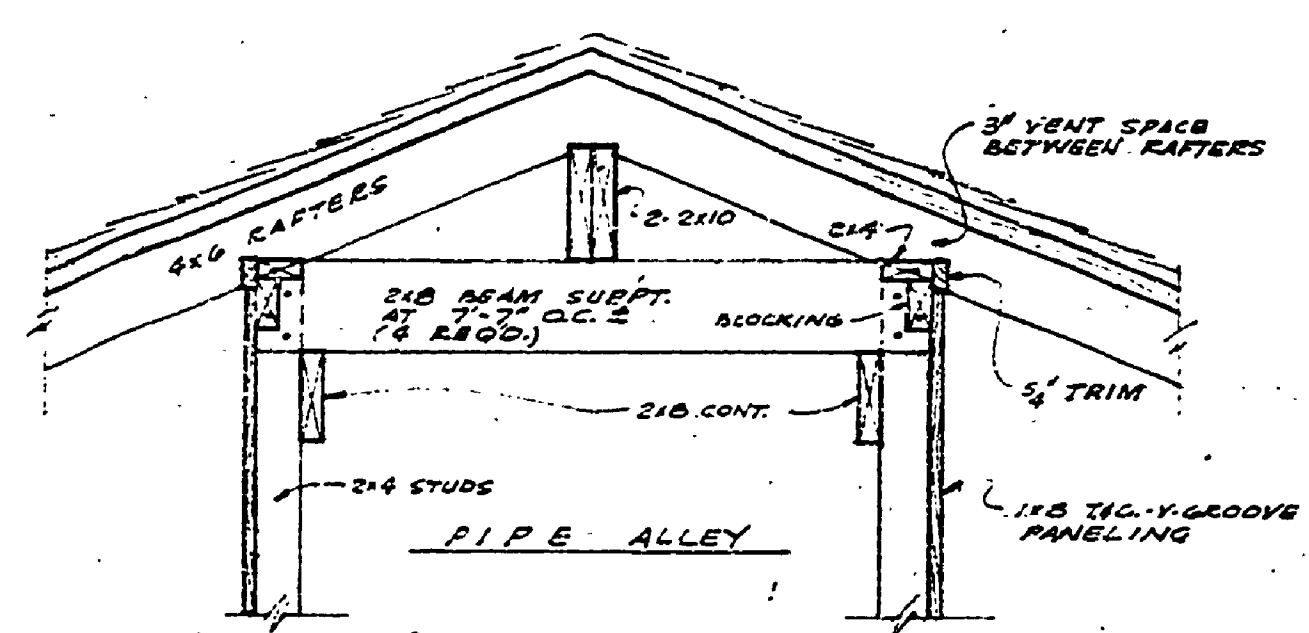



**SECTION - TYPICAL INTERMEDIATE RIDGE BEAM SUPPORT & VENT INTO PIPE ALLEY**  
1/2" = 1'-0"

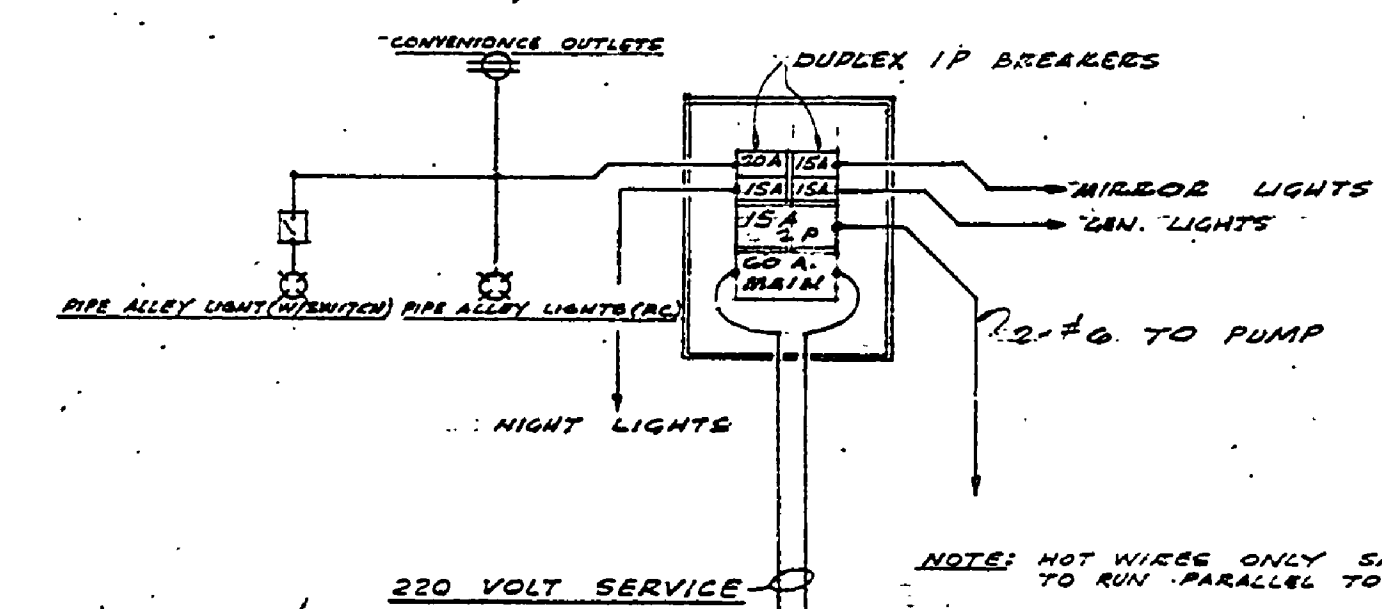


**SCHEMATIC WIRING DIAGRAM**  
ELECTRIC SERVICE PANEL & AUTOMATIC LIGHT CONTROL

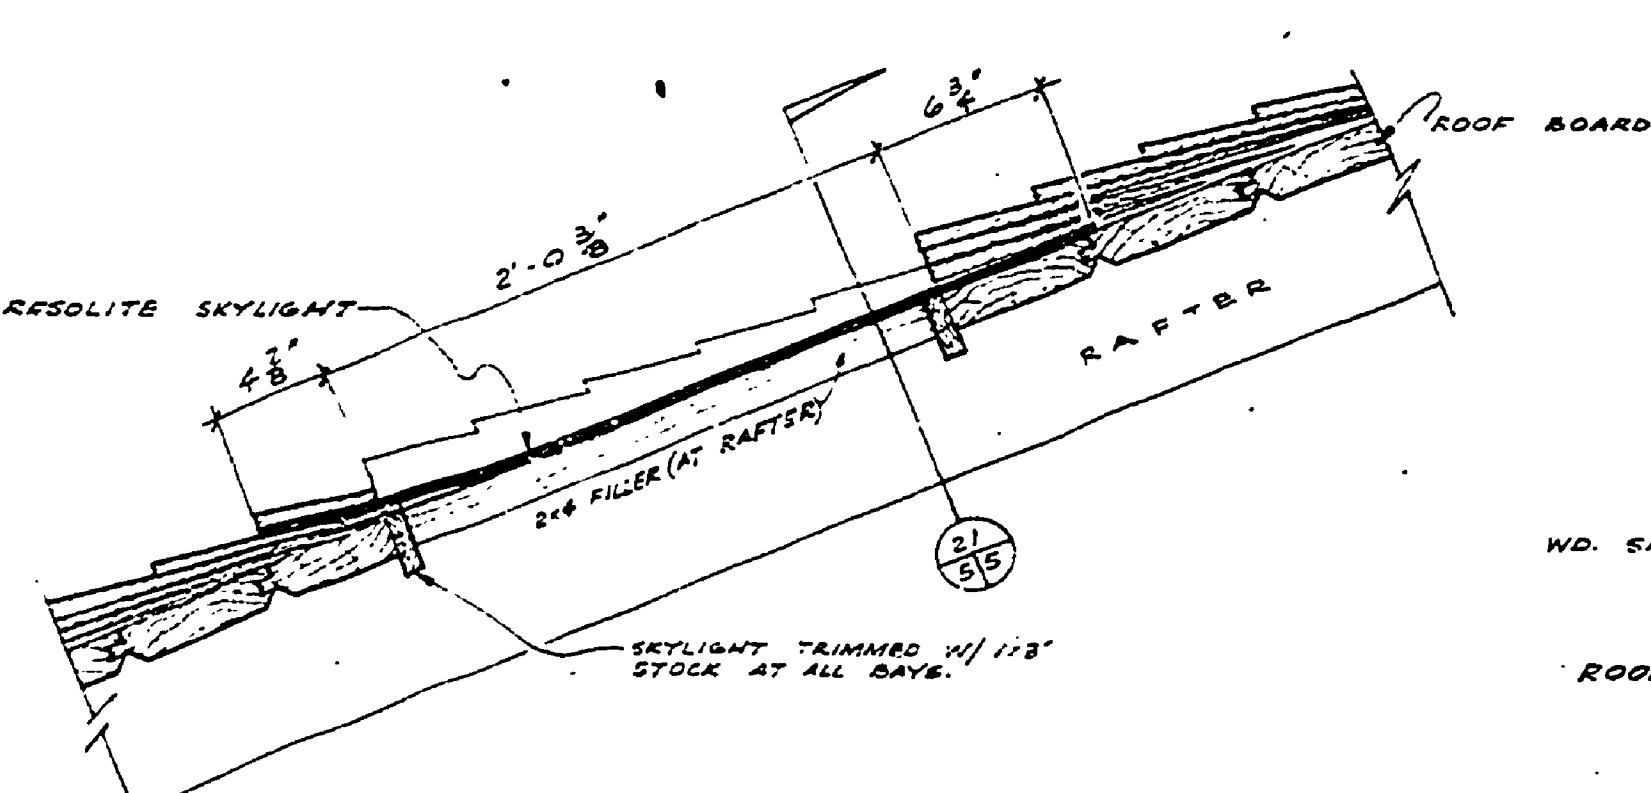


**TYPICAL SKYLIGHT DET.**  
1/2" = 1'-0"

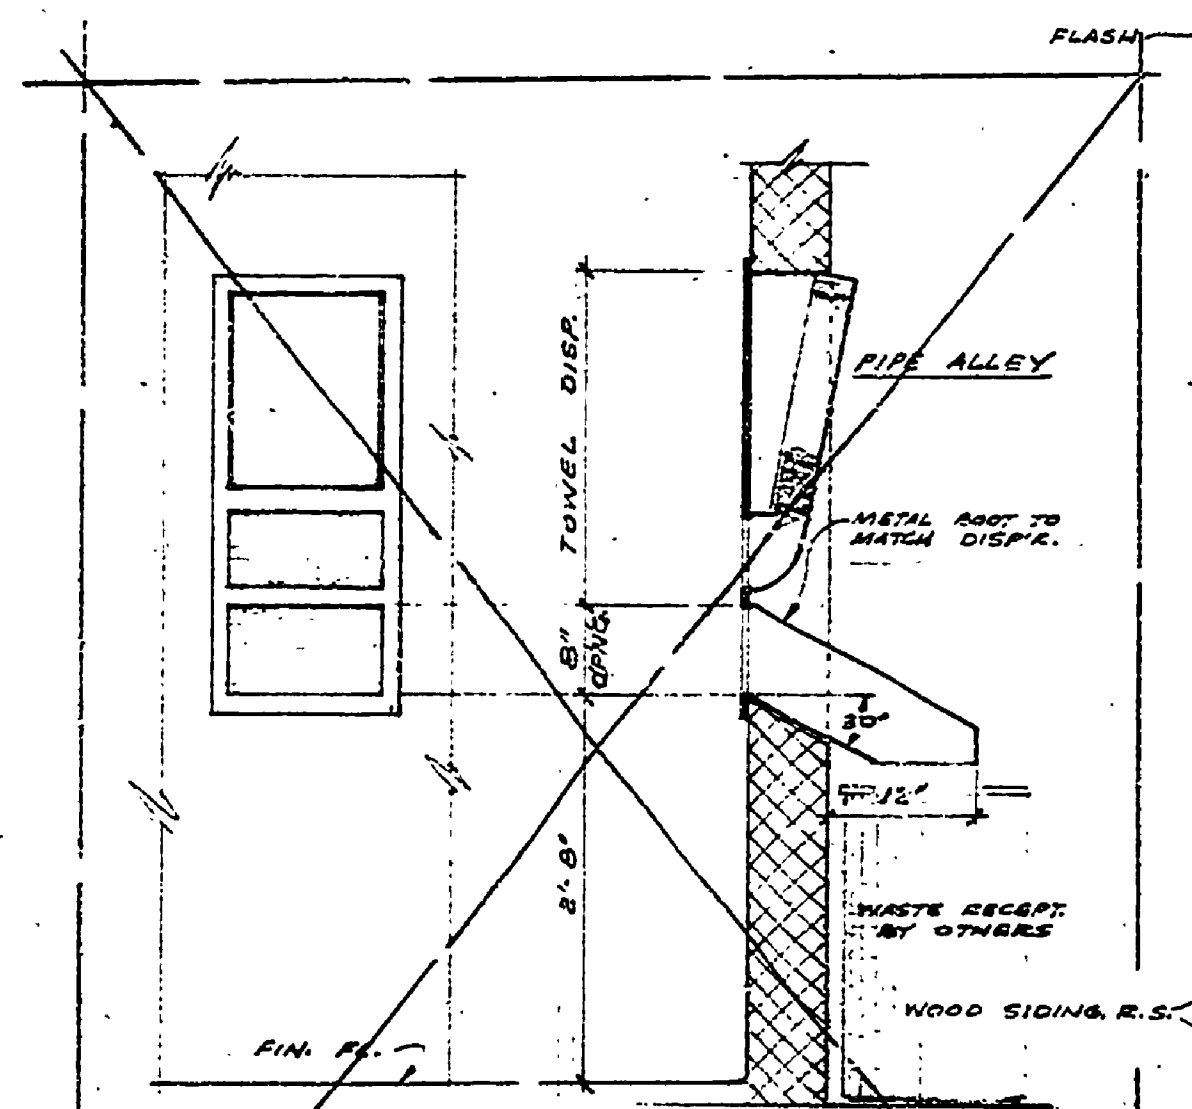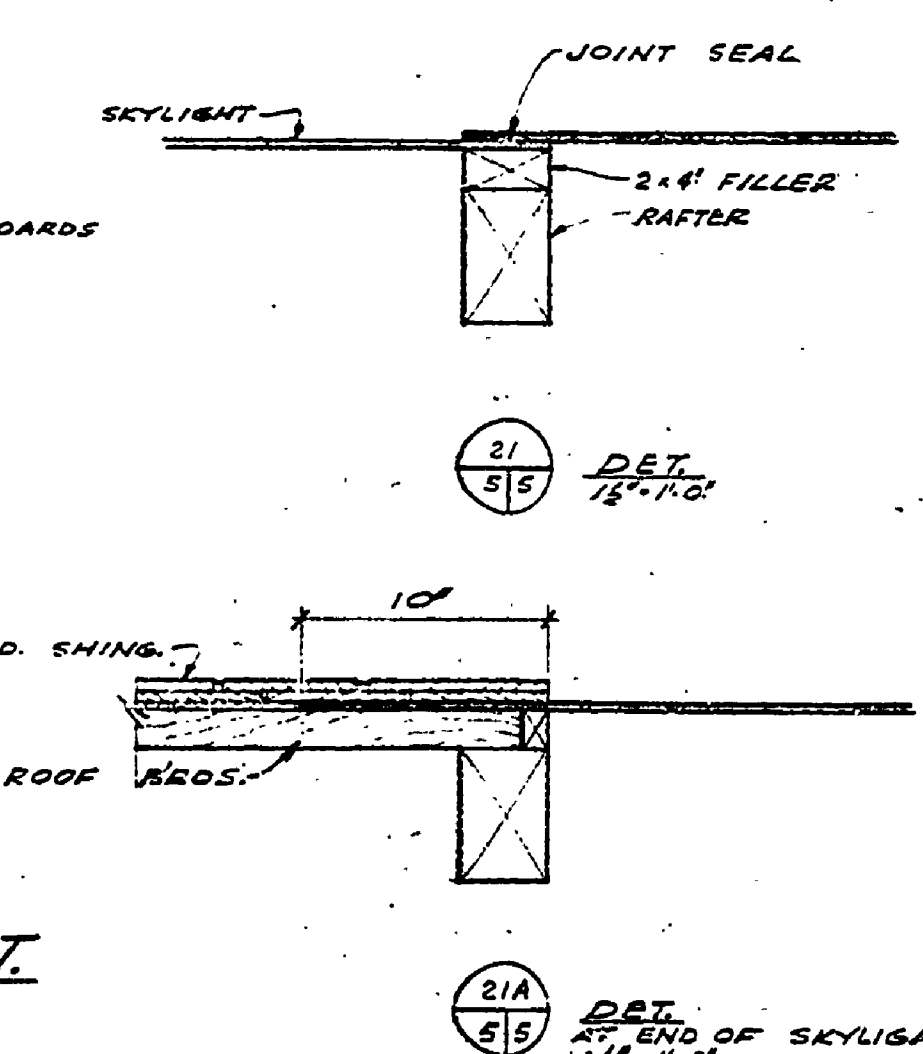

**ELEVATION SECTION**  
RECESSED TOWEL DISPENSER & WASTE DISPOSAL CHUTE  
3/8" = 1'-0"  
~~DELETE THIS DETAIL~~

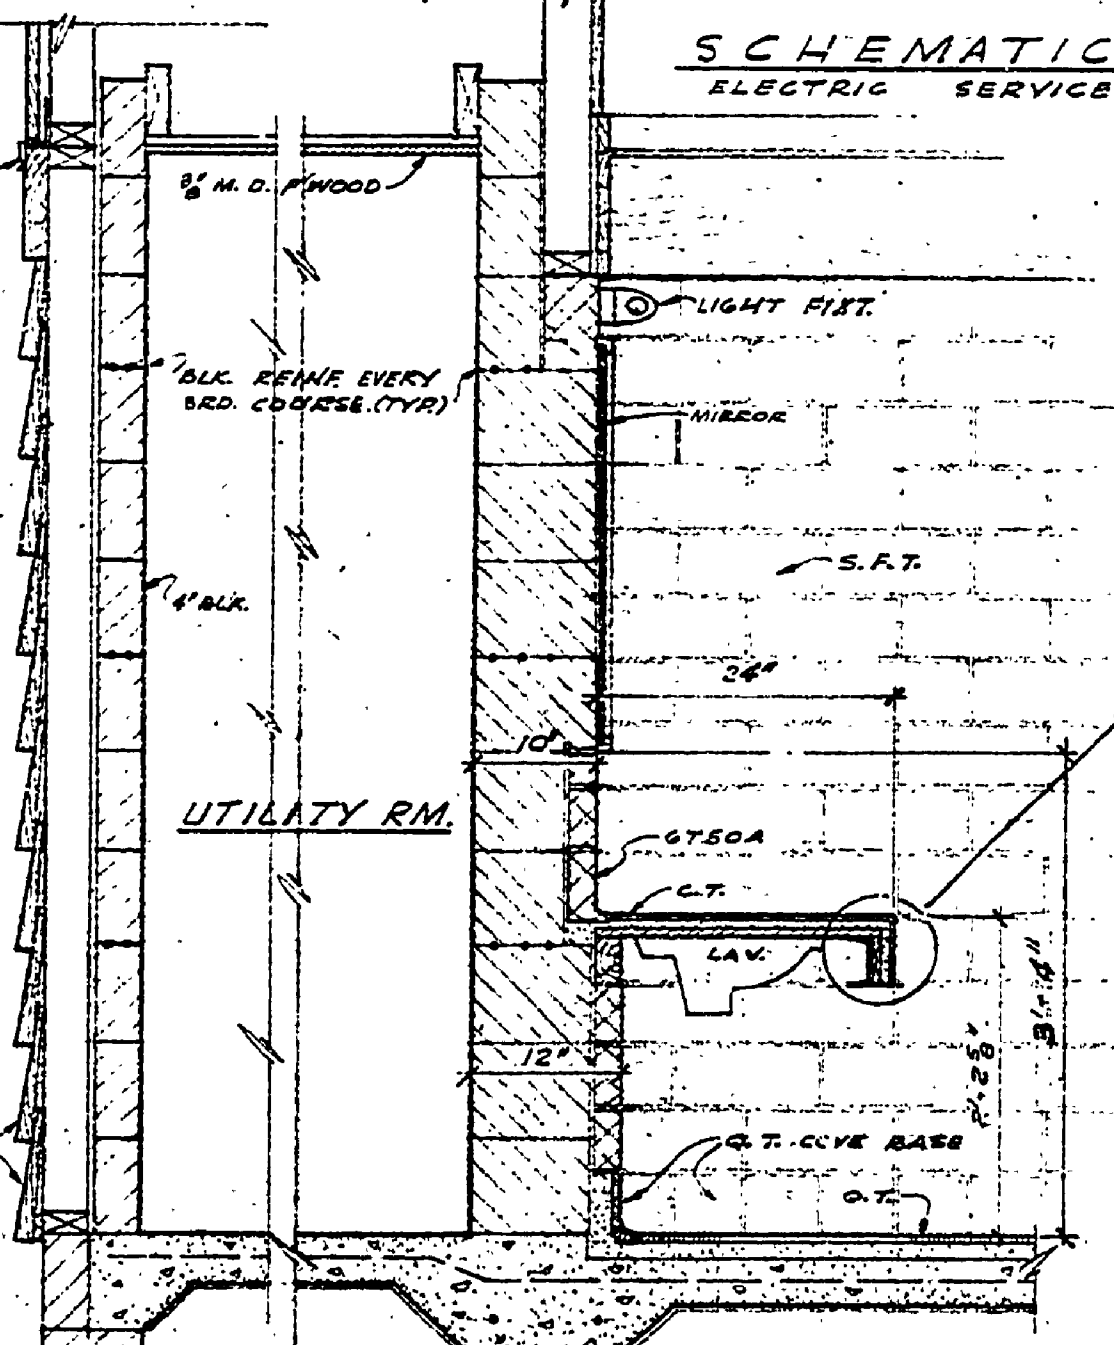

**SECTION**  
3/8" = 1'-0"

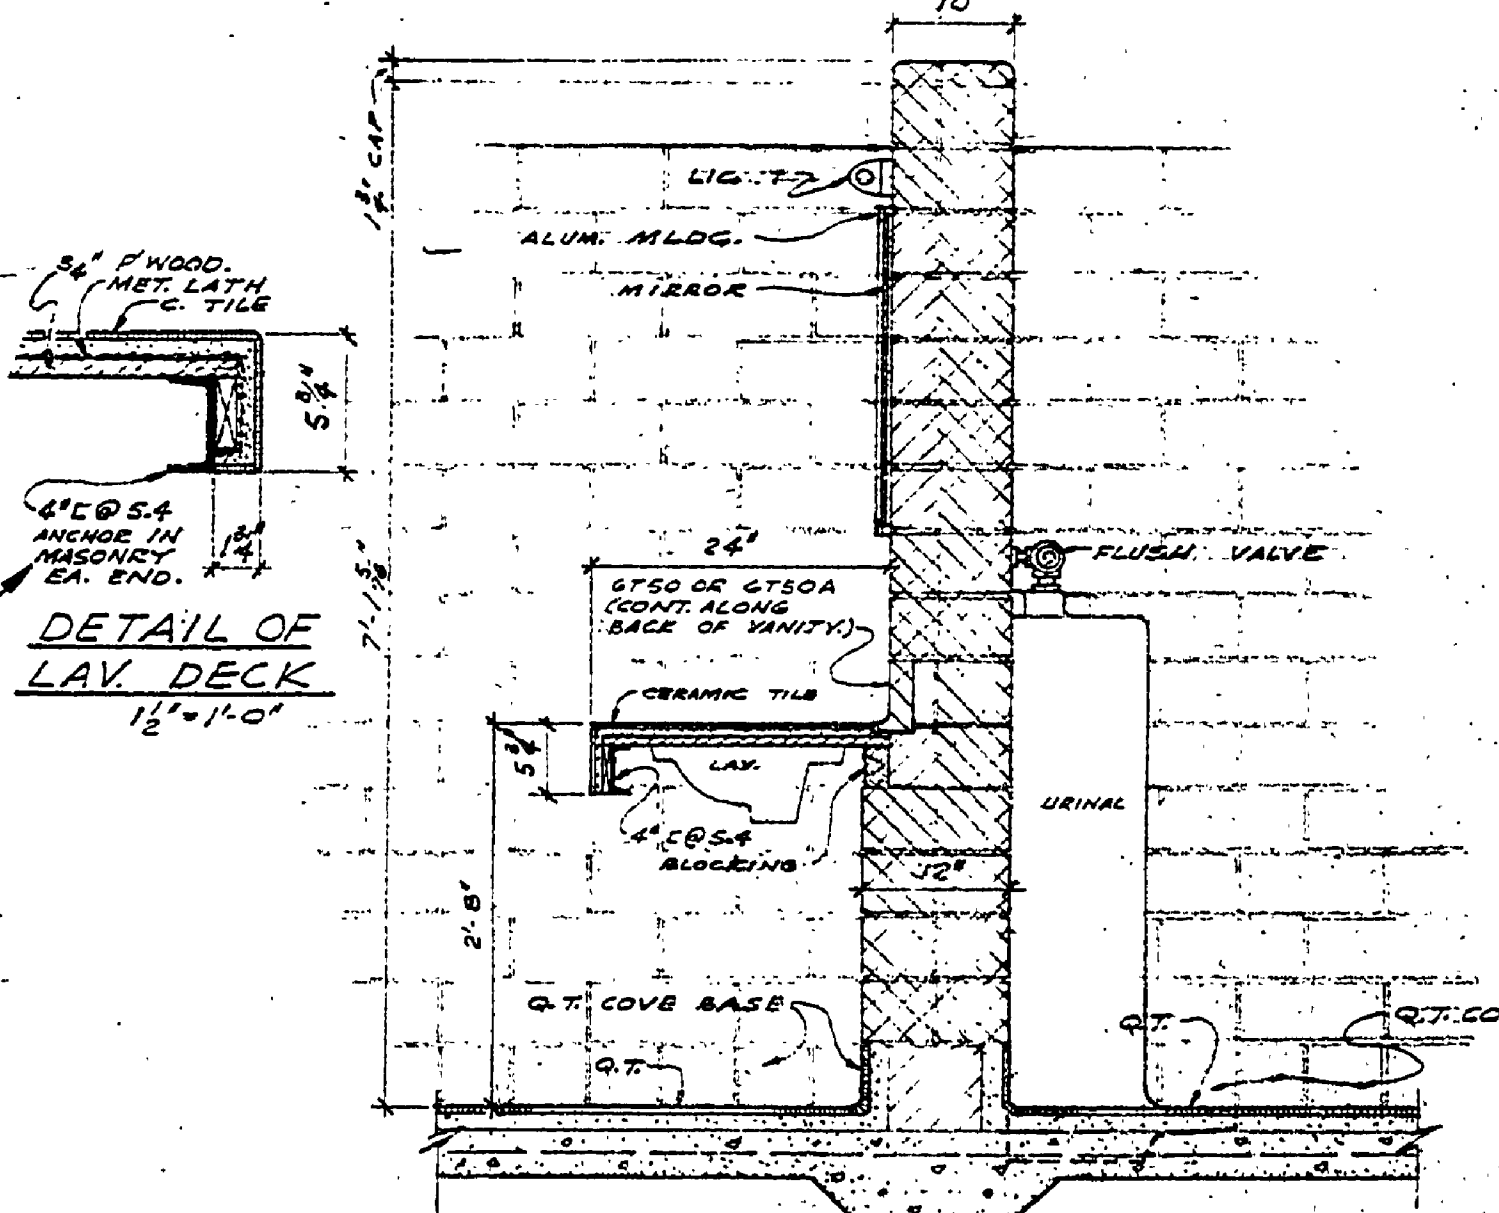

**SECTION**  
3/8" = 1'-0"

MICHIGAN DEPARTMENT OF CONSERVATION  
PARKS AND RECREATION DIVISION

ALBERT E. SLEEPER STATE PARK  
TOILET & SHOWER BUILDING

SHEET NO. 5 OF 5  
PLAN NO. A-170

1/2" = 1'-0" PUMPWAY LOAD CENTER, P.L.C.