



DATE	REVIEWED	DATE	APPROVED	DATE	NO.	DATE	BY	REVISIONS	DATE	BY
DESIGNED BY	ARCHITECTURAL				1			4		
DRAWN BY	ENGINEERING				2			5		
CHECKED BY	LANDSCAPE				3			6		

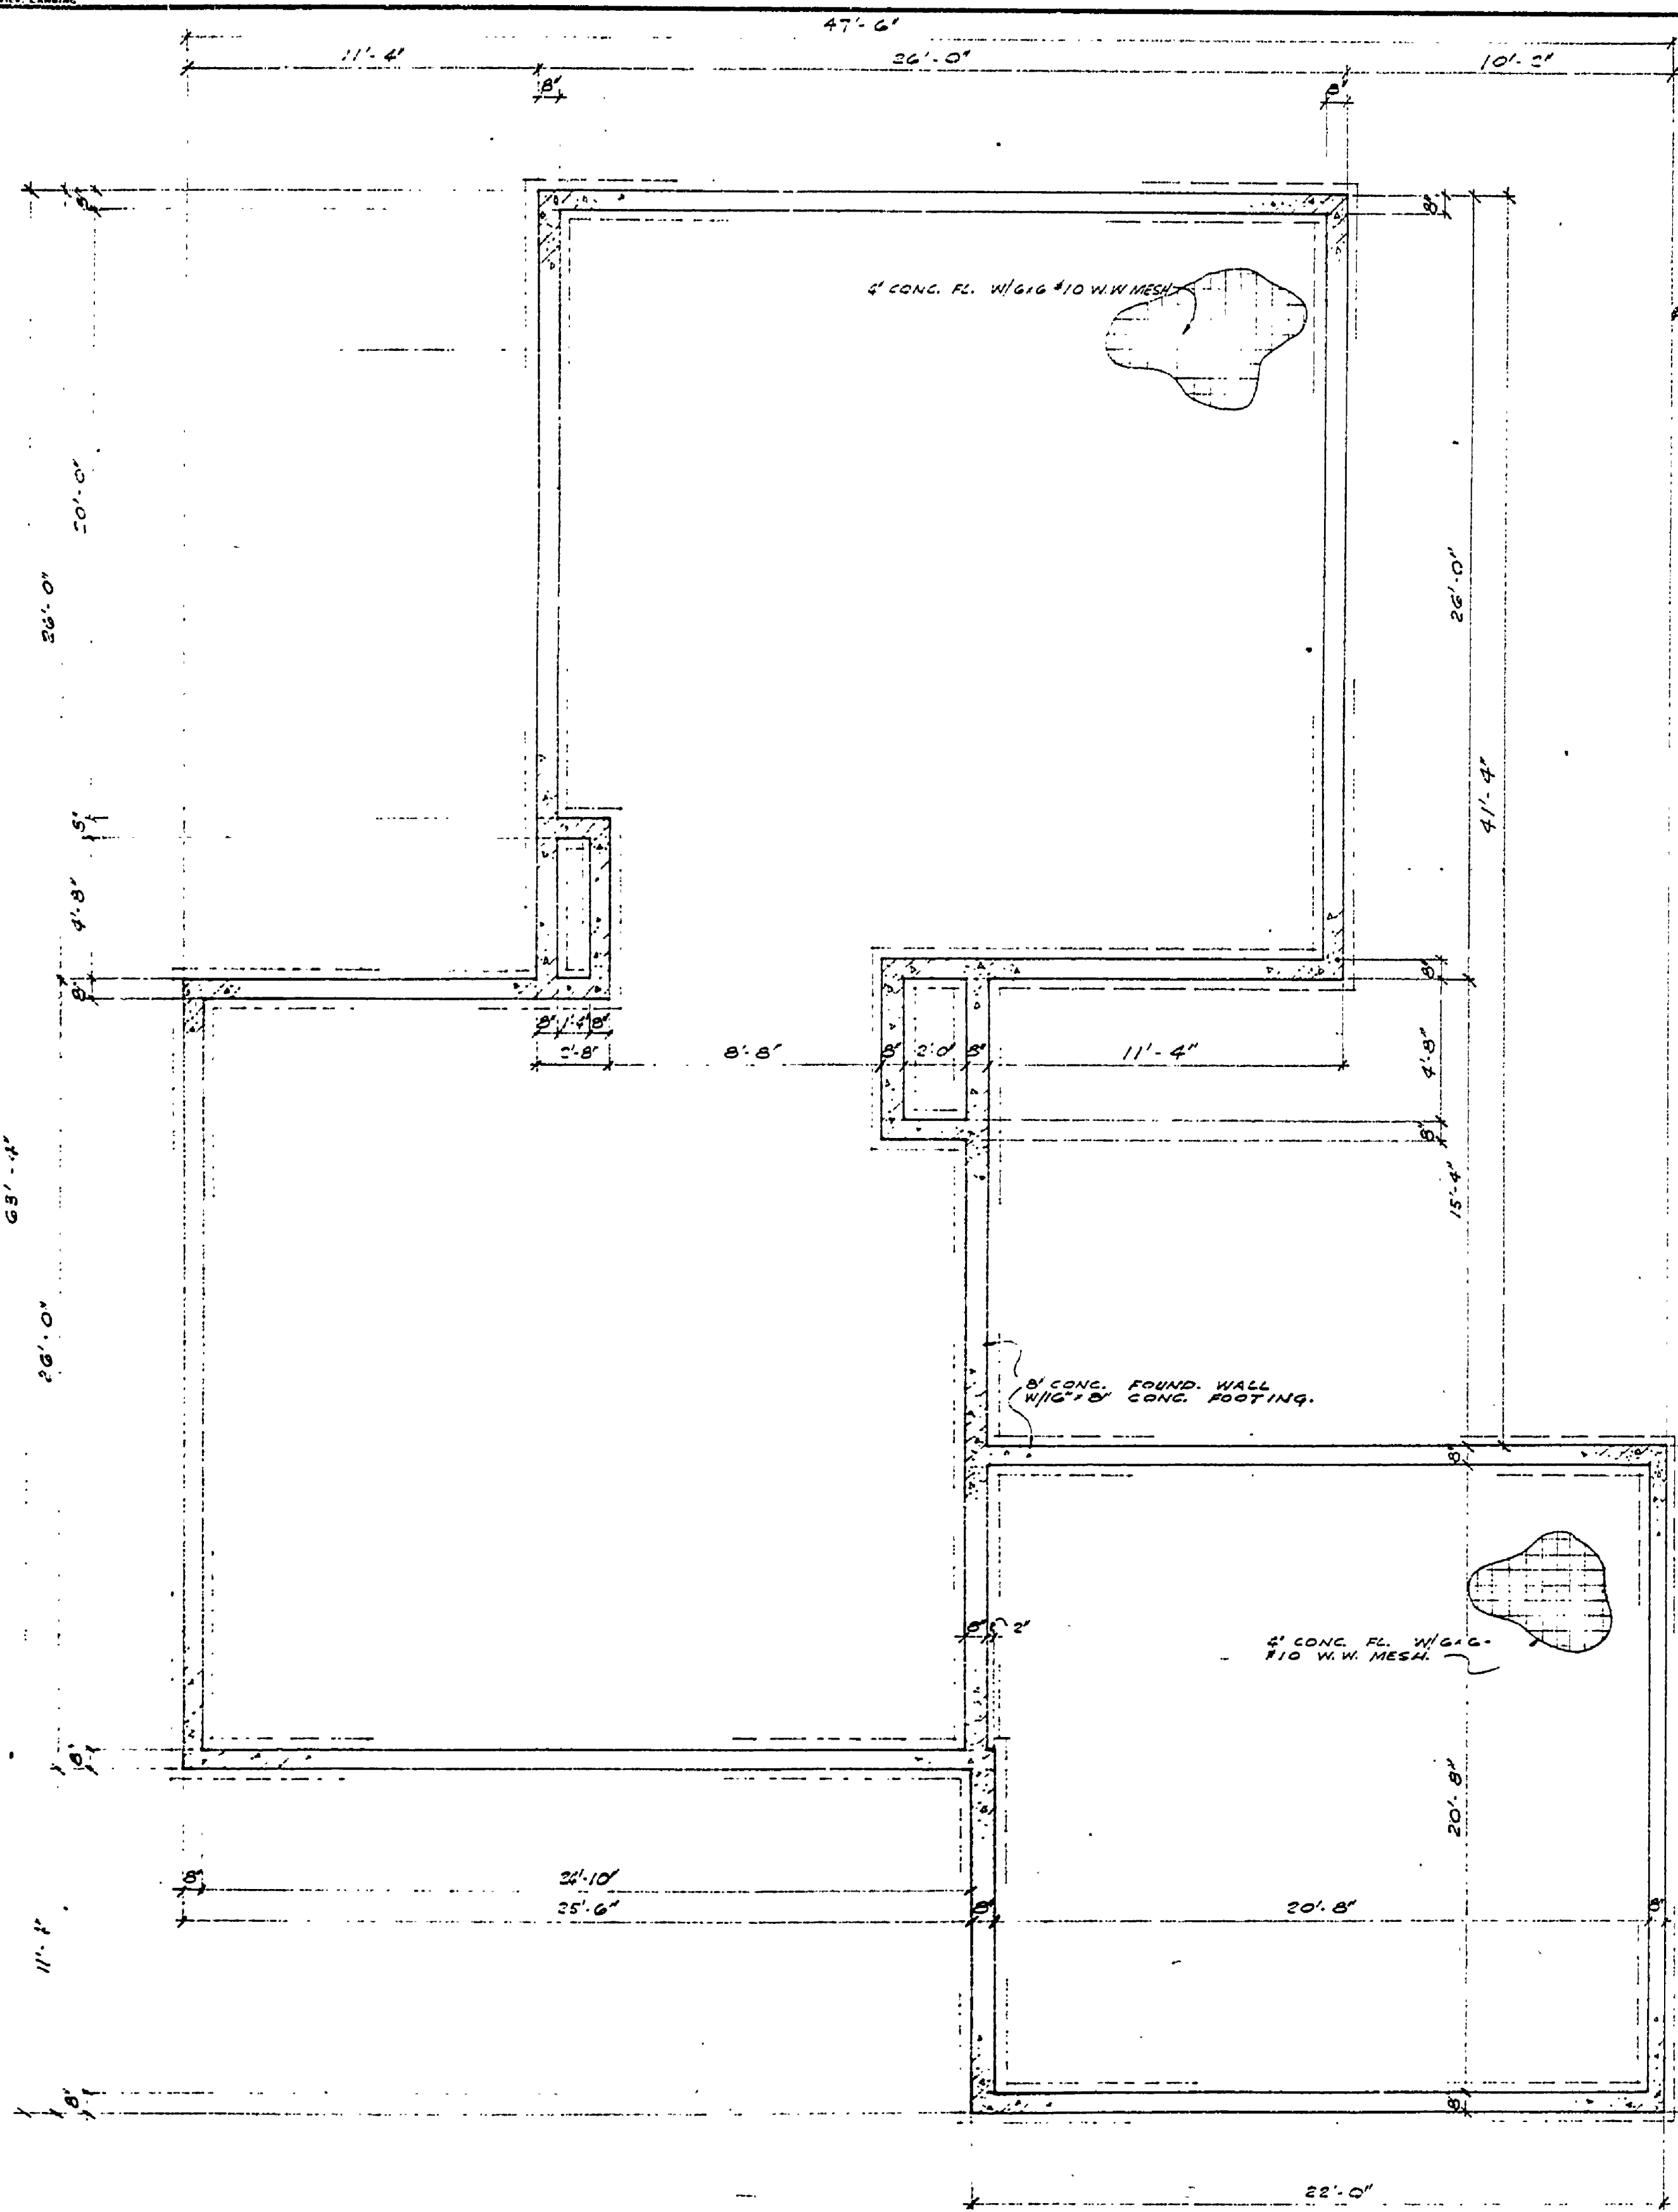


FOUNDATION PLAN
SCALE: 1/4"=1'-0"

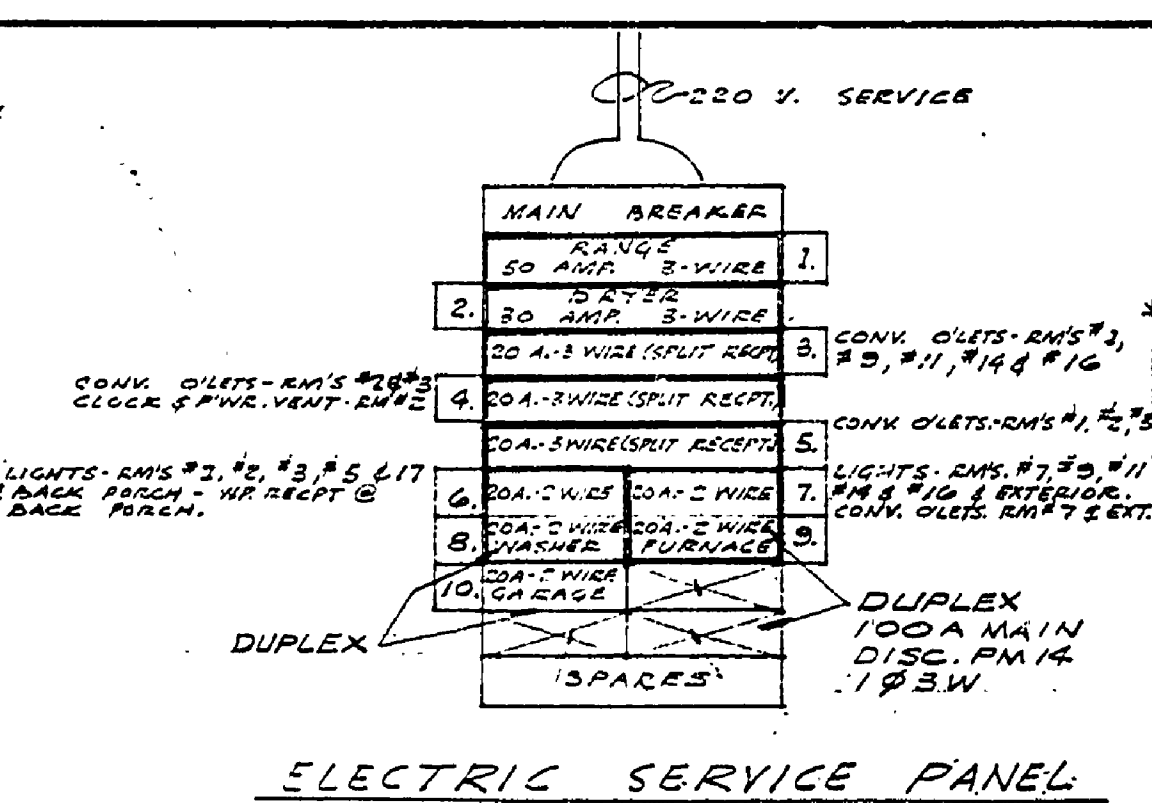


ELECTRIC SERVICE PANEL

ROOM NUMBER	FLOOR	BASE	WALL	CEIL.	TRIM	REMARKS
1. LIVING RM.	•	•	•	•	•	*JOINING AREA
2. KITCHEN	•	•	•	•	•	
3. UTILITY	•	•	•	•	•	*JOINING AREA
4. MECH. CLOS.	•	•	•	•	•	
5. ENTRY	•	•	•	•	•	
6. BENT. CLOS.	•	•	•	•	•	
7. BATH RM.	•	•	•	•	•	
8. LINEN CLOS.	•	•	•	•	•	
9. HALL	•	•	•	•	•	
10. BED ROOM CLOS.	•	•	•	•	•	
11. BED ROOM	•	•	•	•	•	
12. B.R. CLOS.	•	•	•	•	•	
13. B.R. CLOS.	•	•	•	•	•	
14. BED ROOM	•	•	•	•	•	
15. B.R. CLOS.	•	•	•	•	•	
16. BED ROOM	•	•	•	•	•	
17. GARAGE	•	•	•	•	•	

NUMBER	DESIGNATION	SIZE	REMARKS	
	THICKNESS	WIDTH	HEIGHT	
1A	1 1/2"	36"	80"	METAL THRESHOLD
2A	1 1/2"	36"	80"	METAL THRESHOLD
3C	1 1/2"	28"	80"	
4C	1 1/2"	28"	80"	
5B	1 1/2"	28"	80"	
6B	1 1/2"	28"	80"	
7B	1 1/2"	28"	80"	
8B	1 1/2"	28"	80"	
9B	1 1/2"	28"	80"	
10B	1 1/2"	28"	80"	
11D	1 1/2"	36"	80"	1/2 FOLD - 4 REQD. 65 NOM. OPD.
12D	1 1/2"	36"	80"	1/2 FOLD - 4 REQD. 52 NOM. OPD.
13D	1 1/2"	36"	80"	1/2 FOLD - 4 REQD. 55 NOM. OPD.
14D	1 1/2"	36"	80"	1/2 FOLD - 4 REQD. 48 NOM. OPD.
15A	3/4"	36"	80"	1/2 PAIR FWD. DES.
16A	1 1/2"	28"	80"	METAL THRESHOLD
17B	1 1/2"	36"	80"	
18E	1 1/2"	36"	80"	
19A	1 1/2"	28"	80"	WIDENING LITE

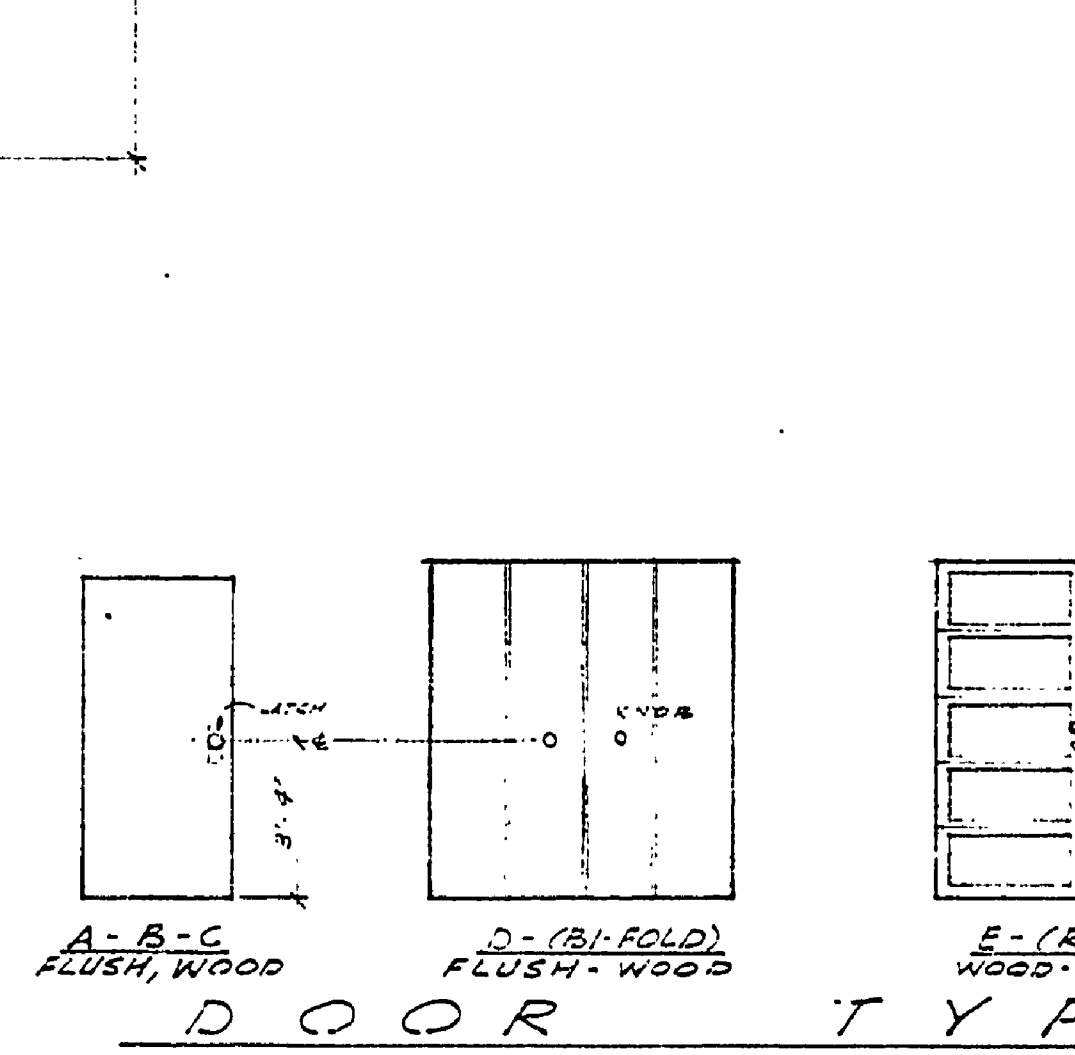


DOOR TYPES

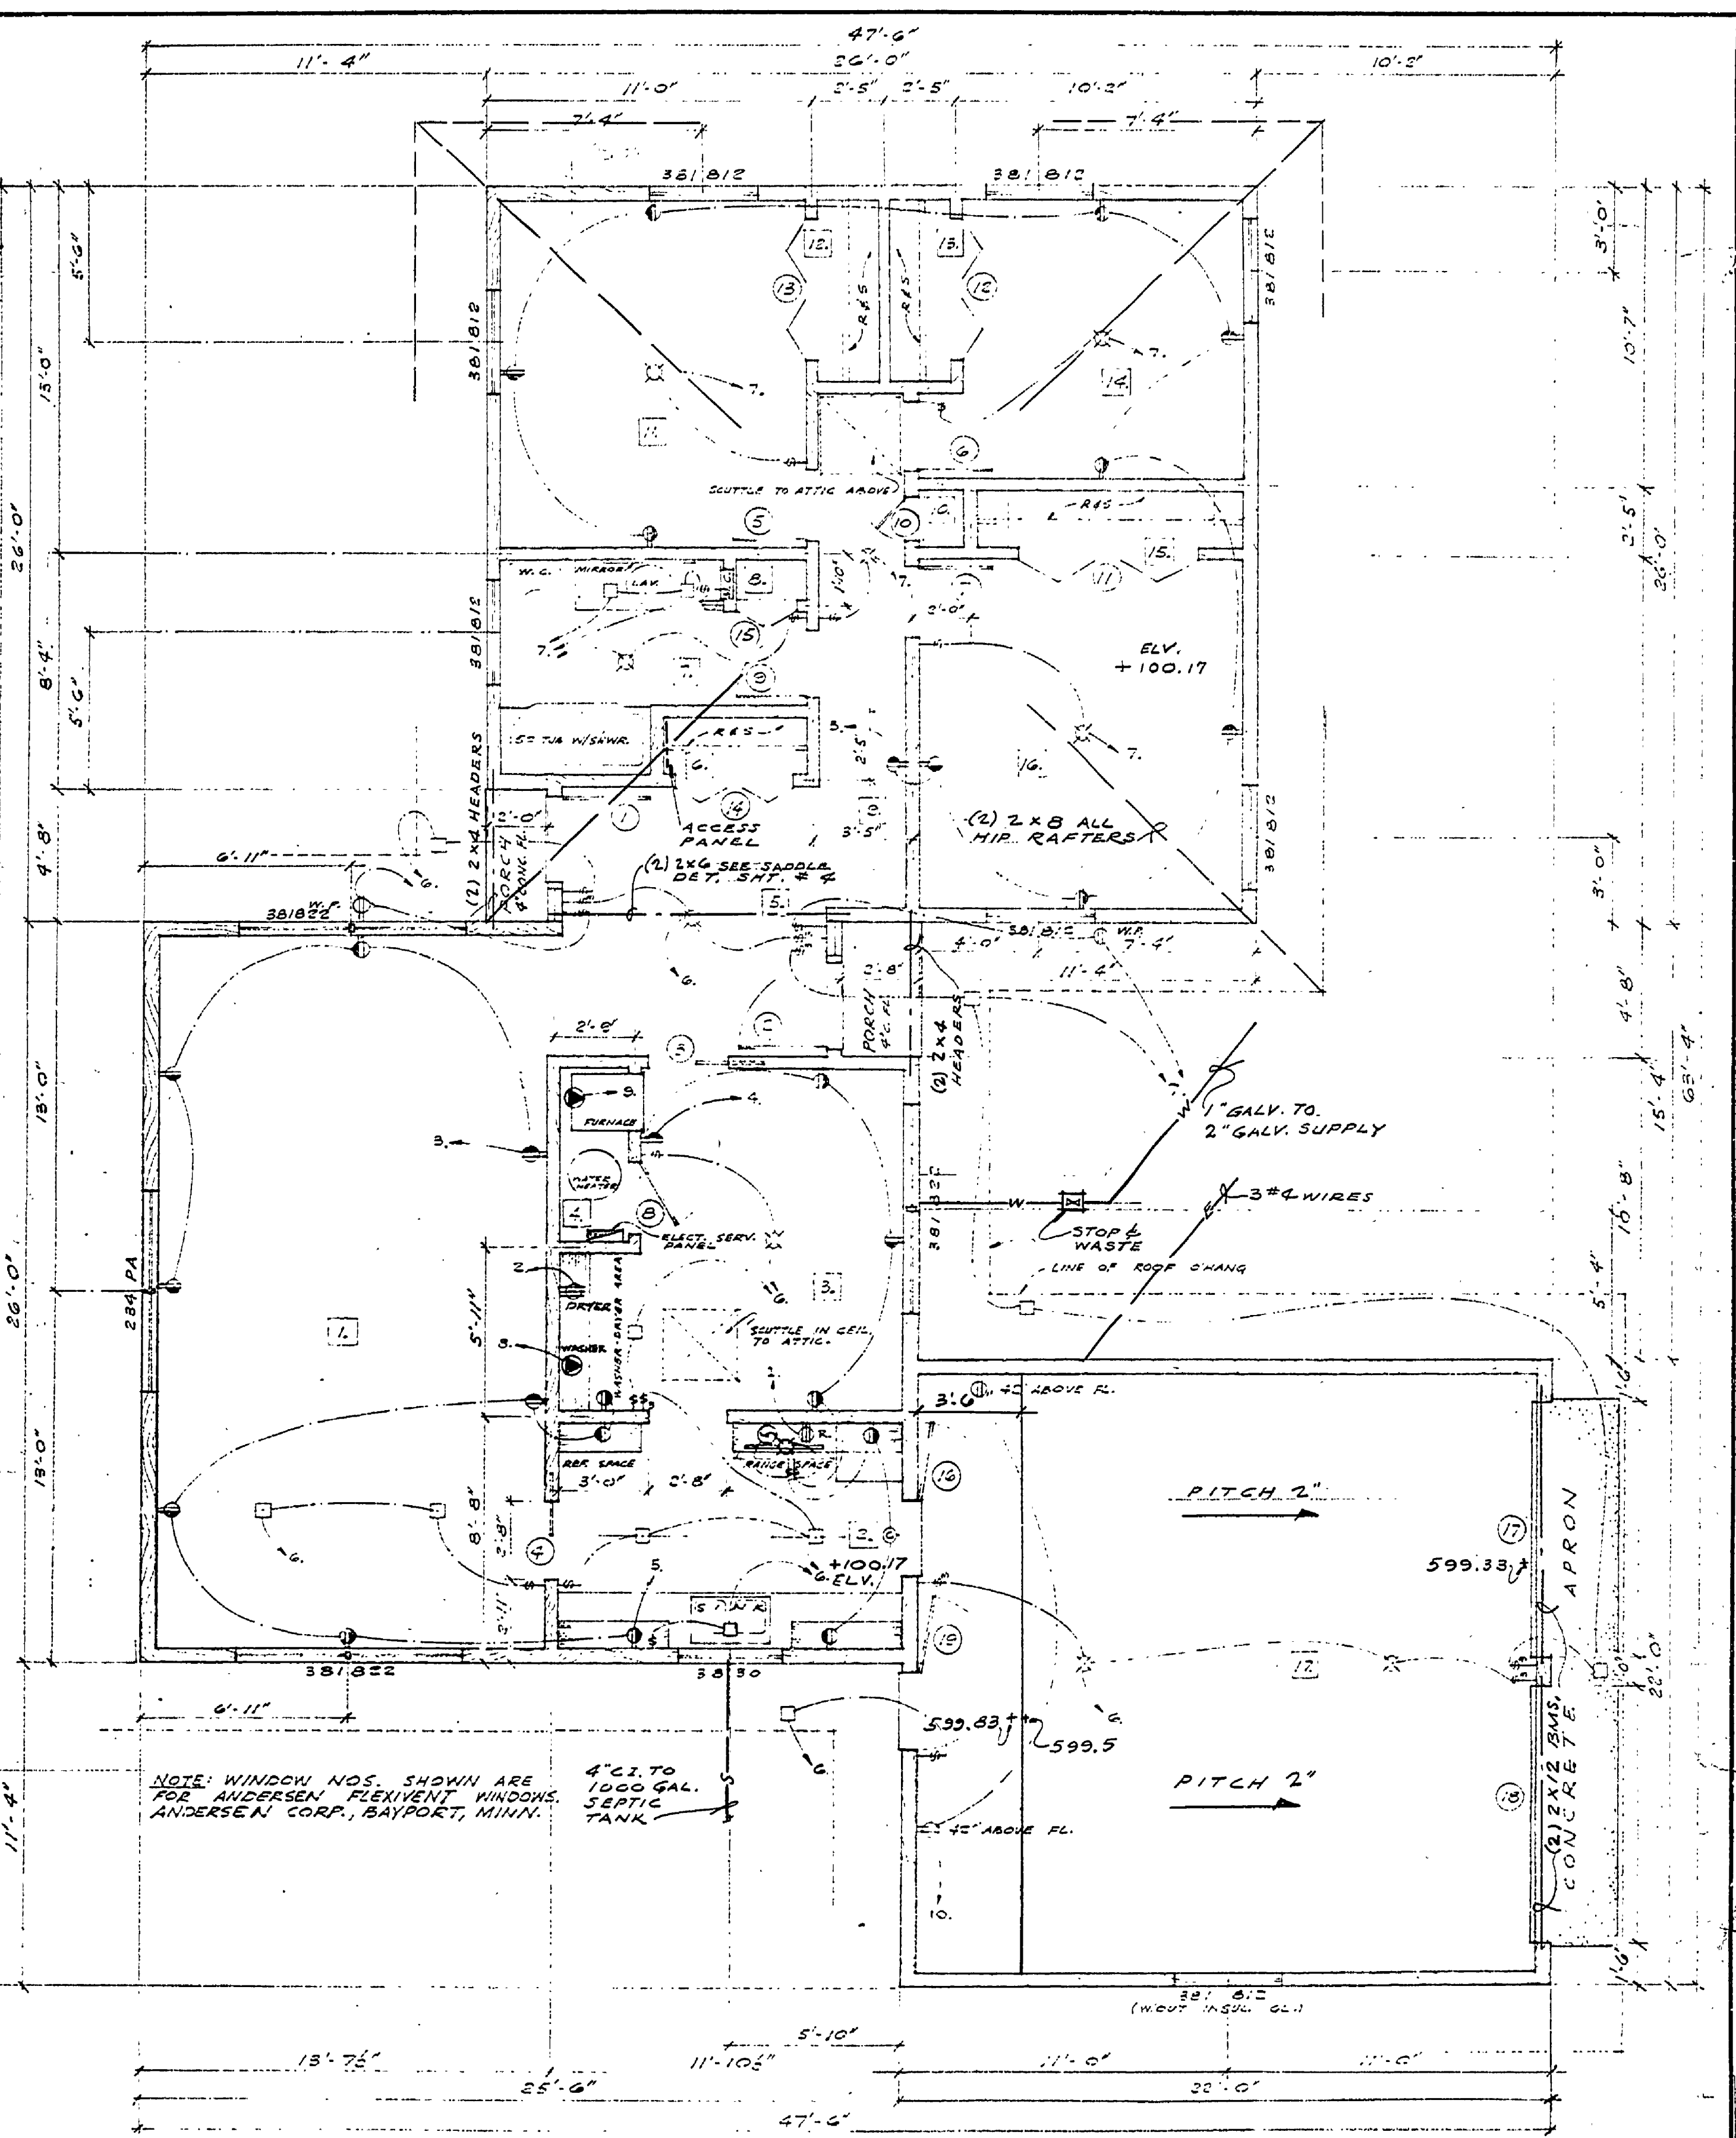

FLOOR PLAN
SCALE: 1/4"=1'-0"

ELECTRICAL SYMBOLS

- CEILING FIXTURE
- CEILING FIXTURE (RECESSED)
- CONDUIT (SPLIT WIRE)
- CONV. GLET (WEATHERPROOF)
- CONV. GLET (W/WEATHERPROOF)
- RANGE
- WASHER GLET
- DISHWASHER GLET
- FURNACE GLET
- CLOCK GLET
- EXHAUST FAN
- ELECT. SERVICE PANEL

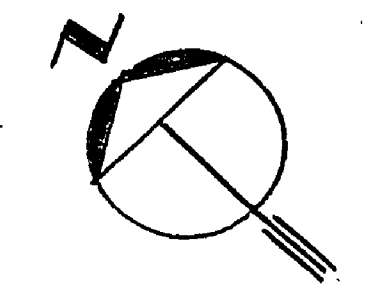

Sheet 4 of 8