



DESIGNED BY	10-59	ARCHITECTURAL
DRAWN BY	10-59	ENGINEERING
CHECKED BY		LANDSCAPE
REVIEWED		
APPROVED		
DATE		
NO.		
BY		
REVISIONS		
4		
3		
2		
1		

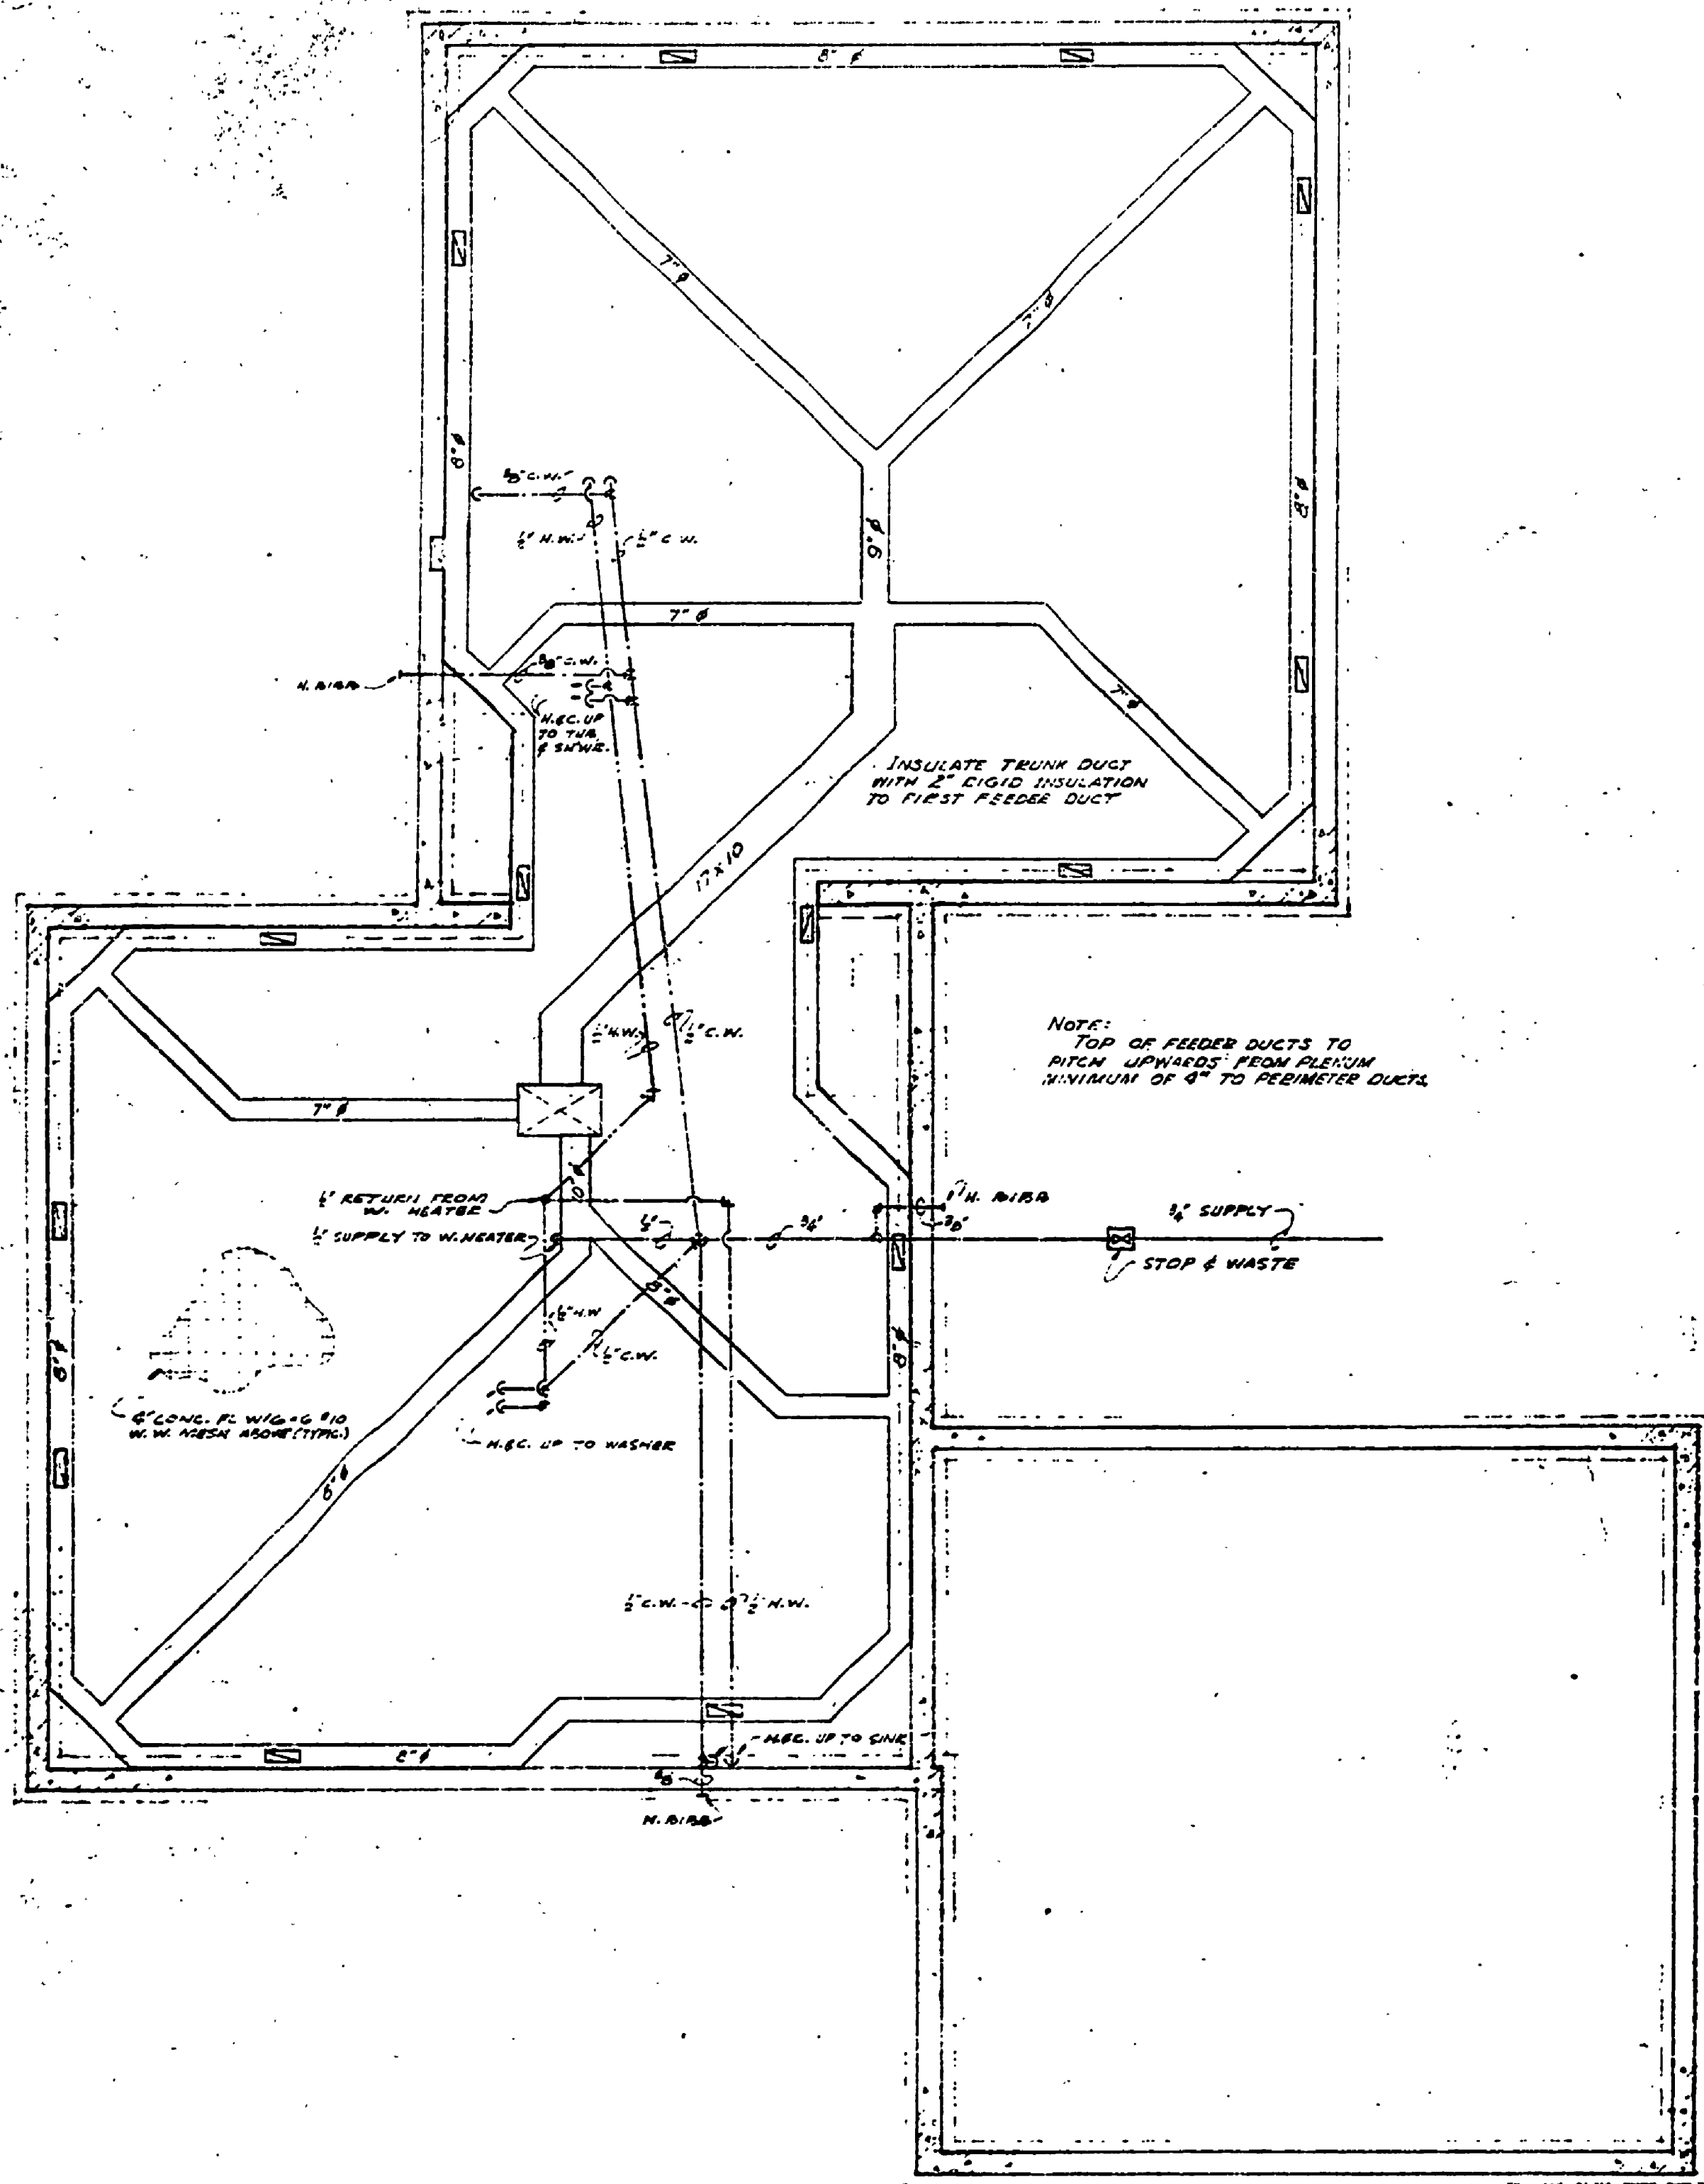

U.G. - HEATING & W. SUPPLY
REVERSE PLAN

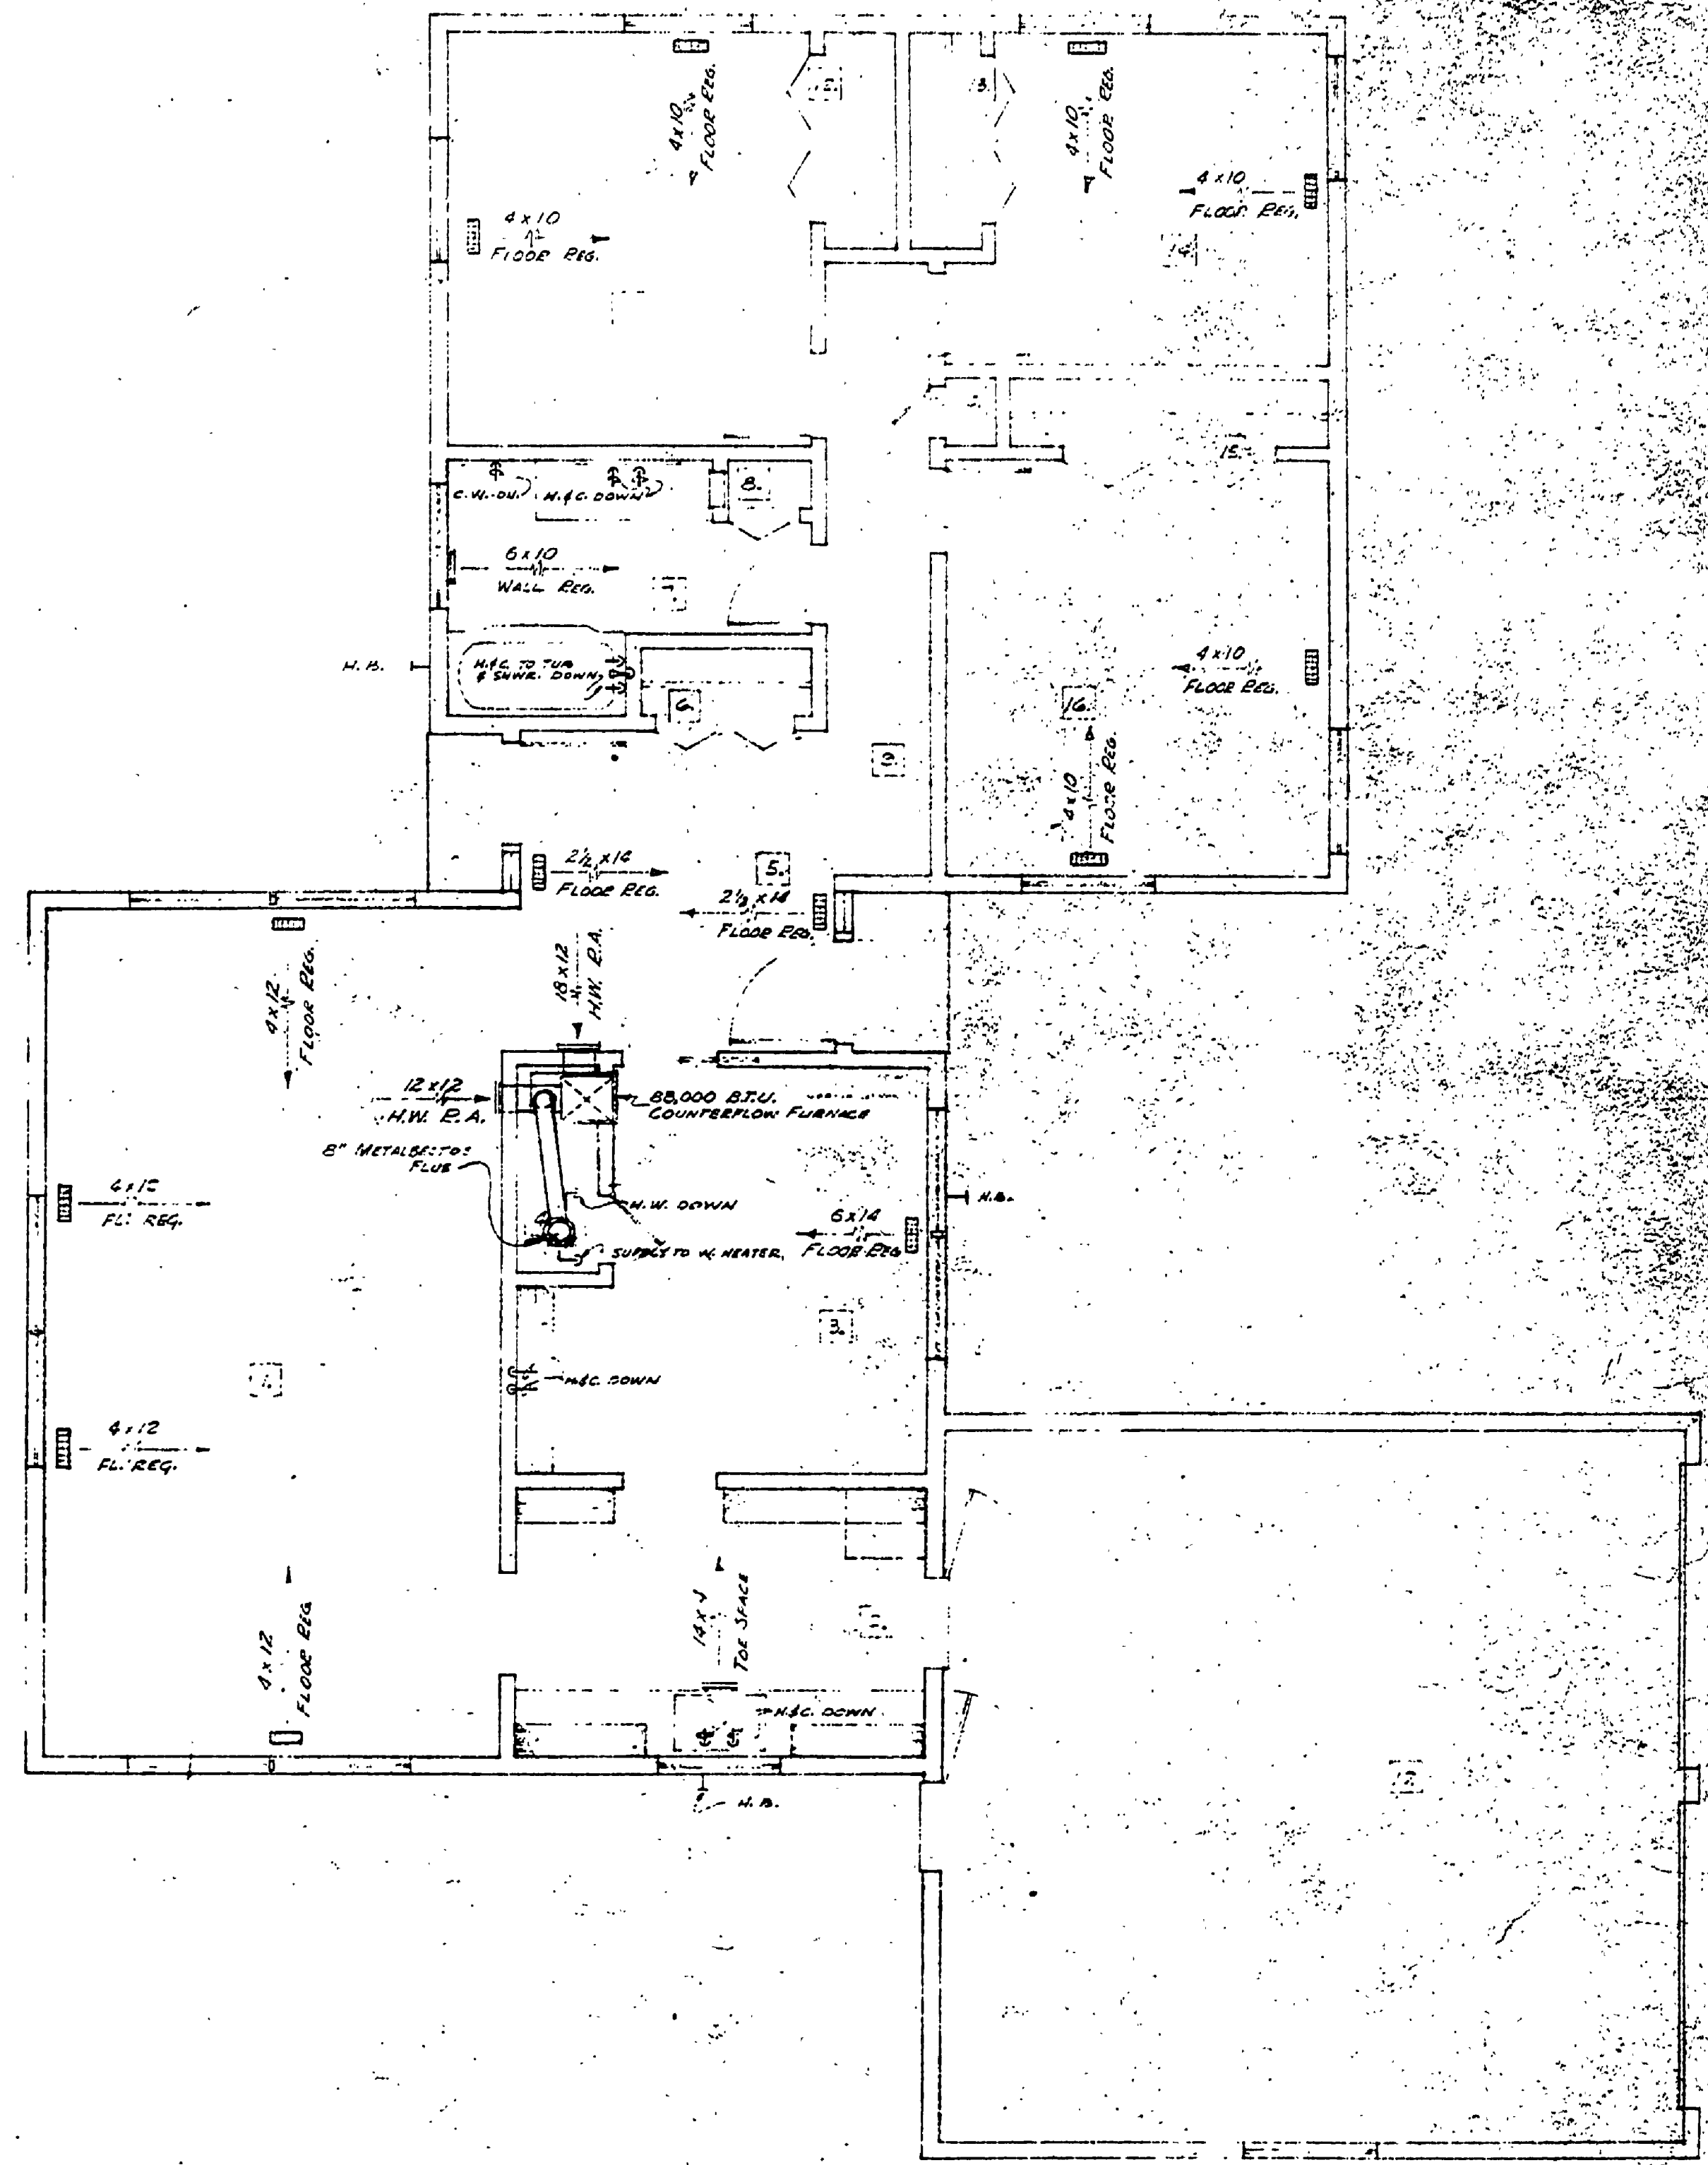

FLOOR PLAN - HEATING & W. SUPPLY
REVERSE PLAN

SLEEPER STATE PARK
RESIDENCE

MICHIGAN
DEPARTMENT OF CONSERVATION
PARKS AND RECREATION DIVISION

MECHANICAL
HEATING & PLUMBING
1060 PROJ.

SHEET
NO. 6
OF 6

173