




DESIGNED BY	DATE	REVIEWED	DATE	APPROVED	DATE	NO.	DATE	BY
ARCHITECTURAL	1/11/51					1		
ENGINEERING	1/11/51					2		
LANDSCAPE	1/11/51					3		

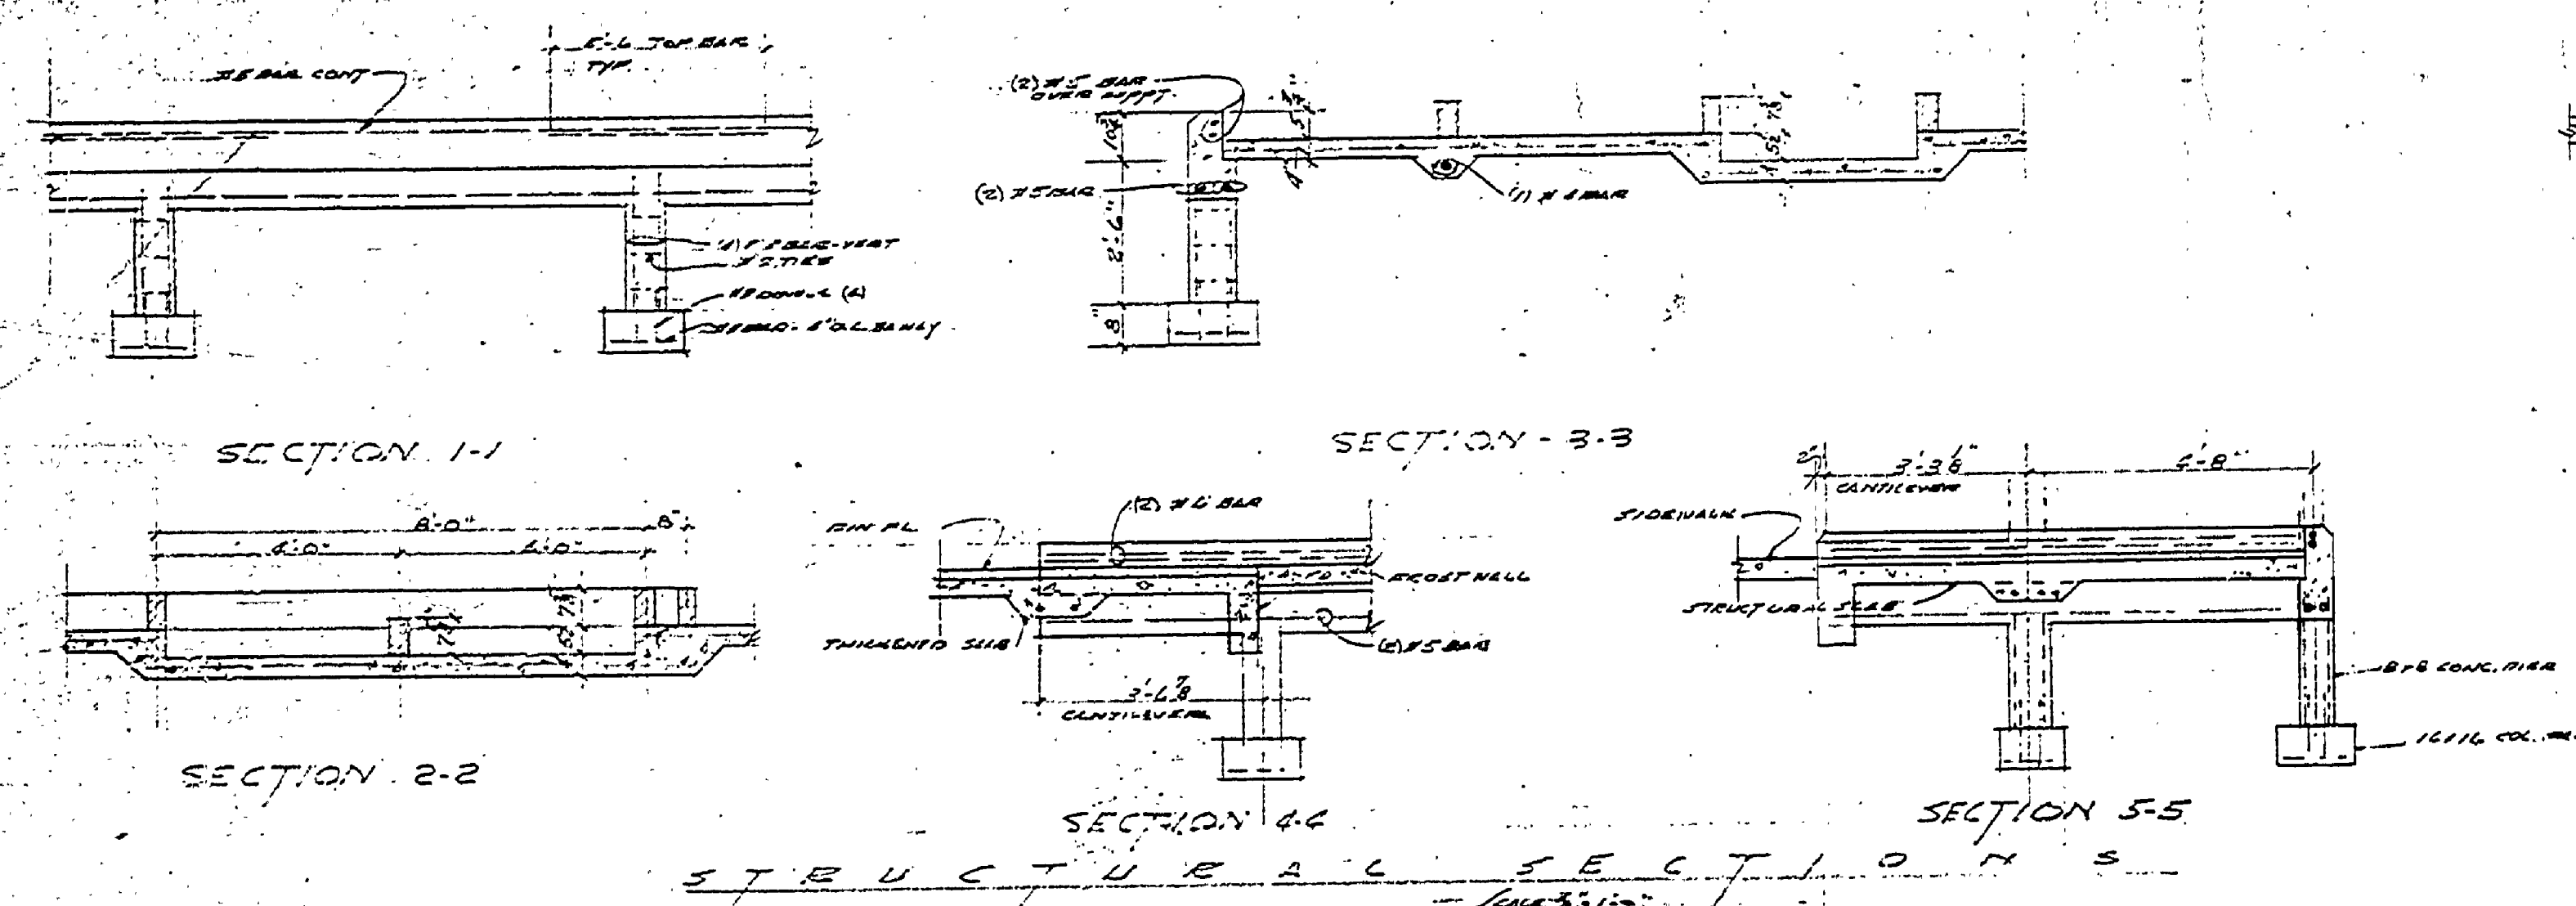



STRUCTURAL SECTIONS

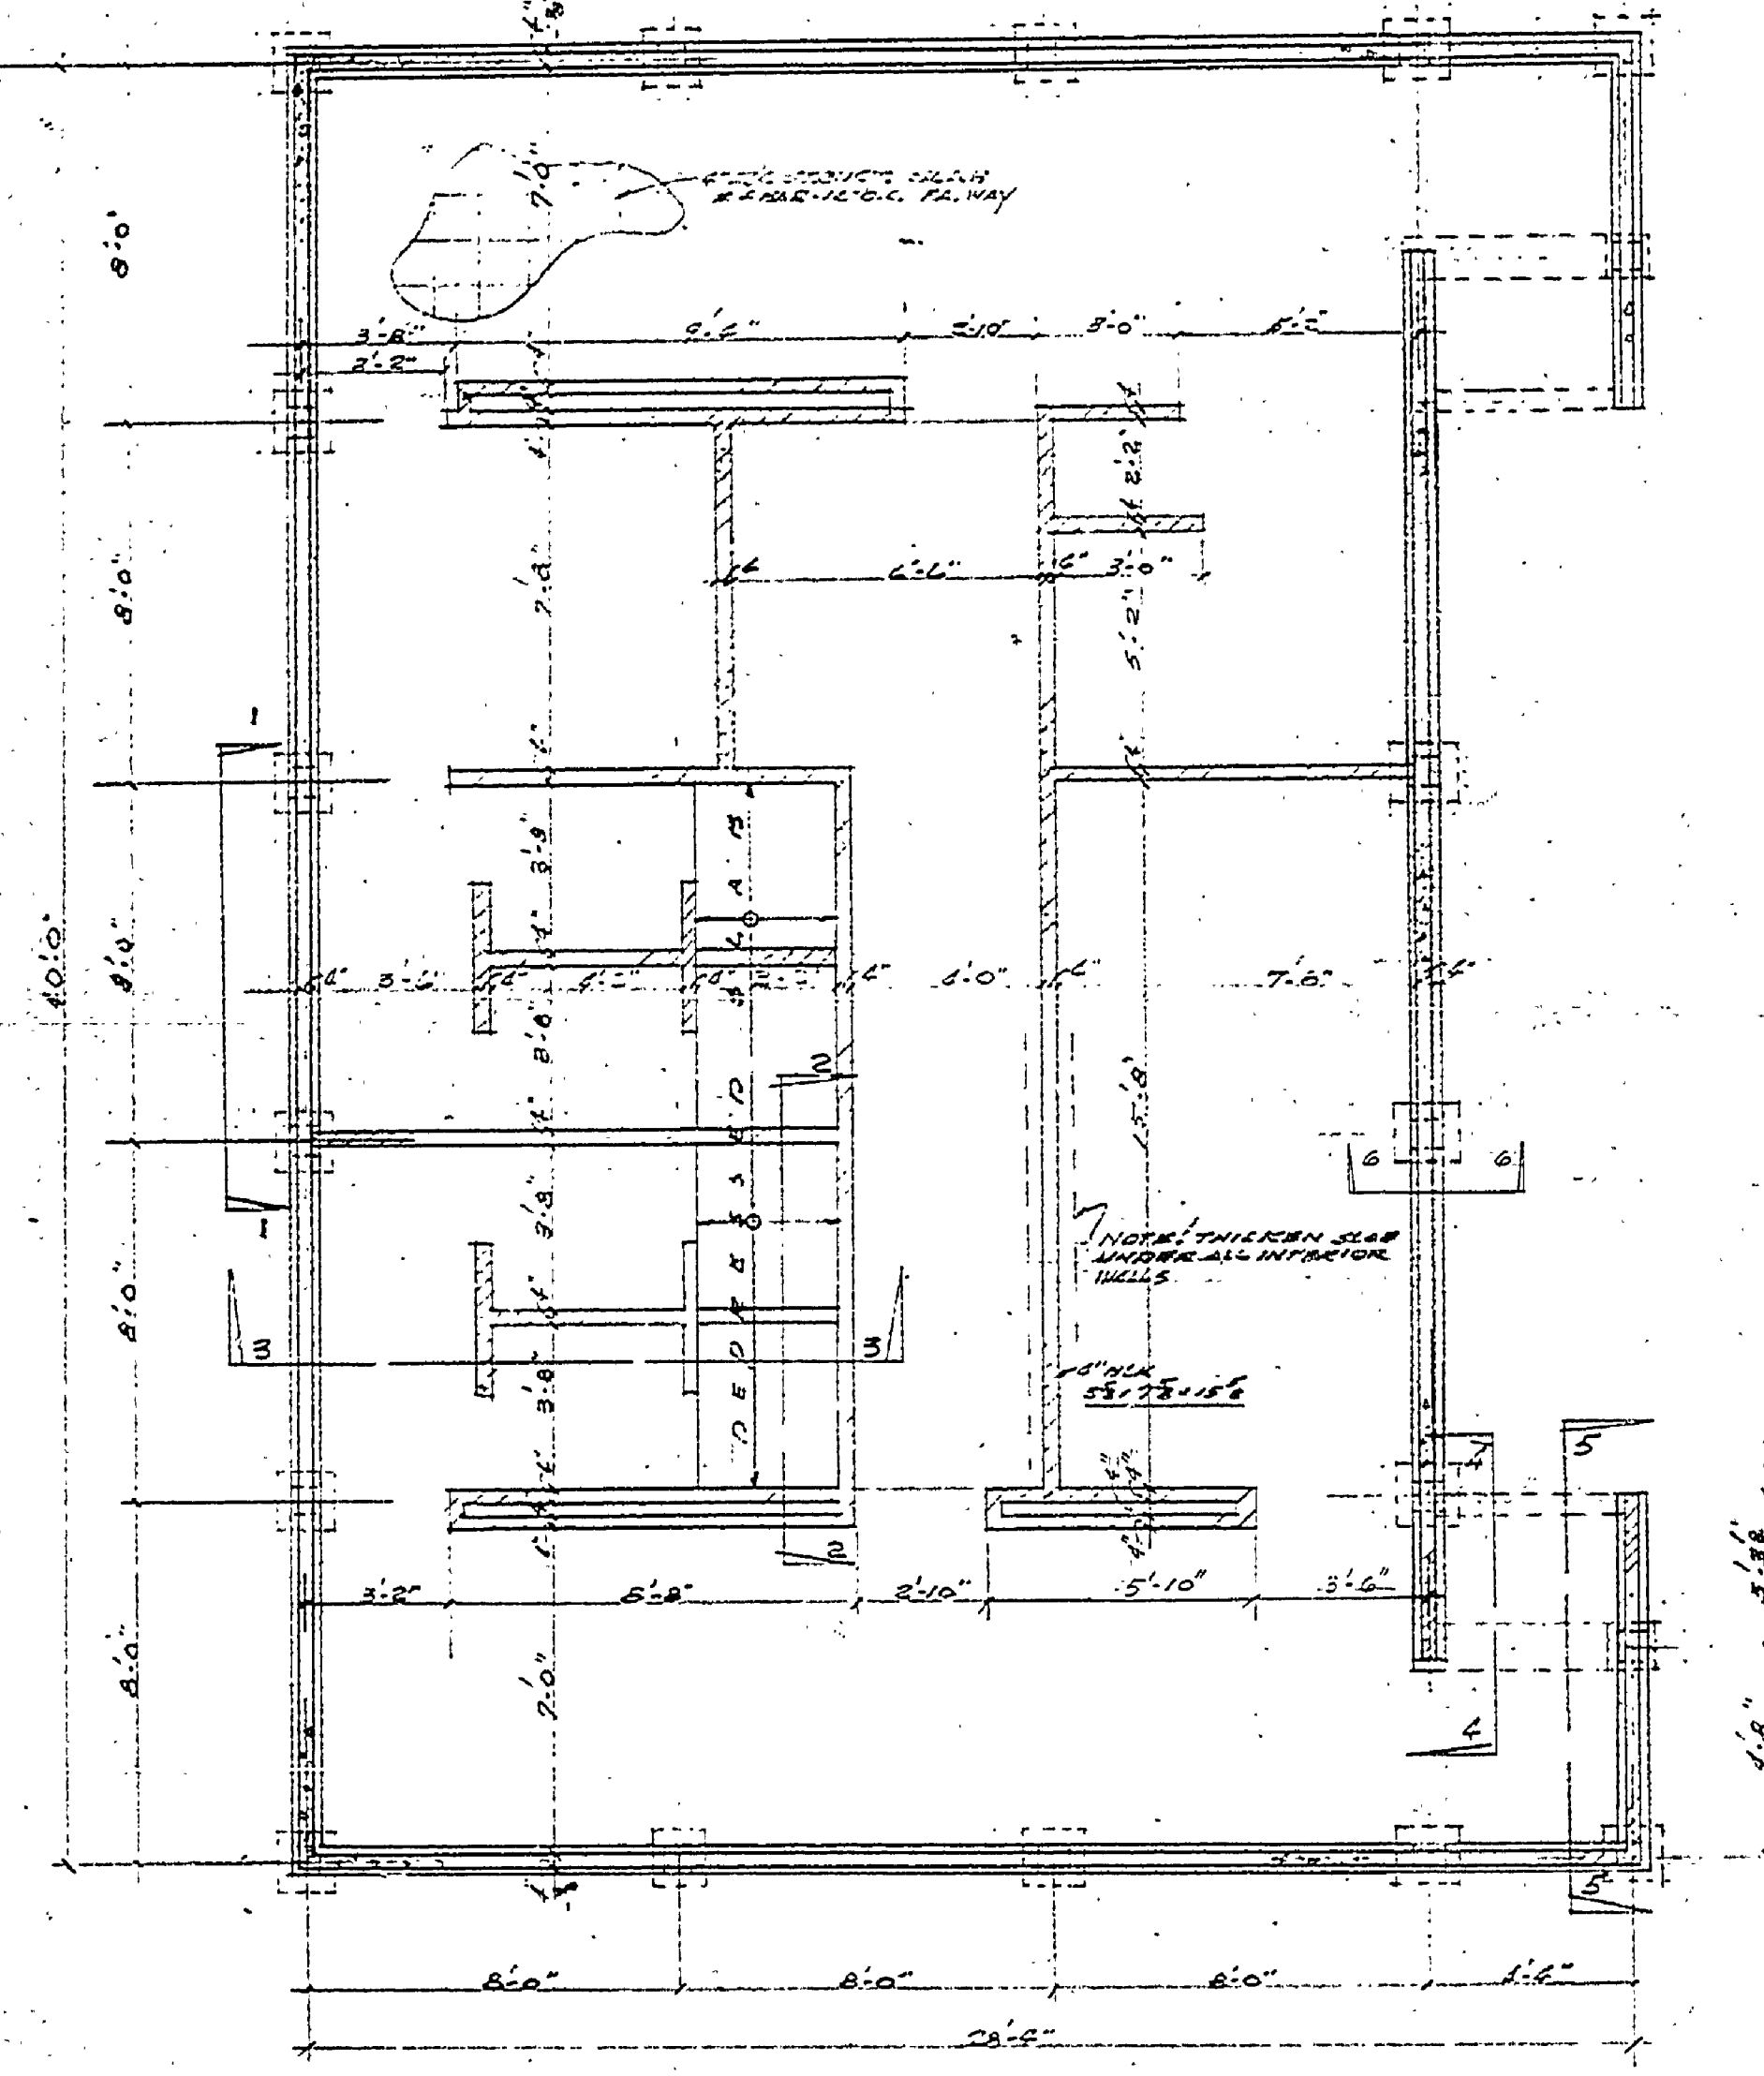

FOUNDATION PLAN

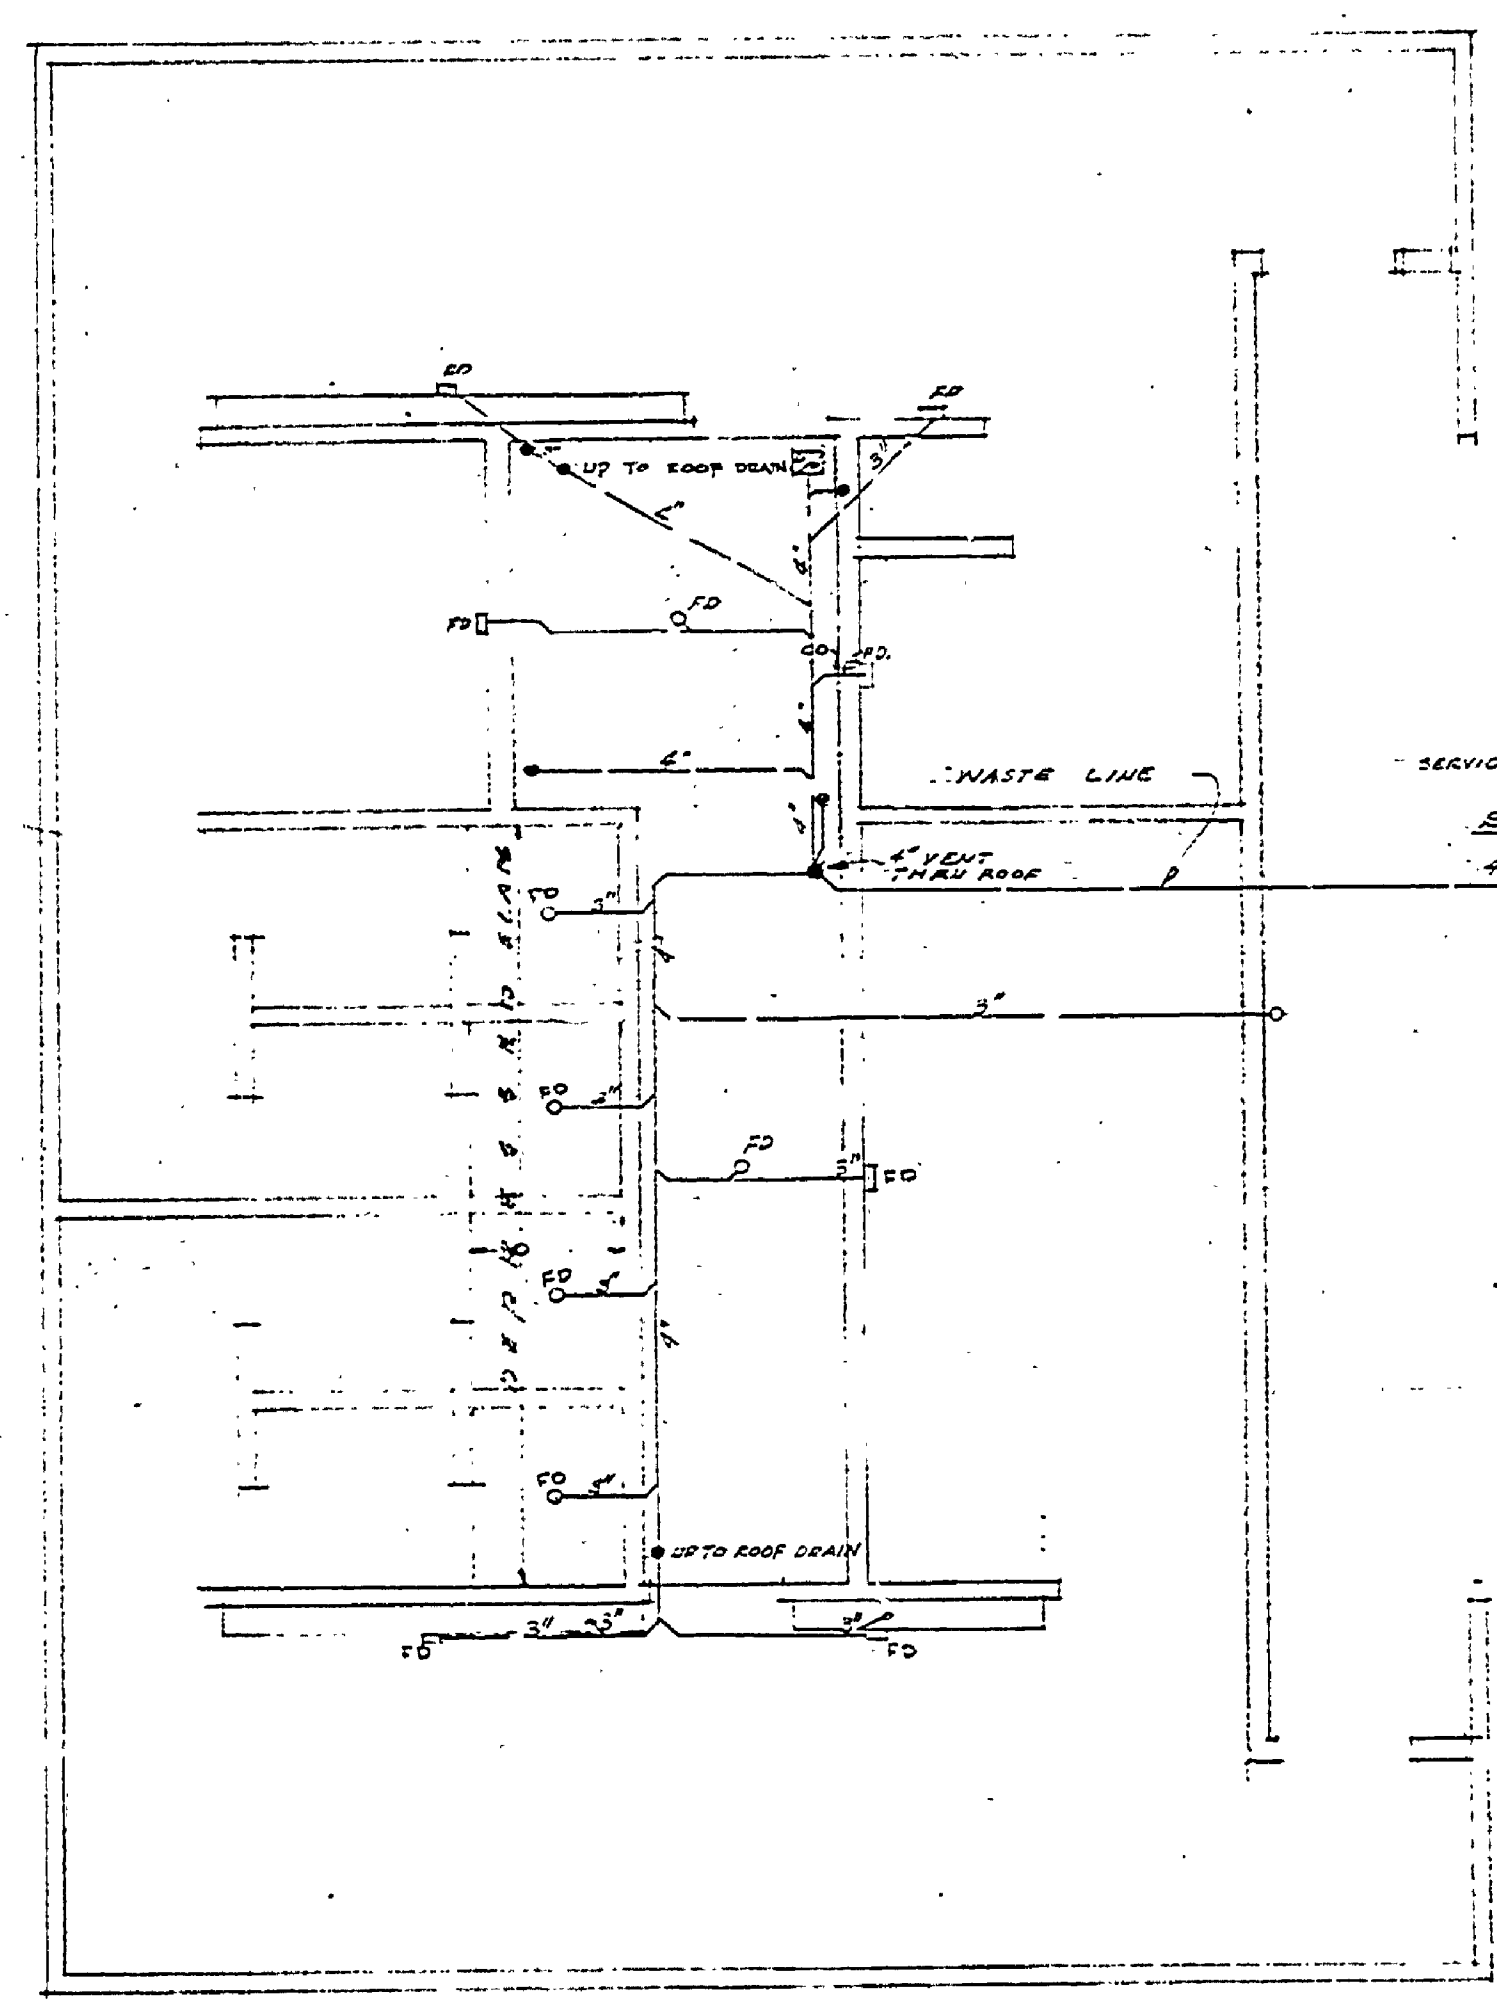

PLUMBING PLAN

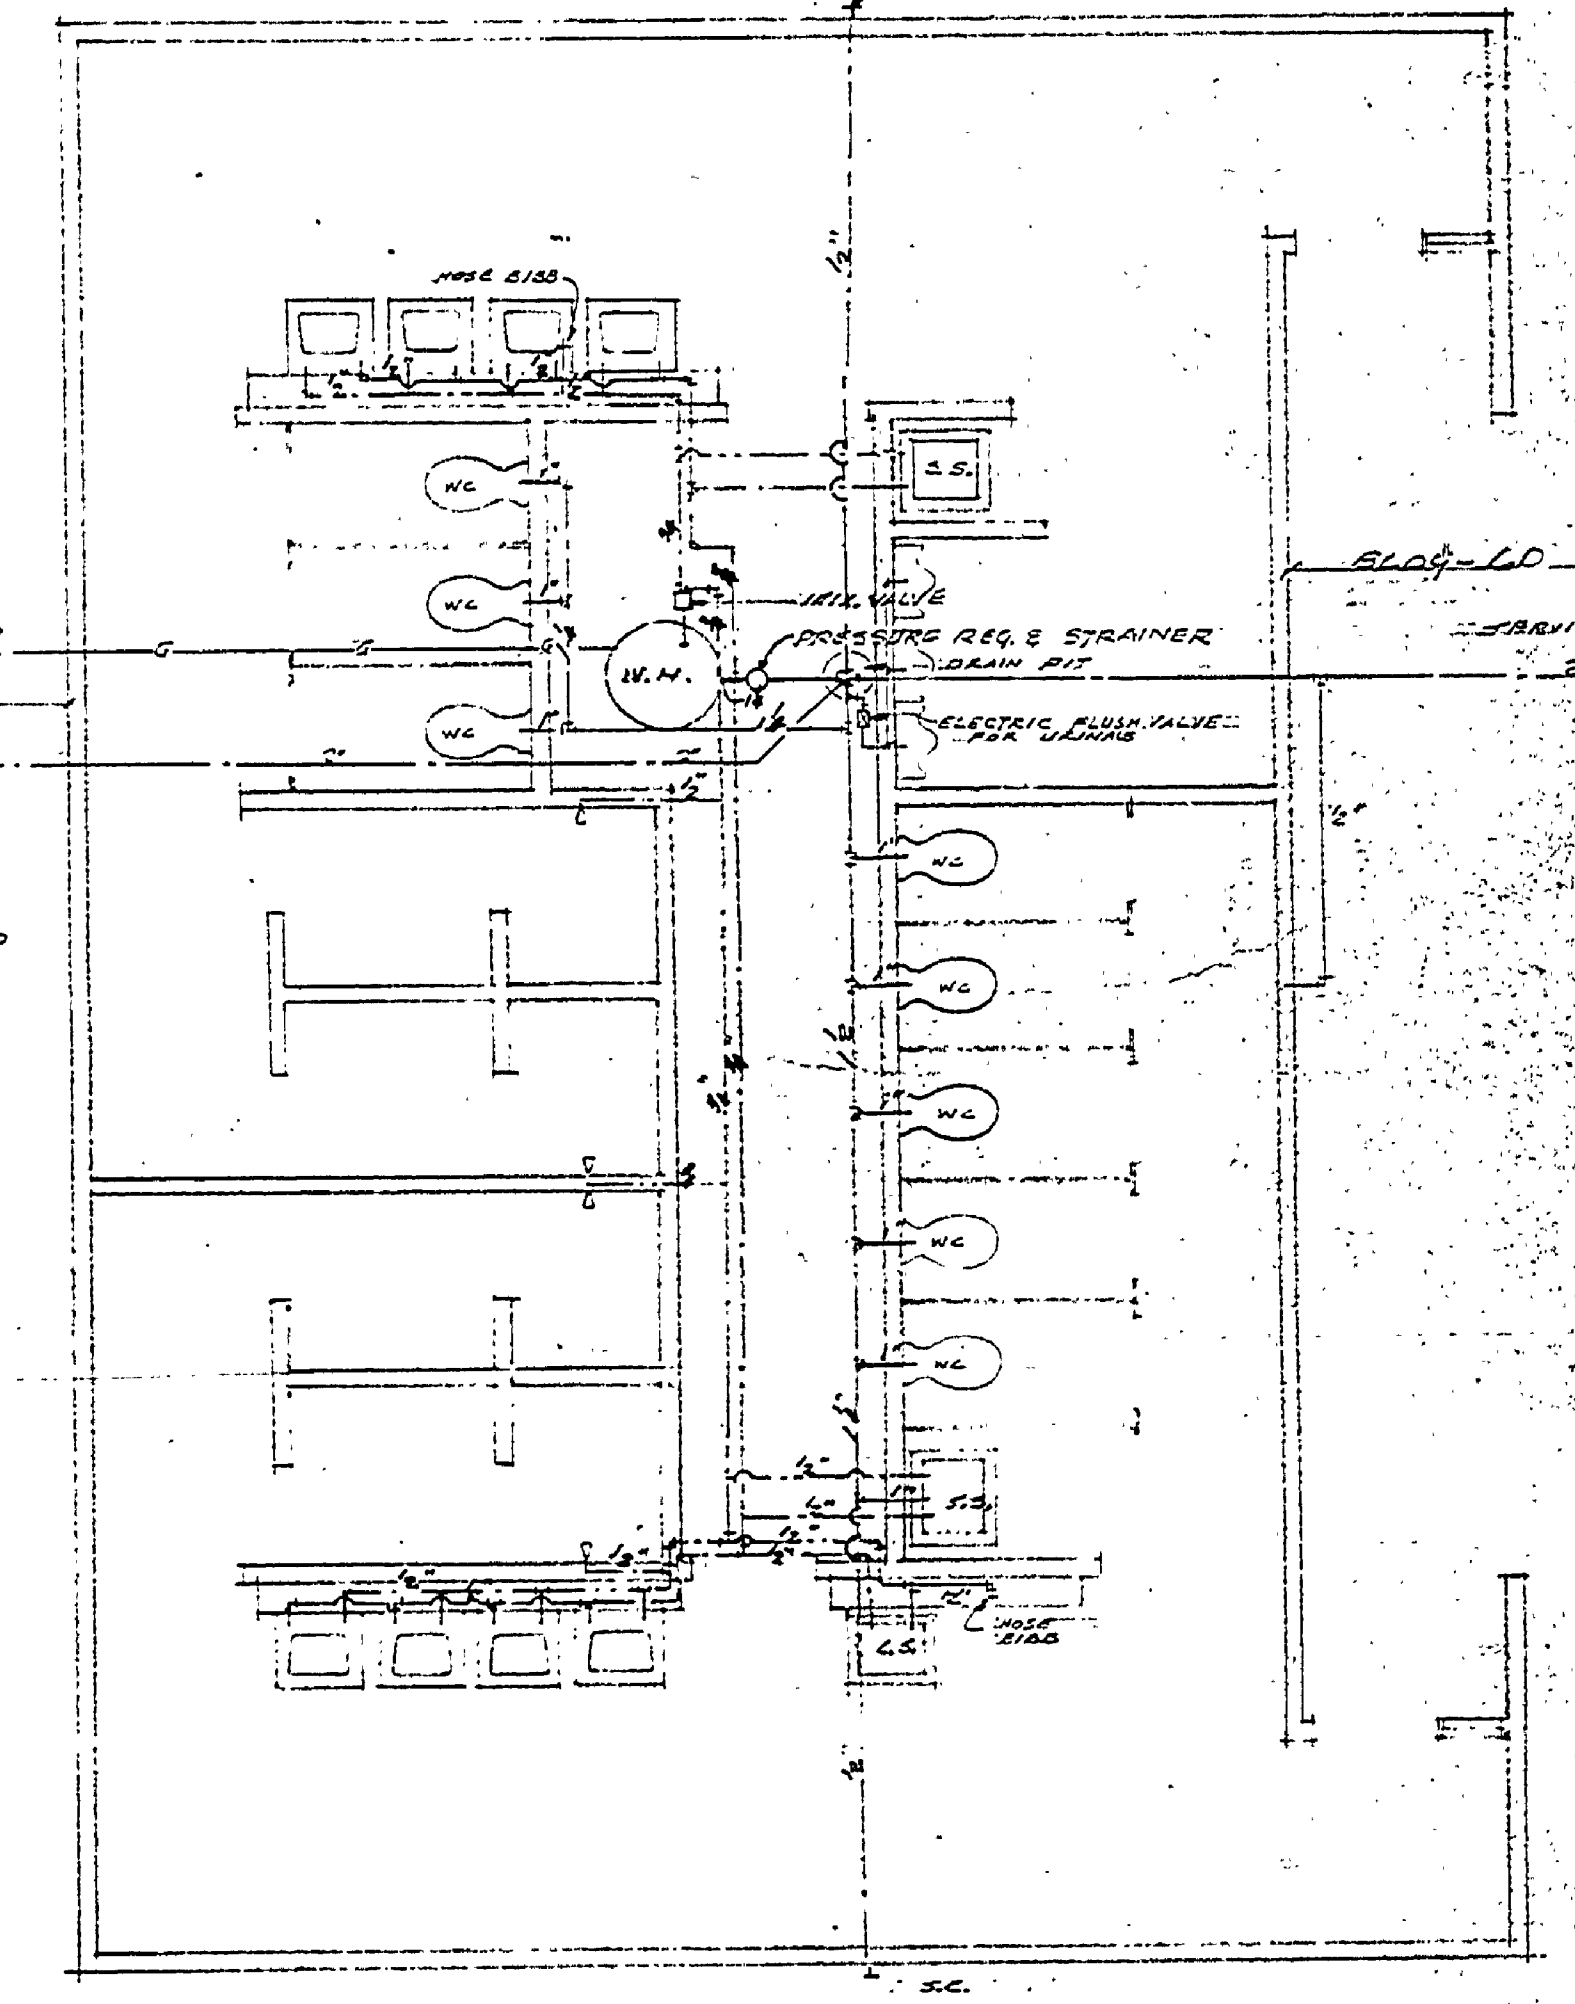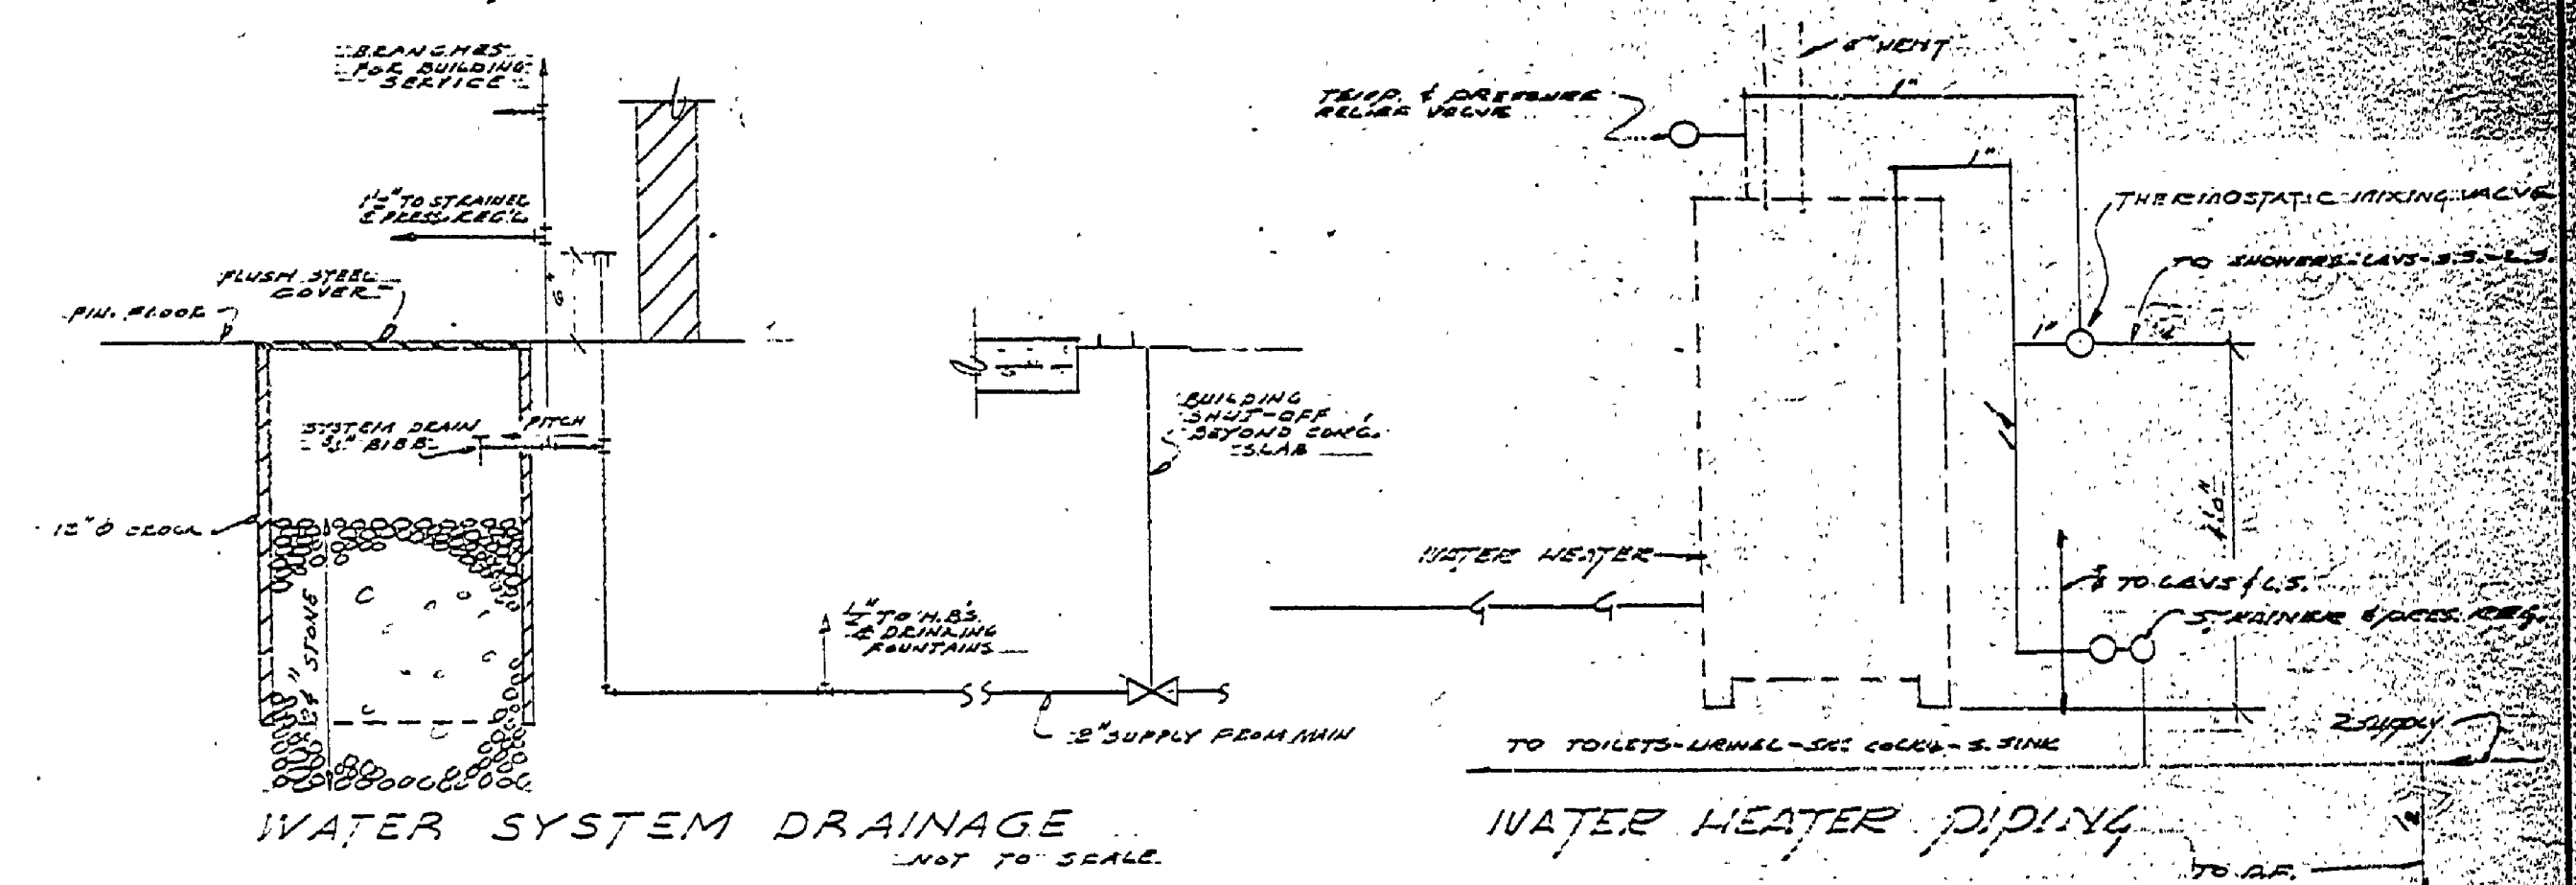

PLUMBING PLAN

MICHIGAN
DEPARTMENT OF CONSERVATION
PARKS AND RECREATION DIVISION

FOUNDATION PLAN - PLUMBING PLANS		PLAN NO.	
HIGGINS LAKE STATE PARK		A-105	
TOILET AND SHOWER BUILDING-6066C		SHEET NO.	OF
		2	5