




DESIGNED BY: N.A.M. & S.P.	DATE: 2-11-41	REVIEWED: 8-1-41	DATE: 1-10-43	APPROVED: [Signature]	DATE: 2-17-43	NO. 1	DATE: 1/12/43	BY: W.P.	REVISIONS: 4
DRAWN BY: S.P.	DATE: 2-11-41	REVIEWED: 8-1-41	DATE: 1-11-43	APPROVED: [Signature]	DATE: 2-17-43	NO. 2	DATE: 1/12/43	BY: W.P.	REVISIONS: 5
CHECKED BY: P.L.	DATE: 8-17-41	REVIEWED: 8-1-41	DATE: 1-11-43	APPROVED: [Signature]	DATE: 2-17-43	NO. 3	DATE: 1/12/43	BY: W.P.	REVISIONS: 6

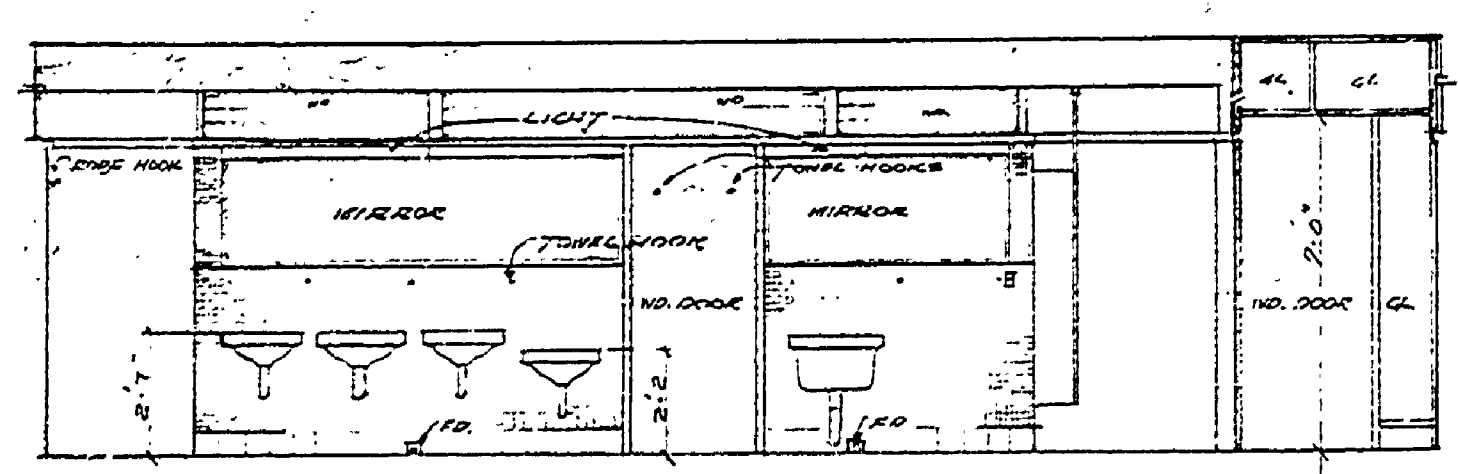


EAST INTERIOR ELEV. - WOMEN'S TOILET

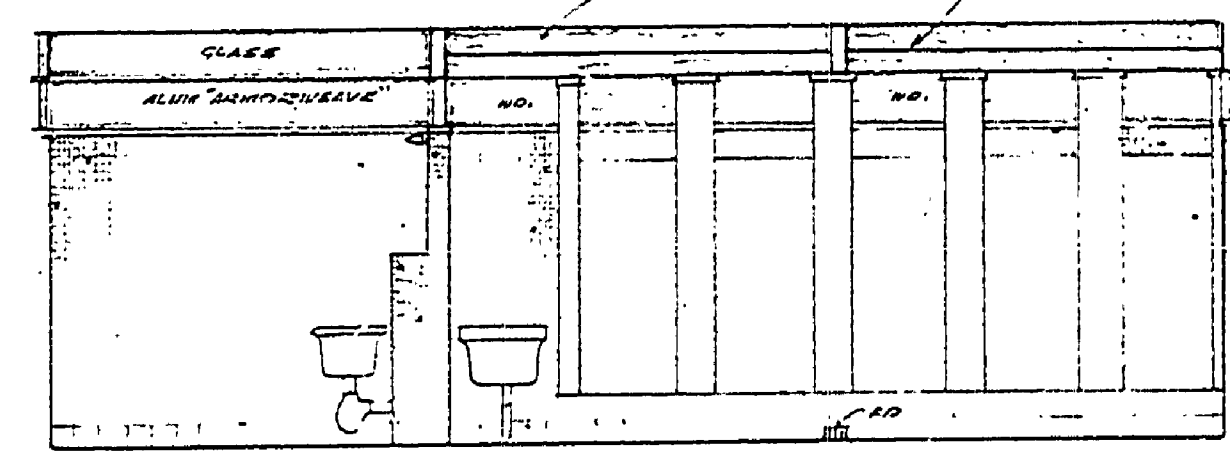


NORTH INTERIOR ELEV. - WOMEN'S TOILET

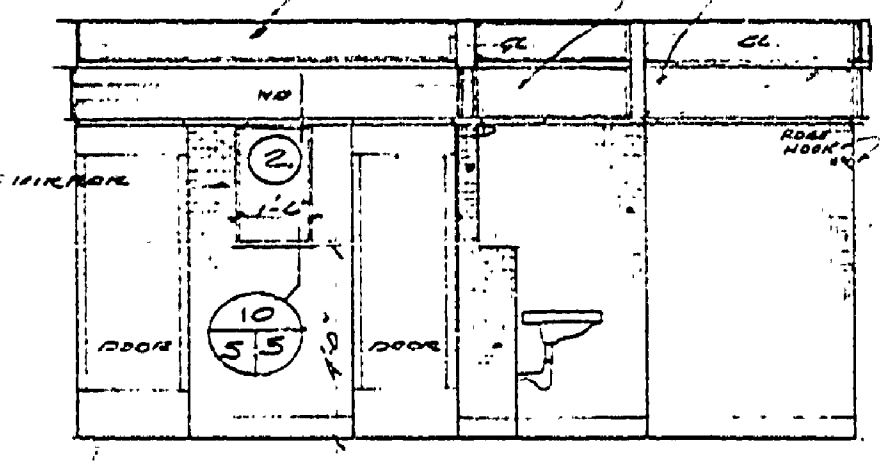


SOUTH INT. ELEV. - WOMEN'S TOILET

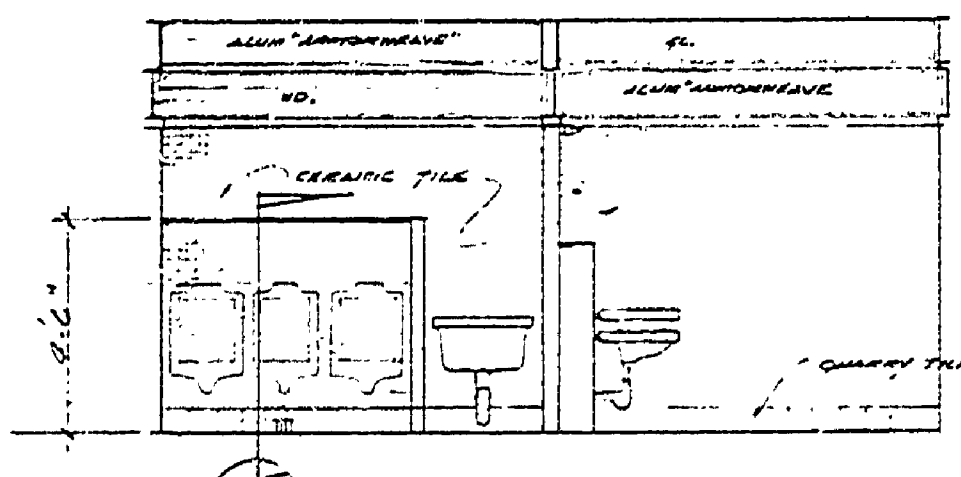






NORTH INT. ELEV. - MEN'S TOILET

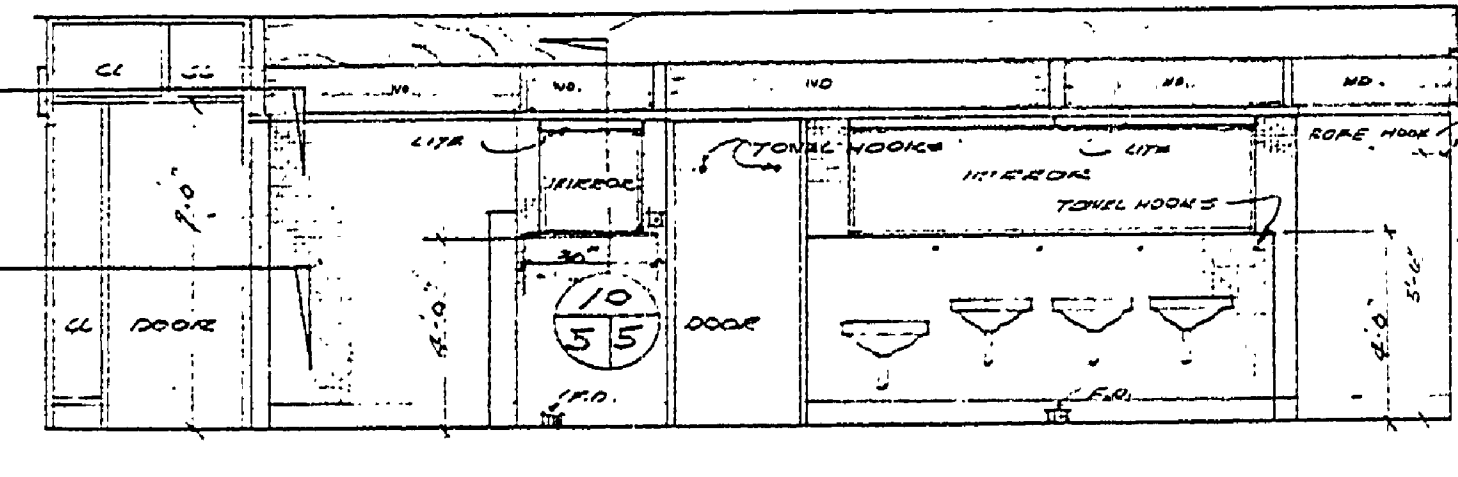

WEST INTERIOR ELEVATION - MEN'S TOILET

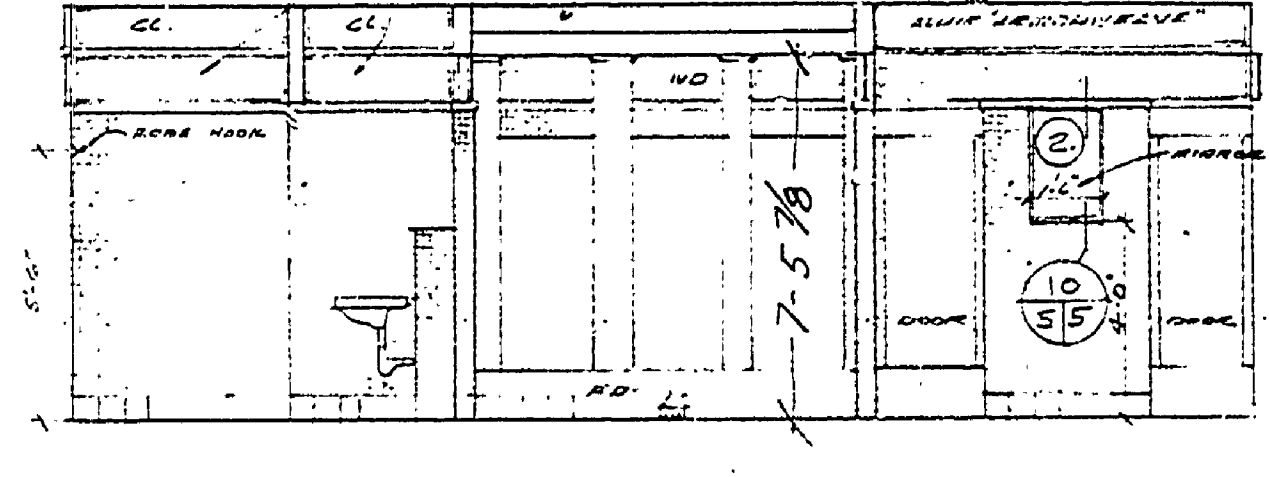

SOUTH INTERIOR ELEV. - MEN'S TOILET

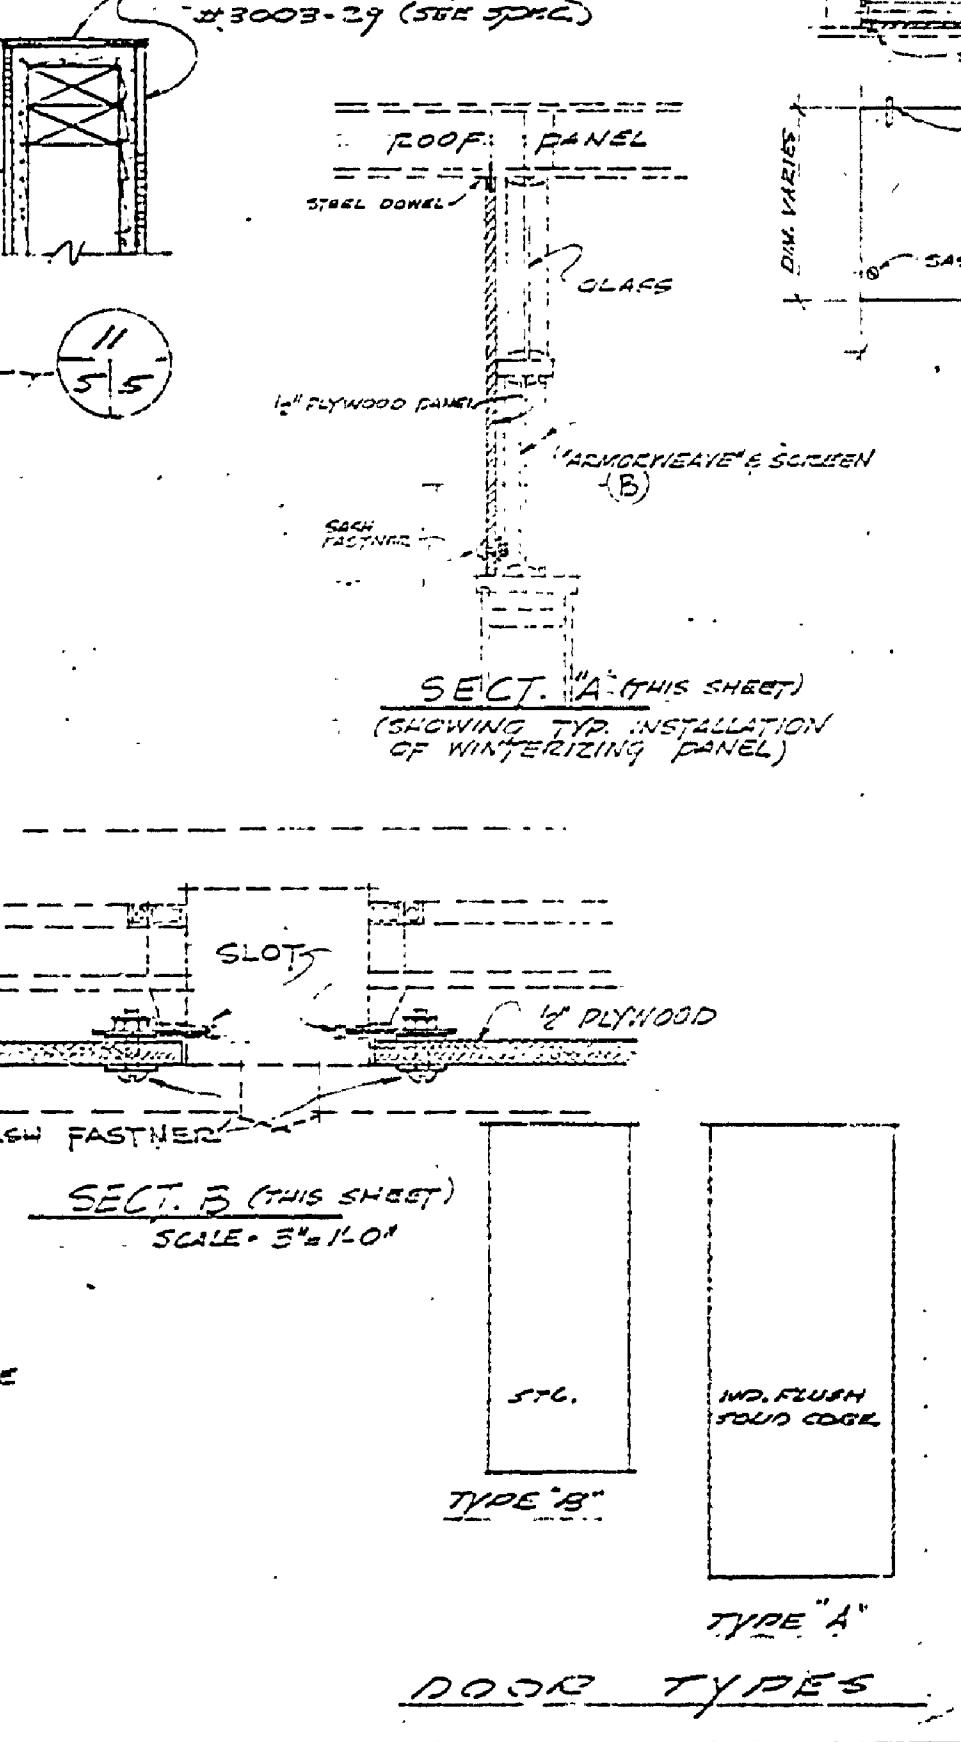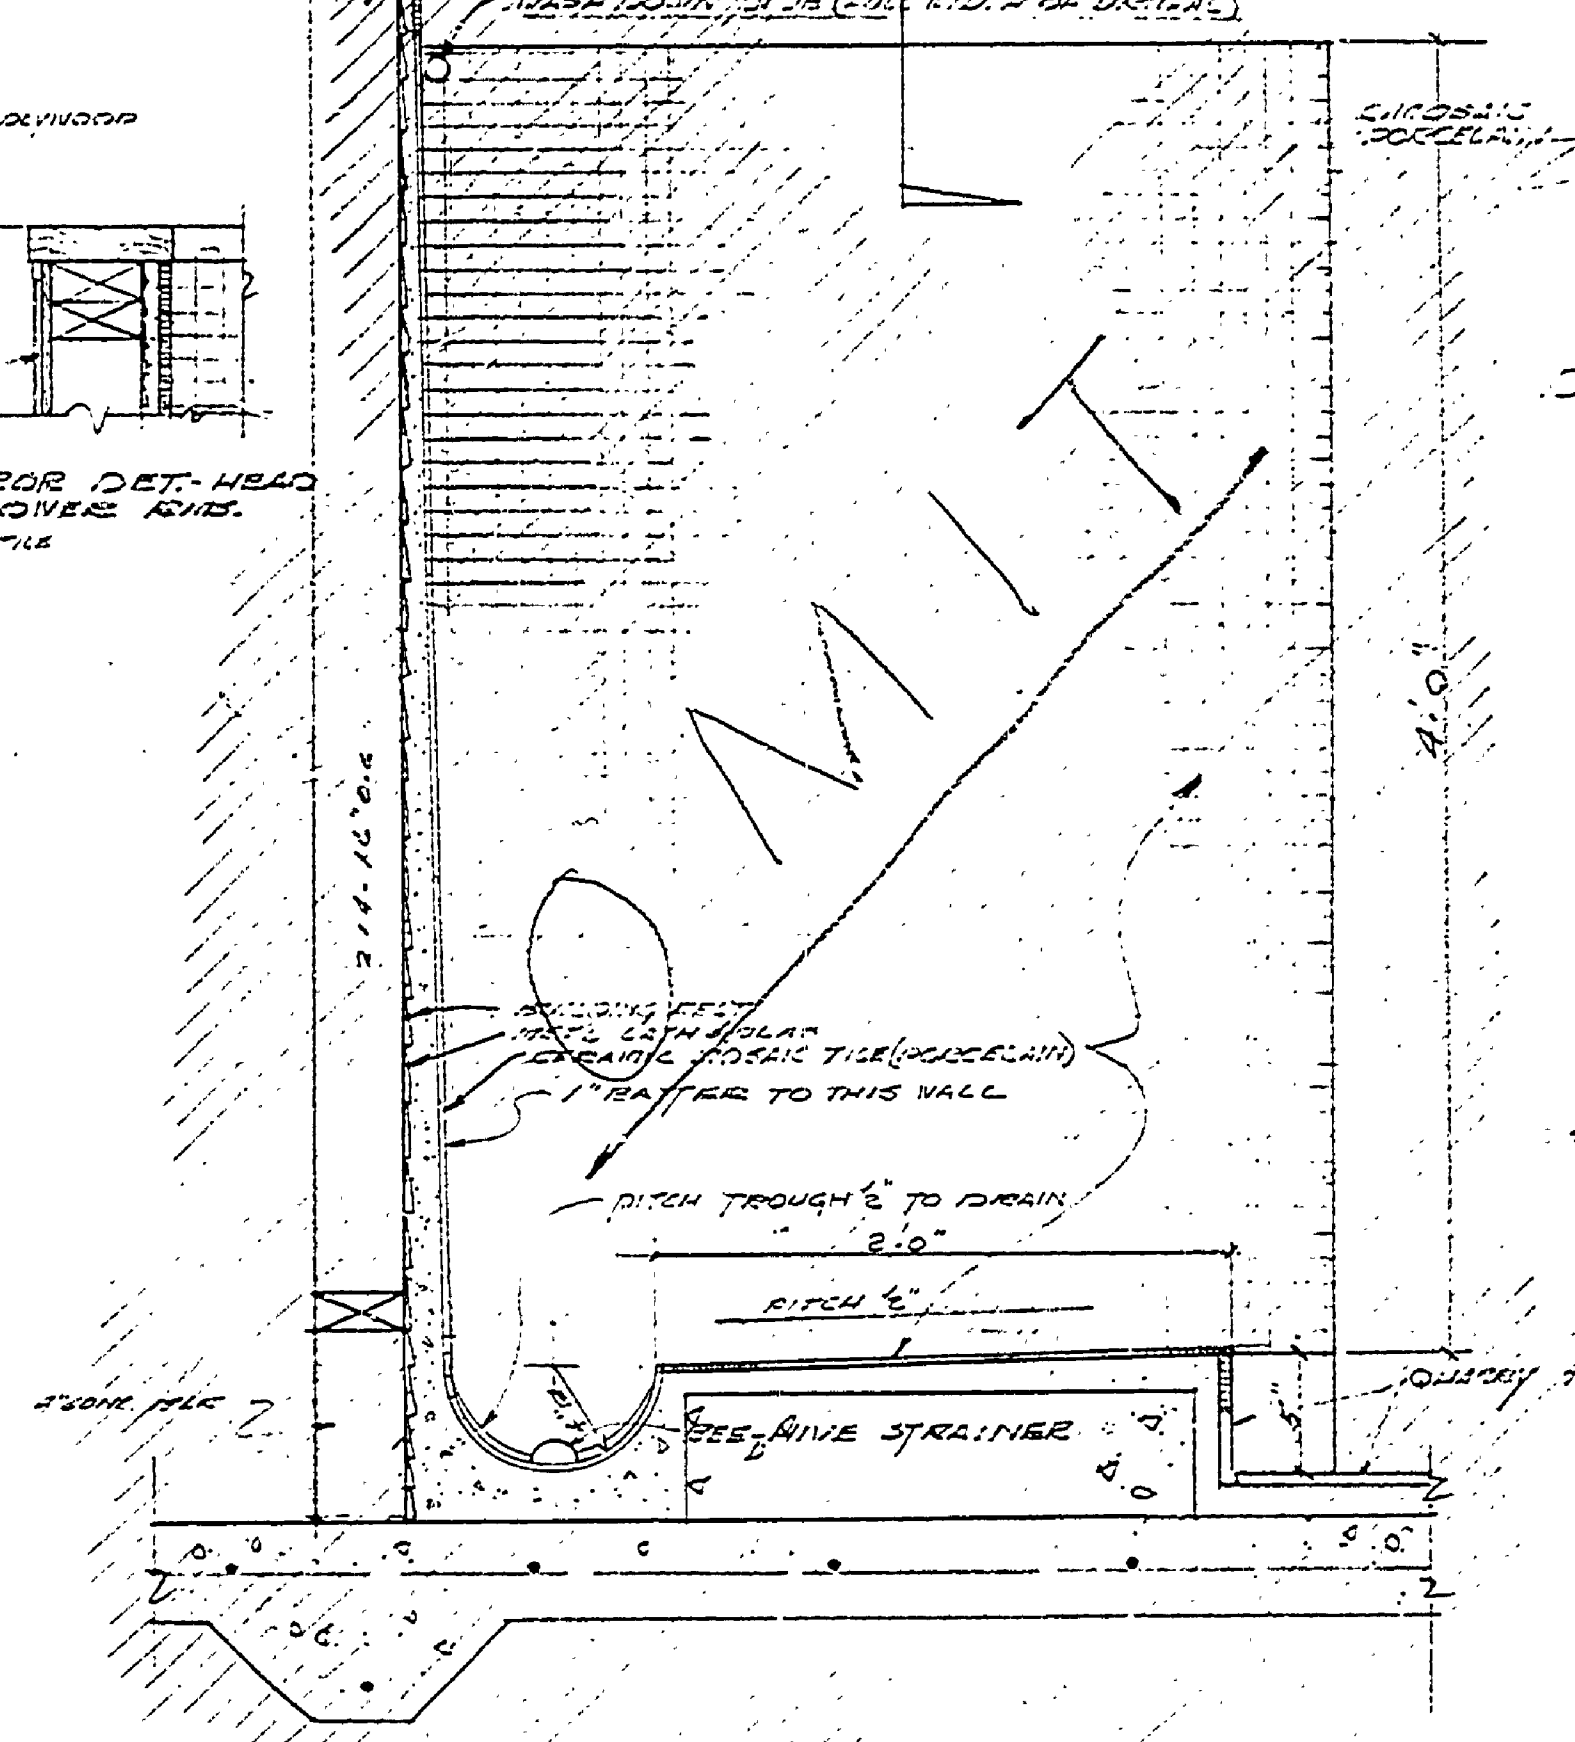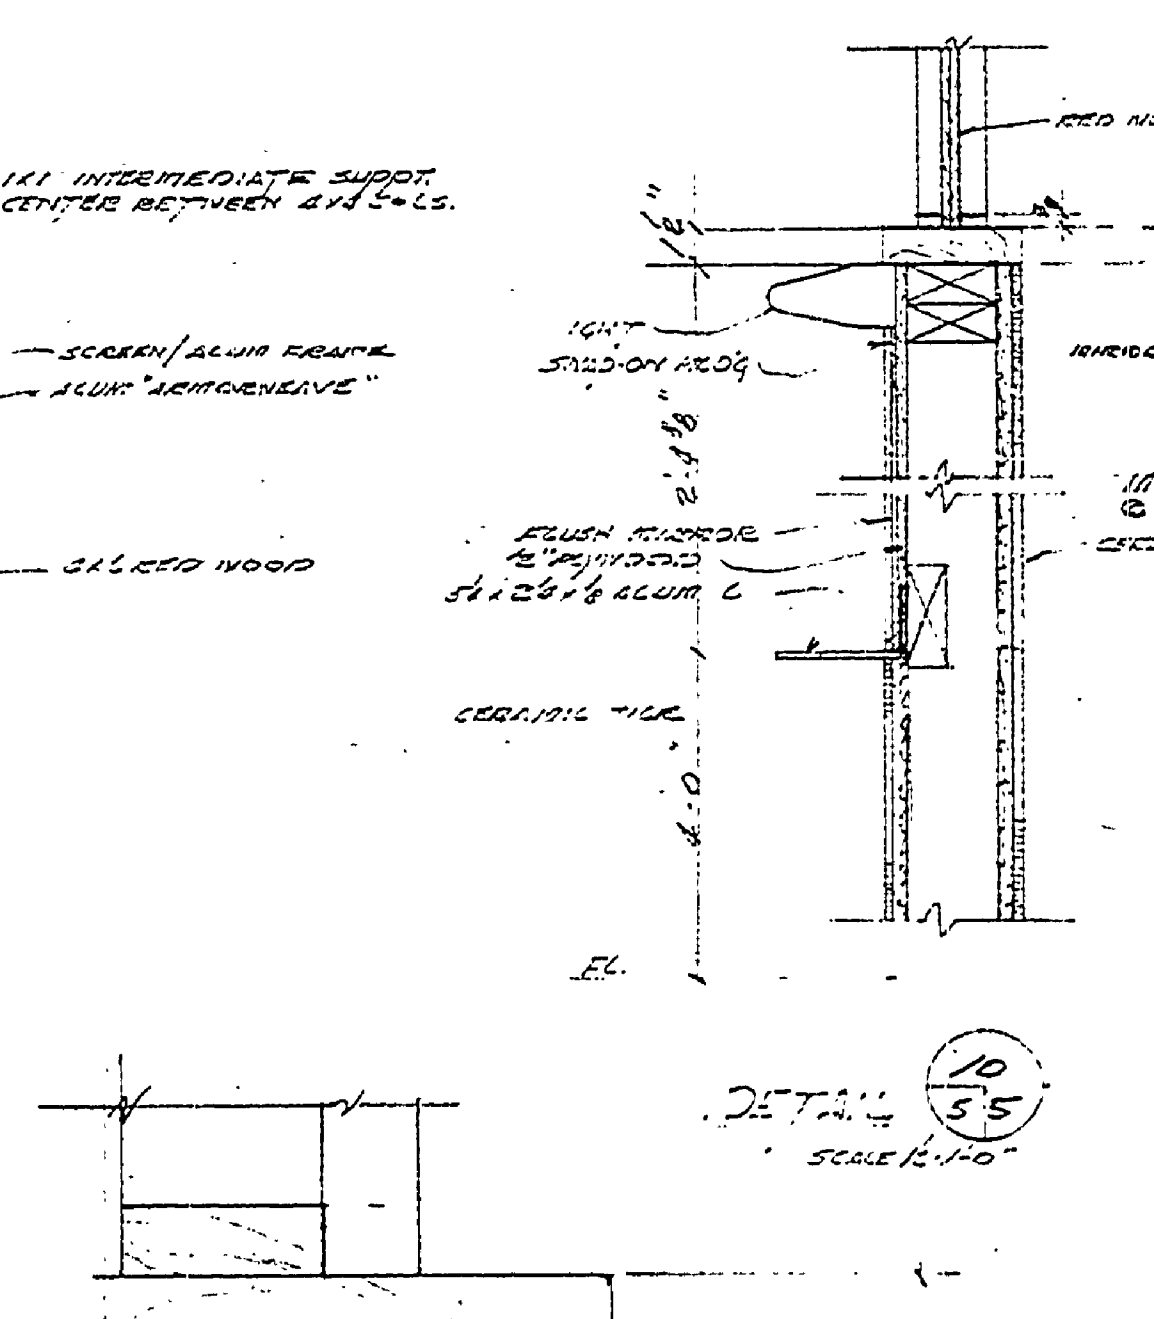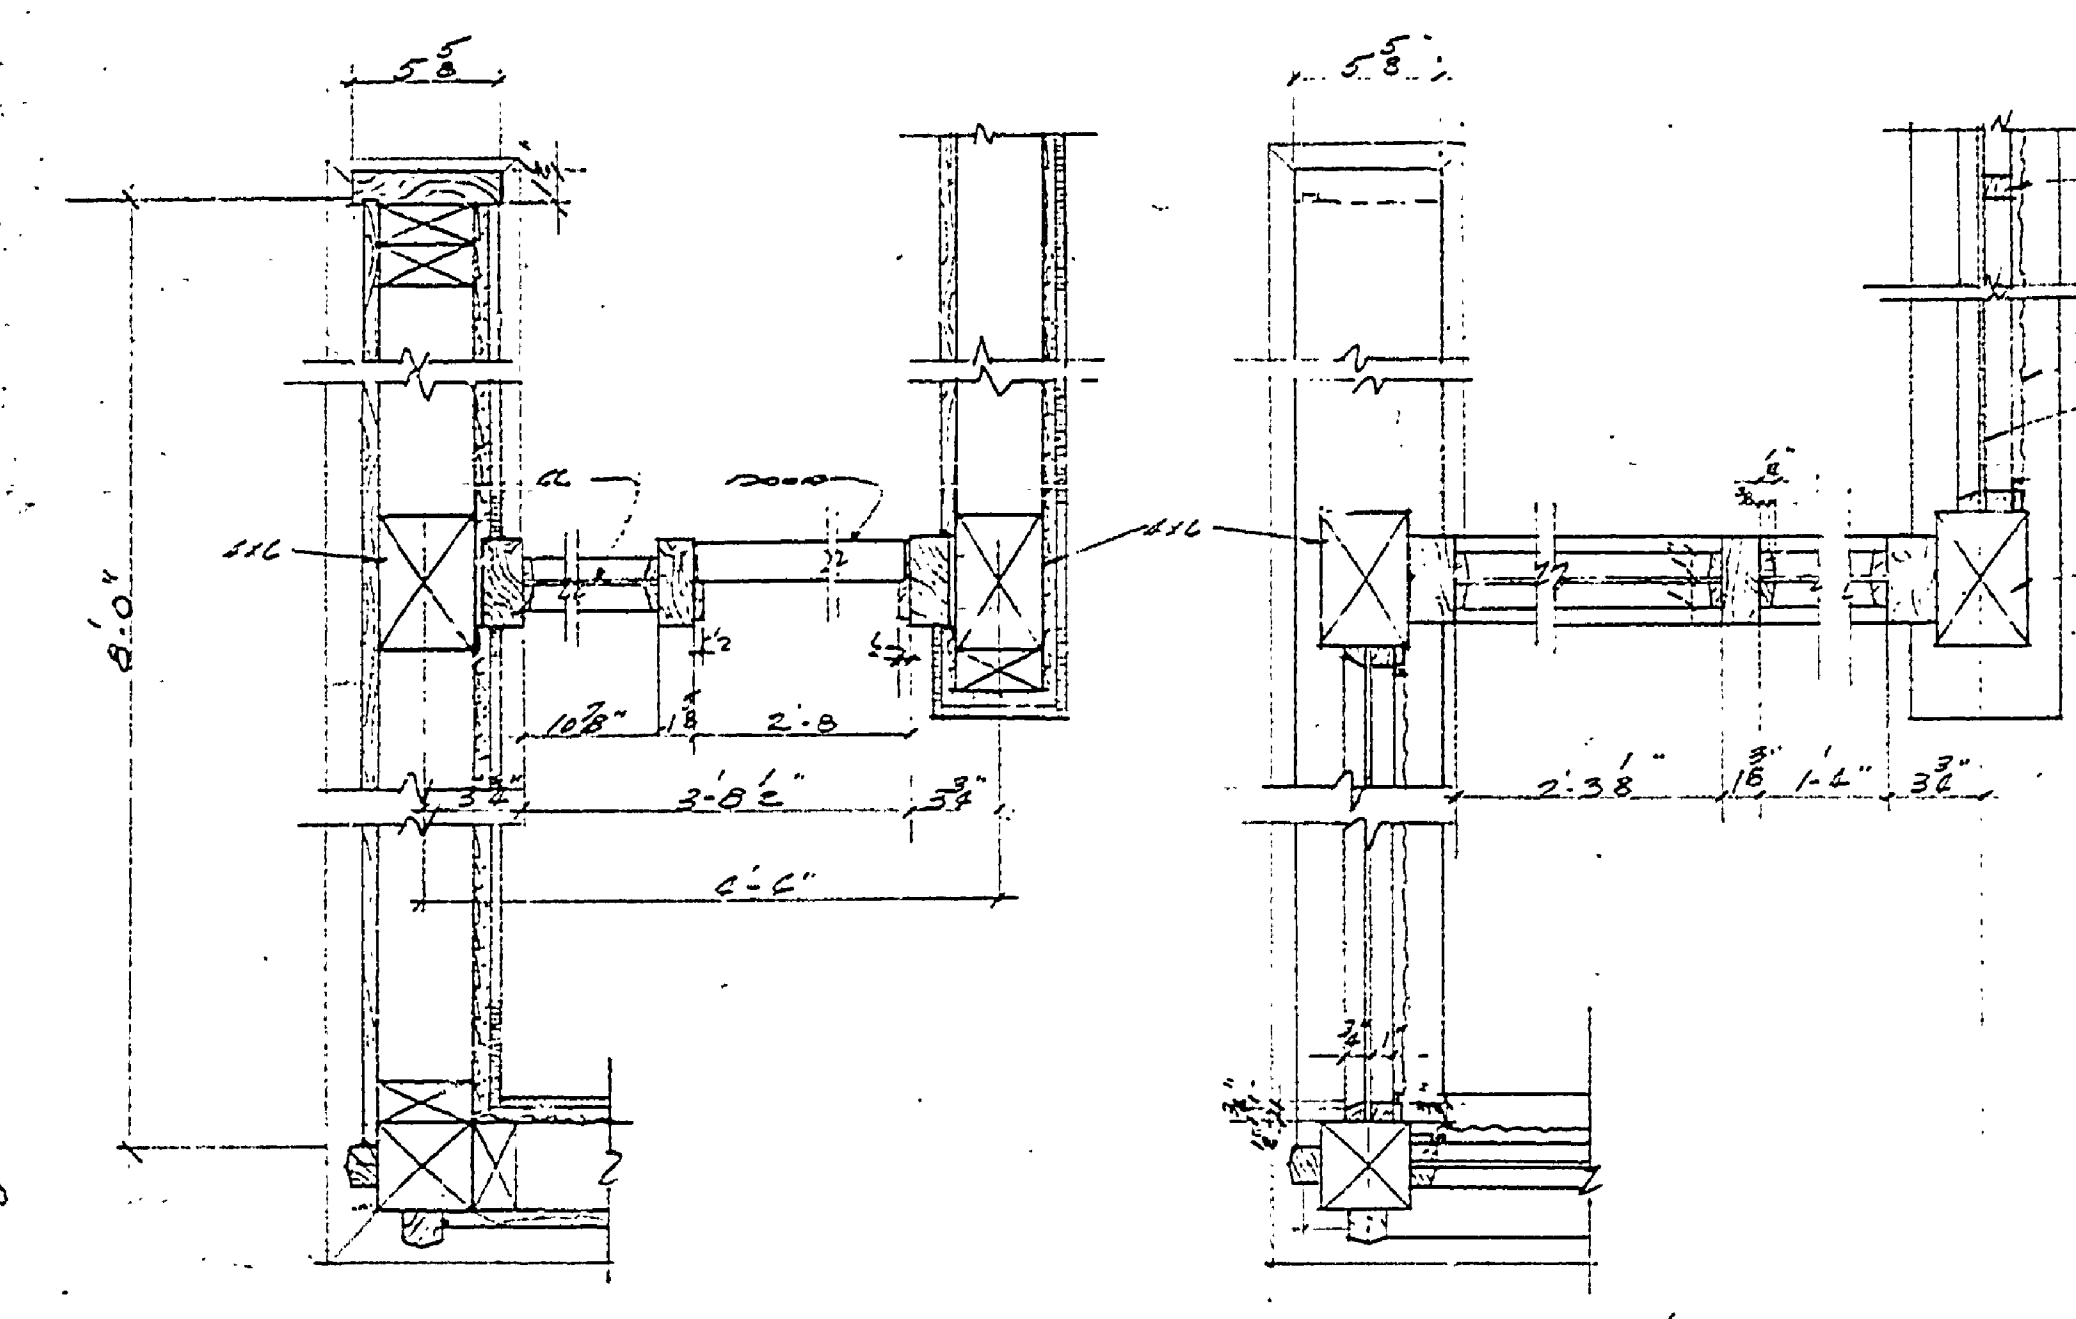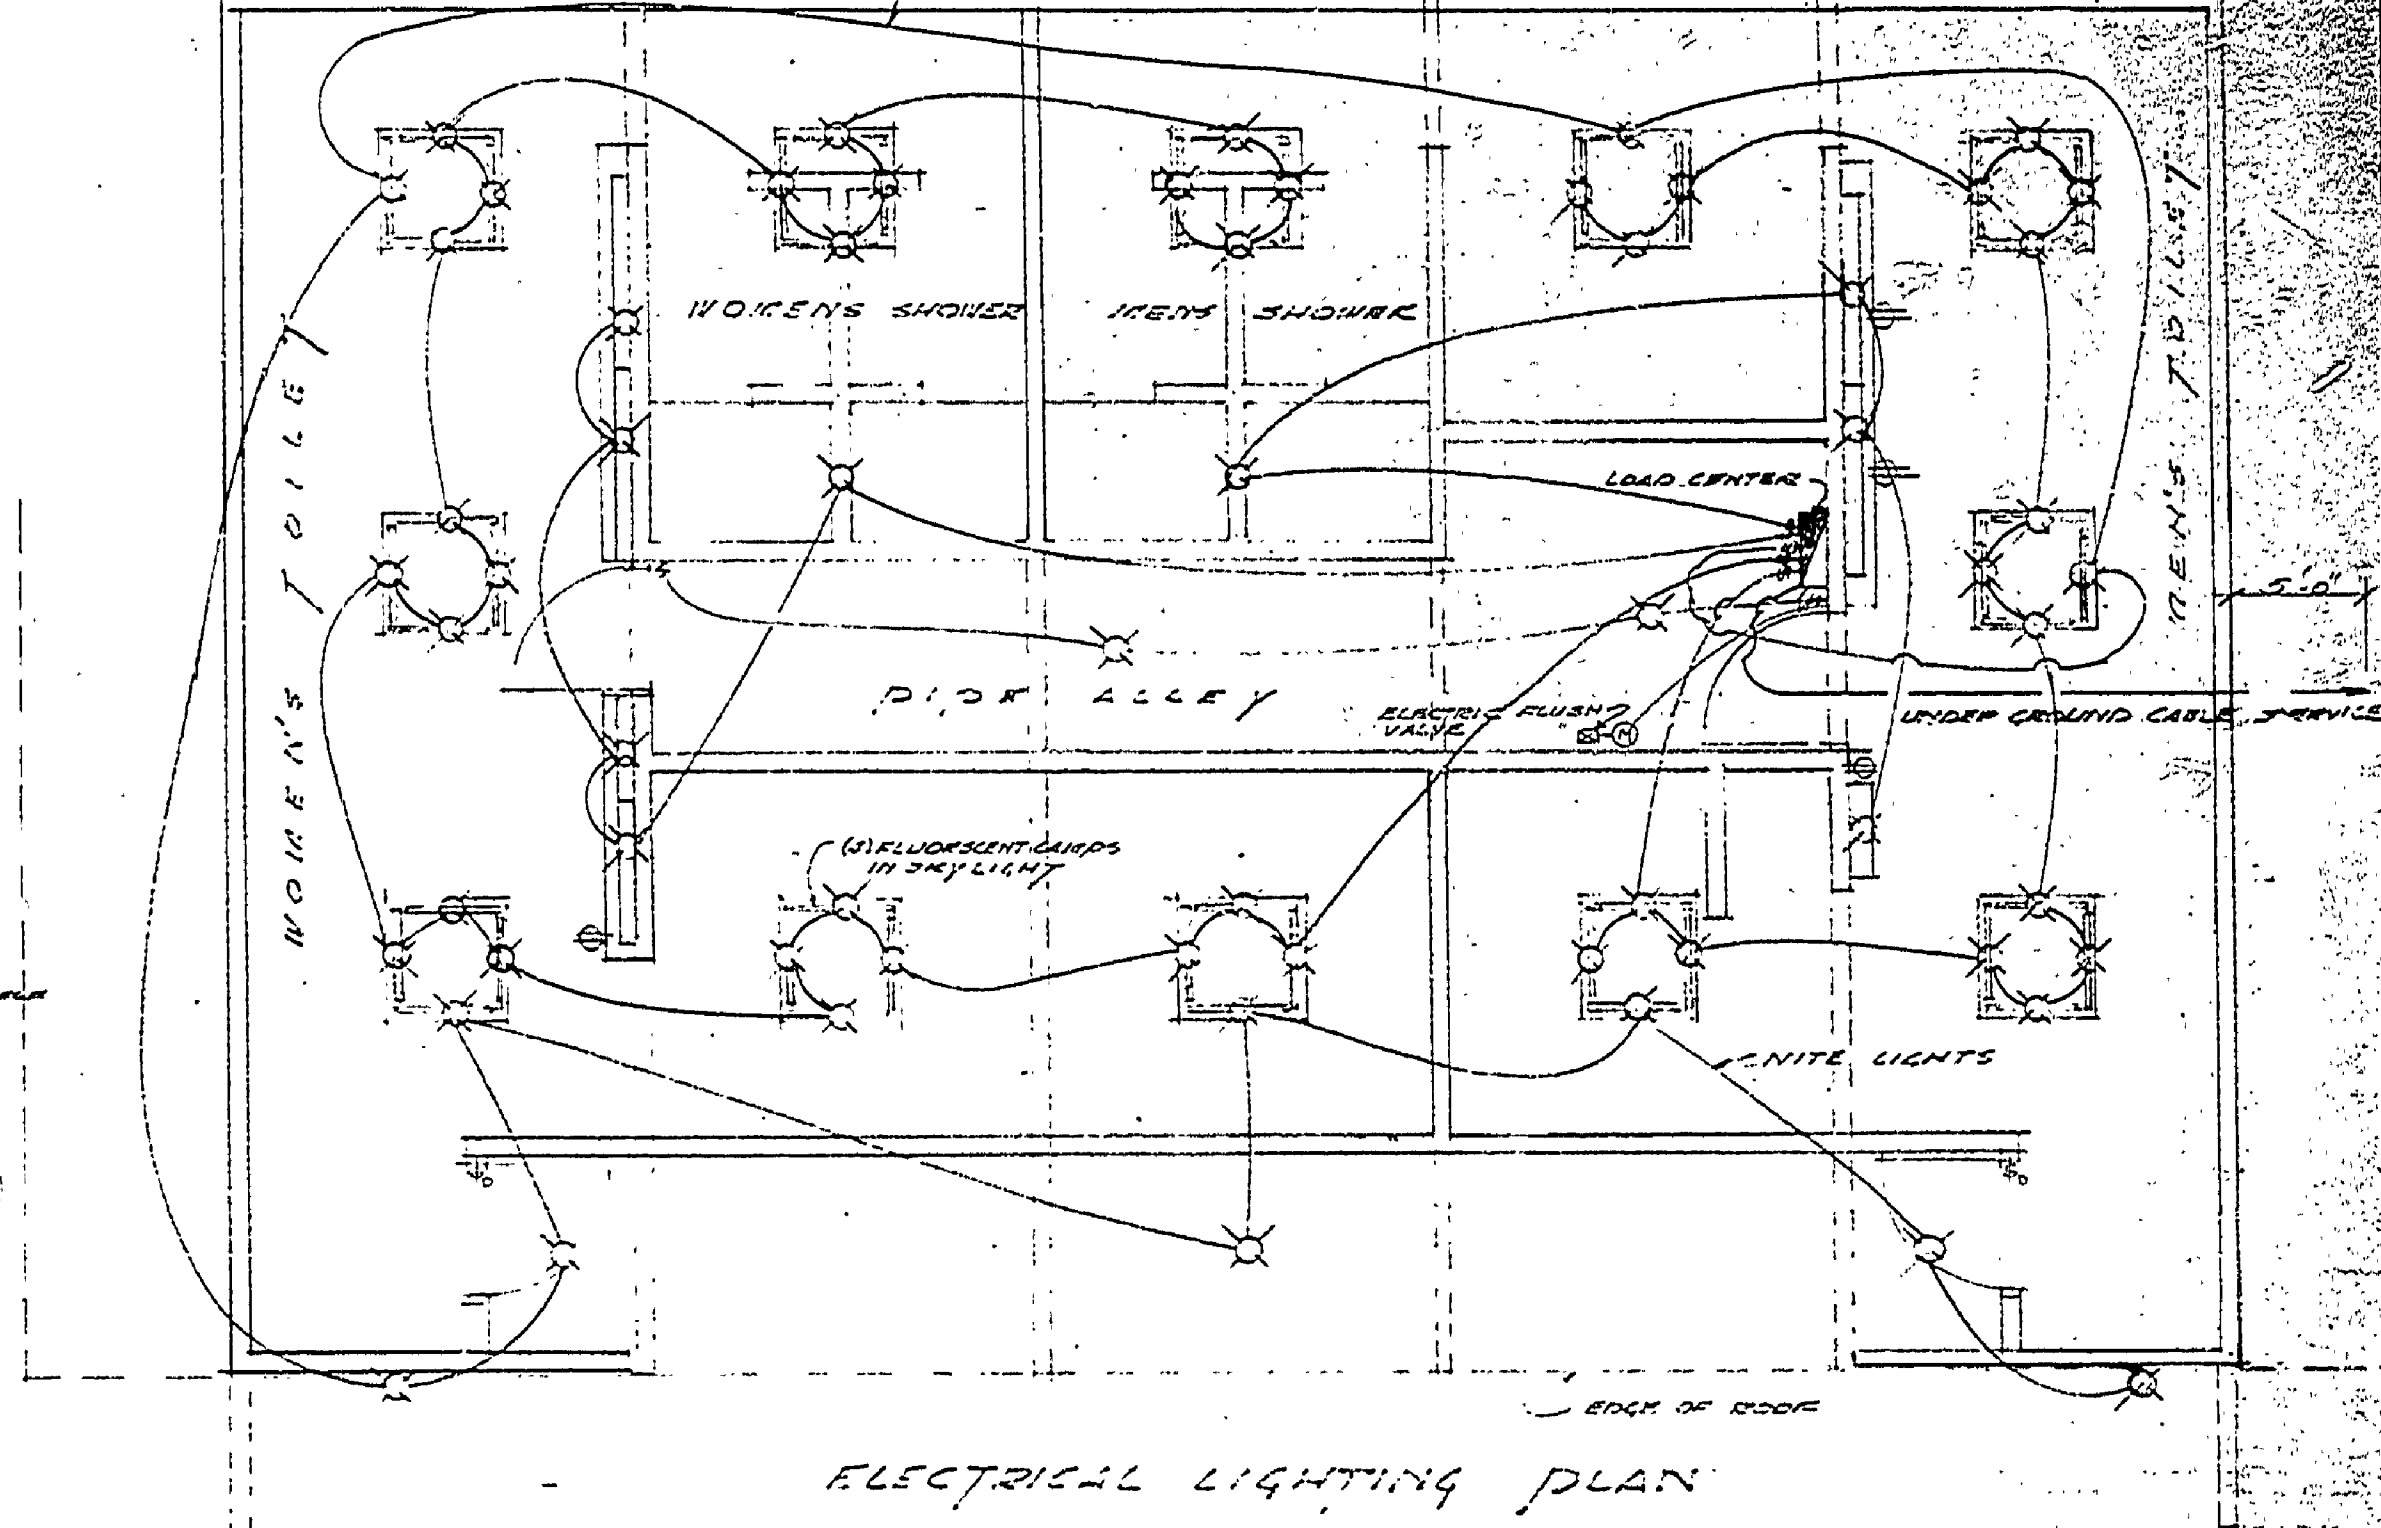


WINTERIZING PANEL SCHEDULE (FOR GASH & LOUVER OPENINGS)


TYPE	NO. REQD.	THICK. INCHES	WIDTH	HT.	REMARKS
A	8	2"	48"	24"	2 1/2" MIN. OVERLAP
B	6	2"	48"	14"	"
C	2	2"	48"	24"	"
D	2	2"	48"	14"	"
E	2	2"	48"	14"	"
F	2	2"	48"	24"	"
G	2	2"	48"	14"	"

DOOR SCHEDULE


DESIGNATION	TYPE	NO.	THICK. INCHES	WIDTH	HT.	REMARKS
1	A	1	1 1/2"	28"	7'0"	POUR CORE
2	A	1	1 1/2"	28"	7'0"	"
3	A	1	1 1/2"	28"	6'4"	"
4	A	1	1 1/2"	28"	6'4"	"
5	B	1	1 1/2"	28"	6'4"	DOWN/TOP/INT.
6	B	1	1 1/2"	28"	6'4"	"
7	B	1	1 1/2"	28"	6'4"	"
8	B	1	1 1/2"	28"	6'4"	"

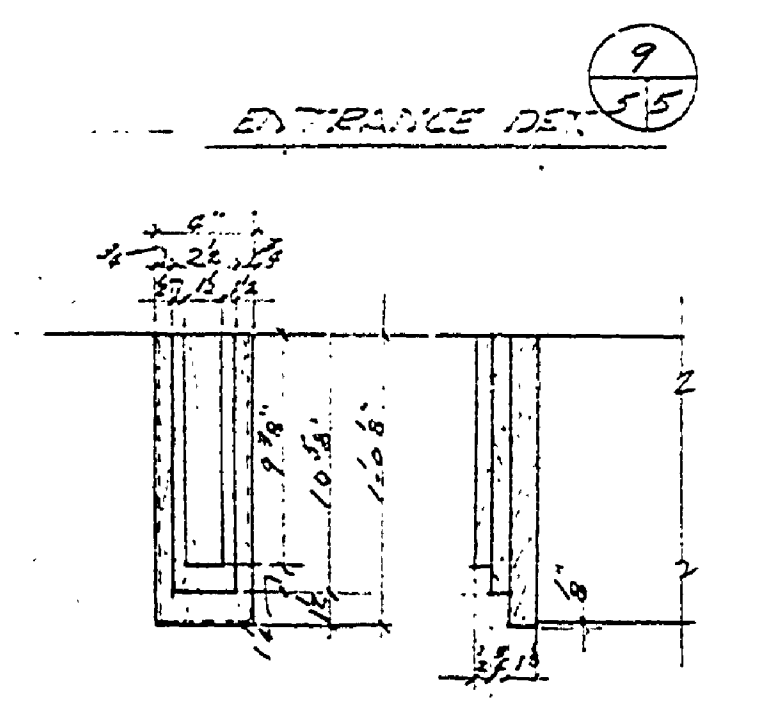

DET. END OF BOX BEAMS

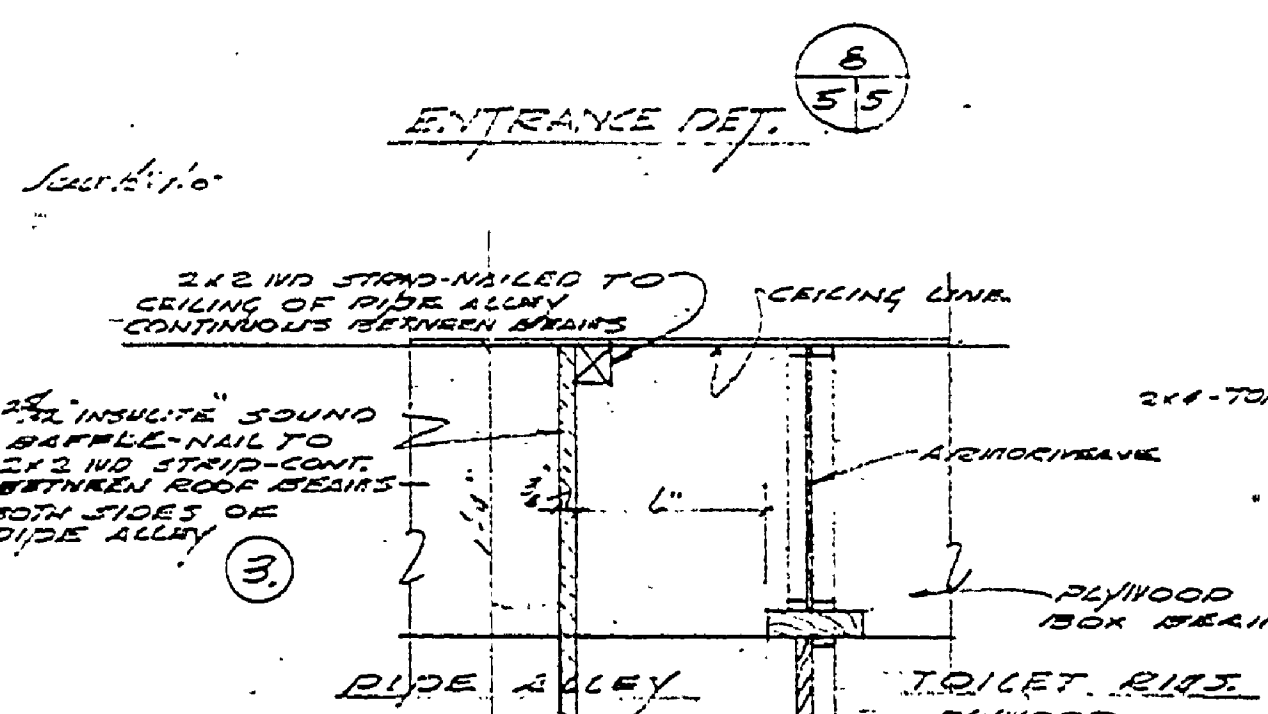

DET. SOUND BAFFLE

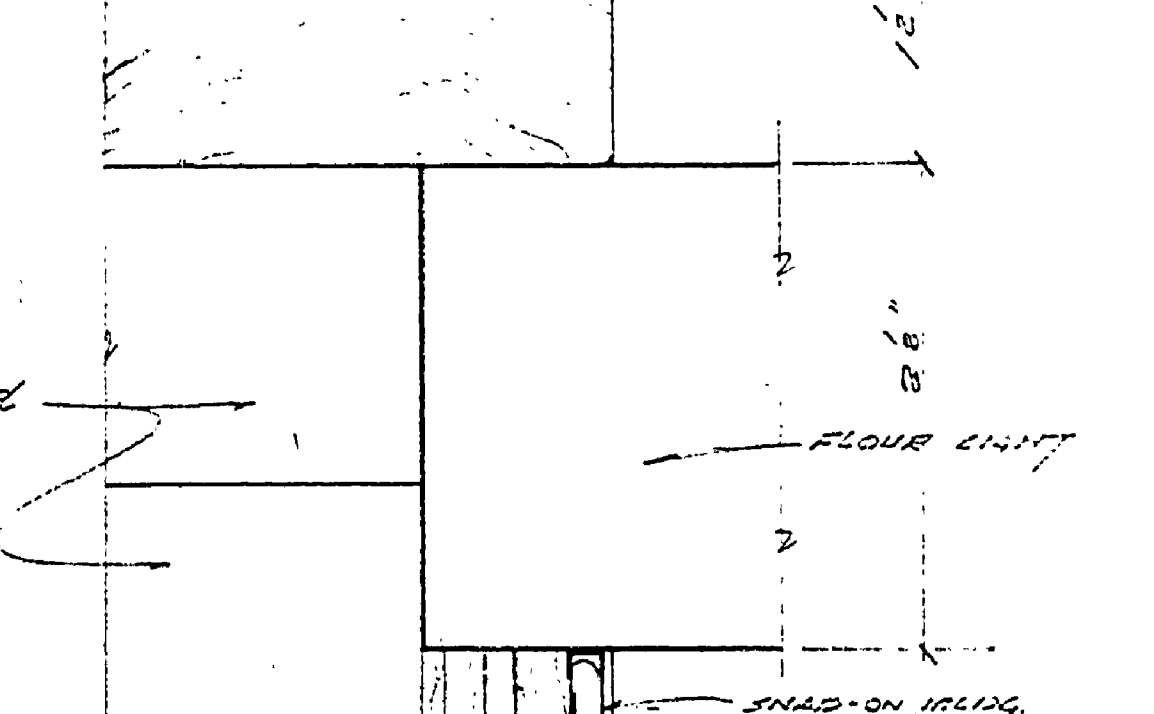

MIRROR & LIGHT DETAIL

FINISH SCHEDULE

ROOM DESIGNATION	CEILING	WALLS	FLOOR	DOOR	TRIM	WOOD FINISH	GLASS	IRON	PAINT
WOMEN'S TOILET	•	•	•	•	•	•	•	•	•
WOMEN'S TOILET WOOD	•	•	•	•	•	•	•	•	•
WOMEN'S SHOWER	•	•	•	•	•	•	•	•	•
WOMEN'S SHOWER WOOD	•	•	•	•	•	•	•	•	•
PIPER ALLEY	•	•	•	•	•	•	•	•	•

MICHIGAN DEPARTMENT OF CONSERVATION PARKS AND RECREATION DIVISION

HIGGINS LAKE STATE PARK TOILET AND SHOWER BUILDING - G.D. SHEET NO. 5 OF 5 PLAN NO. A-105