




DESIGNED BY	DATE	REVIEWED	DATE	APPROVED	DATE	NO.	DATE	BY	REVISIONS
ARCHITECTURAL	1-14-43					1	5/12	WOP	4
ENGINEERING	1-14-43					2			5
LANDSCAPE	1-14-43					3	2-17-43		6

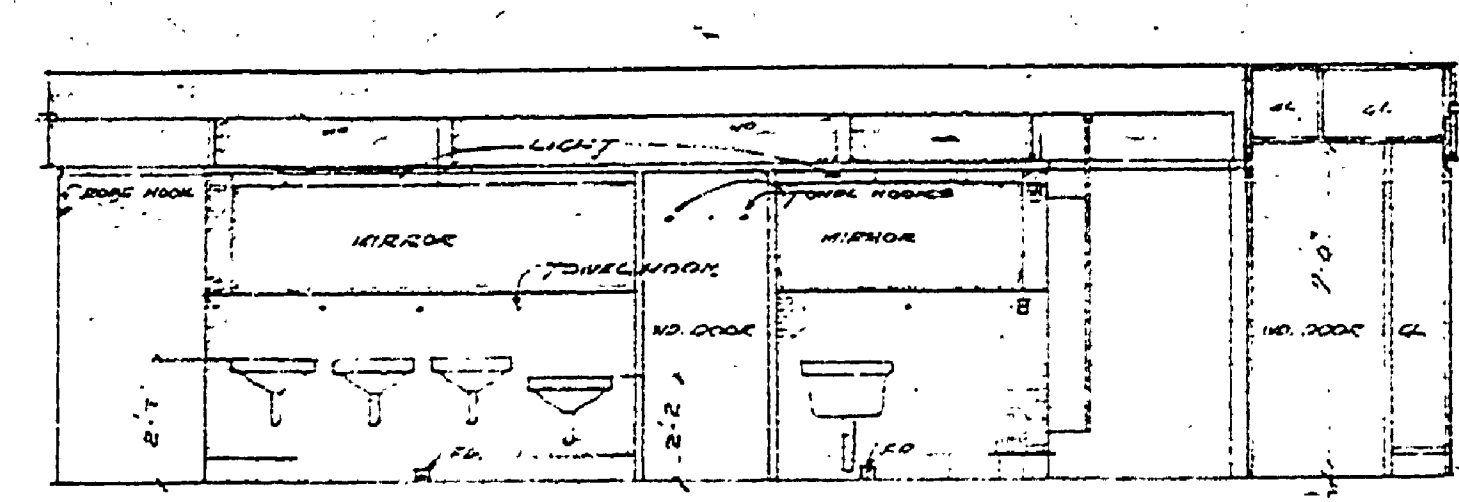


EAST INTERIOR ELEV. - WOMEN'S TOILET

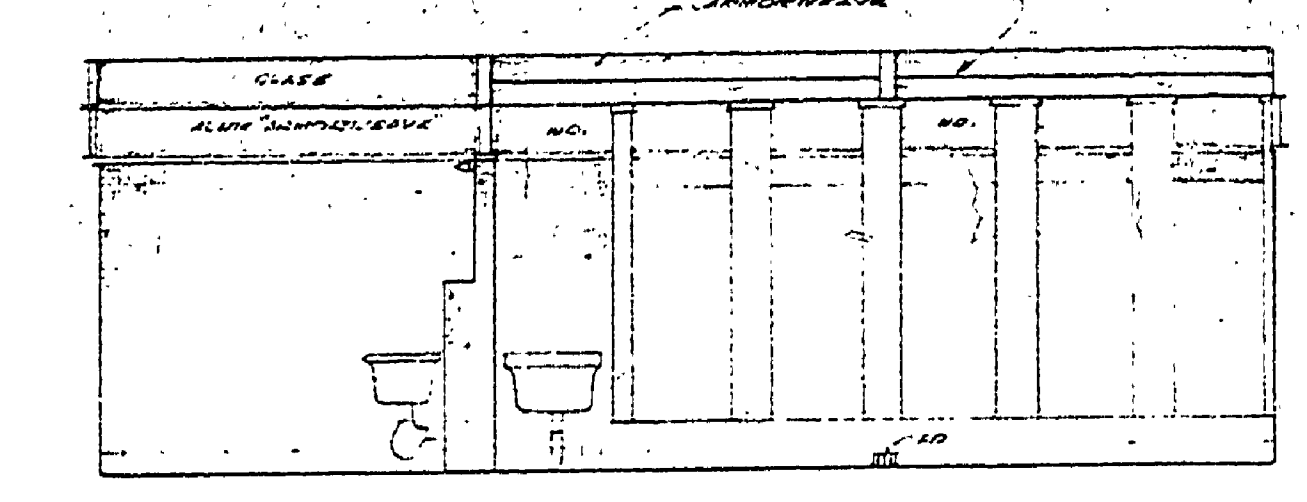


NORTH INTERIOR ELEV. - WOMEN'S TOILET

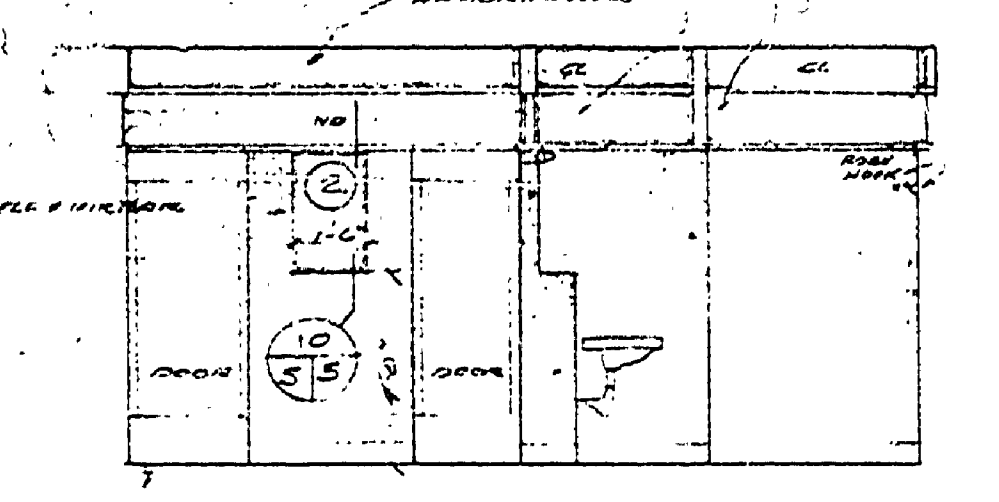


SOUTH INT. ELEV. - WOMEN'S TOILET

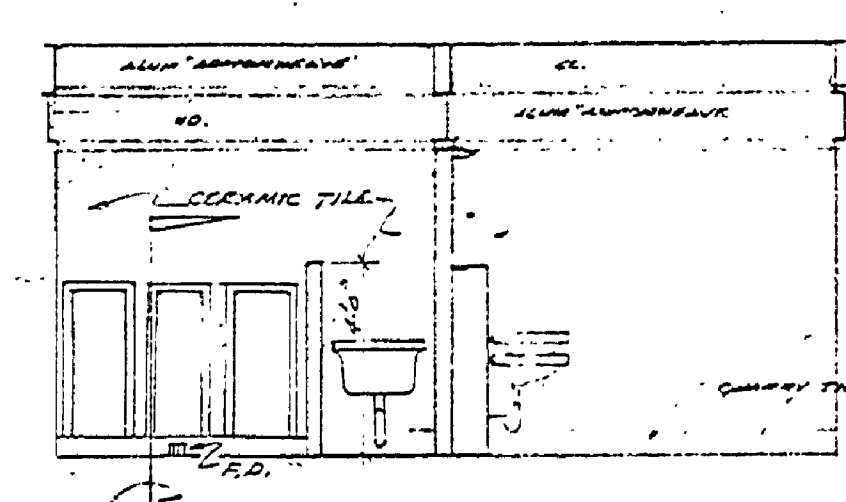


NORTH INT. ELEV. - MEN'S TOILET

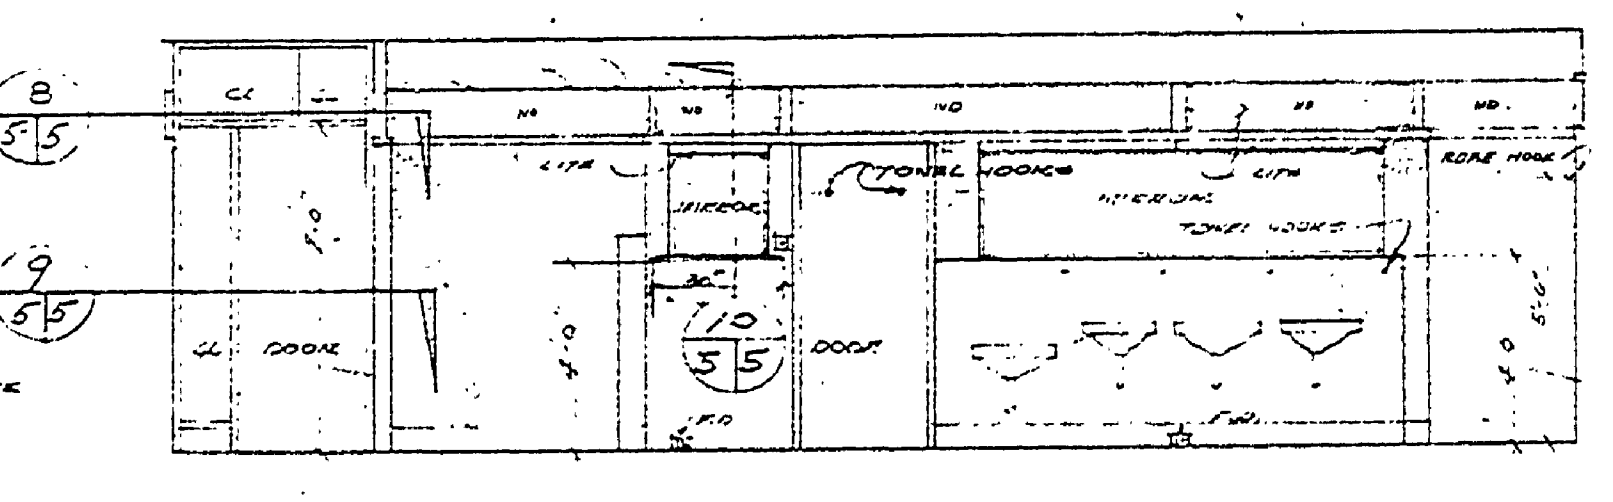



WEST INTERIOR ELEVATION - MEN'S TOILET

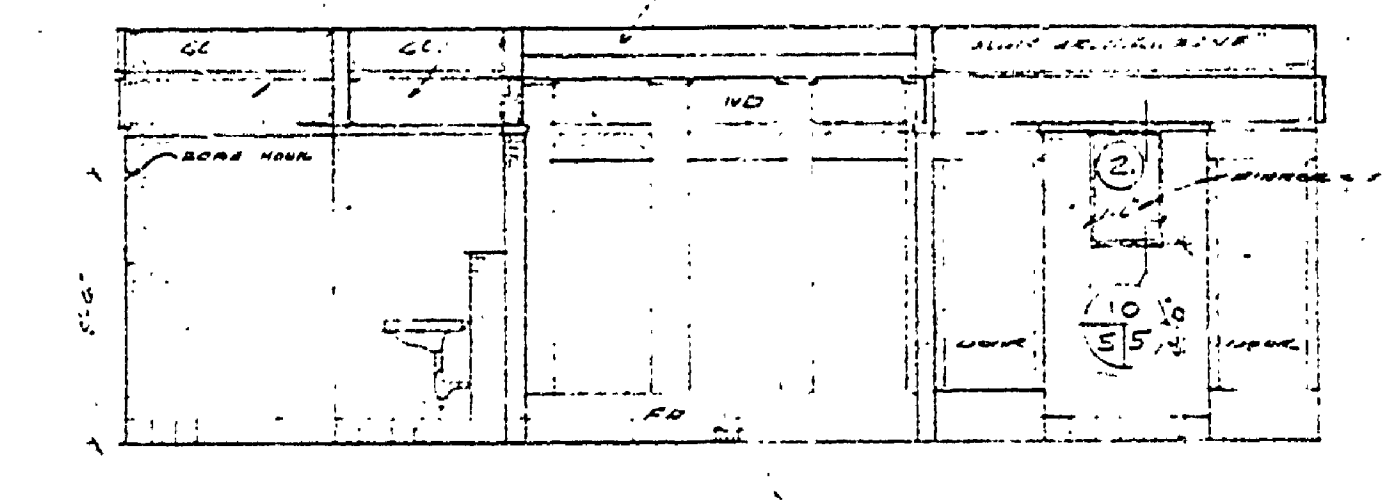



SOUTH INTERIOR ELEV. - MEN'S TOILET

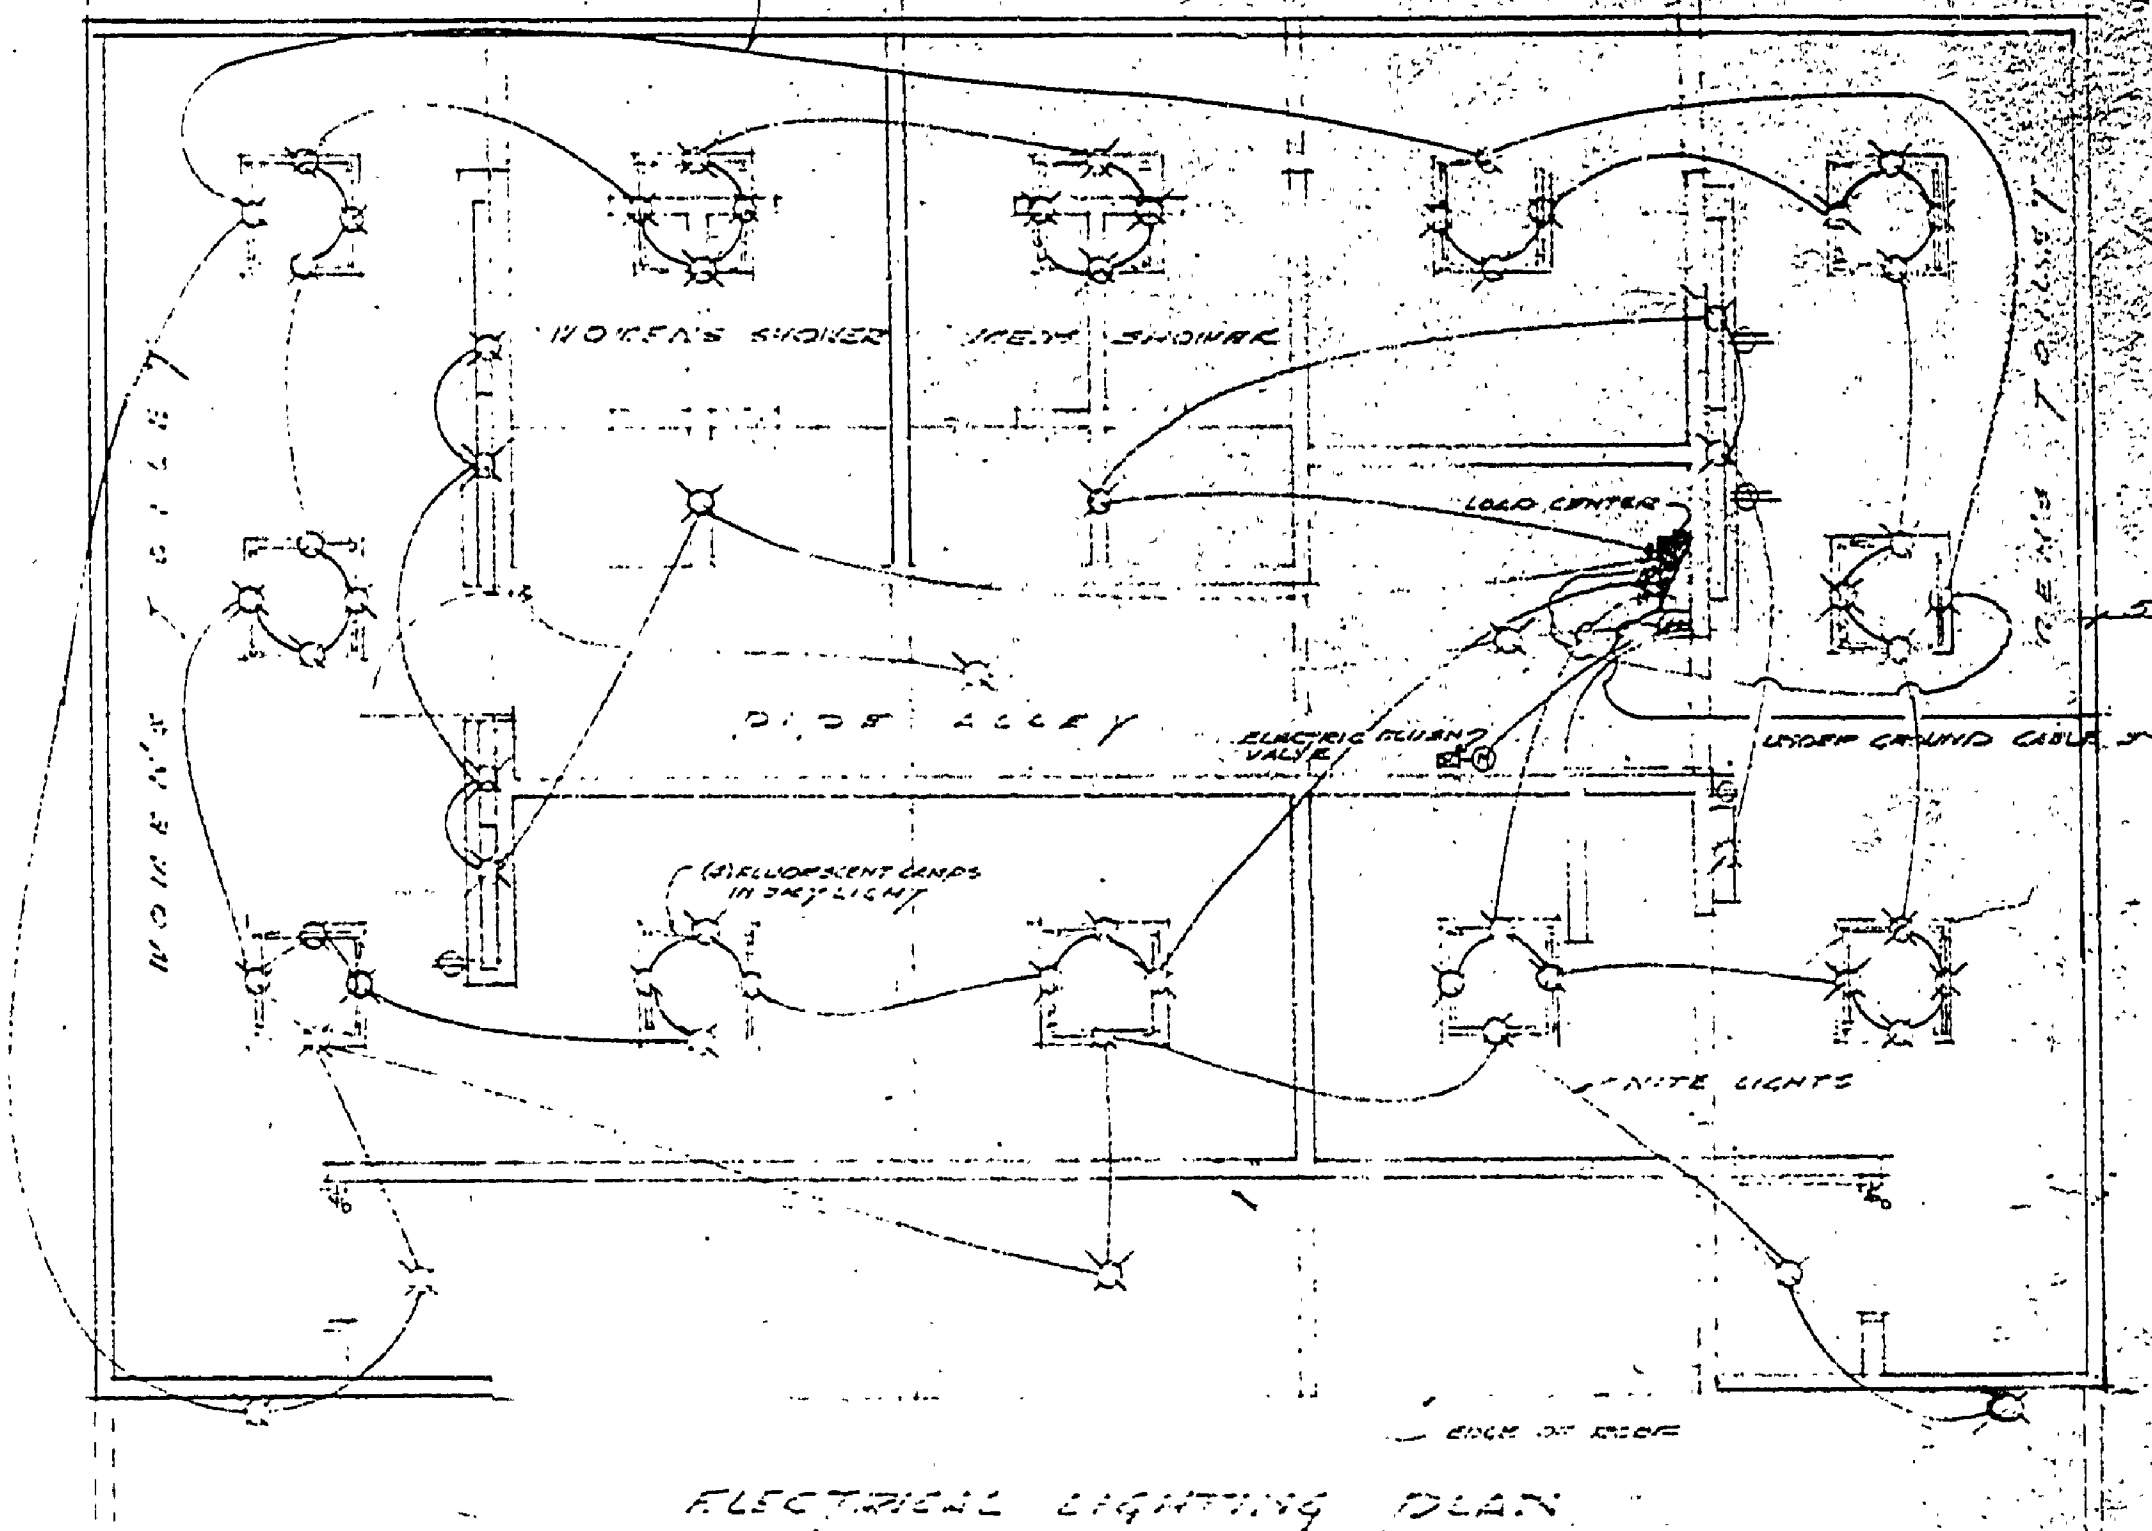


ELECTRICAL LIGHTING PLAN

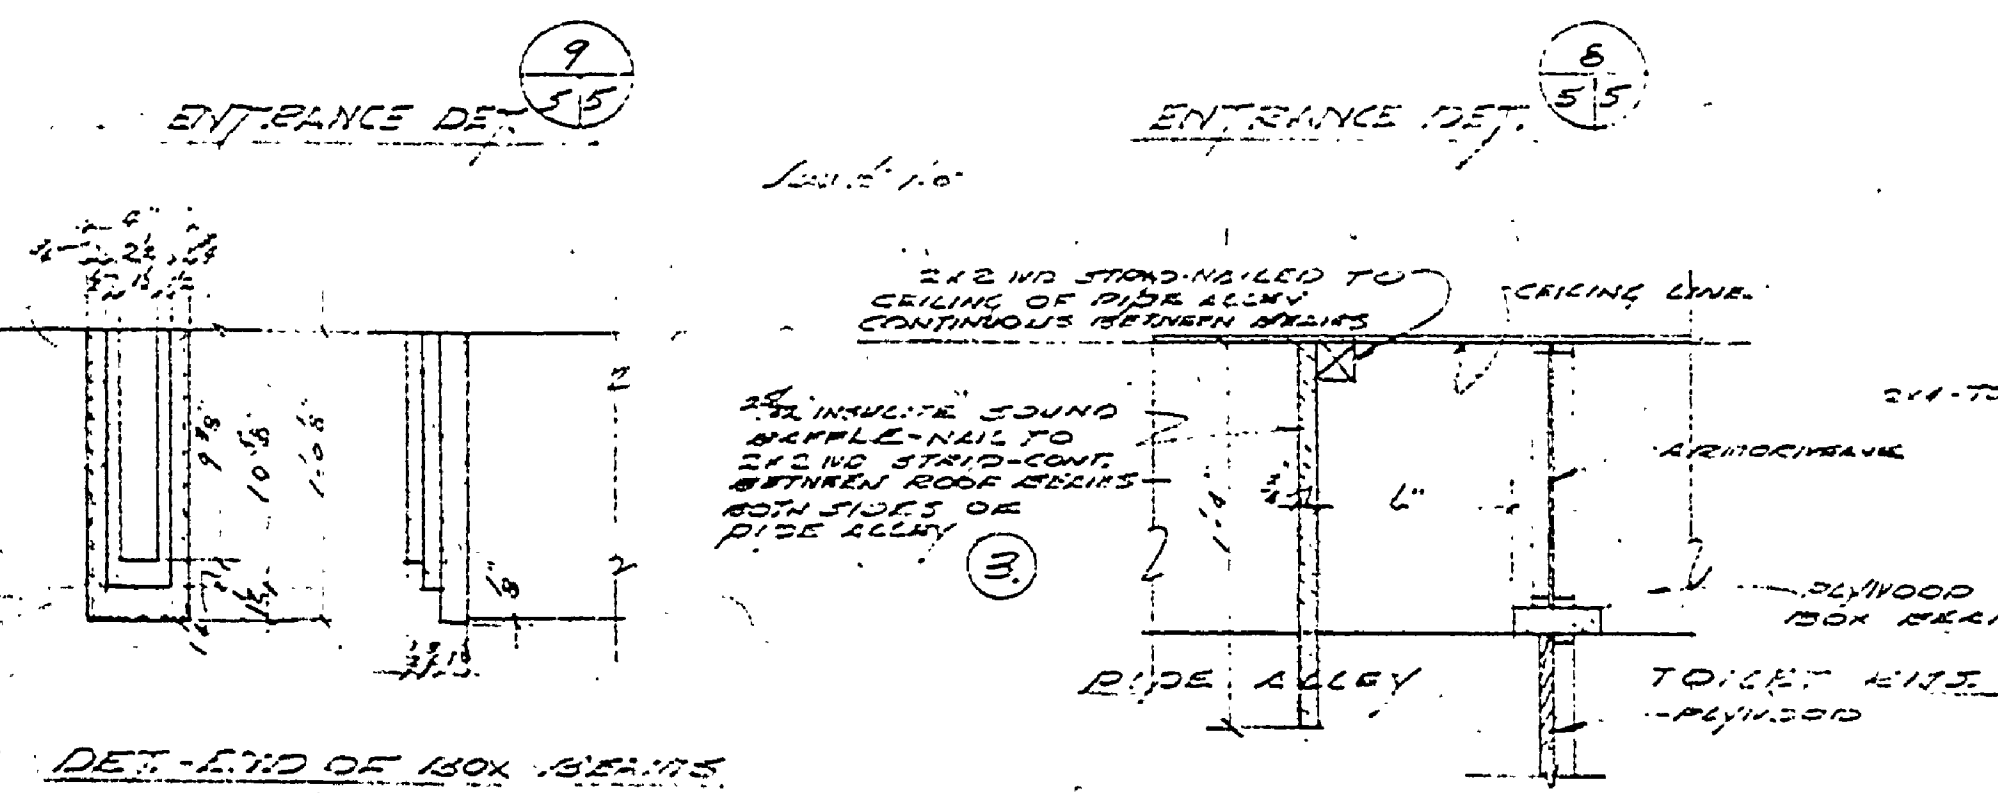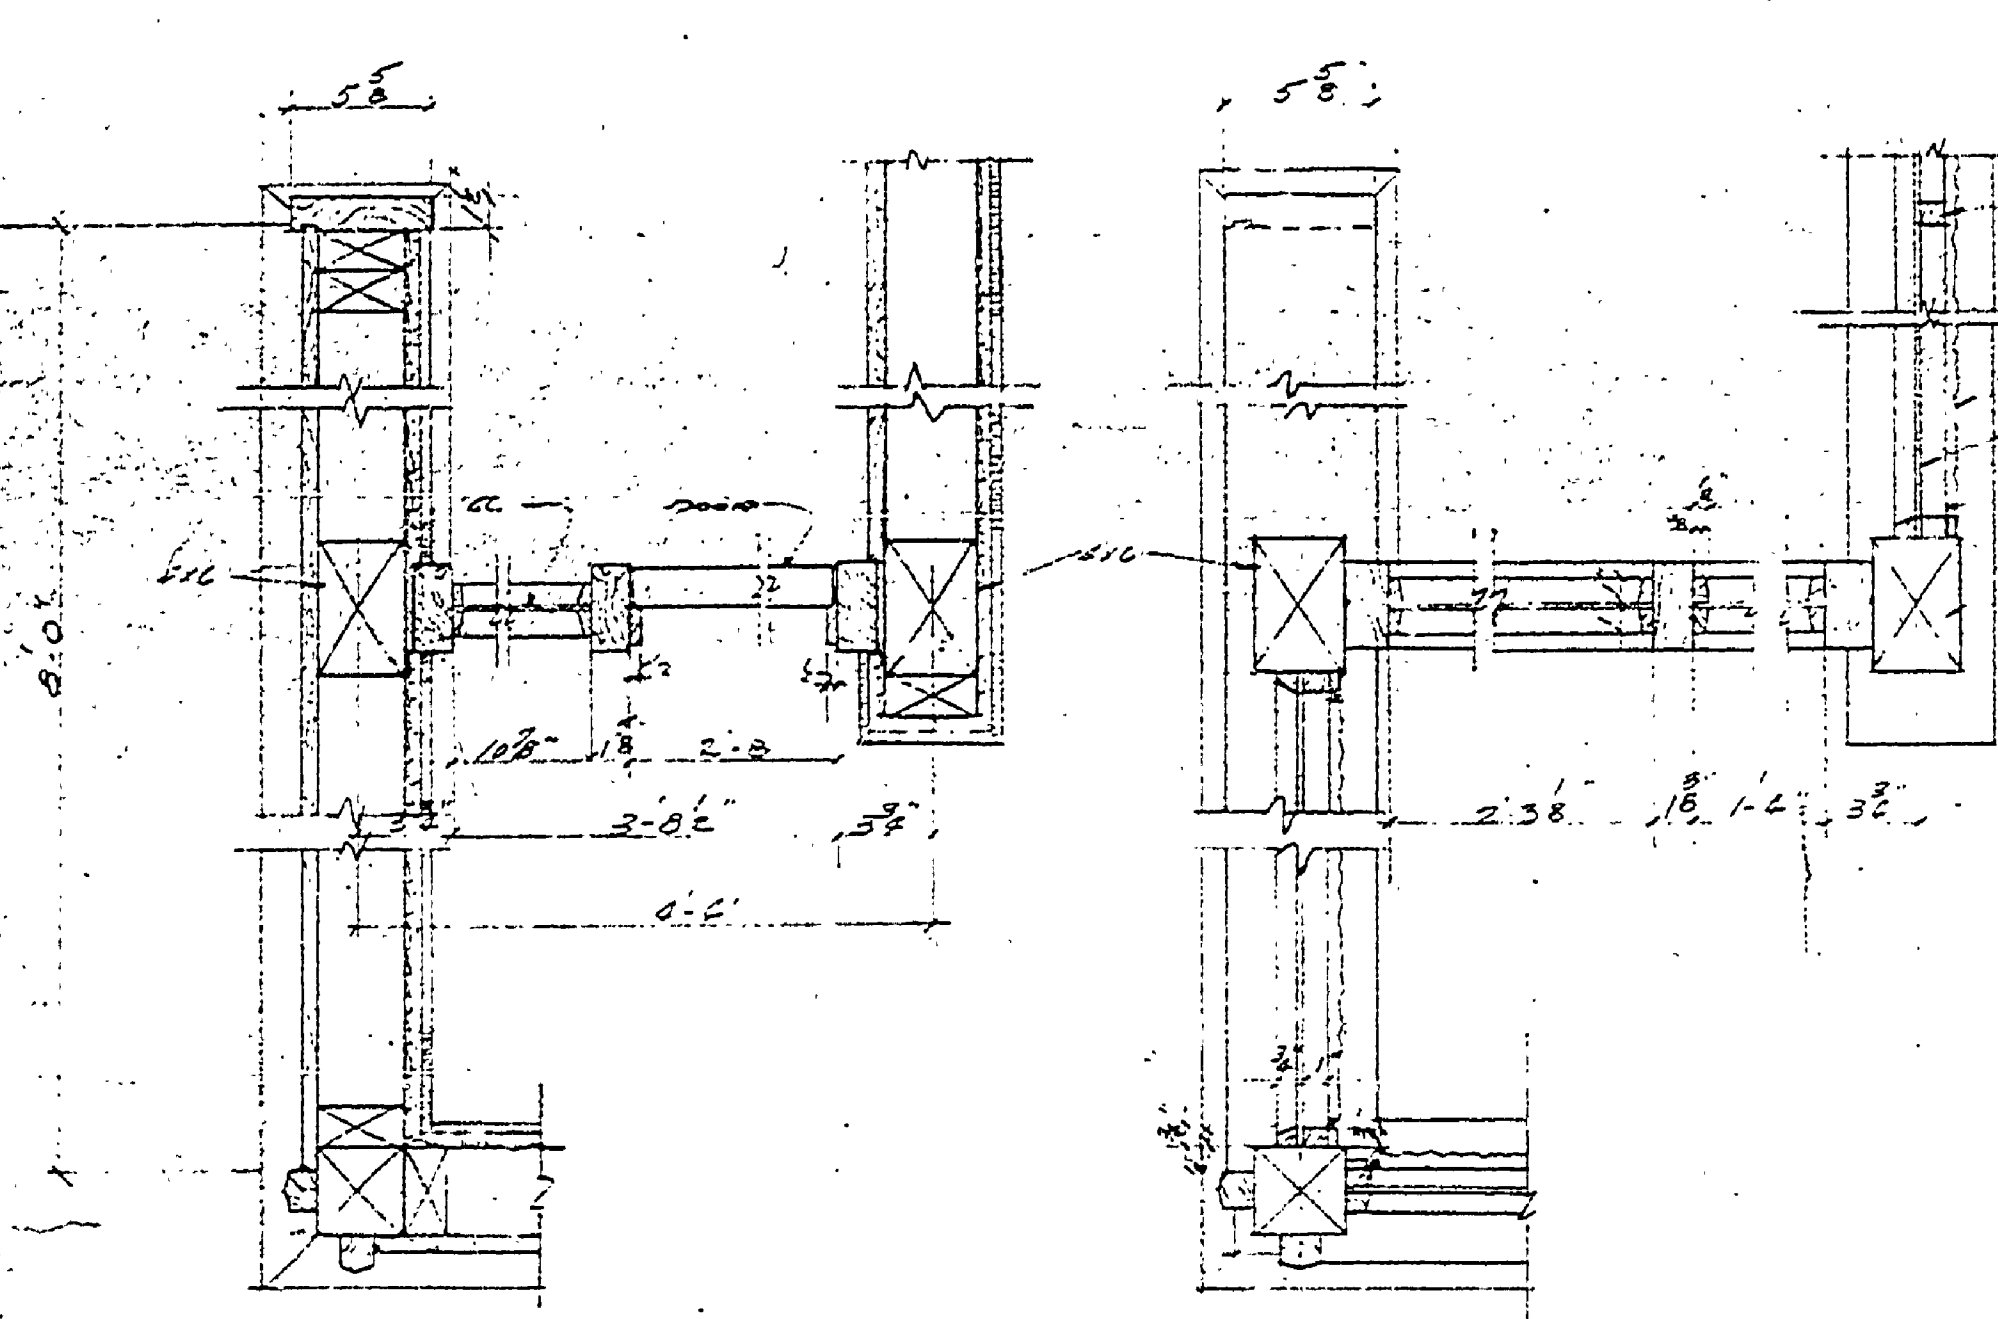


ENTRANCE DET. 9

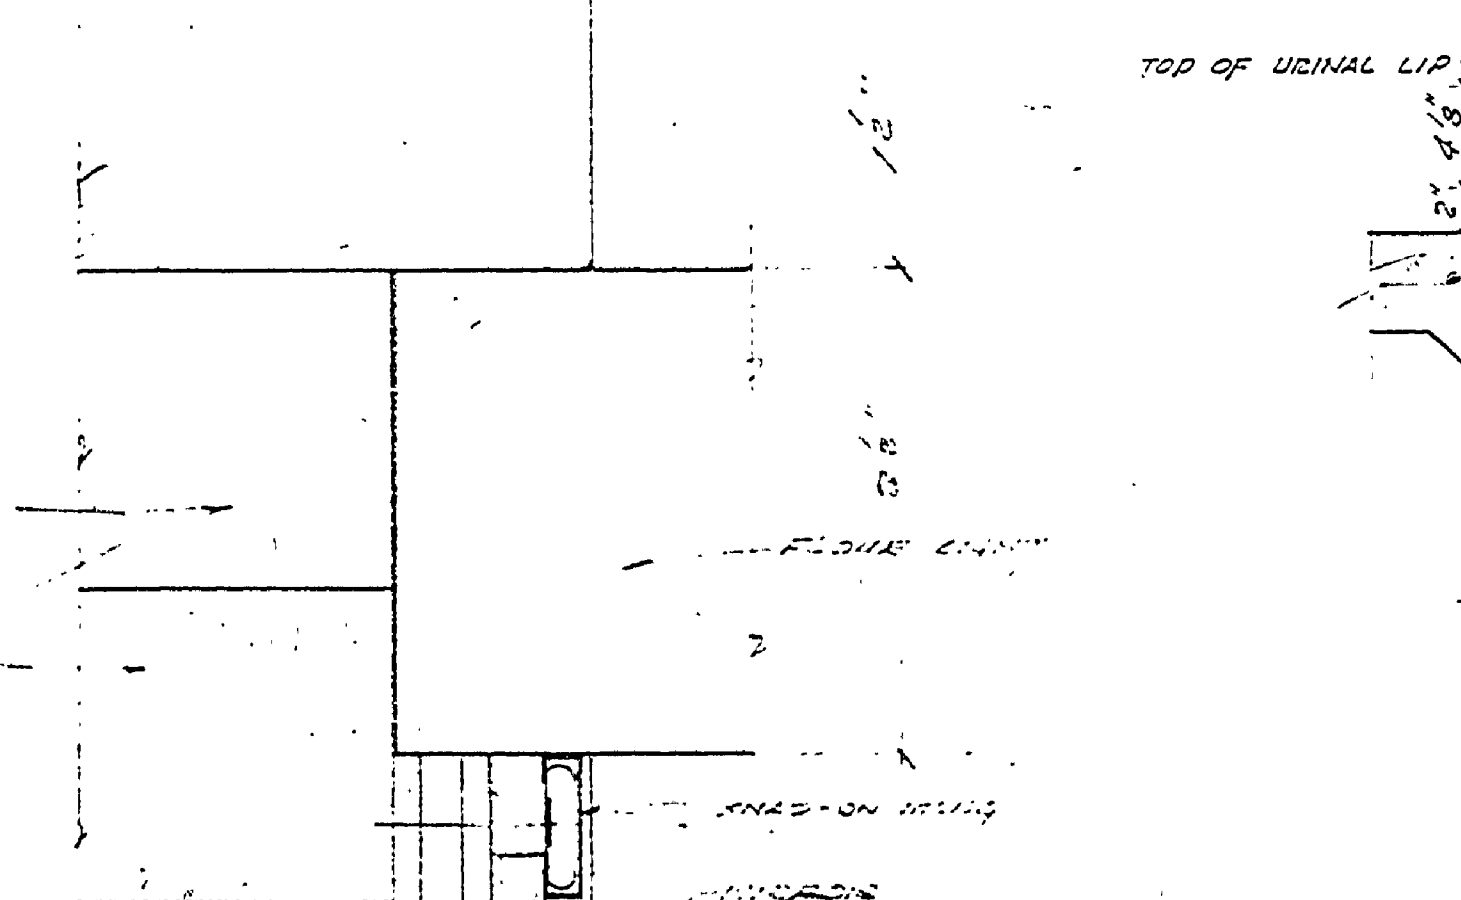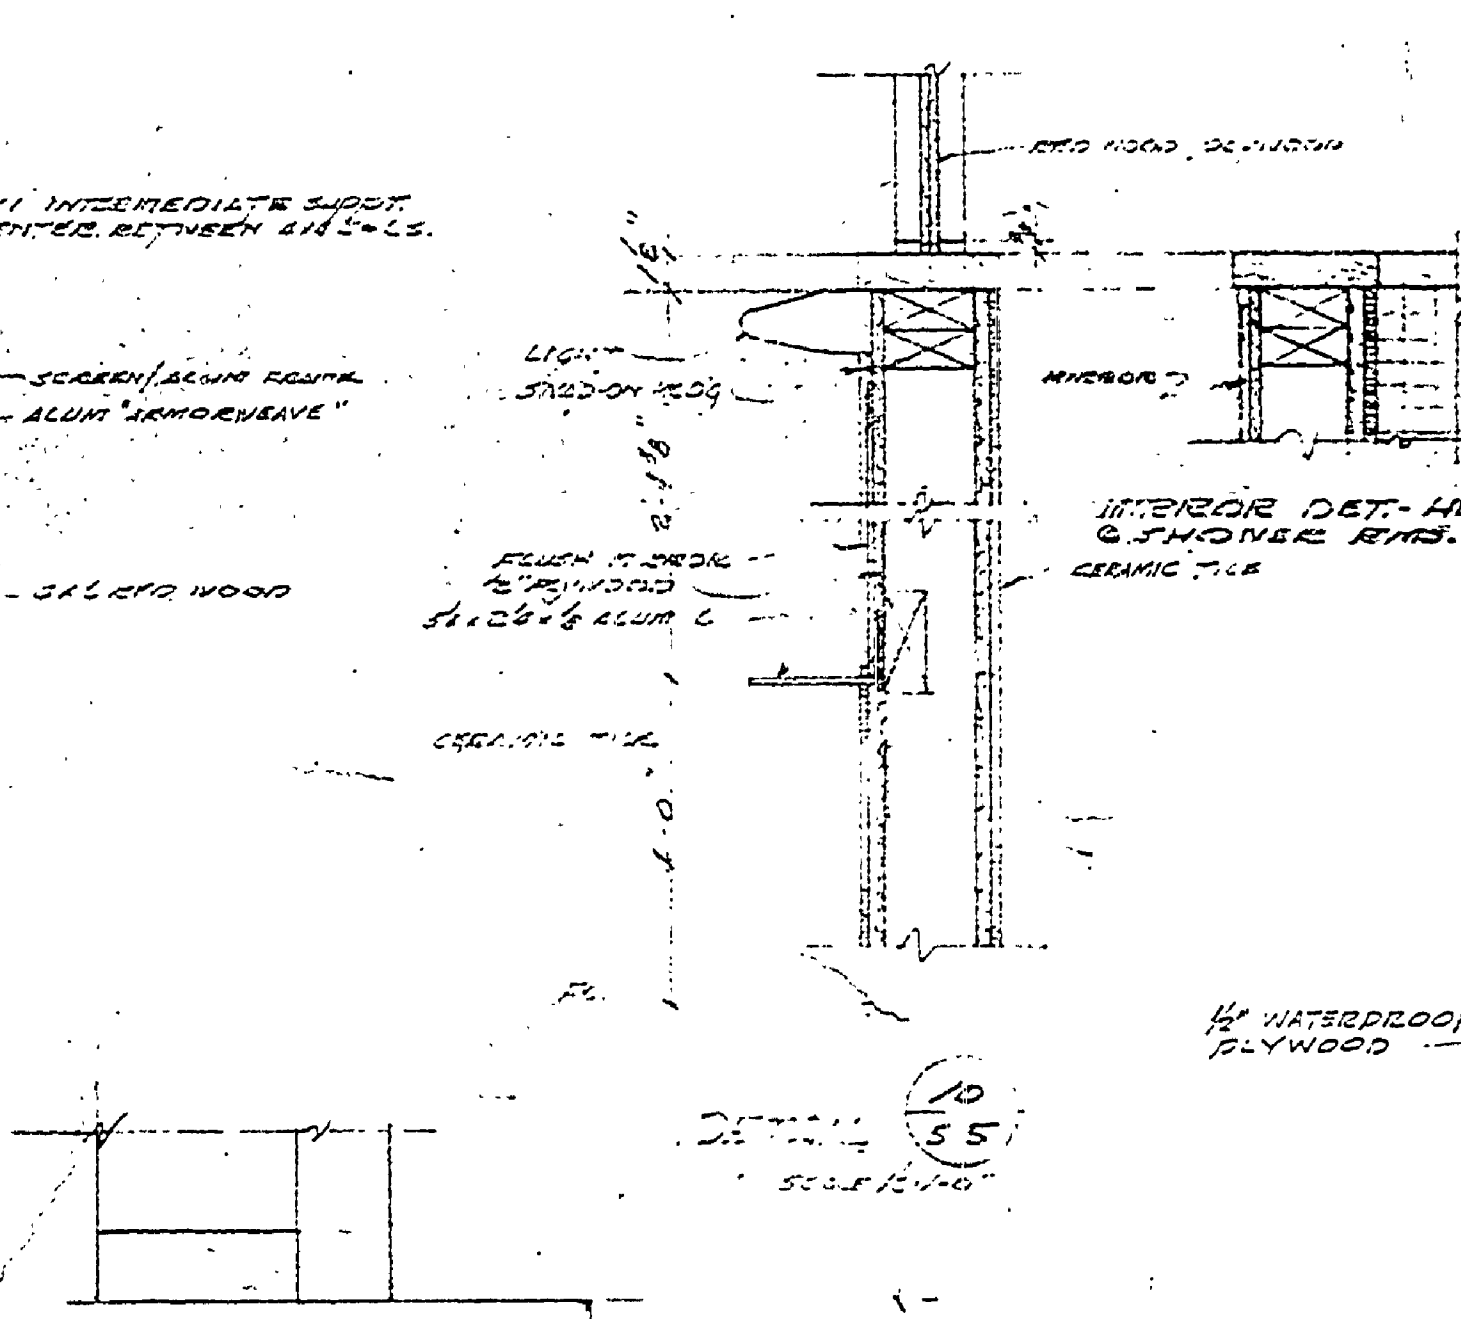

MIRROR & LIGHT DETAIL FULL SIZE

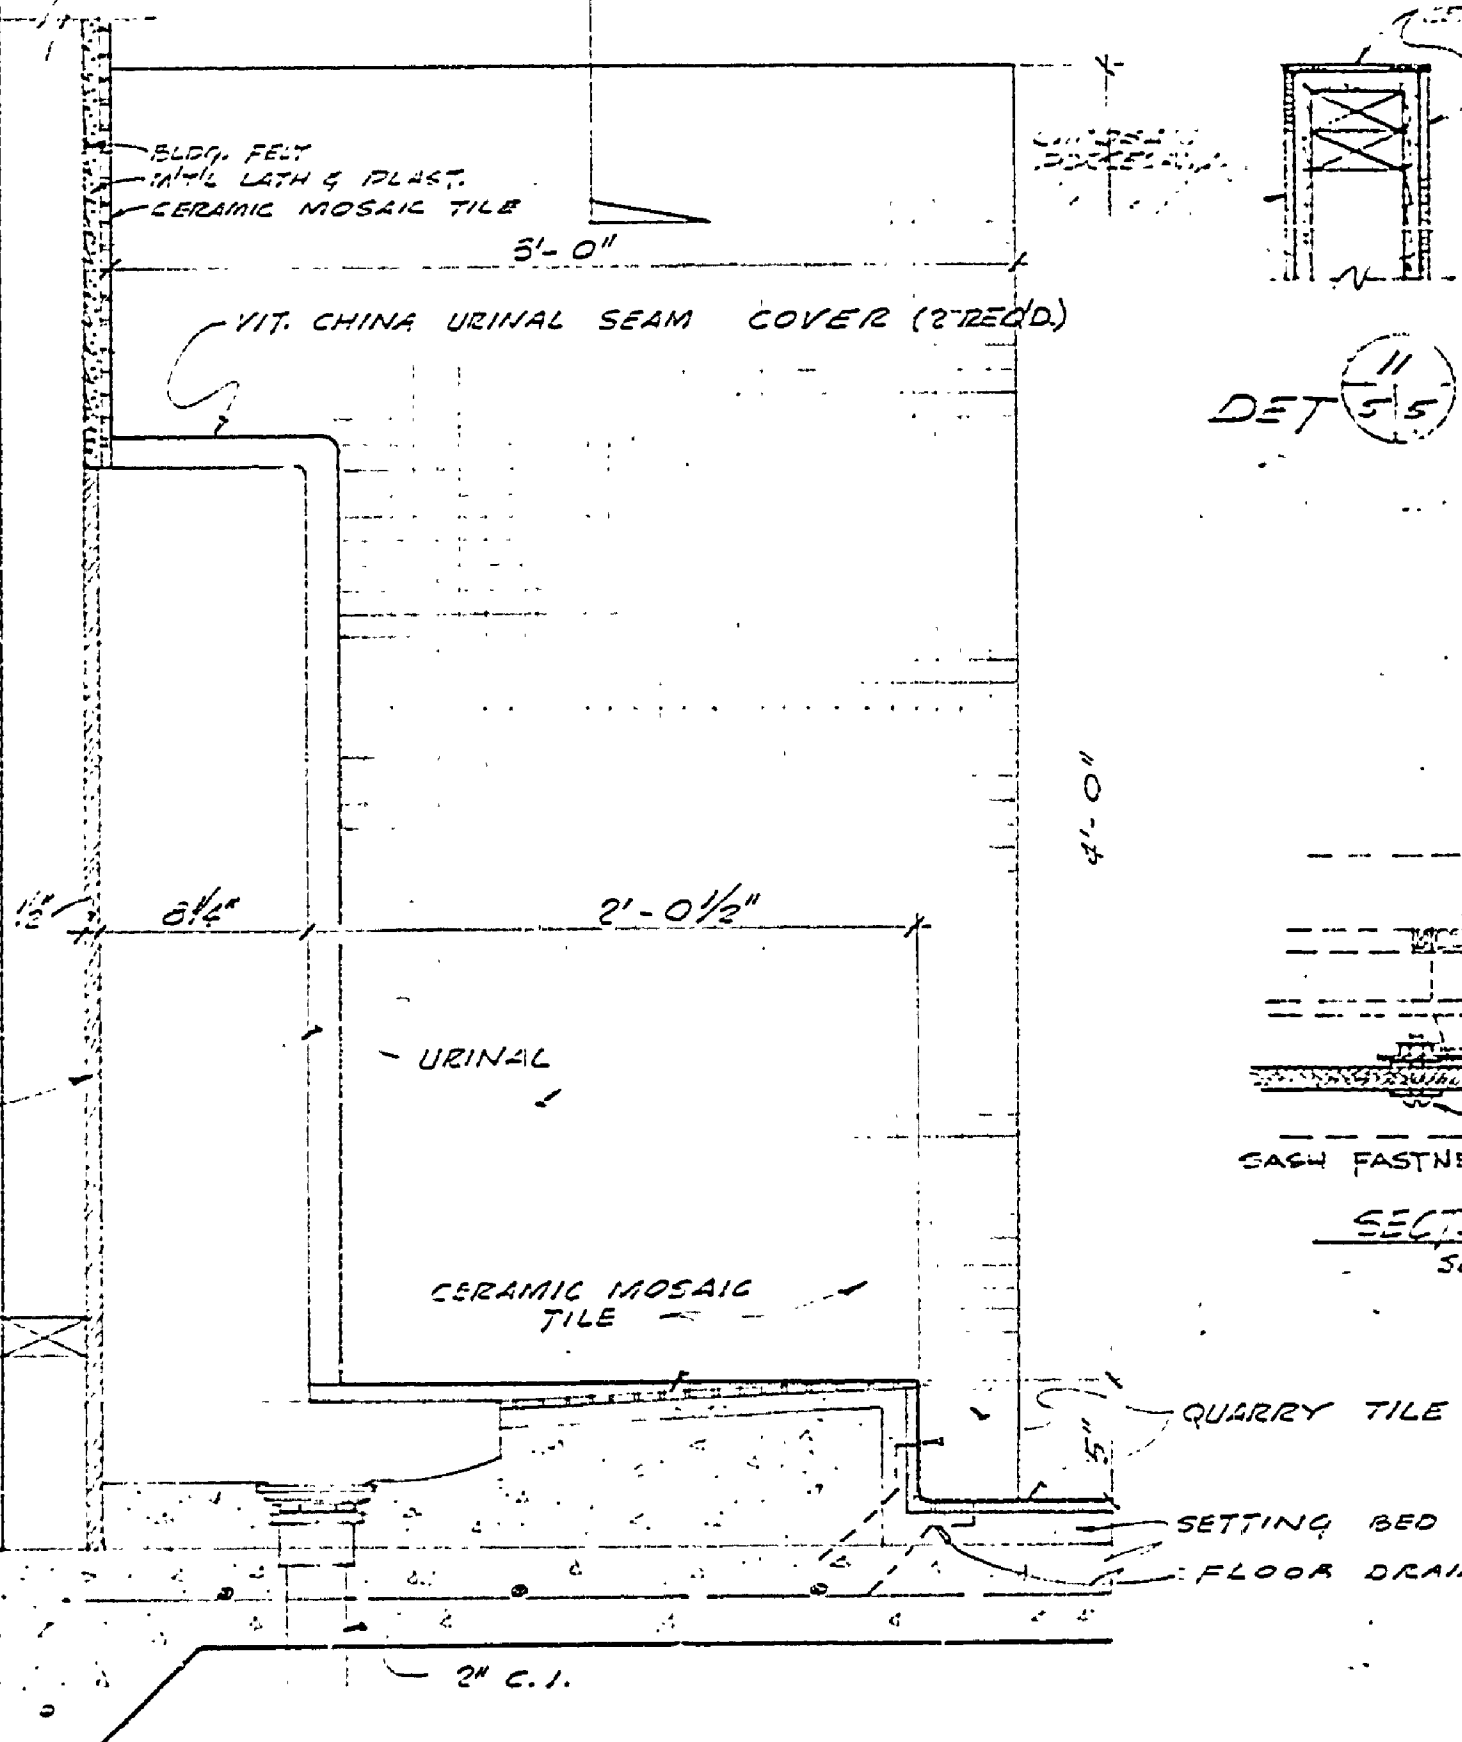

DET. 7 AT URINAL SCALE 1/2" = 1'-0"

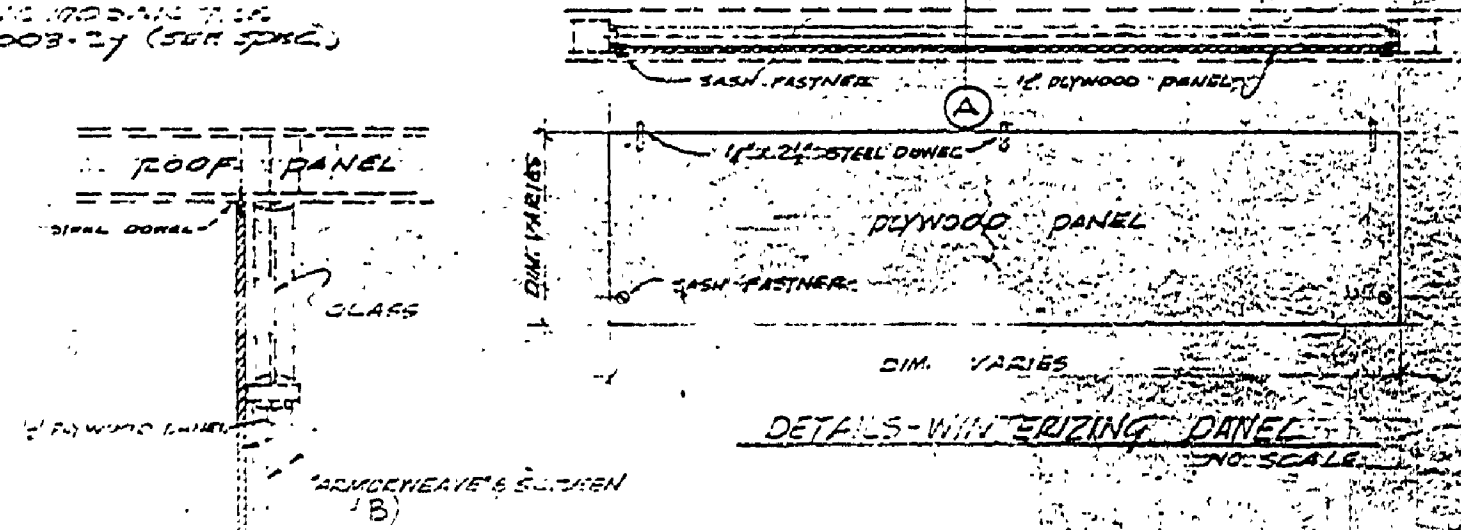

DETAILS - WINDOW CASING

TYPE	NO. REQD.	THICKNESS	WIDTH	HT.	REMARKS
A	8	1/2"	78"	24"	DOUBLE GLAZING
B	6	1/2"	78"	12"	"
C	2	1/2"	48"	24"	"
D	2	1/2"	48"	12"	"
E	2	1/2"	48"	12"	"
F	2	1/2"	48"	24"	"
G	2	1/2"	108"	24"	"

NO.	TYPE	FRAME	THICKNESS	WIDTH	HT.	REMARKS
1	A	HD	1 1/2"	36"	70"	WOOD
2	A	HD	1 1/2"	36"	70"	"
3	A	HD	1 1/2"	36"	70"	"
4	A	HD	1 1/2"	36"	70"	"
5	B	STL	1 1/2"	36"	70"	ALUMINUM
6	B	STL	1 1/2"	36"	70"	"
7	B	STL	1 1/2"	36"	70"	"
8	B	STL	1 1/2"	36"	70"	"

NO.	DESCRIPTION	ROOM	WALL	CEILING	FLOOR	REMARKS
1	PAINT	TOILET	PAINT	PAINT	PAINT	
2	PAINT	TOILET	PAINT	PAINT	PAINT	
3	PAINT	TOILET	PAINT	PAINT	PAINT	
4	PAINT	TOILET	PAINT	PAINT	PAINT	
5	PAINT	TOILET	PAINT	PAINT	PAINT	
6	PAINT	TOILET	PAINT	PAINT	PAINT	
7	PAINT	TOILET	PAINT	PAINT	PAINT	
8	PAINT	TOILET	PAINT	PAINT	PAINT	
9	PAINT	TOILET	PAINT	PAINT	PAINT	
10	PAINT	TOILET	PAINT	PAINT	PAINT	
11	PAINT	TOILET	PAINT	PAINT	PAINT	
12	PAINT	TOILET	PAINT	PAINT	PAINT	
13	PAINT	TOILET	PAINT	PAINT	PAINT	
14	PAINT	TOILET	PAINT	PAINT	PAINT	
15	PAINT	TOILET	PAINT	PAINT	PAINT	
16	PAINT	TOILET	PAINT	PAINT	PAINT	
17	PAINT	TOILET	PAINT	PAINT	PAINT	
18	PAINT	TOILET	PAINT	PAINT	PAINT	
19	PAINT	TOILET	PAINT	PAINT	PAINT	
20	PAINT	TOILET	PAINT	PAINT	PAINT	