




DATE	REVIEWED	DATE	APPROVED	DATE	NO.	DATE	BY
	ARCHITECTURAL				1		
	ENGINEERING				2		
	LANDSCAPE				3		
					4		
					5		
					6		

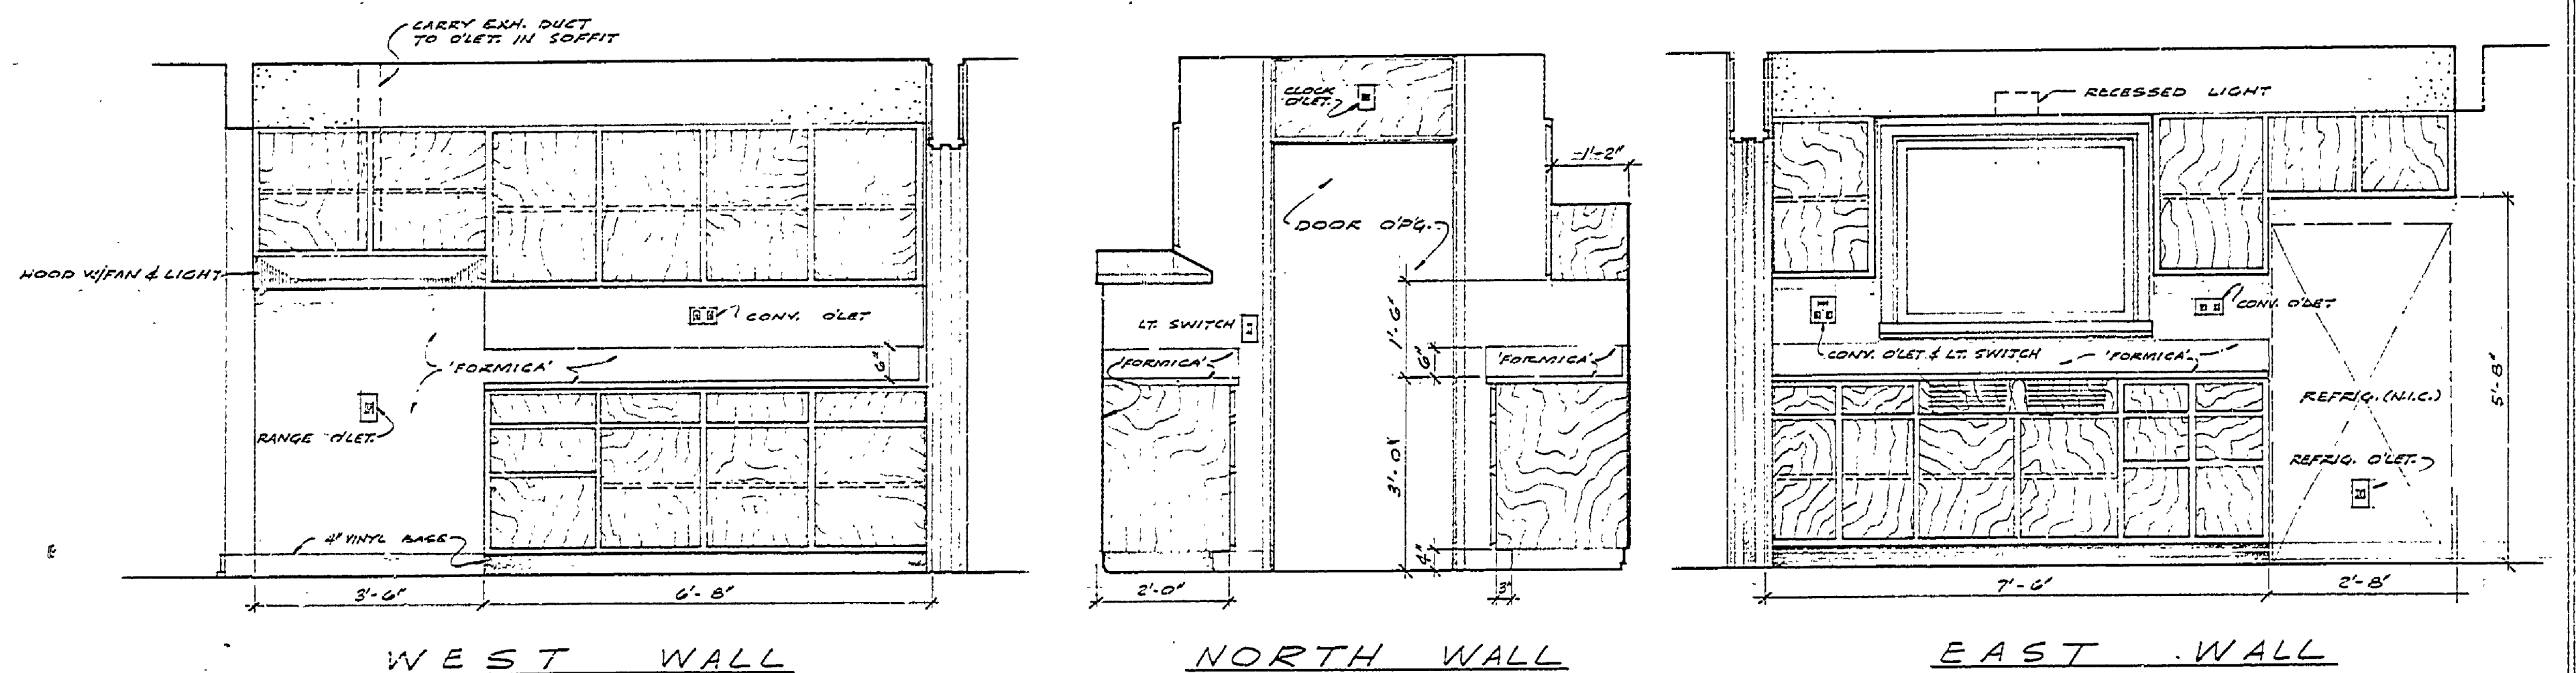

WEST WALL NORTH WALL EAST WALL  
**KITCHEN CASES**  
 SCALE - 1/2" = 1'-0"

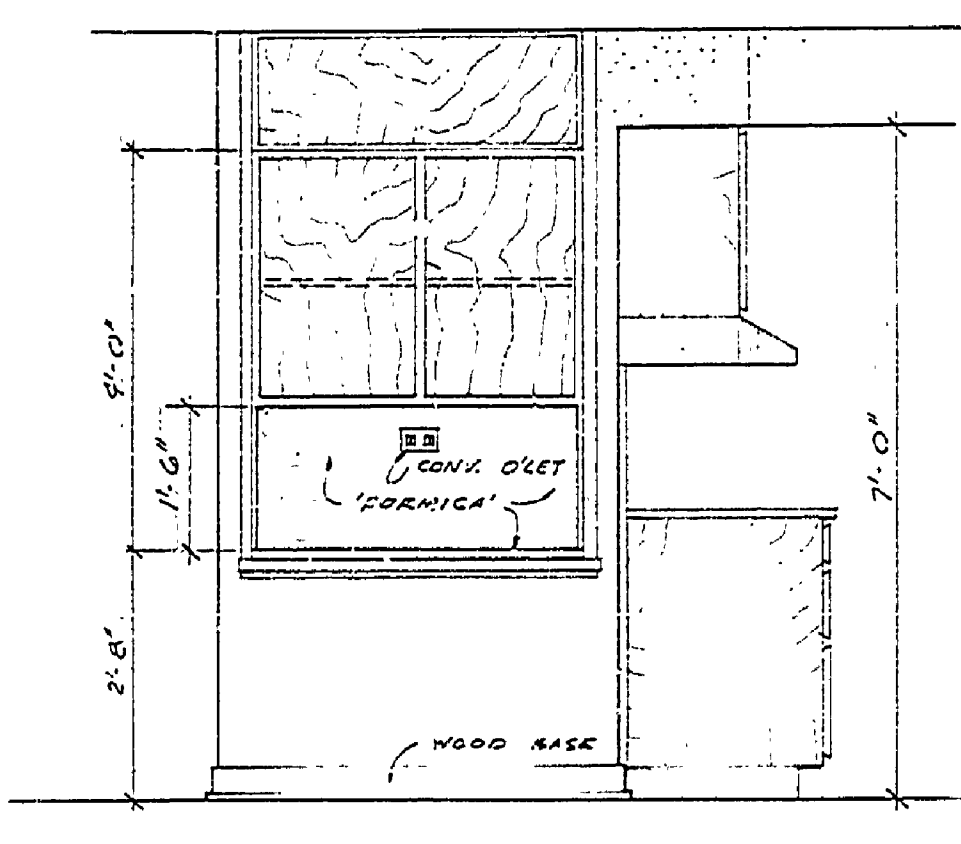


CHINA CAB. (DIN. RM.)  
 SCALE - 1/2" = 1'-0"

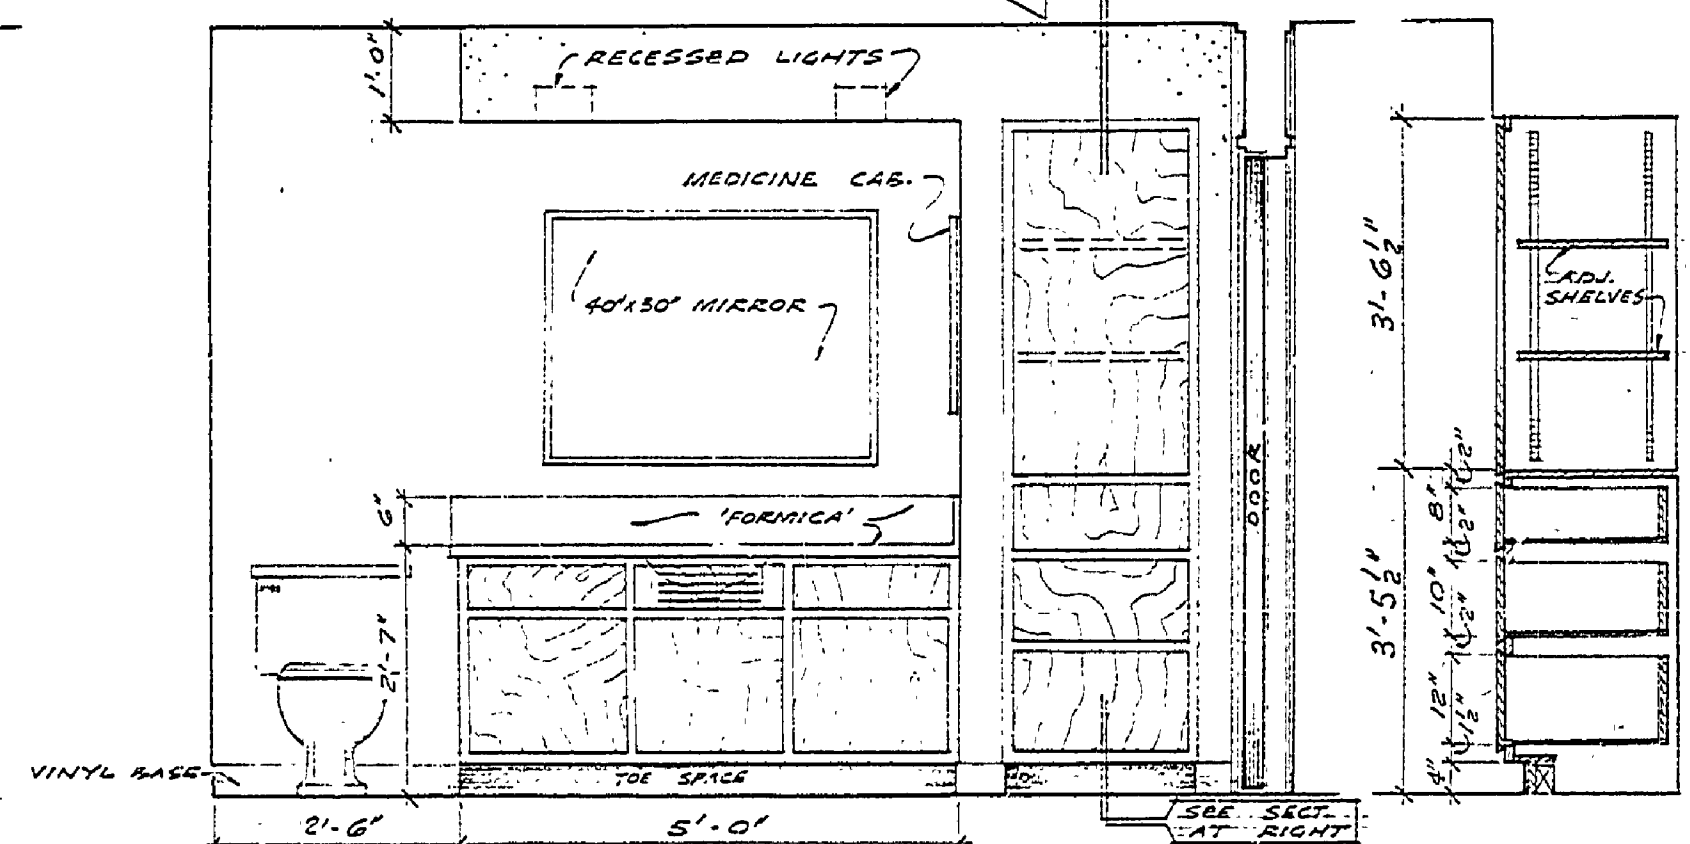


NORTH WALL (BATH) SECT. - LINEN CAB  
 SCALE - 1/2" = 1'-0"


NOTE: ALL DRAWERS TO BE HUNG W/ EXTENSION SLIDES (SEE SPEC)

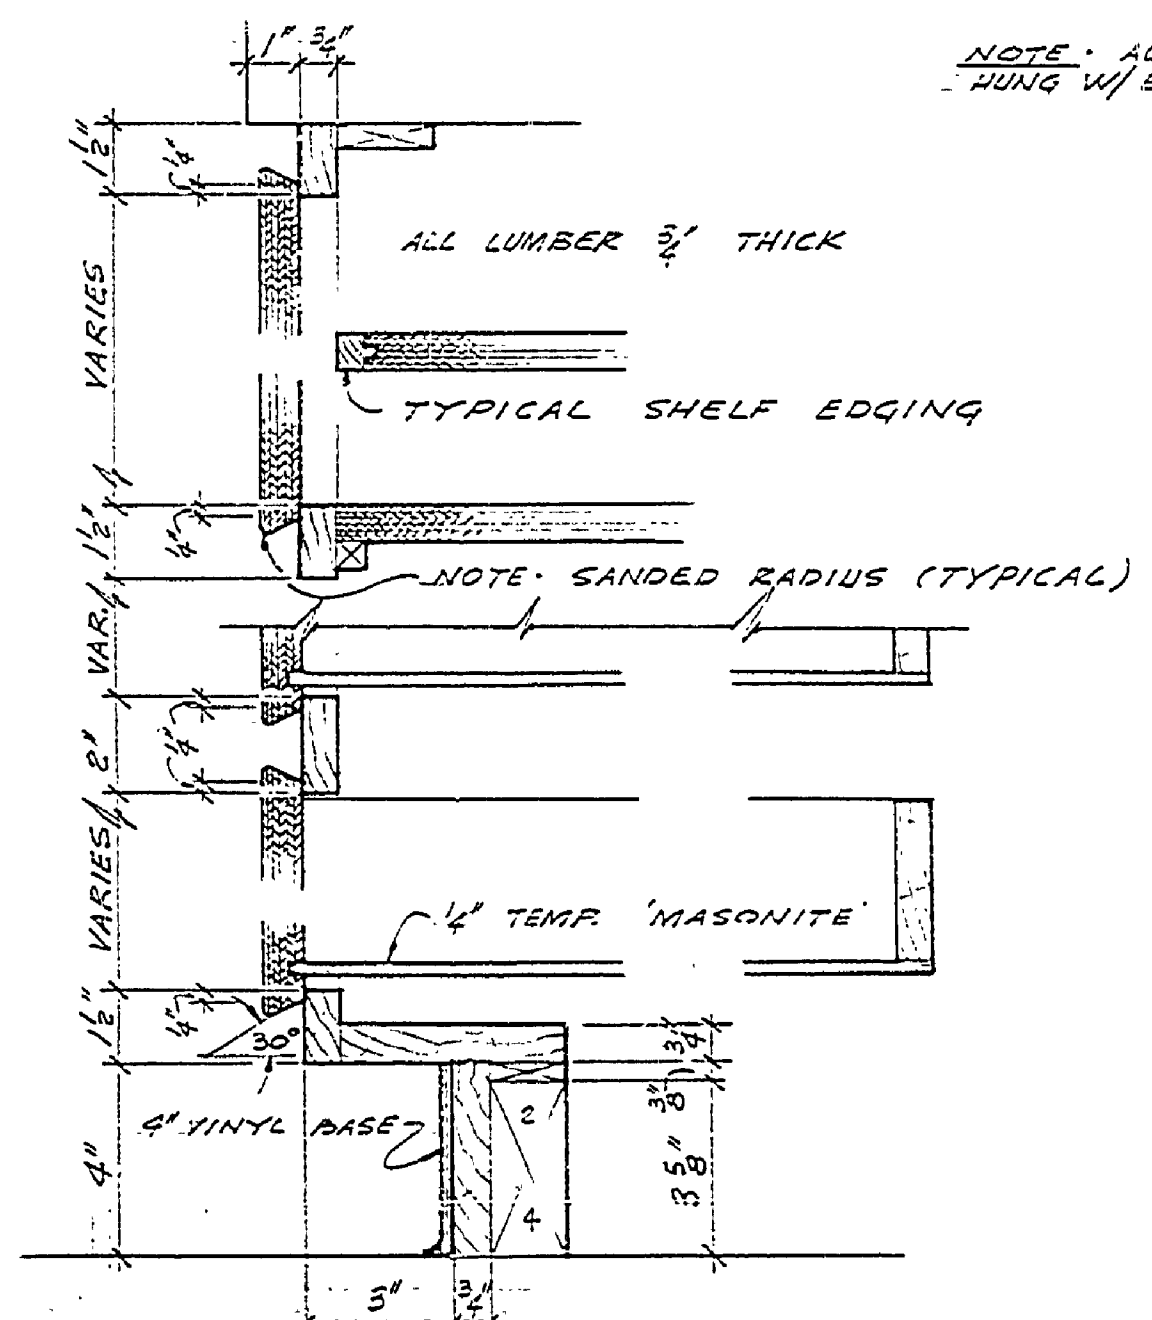

CABINET DETAILS  
 SCALE - 3/8" = 1'-0"

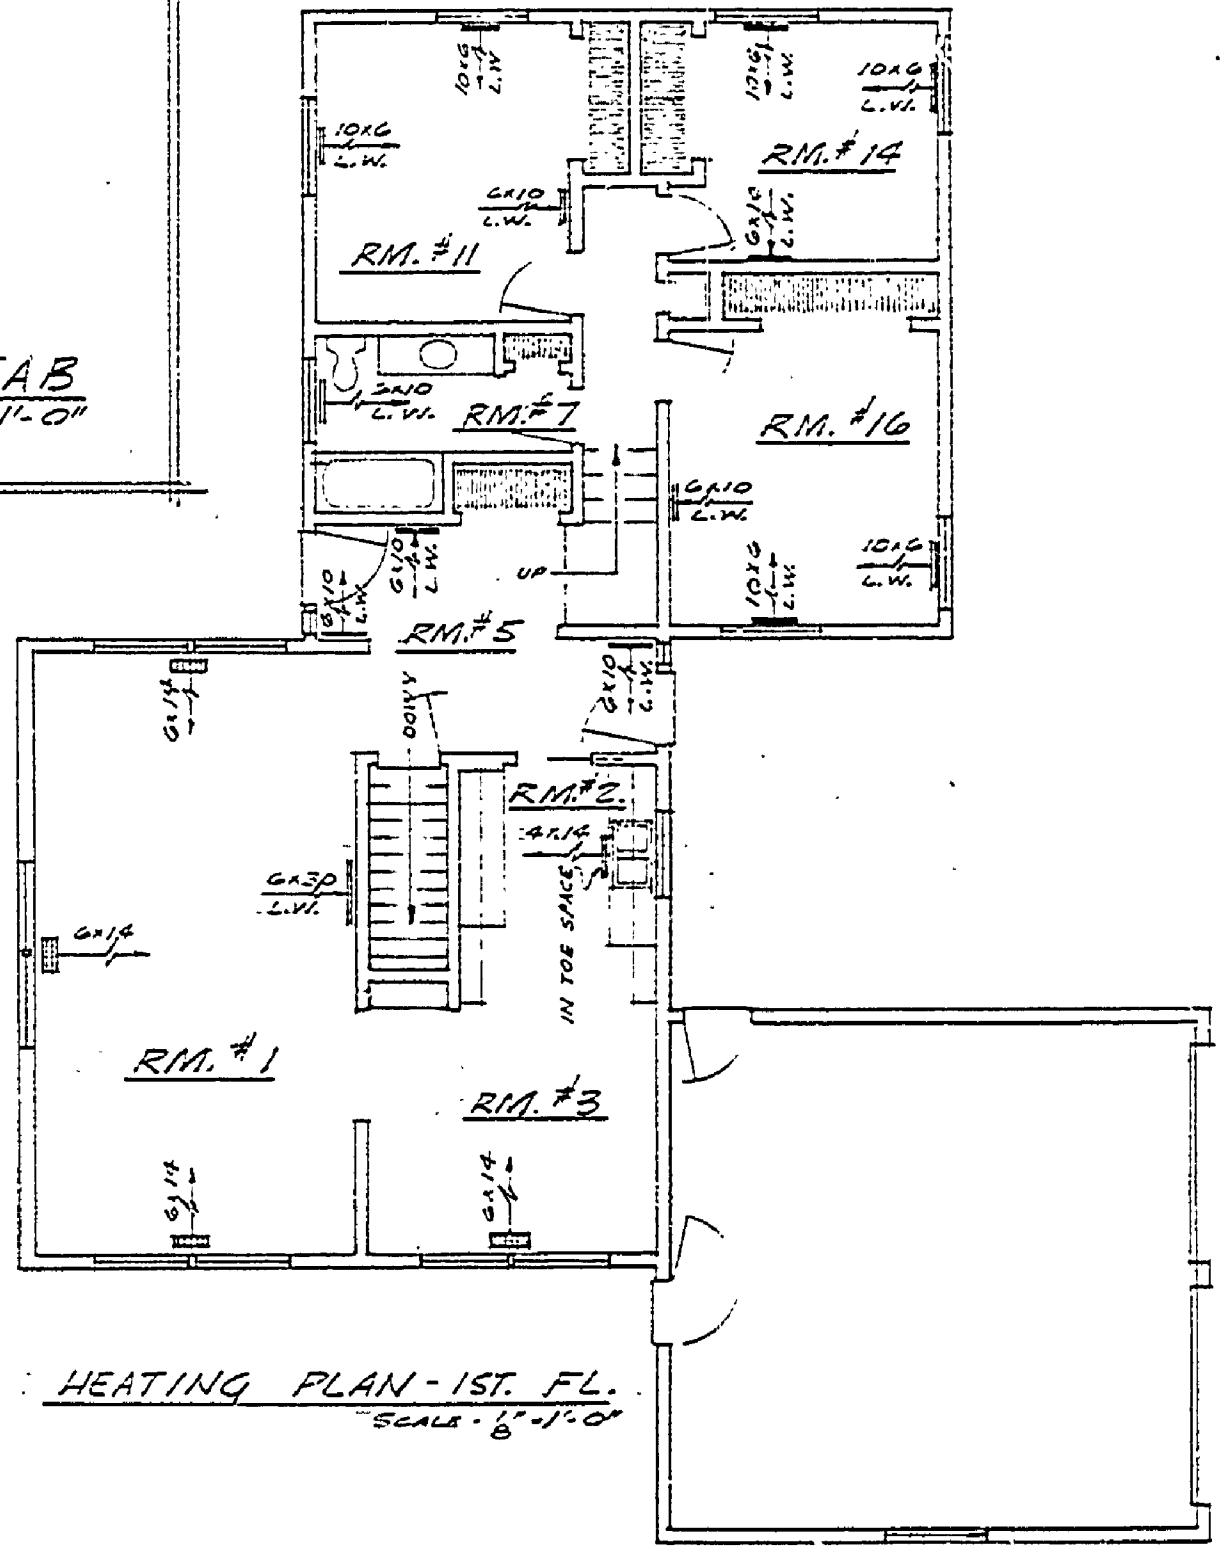

HEATING PLAN - 1ST FL.  
 SCALE - 1/4" = 1'-0"

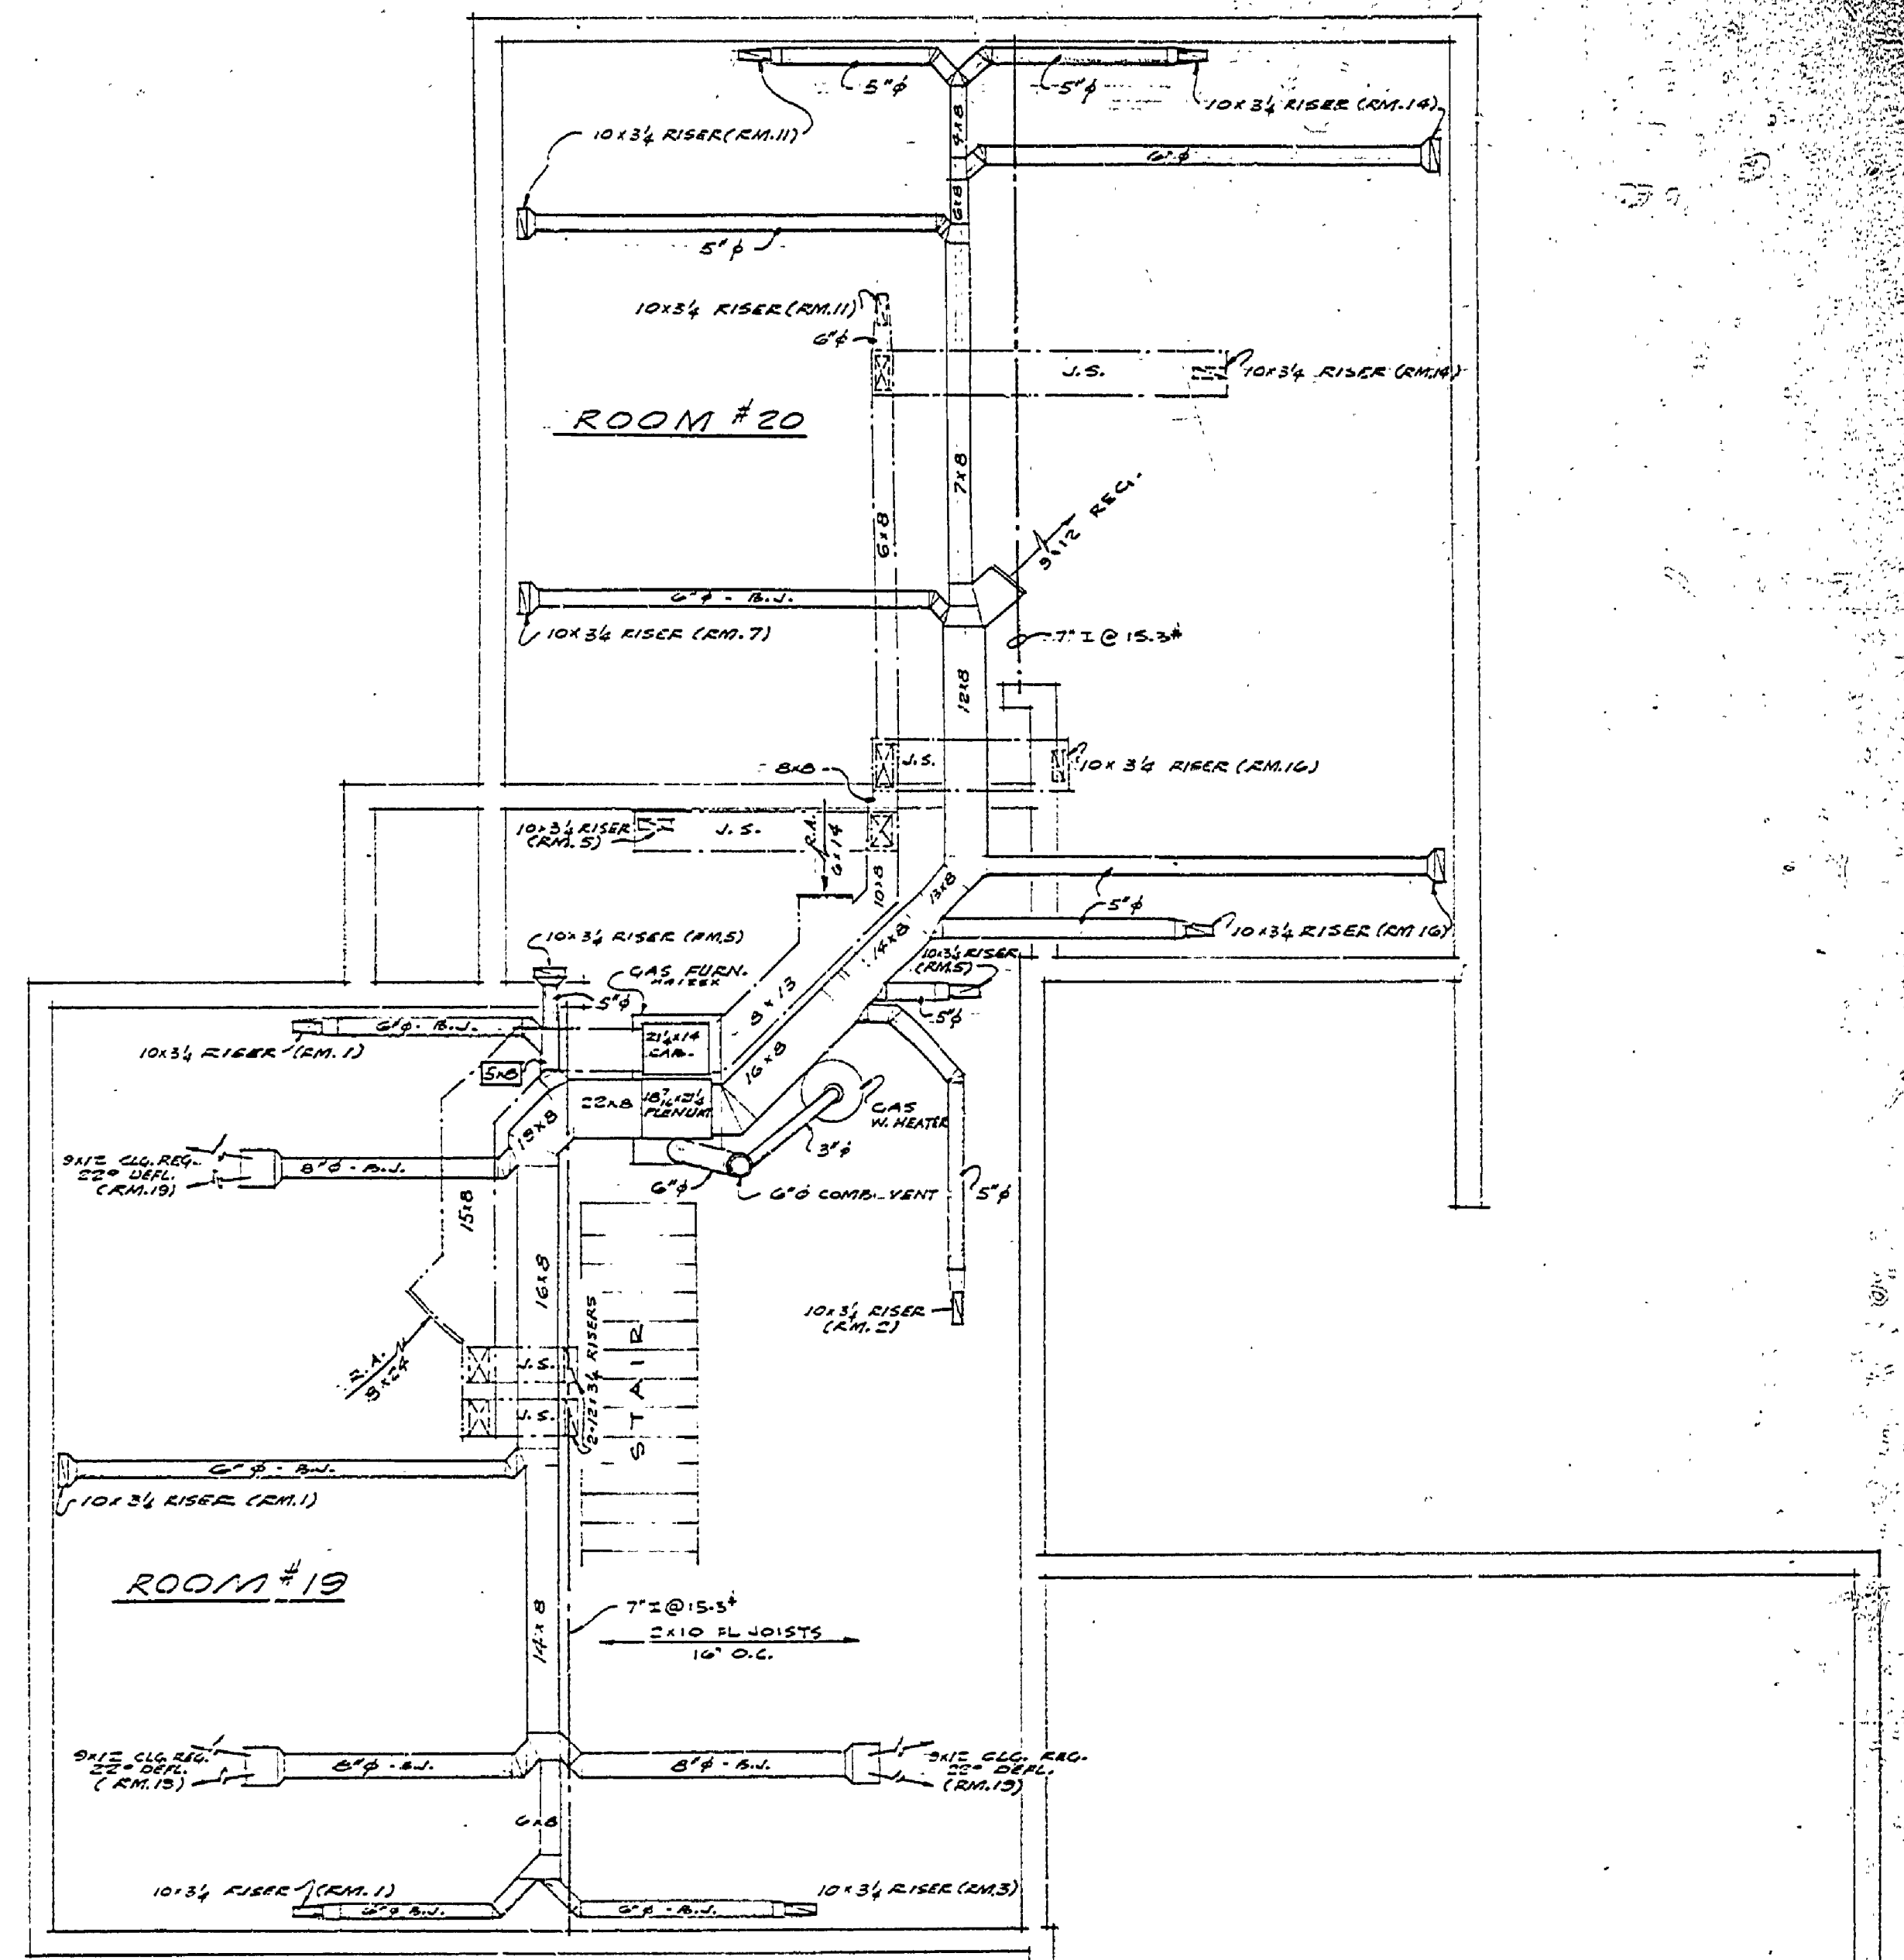

HEATING PLAN - BASEMENT  
 SCALE - 1/4" = 1'-0"

**SYMBOLS & ABBREVIATIONS**

RISER	---
DUCT	---
REGISTER	---
FLOOR REGISTER	---
L.V. - LOW WALL	---
C.G. - CEILING	---
WARM AIR	---
RETURN AIR	---
B.J. - DUCT BETWEEN JOISTS	---
J.S. - JOIST SPACE USED AS RETURN DUCT	---

CONSERVATION COMMISSION APPROVAL	
BY: _____	DATE: _____
RECOMMENDED DESIGN	
FOR APPROVAL: _____	DATE: _____
RECOMMENDED DESIGNER	
FOR APPROVAL: _____	DATE: _____
IN CHARGE OF DESIGN	
SECTION APPROVAL	
BY: _____	DATE: _____
SECTION CHIEF	
MICHIGAN DEPARTMENT OF CONSERVATION	
APPROVED: _____	DATE: _____
CHIEF ENGINEER	
PLAN NO. _____	PROJECT NUMBER _____
SHEET NO. 16	OF 2
PLAN NO. A-106	