




REVISIONS	DATE	BY
4		
5		
6		

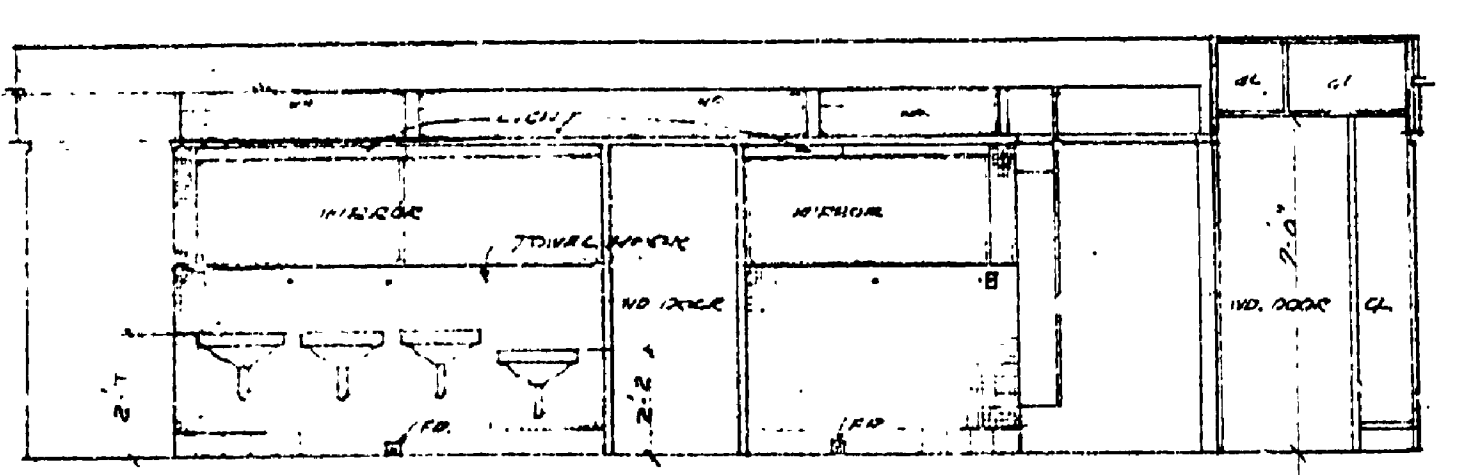


WEST INTERIOR ELEV. - WOMEN'S TOILET
SCALE: 1/8" = 1'-0"

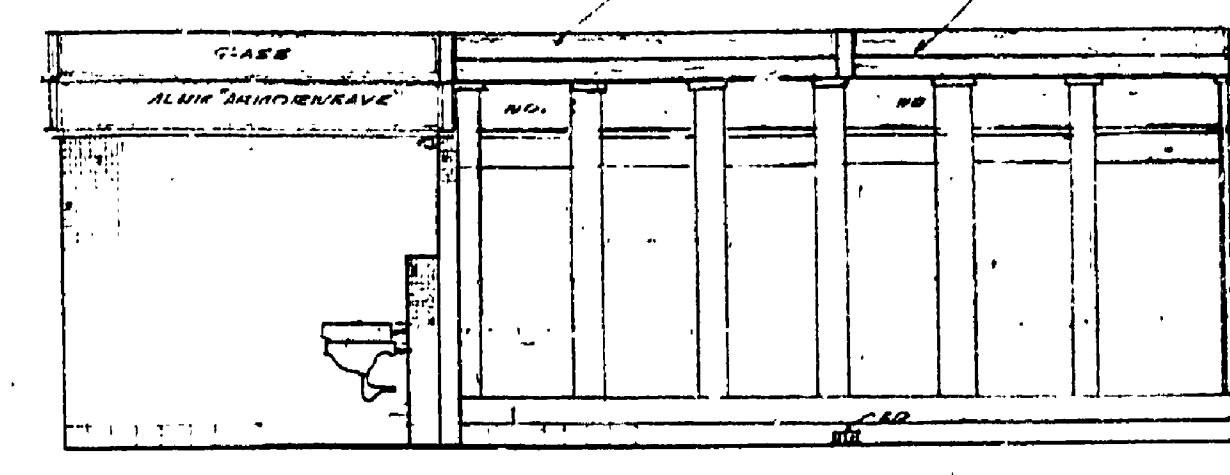


SOUTH INTERIOR ELEV. - WOMEN'S TOILET
SCALE: 1/8" = 1'-0"

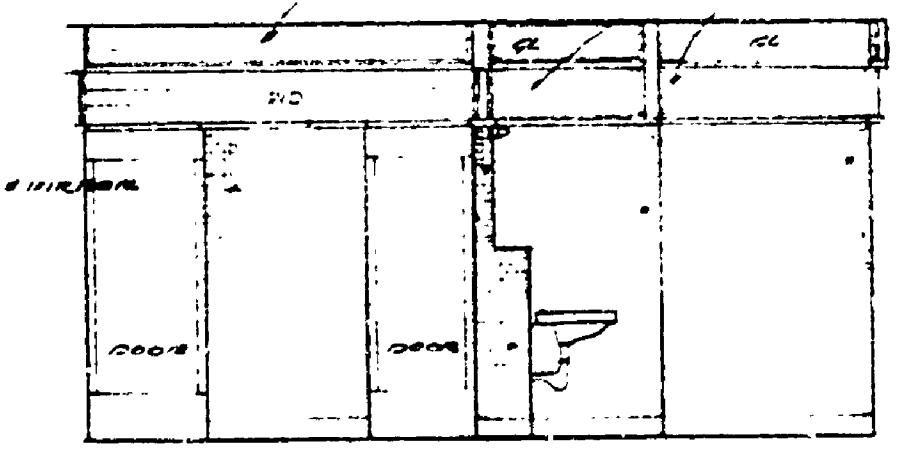


WEST INT. ELEV. - WOMEN'S TOILET
SCALE: 1/8" = 1'-0"

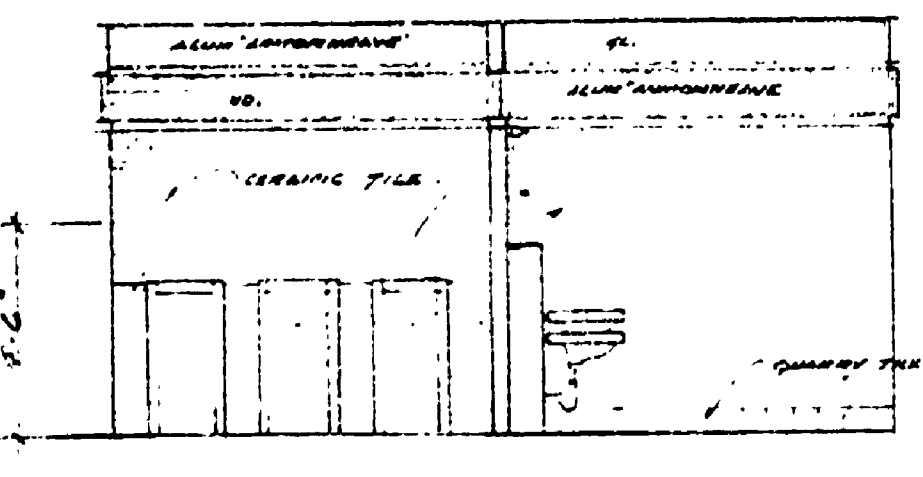


SOUTH INT. ELEV. - MEN'S TOILET
SCALE: 1/8" = 1'-0"

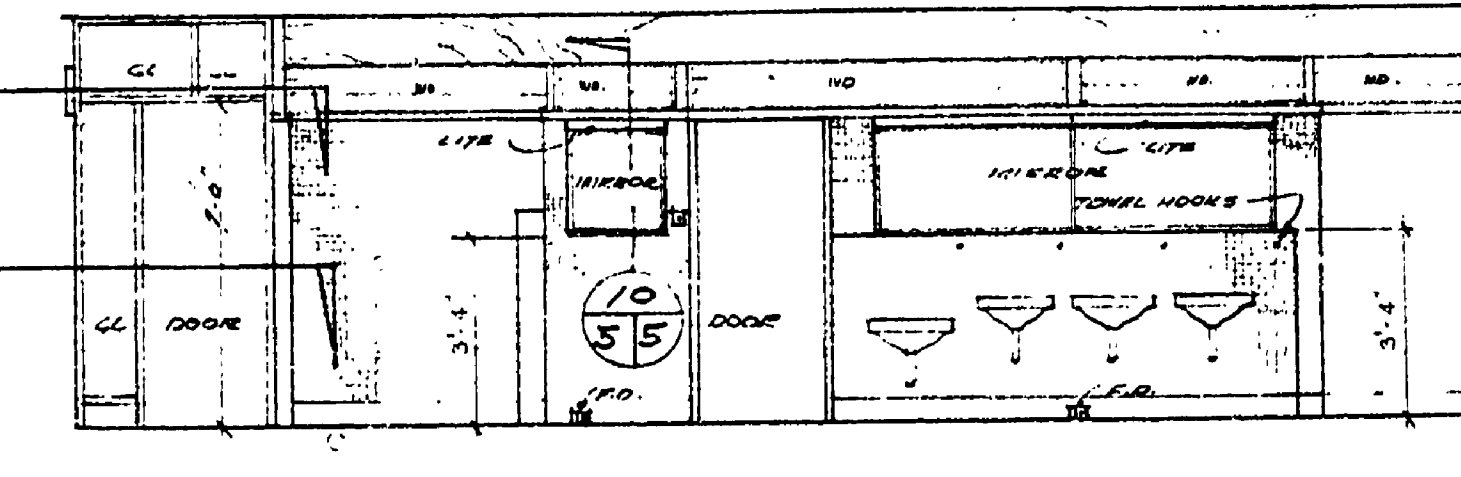


EAST INTERIOR ELEVATION - MEN'S TOILET
SCALE: 1/8" = 1'-0"

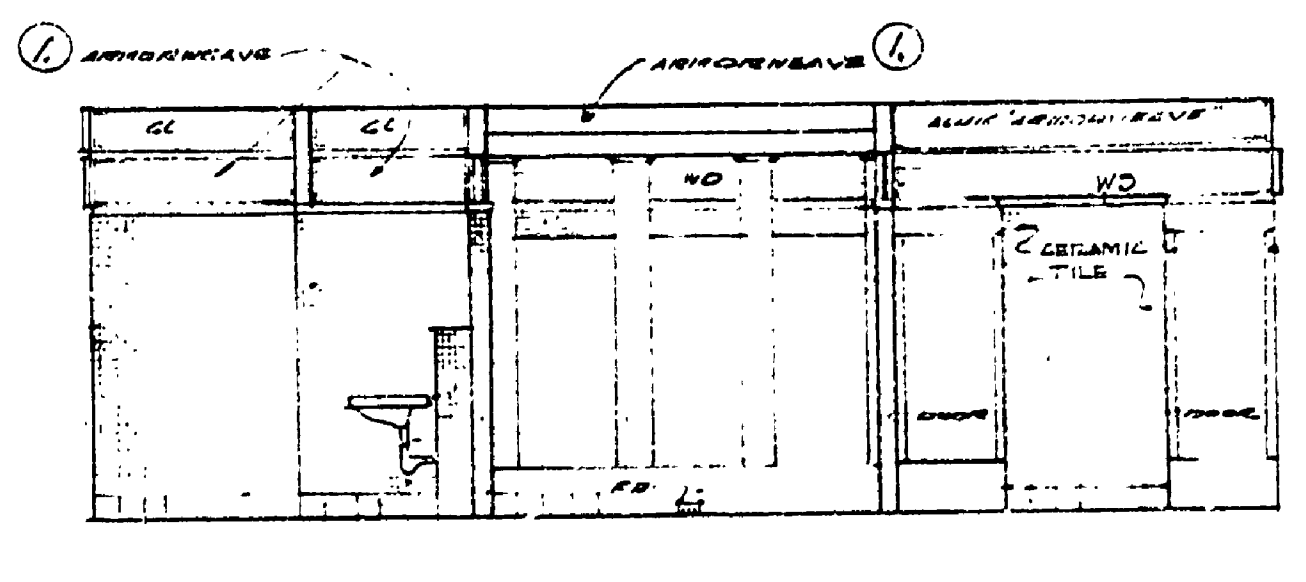

NORTH INTERIOR ELEV. - MEN'S TOILET
SCALE: 1/8" = 1'-0"

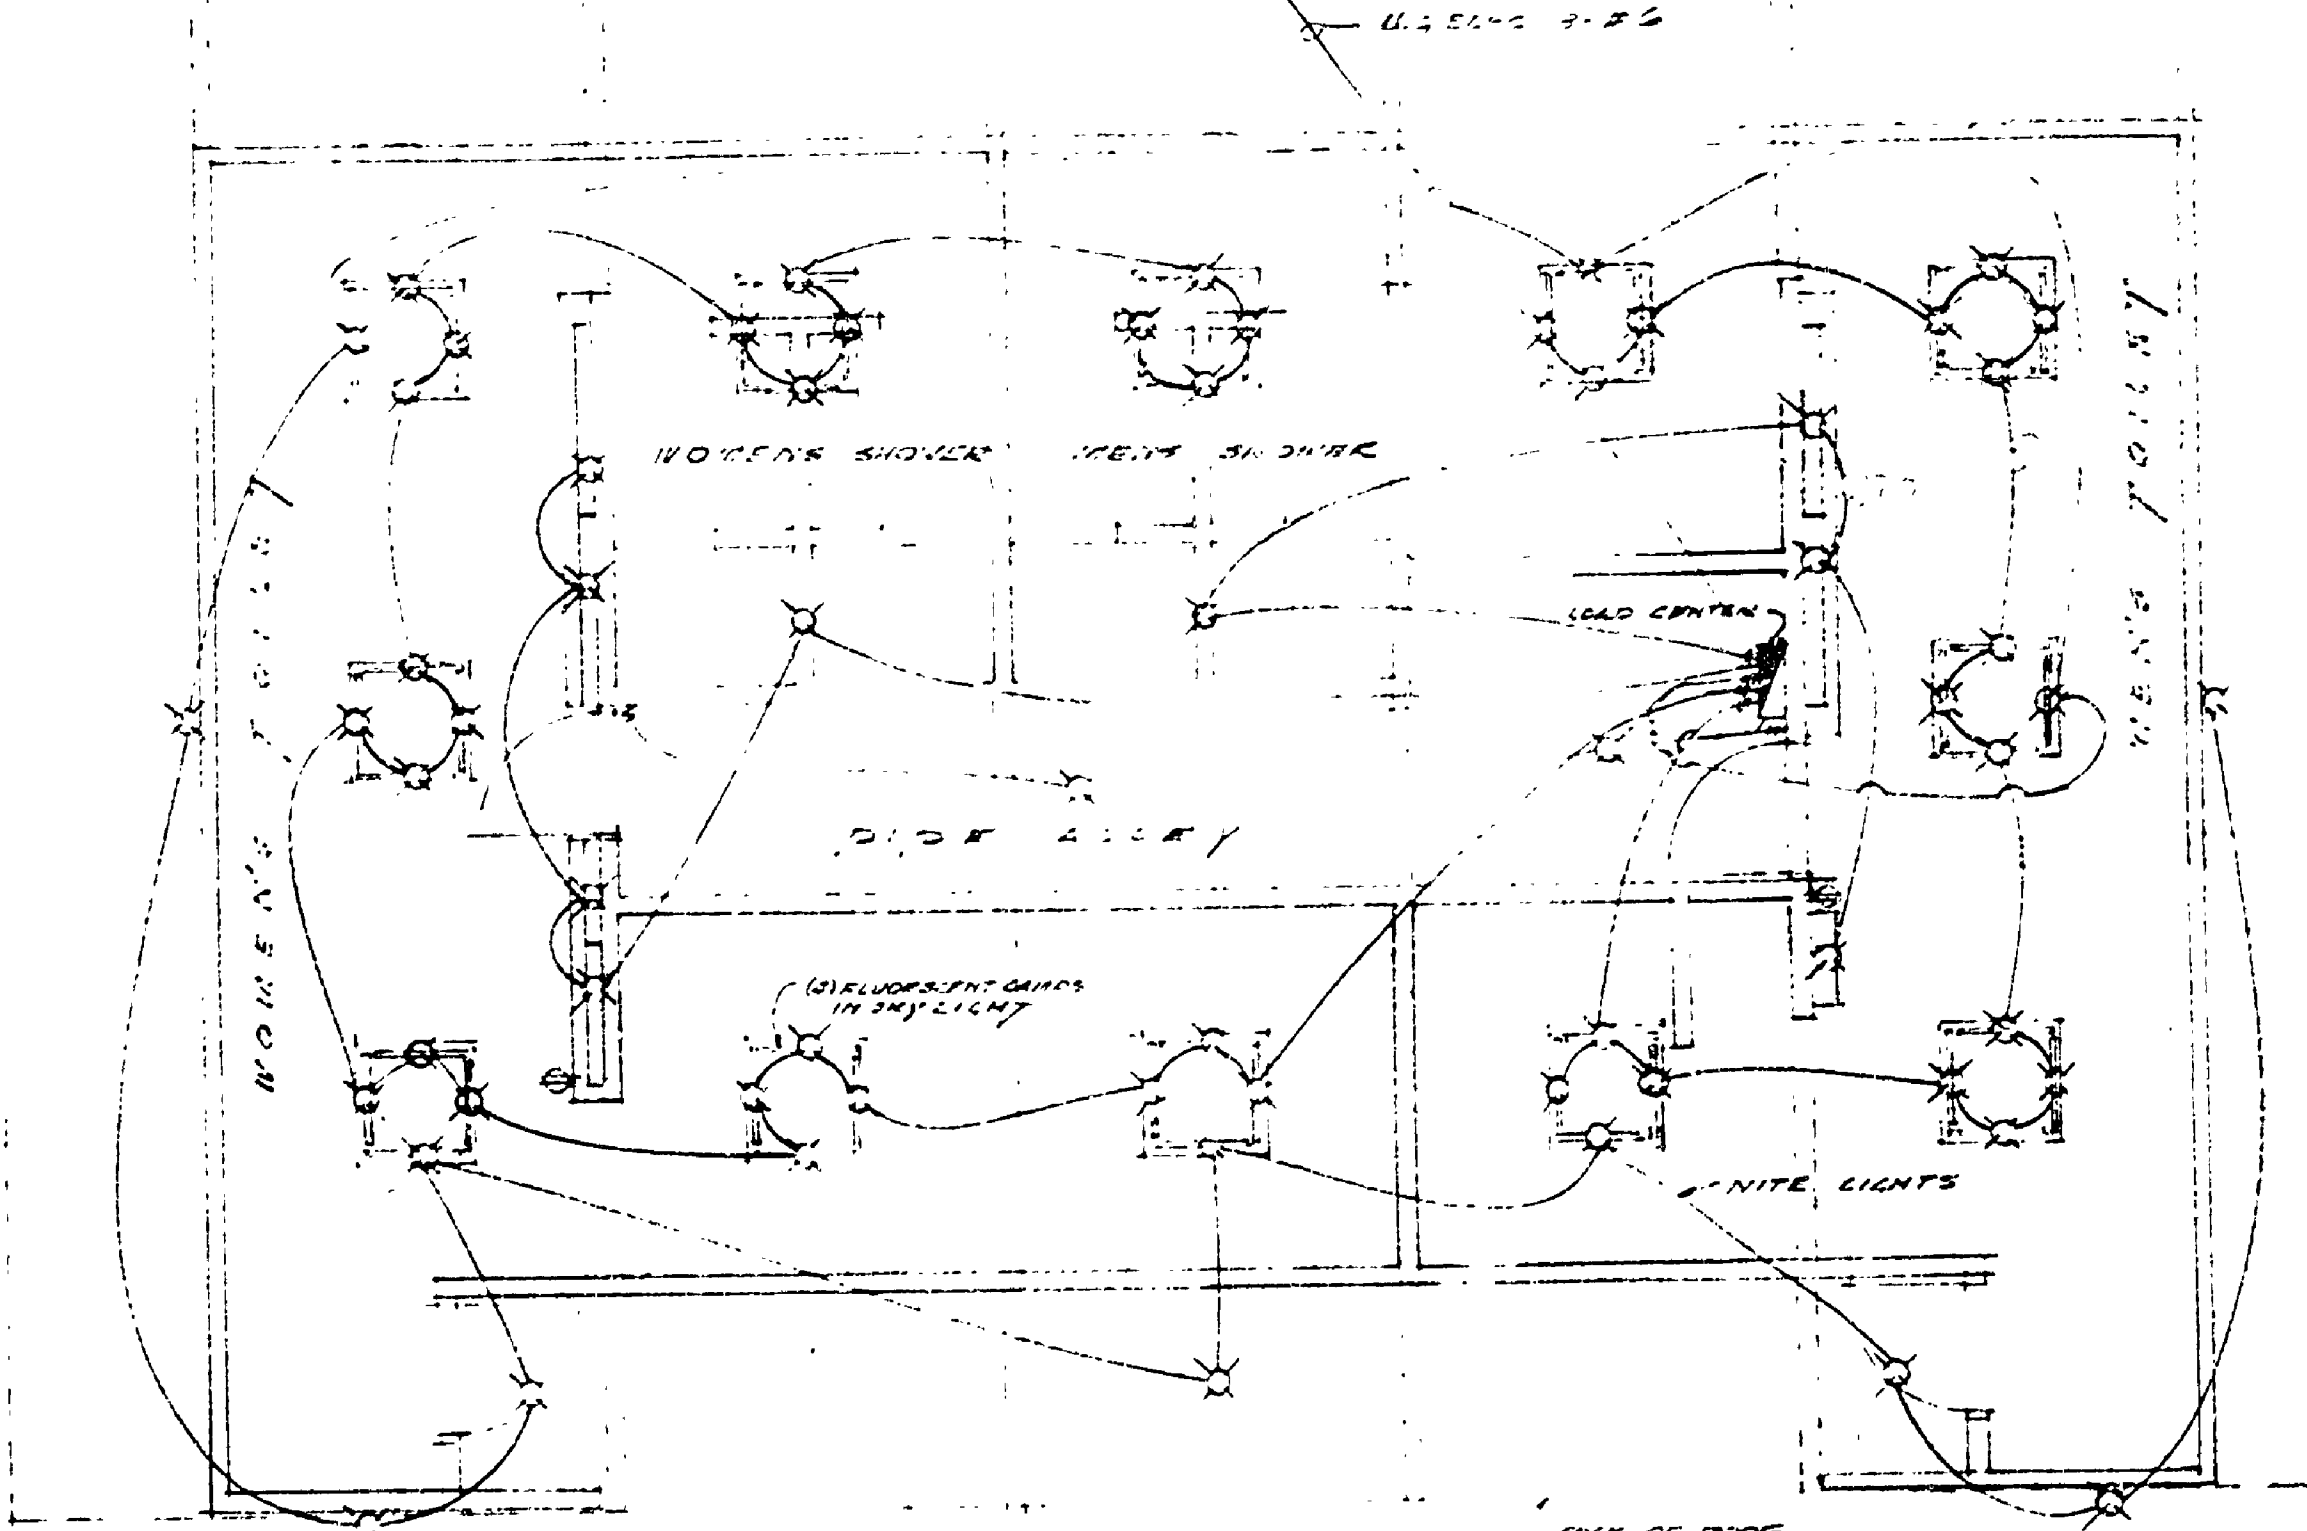


ELECTRICAL LIGHTING PLAN
SCALE: 1/8" = 1'-0"

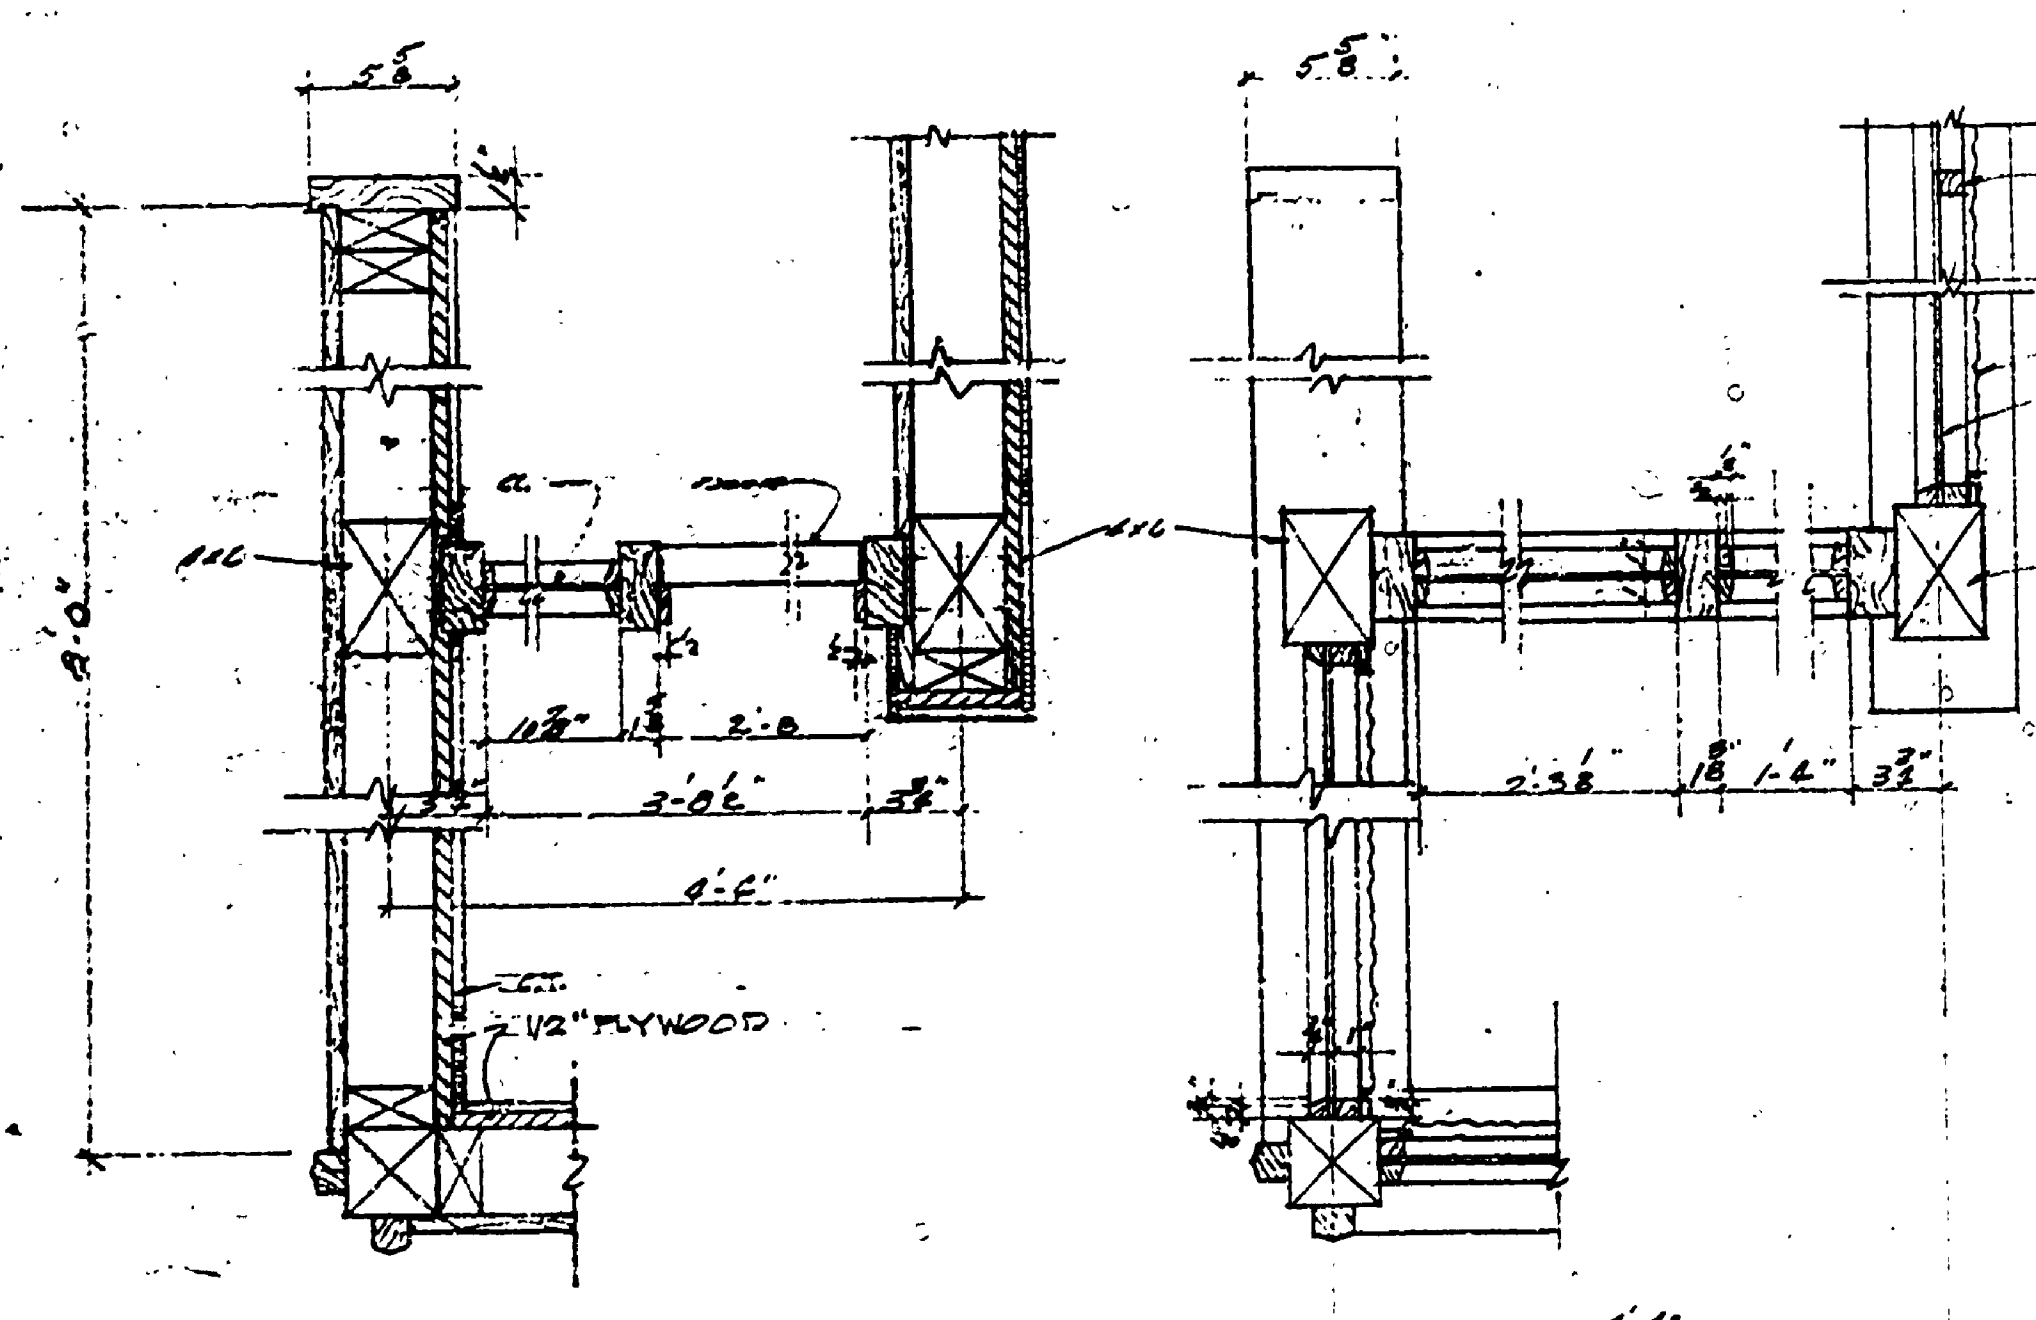


ENTRANCE DET. 9
SCALE: 1/8" = 1'-0"


ENTRANCE DET. 8
SCALE: 1/8" = 1'-0"

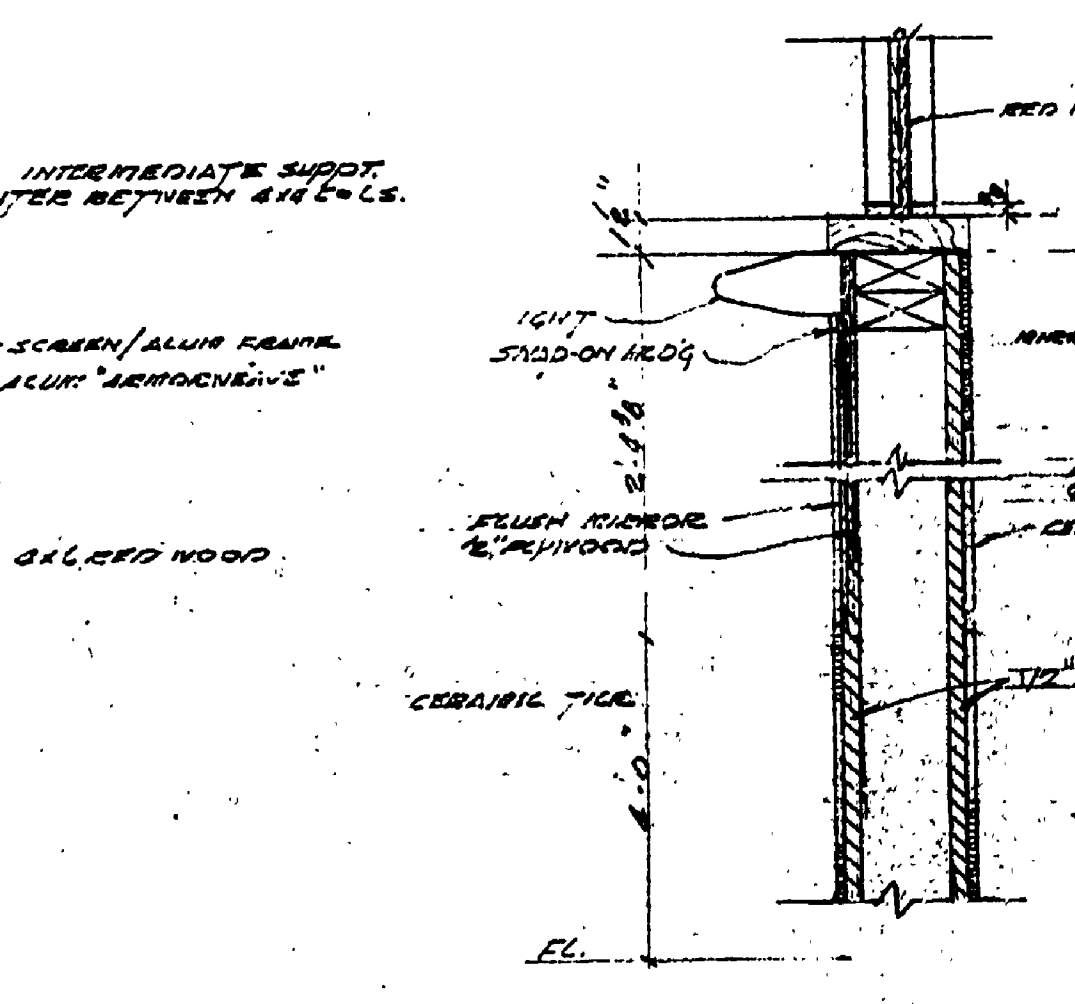

DETAIL 10
SCALE: 1/8" = 1'-0"

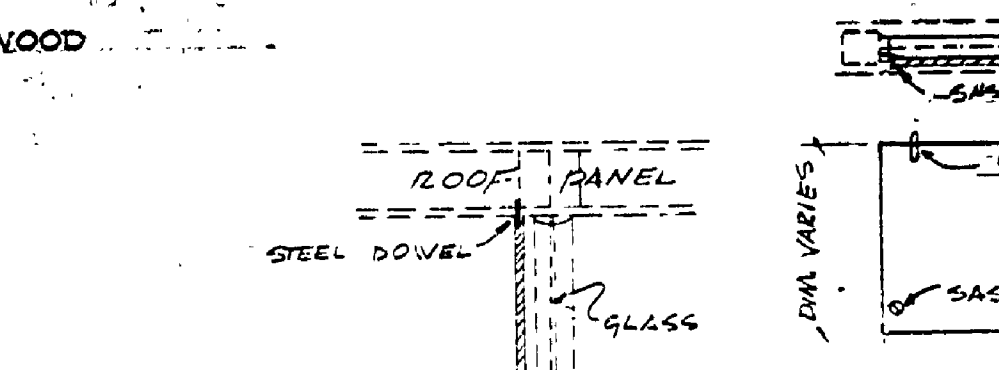

DETAILS - WINTERIZING PANEL
NO SCALE

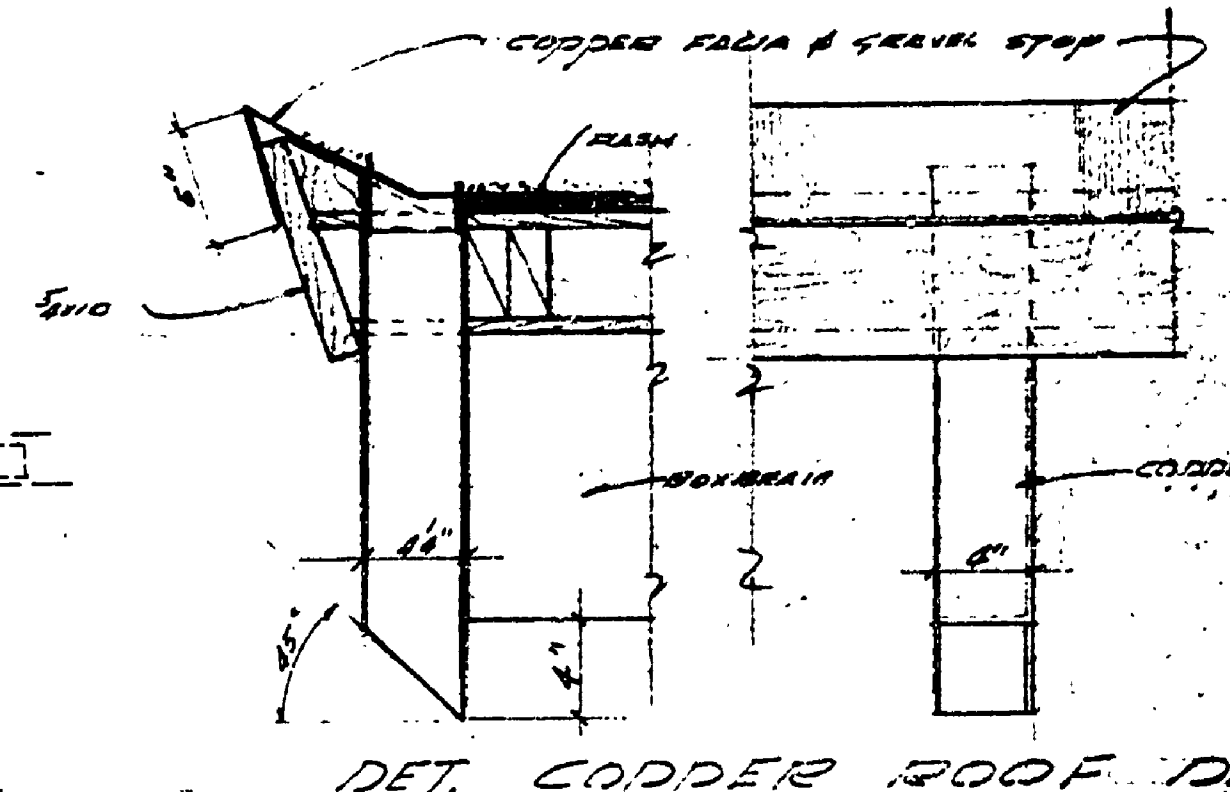

DET. COPPER ROOF DRAIN & REED
SCALE: 1/8" = 1'-0"

DESIGNATION	TYPE	NO.	SIZE	REMARKS
1	A	NO. 12	3'-0" x 7'-0"	WOOD CASE
2	B	NO. 12	3'-0" x 7'-0"	"
3	A	NO. 18	2'-6" x 6'-6"	"
4	A	NO. 18	2'-6" x 6'-6"	"

DOOR TYPES

ROOM DESIGNATION	FLOOR	WALL	CEILING	DOOR	TRIM	REMARKS
TOILET	CERAMIC TILE	ALUM. SASH/FRAME	ALUM. SASH/FRAME	WOOD CASE	WOOD CASE	
WOMEN'S TOILET	CERAMIC TILE	ALUM. SASH/FRAME	ALUM. SASH/FRAME	WOOD CASE	WOOD CASE	
MEN'S TOILET	CERAMIC TILE	ALUM. SASH/FRAME	ALUM. SASH/FRAME	WOOD CASE	WOOD CASE	
WOMEN'S SHOWER	CERAMIC TILE	ALUM. SASH/FRAME	ALUM. SASH/FRAME	WOOD CASE	WOOD CASE	
DIP ALLEY	CERAMIC TILE	ALUM. SASH/FRAME	ALUM. SASH/FRAME	WOOD CASE	WOOD CASE	
INTERIOR ELEVATIONS - MISC. DETAILS - ELEC. DETAILS						

NO.	THICK (INCH)	VT.	HT.	REMARKS
3	1/2"	2'-8 3/4"	2'-0"	DIM. APPROX ONLY CUT TO FIT
6	1/2"	2'-8 3/4"	1'-0"	"
2	1/2"	4'-3 3/4"	2'-0"	"
2	1/2"	4'-0 3/4"	1'-0"	"
2	1/2"	2'-4 1/8"	2'-0"	"
2	1/2"	10'-5 1/2"		"

MICHIGAN DEPARTMENT OF CONSERVATION PARKS AND RECREATION DIVISION

HIGGINS LAKE STATE PARK TOILET & SHOWER BUILDING SOUTH SHEET NO. 5 OF 5 PLAN NO. 1/08