




WEST ELEVATION  
1/4" = 1'-0"

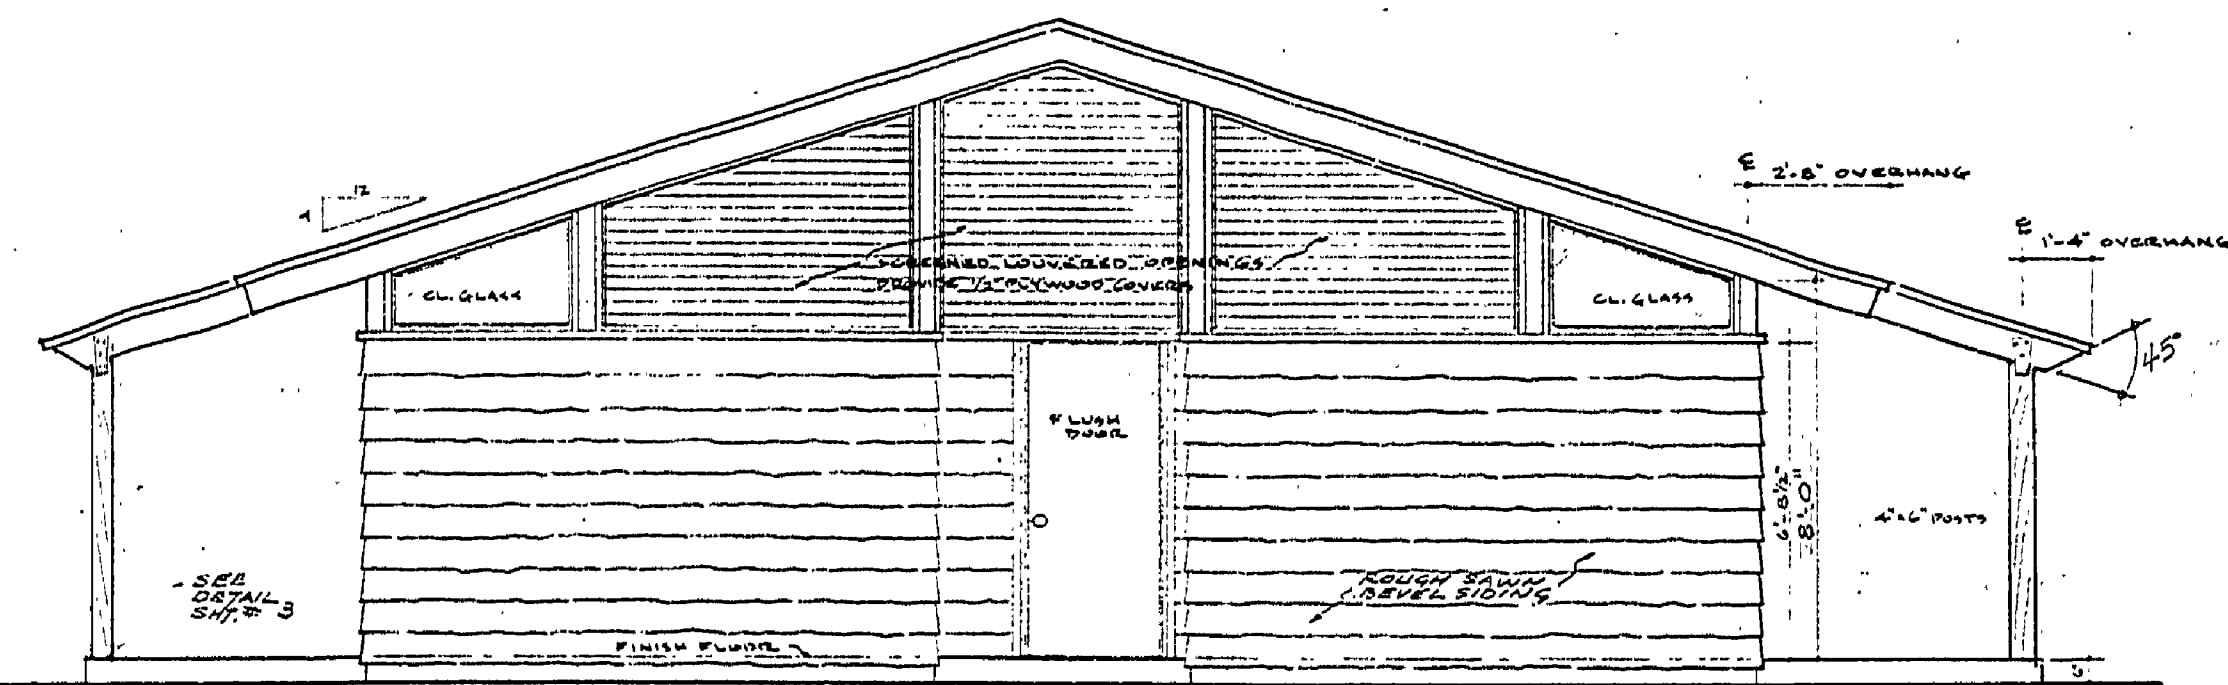


SOUTH ELEVATION  
1/4" = 1'-0"

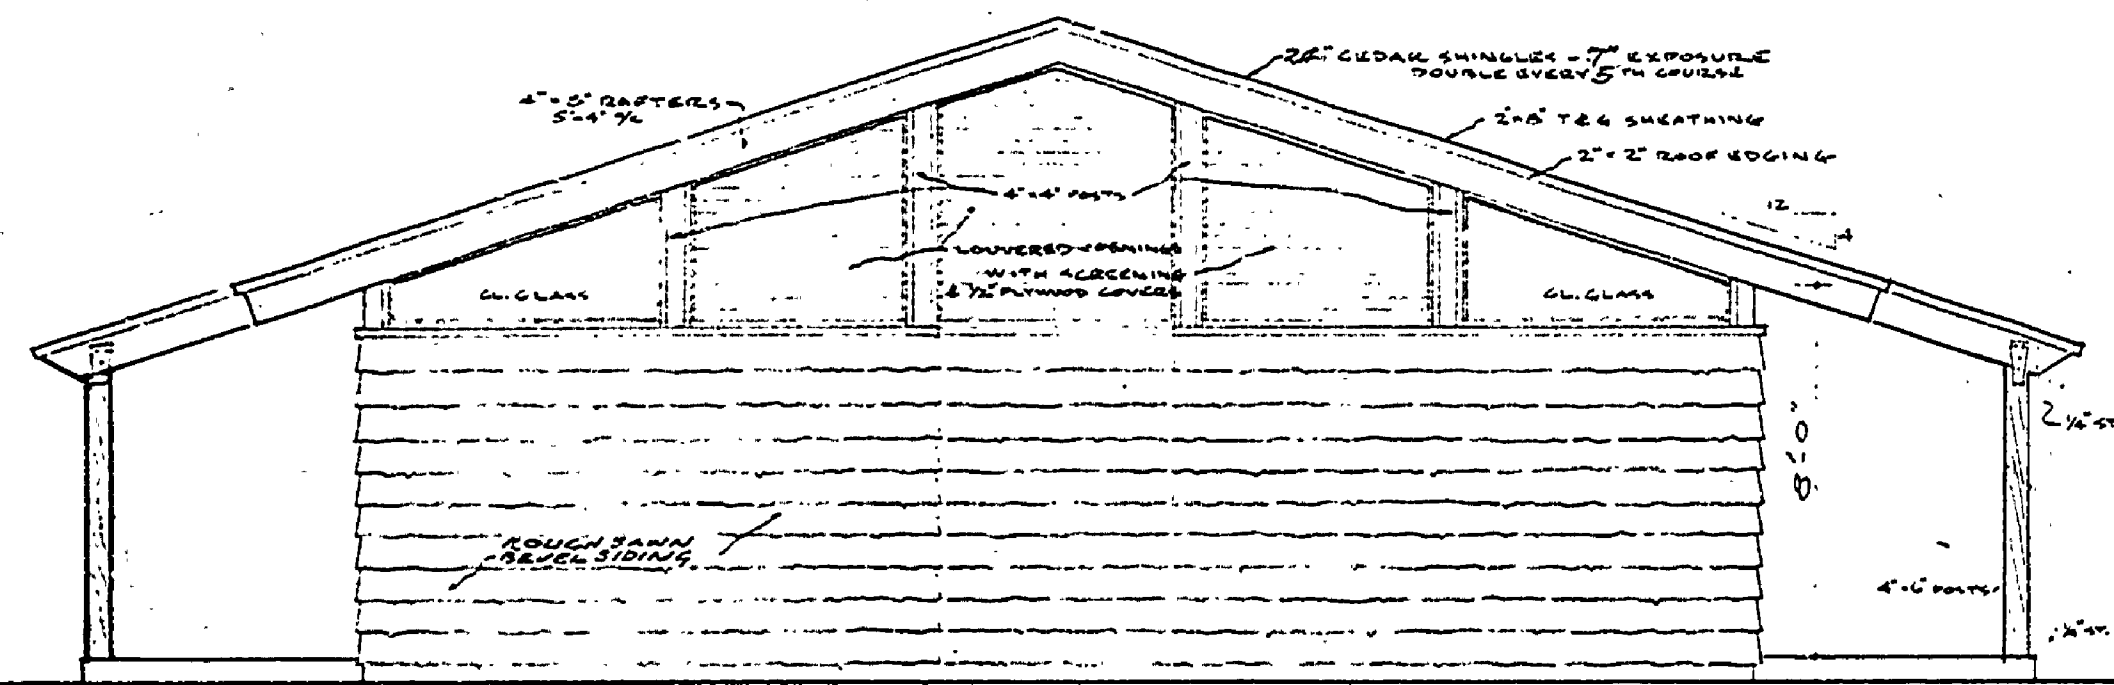


NORTH ELEVATION  
1/4" = 1'-0"

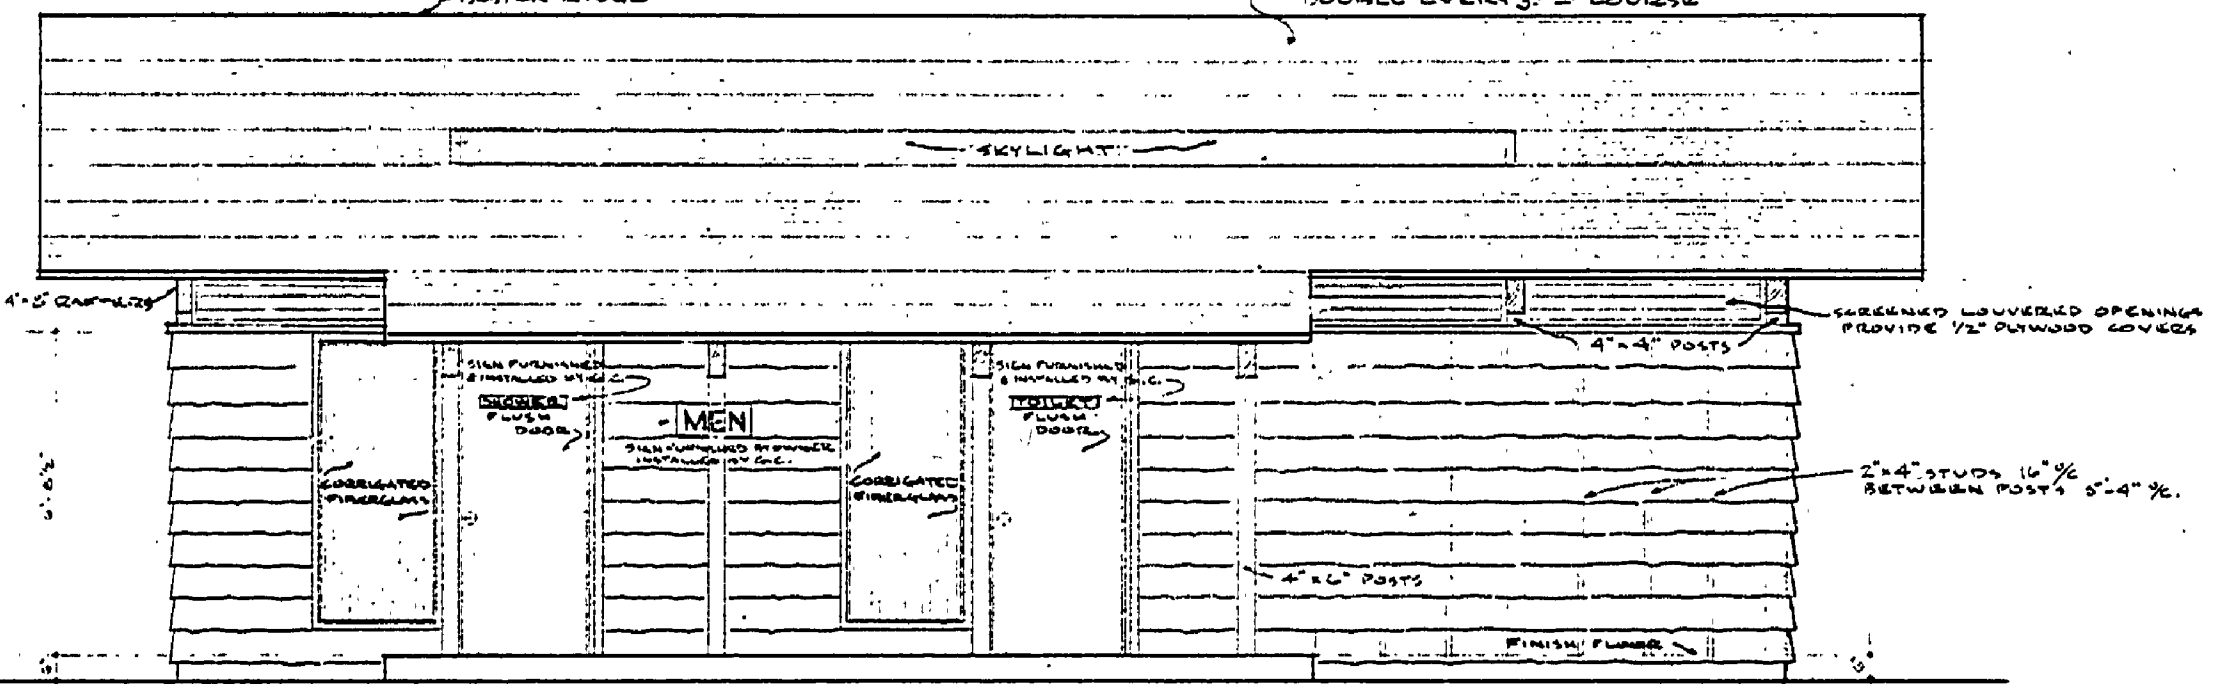


EAST ELEVATION  
1/4" = 1'-0"

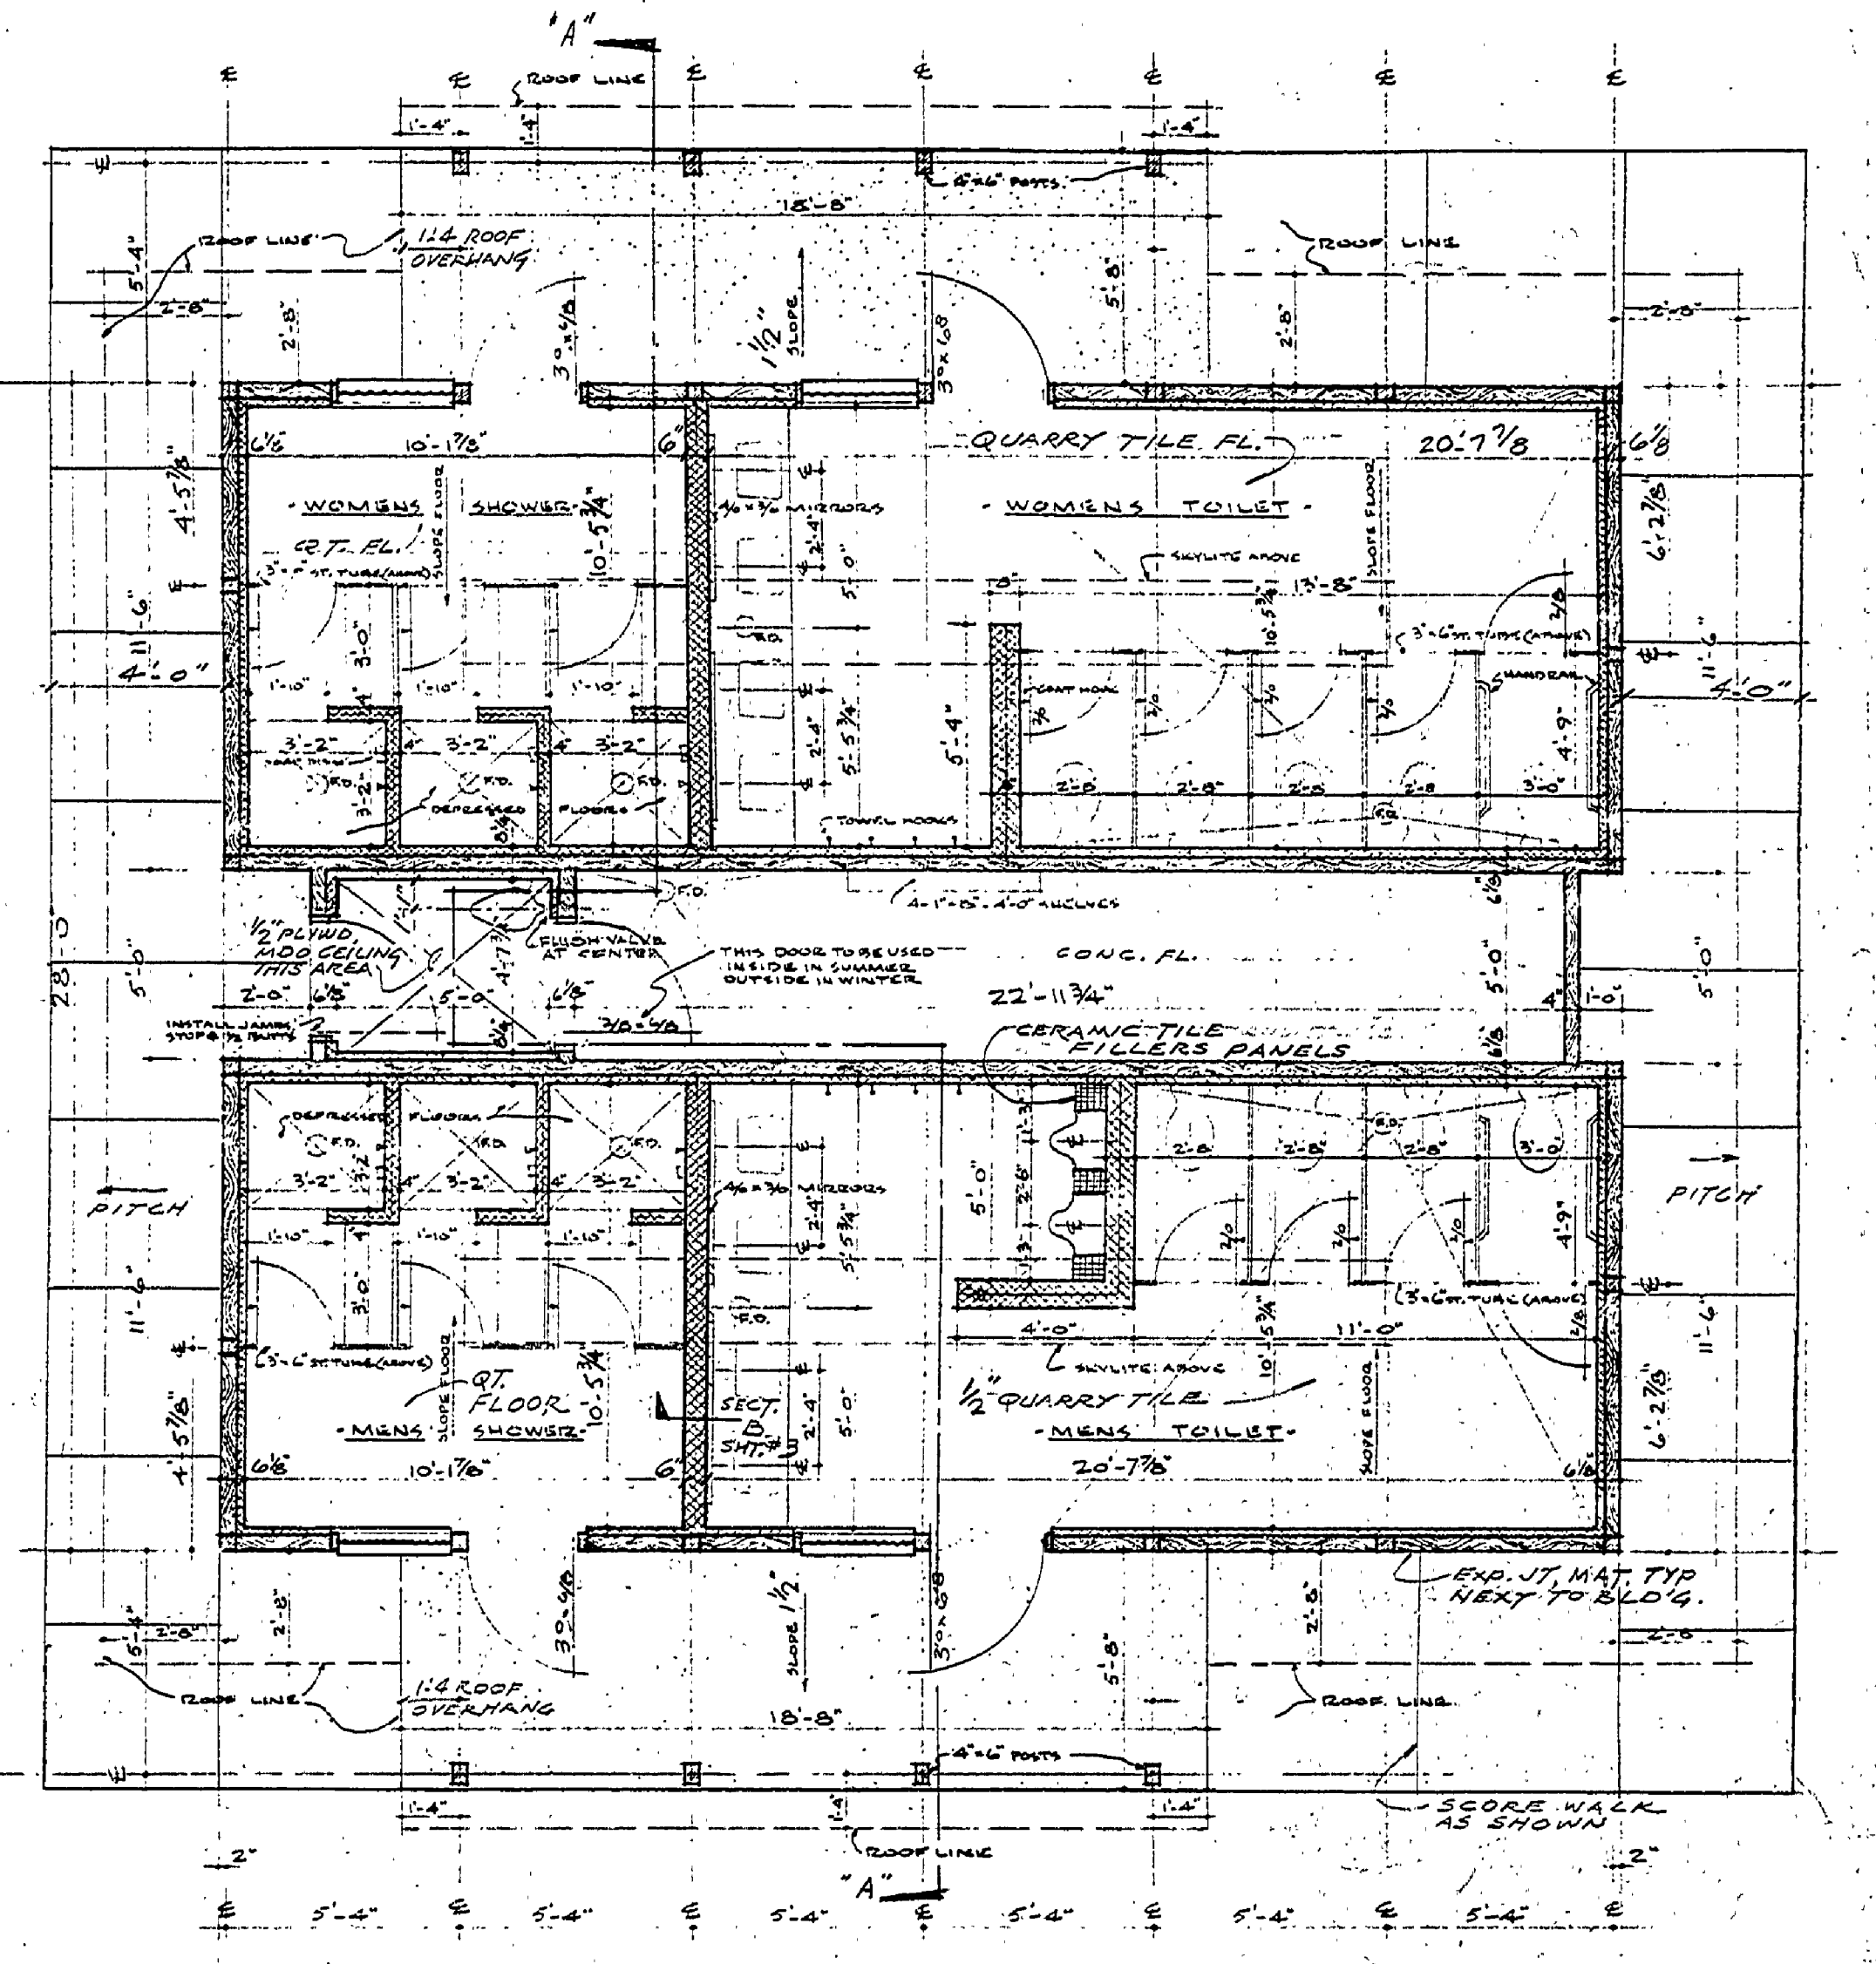


FLOOR PLAN  
1/4" = 1'-0"

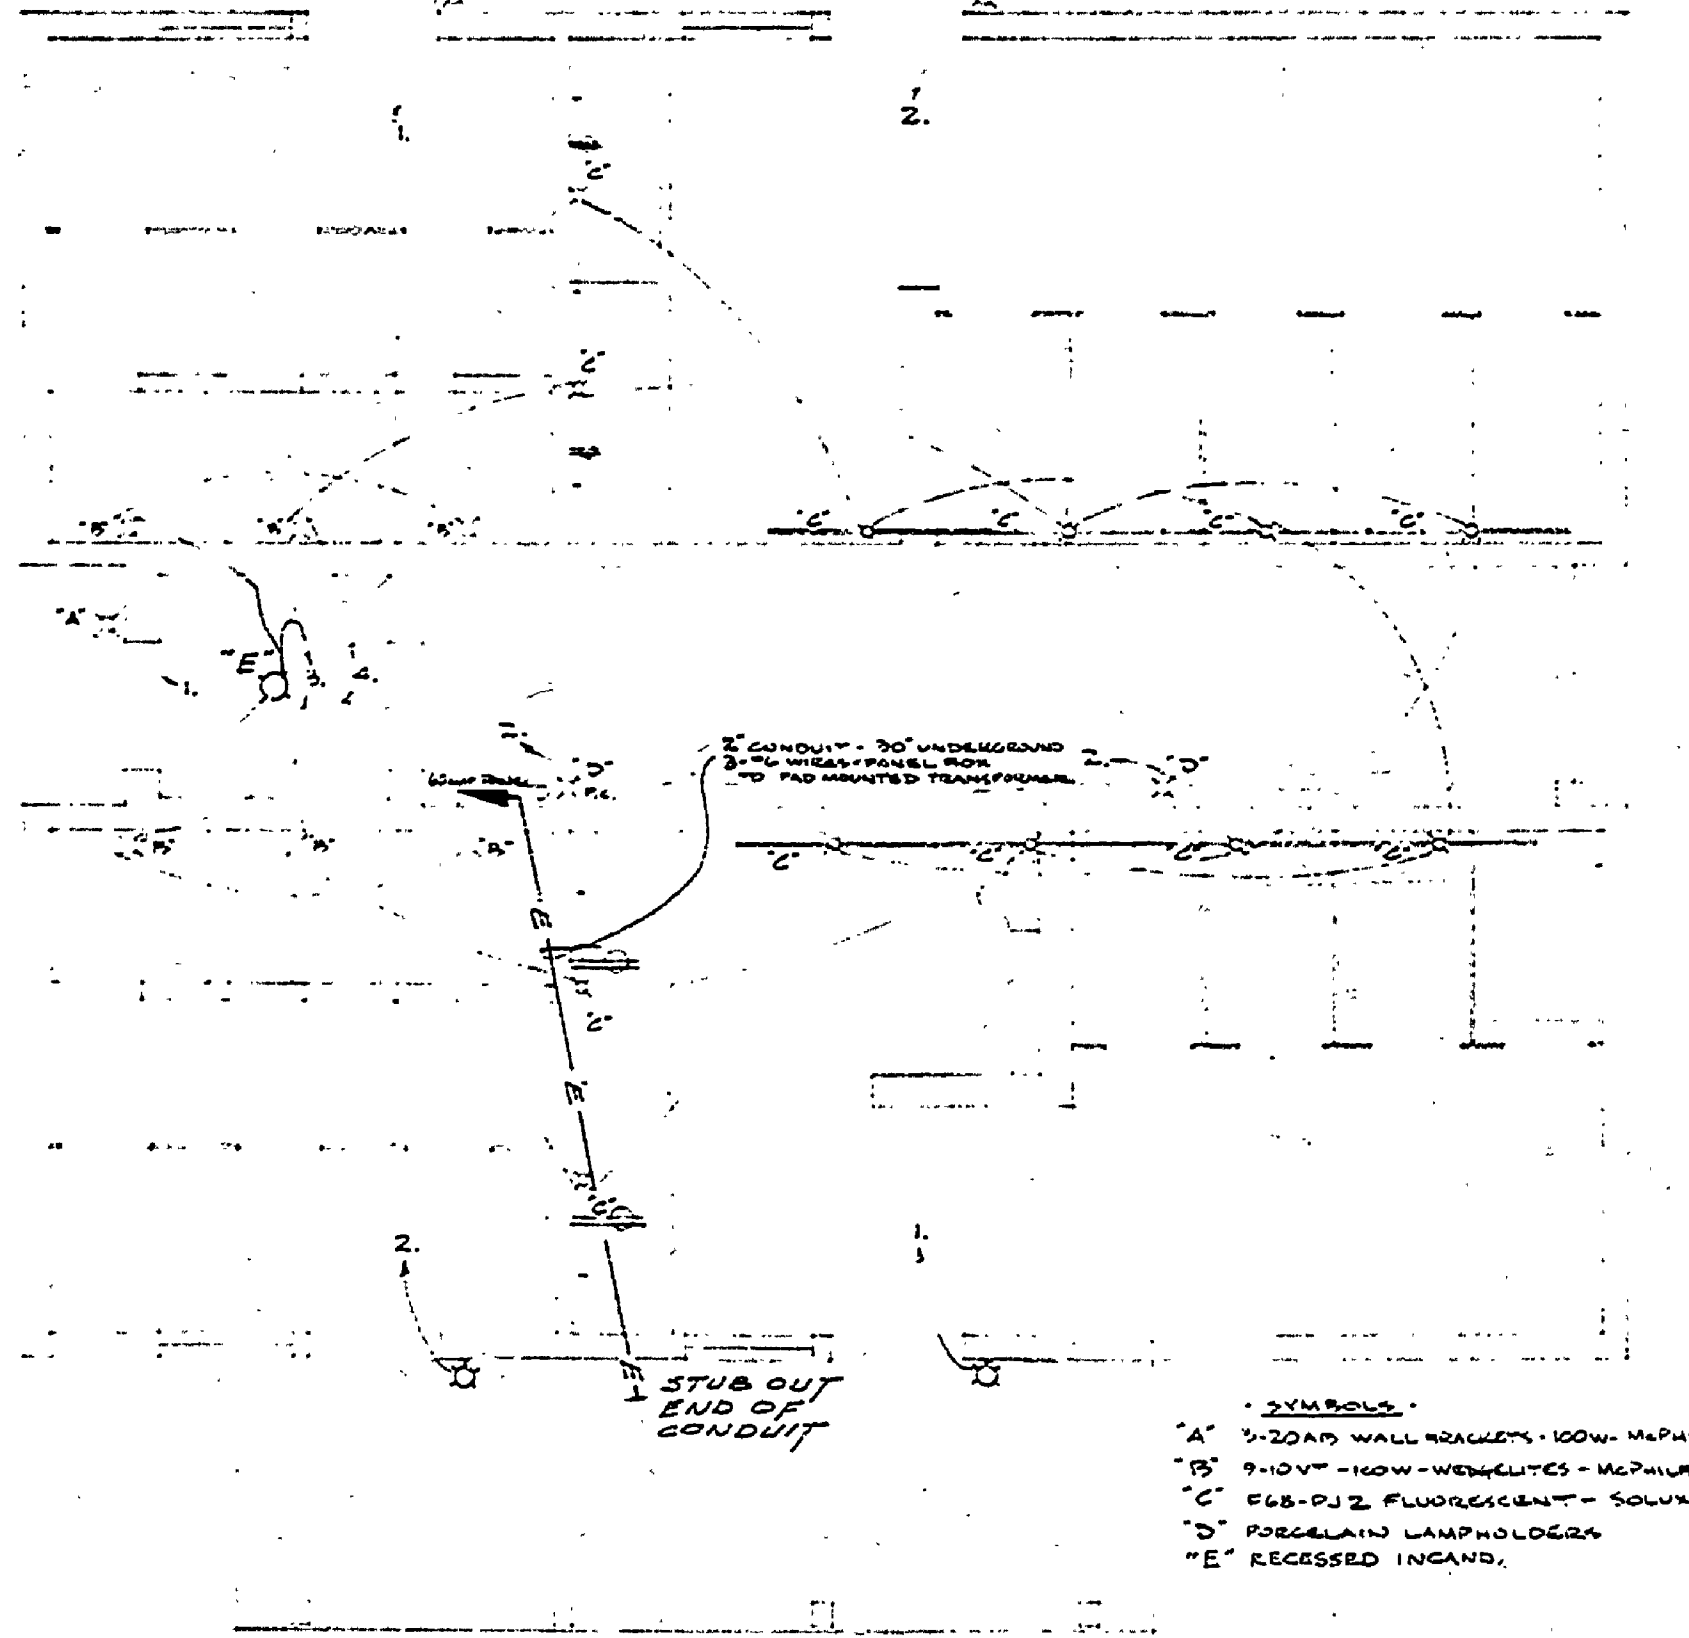

ELECTRICAL PLAN  
1/4" = 1'-0"

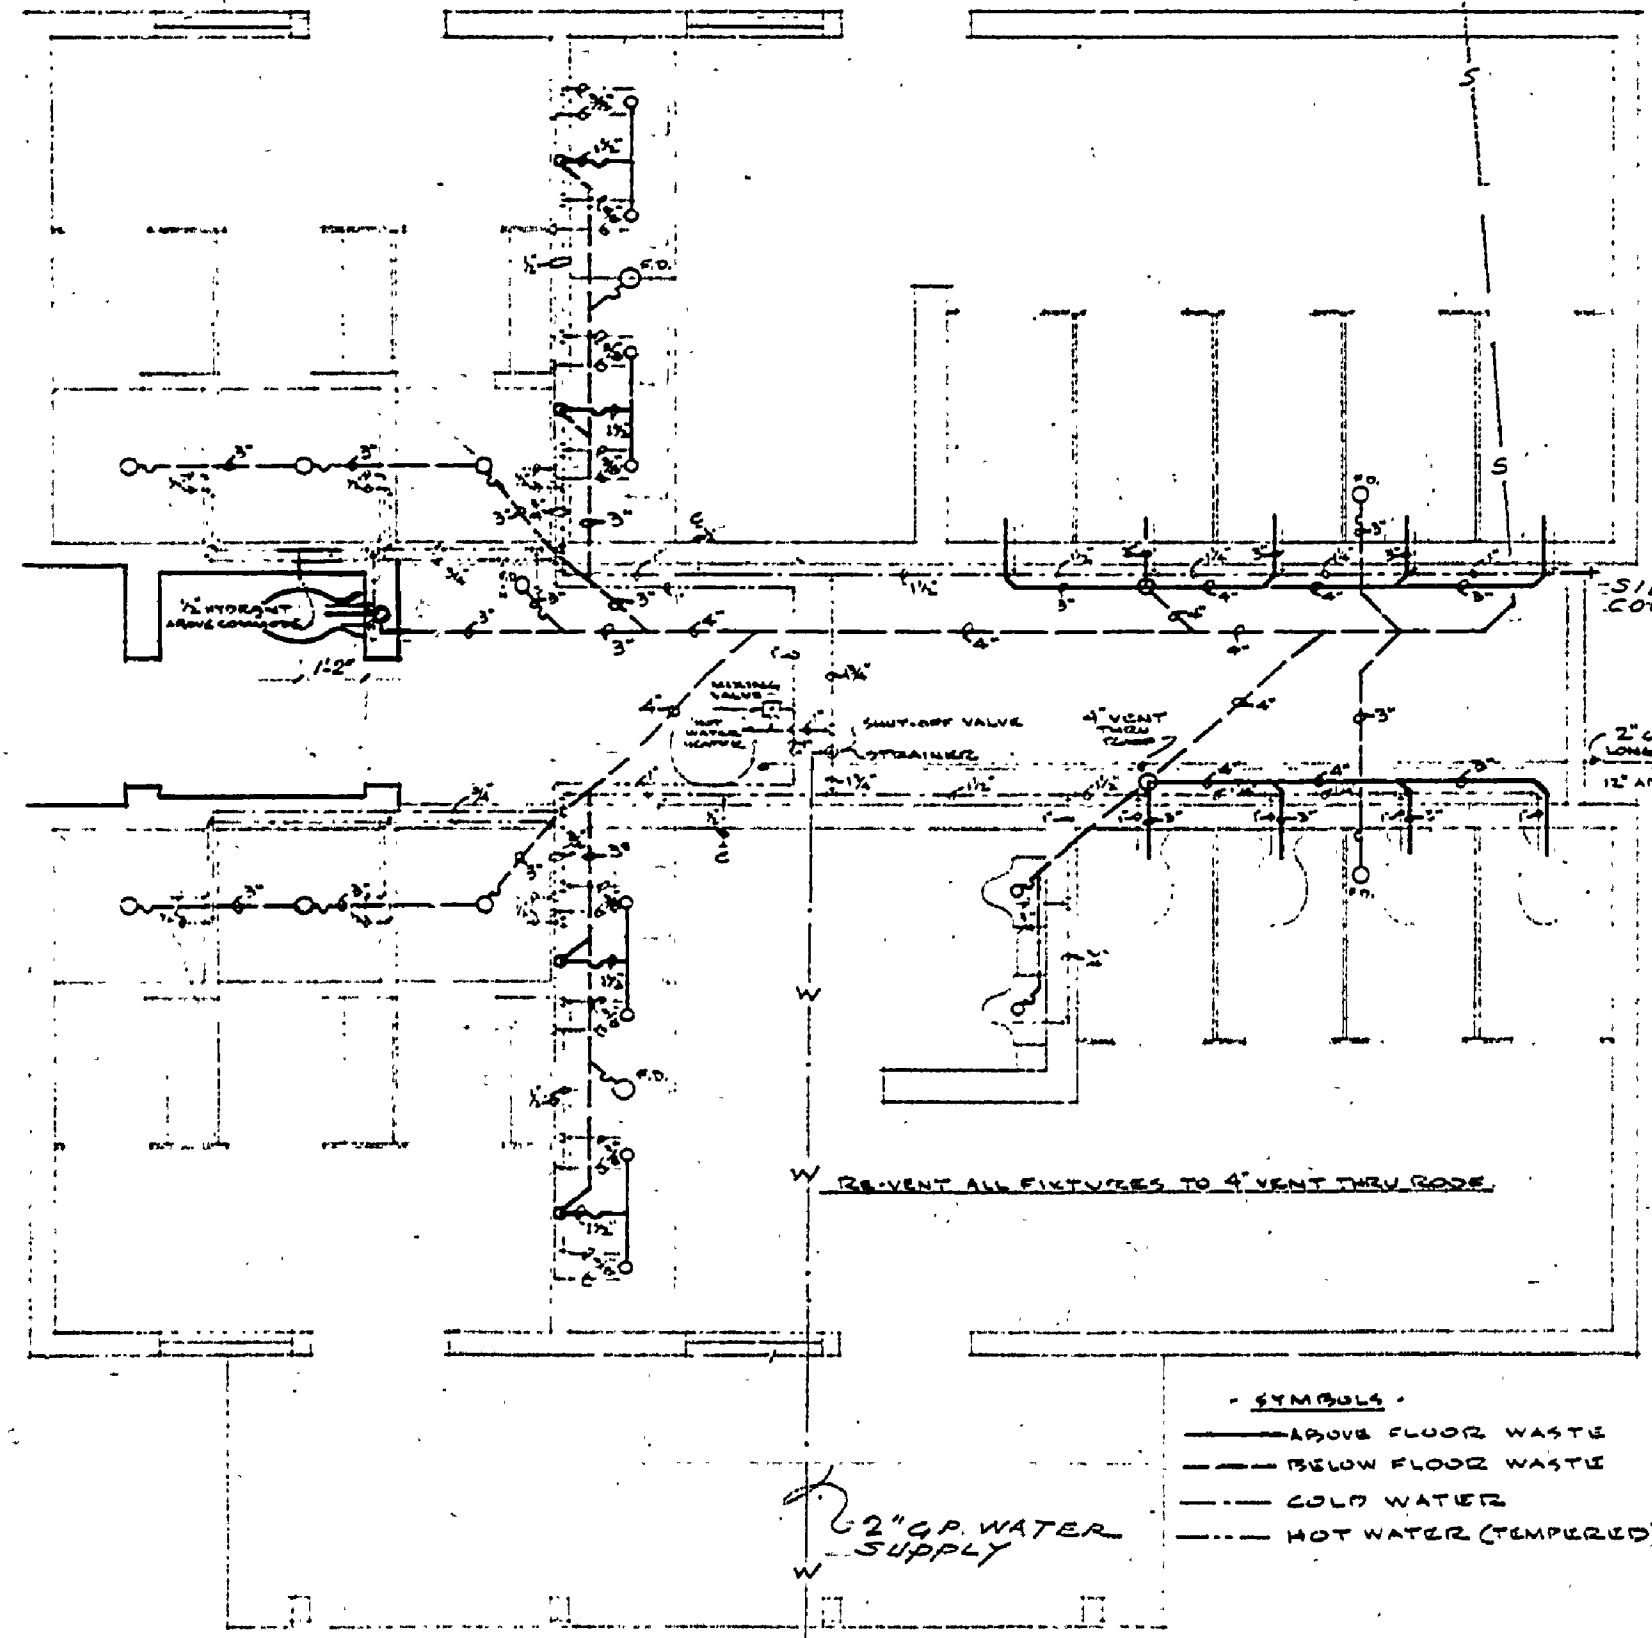


PLUMBING PLAN  
1/4" = 1'-0"

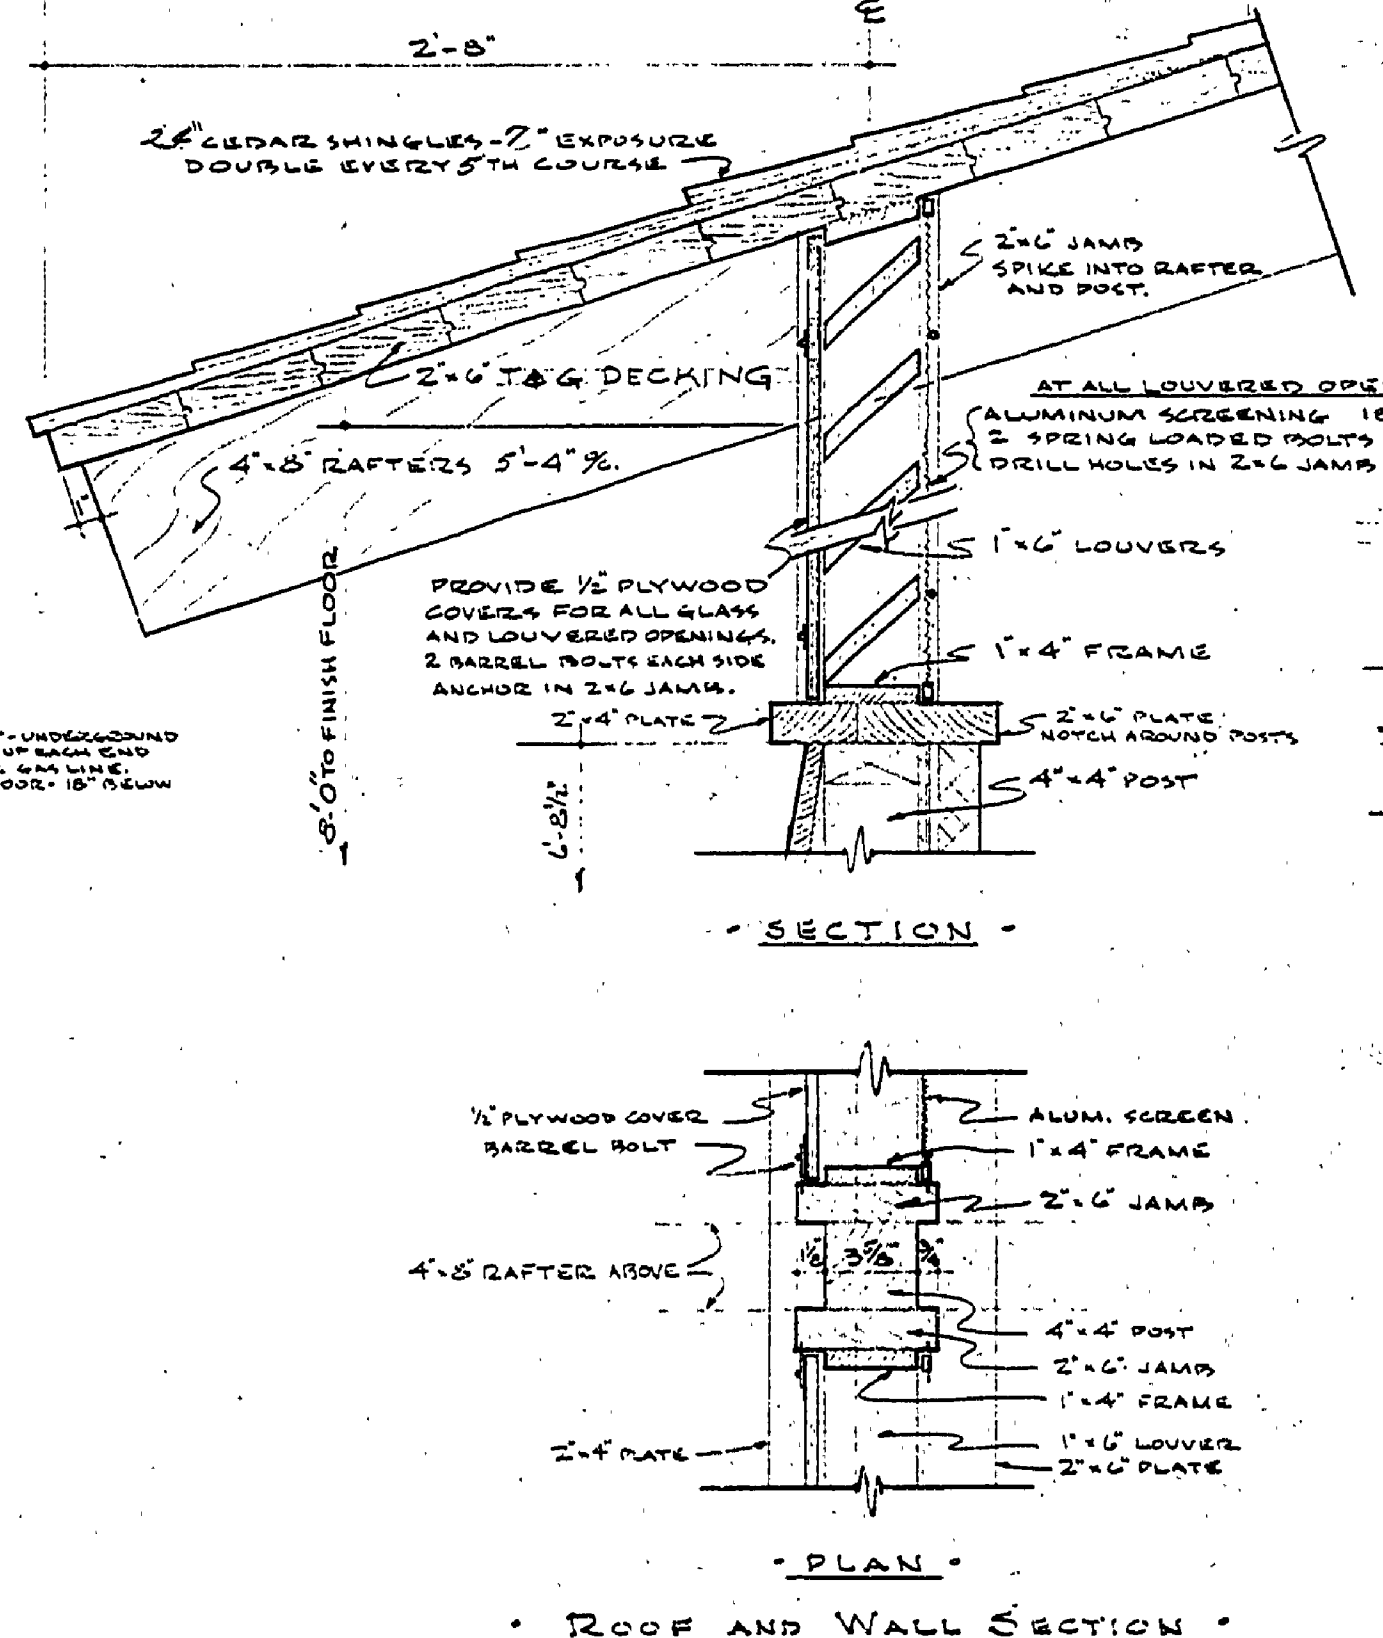

SECTION

PLAN

ROOF AND WALL SECTION  
1/2" = 1'-0"

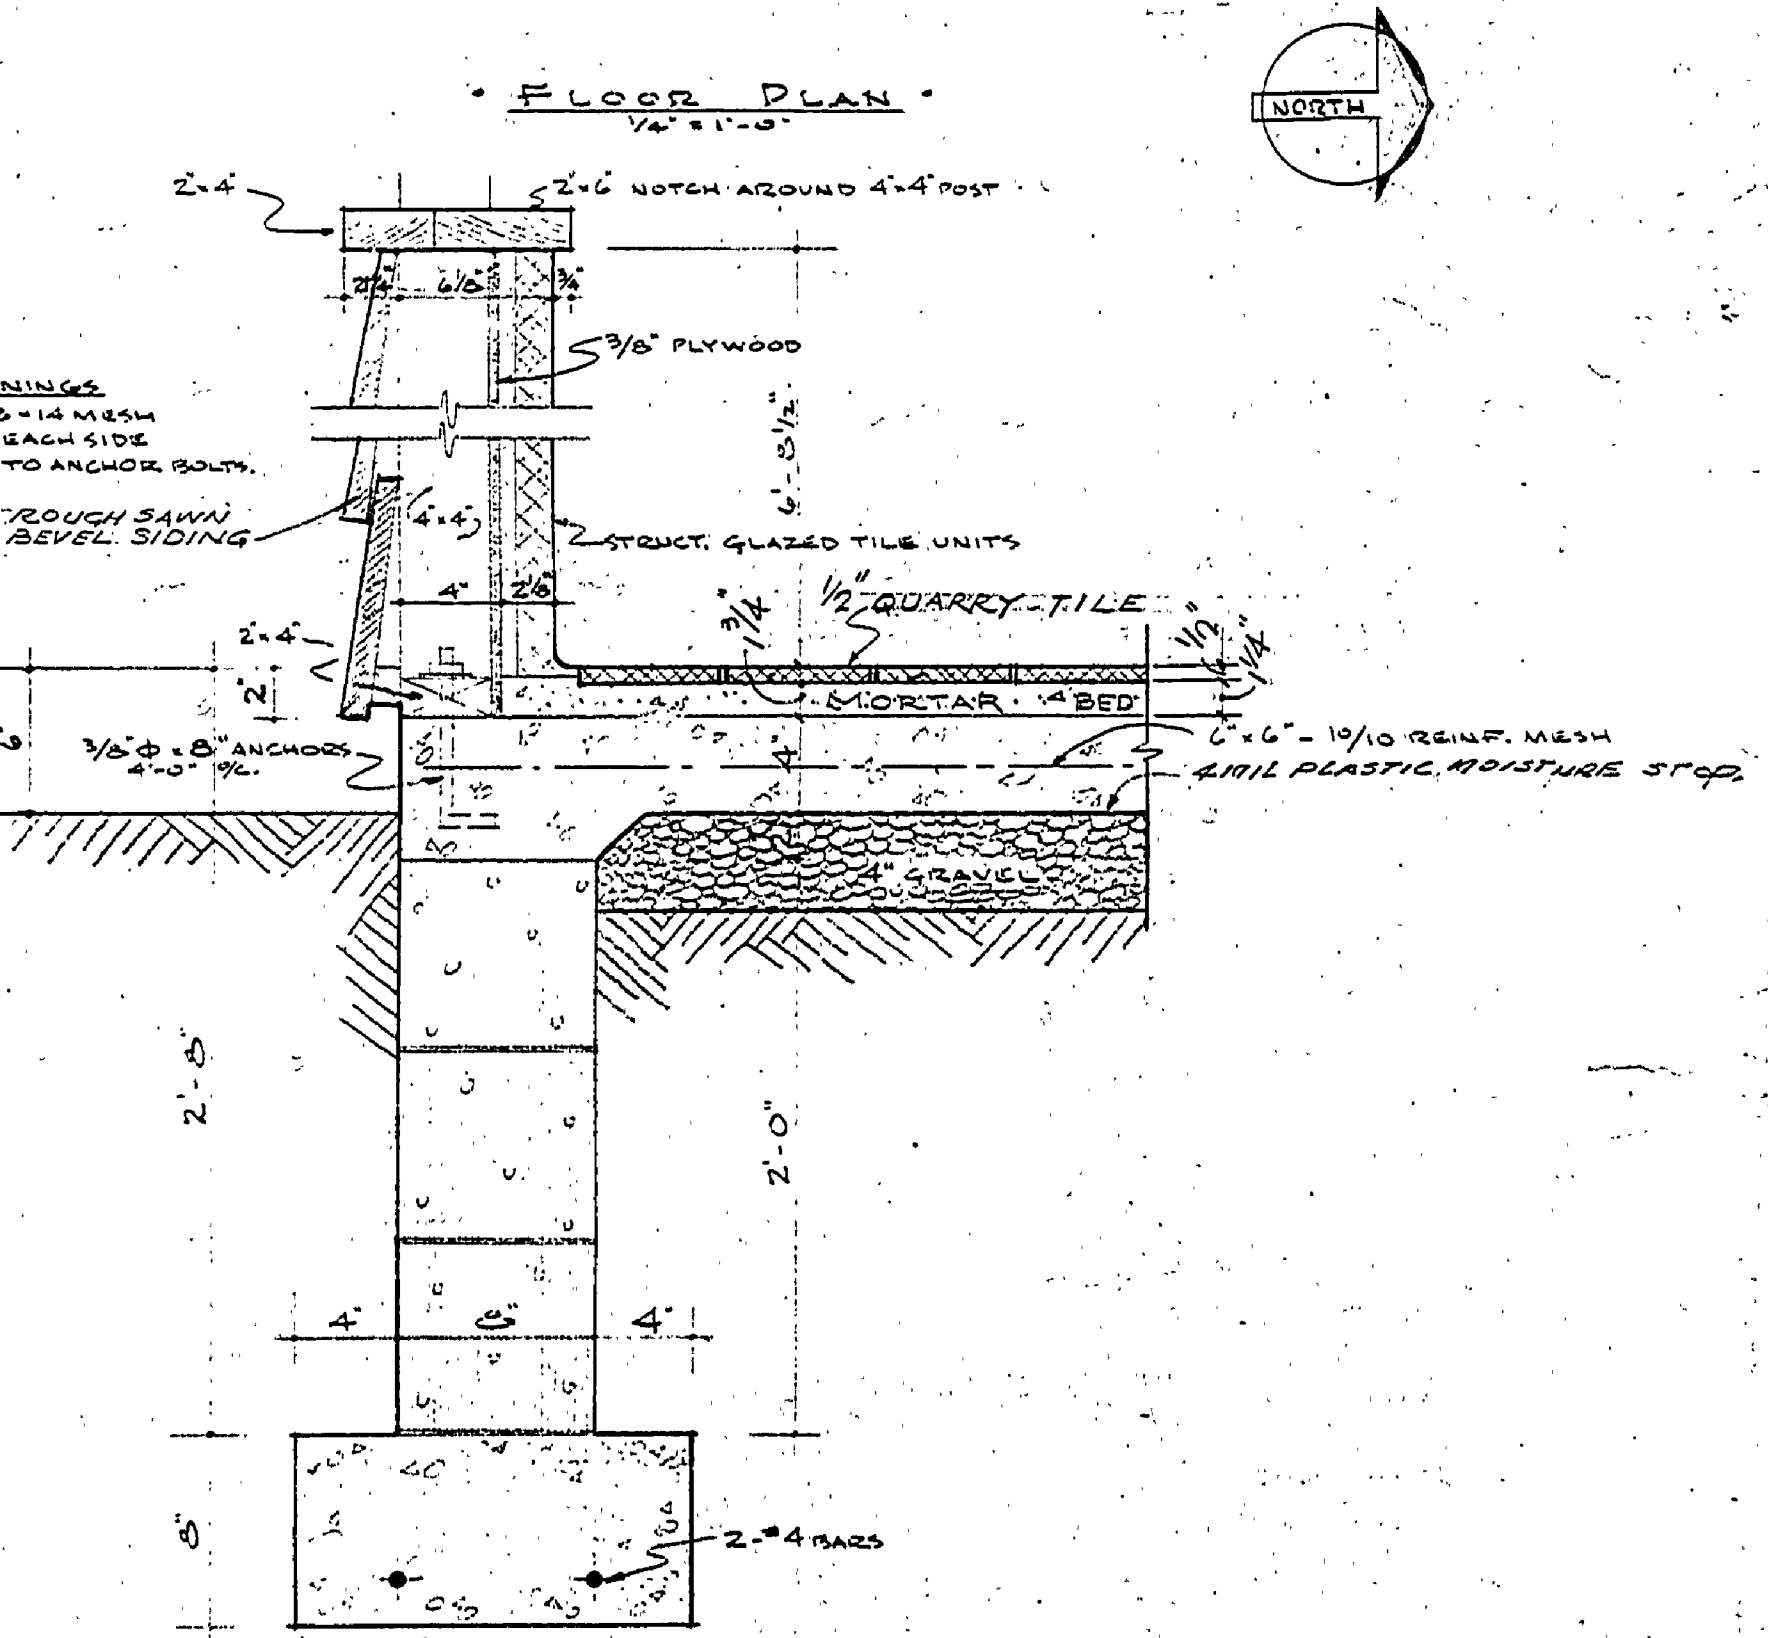

FOUNDATION SECTION  
1/2" = 1'-0"

SURVEYED BY	DESIGNED BY	DRAWN BY R.R.	CHECKED BY	DATE	NO.	DATE	BY	REVISIONS	NO.	DATE	BY	REVISIONS
				3/11/69	1.							
					2.							

MICHIGAN  
DEPARTMENT OF CONSERVATION

HIGGINS LAKE STATE PARK  
EAST CAMPGROUND  
TOILET BUILDING

SHEET NO. 2 OF 3  
FOR PROJECT NO. 999-75-0299-011

PLANS & CONSTRUCTION  
DETAILS  
SHEET 2 OF 3  
PLAN NO. A-106