



SOUTH ELEVATION
SCALE - 1/4" = ONE FOOT

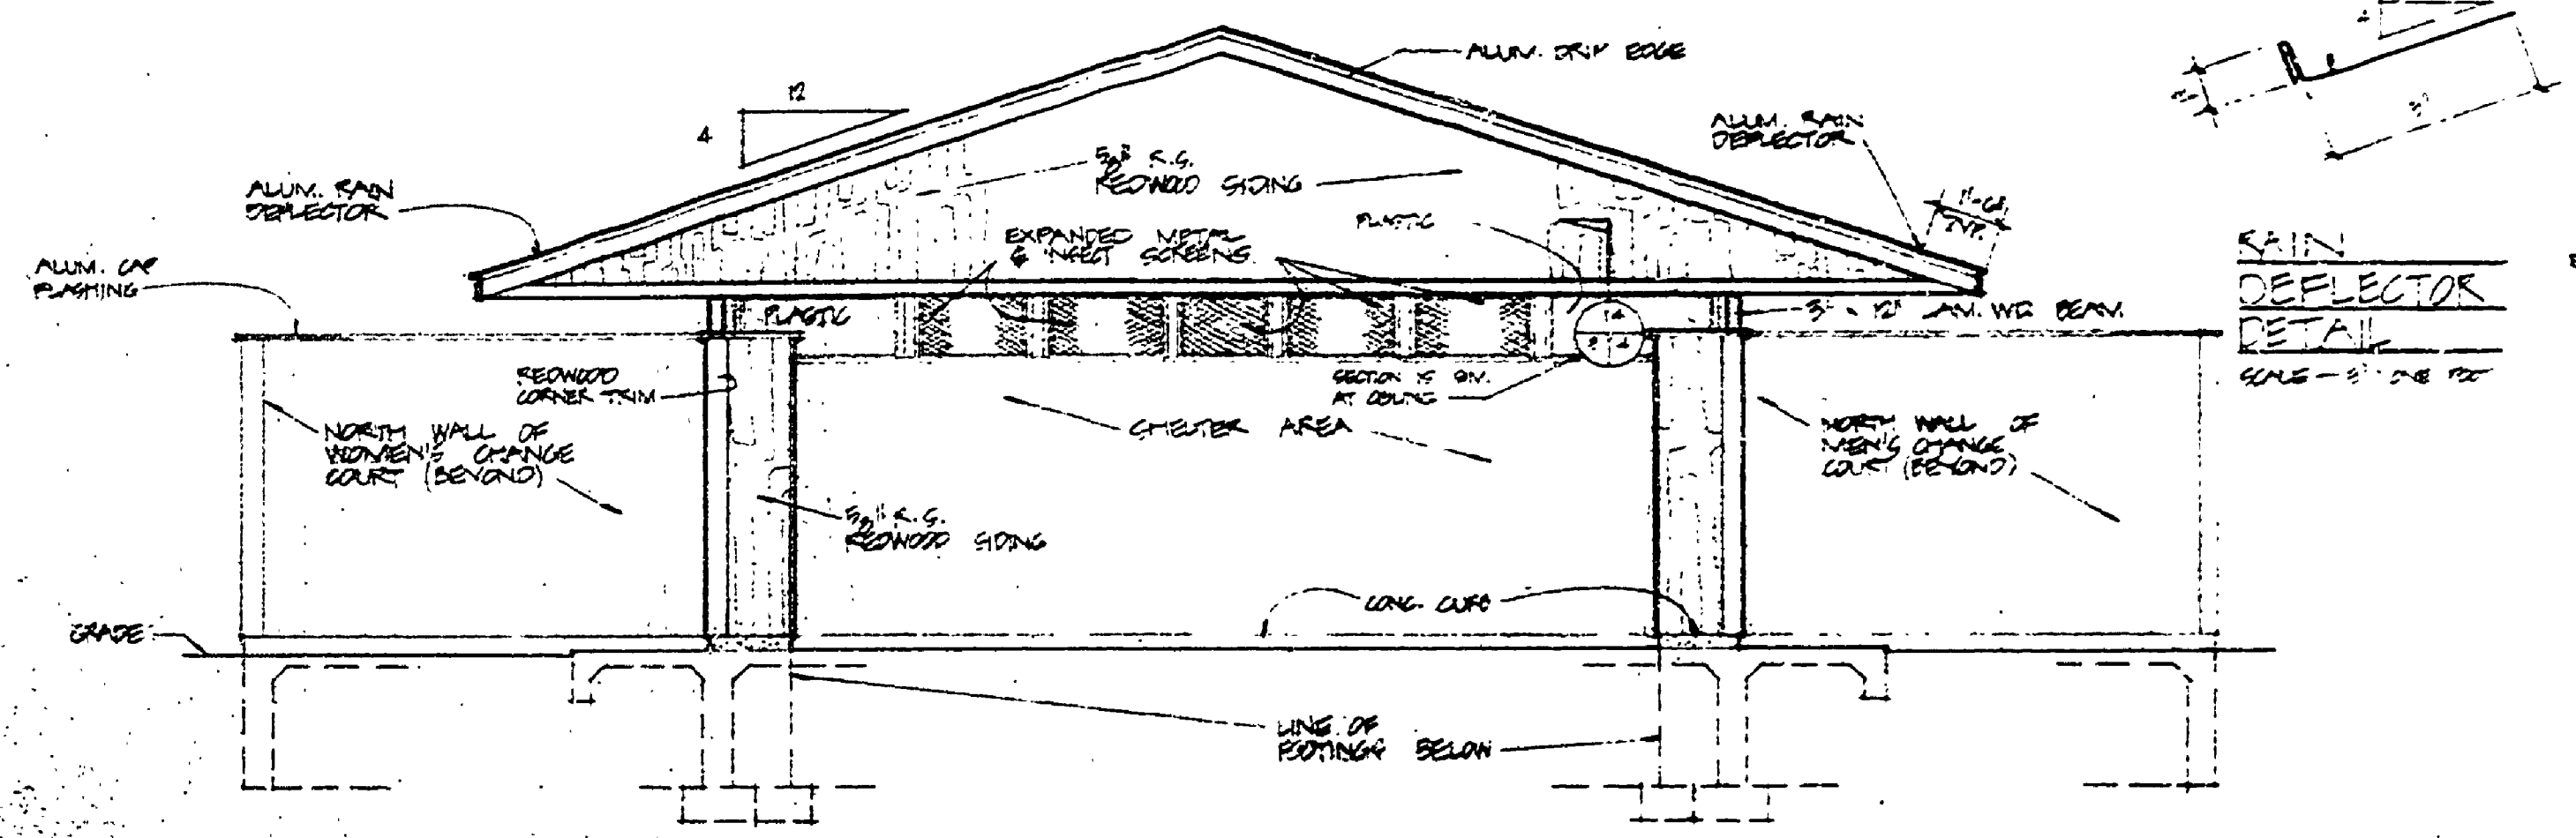


NORTH ELEVATION
SCALE - 1/4" = ONE FOOT

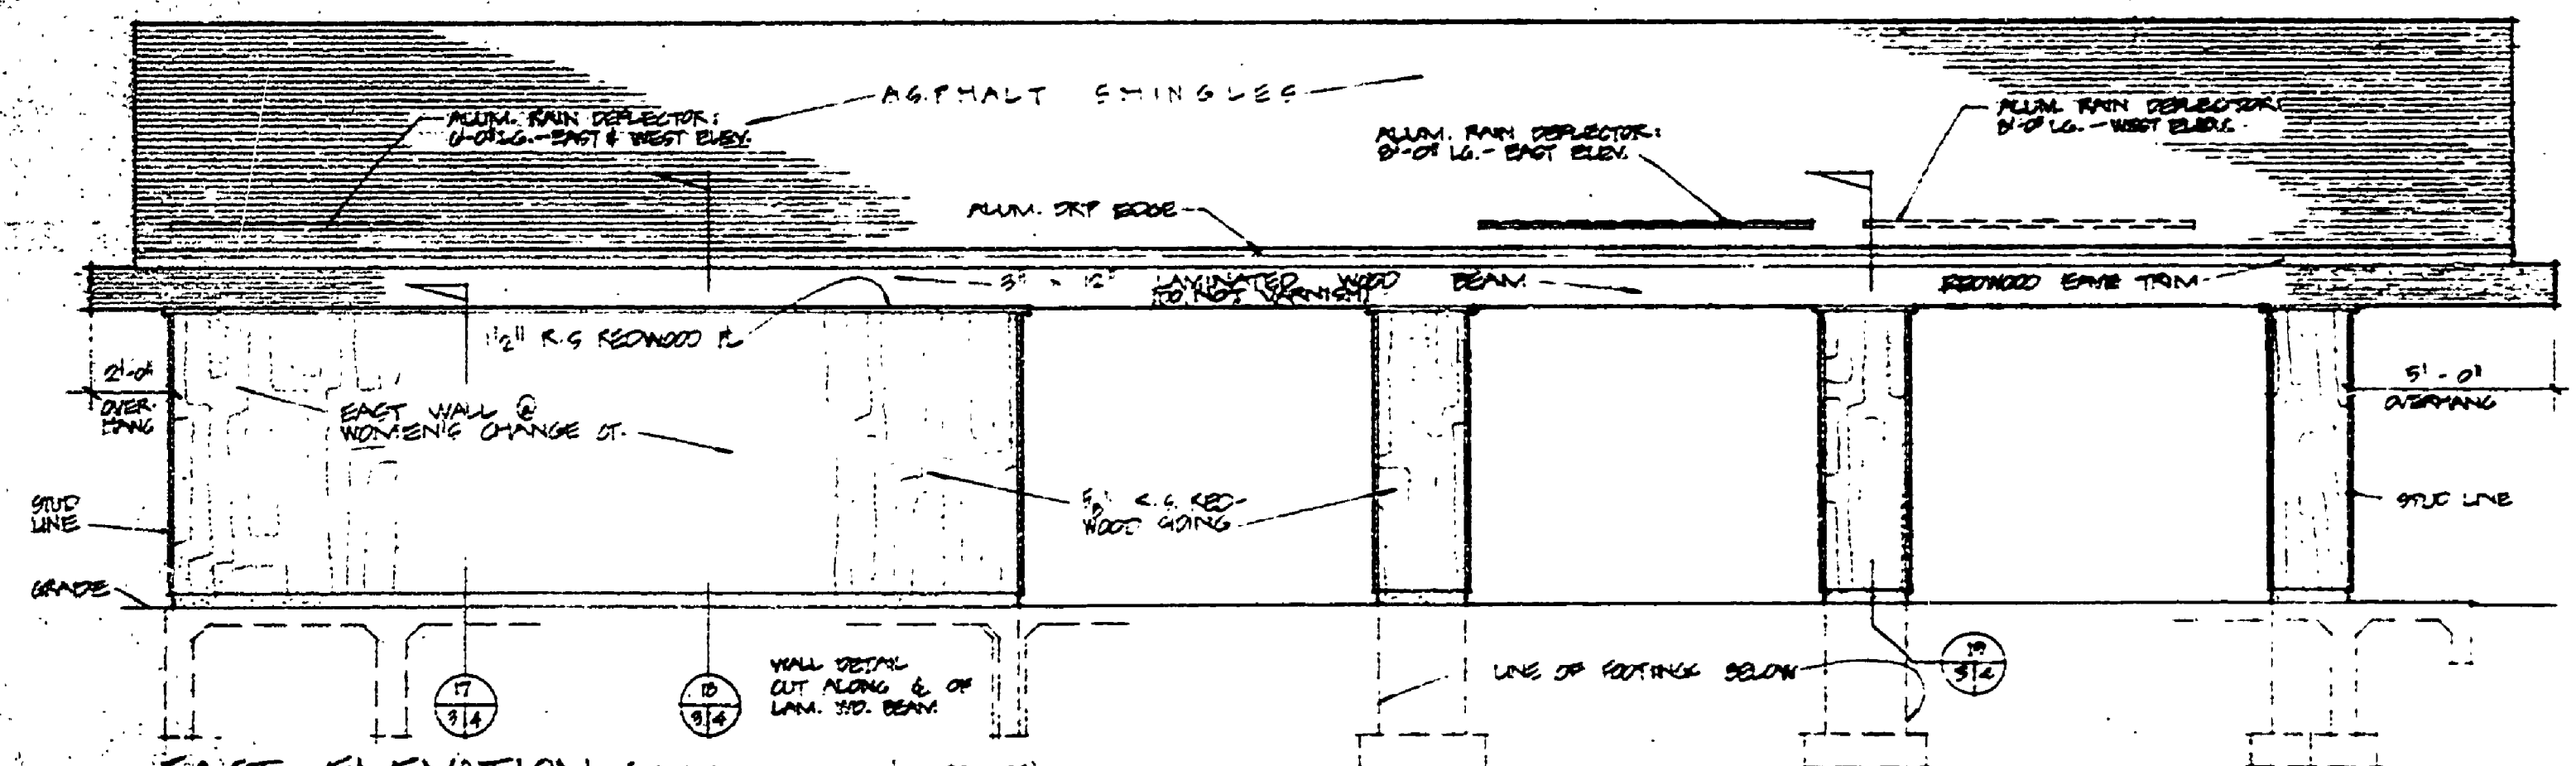

EAST ELEVATION (N. ELEV. SIMILAR & OPPOSITE)
SCALE - 1/4" = ONE FOOT


DOOR SCHEDULE					
MARK	TYPE	DOOR SIZE	MATERIAL	FRAME	REMARKS
1	B	3'-0" x 6'-0"	1/2" PRESS. GL.	PRESS. GL.	CLOSER FEED
2	B	3'-0" x 6'-0"	1/2" PRESS. GL.	PRESS. GL.	CLOSER FEED
3	A	3'-0" x 6'-0"	1/2" PRESS. GL.	PRESS. GL.	
4	D	3'-0" x 6'-0"	1/2" PRESS. GL.	PRESS. GL.	CLOSER FEED
5	B	3'-0" x 6'-0"	1/2" PRESS. GL.	PRESS. GL.	CLOSER FEED

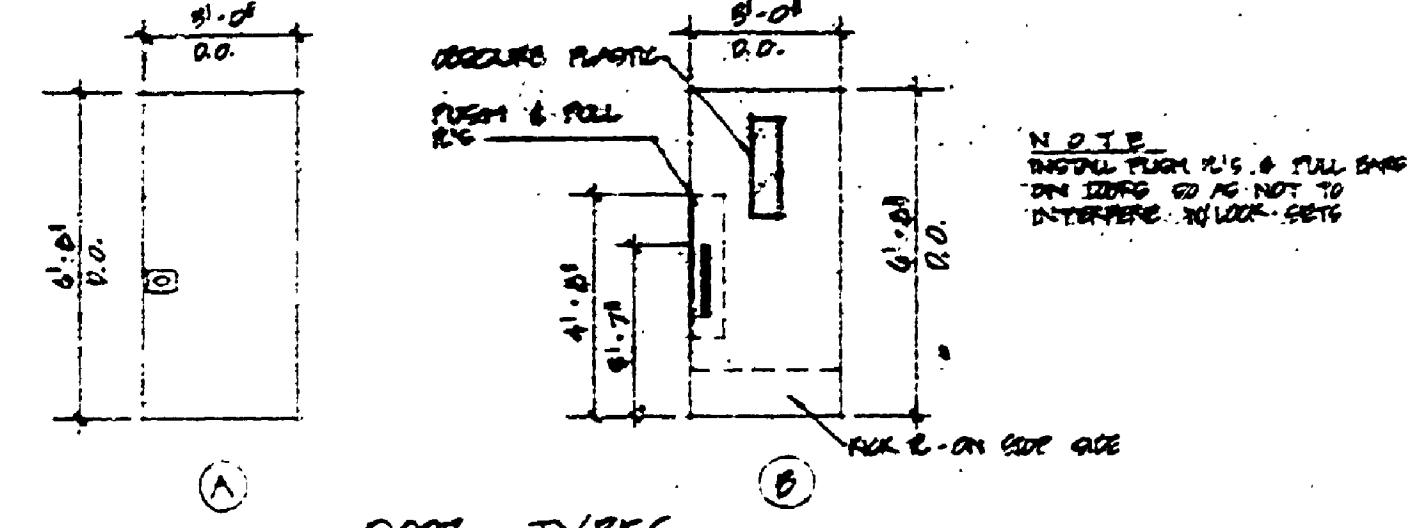


DOOR TYPES

ROOM FINISH SCHEDULE						
RM. NO.	RM. NAME	FLOOR	BASES	WALLS	CEILING	REMARKS
1	MENS CHANGE CT.					
2	MENS TOILET					
3	WOMENS TOILET					
4	WOMENS CHANGE CT.					
5	PROGAGE					
6	CHETER					
7	PIPE ALLEY					

NOTE: SPAN ALL WOOD MEMBERS OVER EXISTING CONCRETE SLAB. USE 1/2" X 4" X 8" LAM. WOOD BEAMS. ALL TRIM LATED.

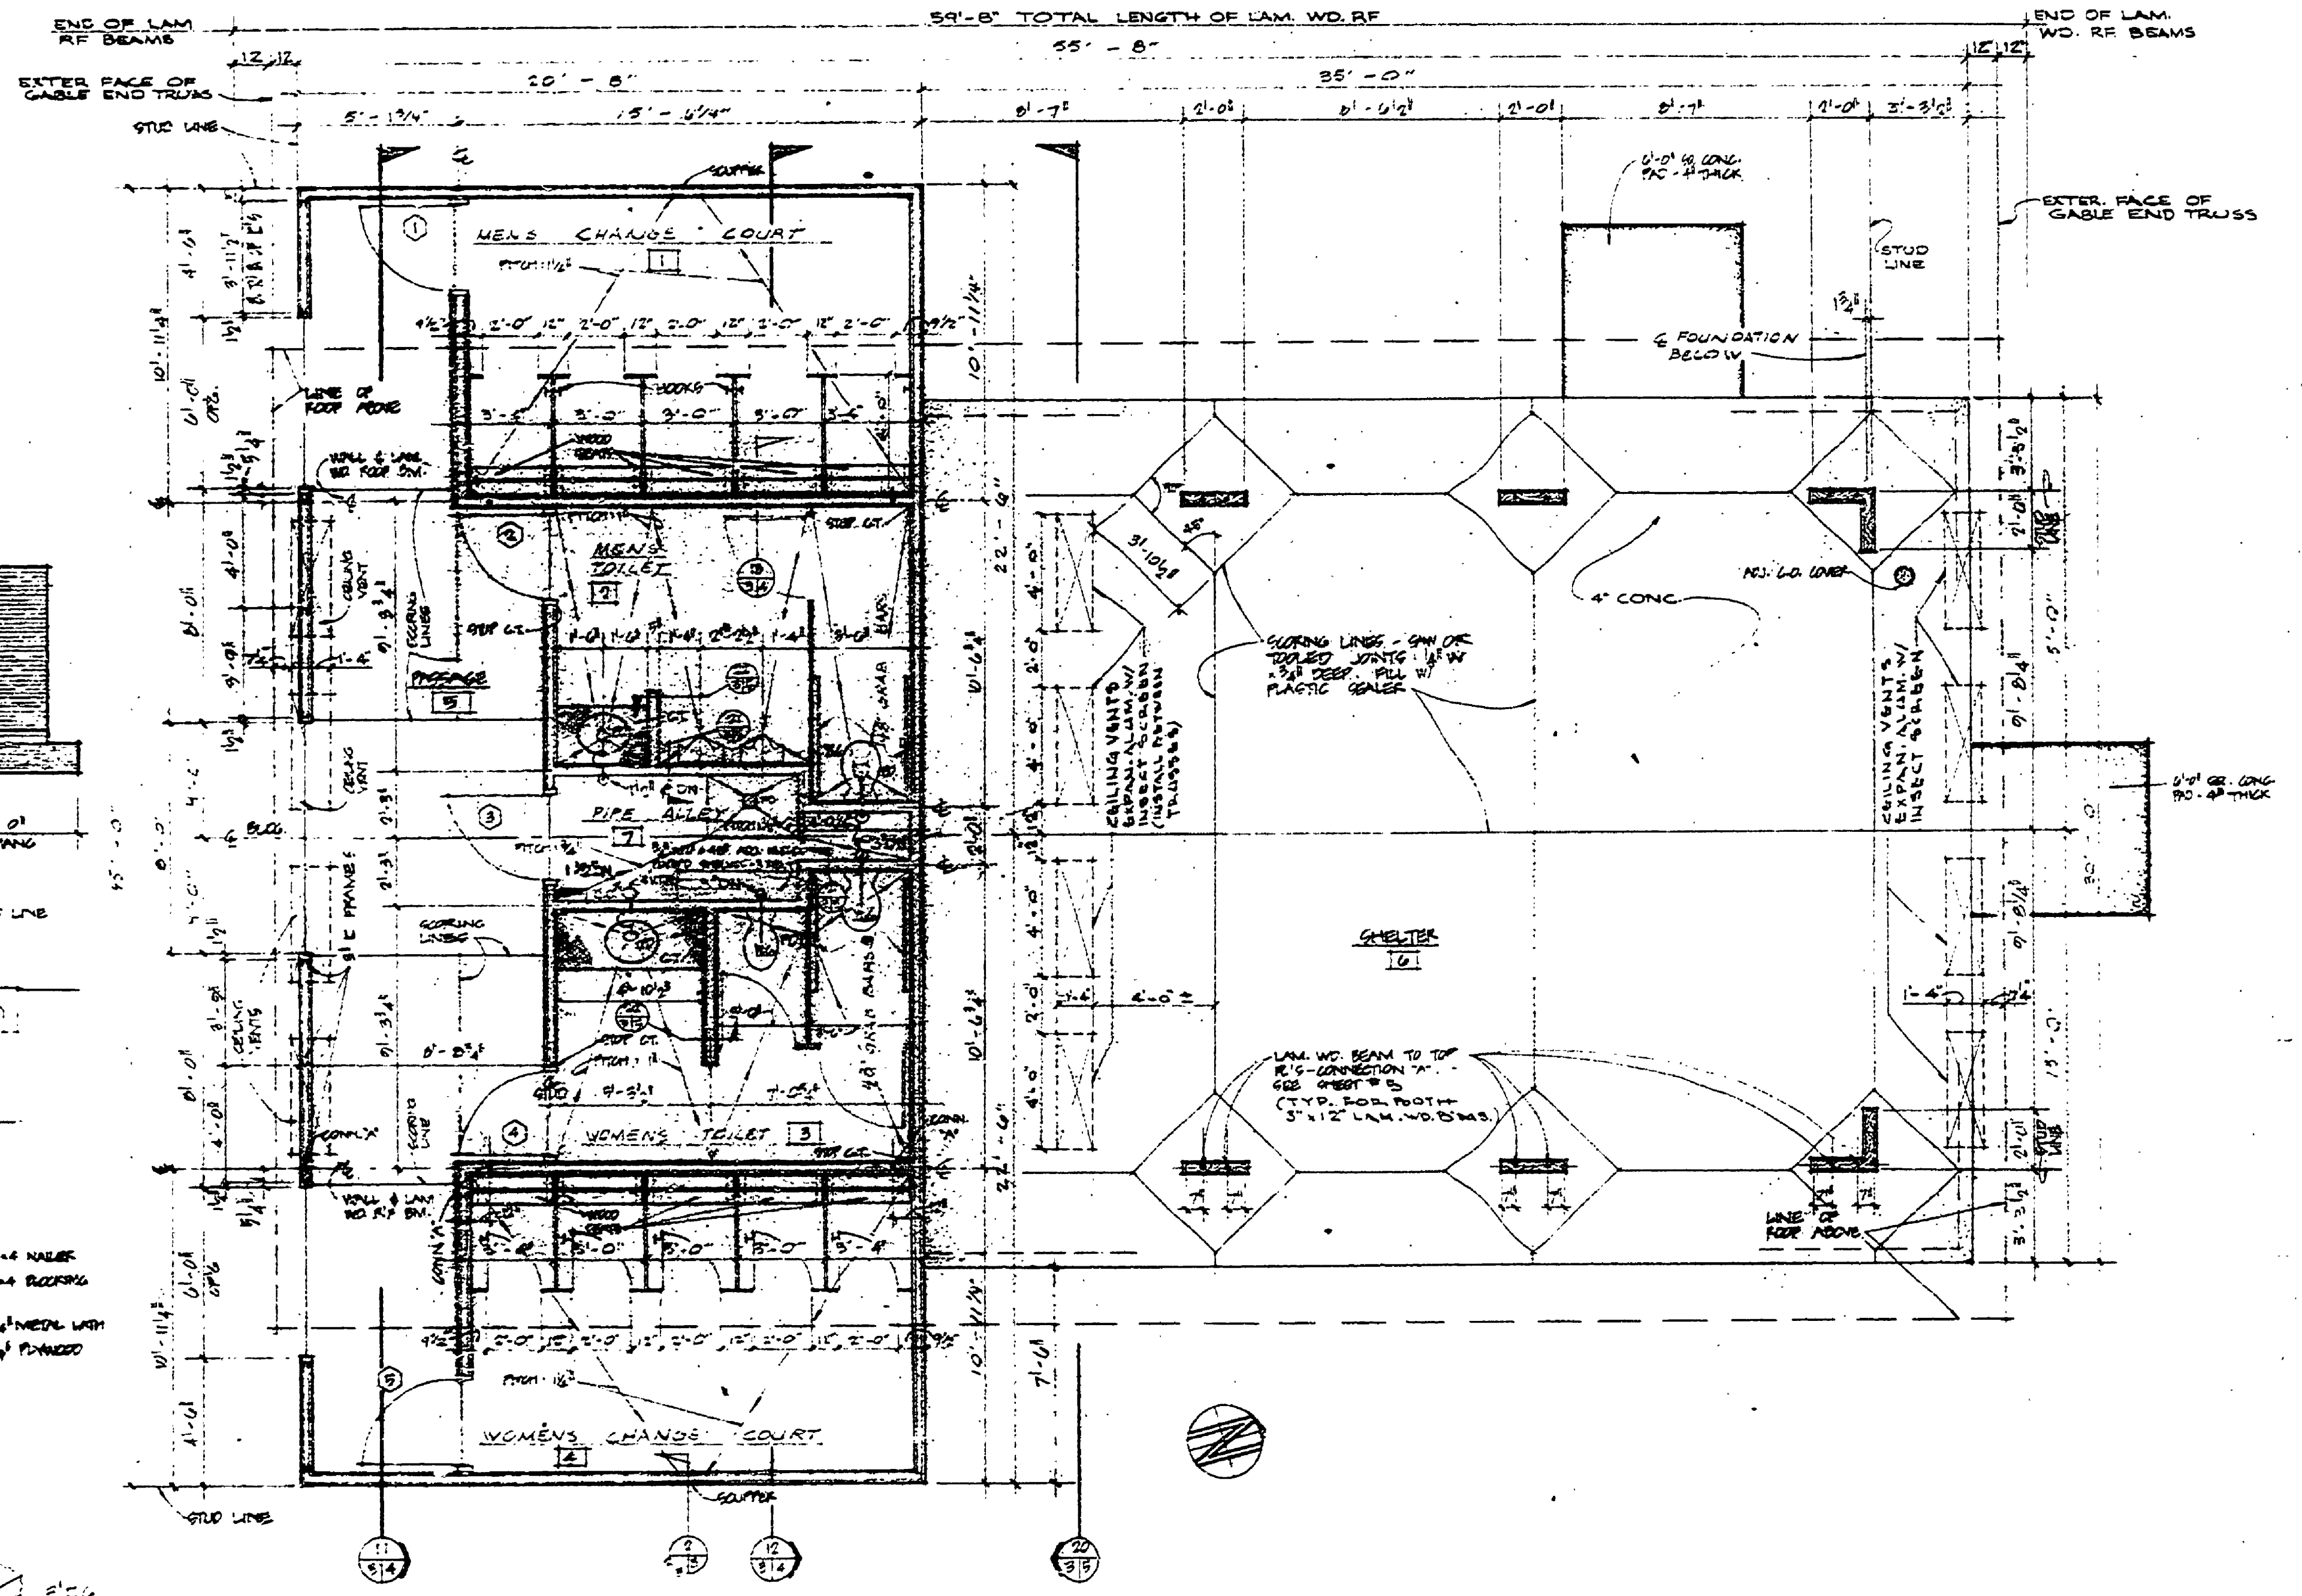

FLOOR PLAN: FINISH FLOOR - ELEV. 1160'-0"
SCALE - 1/4" = ONE FOOT

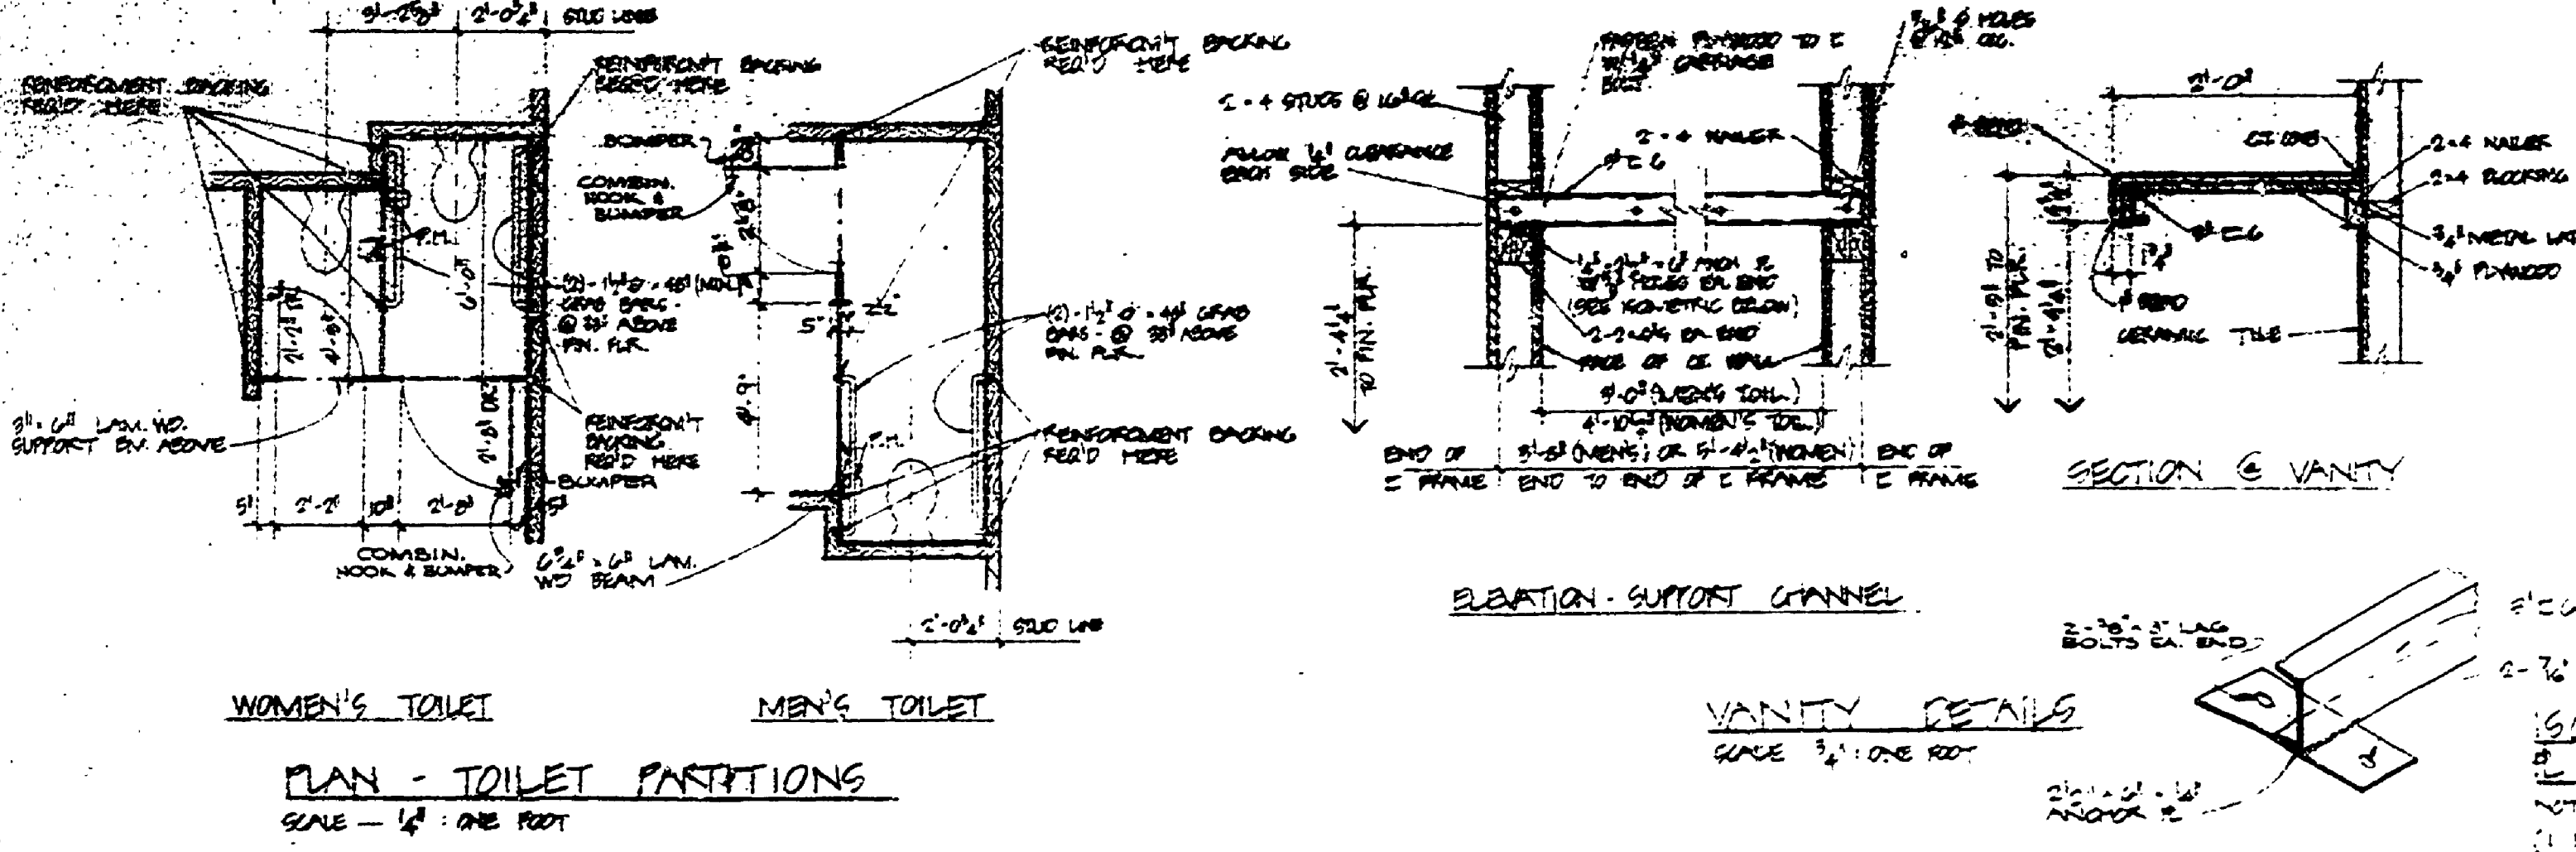

WOMEN'S TOILET **MEN'S TOILET**

PLAN - TOILET PARTITIONS
SCALE - 1/4" = ONE FOOT

VANITY DETAILS
SCALE 3/4" = ONE FOOT

ISOMETRIC - E TO ANCHOR
E @ VANITY
NOT TO SCALE (I.E. REID'S END)

SURVEYED BY	DRAWN BY G. TOMPALE	DATE	NO.	DATE	BY	REVISIONS	NO.	DATE	BY	REVISIONS	MICHIGAN DEPARTMENT OF NATURAL RESOURCES	FLOOR PLAN, SCHEDULES, ELEVATIONS, DETAILS, WASTE PLUMBING PLAN (ABOVE FLR.) SHEET TITLE	NORTH AUGUSTUS LAW STATE PARK AREA OR PARK	PROJECT NO. 24-1577
DESIGNED BY G.R.G., M	CHECKED BY M	DATE	1.				3.						TOILET & CHANGE COURT BUILDING PROJECT	SHEET 3 OF 6 PLAN NO. A-110