




DRAWN BY		CHECKED BY		DATE							
J.W.F.		J.W.F.		4-14-52							
REVIEWED BY SECTIONS		APPROVED BY		NO. DATE		BY		REVISIONS		DATE	
ARCHITECTURAL				1	10/1/52	W.A.		4			
ENGINEERING		ASSISTANT CHIEF IN CHARGE		2				5			
LANDSCAPE		OF DESIGN		3				6			

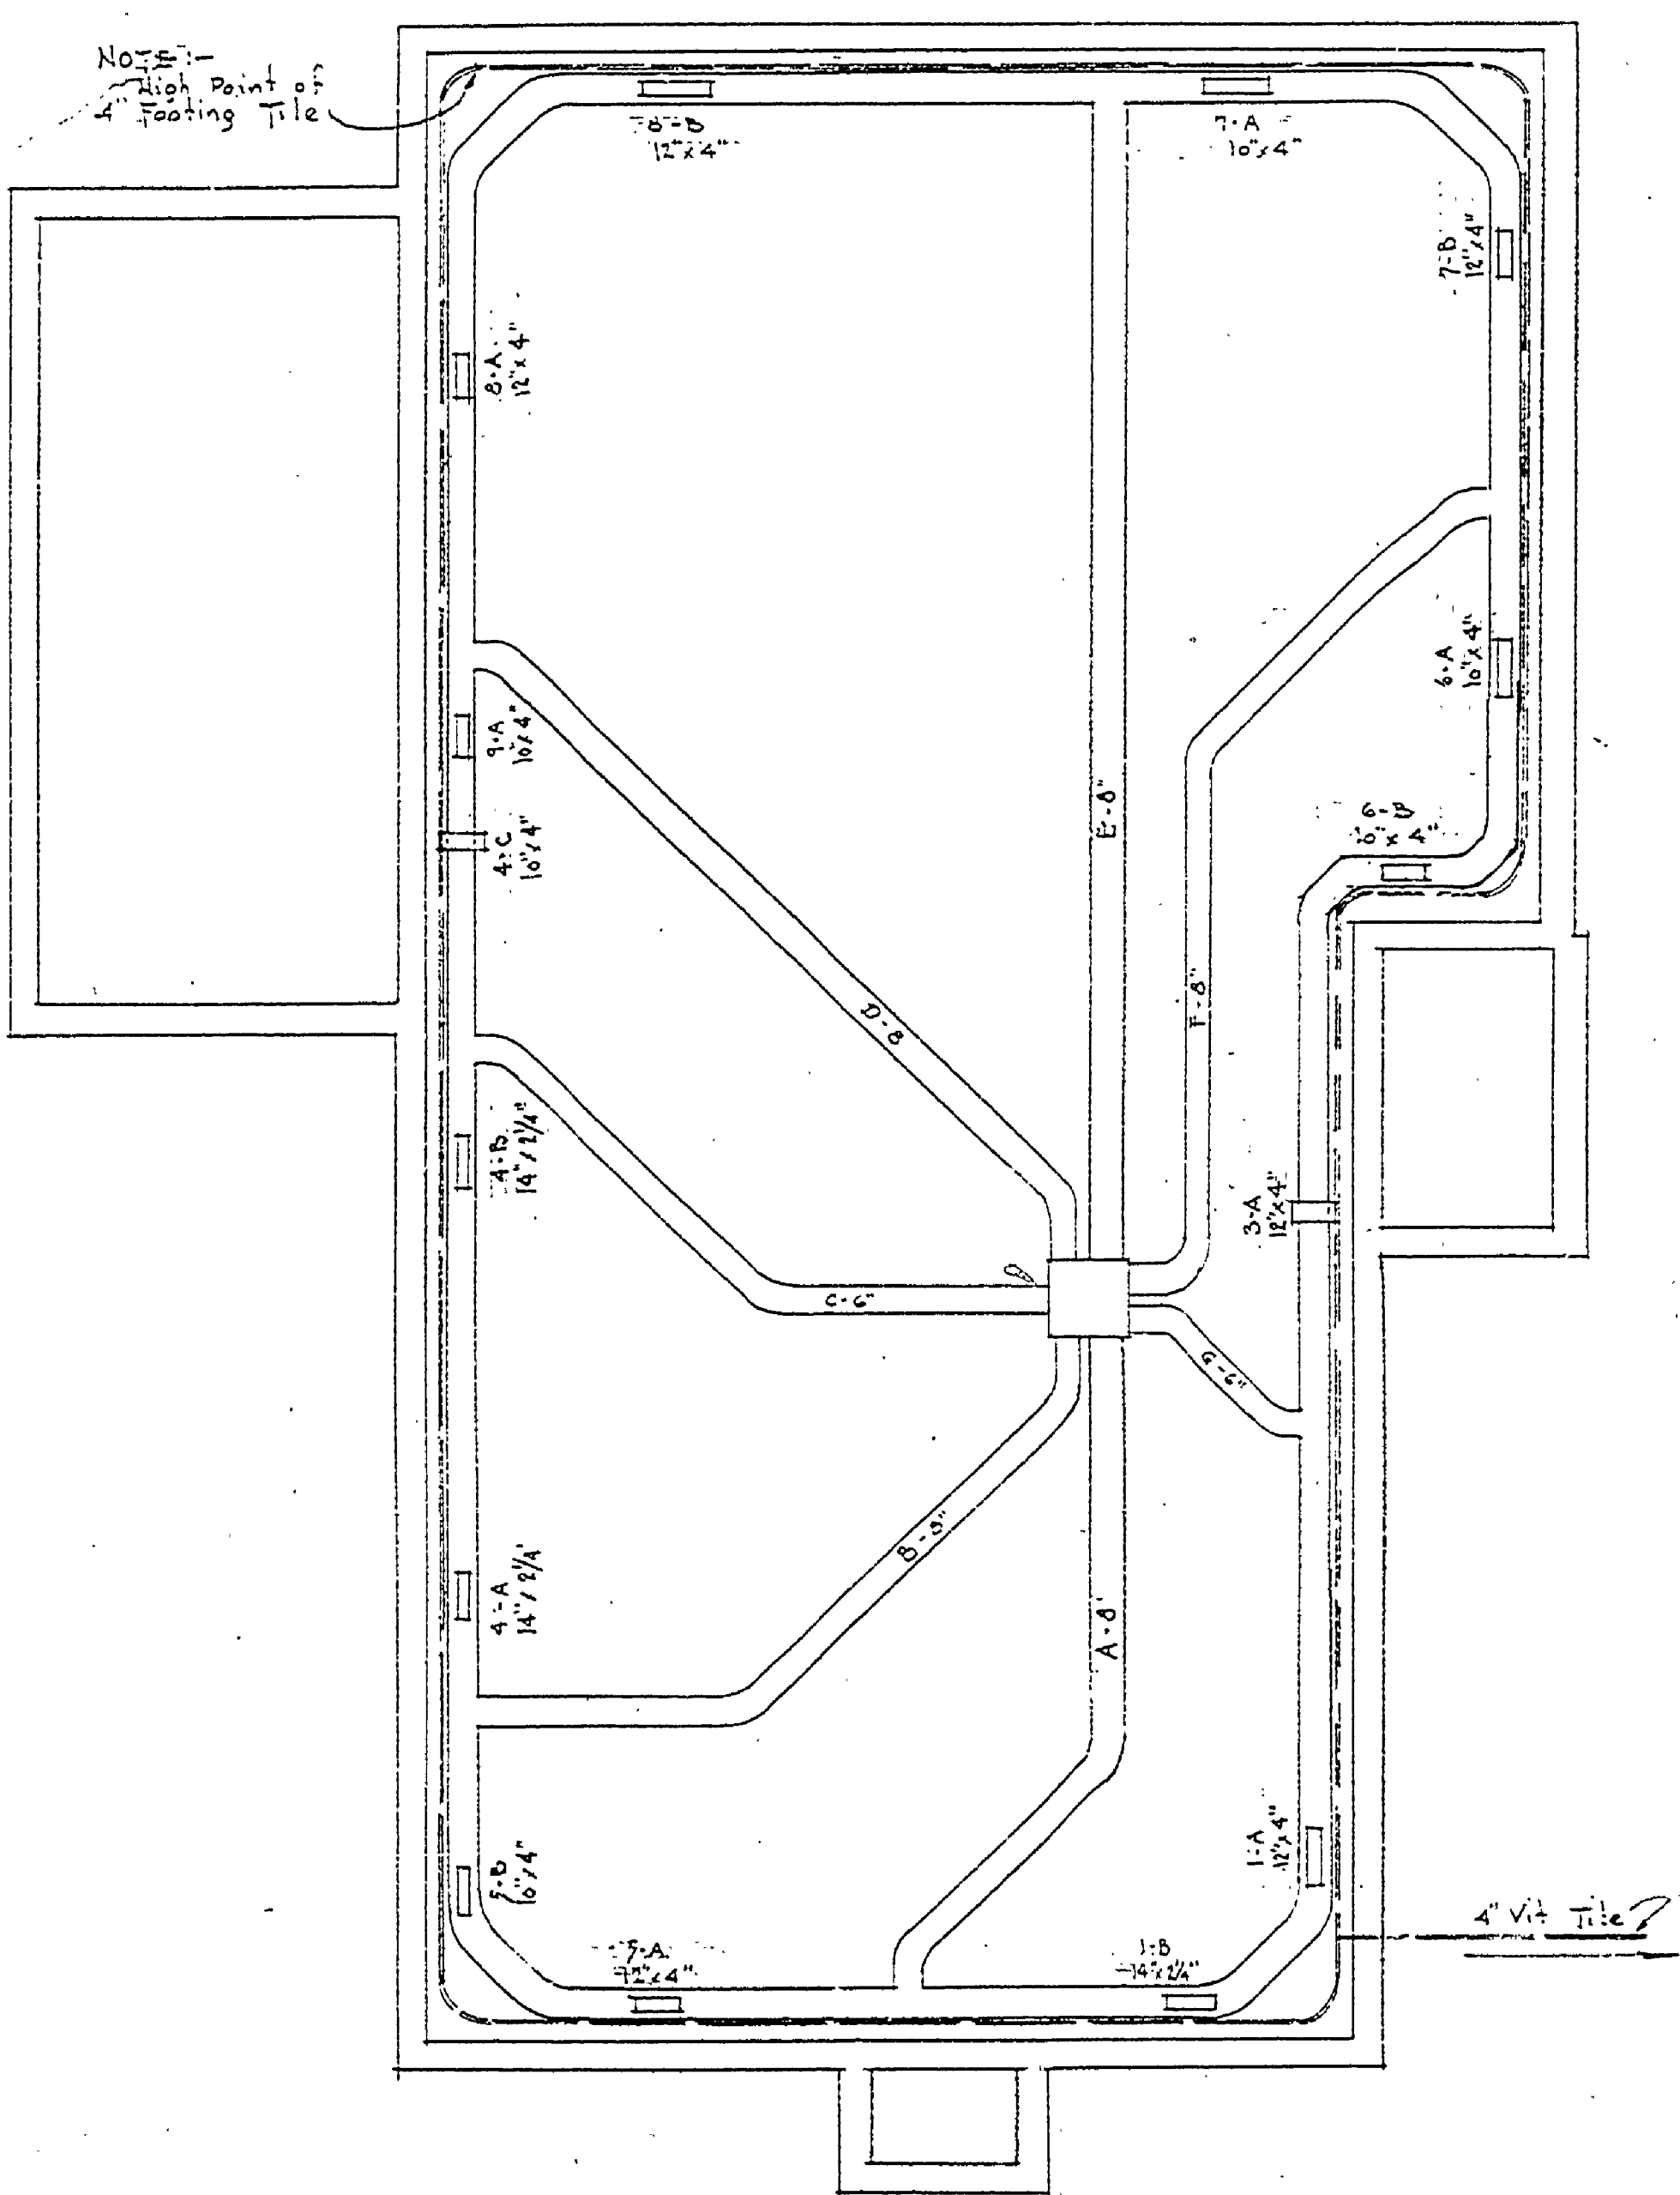


HEATING PLAN
Scale: 1/8" = 1'-0"

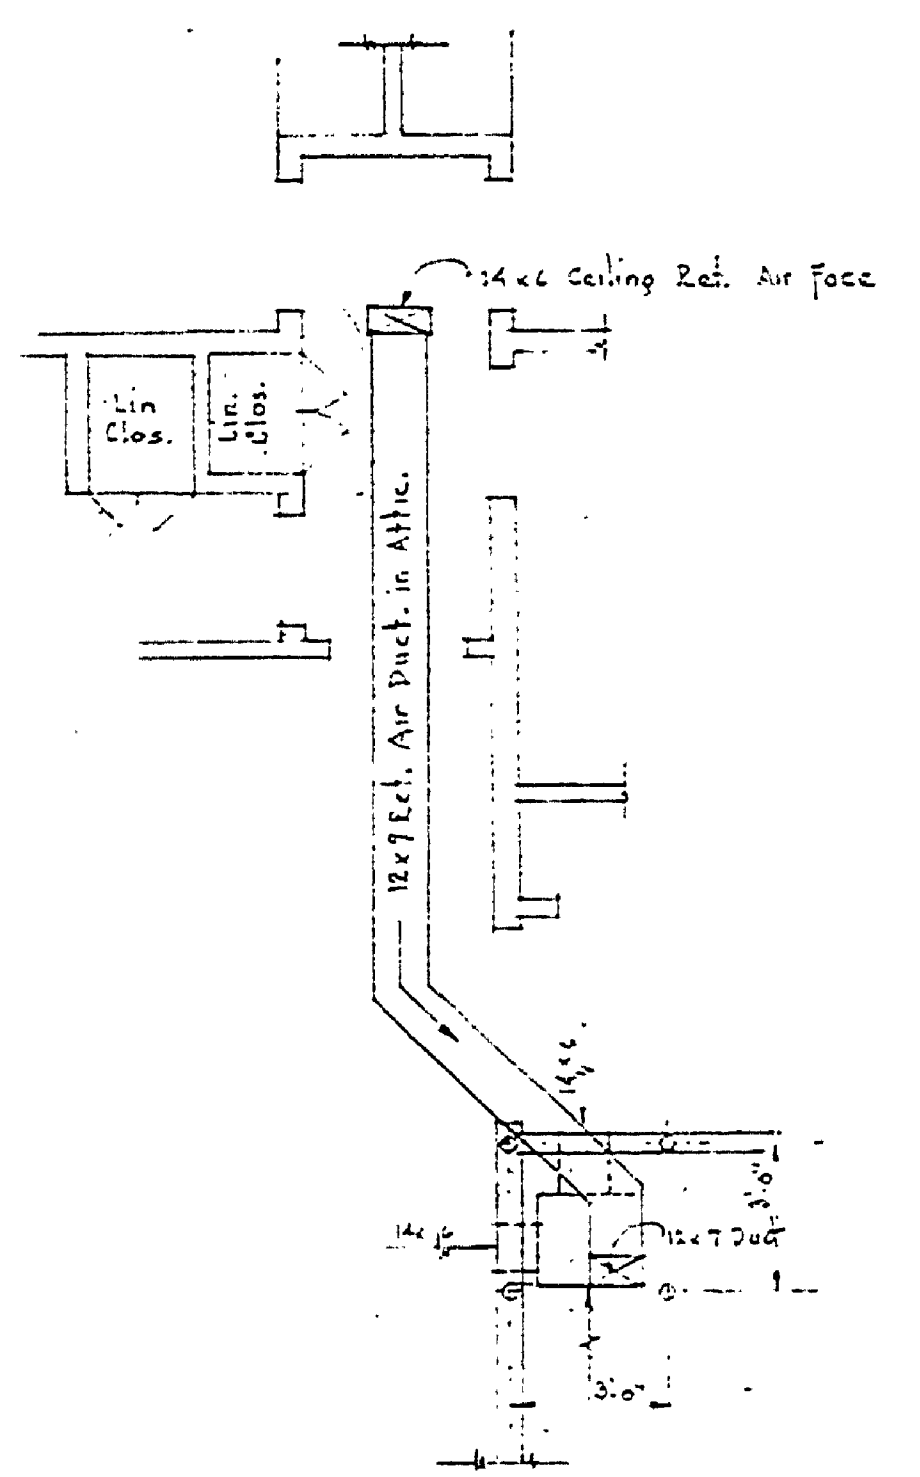


PLAN LAYOUT OF RETURN DUCT
Scale: 1/8" = 1'-0"

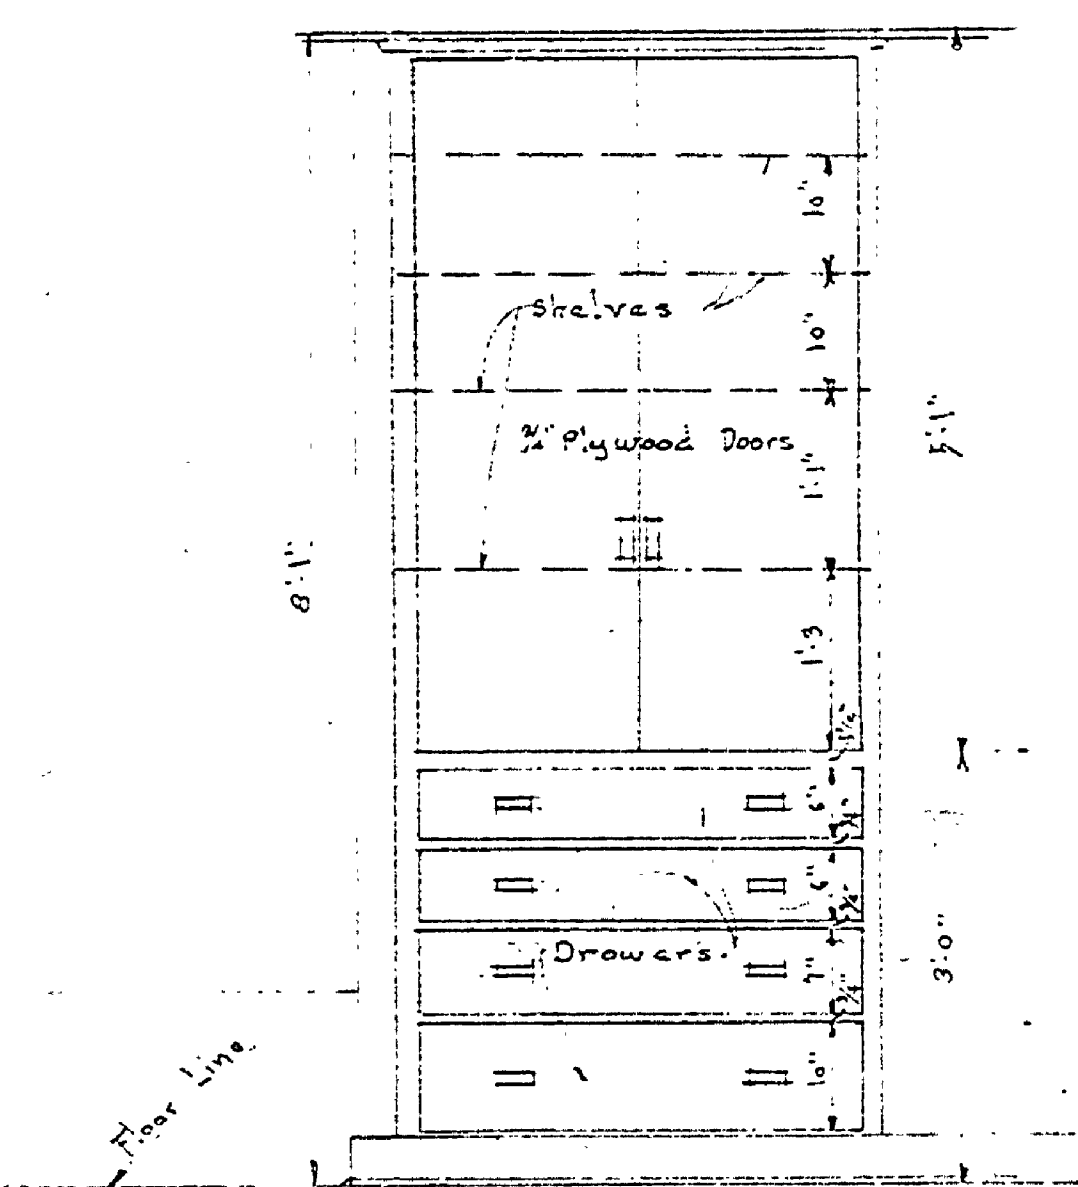

ELEVATION

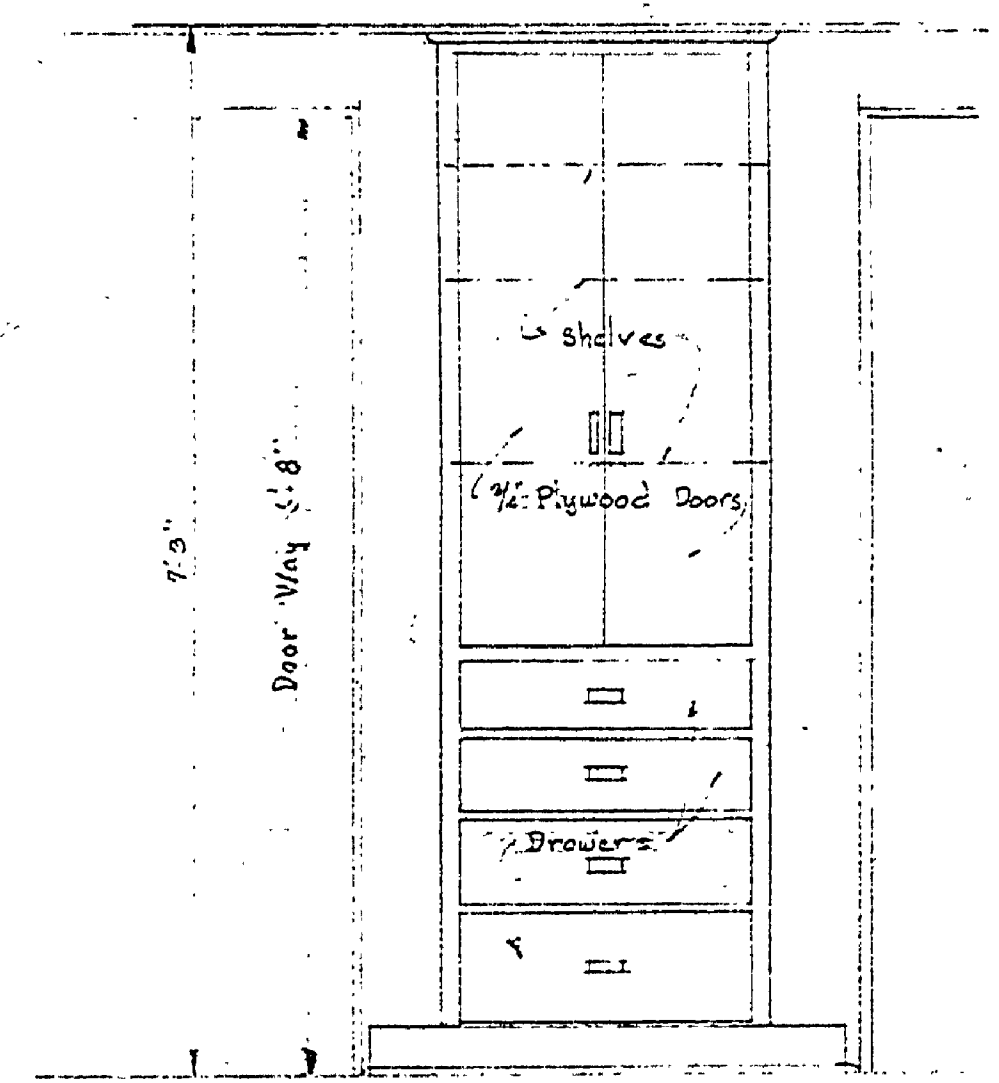

ELEVATION

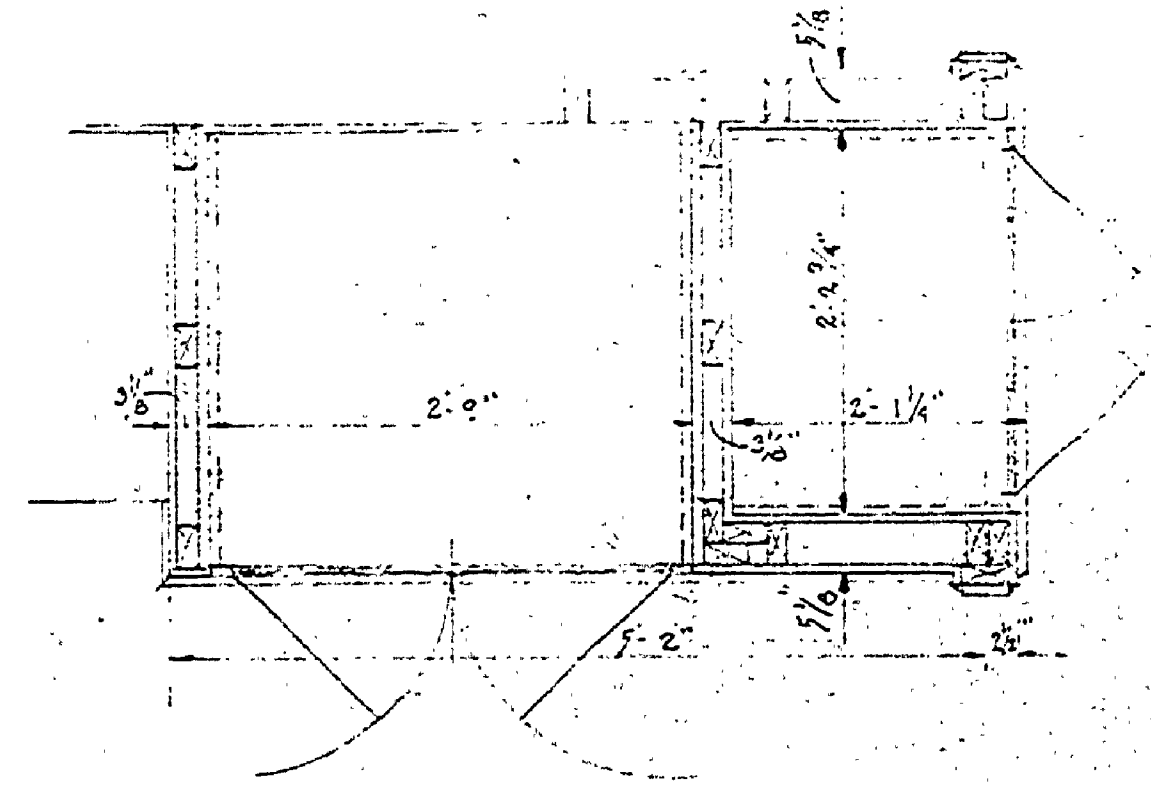

PLAN

LINEN CLOSET DETAIL
Scale: 1/8" = 1'-0"

MASTER PLAN BUDG. No. 1

MICHIGAN
DEPARTMENT OF CONSERVATION
PARKS AND RECREATION DIVISION

INDIAN LAKE STATE PARK
MANAGER'S RESIDENCE

SHEET
NO. 4
OF

PLAN NO.
A-102