




REAR ELEVATION

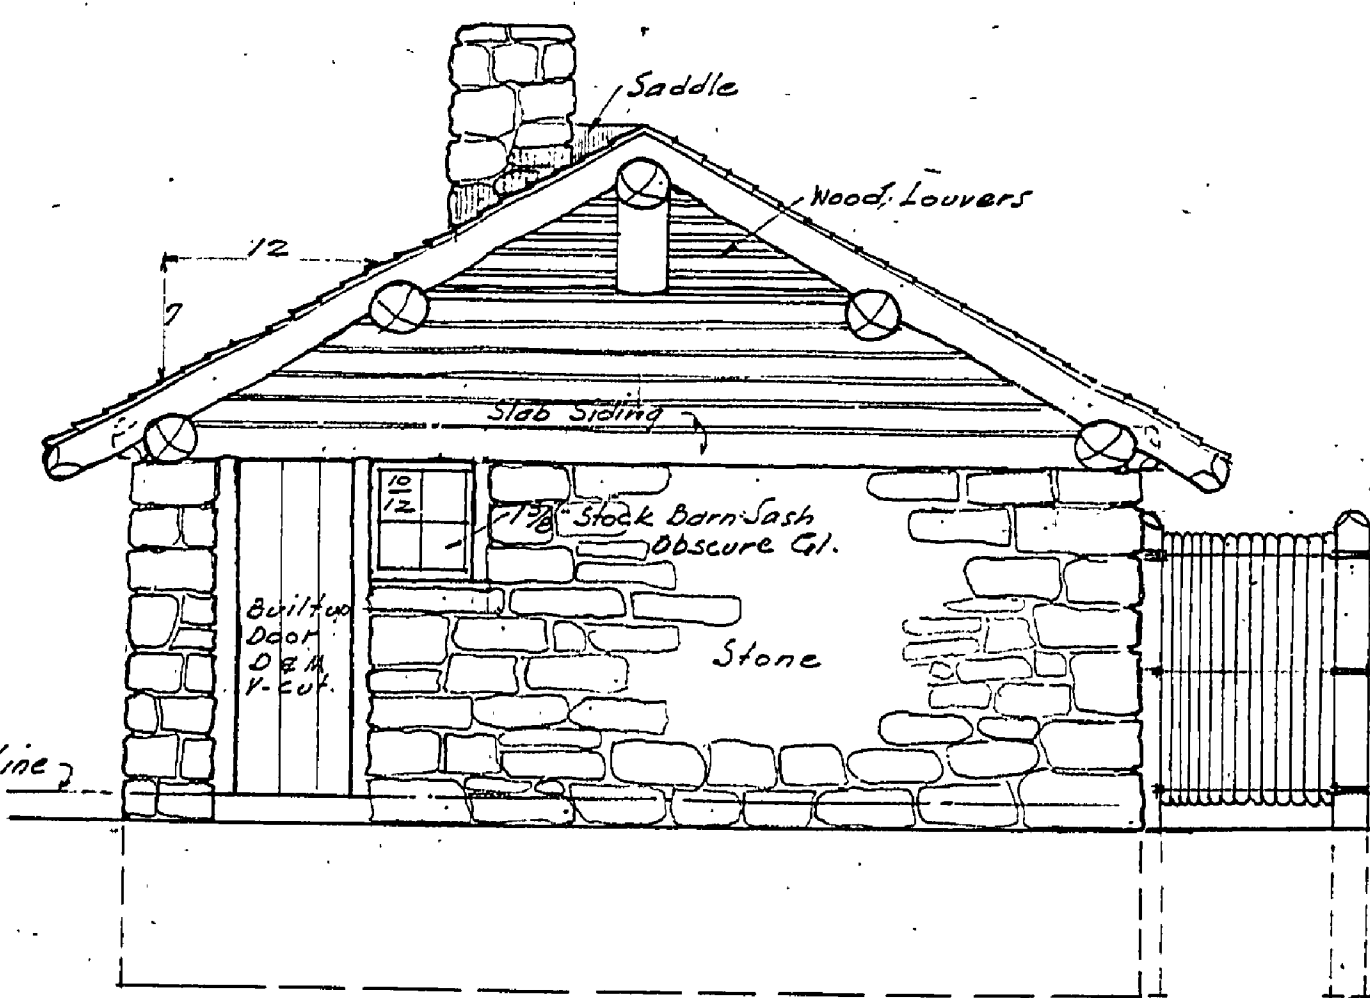

RIGHT SIDE ELEVATION

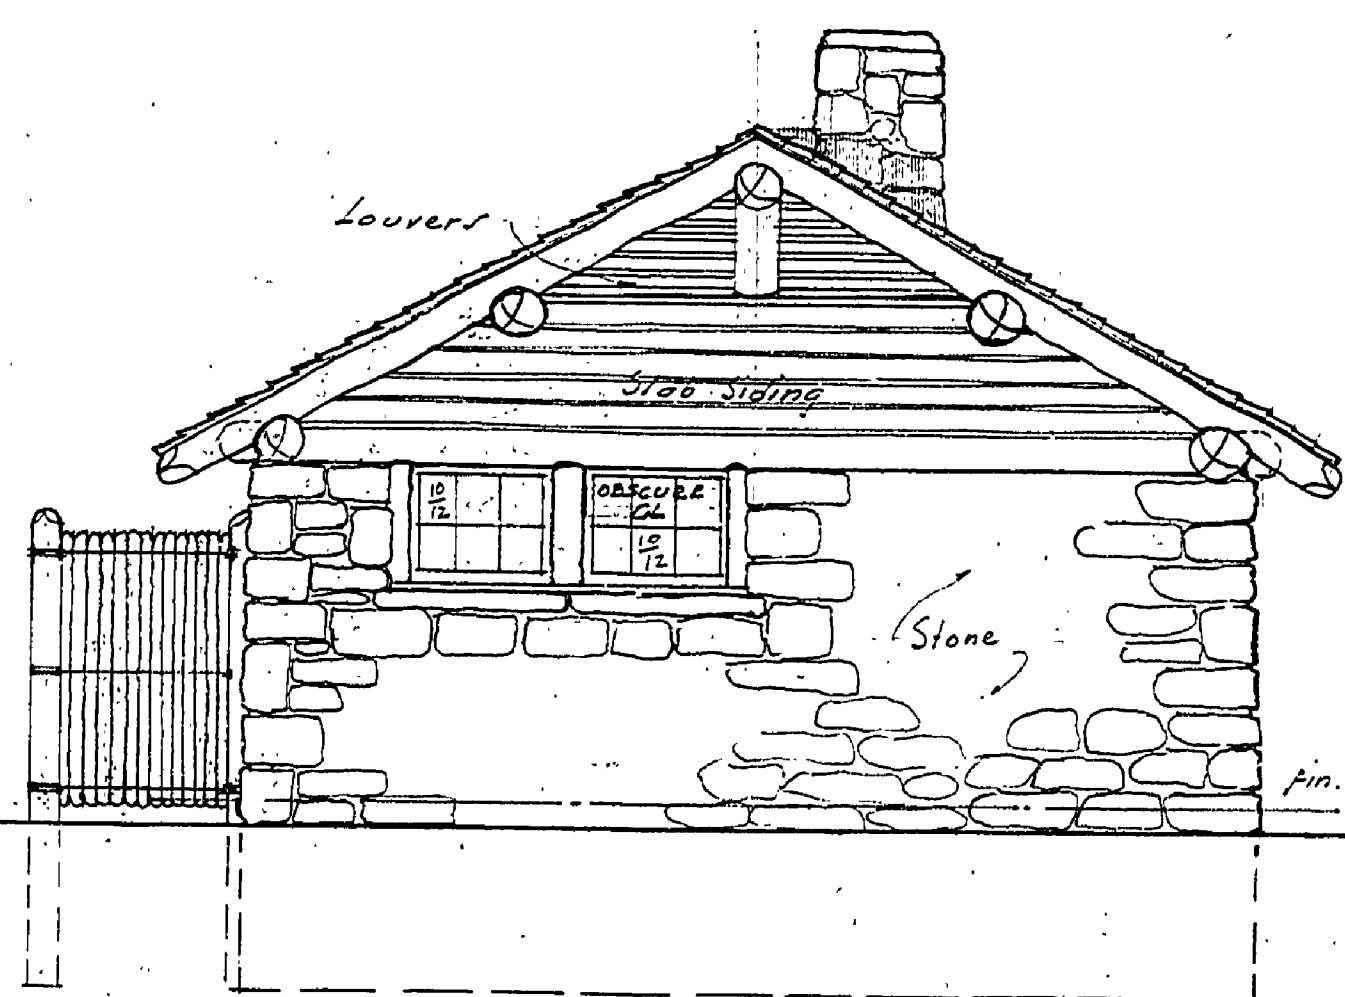


LEFT SIDE ELEVATION

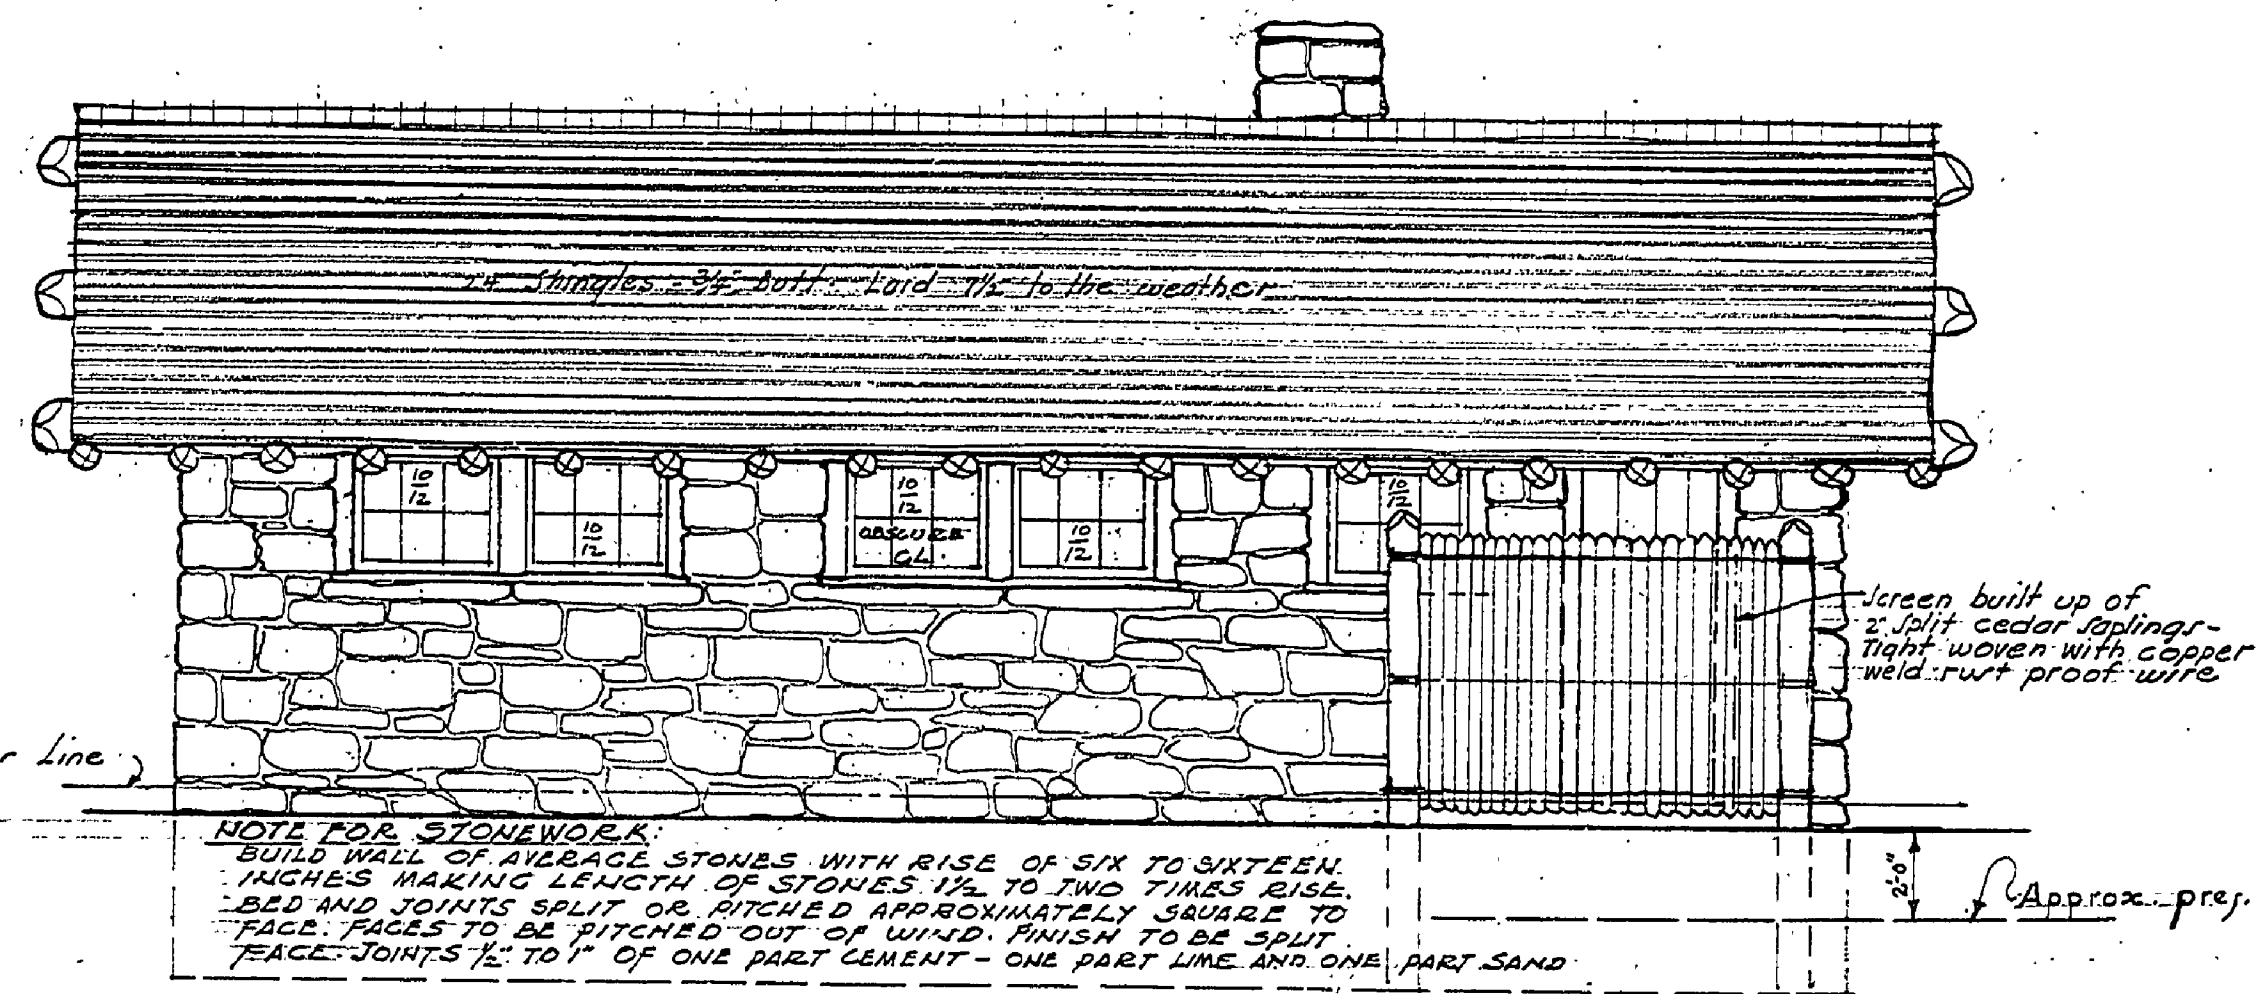


FRONT ELEVATION


Scale: 1/4" = 1'-0"

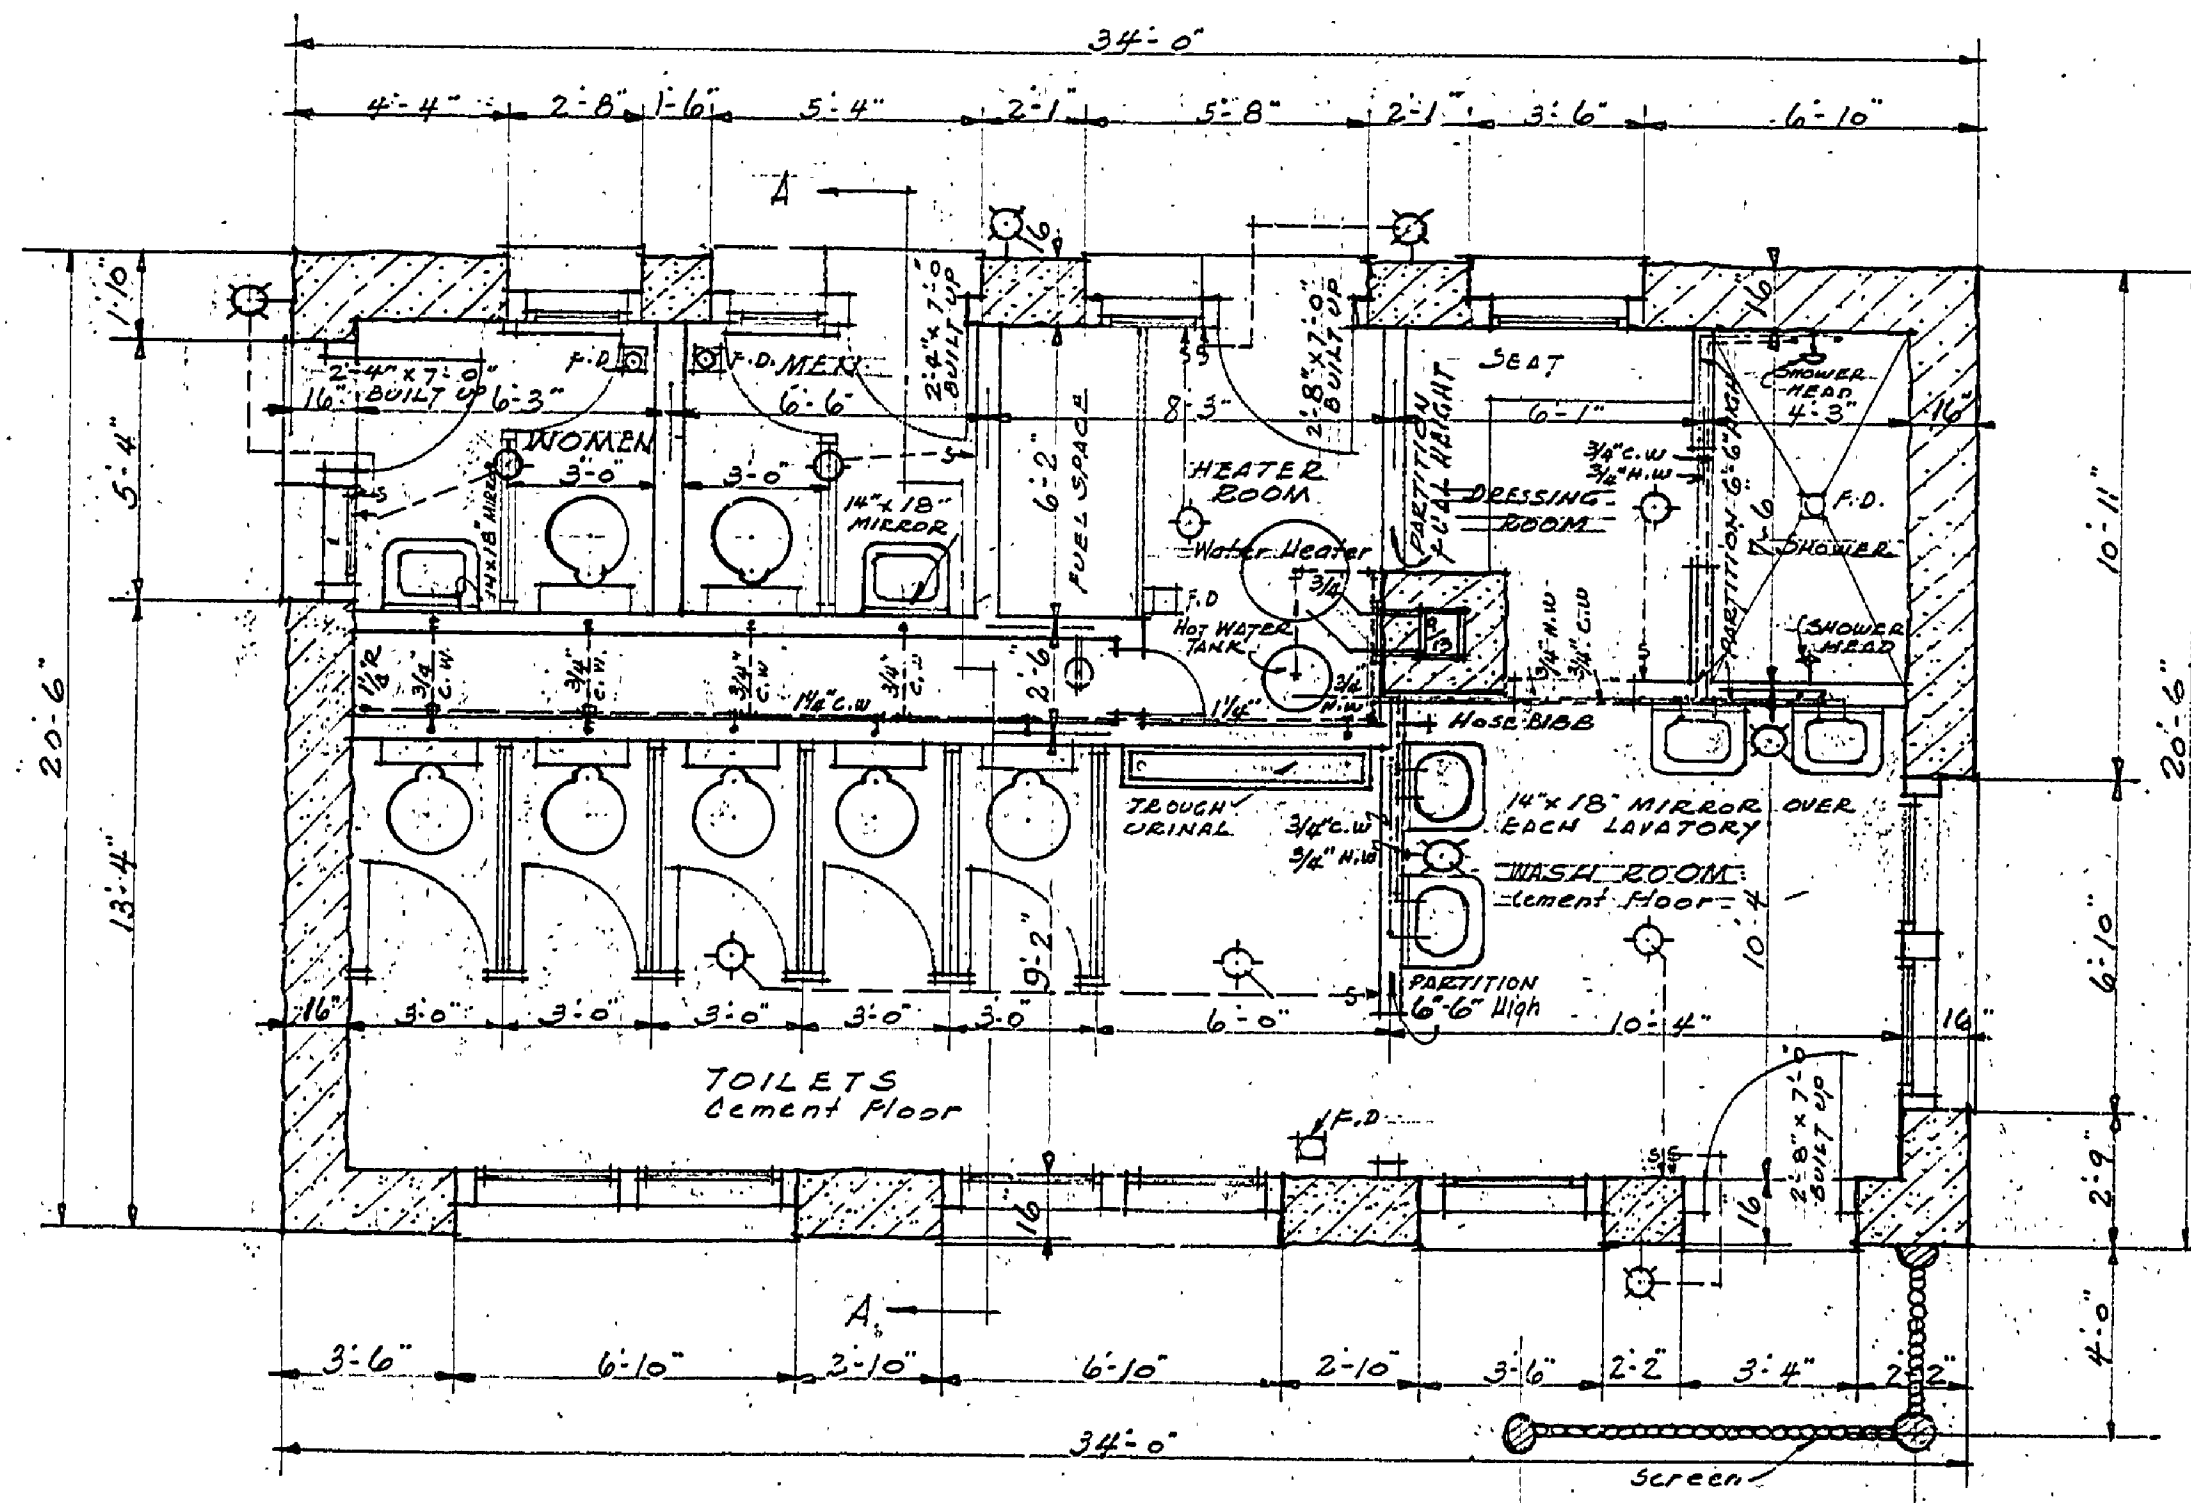


FLOOR PLAN
Scale: 1/4" = 1'-0"

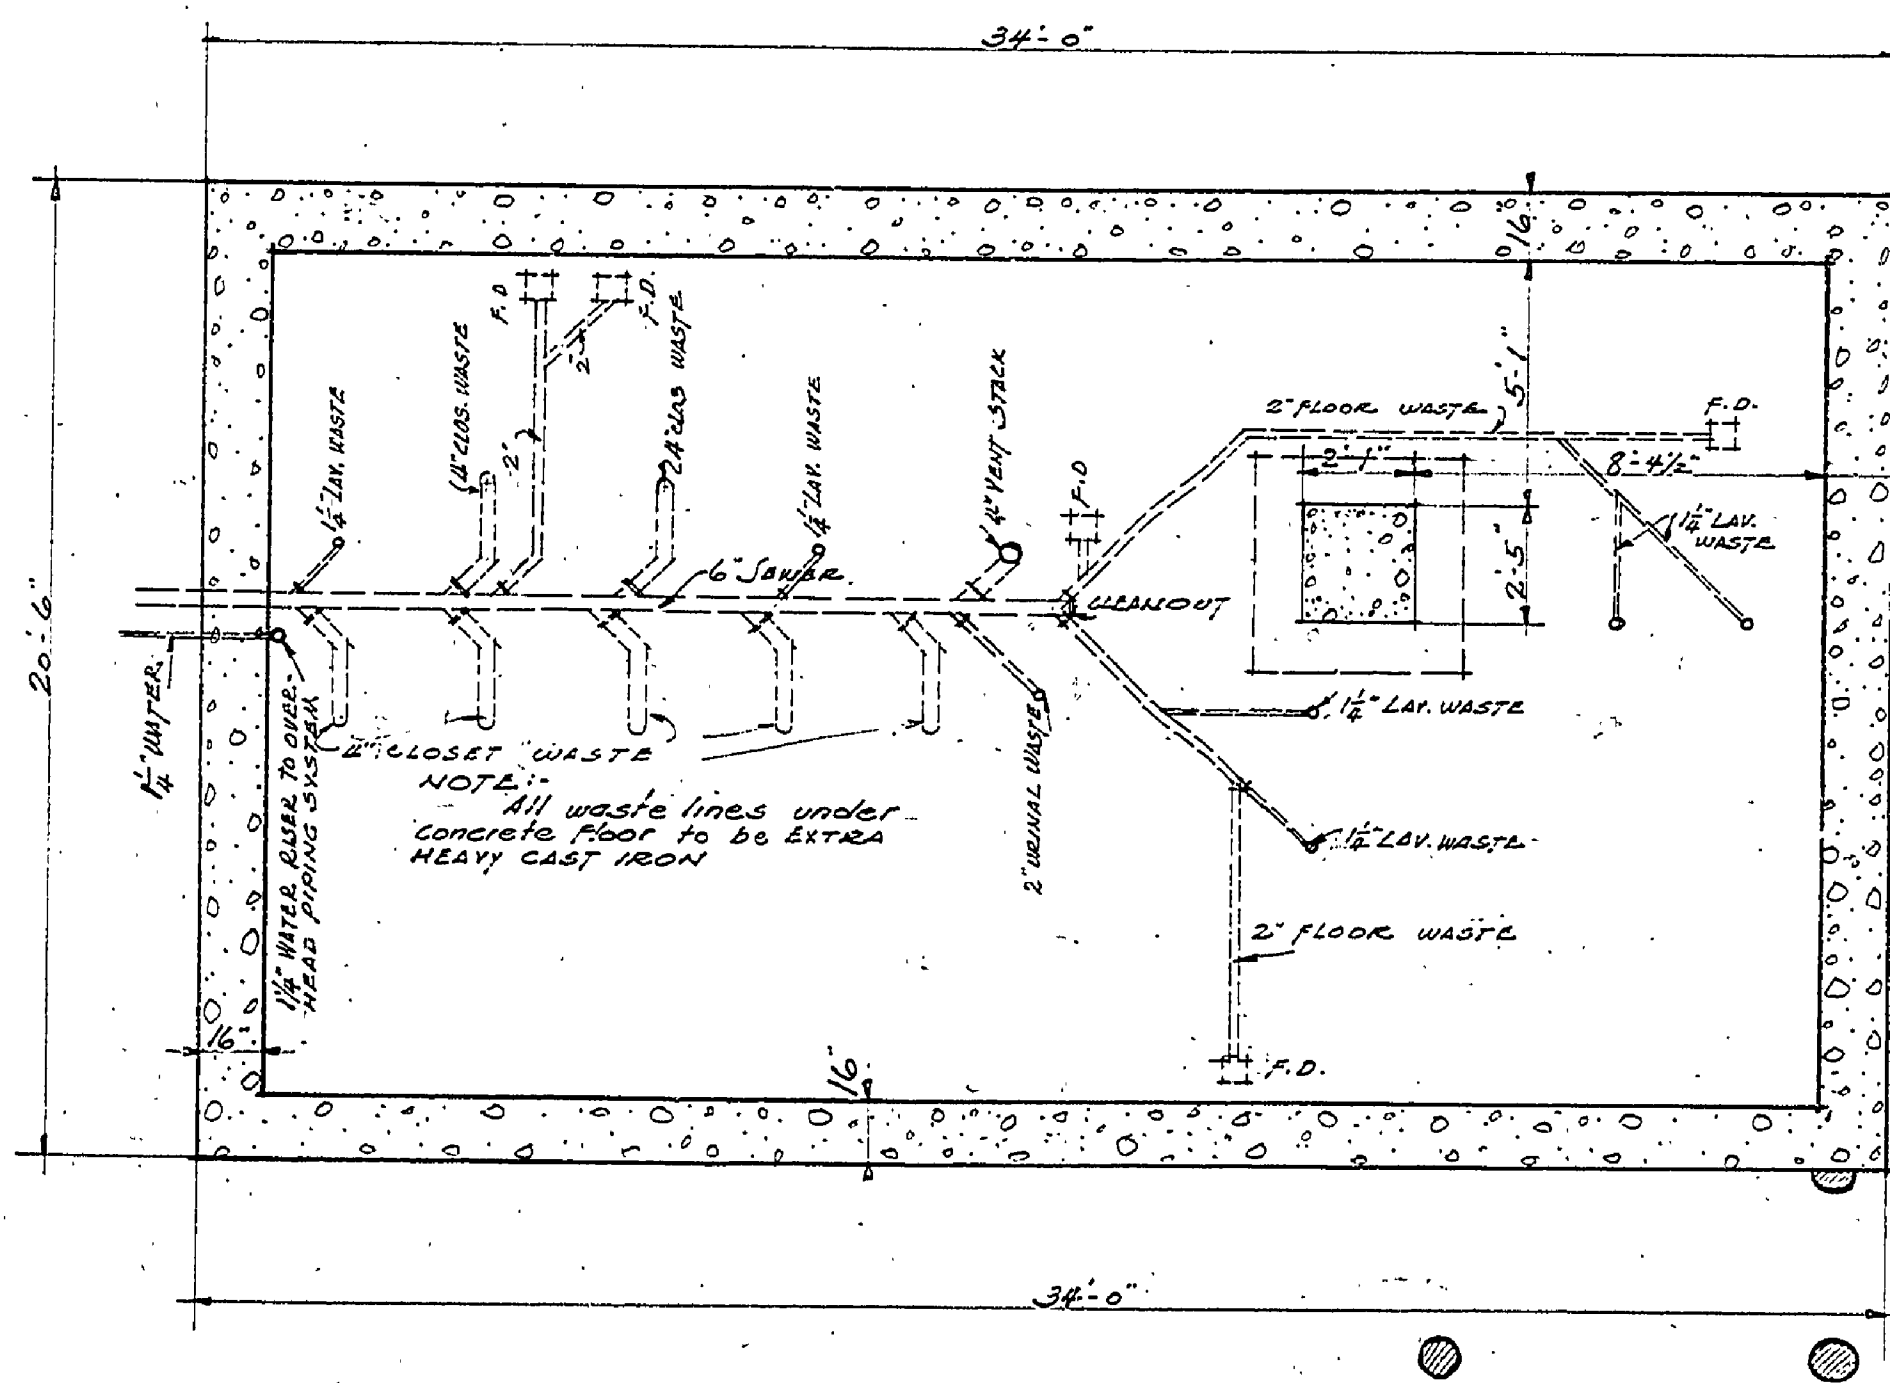

FOUNDATION & PIPING PLAN
Scale: 1/4" = 1'-0"

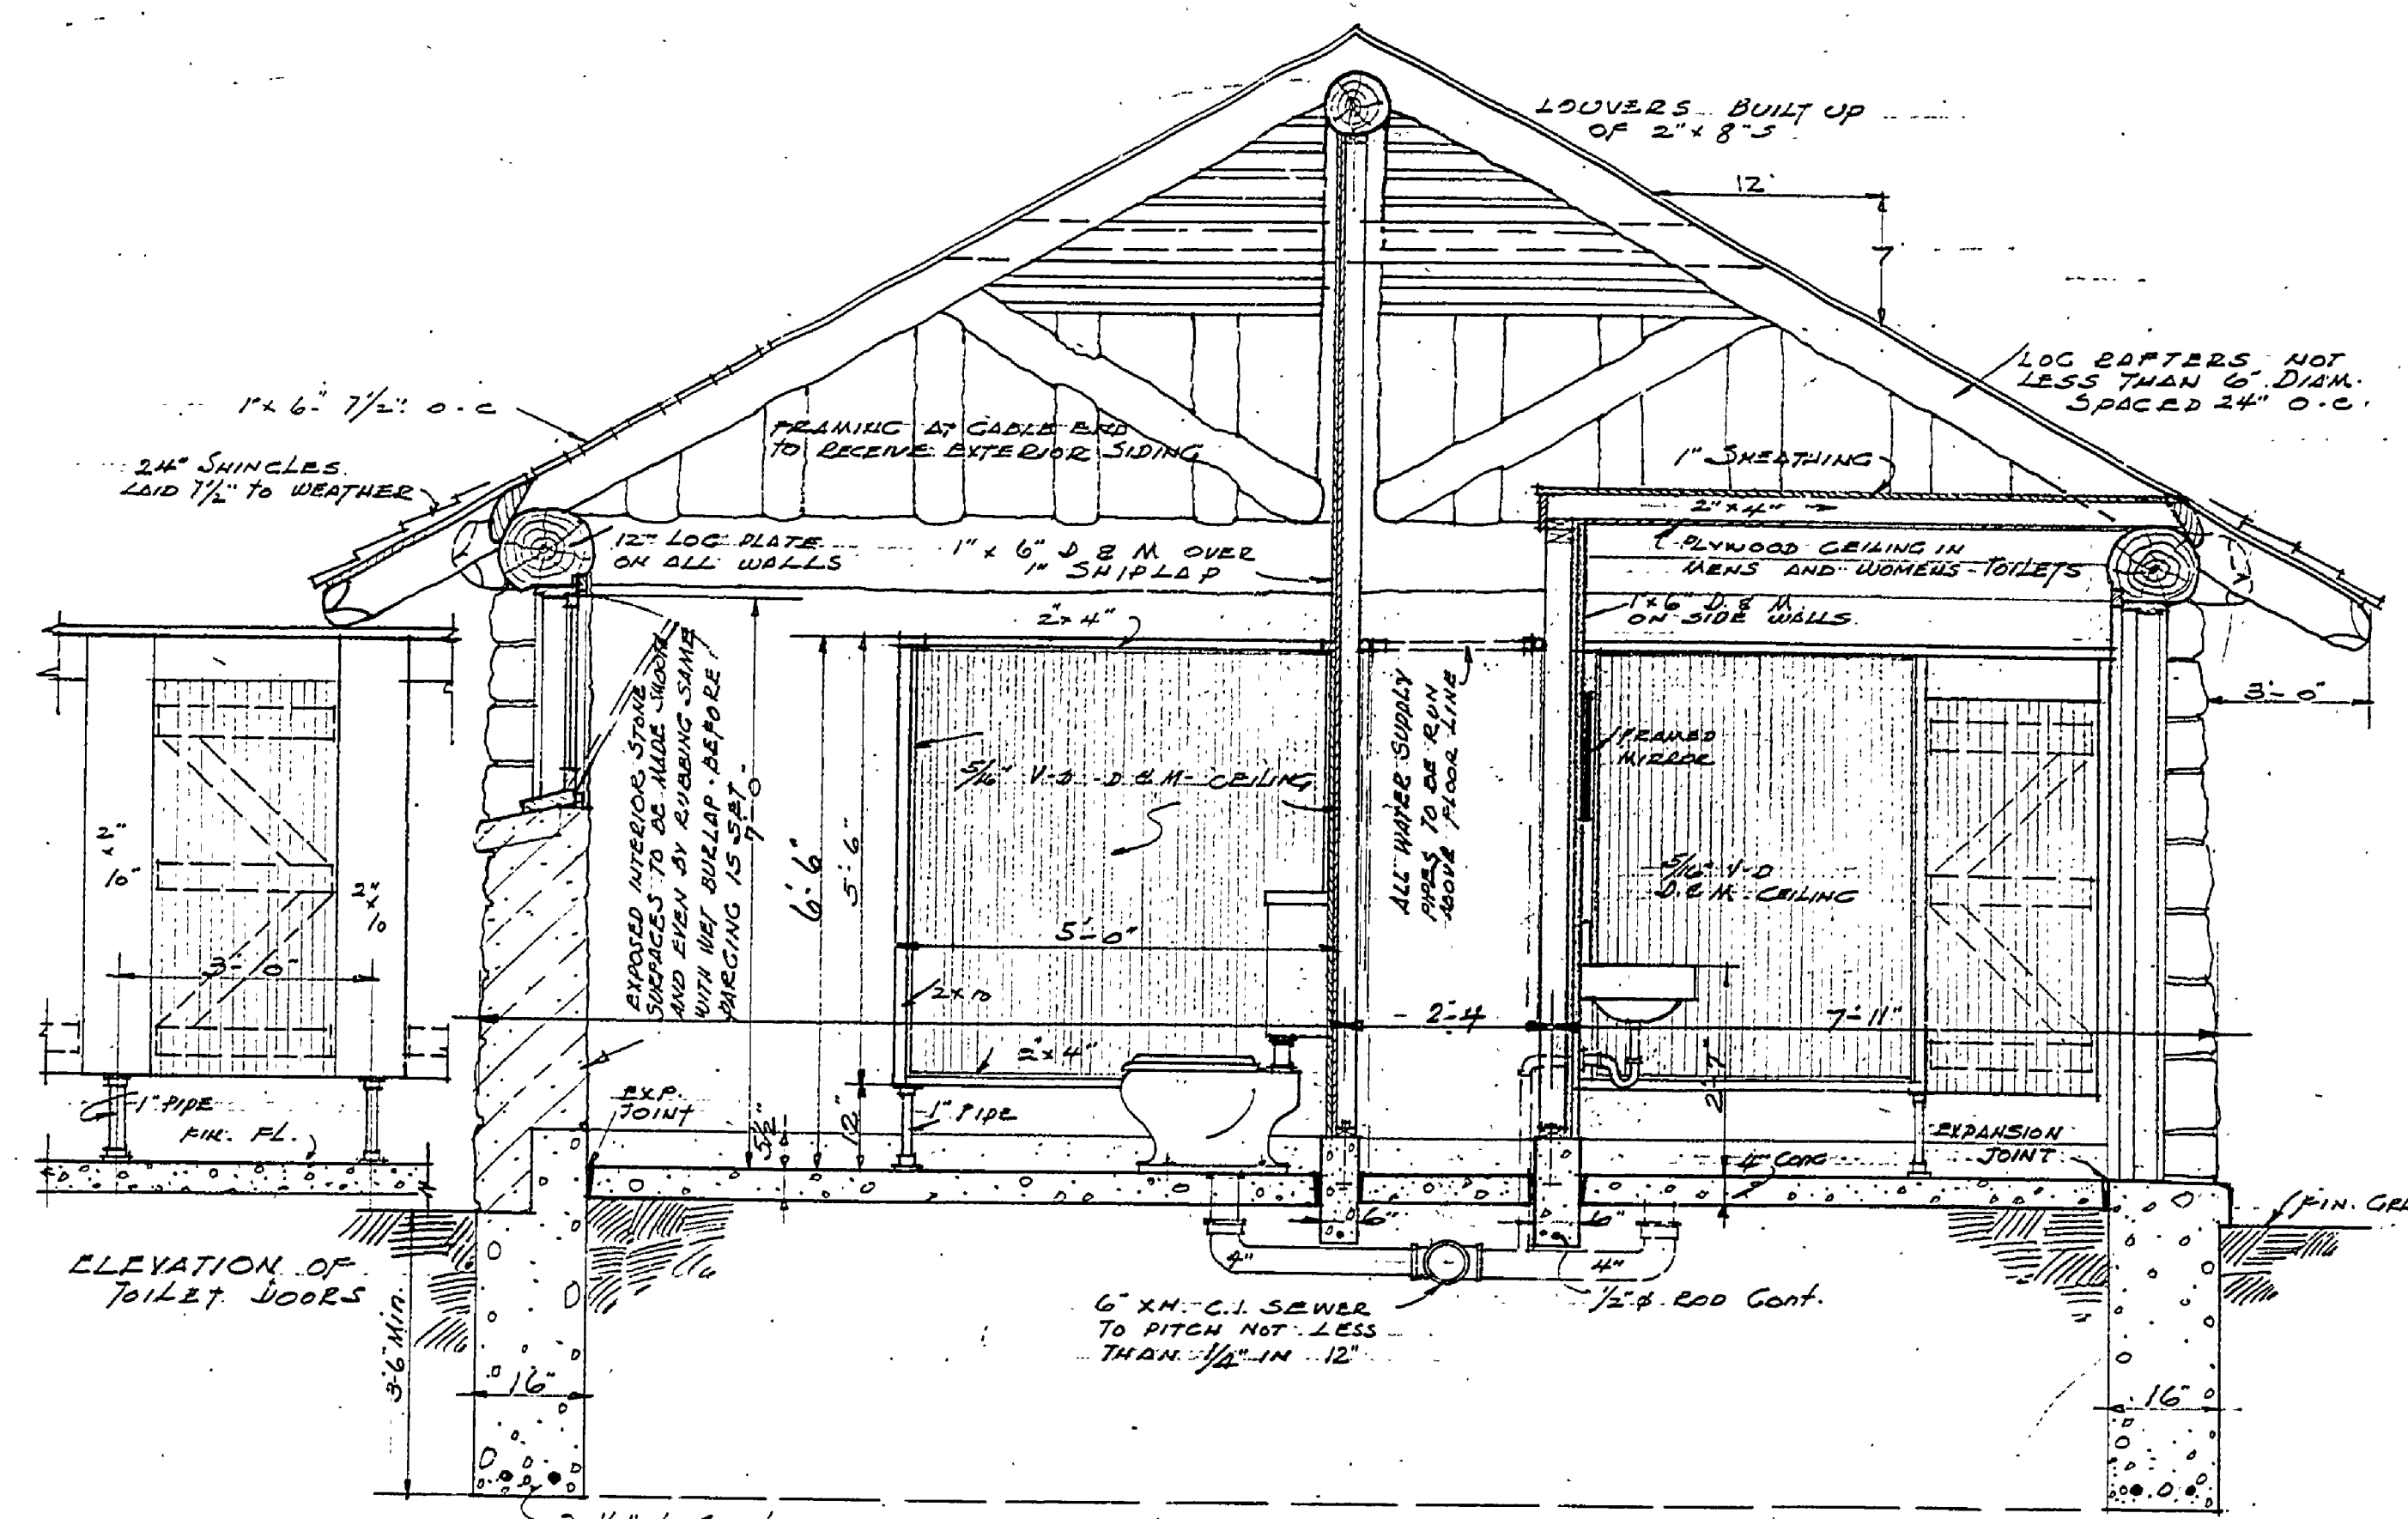

SECTION ON LINE A-A
Scale: 1/2" = 1'-0"

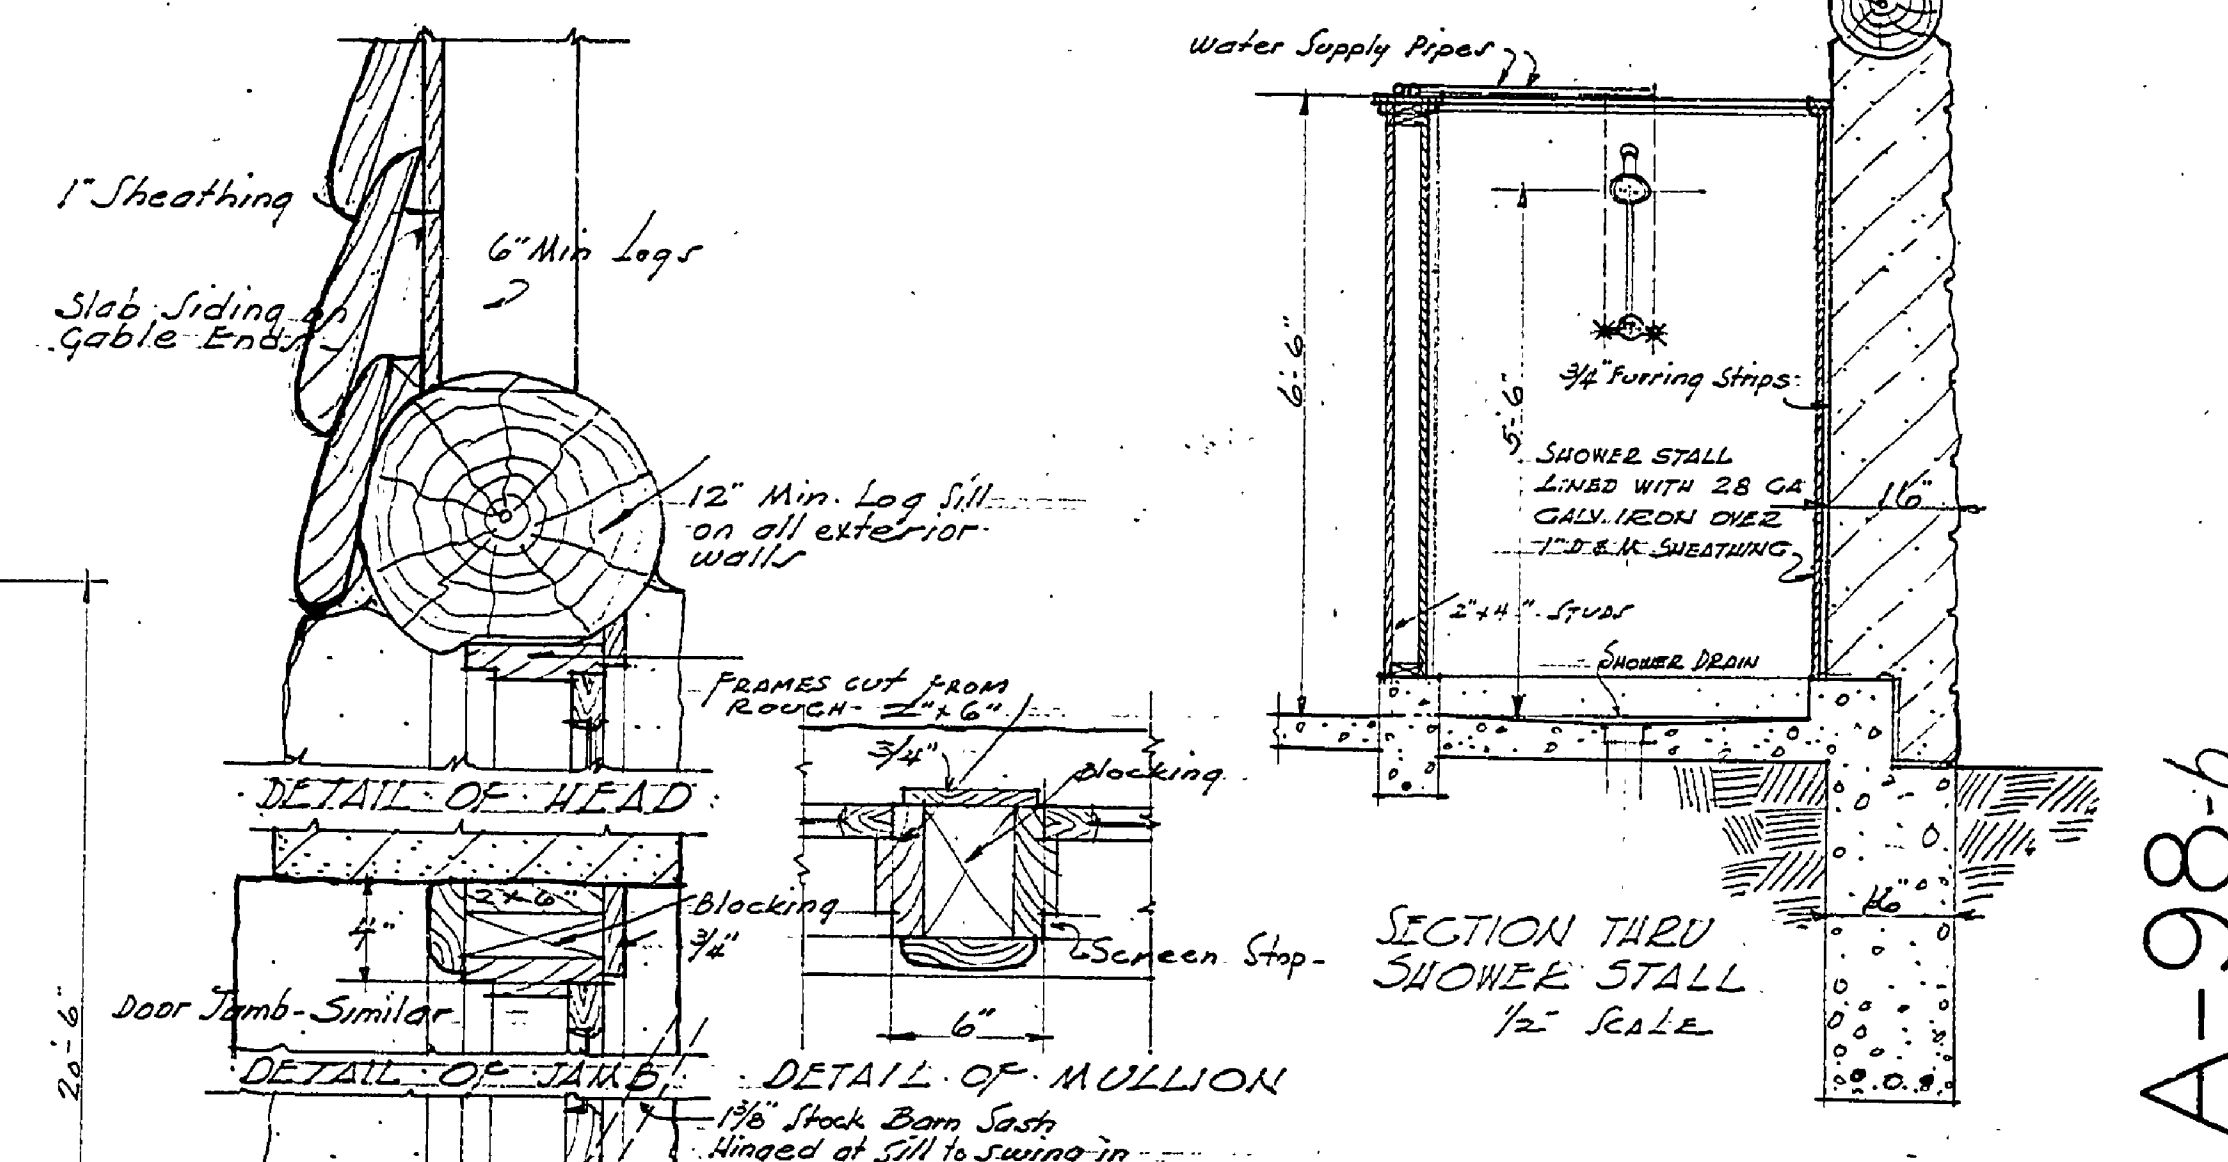

DETAIL OF HEAD
DETAIL OF JAMB
DETAIL OF MULLION
DETAIL OF SILL
DETAILS OF WINDOW FRAMES
Scale: 1/2" = 1'-0"

Mitchell 12/4/36
Lead Architect

INSURANCE No. 13

DEPARTMENT OF THE INTERIOR NATIONAL PARK SERVICE And MICHIGAN DEPARTMENT OF CONSERVATION CO-OPERATING			
BRANCH OF PLANNING	STATE PARK DIVISION	SHEET NO. OF 1 1	
SYMBOL	J. W. WELLS CAMP #9	FILE NO.	
NUMBER	108	COMB. BATH & TOILET BUILDING	
DRAWN BY	G.E.P.	CAMP GROUP AREA	
CHECKED	DESIGNED	GEO. E. PAGE	
DATE	PROJECT SUPERINTENDENT	A. S. CULTE, C.T.	
RECOMMENDED FOR CONSTRUCTION	SUBMITTED	DATE	
DATE	APPROVED	DATE	
APPROVED FOR CONSTRUCTION 12/14/36	DATE	MICH. CONSERVATION COMM.	

A-98-b

DEC 10 1936